



TOWER-A

TOWER-B

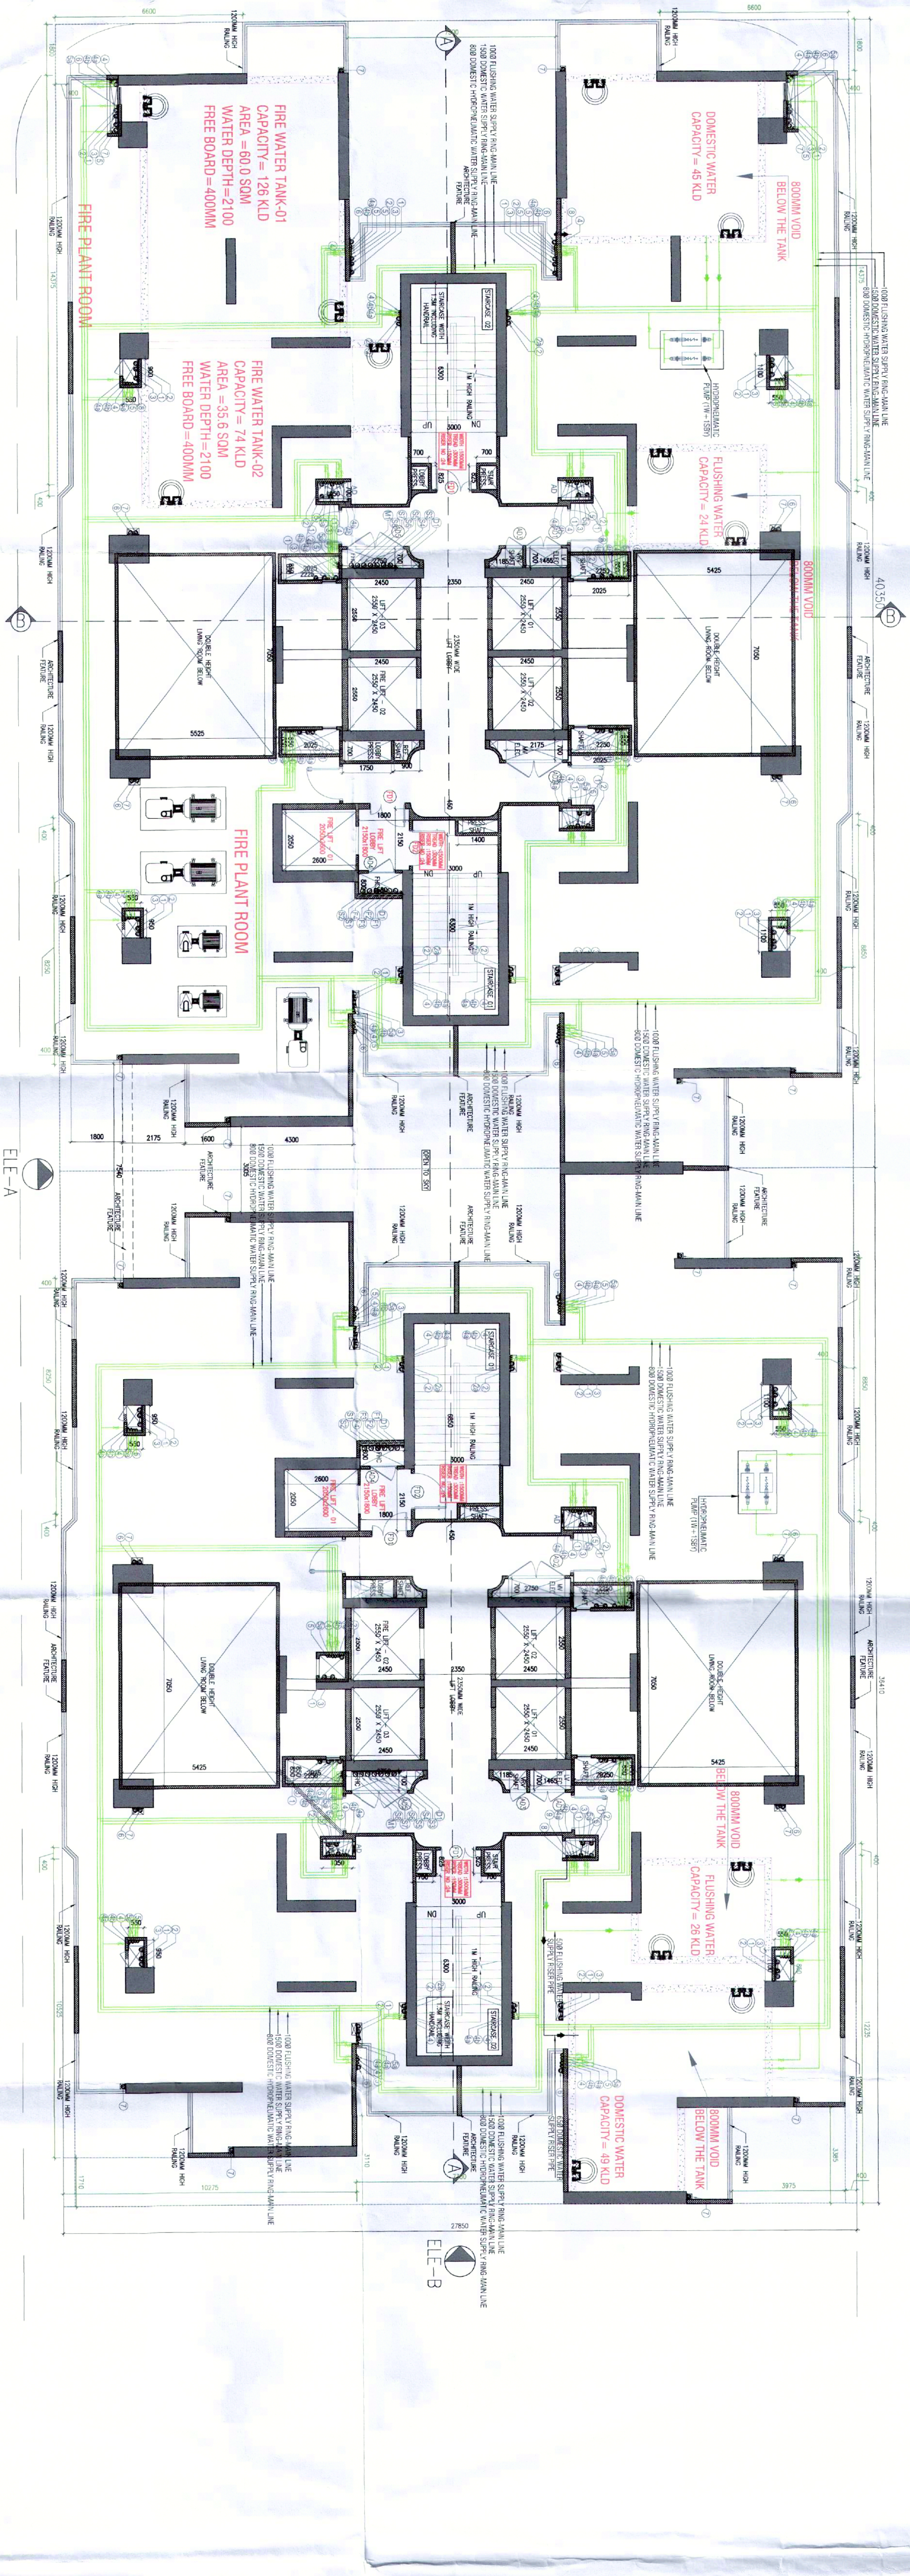

1 TOWER-A-B
1:100 - SERVICE LVL. 41ST FLOOR PLAN

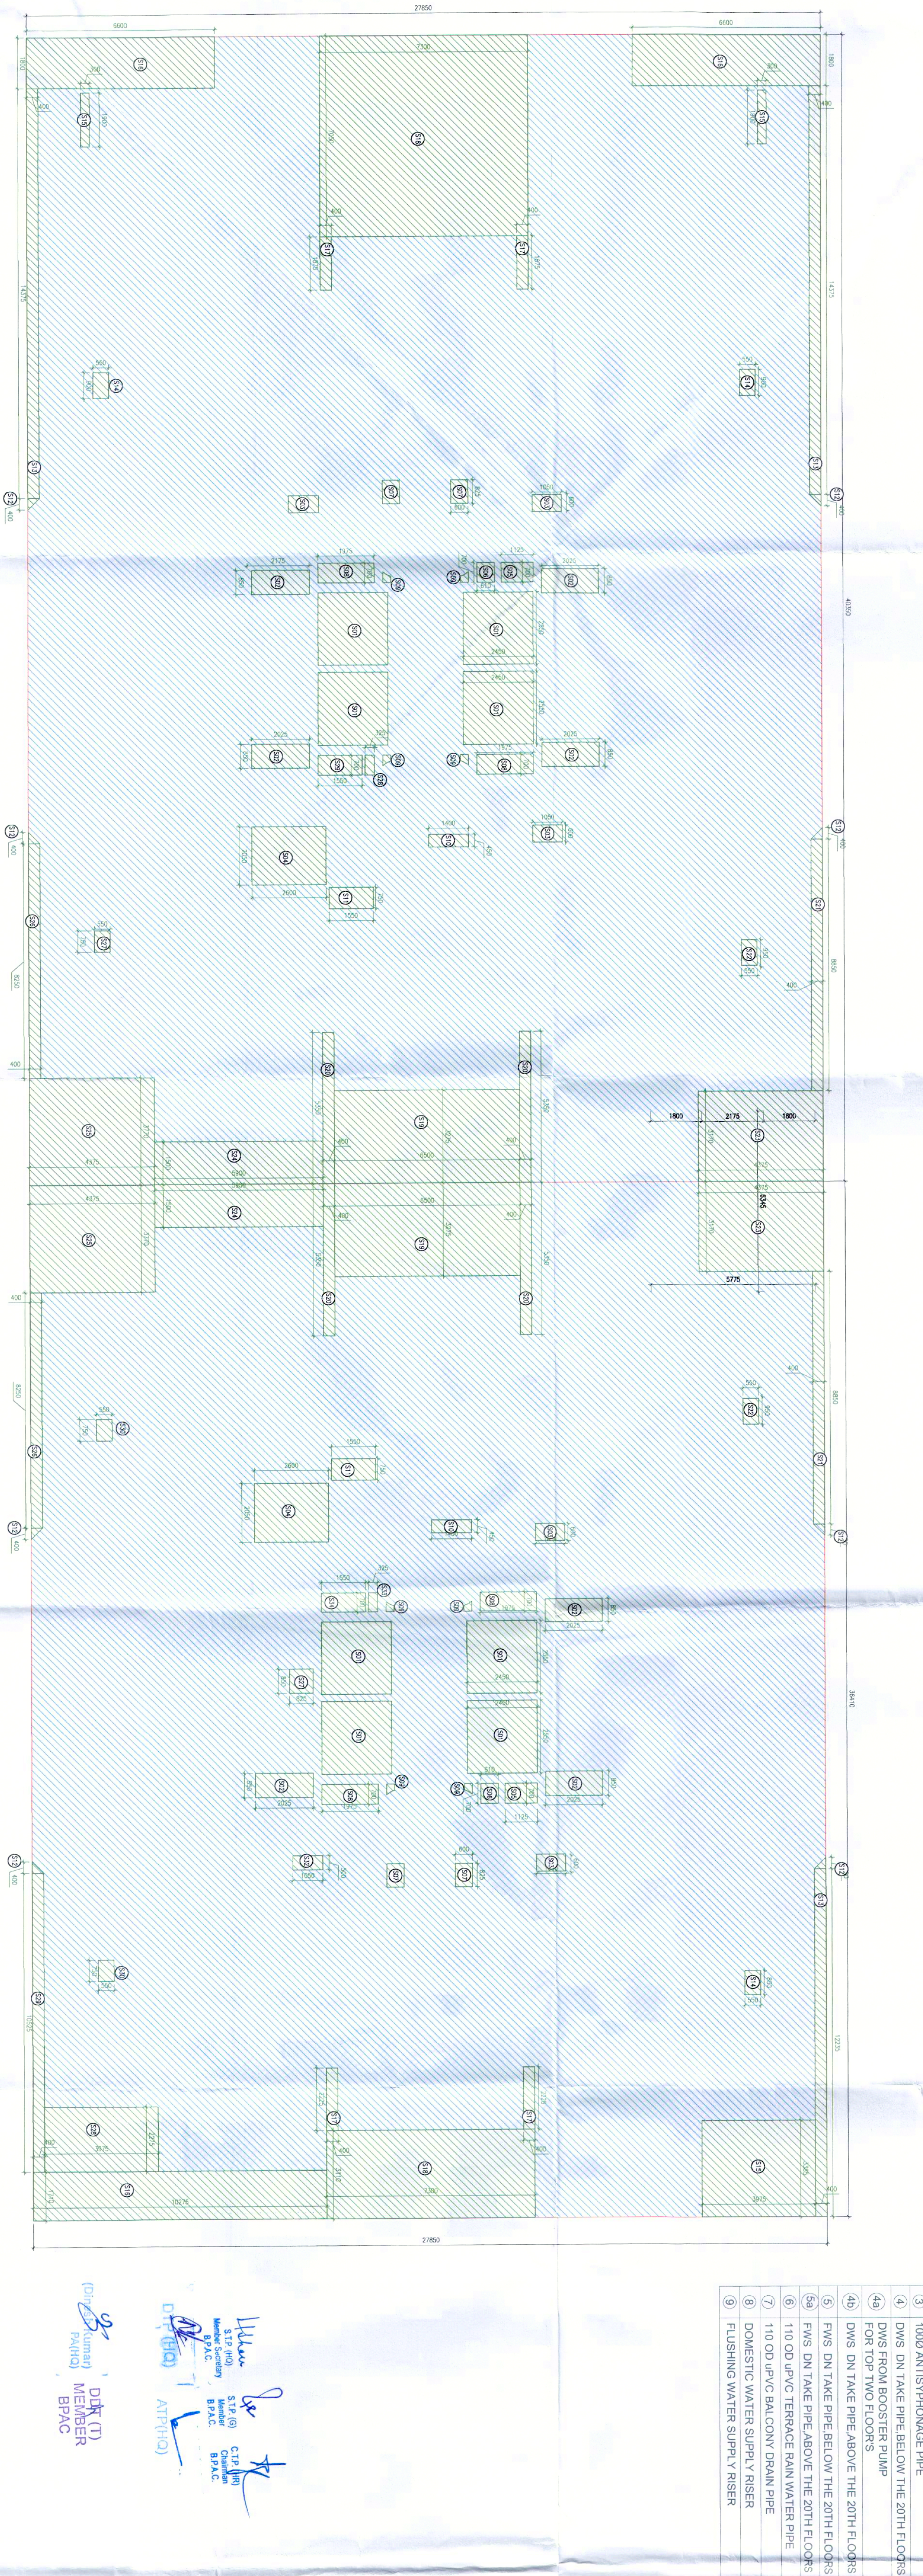

2 TOWER-A-B | AREA DIAGRAM
1:100 - SERVICE LVL. 41ST FLOOR PLAN

TOWER-A			
SERVICES FROM NON-SERVICE AREA			
Description	Length (mm)	Breadth (mm)	Total Area (sqm)
Area of rectangle A17	4000	2700	11227.5
Total of all Additions A			
11227.5			

TOWER-B			
SERVICES FROM NON-SERVICE AREA			
Description	Length (mm)	Breadth (mm)	Total Area (sqm)
Area of rectangle A17	3610	2700	10141.5
Total of all Additions B			
10141.5			

Plumbing Legend:


- 1000 SOIL PIPE
- 1000 WASTE PIPE
- 1000 ANTI-SIPHONAGE PIPE
- DWS ON TAKE PIPE BELOW THE 20TH FLOORS
- DWS FROM BOOSTER PUMP
- FWS ON TAKE PIPE ABOVE THE 20TH FLOORS
- FWS ON TAKE PIPE ABOVE THE 20TH FLOORS
- 110 OD UPVC TERRACE RAIN WATER PIPE
- 110 OD UPVC BALCONY DRAIN PIPE
- DOMESTIC WATER SUPPLY RISER
- FLUSHING WATER SUPPLY RISER

Rough Opening Schedule			
Tags	Width	Height	Remarks
D1	1200	2400	0
D2	1050	2400	0
D3	850	2400	0
D4	850	2400	0
D5	750	2400	0

PROJECT TITLE
RIVERGAY INFRASTRUCTURE PRIVATE LIMITED

ARCHITECT
RIVERGAY INFRASTRUCTURE PRIVATE LIMITED

DATE
05.09.2024

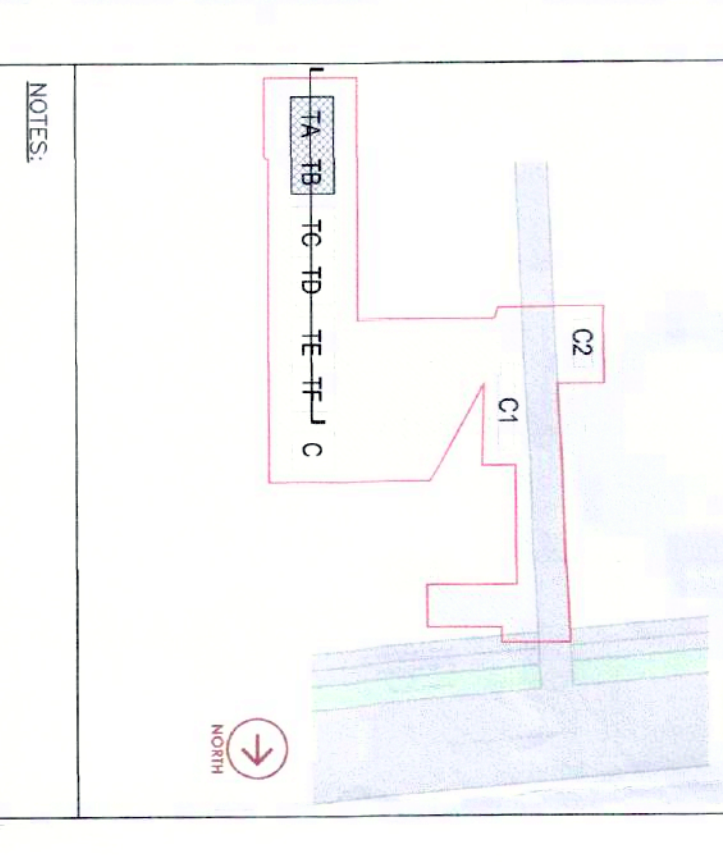

DRAWING NO. S-18

SCALE: 1:100
DATE: 05.09.2024
DRAWING NAME: S-PLAN-06