


60 M WIDE SECTOR ROAD

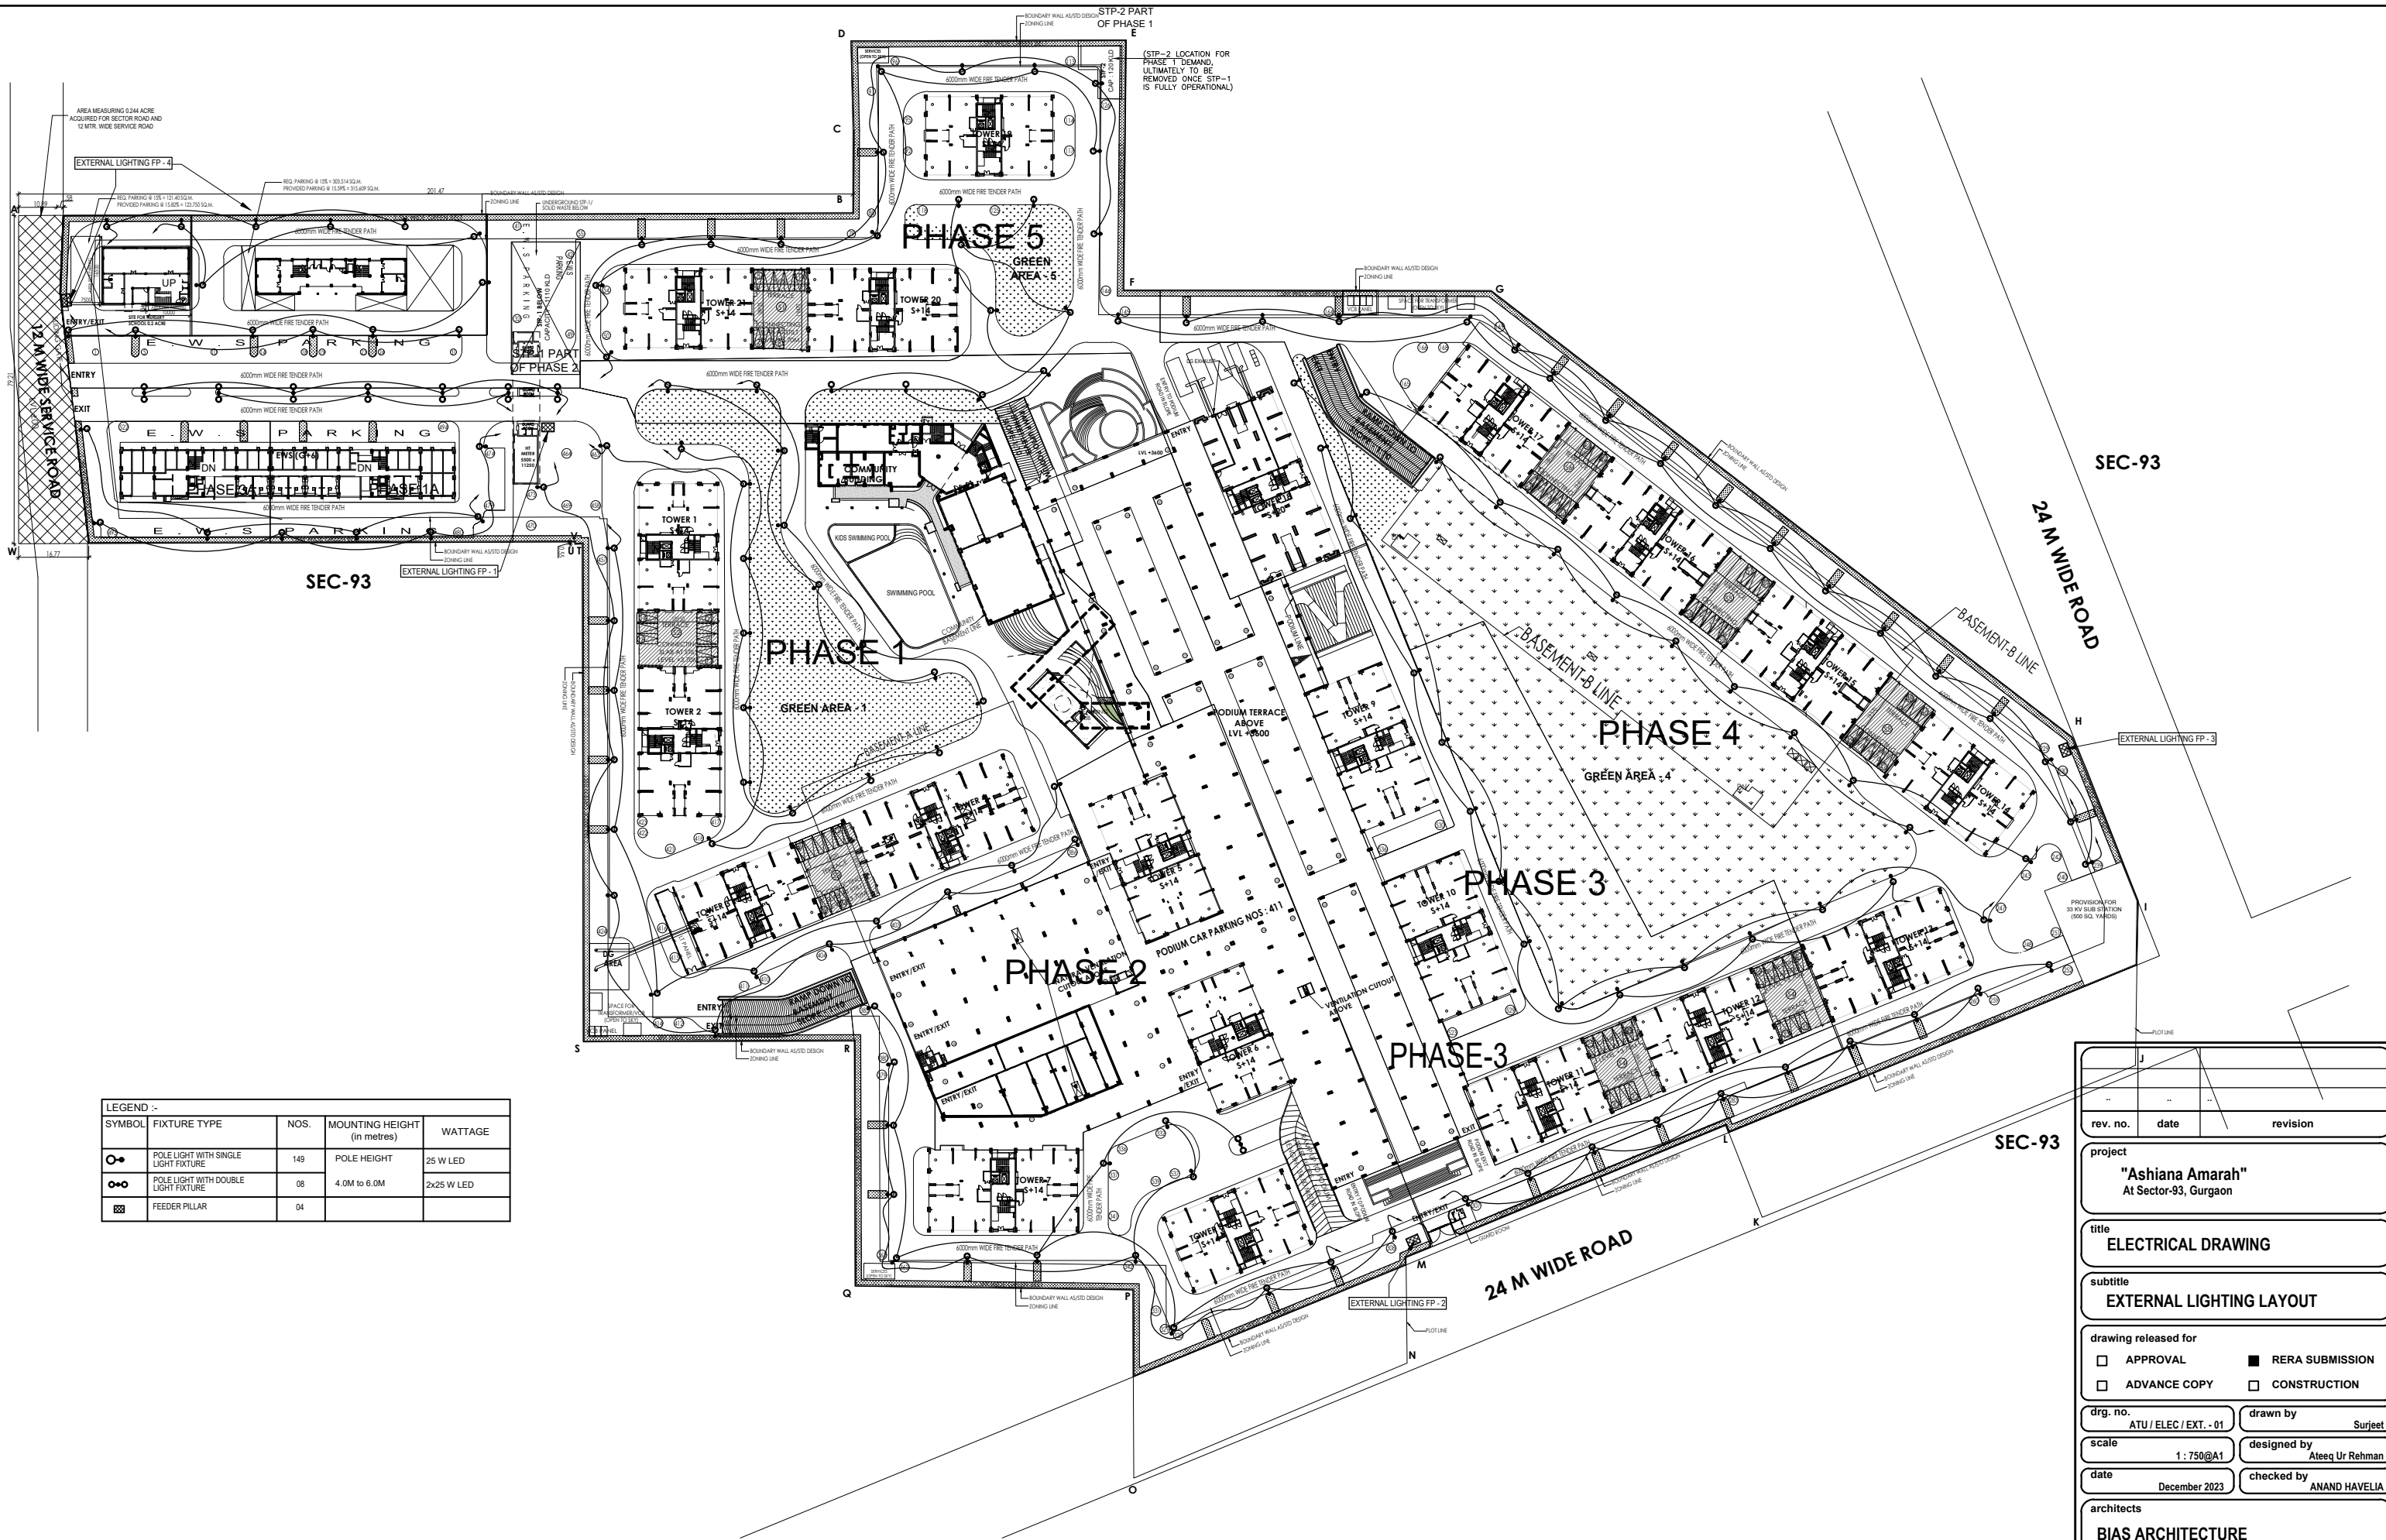

LEGEND :-				
SYMBOL	FIXTURE TYPE	NOS.	MOUNTING HEIGHT (in metres)	WATTAGE
	POLE LIGHT WITH SINGLE LIGHT FIXTURE	149	POLE HEIGHT	25 W LED
	POLE LIGHT WITH DOUBLE LIGHT FIXTURE	08	4.0M to 6.0M	2x25 W LED
	FEEDER PILLAR	04		

rev. no.	date	revision
project "Ashiana Amarah" At Sector-93, Gurgaon		
title ELECTRICAL DRAWING		
subtitle EXTERNAL LIGHTING LAYOUT		
drawing released for ☐ APPROVAL ☒ RERA SUBMISSION ☐ ADVANCE COPY ☐ CONSTRUCTION		
drg. no. ATU / ELEC / EXT. - 01		drawn by Surjeet
scale 1 : 750@A1		designed by Ateeq Ur Rehman
date December 2023		checked by ANAND HAVELIA
architects BIAS ARCHITECTURE 502, Tower No. 12, Commonwealth Games Village, New Delhi 110 092, India t : +91 11 2121 1603/606 www.biasarchitecture.com		
services consultant Consummate Engineering Services (P) Ltd. Noida Office : B - 67, Sector - 67, Noida - 201 301 Tel : (0120) 2303500 (24 Lines) Lik. Office : R 006, Rohitas Plumeria, Gomti Nagar, Lucknow e mail : mail@cespl.in, website : www.cespl.in		