




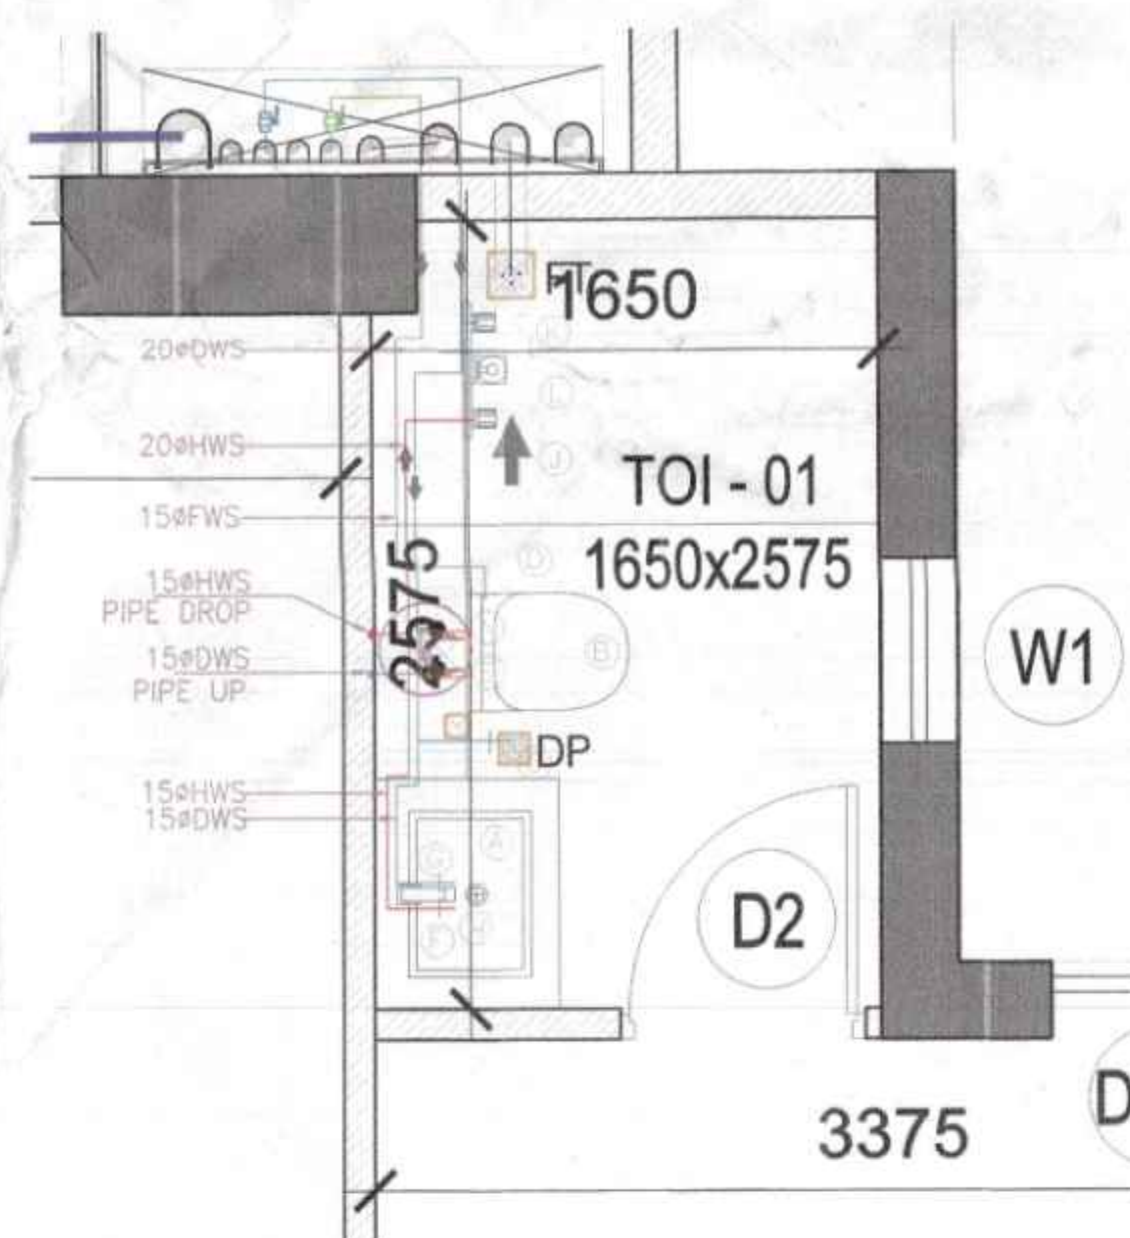


1 TOILET 1 - WATER SUPPLY LAYOUT
1:25

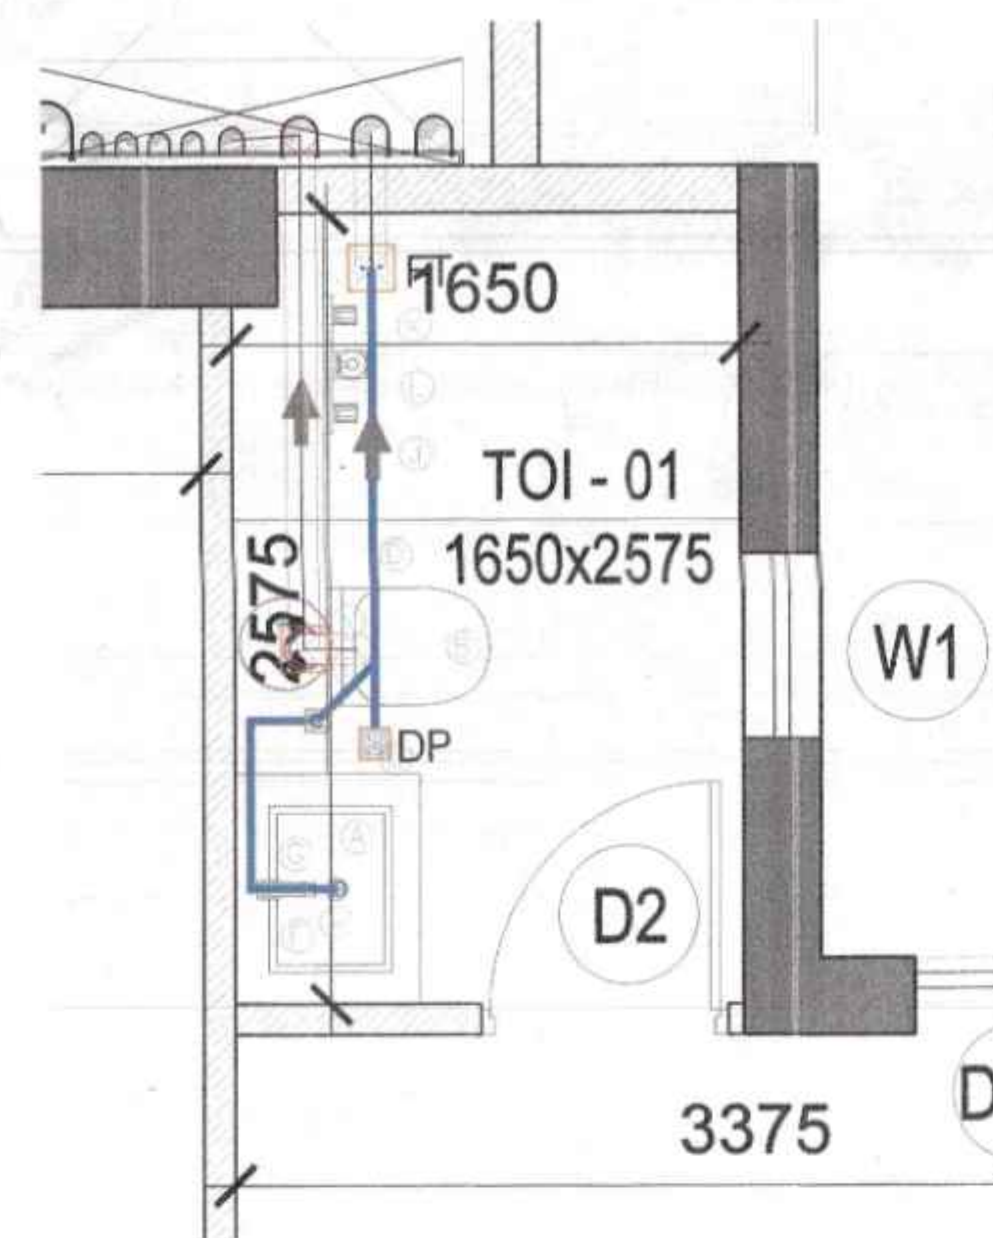


1 TOILET 1 - DRAINAGE LAYOUT
1:25

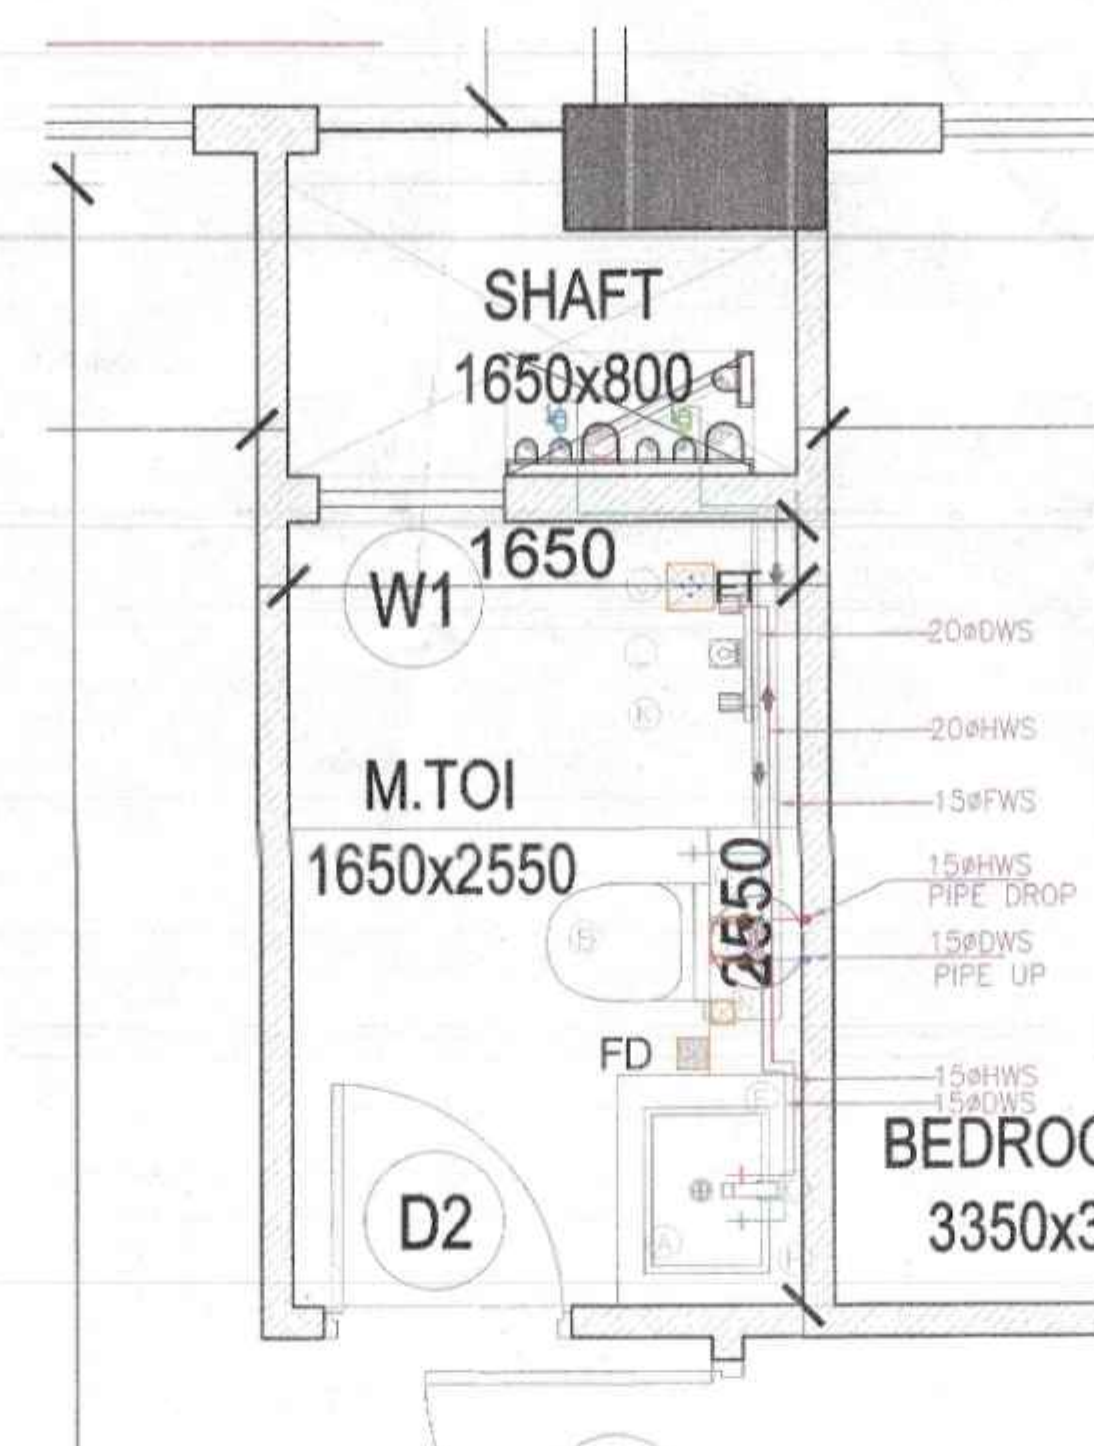


3 TOILET 3 - WATER SUPPLY LAYOUT
1:25

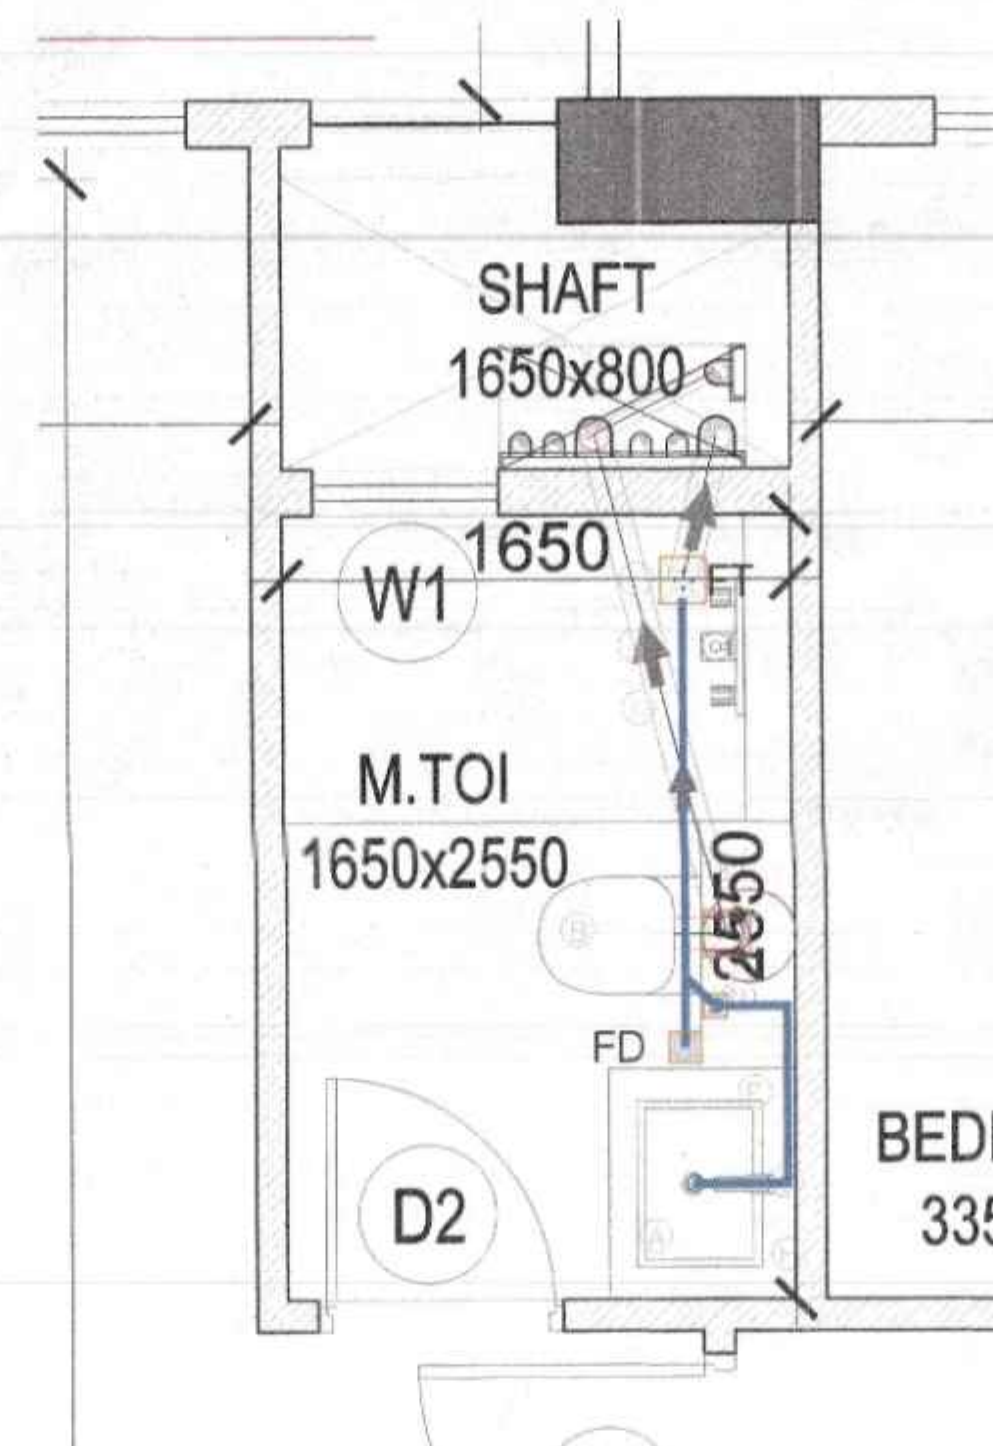


3 TOILET 3 - DRAINAGE LAYOUT
1:25

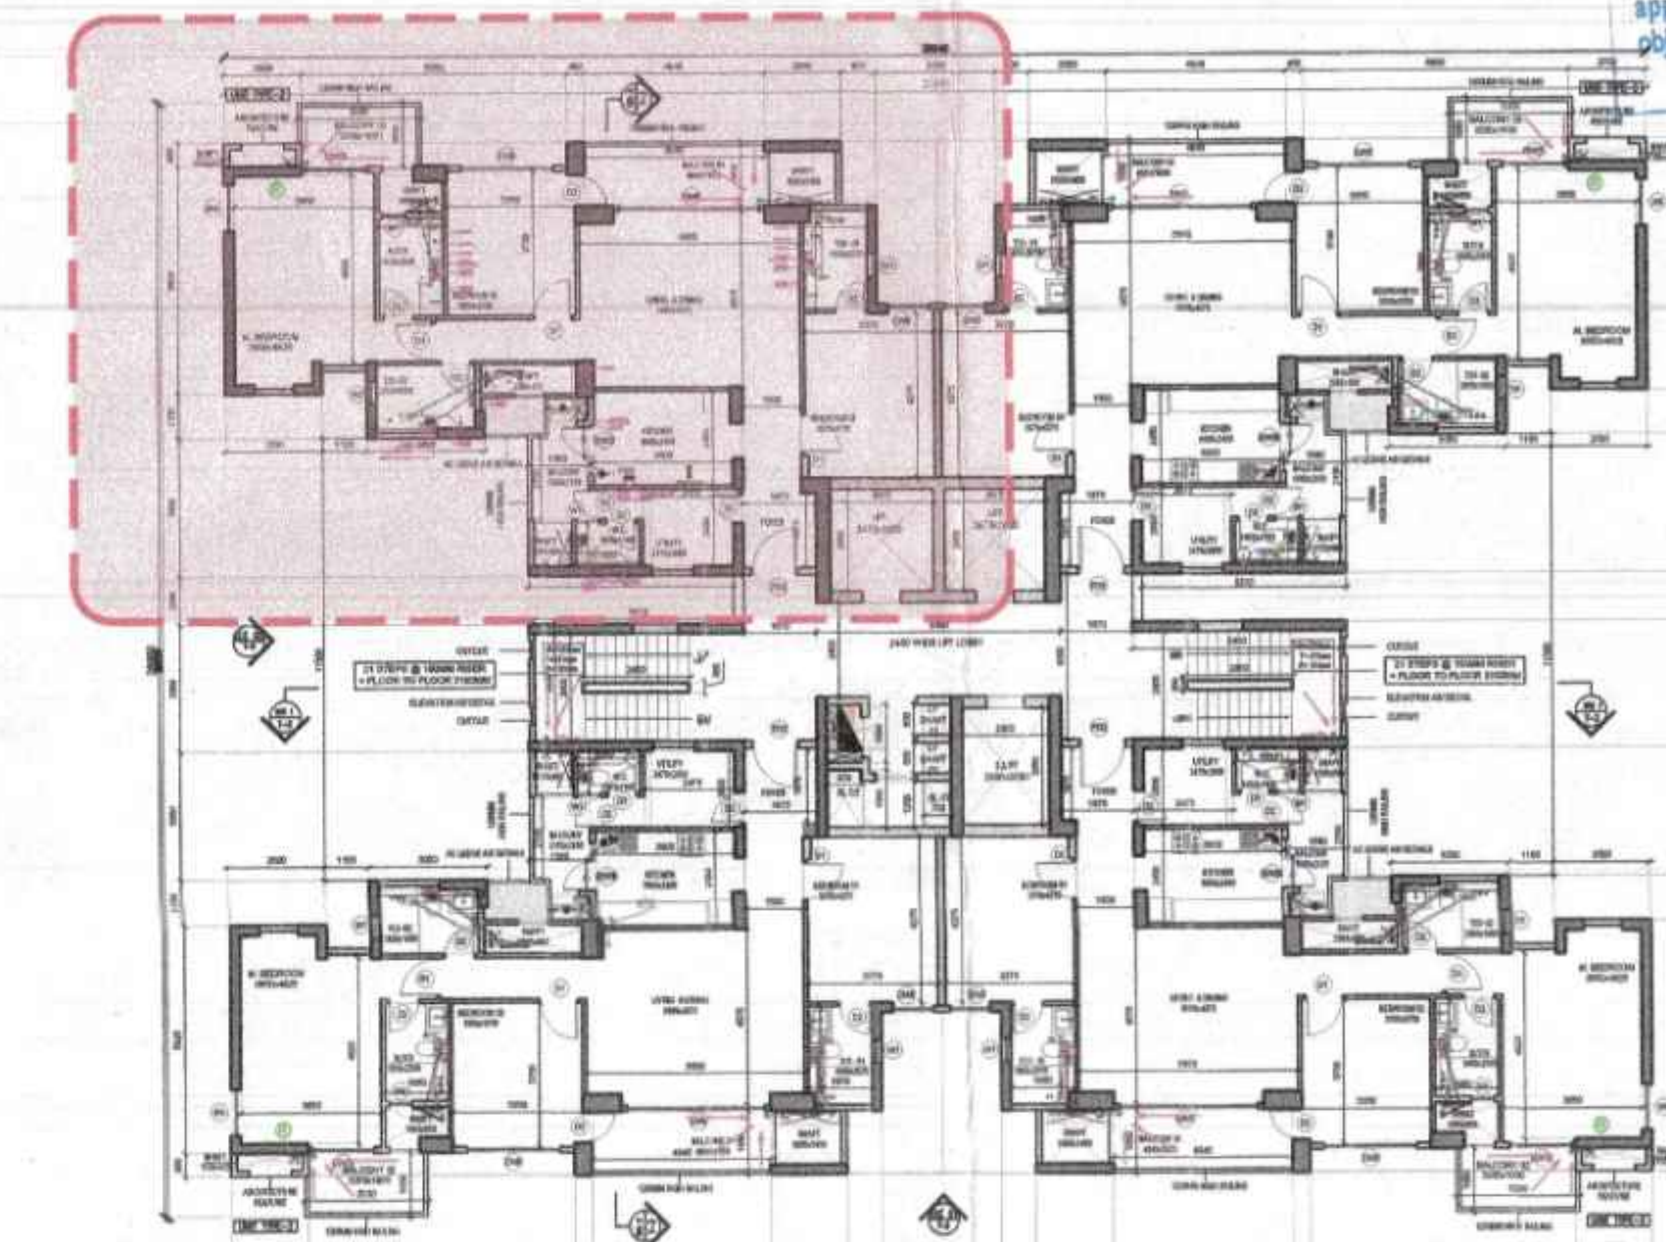


1 TOWER 3,4 - TYPICAL FLOOR PLAN
1:200

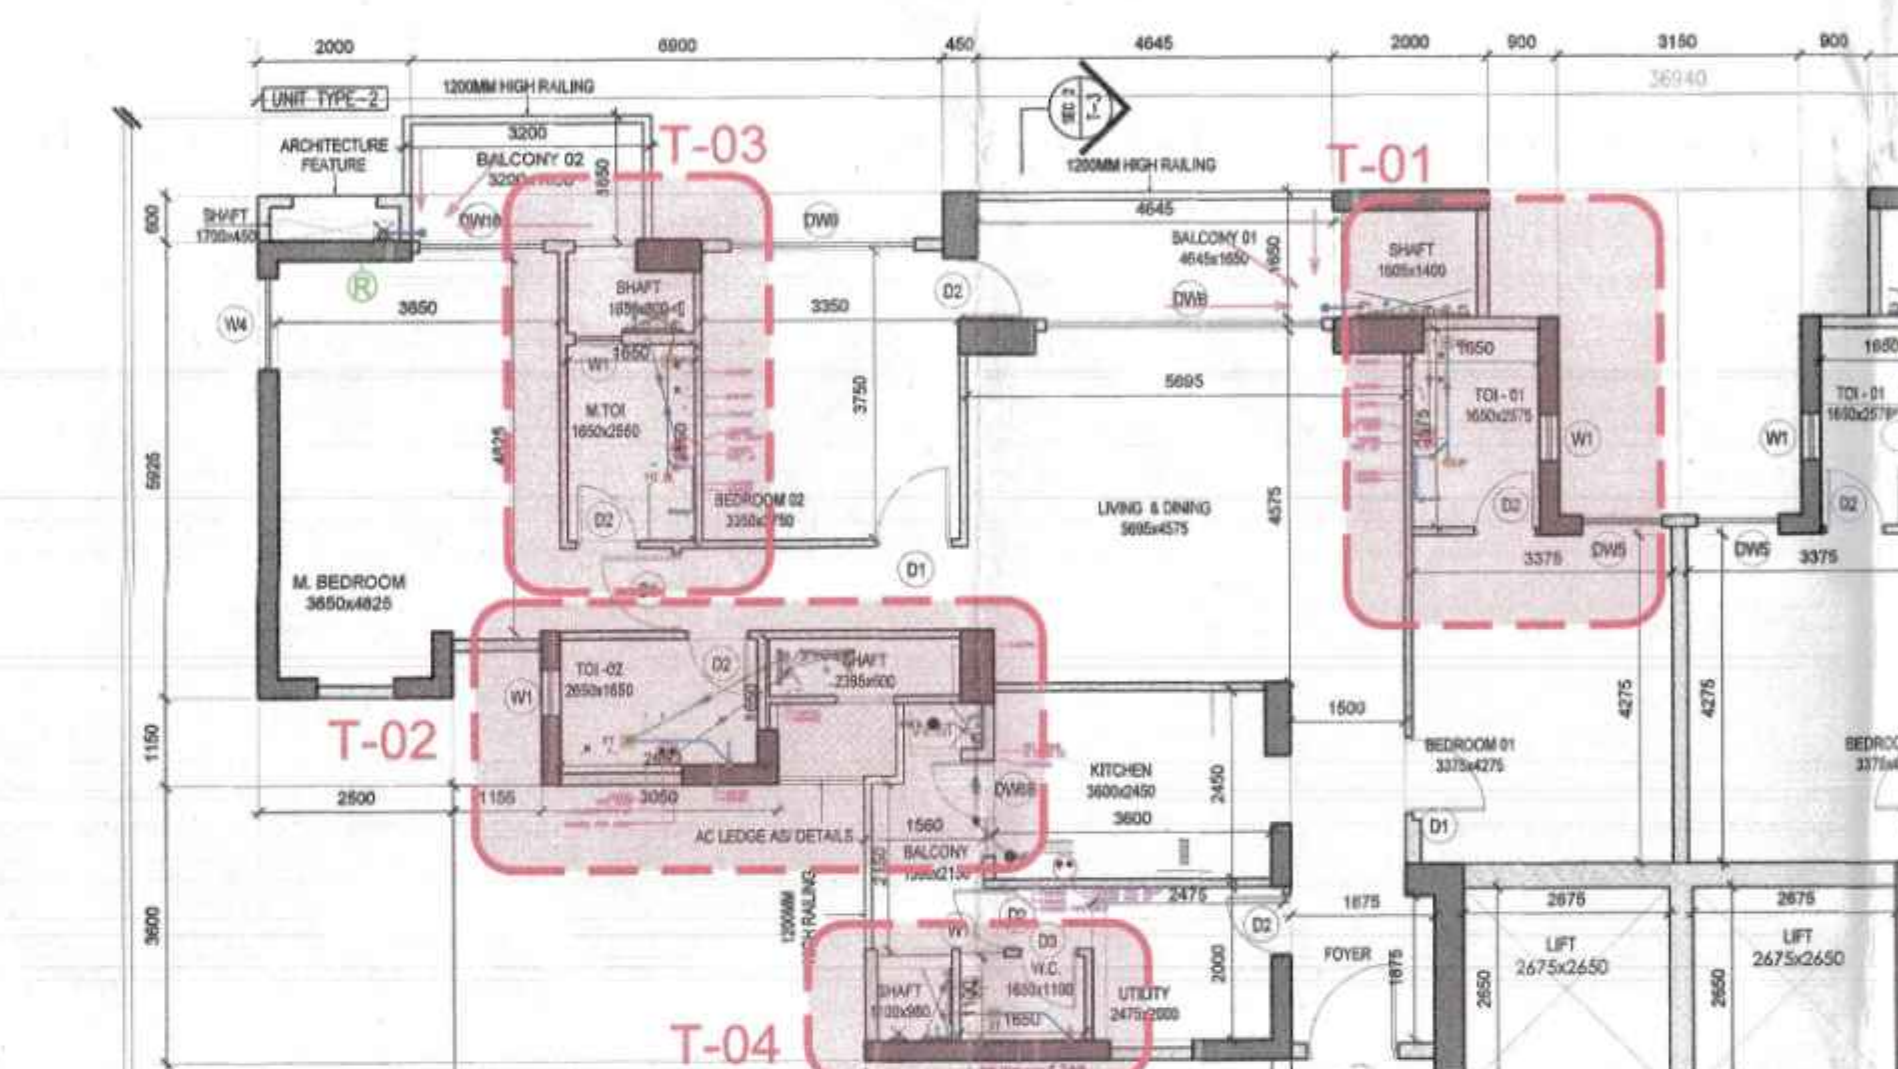


1 TOWER 3,4 - TYPICAL UNIT
1:100

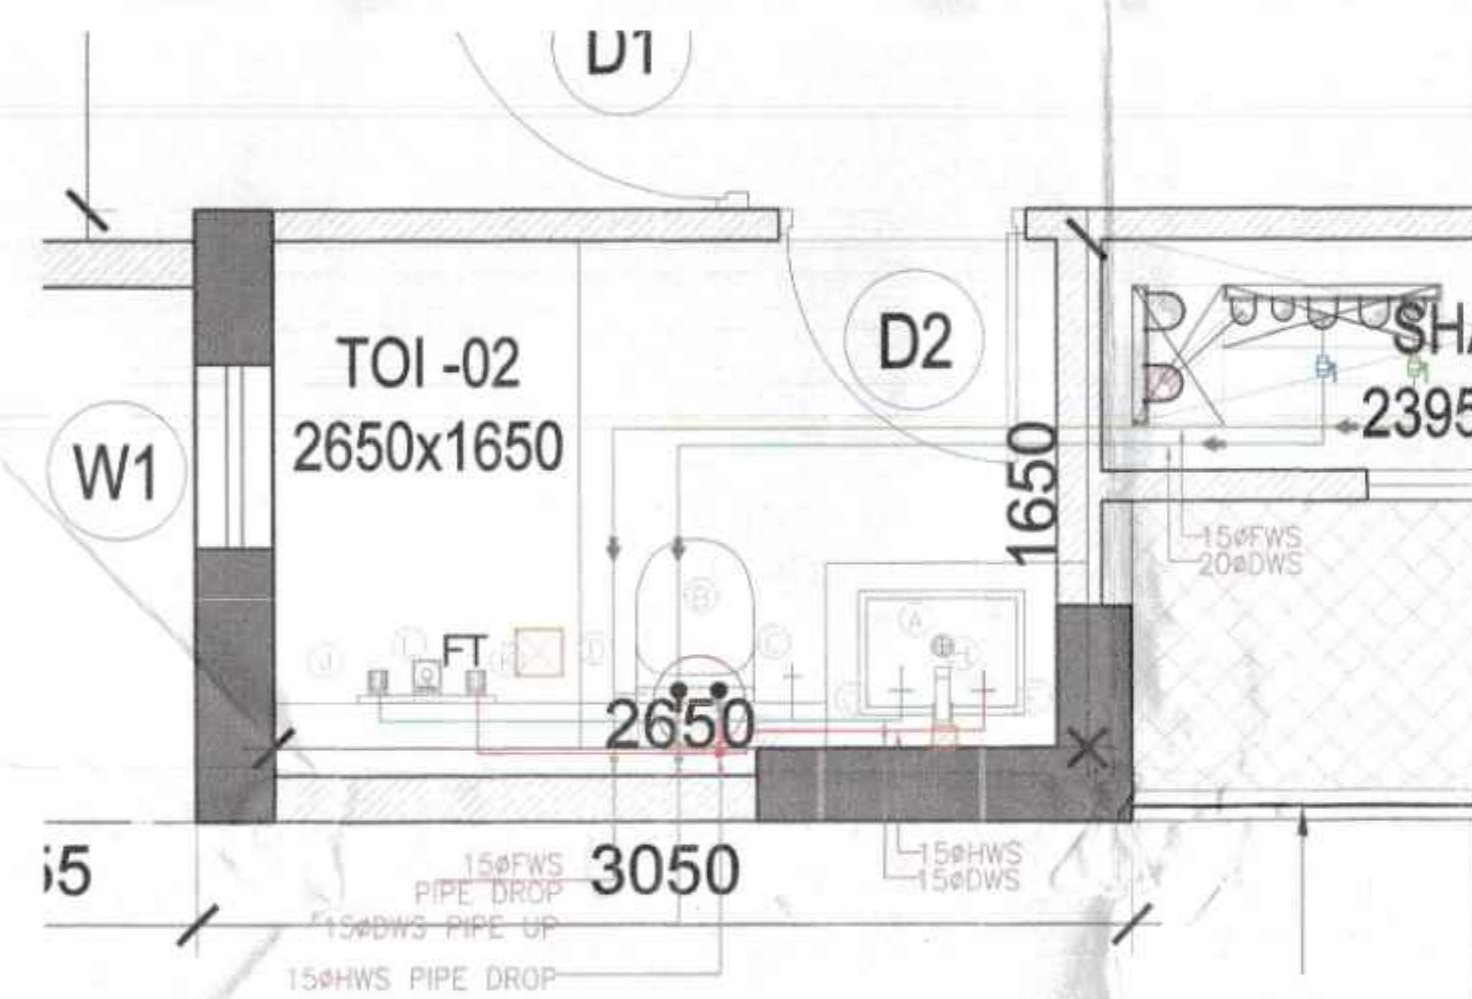


2 TOILET 2 - WATER SUPPLY LAYOUT
1:25

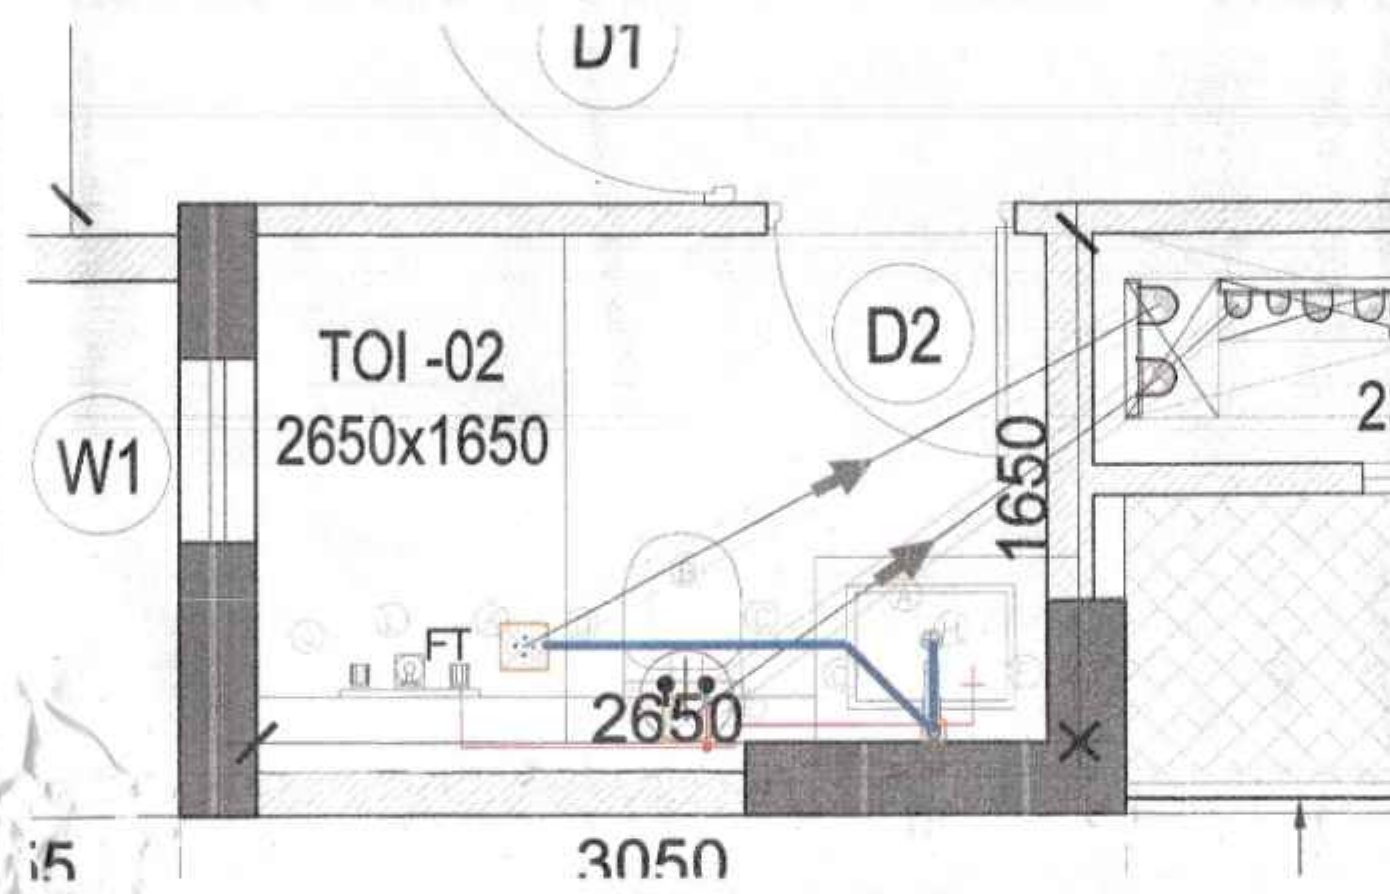

2 TOILET 2 - DRAINAGE LAYOUT
1:25

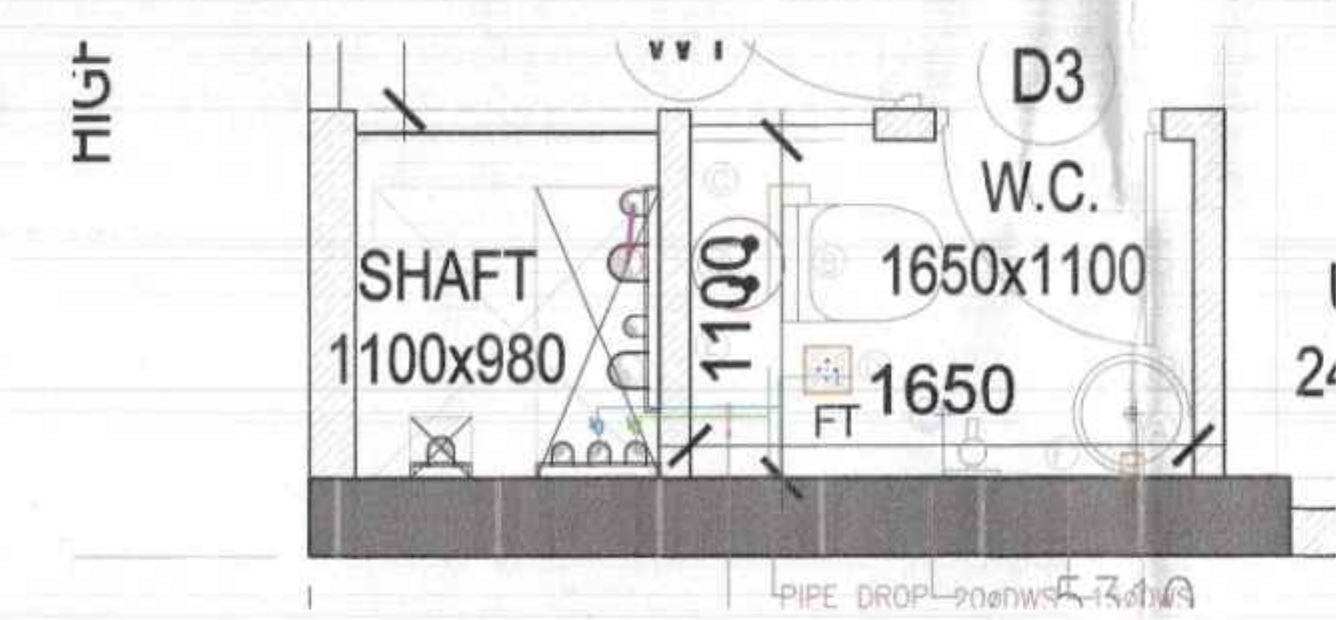

4 TOILET 4 - WATER SUPPLY LAYOUT
1:25

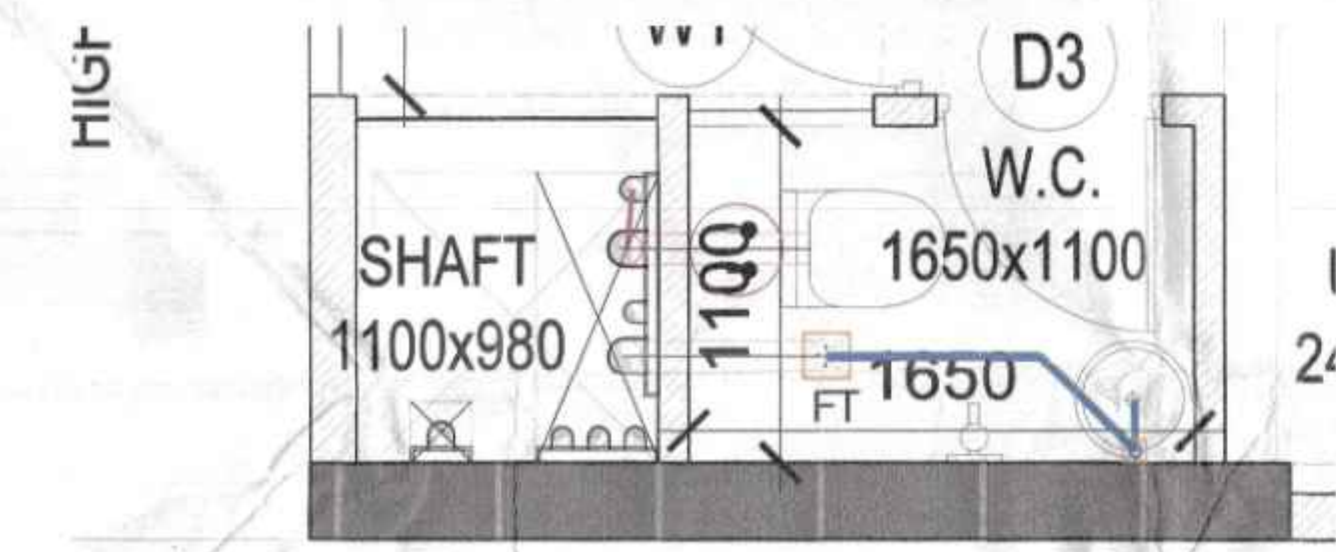

4 TOILET 4 - DRAINAGE LAYOUT
1:25

TYPICAL TOILET FINISHES				
NO.	USAGE	ITEM NAME / CODE	BRAND	SIZE
15	Counter/Top	Granite	-	Stone
16	Flooring	Antiskid Vitrified Tile	-	600 x 600
17	Dado	Vitrified Tile	-	600 x 300
18	Dado	Vitrified Tile	-	600 x 300
19	Wall Paint	O.B.D	-	-

TYPICAL TOILET FIXTURES		
Tag	Description	Make and Model
A	Wash Basin (W.B.)	As / Selection
B	Water Closet (W.C.)	As / Selection
C	Toilet Paper Holder (T.P.H.)	As / Selection
D	Health Faucet (H.F.)	As / Selection
E	Top Mounted Flush Plate (F.P.)	As / Selection
F	Mirror	As / Selection
G	Mirror Lights (M.L.)	As / Selection
H	Wash Basin Mixer	As / Selection
I	Floor Trap (F.T.)	As / Selection
J	Head Shower (H.S.)	As / Selection
K	Diverter	As / Selection
L	Bath Spout	As / Selection
M	Floor Drain (F.D.)	As / Selection
N	Geyser	As / Selection

PLUMBING LEGEND	
1	110 OD SOIL PIPE
2	110 OD WASTE PIPE
3	75 OD ANTI VENT PIPE
4	DOMESTIC WATER SUPPLY PIPE
5	FLUSHING WATER SUPPLY PIPE
6	DOMESTIC WATER RISER PIPE TO OHT
7	FLUSHING WATER RISER PIPE TO OHT
8	110 OD RAIN WATER PIPE
FT	FLOOR TRAP CUTOFF
FD	FLOOR DRAIN
BD	BALCONY DRAIN
MT	MULTI FLOOR TRAP
FCD	FLOOR CLEAN OUT PLUG

PIPE CONNECTION DIA :-	
WC TO TO STACK	110 OD uPVC SOIL PIPE
URINAL BASIN TO UT	50 OD uPVC SOIL PIPE
UT TO STACK	110 OD uPVC SOIL PIPE
WASH BASIN TO FT	40 OD uPVC WASTE PIPE
FT TO STACK	110 OD uPVC WASTE PIPE
FD TO FT	63 OD uPVC WASTE PIPE
SINK TO FT	50 OD uPVC WASTE PIPE

PIPE SLOPE TABLE :-	
160 OD SOIL & WASTE PIPE	SLOPE - 1:100
110 OD SOIL & WASTE PIPE	SLOPE - 1:70

Checked and found ok for Public Health
(Internal) Service only subject to comments in
in forwarding letter to 19/5/15. Dt. 14/4/23

SUBMISSION DRAWINGS

FOR APPROVAL AND STAMPING
S.T.P. (H) S.T.P. (G) C.T.P. (H)
Member Secretary Member Secretary
B.P.A.C. B.P.A.C. B.P.A.C.

D.T.P. (H) D.T.P. (T) A.T.P. (H)
MEMBER MEMBER
B.P.A.C. B.P.A.C.

(Dinesh Kumar)
PA(HQ)

NOTES:

ARCHITECT

MORPHOGENESIS
41, Industrial Estate, Okhla Phase - III,
New Delhi 110020
TEL: 91 11 41828070
E Mail: studio@morphogenesis.org

CONSULTING STRUCTURAL ENGINEER

DUCON
CONSULTANTS PRIVATE LIMITED
A-34, 3rd FLOOR, SAFAL, PROPTUNE,
CORPORATE ROAD, RAJOKHARA, GATE NO. 1,
PRAJAPATI NAGAR, NEW DELHI - 110028
PH: 78-4007318, 98705048, 98705048

CONSULTING MEP

AEON Integrated Building Design Consultant LLP
A-122, 6th Floor, Sector 134, Noida, U.P. 201 308,
www.aeonconsultants.in

CONSULTING LANDSCAPE ARCHITECT

ORACLE

G-98, Kalkaji,
New Delhi - 110019
Ph.: +91-11-26481830

KEY PLAN



PROJECT

Revised Building Plan of Group Housing Colony
measuring 14.025 Acres (Licence No.285, of 2007
dated 02-12-2007) in sector 62, Gurgaon Manesar
Urban Complex, being developed by Juhl Promoters
Pvt Ltd & others in collaboration with Emaar MGF
Land. Ltd.

DEVELOPER

Emaar India Ltd.

EMAAR Business Park, MG Road
Skanderpur, Sector-28, Gurgaon
Haryana - 122002

EMAAR

DEVELOPER'S SIGNATURE :

AUTHORIZED SIGNATORY

ARCHITECT'S SIGNATURE :

DRAWING NAME

TOWER 3 & TOWER 4
TYPICAL FLOOR TOILET DETAILS

DRAWING NO.

S-45

SCALE

As Mentioned

DATE

AUG 2023

NORTH

