


(GYMLOBBY: 400 SQM / 1 person / 1.4 sqm) = 286 persons	
(MEETING ROOM-3: 950QM / 1 person / 1.4 sqm) = 35 persons	
(MEETING ROOM-2: 750QM / 1 person / 1.4 sqm) = 54 persons	
(MEETING ROOM-1: 44 SQM / 1 person / 1.4 sqm) = 31 persons	
(MULTIPURPOSE HALL-1: 750QM / 1 person / 1.4 sqm) = 54 persons	
(KIDS' PLAY LOUNGE + CRECHE: 905QM / 1 person / 1.4 sqm) = 64 persons	
(CIRCULATION SPACE, STORAGE AND OFFICE: 850SQM / 1 person / 06 sqm) = 142 persons	
TOTAL	666 persons

Required staircase width @ 10mm/person for 666 persons = 6660 mm i.e. MINIMUM 7000 MM.

S/NO	Door T/s	Result Opening (W)	SB	Unit	Pre Rating
COMB FIRE DOORS					
1	FD 0	2500	0	2400	2918
2	FD1	1250	0	2400	2918
3	FD2	1250	0	2400	2918
4	FD3	1250	0	2400	2918
5	FD4	1250	0	2400	2918
6	FD5	750	100	2400	2918
7	FD6	1050	100	2400	2918
8	FD7	1050	100	2400	2918
9	FD19	1250	100	2400	2918
10	FD10	900	100	2400	2918
11	FD11	900	100	2400	2918
12	FD12	900	0	2400	2918
EXTERNAL DOORS					
1	ED	1250	0	2400	-
2	ED	1250	0	2400	-
INTERNAL DOORS					
1	CL1	1150	0	2400	-
2	CL2	1700	0	2400	-
3	CL3	2000	0	2400	-
4	CL4	1250	0	2400	-
5	CL5	1250	0	2400	-
6	CL6	1250	0	2400	-
7	CL7	1150	0	2400	-
8	CL8	2000	0	2400	-
EXTERNAL DOORS					
1	OD1	2250	0	3000	-
2	OD1-2	2250	0	3000	-
3	OD1-3	2250	0	3000	-
4	OD1-4	2250	0	3000	-

TOWER - B
ST FLOOR F
LVL+6450

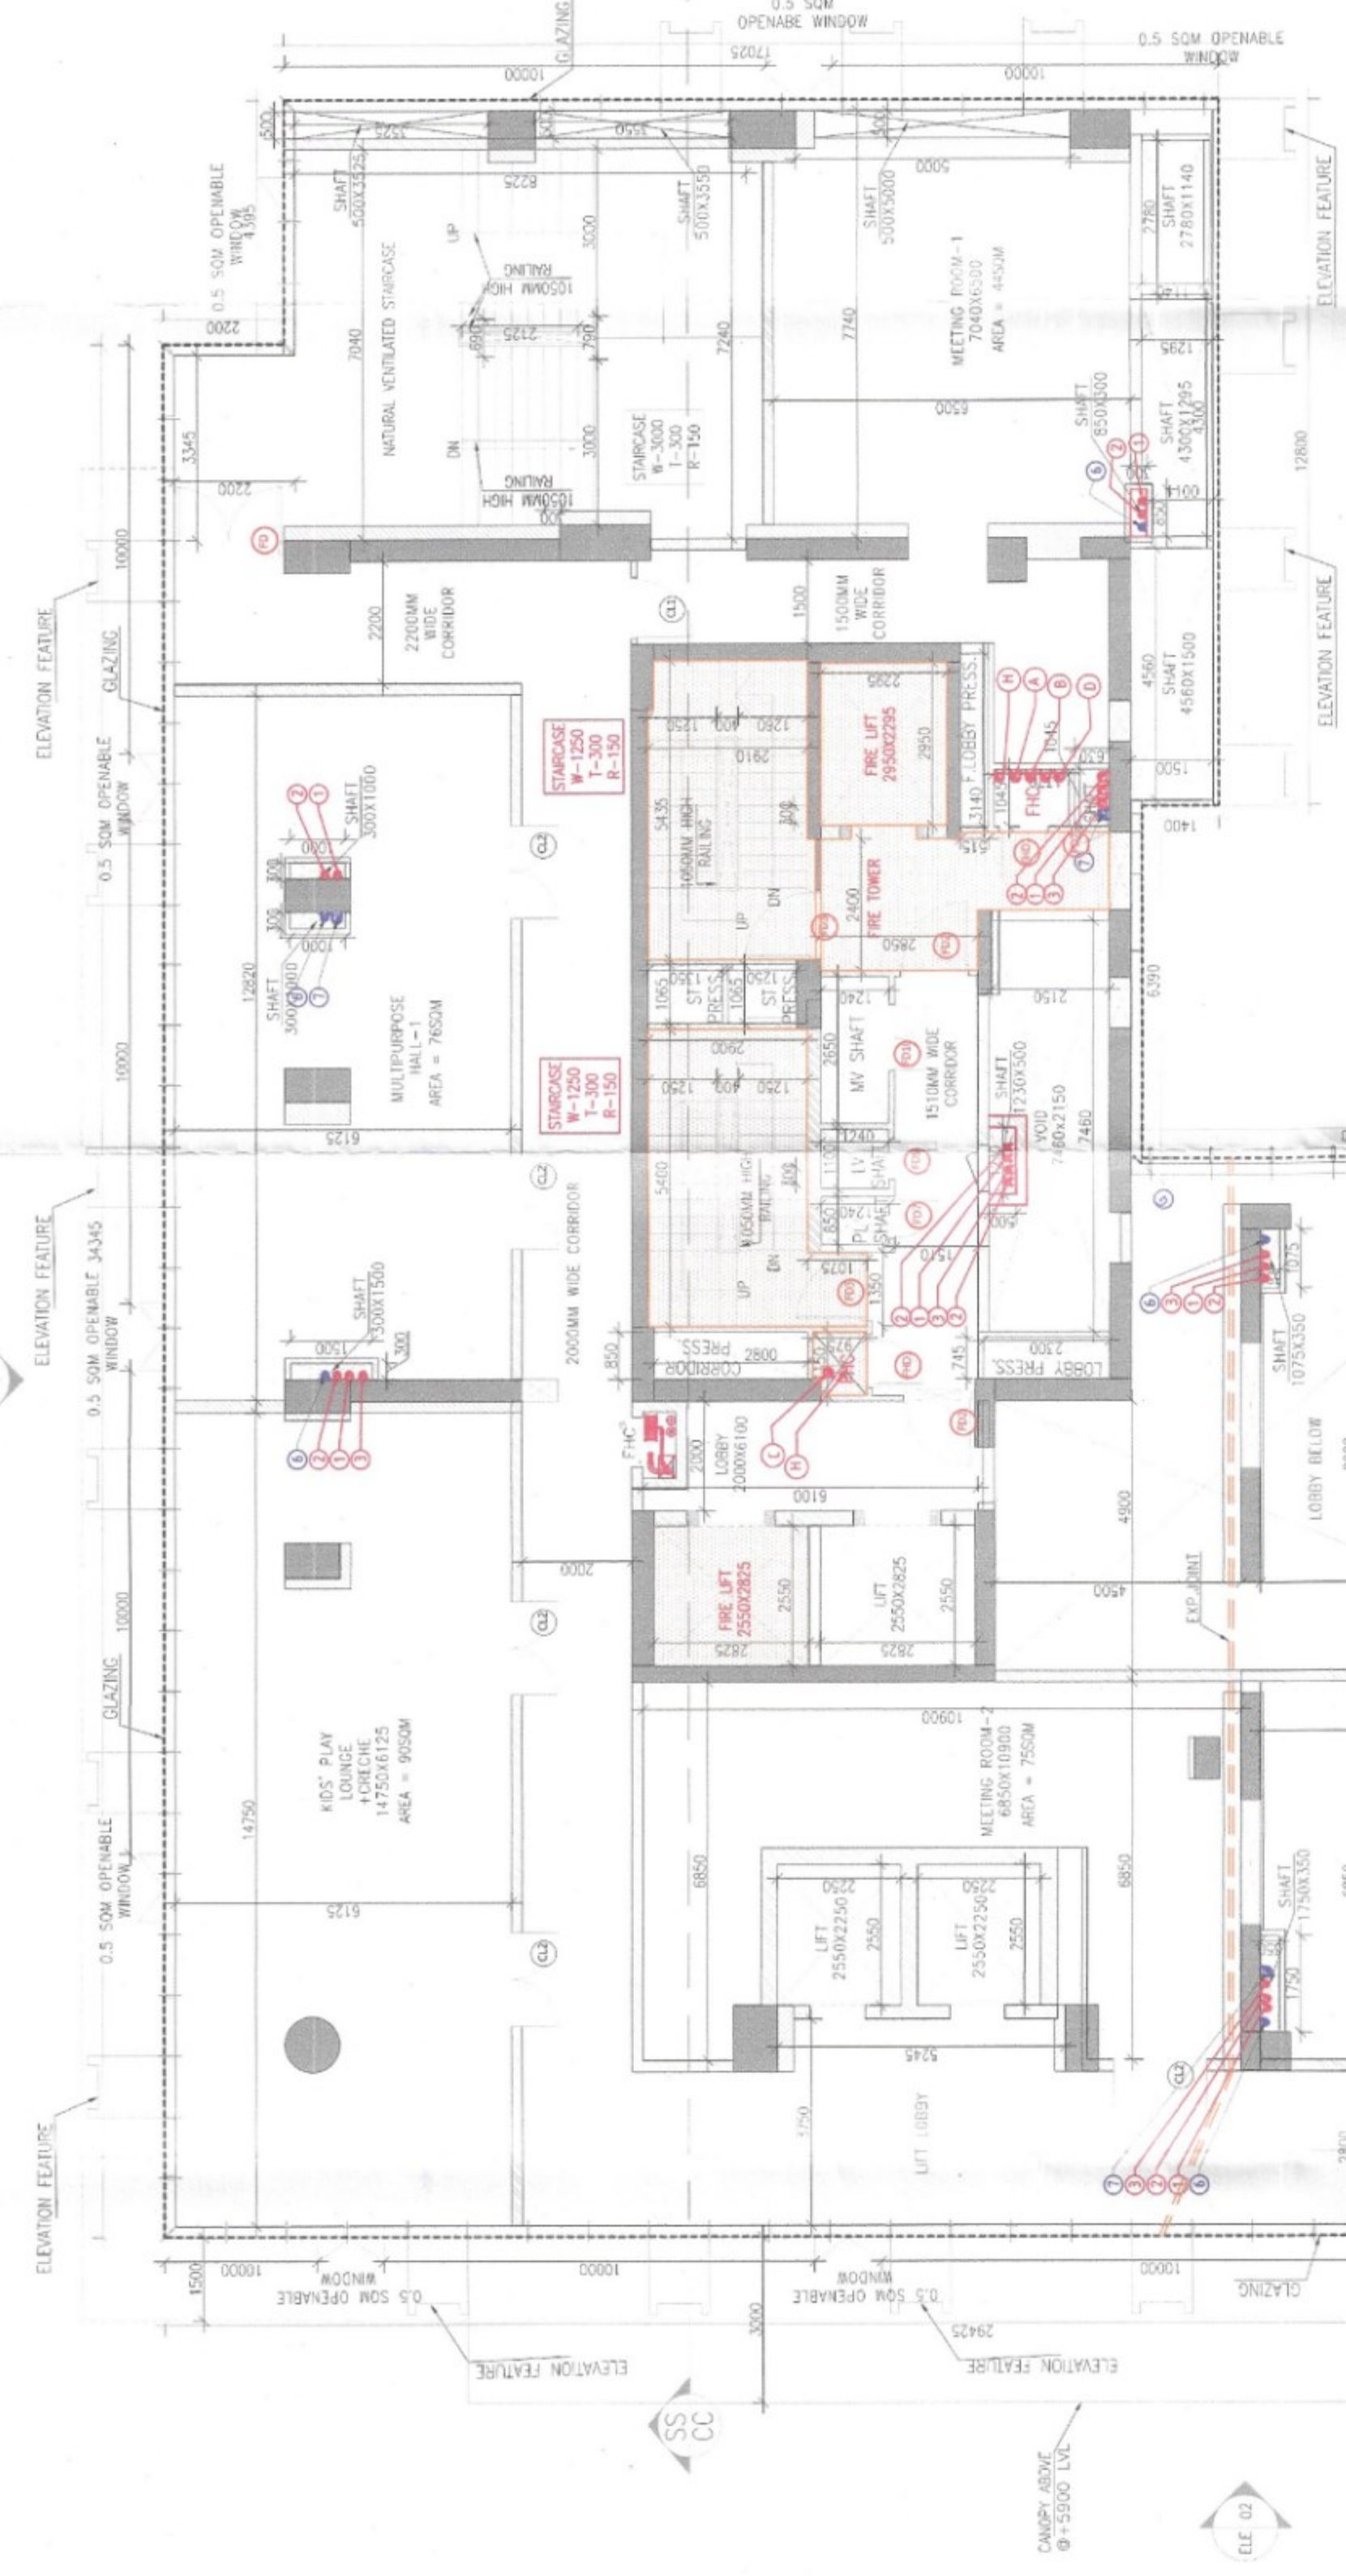

PLUMBING LEGEND -	S/N/O	DESCRIPTION	SYMBOL
	1.	100 ØPVC VERTICAL SOIL & VENT PIPE	
	2.	160 ØUPVC VERTICAL SOIL & VENT PIPE	
	3.	100 ØUPVC VERTICAL WASTE & VENT PIPE	
	4.	160 ØUPVC VERTICAL WASTE & VENT PIPE	
	5.	100 ØUPVC ANTISEPTIC PIPE	
	6.	DOMESTIC WATER SUPPLY PIPE (HYDRO)	
	7.	FLUSHING WATER SUPPLY PIPE (HYDRO)	
	8.	DOMESTIC WATER SUPPLY CUMULATIVE TAKE PIPE	
	9.	90 ØUPVC RAIN WATER PIPE	
	10.	160 ØUPVC RAIN WATER PIPE FOR TERRACE	
	11.	DOMESTIC WATER SUPPLY RISER PIPE	
	12.	DOMESTIC WATER SUPPLY	
	13.	FLUSHING WATER SUPPLY	
	14.	HOT WATER SUPPLY	
	15.	GARDEN HYDRANT SUPPLY	
	16.	EXTERNAL STORM WATER LINE	
	17.	EXTERNAL SEWAGE LINE	
	18.	SEWAGE MANHOLE	
	19.	STORM WATER MANHOLE	
	20.	GARDEN HYDRANT	

NOTES:
AIR CONDITIONING SYSTEM IS BEING PROVIDED. MECHANICALLY VENTILATED AND CENTRALLY AIR CONDITIONED WITH POWER BACK-UP.
TOILETS ARE MECHANICALLY VENTILATED.
ALL UTLS SHALL HAVE POWER BACK-UP.
ALL ELECTRICAL INSTALLATION SHALL BE AS PER FIRE/FIGHTING/SAFETY PROVISIONS WILL BE AS PER RELEVANT CODE PROVISIONS.
PER RELEVANT CODE SHALL HAVE MECHANICALLY VENTILATED AS PER RELEVANT CODE.
ALL DUCTS ARE VENTILATED AS PER HARYANA BUILDING CODE 2017.
THE SPINNAWATER SYSTEM WHEREVER REQUIRED BY RELEVANT CODE.
BUILDING WILL BE DESIGNED/STRUCTURES AS PER RELEVANT STANDARDS FOR DISASTER RESISTANCE.
ALL STRUCTURES SHALL BE PROVIDED AS PER HARYANA ZONING NORMS.
ALL UNPAID RAMP WITH RAILING.
ALL PER FIGHTING INSTALLATION SHALL BE AS PER RELEVANT CODE.
THE SPINNAWATER HARVESTING SYSTEM SHALL BE PROVIDED AS PER RELEVANT GROUND WATER AUTHORITY NORM.

OBJECT

BUILDING PLAN OF G.H. SITE NO.1
IN SECTOR-42 GURUGRAM

TNER

M/s Experion Developers Pvt. Ltd.
(Formerly M/s Gold Developers Pvt. Ltd)
8th Floor, Milestone Experion Centre, Sector 15(Part-2),
Gurgaon, Haryana-122001

ARCHITECTS

Continued

Arcoop Associates Pvt. Ltd.
Plot 36B, Sector-32, Gurgaon 122001
Ph. 26242050, 26242169

ASSOCIATE ARCHITECTS-Submission Drawings

CosMAN, 11th Floor, Tower-2, DLF Corporate Greens
Sector-74A, Gurgaon 122004

OWNER'S SEAL
& SIGNATUREARCHITECT'S SEAL
& SIGNATURE

Ar. Ravinder Kumar
CA/2012/55971

	Checked and found ok for Public Health AUGUST-2024 All nice and respect to comments in	
--	--	--

Drawing No.: _____
 Drawing Title: _____
 SUPERINTENDING ENGINEER (HQ)
 O/o Chief Engineer-III,
 HVP, Panchkula.

DDT (VT)
 MEMBER
 BPAC

03

1