

1. BUILDING WILL BE DESIGNED (STRUCTURES) AS PER RELEVANT IS CODES FOR EARTH QUAKE RESISTANCE.
2. BUILDING HAS AUTOMATIC SPRINKLER SYSTEM ON ALL FLOORS.

REVISOR (1st Revision) GROUP HOUSING ON
SITE MEASURING 9.53 ACRES IN RESIDENTIAL
PLOTTED COLONY MEASURING 177.86
ACRES(LICENSE NO. 10 OF 2009 DATED
2007.08.22) IN SECTOR 65 & 62 GURGRAM
BEING DEVELOPED BY ACTIVE PROMOTERS
AND OTHERS IN COLLABORATION WITH EMAAR
INDIA LTD.(FORMERLY KNOWN AS
EMAAR MGF LAND LTD)

DSP
DSP DESIGN ASSOCIATES PVT. LTD
Architects & Interior Designers

5th Floor, Devchand House, Shiv Sagar
Estate, Dr Annie Besant Road, Opposite
Nehru Centre, Worli, Mumbai - 400 018.
Tel: +91 22 4915 1800
Web: www.dipdesign.co.in

• MUMBAI • BENGALURU • PUNE • NEW DELHI • HYDERABAD

Associate Architects

RSMS ARCHITECTS PVT. LTD.
69, Nora Niwas Bhawani Kunj
(Behind D2), Vasant Kunj,
New Delhi-110070.
Tel.: 011-26598616, 26598617
www.rsms-arch.com

Received and found ok for release to agents
by Service only subject to comments in
Remarks column. Date: 06/06/14

V. J. [Signature] Engineer (HO)
Chief Engineer-I
HSPV, Panchula

DDT(T)
MEMBER
BPAC

[Handwritten signature]
S.P. (G)
Chairman
B.P.A.C.

[Handwritten signature]
DIP (HQ)

[Handwritten signature]
A.T.F. (HQ)

[Handwritten signature]
PA

[Handwritten signature]
J.D.

ARCHITECT'S SEAL & SIGNATURE	OWNER'S SEAL & SIGNATURE
---------------------------------	-----------------------------

For DSP

Manmeet Singh Bali

INDIA

CA200320546

APRIL - 2024.	Scale : 1:100	(1st Revision)
---------------	---------------	----------------

GROUND TO, 3RD FLOOR, ROOF PLAN
SECTION - 1 2 & ELEVATION-A

CLUB-2/COMMUNITY BUILDING

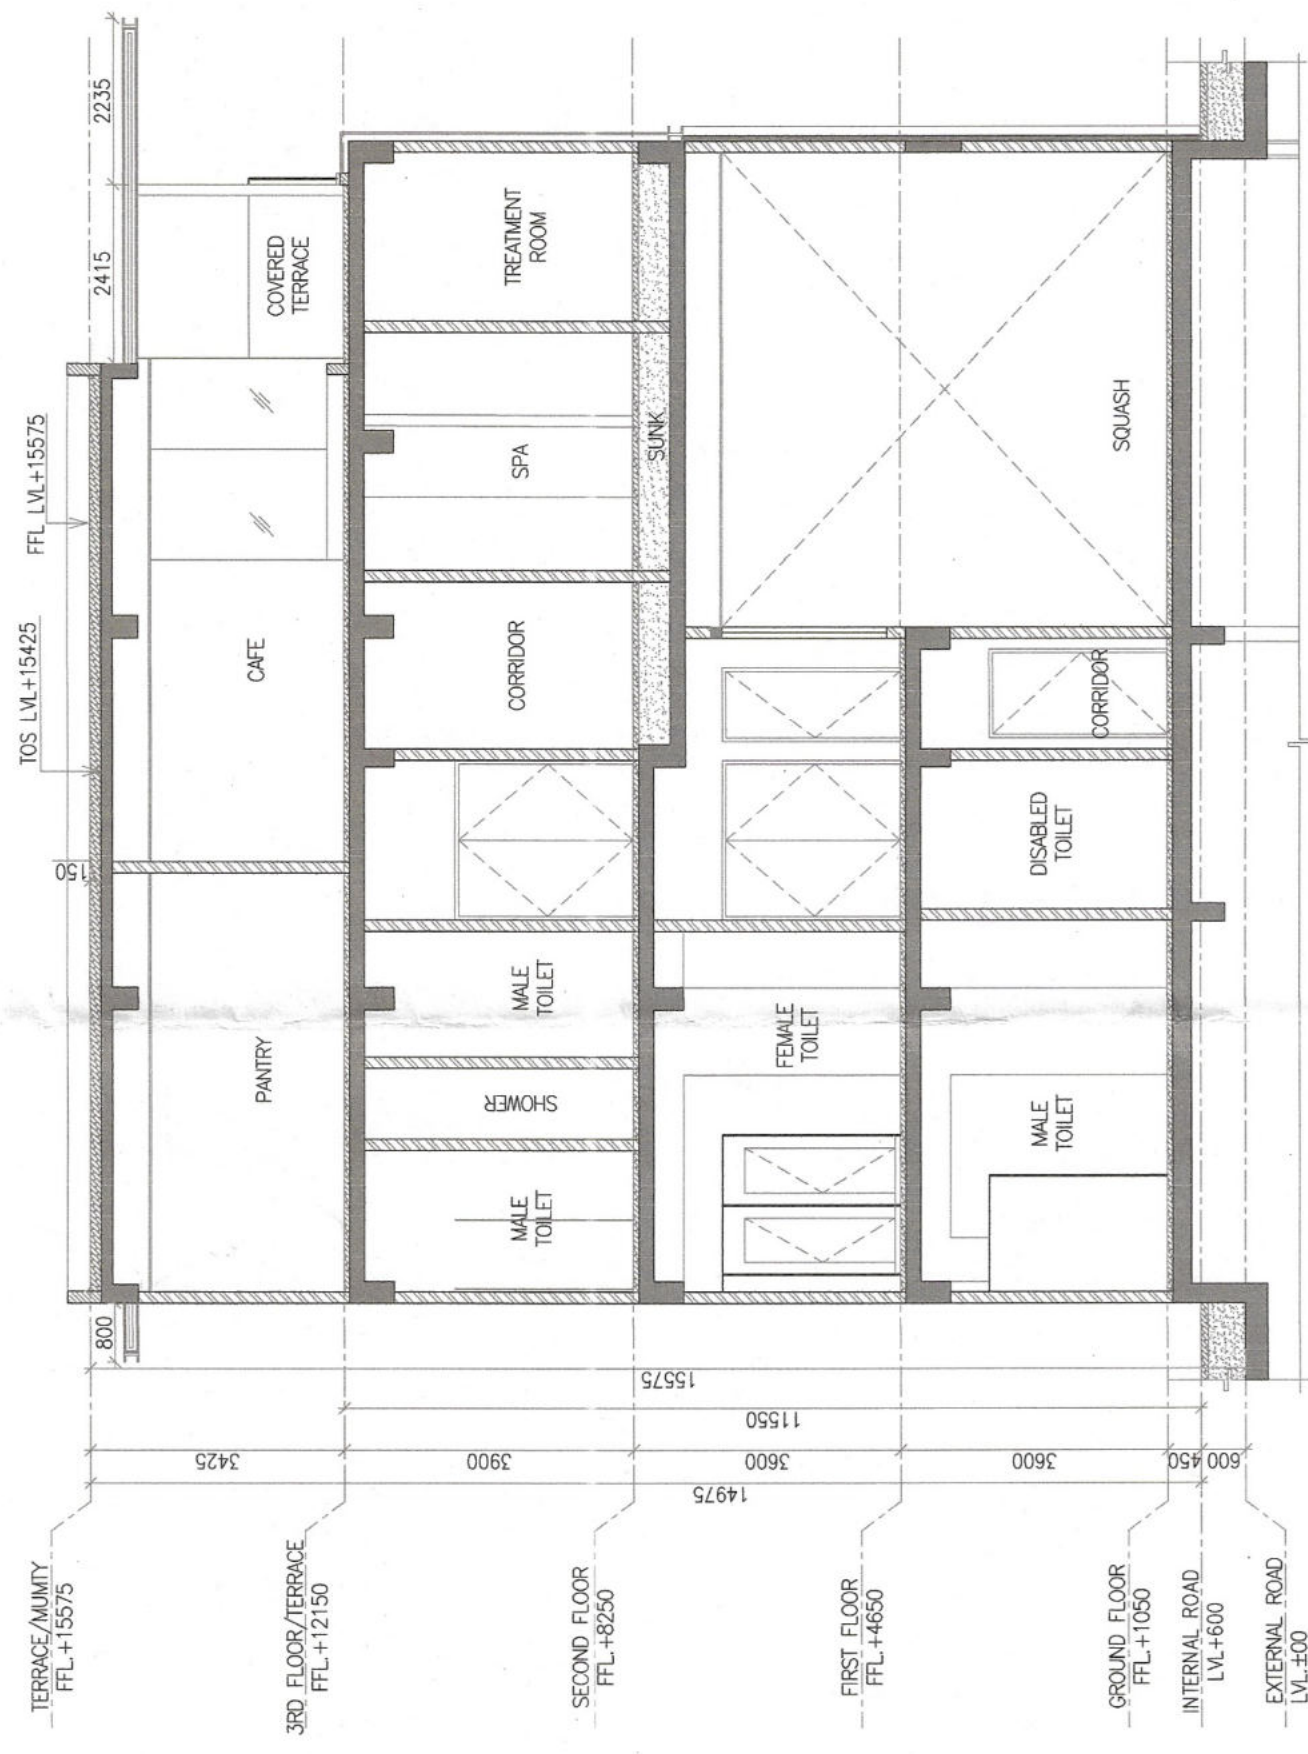
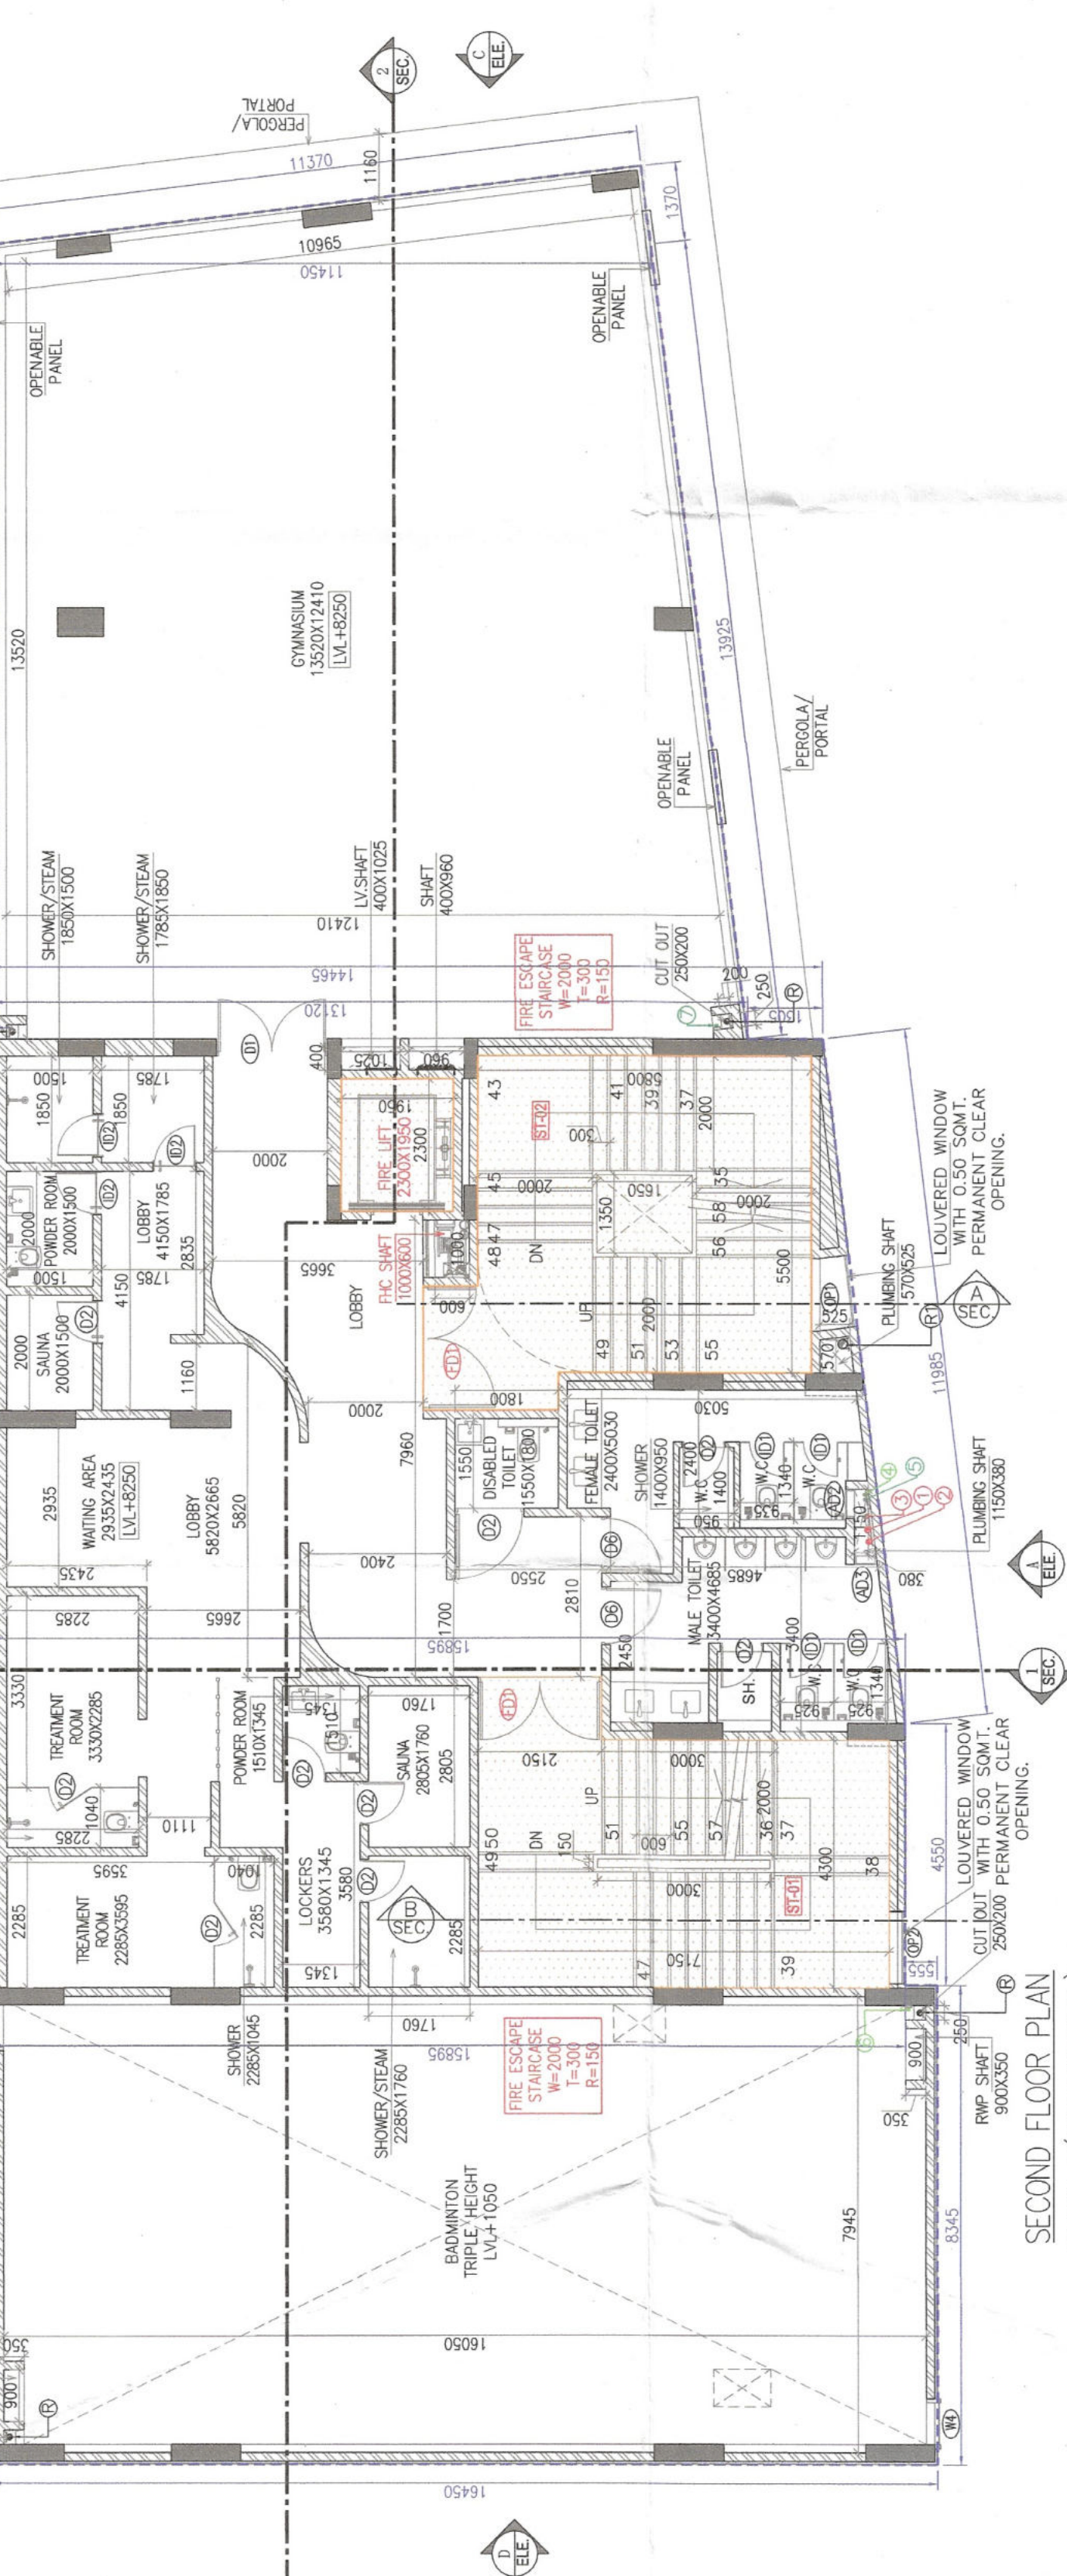
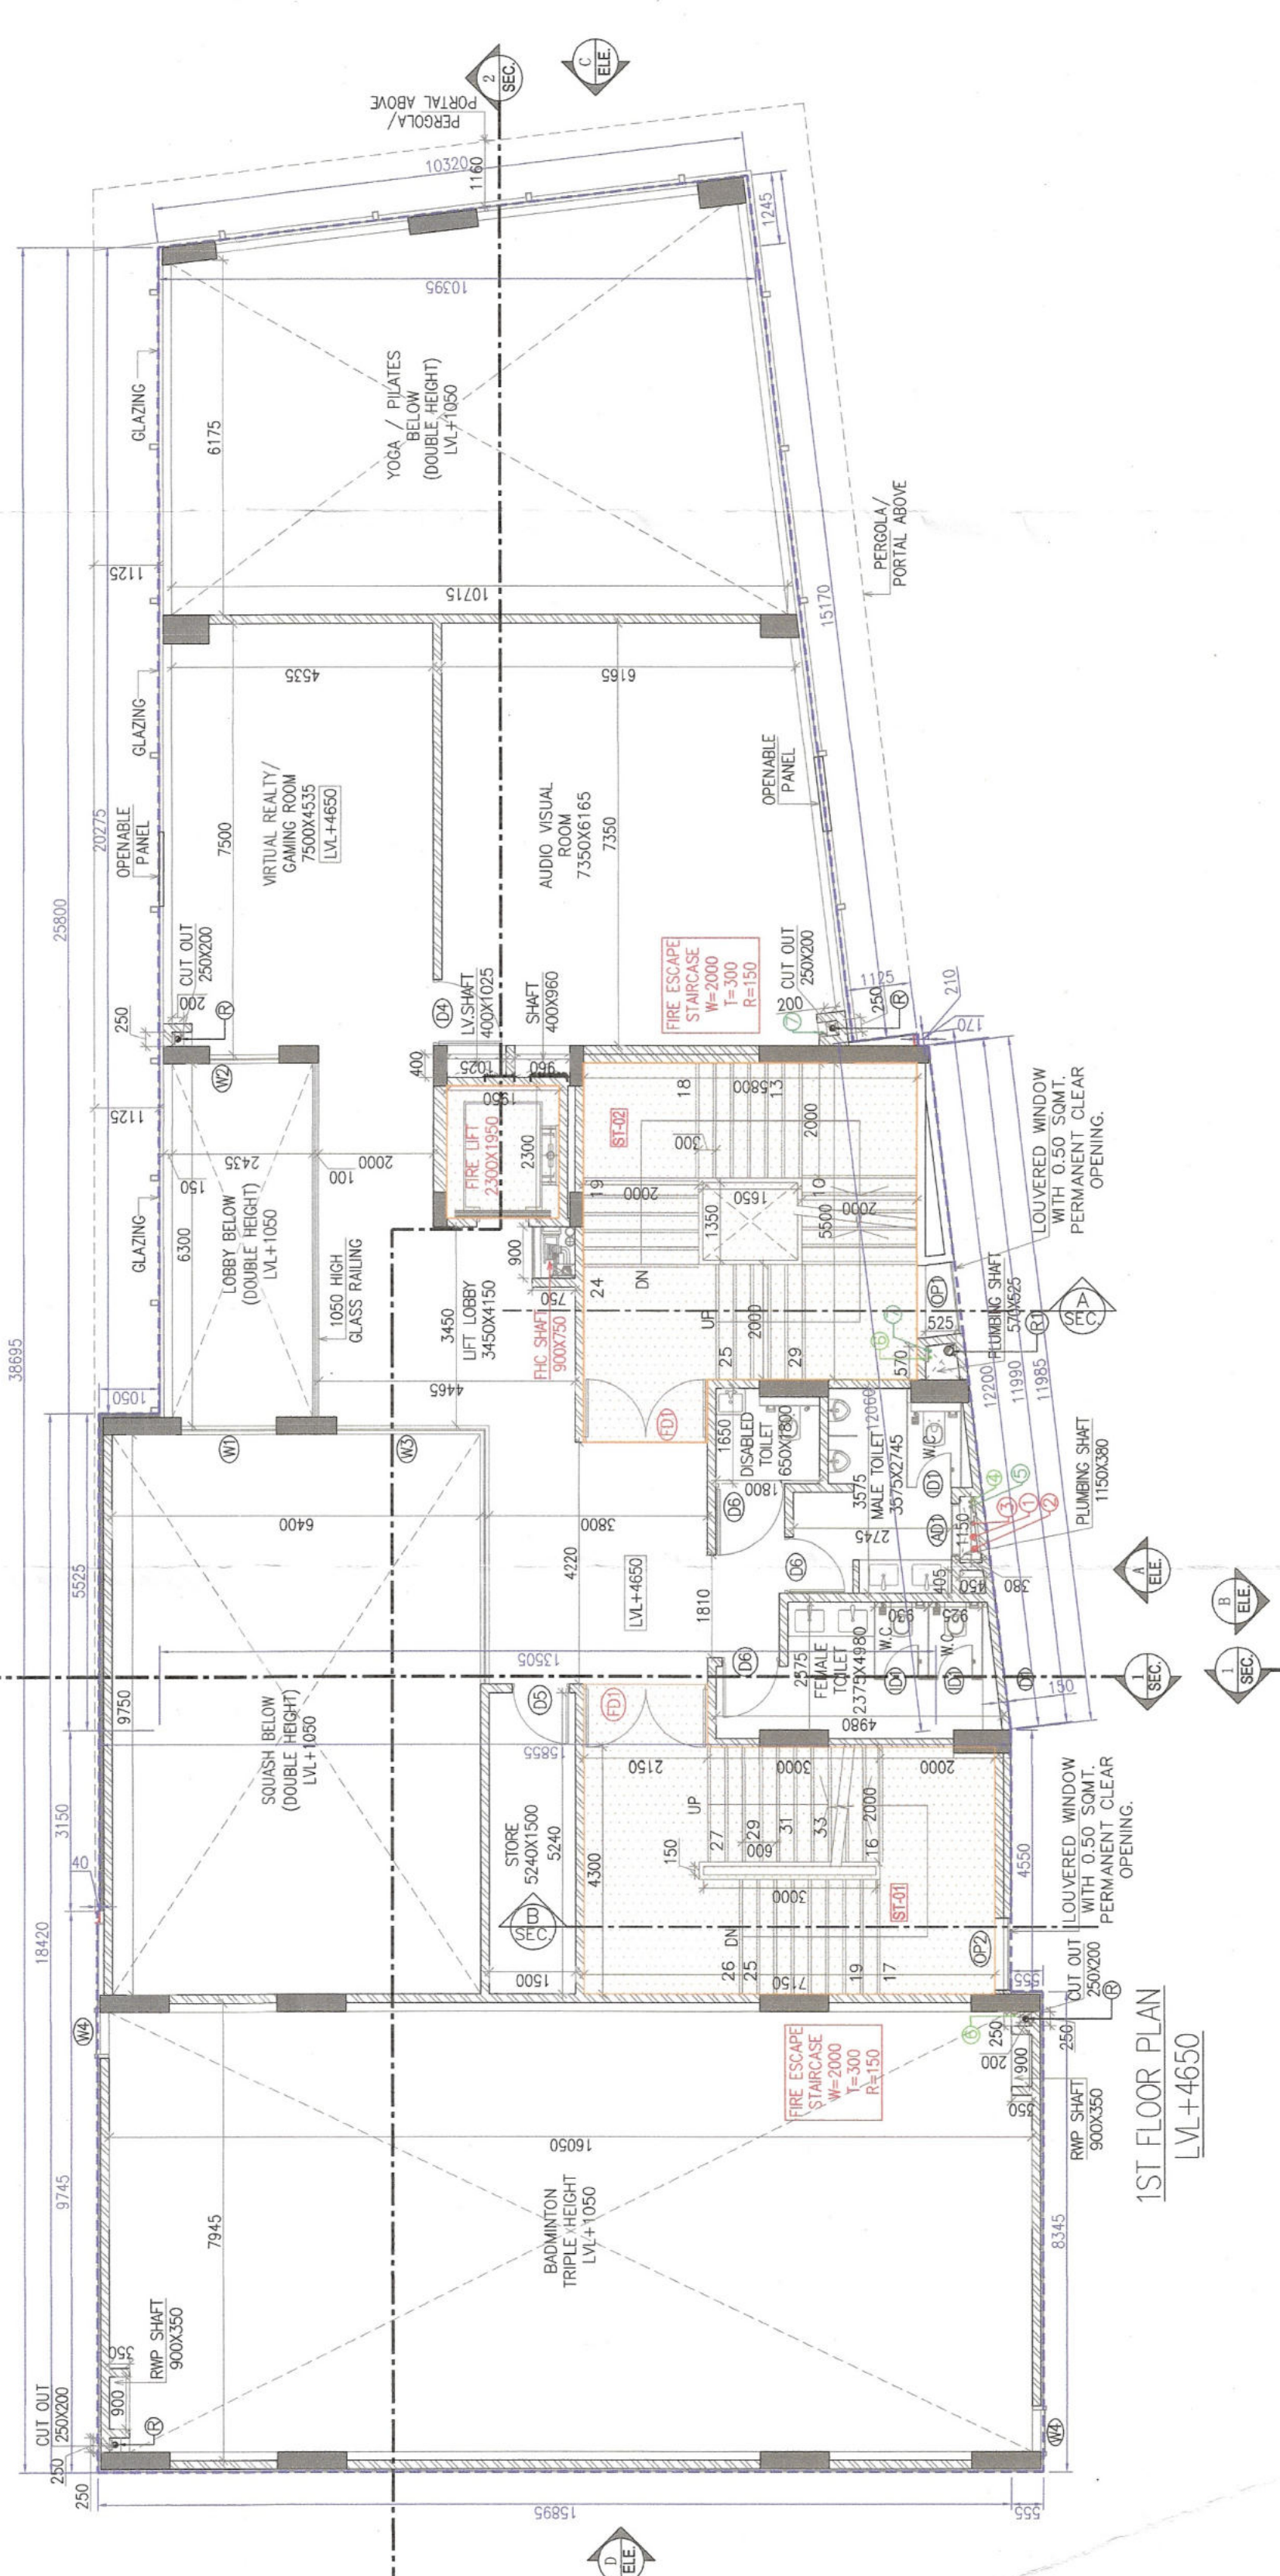
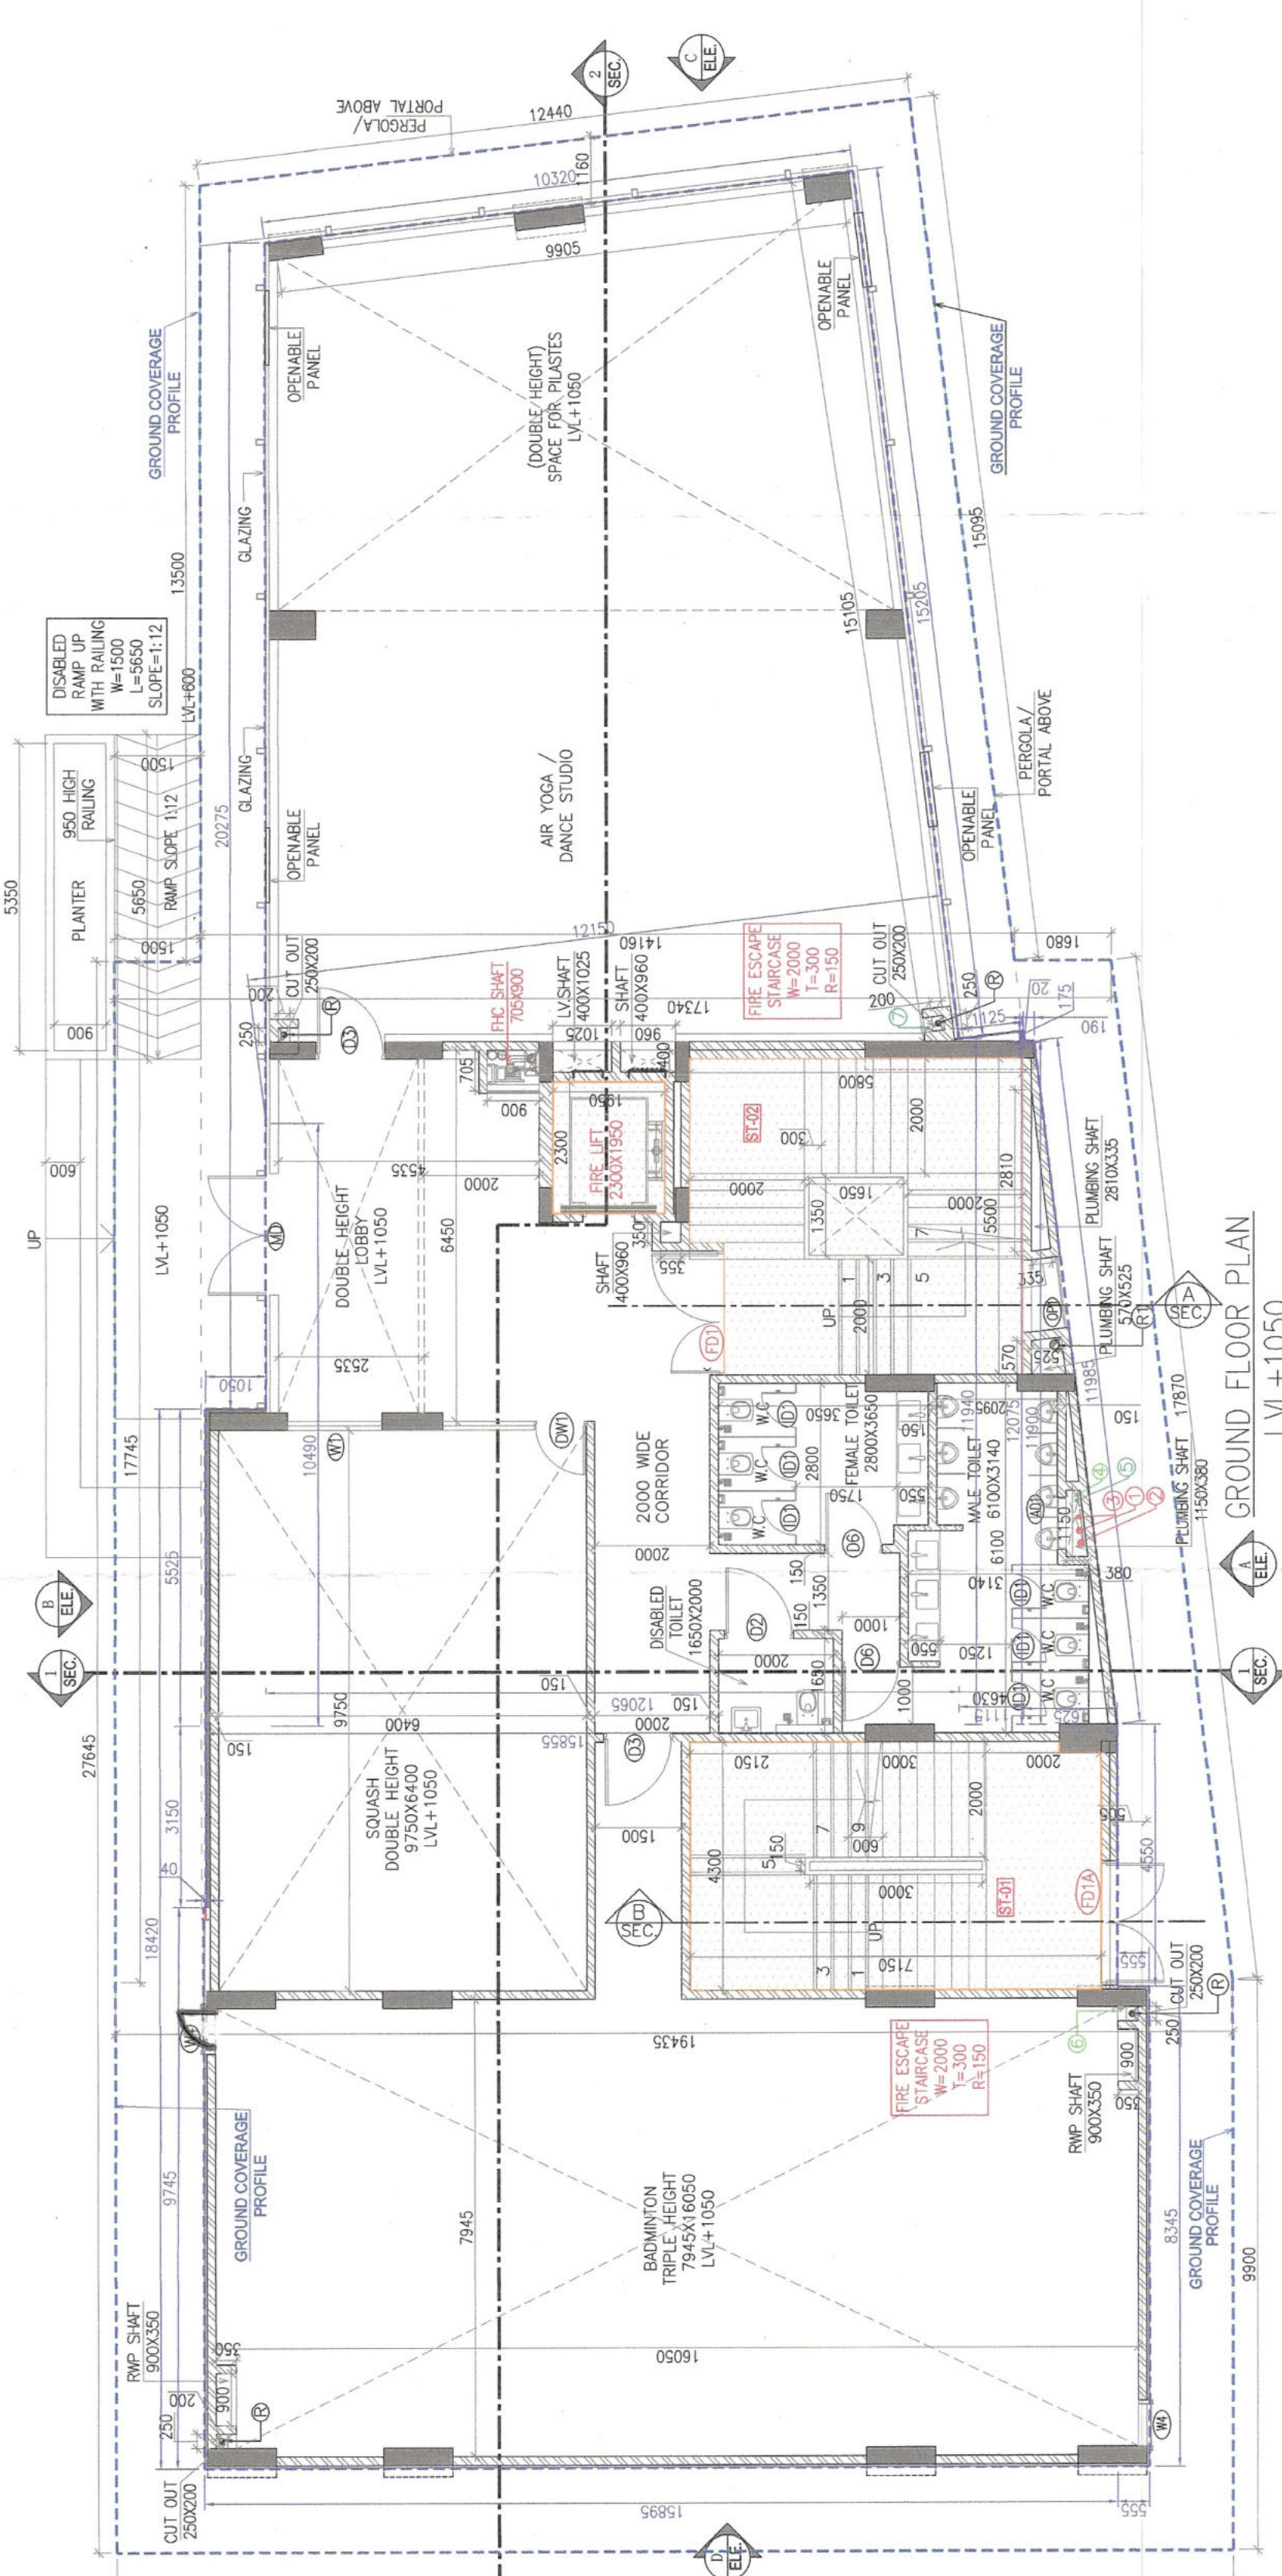
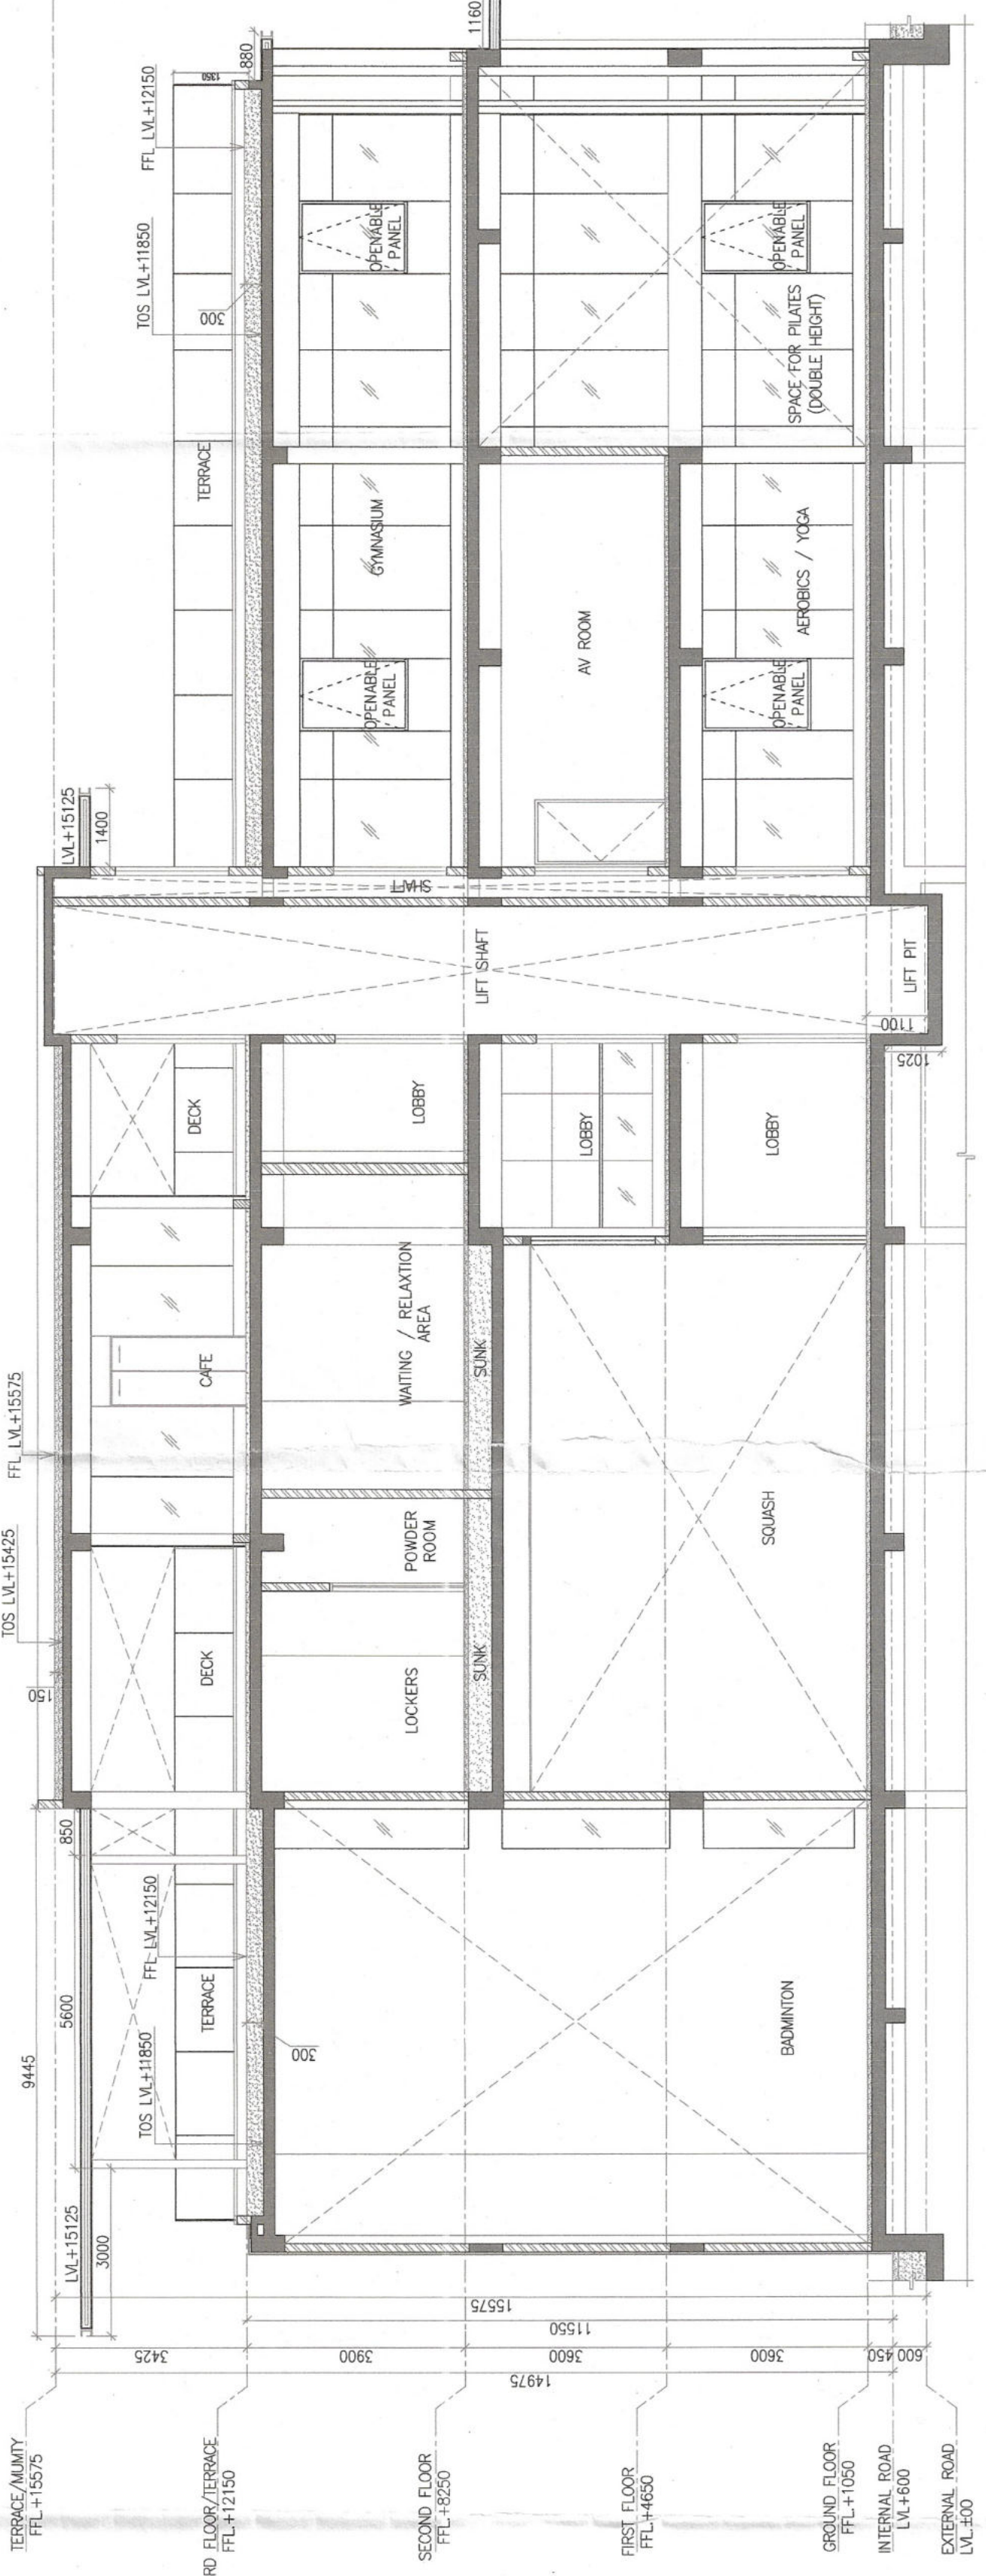
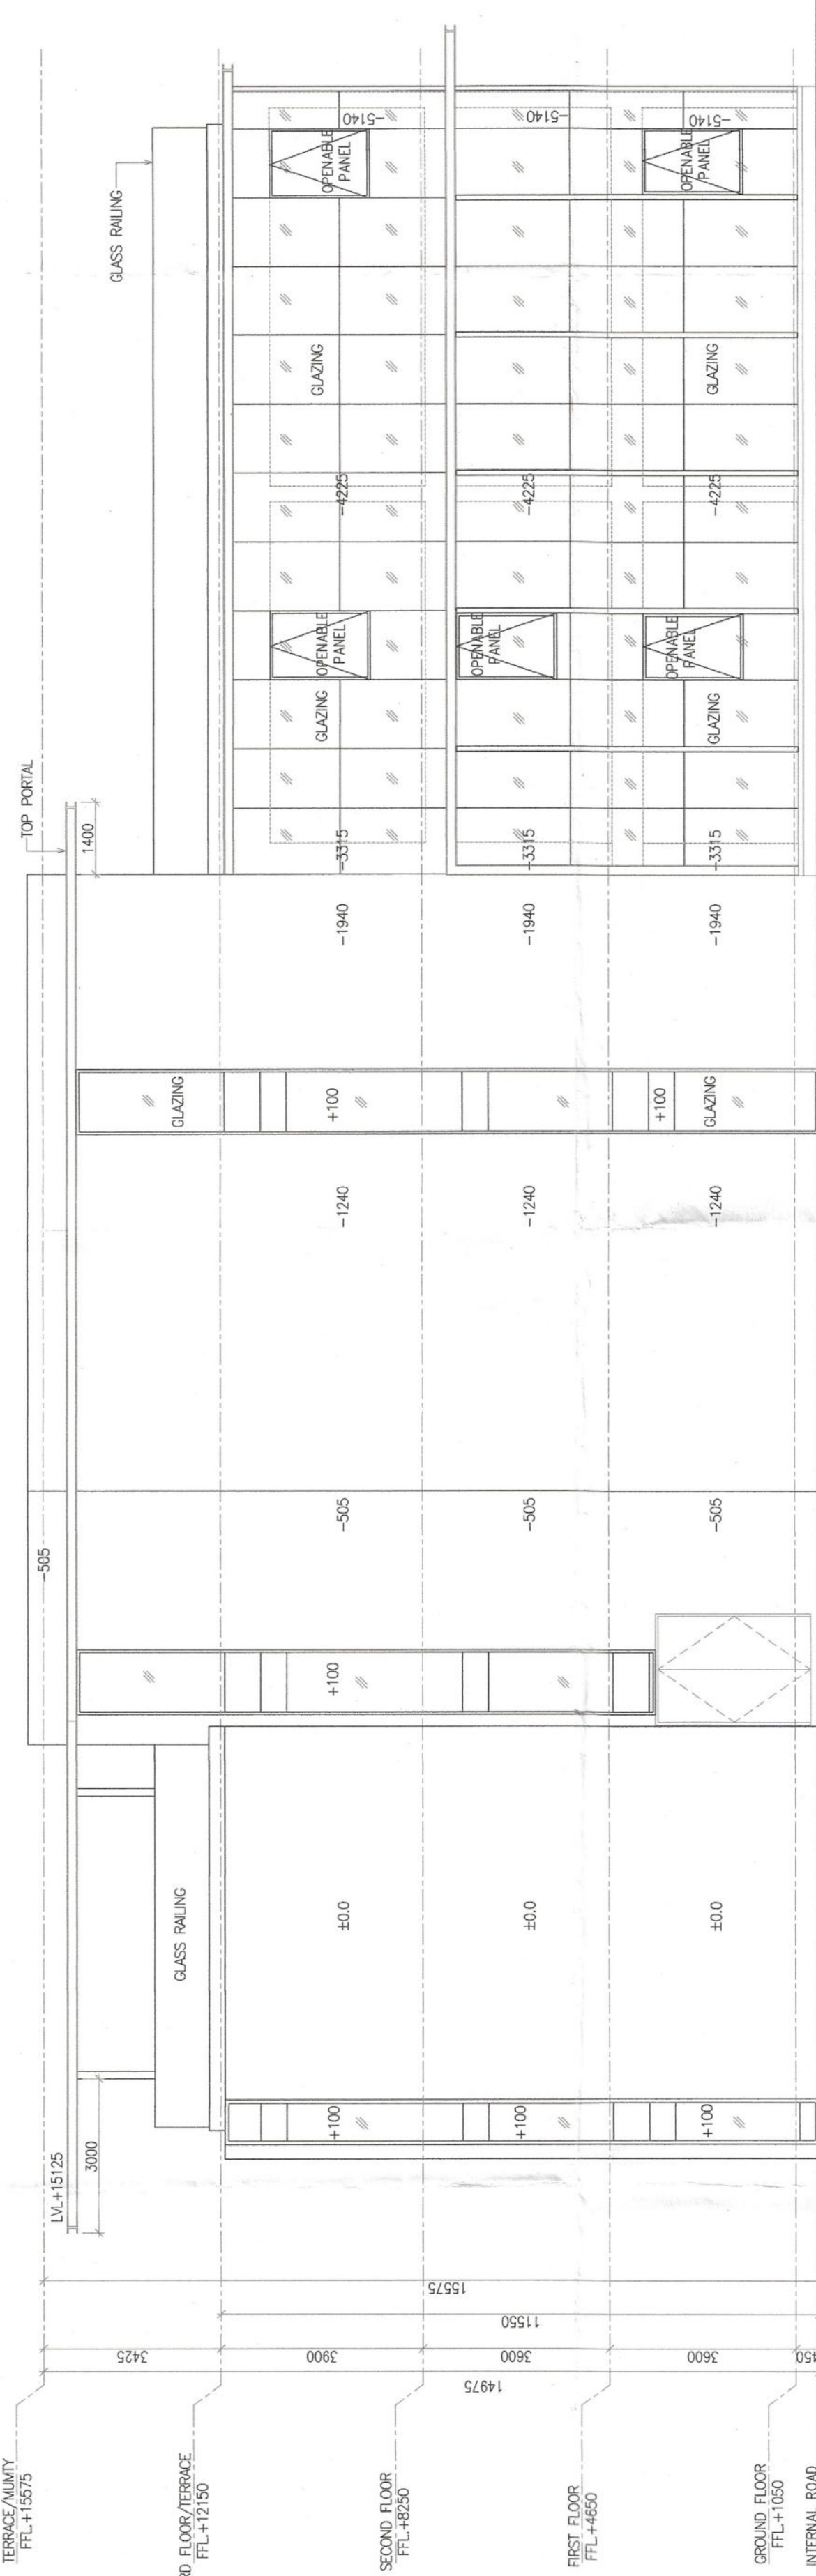
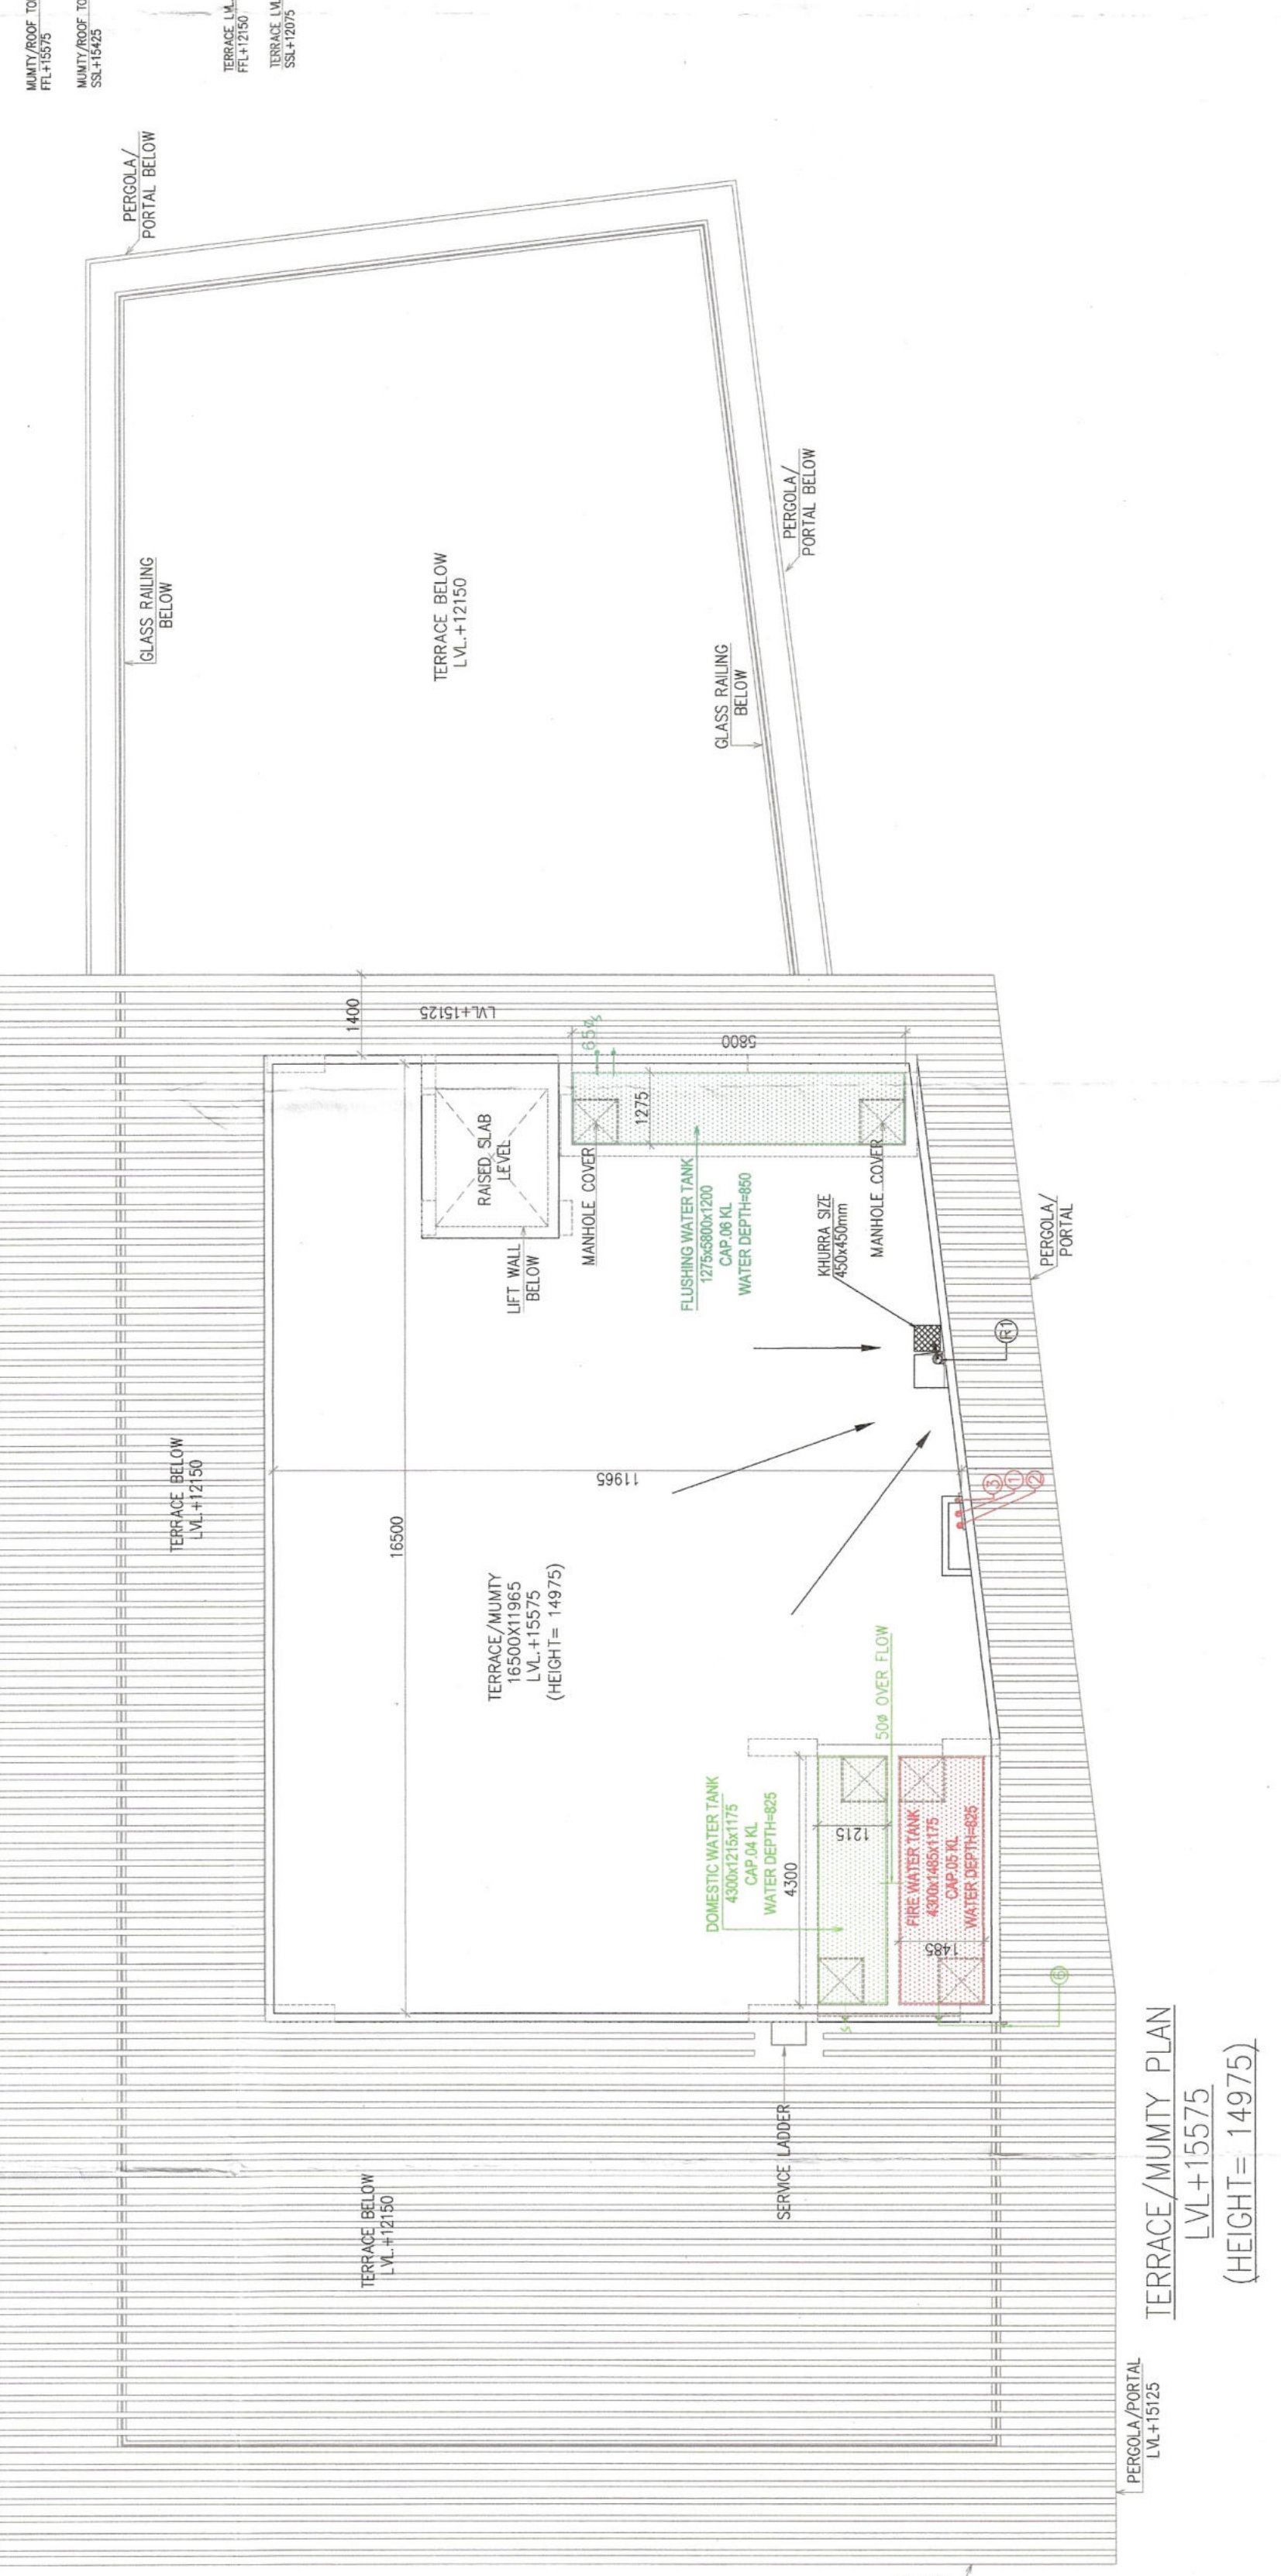
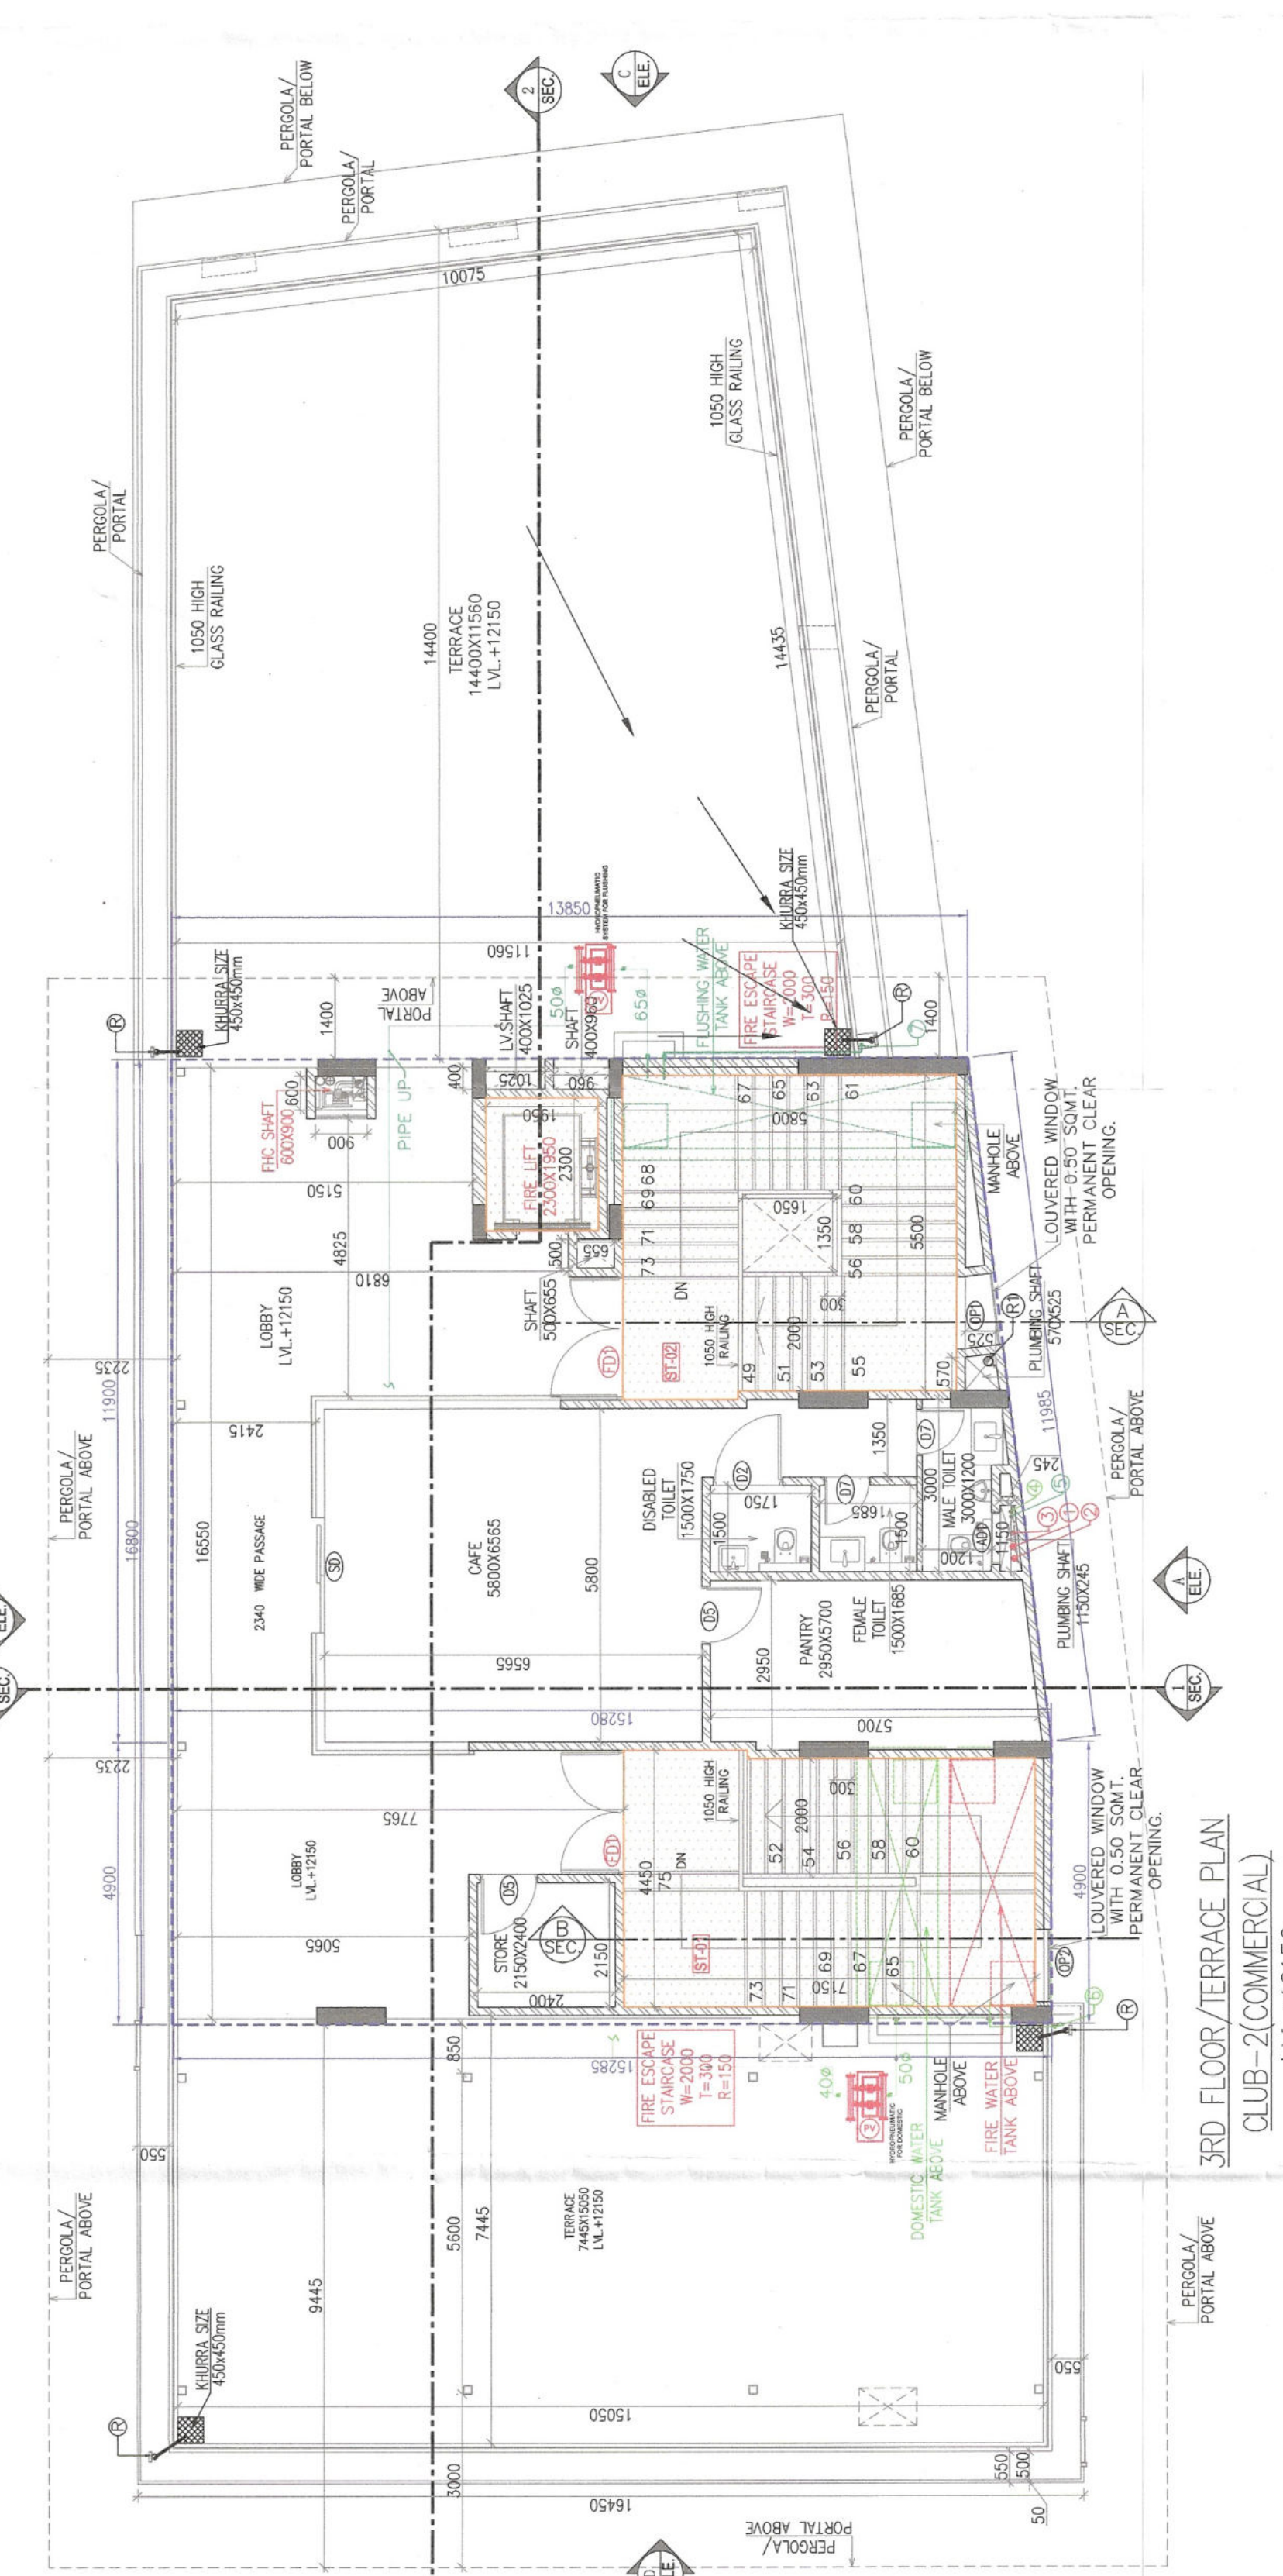
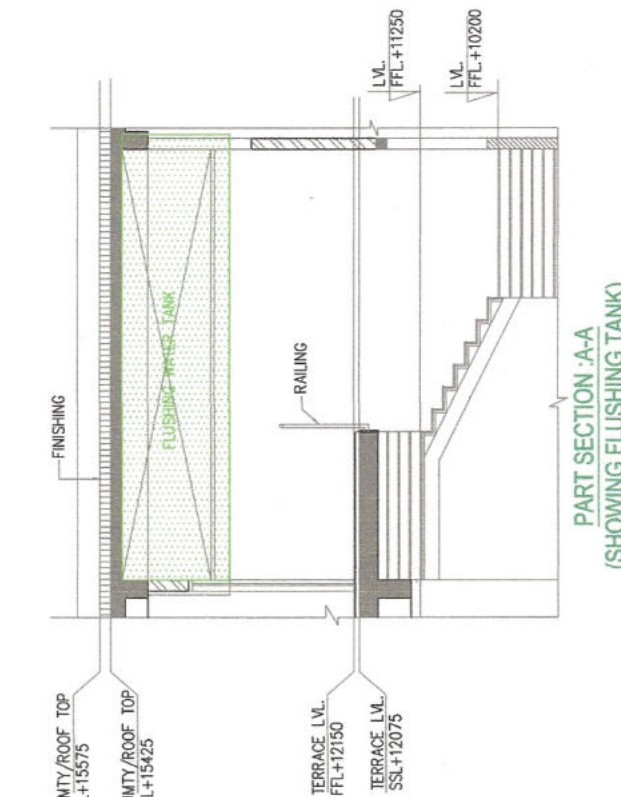
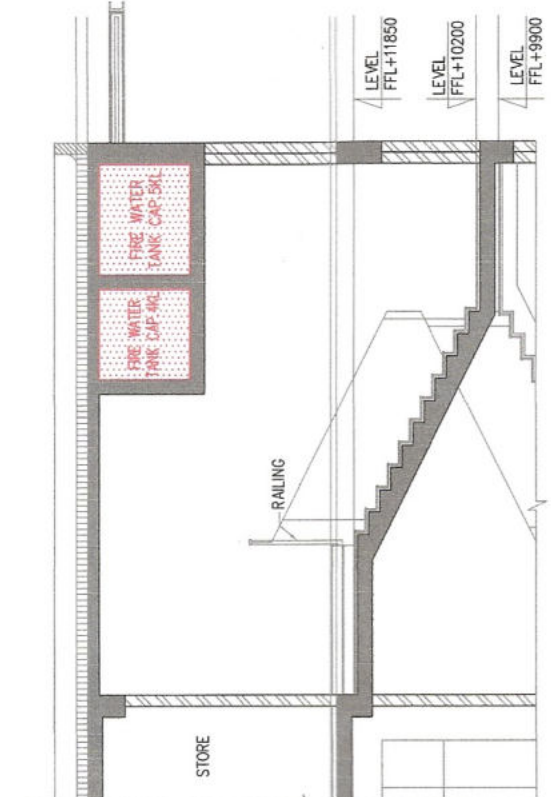
[illegible][illegible]

PIPE CONNECTION DIA. :-	
WC TO STACK	110 OD UPVC SOIL PIPE
URINAL BASIN TO UT	50 OD UPVC SOIL PIPE
UT TO STACK	110 OD UPVC SOIL PIPE
WASH BASIN TO FT	40 OD UPVC WASTE PIPE
FT TO STACK	110 OD UPVC WASTE PIPE
FT TO FT	63 OD UPVC WASTE PIPE
SNK TO FT	50 OD UPVC WASTE PIPE

PLUMBING LEGEND—

DWS	DOMESTIC WATER SUPPLY
FWS	FLUSHING WATER SUPPLY
DWR	DOMESTIC WATER RISER
FWR	FLUSHING WATER RISER
BDV	1" TO 40# BALL VALVE / ABOVE 40# BUTTERFLY VALVE

1.	150X150 IN SLAB FOR FT/MC	00P1
2.	100X100 IN SLAB FOR FD	00P2
3.	75X75 IN SLAB FOR WASH BASIN/URNAL	00P3
4.	75X150 IN SLAB FOR WASH BASIN/URNAL	00P4
5.	150MM. LEDGE WALL LOW HEIGHT RED.	
6.	75MM. LEDGE WALL LOW HEIGHT RED.	

[illegible]