
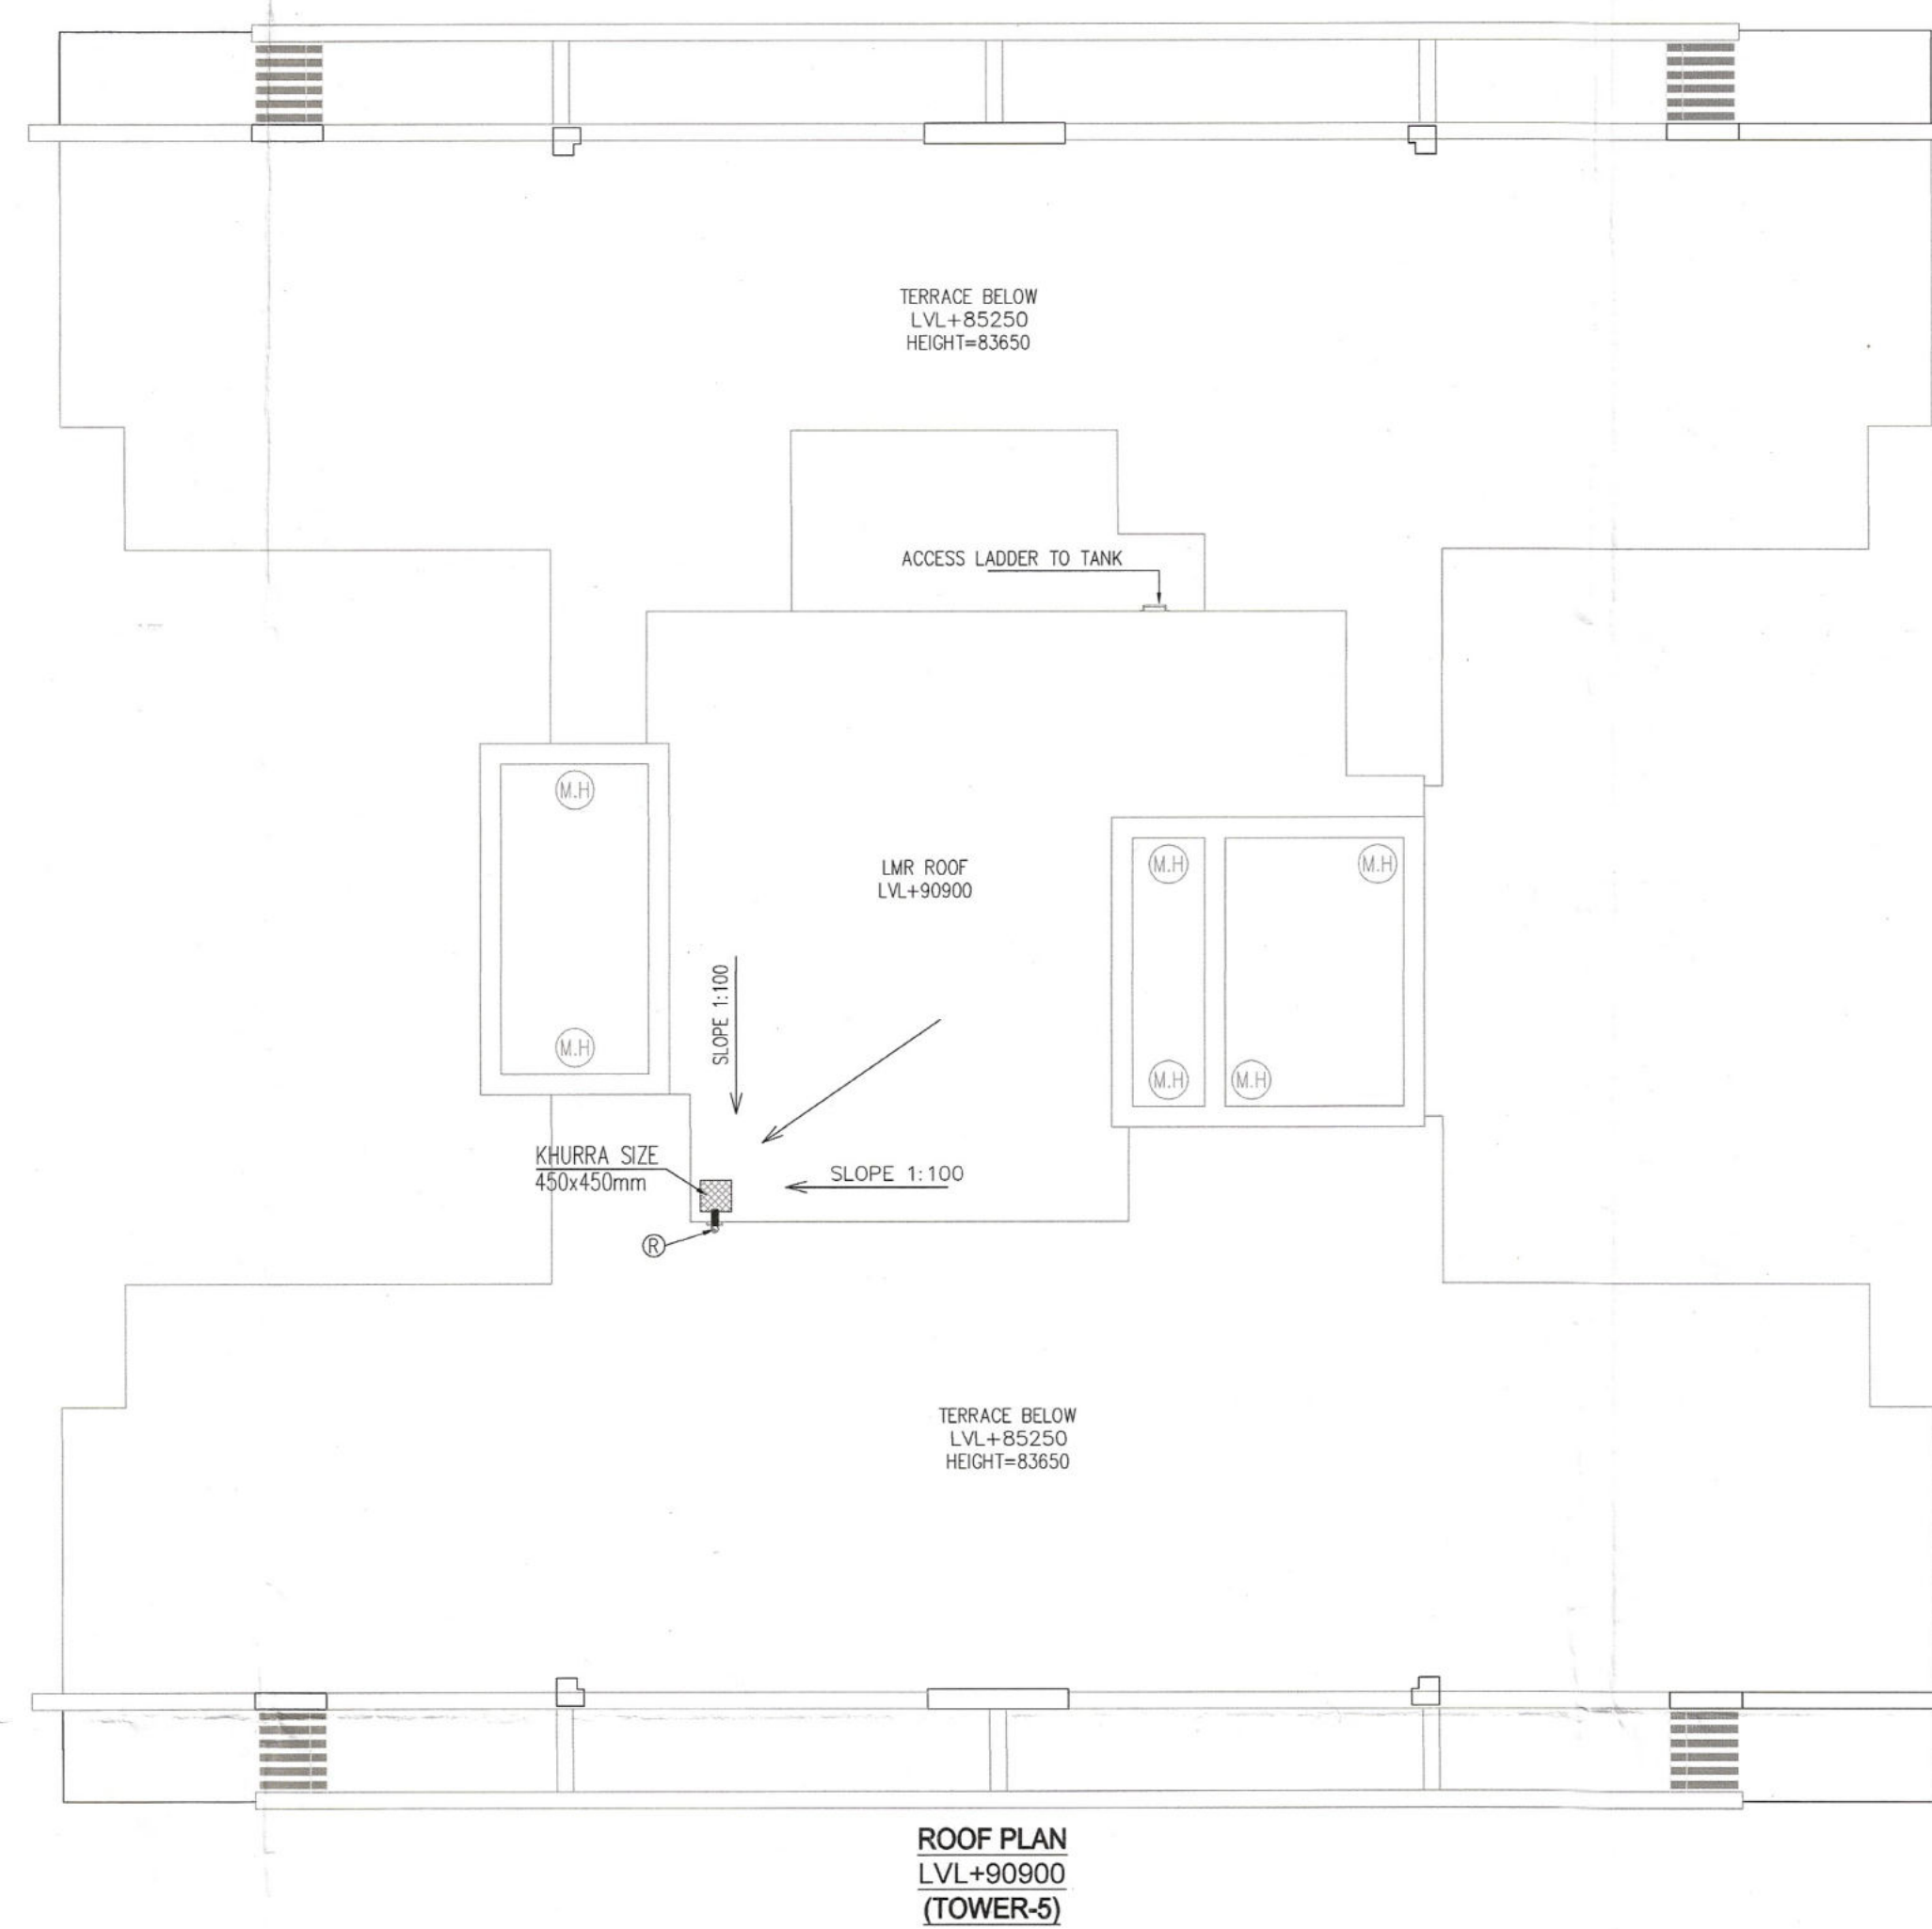


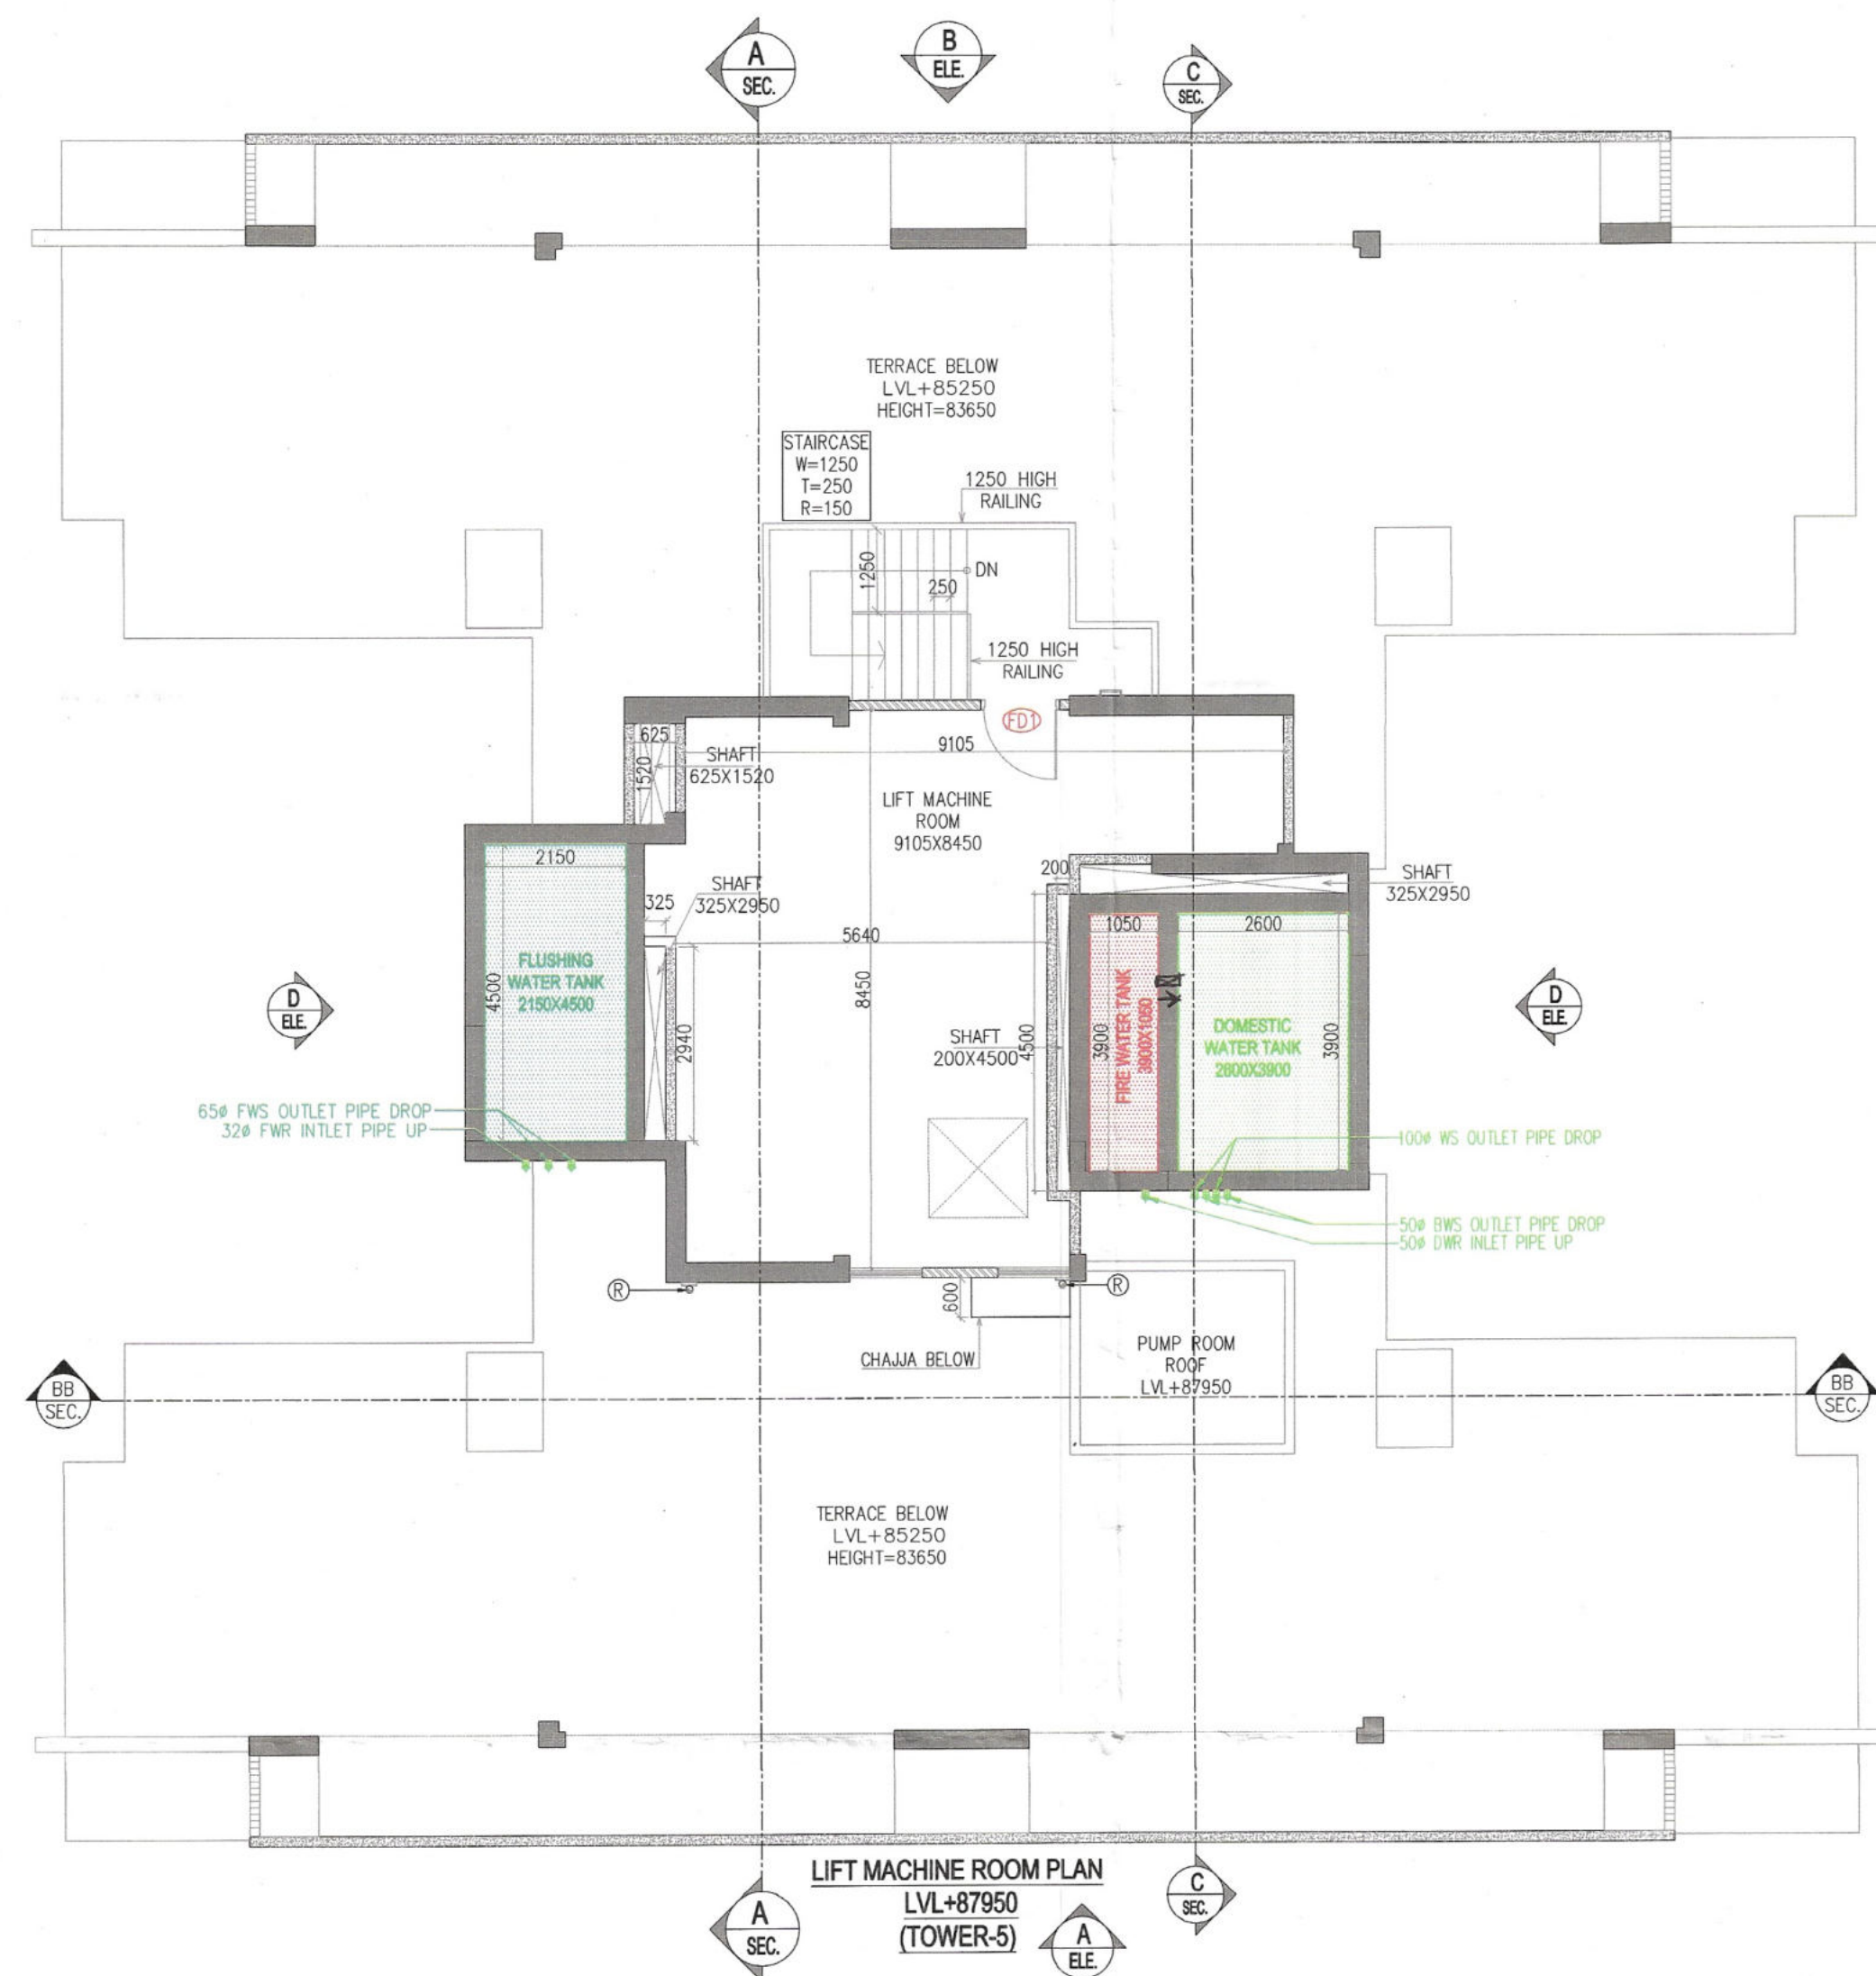

PLUMBING LEGEND:-

1	110 OD SOIL PIPE	
2	110 OD WASTE PIPE	
3	75 OD ANTI VENT PIPE	
4	DOMESTIC WATER SUPPLY PIPE	
5	FLUSHING WATER SUPPLY PIPE	
6	DOMESTIC WATER RISER PIPE TO OHT	
7	FLUSHING WATER RISER PIPE TO OHT	
8	AC DRAIN PIPE	
R	160 OD RAIN WATER PIPE	
R1	110 OD RAIN WATER PIPE	
FT	FLOOR TRAP CUTOUT	
FD	FLOOR DRAIN	
BD	BALCONY DRAIN	
MFT	MULTI FLOOR TRAP	

PIPE SLOPE TABLE :-

160 OD SOIL & WASTE PIPE	SLOPE:- 1:100
110 OD SOIL & WASTE PIPE	SLOPE:- 1:70

PLUMBING LEGEND:-

DWS	DOMESTIC WATER SUPPLY
FWS	FLUSHING WATER SUPPLY
DWR	DOMESTIC WATER RISER
FWR	FLUSHING WATER RISER
BWS	DOMESTIC WATER SUPPLY FOR BOOSTER PUMP
BY	UP TO 40# BALL VALVE / ABOVE 40# BUTTERFLY VALVE

LEGEND : (FIRE FIGHTING & ALARM SYSTEM)

S.NO.	SYMBOL	DESCRIPTION	POSITION
1.	A	80# FHC / SPRINKLER DRAIN PIPE	
2.	B	150# HYDRANT PIPE FOR LOW ZONE	
3.	C	150# HYDRANT PIPE FOR MID ZONE	
4.	D	150# HYDRANT PIPE FOR HIGH ZONE	
5.	E	150# SPRINKLER PIPE FOR LOW ZONE	
6.	F	150# SPRINKLER PIPE FOR MID ZONE	
7.	G	150# SPRINKLER PIPE FOR HIGH ZONE	
8.	H	100# HYDRANT PIPE (BASEMENT)	
9.	I	150# MAKE-UP PIPE FROM OHT	
10.	J	FIRE WATER LINE FOR SPRINKLER SYSTEM	
11.	K	ISOLATING VALVE	
12.	L	FLOW SWITCH	
13.	M	SPRINKLER DRAIN PIPE	
14.	N	SIDE WALL TYPE SPRINKLER HEAD	
15.	O	SIDE WALL (EXTENDED COVERAGE) TYPE SPRINKLER HEAD	
16.	P	PENDENT TYPE SPRINKLER	
17.	Q	UPRIGHT TYPE SPRINKLER	
18.	R	SPRINKLER PIPE SLEEVE	
19.	S	CO2 FIRE EXTINGUISHER 4.5 Kg CAP ISI MARKED	
20.	T	WATER CO2 FIRE EXTINGUISHER 9LTR CAP ISI MARKED	

DOOR SCHEDULE

SR. NO.	ROOM NAME	DOOR NAME	DESCRIPTION	OPENING SIZE (MM) WxH	SILL (MM)
01	LIVING ROOM (MAIN DOOR)	FD1	FLUSH DOOR 1 HOUR FIRE RATED	1200 x 2450	0.00
02	BED ROOM	FD2	FLUSH DOOR	1000 x 2450	0.00
03	COMMON TOILET	FD3	FLUSH DOOR	800 x 2450	0.00
04	MASTER TOILET	FD4	FLUSH DOOR	800 x 2450	0.00
05	TOILET	FD5	FLUSH DOOR	800 x 2450	0.00
06	POUNCE AREA	FD6	FLUSH DOOR 2 HOUR FIRE RATED	1200 x 2450	0.00
07	STAIRCASE	FD10	LOUVERED DOOR 2 HOUR FIRE RATED	1250 x 2150	300
08	TERRACE LOBBY & TERRACE PUMP ROOM	FD10A	LOUVERED DOOR	1250 x 2150	300
09	MAIL ROOM & RECEPTION	FD11	FLUSH DOOR	1000 x 2450	0.00
10	BEDROOM (BALCONY) SERVICE PERSONAL ROOM	G02	GLASS DOOR	900 x 2450	0.00
11	SERVICE LIFT	LD1	LIFT DOOR AS PER VENDOR	1000 x 2325	0.00
12	PASSENGER LIFT	LD2	LIFT DOOR AS PER VENDOR	1000 x 2325	0.00
13	ELECTRIC SHAFT	MD2	METAL DOOR 2 HOUR FIRE RATED	1050 x 2150	300
14	FHC SHAFT	MD4	METAL DOOR	1200 x 2150	300
15	FTTH SHAFT	MD5	METAL DOOR 2 HOUR FIRE RATED	800 x 2150	300
16	FTTH ROOM	MD6	METAL DOOR 2 HOUR FIRE RATED	1200 x 2325	0.00
17	STAIRCASE	MD10	METAL DOOR 2 HOUR FIRE RATED	1250 x 2450	0.00
18	LIFT LOBBY	MD18	METAL DOOR 2 HOUR FIRE RATED	1250 x 2250	250
19	SHAFT DOOR	SH01	OPENABLE FIBRE CEMENT BOARD	450 x 2250	200
20	SHAFT DOOR	SH02	OPENABLE FIBRE CEMENT BOARD	750 x 2250	200
21	SHAFT DOOR	SH03	OPENABLE FIBRE CEMENT BOARD	600 x 2250	200
22	SHAFT DOOR	SH03A	OPENABLE FIBRE CEMENT BOARD	600 x 1800	200
23	SHAFT DOOR	SH04	OPENABLE FIBRE CEMENT BOARD	250 x 2250	200
24	ENTRANCE LOBBY	GS01	SLIDING GLASS DOOR WITH FIXED PANEL	4850 x 3675	0.00
25	ENTRANCE LOBBY	GL1	GLASS FIXED PANEL	4850 x 3675	0.00

WINDOW SCHEDULE

SR. NO.	ROOM NAME	WINDOW NAME	DESCRIPTION	OPENING SIZE (MM) WxH	SILL (MM)
01	MASTER BEDROOM	W2	ALUMINUM SLIDING WINDOW	1600 x 2450	0.00
02	BEDROOM	W3	ALUMINUM FIXED + SLIDING WINDOW	2100 x 2250	200
03	DOUBLE STAIR CASE	W3A	ALUMINUM FIXED WINDOW	2100 x 2250	200
04	M. TOILET / C. TOILET	W7	ALUMINUM CASSEMENT WINDOW	600 x 1200	1250
05	STAIRCASE	W9	ALUMINUM LOUVERED WINDOW	1250 x 1550	900
06	LIFT LOBBY	W11	ALUMINUM LOUVERED WINDOW + DOOR	970 x 1200	1250
07	KITCHEN	W17	ALUMINUM CASSEMENT WINDOW + DOOR	1480 x 2450	AS/DE
08	LIVING ROOM	W19	ALUMINUM SLIDING WINDOW	4050 x 2450	0.00

ALUMINUM LOUVERS (TYPICAL)

SR. NO.	TYPE/MARK	LENGTH	HEIGHT
01	L01	1500	2600
02	L02	1200	2450
03	L03	1350	2450

RAILING SCHEDULE (TYPICAL)

SR. NO.	TYPE/MARK	LENGTH
01	GR1	5395
02	GR2	3970

SHAFT SCHEDULE (TYPICAL)

SR. NO.	TYPE/MARK	SHAFT NAME
01	SE01	SERVICE ELEVATOR
02	PE01	PASSENGER ELEVATOR
03	PE02	PASSENGER ELEVATOR
04	SH01	PLUMBING SHAFT
05	SH02	PLUMBING SHAFT
06	SH03	ELECTRICAL SHAFT
07	SH04	FHC SHAFT
08	SH05	FTTH SHAFT
09	SH06	OWC EXHAUST SHAFT

Note :-
1. BUILDING WILL BE DESIGNED (STRUCTURES) AS PER RELEVANT IS CODES FOR EARTH QUAKE RESISTANCE.

DDP (T) MEMBER BPAC

LEGEND:-

This is a "PROVISIONAL BUILDING PLAN" approved only for the purpose of inviting objections from the general public.

Signature of S.T.P. (HQ) Member Secretary B.P.A.C.
Signature of S.T.P. (G) Member B.P.A.C.
Signature of C.T.P. (HQ) Chairman B.P.A.C.
Signature of D.T.P. (HQ)
Signature of P.A.
Signature of A.P.
Signature of (Dinesh Kumar) P.A. (HQ)

PROJECT:-

REVISED (1st Revision) GROUP HOUSING ON SITE MEASURING 9.53 ACRES IN RESIDENTIAL PLOTTED COLONY MEASURING 177.86 ACRES/LICENSE NO. 10 OF 2009 DATED DT.21.05.2009, LICENSE NO. 113 OF 2011 DATED 22.12.2011 & LICENSE NO. 117 OF 2022 DATED 23.08.2022) IN SECTOR 65 & 62, GURUGRAM BEING DEVELOPED BY ACTIVE PROMOTERS AND OTHERS IN COLLABORATION WITH EMAAR INDIA LTD (FORMERLY KNOWN AS EMAAR MGF LAND LTD)

ARCHITECT:-

DSP DESIGN ASSOCIATES PVT. LTD.
Architects & Interior Designers

6th Floor, Devchand House, Shiv Nagar, Gurgaon, Haryana, India. Opposite Nehru Centre, West, Mumbai - 400 018. Tel: +91 22 4915 1800. Web: www.dspdesign.co.in

MUMBAI • BENGALURU • PUNE • NEW DELHI • HYDERABAD

Associate Architects

RISMS ARCHITECTS

RSMS ARCHITECTS PVT. LTD.
69, Nora Niwas Bhowani Kunj (Behind D2), Vasant Kunj, New Delhi-110070.
Tel.: 011-26898616, 26898617
www.rsms-arch.com

Checked and found ok for Public Health (Internal) Service only subject to comments in forwarding letter. 15/03/24. DV. 06/06/24

Signature of Superintending Engineer (HQ) Chief Engineer-I HSVP, Panchkula

ARCHITECT'S SEAL & SIGNATURE

OWNER'S SEAL & SIGNATURE

For DSP
Mammeet Singh Bala
Architect (B.Arch, MCA)
CA/2003/20549

APRIL-2024. Scale : 1:100 (1st Revision)

Drawing Title:-

Drawing No:-

L.M.R., ROOF PLAN (TOWER-5)

T5-02

26052024