

THIS BUILDING HAS AUTOMATIC SPRINKLER SYSTEM
WHEREVER REQUIRED BY NBC.

2. BUILDING WILL BE DESIGNED (S) (R) (L) (U) (R) (S)
AS PER RELEVANT IS CODES FOR EARTH QUAKE RESISTANCE.

This is a "PROVISIONAL BUILDING PLAN"
approved only for the purpose of inviting
Objections from the general public

 S.P. (H)
Member of the Building Committee

 S.P. (G)
Member

 C.F. (R)
Chairman

 B.P.C.

AD PA ATP

Rajesh Dutt
JD/HQ)

READ WITH THIS OFFICE
NO.


[illegible]

PLUMBING LEGEND:--	
1	1000/1700 SOIL PIPE
2	1000/1700 WASTE PIPE
2A	1000/1700 WASTE PIPE FOR UTILITY BALCONY
3	1000/1700 JUNCTION WASTE PIPE
4	750 VENT PIPE
5	1000/1700 RAIN WATER PIPE FOR BALCONY
6	1000/1700 RAIN WATER PIPE FOR TERRACE
7	1500/RAIN WATER PIPE FOR TERRACE
8	DOMESTIC WATER SUPPLY (BOOSTER) (TOP SIX FLOORS)
9	DOMESTIC WATER SUPPLY (BT GRAVITY) UP TO GROUND FLOOR
10	FLOODING WATER SUPPLY (BT GRAVITY) UP TO 4TH FLOOR
11	DOMESTIC WATER SUPPLY RISER FOR OLD TANK
12	FLOODING WATER SUPPLY RISER FOR OLD TANK

PLUMBING LEGEND: —	
DWS	DOMESTIC WATER SUPPLY
FWS	FLUSHING WATER SUPPLY
MFT	MULTI FLOOR TRAP
FT	FLOOR TRAP
UT	URNAL TRAP
FD	FLOOR DRAIN
FCO	FLOOR CLEAN OUT PLUG
CDP	CLEAN OUT PLUG
BD	BALCONY DRAIN
DP	DRAIN POINT

IN	FIRE FIGHTING PIPE LEGEND:-
A	HYDRANT PIPE ZONE-1
B	HYDRANT PIPE ZONE-2
C	HYDRANT PIPE ZONE-3
D	SPRINKLER PIPE ZONE-1
E	SPRINKLER PIPE ZONE-2
F	SPRINKLER PIPE ZONE-3
G	SPRINKLER STAND BY PIPE ZONE-1
H	SPRINKLER STAND BY PIPE ZONE-2
I	SPRINKLER STAND BY PIPE ZONE-3
J	DRAIN PIPE
K	FIRE HOSE CABINET
INC	


Typical Mechanical Ventilation Calculation for WC									
Towse-D2 Toilet Exhaust sheet									
S. No.	LOCATIONS	Length	Width	Toilet Dimension in (mtr)	Total Area in (sq. mtr)	Total Volume in (cu. mtr)	Toilet weight in (kg)	Solarized Exhaust Fan in (CFM)	Exhaust Duct Size Diameter (mm)
1. Typical Mechanical Ventilation Calculation for WC									
1.1	TOILET	2.275	1.475	1.81	41.00	2.70	8.86	364 /	1410 CFM, 325x189
	INFLANCE						73		100 (D)

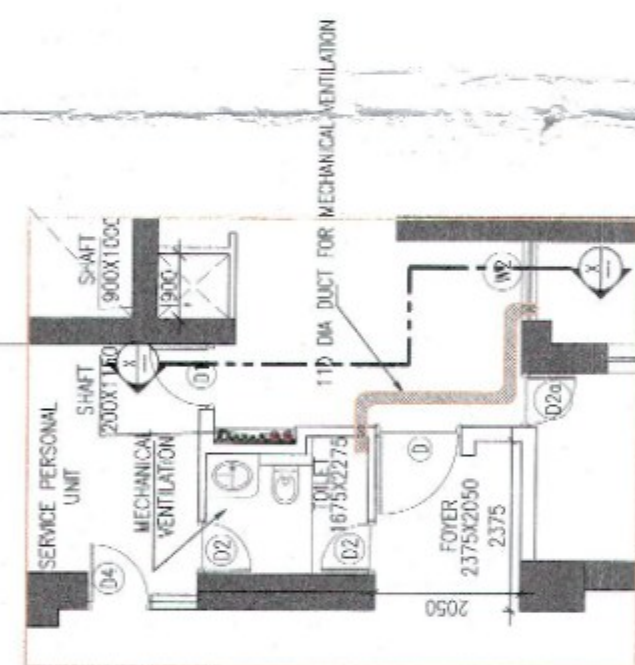

DETAIL FOR
MECHANICAL VENTILATION OF TOILET AREA




SECTION

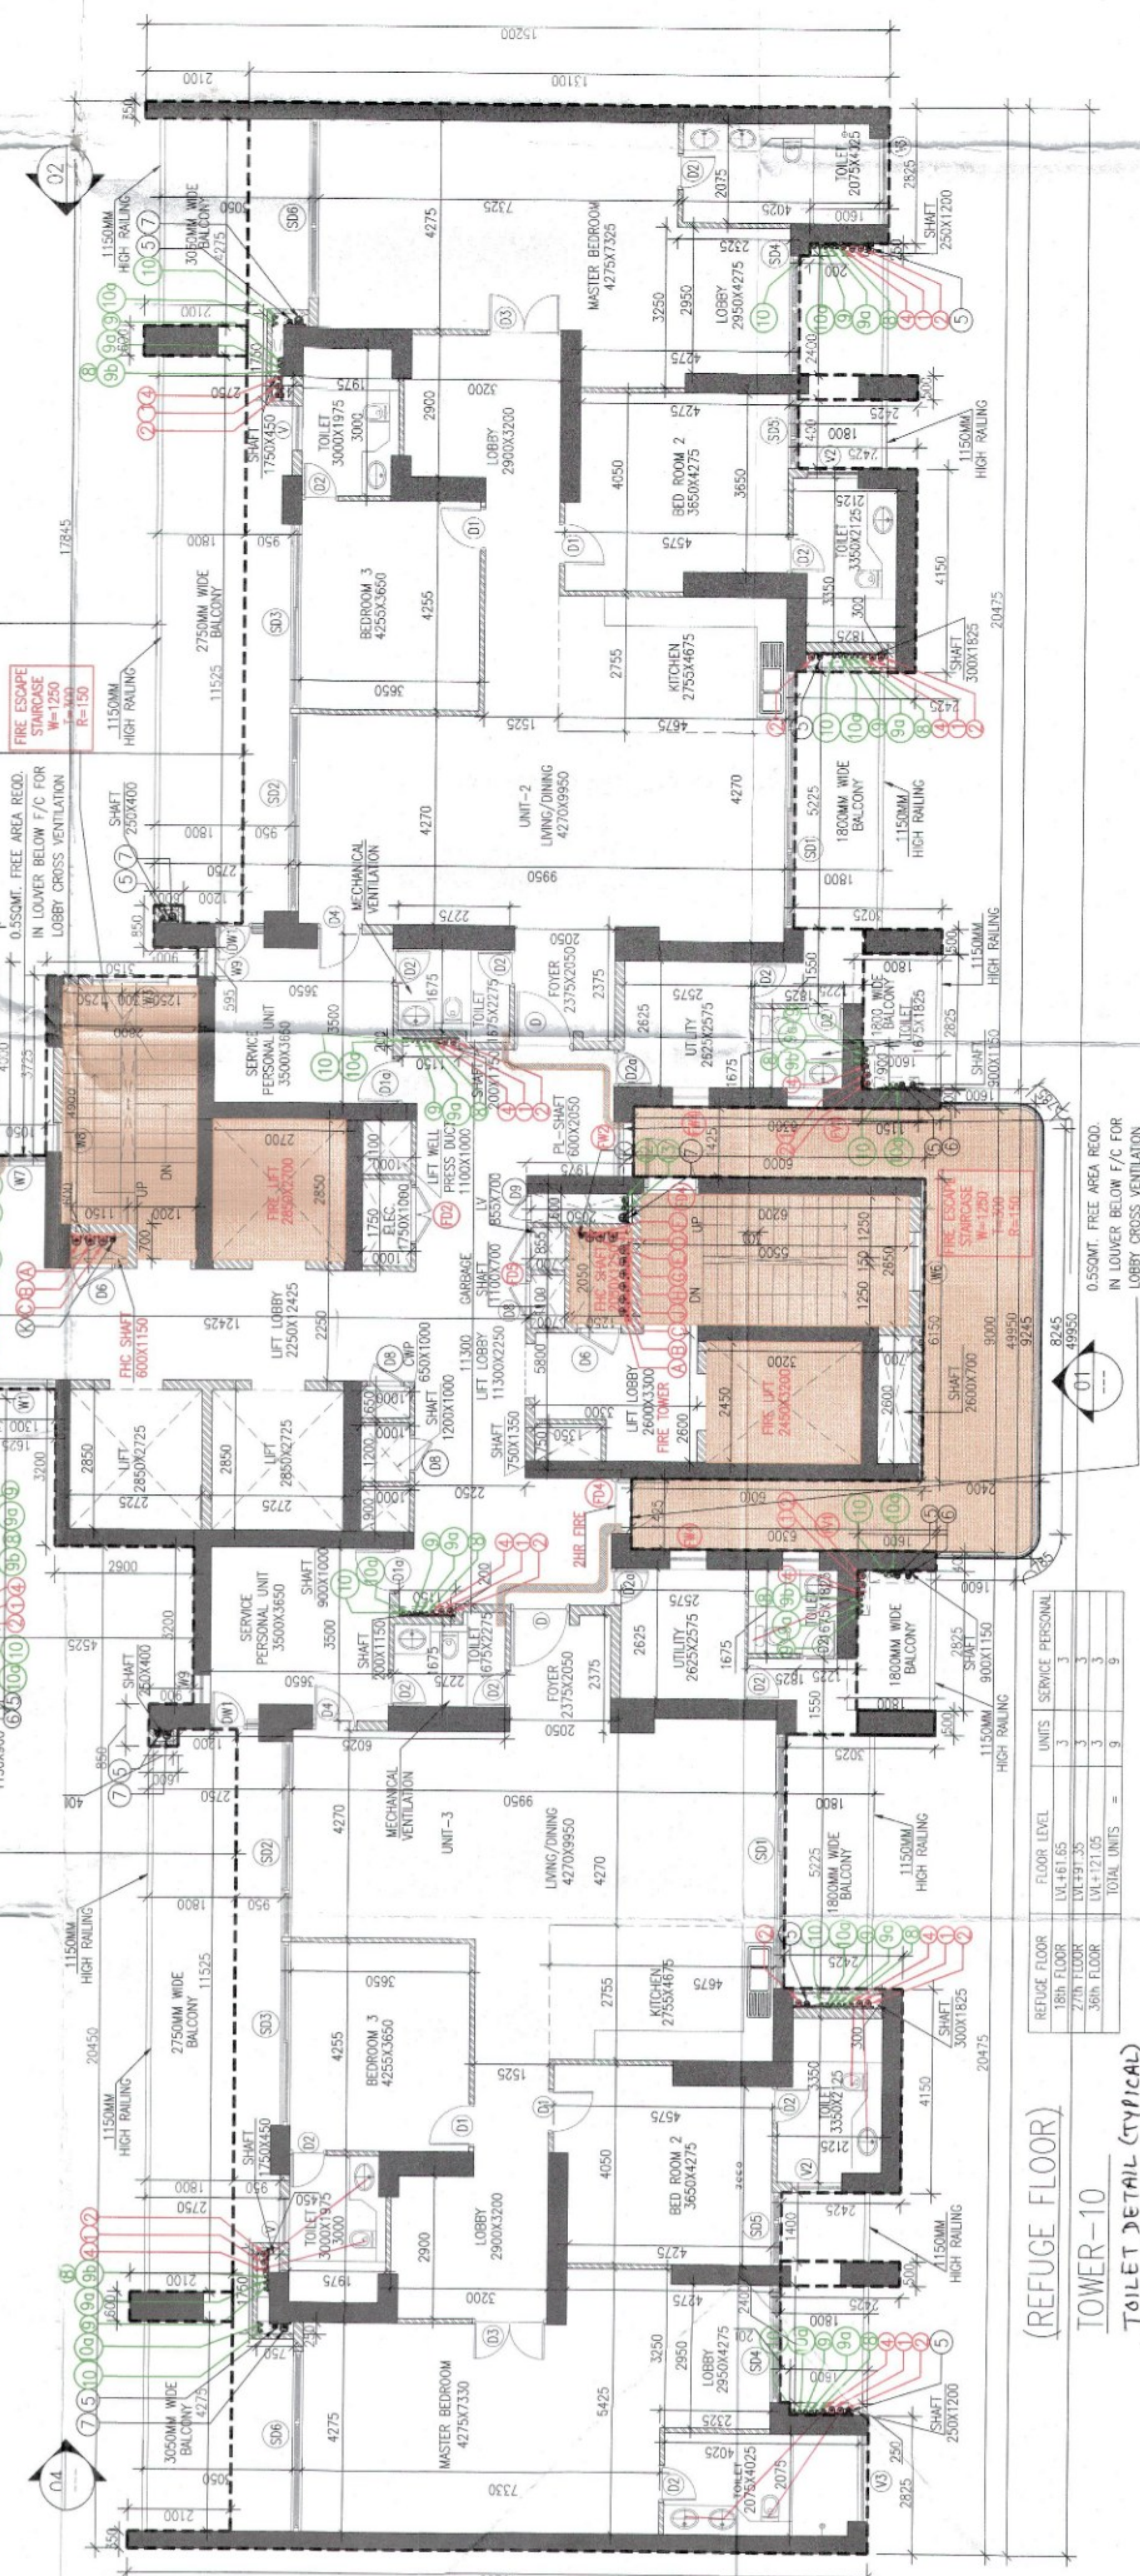

(REFUGE FLOOR)


TOWER-10
TOILET DETAIL (TYPICAL)

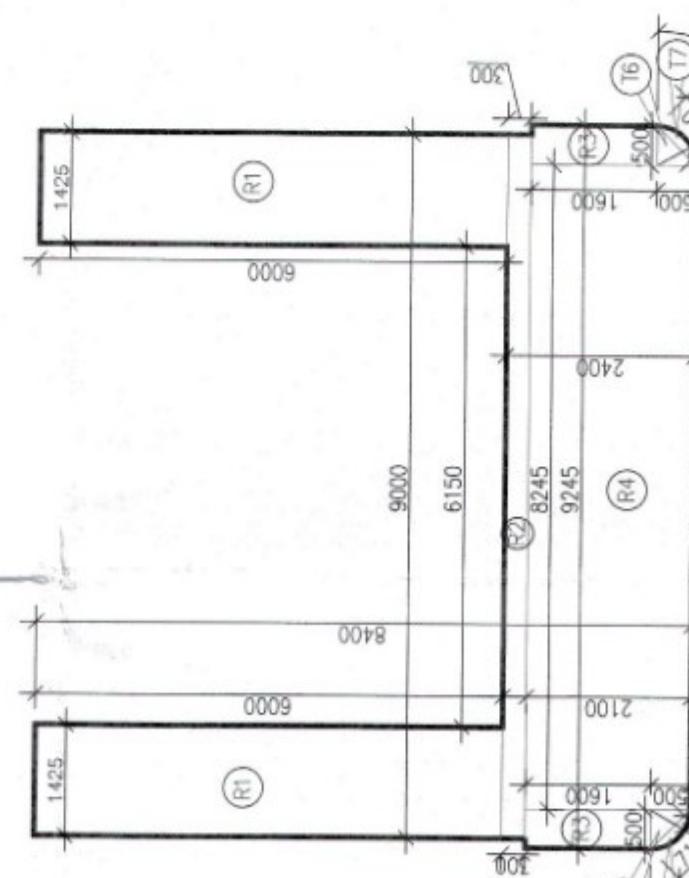

18TH, 27TH & 36TH FLOOR REFUGE AREA

[illegible]

ARC AREA					
GROSS - B					
T7	=	Z	X	3.14	x
				0.500	x
				0.500	x
				90	\
				360	\
				0.5	x
				0.500	-
				0.145	x
				0.710	x

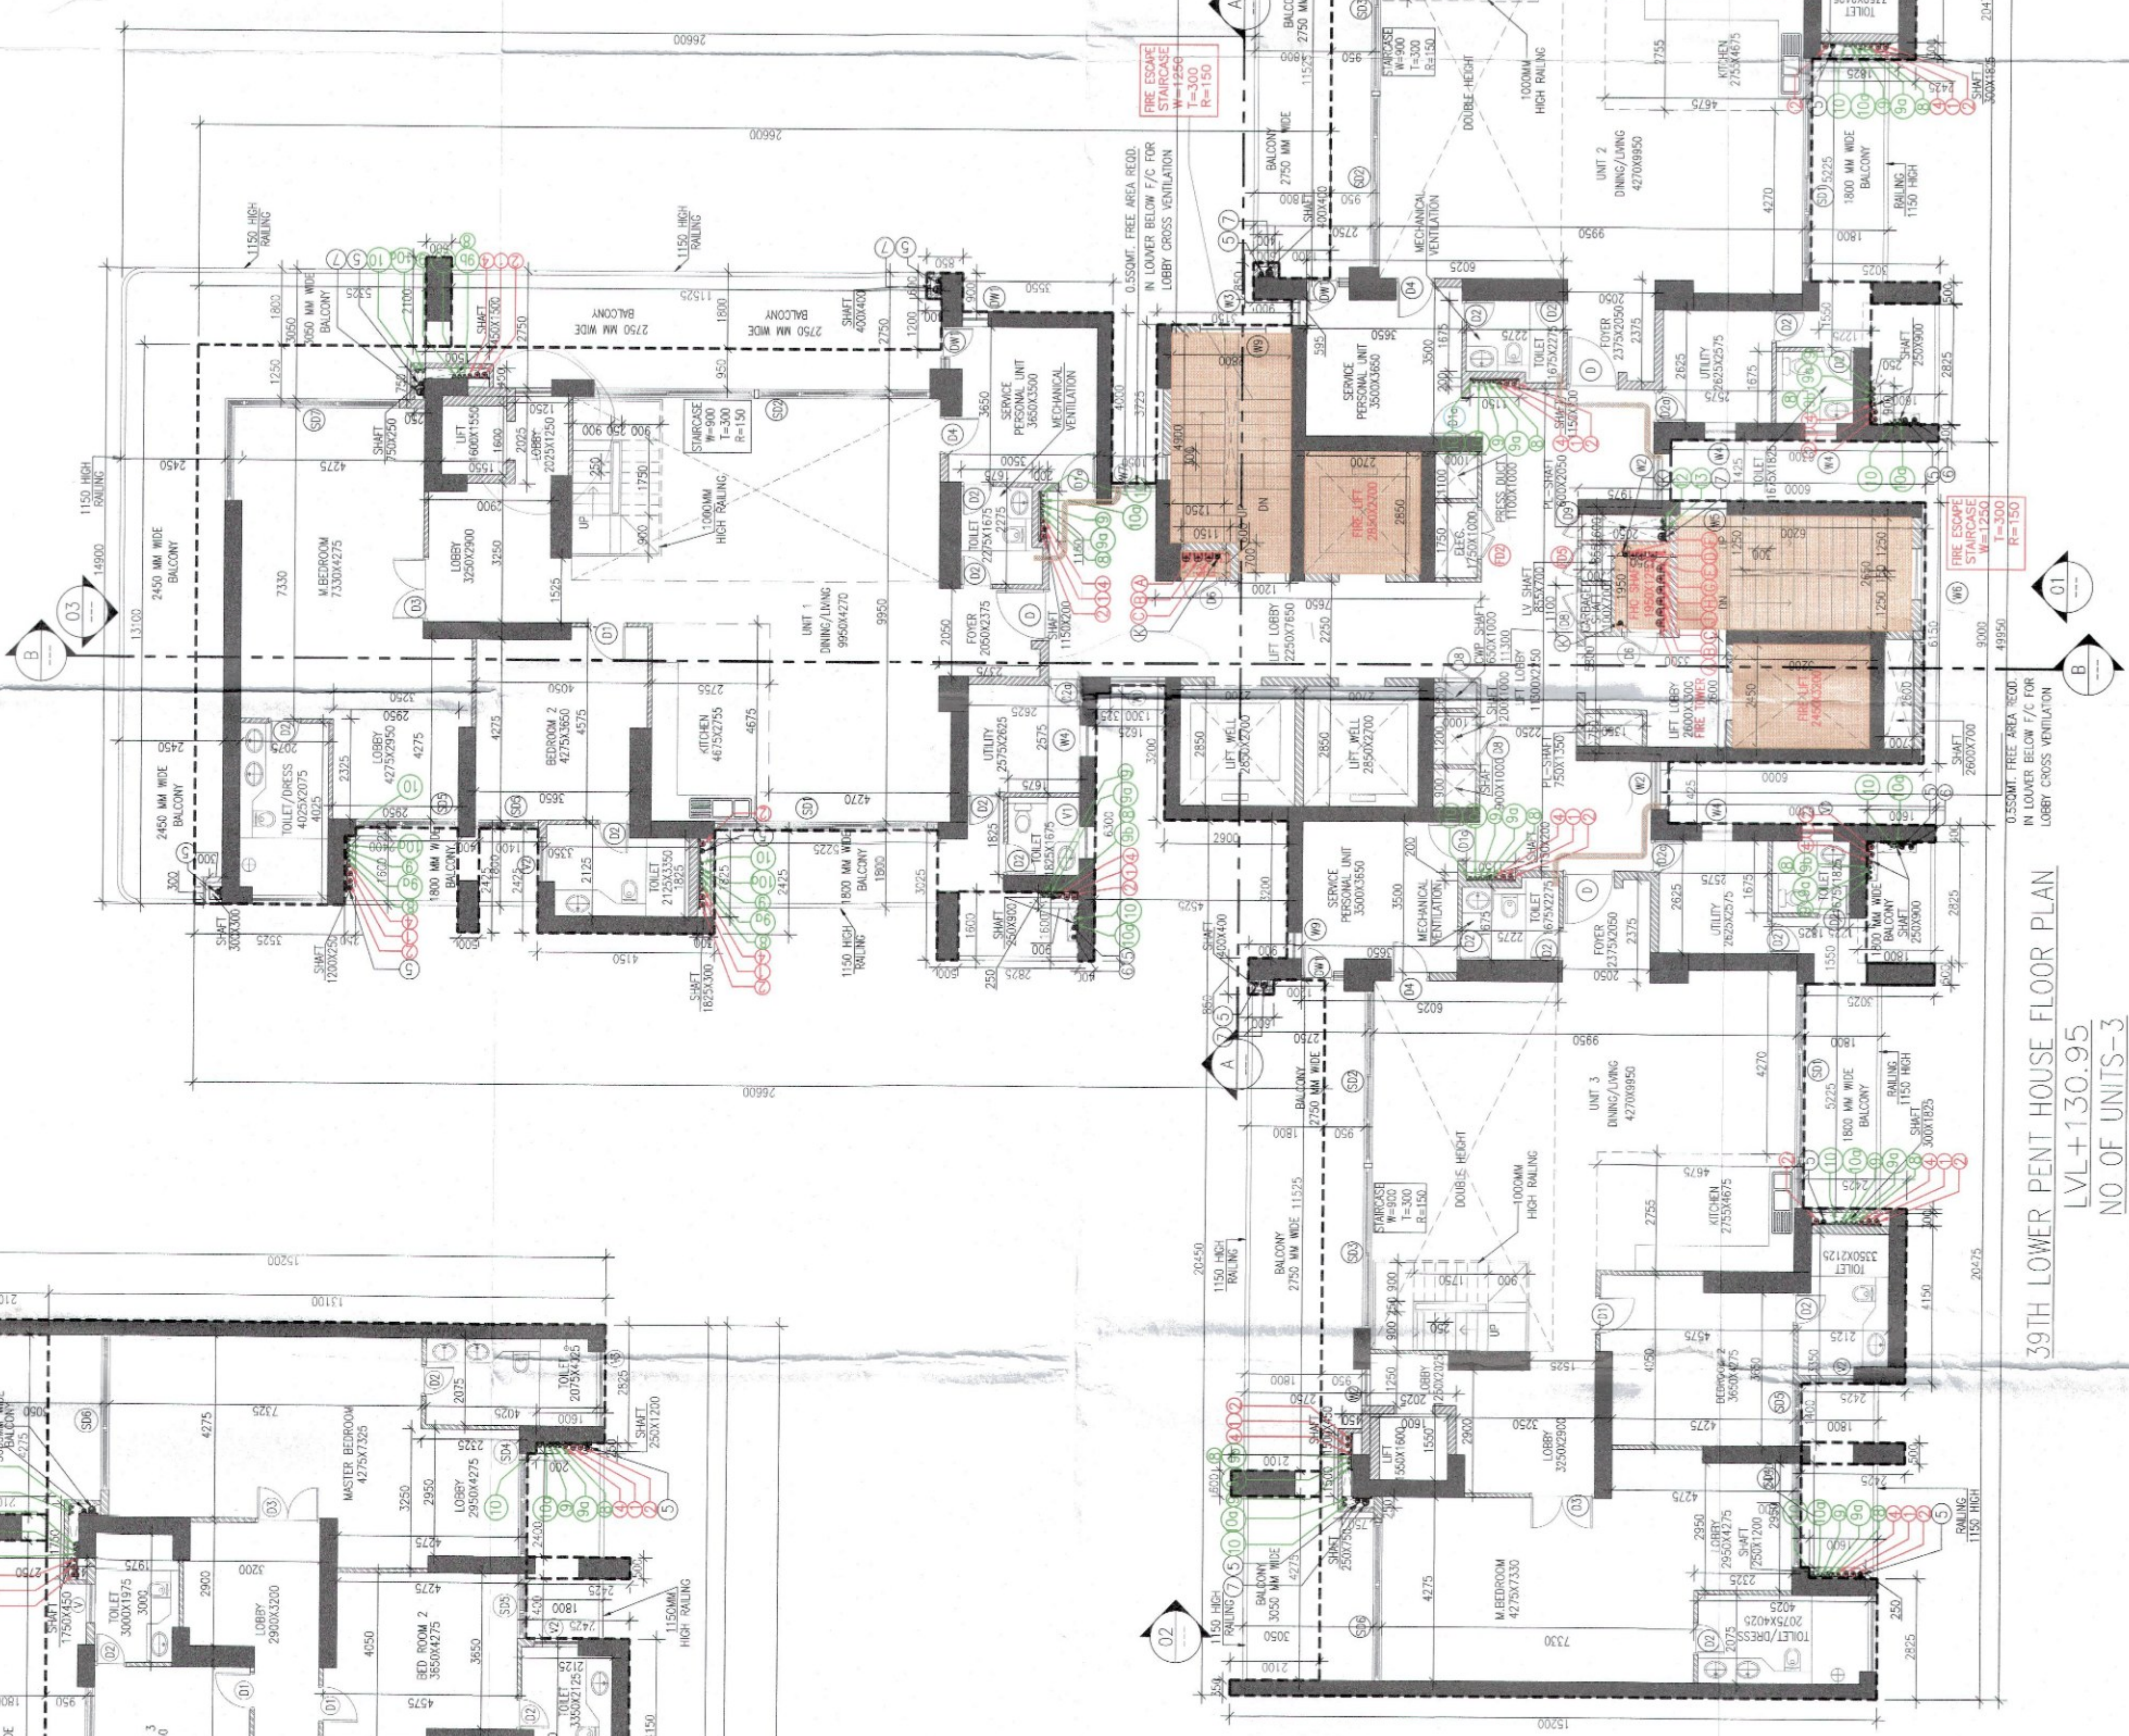

39TH LOWER PENT HOUSE FLOOR PLAN

LVL+130.95

NO OF UNITS-3

NO OF SERVICE PERSONAL-3

TOWER- 10

SUBJECT:

ADDITIONAL & REVISED BUILDING PLANS FOR GROUP HOUSING COLONY UNDER MIX LAND USE ZONED ZONE (99% GH COMPONENT + 01% COMMERCIAL COMPONENT) WITH 350 FAR (LICENCE NO 80 OF 2012 DATED 17.08.2012) OVER AN AREA MEASURING 24.10 ACRES FALLING IN SECTOR 106, GURUGRAM BEING DEVELOPED BY ELAN AVENUE LTD AND OTHERS' (PRIOR KNOWN AS AIRMID DEVELOPERS (I)D.)

SEAL
URE

an Avenue Limited
Authorised Signatory

ARCHITECT'S SEAL
& SIGNATURE

Ar. Randeep Kumar
CA/2012/55971

Check found ok for Public Health
(Info.) Service only subject to comments in
2-1122-2712

JUNE.-2024.

Scale : 1:100

1 / 1 Accounting Engineering Drawing No:-

✓ Engineer-I
✓ P, Panchkula
✓ WER-10

© 2007 The Authors
Journal compilation © 2007 Blackwell Publishing Ltd

39TH FLOOR PLAN