


PLUMBING LEGEND -			
1	100/150/200 WATER PIPE	100/150/200 WATER PIPE FOR BALCONY	2400
2	100/150/200 WATER PIPE	100/150/200 WATER PIPE FOR TERRACE	2400
3	100/150/200 WATER PIPE	100/150/200 WATER PIPE FOR TERRACE	2400
4	75/100/125 WATER PIPE	75/100/125 WATER PIPE FOR TERRACE	2400
5	100/150/200 WATER PIPE	100/150/200 WATER PIPE FOR TERRACE	2400
6	100/150/200 WATER PIPE	100/150/200 WATER PIPE FOR TERRACE	2400
7	100/150/200 WATER PIPE	100/150/200 WATER PIPE FOR TERRACE	2400
8	100/150/200 WATER PIPE	100/150/200 WATER PIPE FOR TERRACE	2400
9	100/150/200 WATER PIPE	100/150/200 WATER PIPE FOR TERRACE	2400
10	100/150/200 WATER PIPE	100/150/200 WATER PIPE FOR TERRACE	2400
11	100/150/200 WATER PIPE	100/150/200 WATER PIPE FOR TERRACE	2400
12	100/150/200 WATER PIPE	100/150/200 WATER PIPE FOR TERRACE	2400


PLUMBING LEGEND -			
1	100/150/200 WATER PIPE	100/150/200 WATER PIPE FOR BALCONY	2400
2	100/150/200 WATER PIPE	100/150/200 WATER PIPE FOR TERRACE	2400
3	100/150/200 WATER PIPE	100/150/200 WATER PIPE FOR TERRACE	2400
4	75/100/125 WATER PIPE	75/100/125 WATER PIPE FOR TERRACE	2400
5	100/150/200 WATER PIPE	100/150/200 WATER PIPE FOR TERRACE	2400
6	100/150/200 WATER PIPE	100/150/200 WATER PIPE FOR TERRACE	2400
7	100/150/200 WATER PIPE	100/150/200 WATER PIPE FOR TERRACE	2400
8	100/150/200 WATER PIPE	100/150/200 WATER PIPE FOR TERRACE	2400
9	100/150/200 WATER PIPE	100/150/200 WATER PIPE FOR TERRACE	2400
10	100/150/200 WATER PIPE	100/150/200 WATER PIPE FOR TERRACE	2400
11	100/150/200 WATER PIPE	100/150/200 WATER PIPE FOR TERRACE	2400
12	100/150/200 WATER PIPE	100/150/200 WATER PIPE FOR TERRACE	2400

SCHEDULE OF DOORS & WINDOWS			
D	TYPE	LOCATION	QTY
D1	900x2100	FRONT DOOR (1st FLOOR)	2400
D2	900x2100	FRONT DOOR (1st FLOOR)	2400
D3	900x2100	FRONT DOOR (1st FLOOR)	2400
D100	900x2100	FRONT DOOR (1st FLOOR)	2400

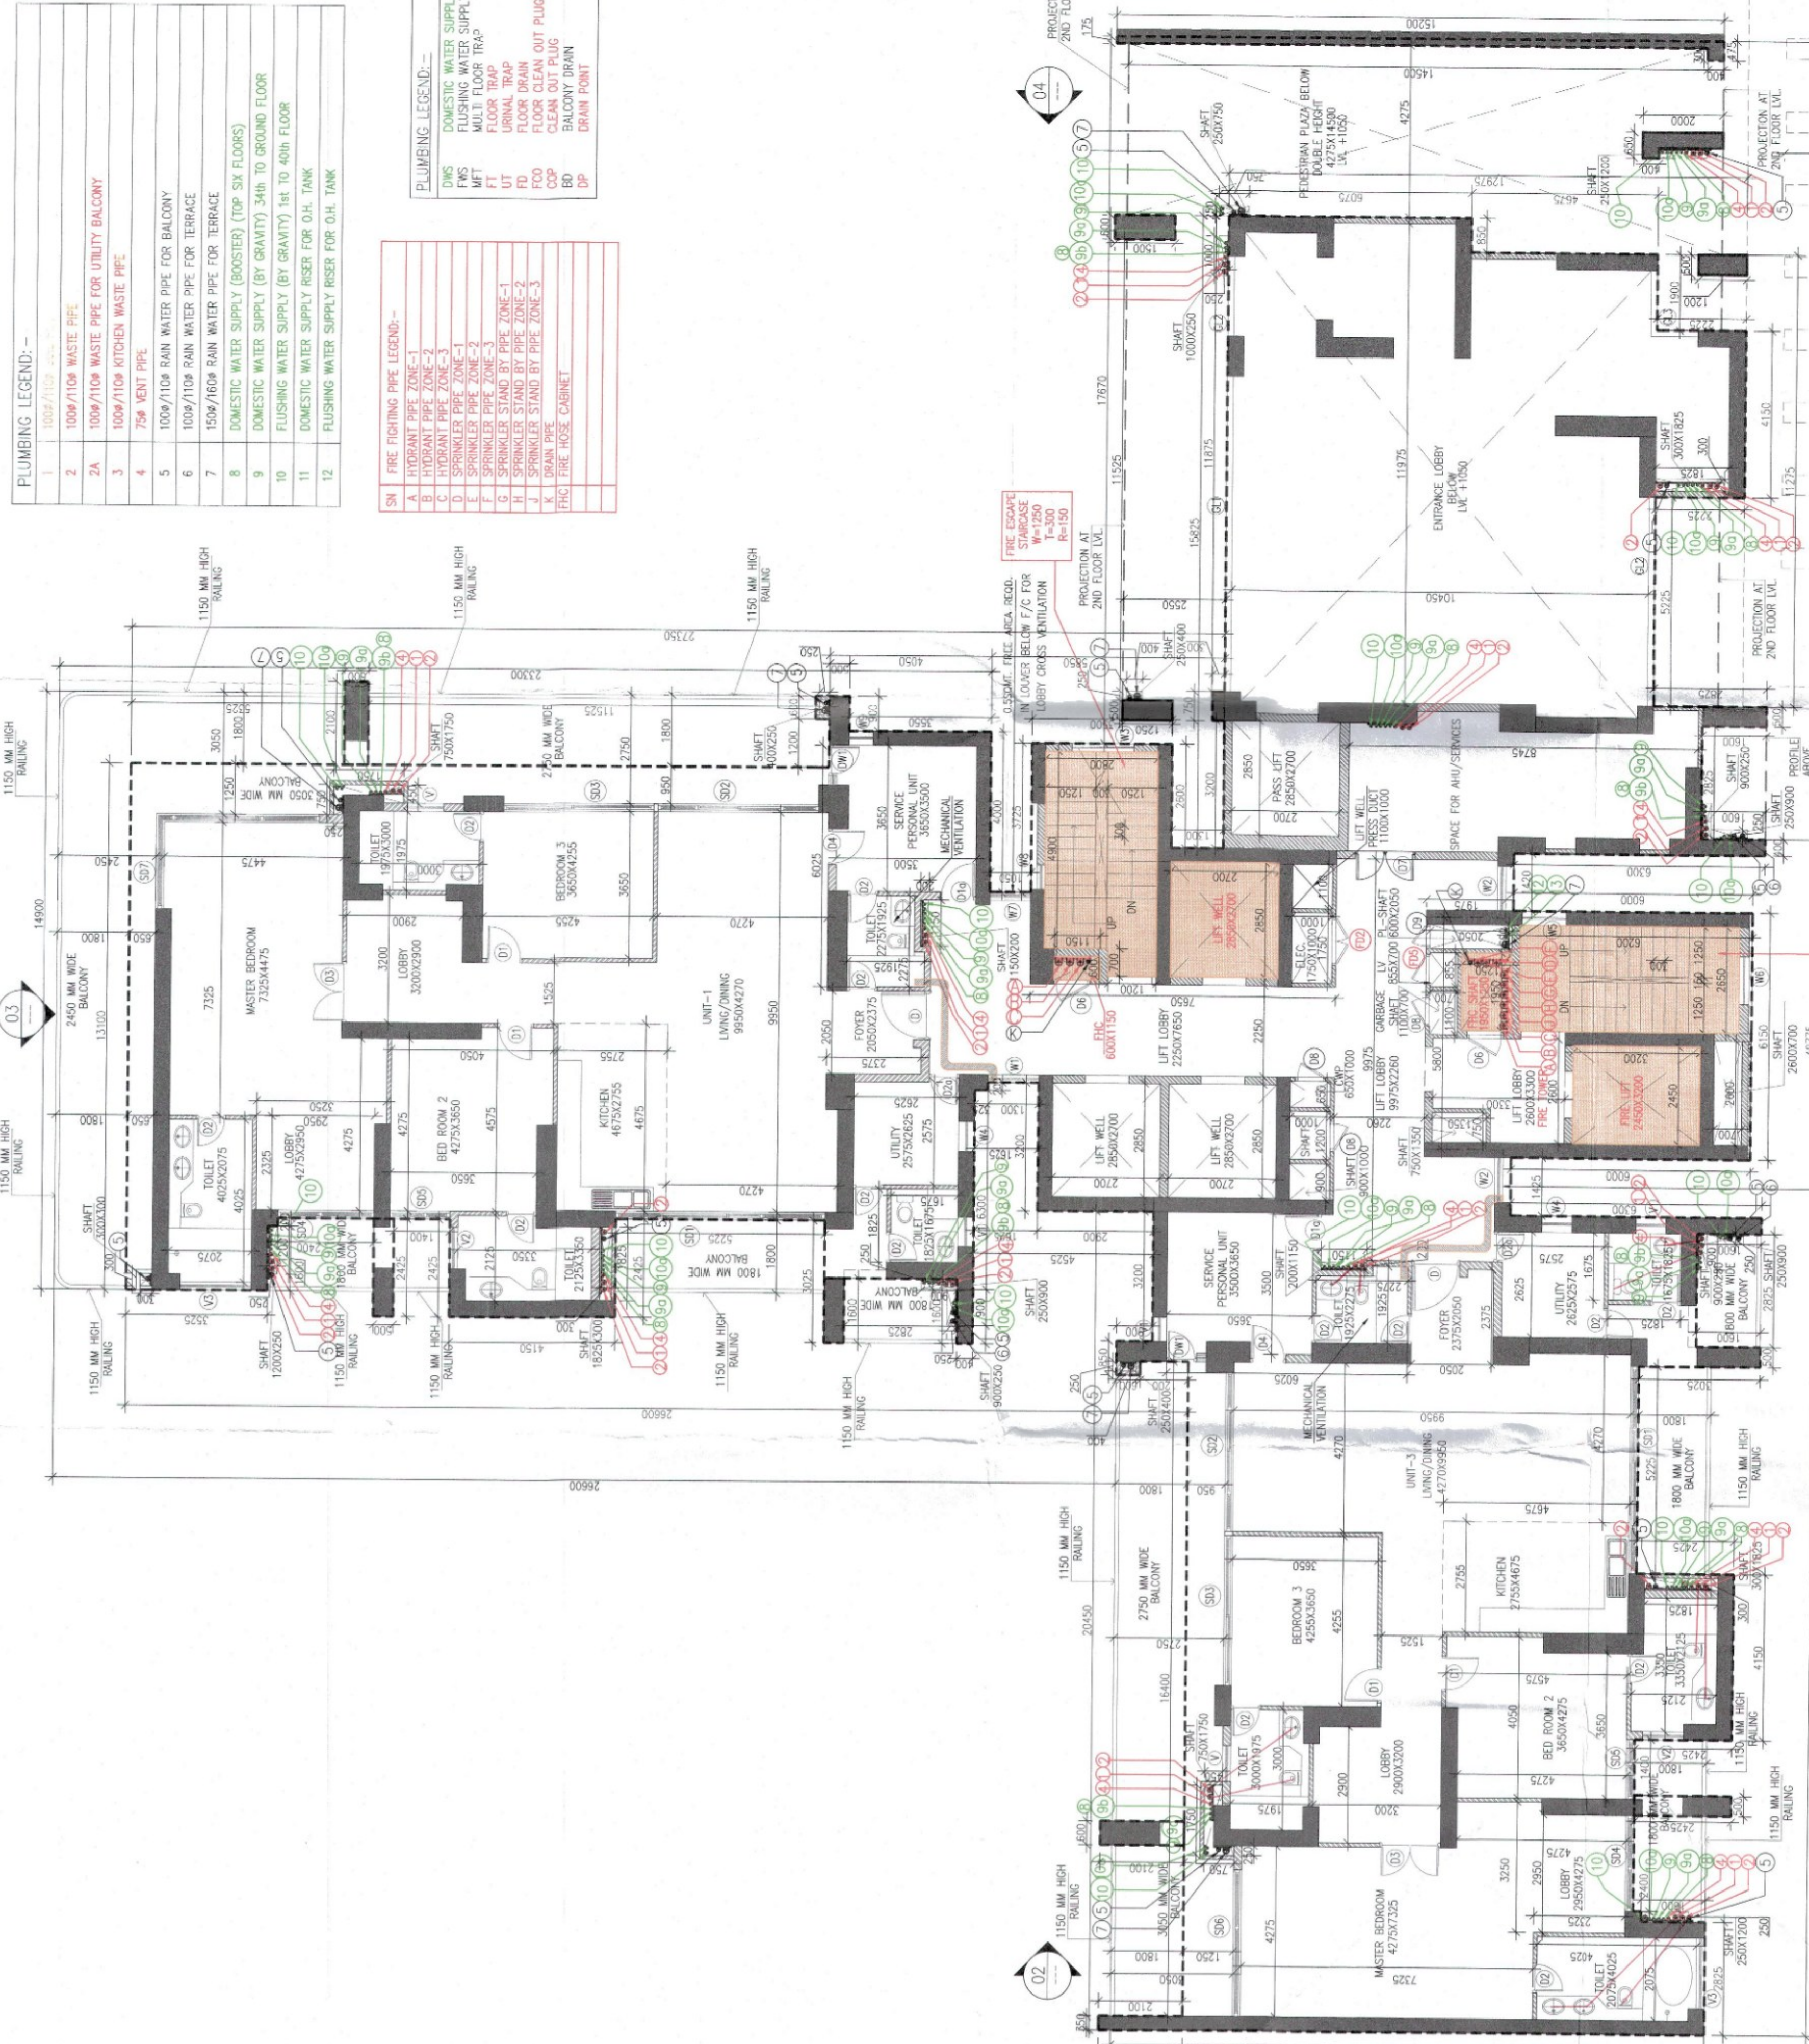

FIRST FLOOR PLAN
LVL: F5.55
NO. OF UNITS - 2
NO. OF SERVICE PERSONAL - 2
TOWER - 11

Typical Mechanical Ventilation Calculation for WC									
S. No.	LOCATION	Room Description	Area (sqm)	Volume (cu m)	Height (m)	Exhaust Duct Diameter (mm)	Exhaust Duct Length (m)	Exhaust Duct Material	Exhaust Duct Cost (Rs)
1.1	Typical Mechanical Ventilation Calculation for WC	WC	2.295	2.295	2.295	100	2.295	100	2.295
1.2	Typical Mechanical Ventilation Calculation for WC	WC	2.295	2.295	2.295	100	2.295	100	2.295

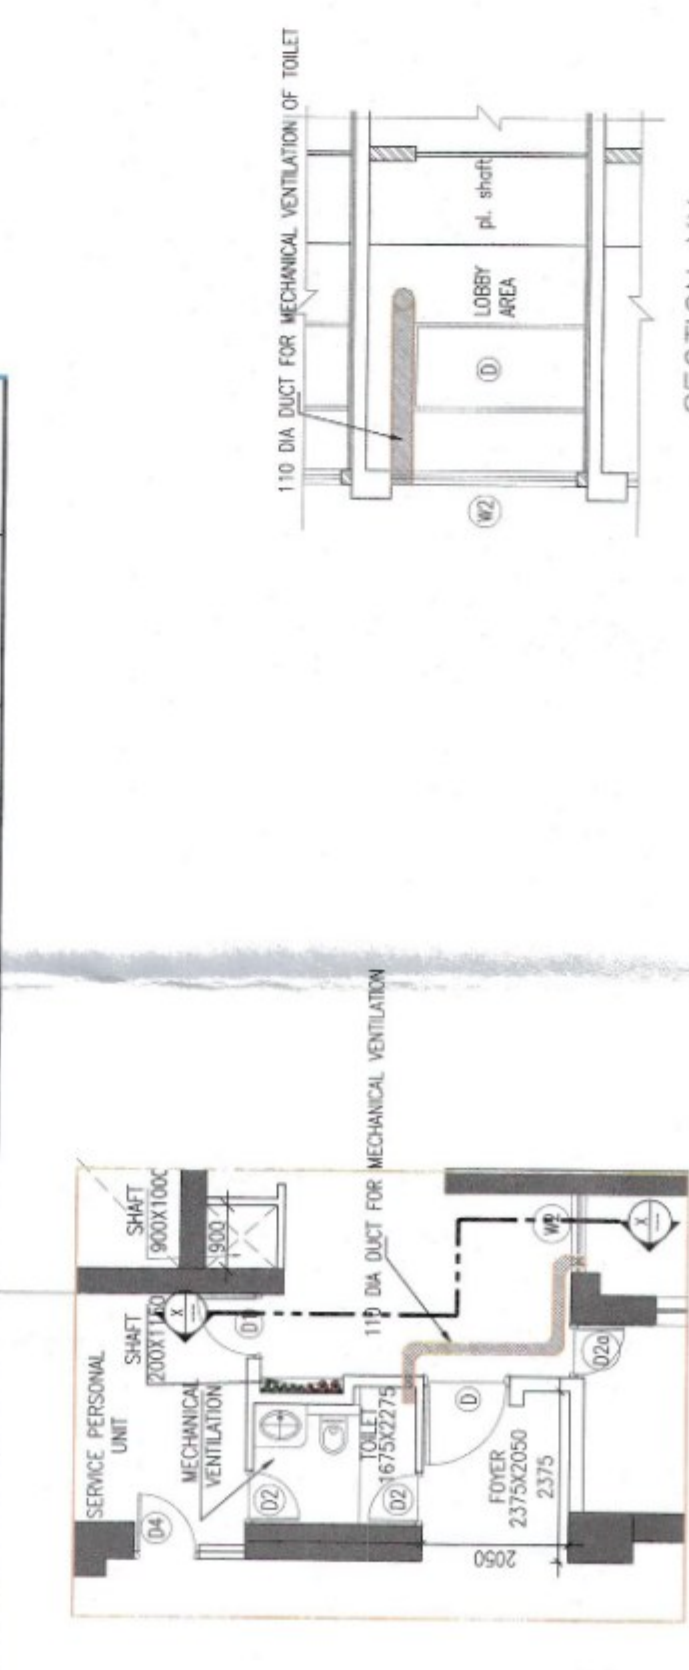


DETAIL FOR MECHANICAL VENTILATION OF TOILET AREA

SERVICE PERSONAL UNIT (CARPET AREA)									
S. No.	LOCATION	Room Description	Area (sqm)	Volume (cu m)	Height (m)	Exhaust Duct Diameter (mm)	Exhaust Duct Length (m)	Exhaust Duct Material	Exhaust Duct Cost (Rs)
1.1	Typical Mechanical Ventilation Calculation for WC	WC	2.295	2.295	2.295	100	2.295	100	2.295
1.2	Typical Mechanical Ventilation Calculation for WC	WC	2.295	2.295	2.295	100	2.295	100	2.295

SERVICE PERSONAL UNIT (CARPET AREA)									
S. No.	LOCATION	Room Description	Area (sqm)	Volume (cu m)	Height (m)	Exhaust Duct Diameter (mm)	Exhaust Duct Length (m)	Exhaust Duct Material	Exhaust Duct Cost (Rs)
1.1	Typical Mechanical Ventilation Calculation for WC	WC	2.295	2.295	2.295	100	2.295	100	2.295
1.2	Typical Mechanical Ventilation Calculation for WC	WC	2.295	2.295	2.295	100	2.295	100	2.295

PERSONAL UNIT (CARPET AREA)
AREA DIAGRAM TOWER-11

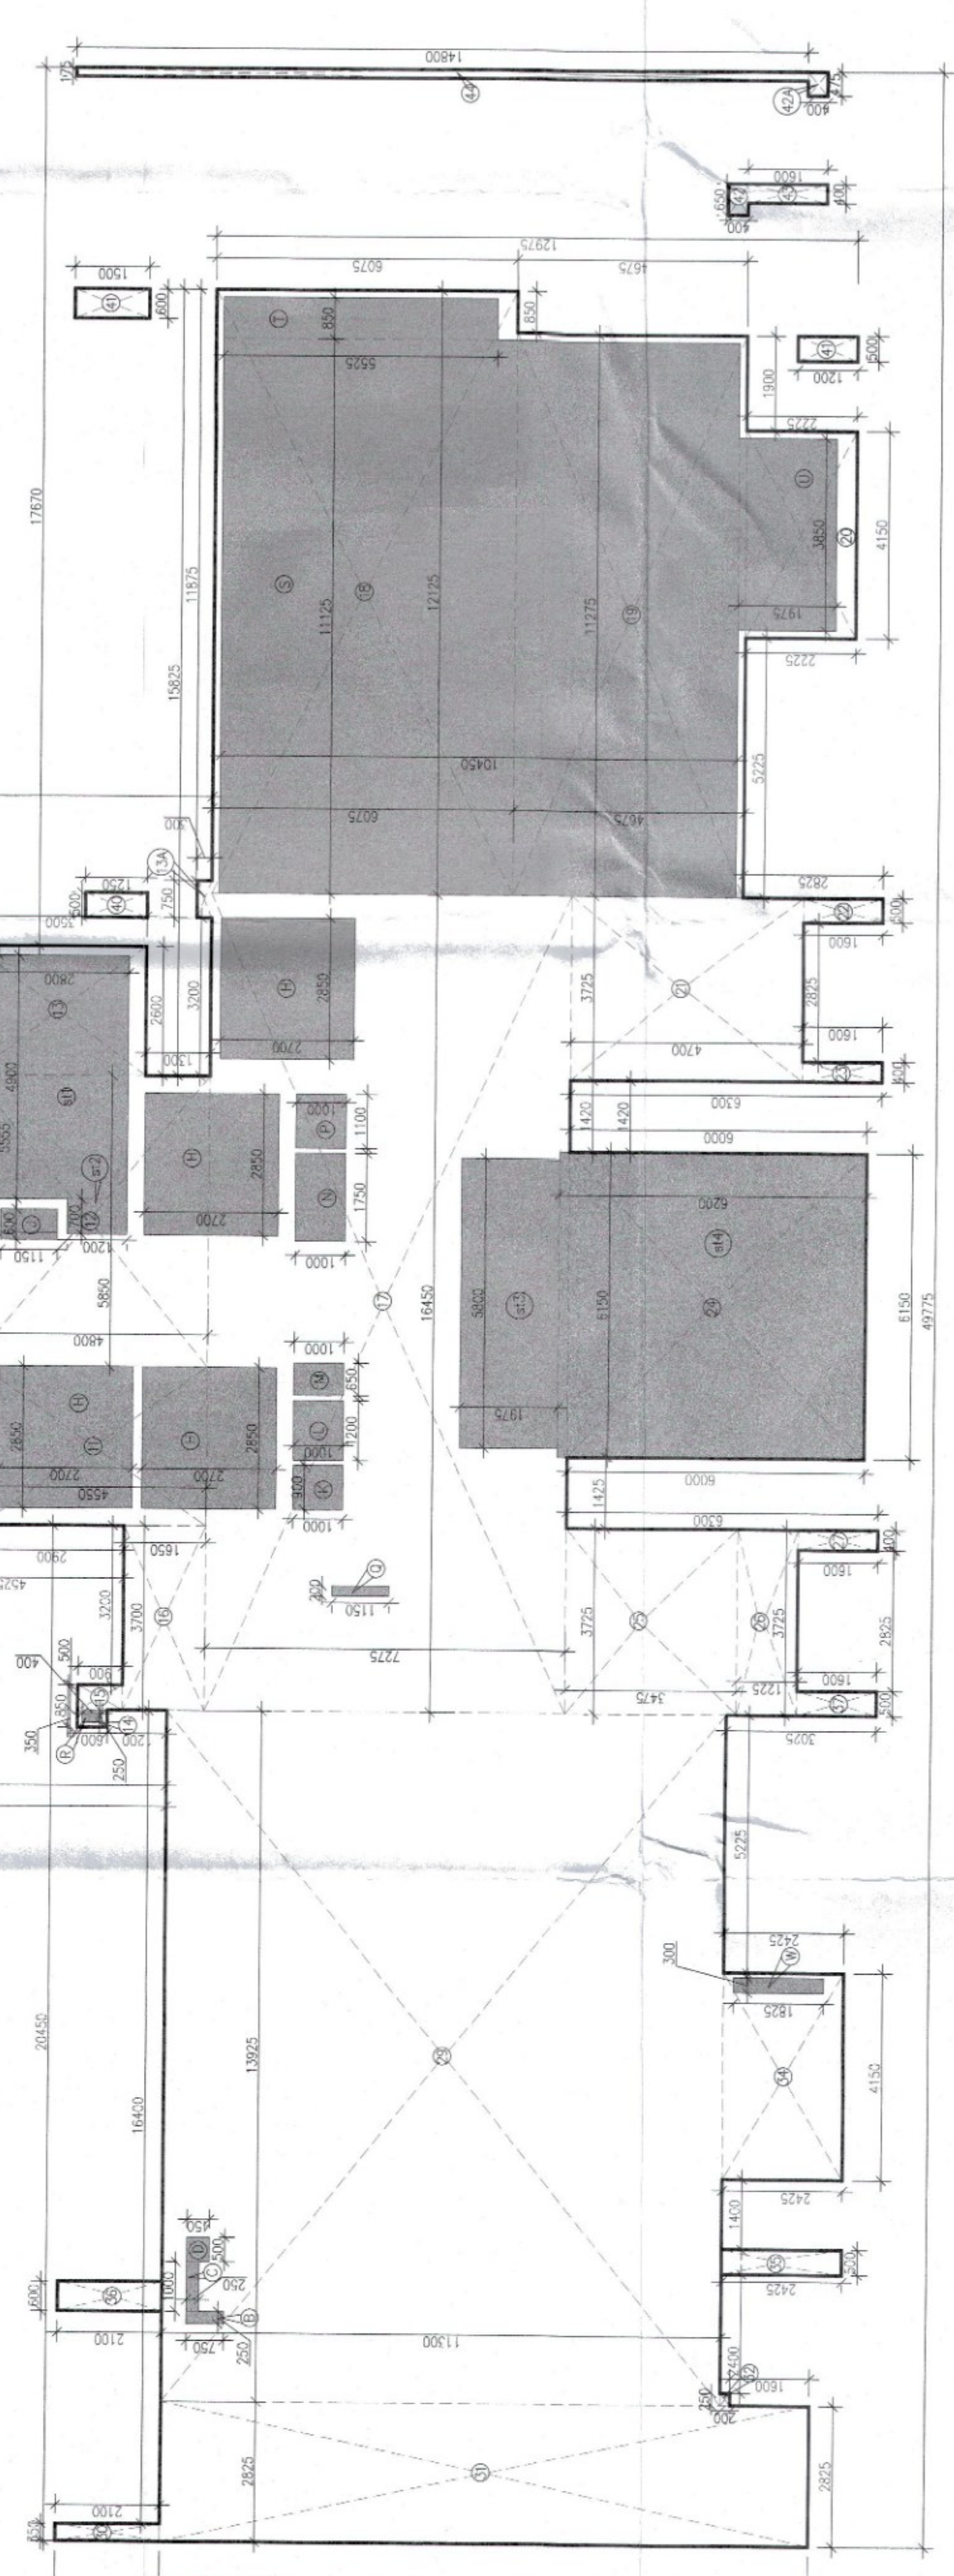

1ST FLOOR PLAN
AREA DIAGRAM
TOWER-11

Note:-

- BUILDING HAS AUTOMATIC SPRINKLER SYSTEM WHEREVER REQUIRED BY NBC.
- BUILDING WILL BE DESIGNED (STRUCTURES) AS PER RELEVANT IS CODES FOR EARTH QUAKE RESISTANCE.
- WC SHALL BE MECHANICALLY LIGHT & VENTILATED WHEREVER REQUIRED.

This is a PROVISIONAL BUILDING PLAN approved on 11.11.2024 for use of building. Objections, if any, to be made in writing to the Architect within 15 days of the date of approval.

TO BE READ WITH THIS OFFICE MEMO NO. 11/2024 DATED: 11/11/2024

PROJECT: ADDITIONAL & REVISED BUILDING PLANS FOR GROUP HOUSING COLONY UNDER MX LAND USE IN TDD ZONE (99% GR COMPONENT + 01% COMMERCIAL COMPONENT) WITH 350 FAR (LICENCE NO 80 OF 2012 DATED 17.08.2012) OVER AN AREA MEASURING 24.10 ACRES FALLING IN SECTOR 106, GURUGRAM BEING DEVELOPED BY ELAN AVENUE LTD AND OTHER'S (EARLIER KNOWN AS ARMD DEVELOPERS LTD.)

OWNER'S SEAL & SIGNATURE
Elan Avenue Limited
Authorized Signatory

ARCHITECT'S SEAL & SIGNATURE
Architect's Seal
Architect's Signature

DATE: 11/11/2024
Scale: 1:100
Drawing Title: TOWER-11
Drawing No: 11/2024