

TO BE READ WITH THIS OFFICE
MEMO NO.:
DA 30.

SCHEDULE OF DOORS & WINDOWS				LEVEL	REL. LVL.
TYPE	SIZE	LOCATION	DESCRIPTION		
D1A	120X2400	UNIT ENTRY	FIRE DOOR (1 HR)	2400	
D1B	360X2400	SERVICE RECIPIAL	MOLDED DOOR	2400	
D1C	360X2400	TOULIST/STAIR	FIRE DOOR (1 HR)	2400	
D1D	120X2400	MATERIAL ROOM	MOLDED DOOR	2400	
D1E	360X2400	RED ROOM	MOLDED DOOR	2400	
D1F	360X2400	FIRE TRAPED EXT	FIRE TRAPED EXT	2400	
D1G	360X2400	TOULIST/STAIR	FIRE DOOR (1 HR)	2400	
D1H	360X2400	ENTRANCE CORR	AL. GLASS DOOR	2400	
D1I	750 X 2300	STAIR CORR	MOLDED DOOR (1/2 HR)	1000	
D1J	750 X 2300	PLUMBING STAIR	MOLDED DOOR (1/2 HR)	1000	
D1K	750 X 2300	VENTILATION	PUMP ELECTRICAL	2400	
D1L	120X2400	ELECTRICAL SHED	DOOR/VENTILATION DOOR (1/2 HR)	2400	
D1M	110X2400	UNIT SHED	FIRE DOOR (1 HR)	2400	
D1N	750 X 2300	LOFT SHED	FIRE DOOR (1 HR)	1500	
D1O	501 X 525 X 2100	DISINTEGRATES	AL. SLIDING DOOR	2700	
D1P	501 X 525 X 2100	RED ROOM	AL. WINDOW	1300	
D1Q	501 X 525 X 2100	RED ROOM	AL. SLIDING DOOR	2700	
D1R	501 X 525 X 2100	LOBBY	AL. SLIDING DOOR	2700	
D1S	501 X 525 X 2100	LOBBY	AL. SLIDING DOOR	2700	
D1T	501 X 525 X 2100	RED ROOM	AL. SLIDING DOOR	2700	
D1U	1000 X 2300	UNIT	DOOR/WINDOW	600/200	
D1V	1000 X 2300	UNIT	DOOR/WINDOW	1000	
D1W	1000 X 2300	UNIT	LOBBY	1000	
D1X	1000 X 2300	LOBBY	FIRE GLASS (1 HR)	1000	
D1Y	1000 X 2300	LOBBY	FIRE GLASS (1 HR)	1200	
D1Z	750 X 2300	UNIT	AL. GLASS WINDOW	1000	
D2A	750 X 2300	UNIT	FIRE GLASS WINDOW	1000	
D2B	1200 X 2300	STAIRCASE	LOBBY	1000	
D2C	1200 X 2300	STAIRCASE	LOBBY	1000	
D2D	1000 X 1500	STAIRCASE	LOBBY	1000	
D2E	1000 X 1500	STAIRCASE	LOBBY	1000	
D2F	1000 X 1500	STAIRCASE	LOBBY	1000	
D2G	1000 X 1500	STAIRCASE	LOBBY	1000	
D2H	1000 X 1500	STAIRCASE	LOBBY	1000	
D2I	1000 X 1500	STAIRCASE	LOBBY	1000	
D2J	1000 X 1500	STAIRCASE	LOBBY	1000	
D2K	1000 X 1500	STAIRCASE	LOBBY	1000	
D2L	1000 X 1500	STAIRCASE	LOBBY	1000	
D2M	1000 X 1500	STAIRCASE	LOBBY	1000	
D2N	1000 X 1500	STAIRCASE	LOBBY	1000	
D2O	1000 X 1500	STAIRCASE	LOBBY	1000	
D2P	1000 X 1500	STAIRCASE	LOBBY	1000	
D2Q	1000 X 1500	STAIRCASE	LOBBY	1000	
D2R	1000 X 1500	STAIRCASE	LOBBY	1000	
D2S	1000 X 1500	STAIRCASE	LOBBY	1000	
D2T	1000 X 1500	STAIRCASE	LOBBY	1000	
D2U	1000 X 1500	STAIRCASE	LOBBY	1000	
D2V	1000 X 1500	STAIRCASE	LOBBY	1000	
D2W	1000 X 1500	STAIRCASE	LOBBY	1000	
D2X	1000 X 1500	STAIRCASE	LOBBY	1000	
D2Y	1000 X 1500	STAIRCASE	LOBBY	1000	
D2Z	1000 X 1500	STAIRCASE	LOBBY	1000	

Typical Mechanical Ventilation Calculation for WC										
Tower-11 Toilet Exhaust sheet										
S. No.	LOCATIONS	Toilet Dimension (in feet)		Toilet Area Width (in feet) x Length (in feet)		Toilet weight Toilet area (in sq ft) x Toilet weight (in lbs/cu ft)		Selected Exhaust Fan	Exhaust Size Fan Size Unit/ft Diameter (mm)	
2. Typical Mechanical Ventilation Calculation for WC										
1.	TOILET	2.275	1.875	3.81	41.08	2.70	8.66	36.4	73	
								140CFM CFM	300x126x180	110 (100)


PLUMBING LEGEND: -

1	100/110/120 - 250' x 12"	
2	100/110/120 WASTE PIPE	
3A	100/110/120 WASTE PIPE FOR UTILITY BALCONY	
3B	100/110/120 KITCHEN WASTE PIPE	
4	750' VENT PIPE	
5	100/110/120 RAIN WATER PIPE FOR BALCONY	
6	100/110/120 RAIN WATER PIPE FOR TERRACE	
7	1500/1100 RAIN WATER PIPE FOR TERRACE	
8	DOMESTIC WATER SUPPLY (ROOFTOP) (100' x 1/2" DOWNS)	
9	DOMESTIC WATER SUPPLY (BT GRANTY) 4" to 4000 FLOOR	
10	FLOODING WATER SUPPLY (BT GRANTY) 1" to 4000 FLOOR	
11	DOMESTIC WATER SUPPLY RISER FOR 0.4" TANK	
12	FLOODING WATER SUPPLY RISER FOR 0.4" TANK	

FIRE FIGHTING PIPE LEGEND -	
N	HYDRANT PIPE ZONE-1
M	HYDRANT PIPE ZONE-2
B	HYDRANT PIPE ZONE-3
C	SPRINKLER PIPE ZONE-1
D	SPRINKLER PIPE ZONE-2
E	SPRINKLER PIPE ZONE-3
G	SPRINKLER STAND BY PIPE ZONE-1
H	SPRINKLER STAND BY PIPE ZONE-2
J	SPRINKLER STAND BY PIPE ZONE-3
K	DRAIN PIPE
HC	FIRE HOSE CABINET

MECHANICAL VENTILATION OF TOILET AREA

SECTION XXV

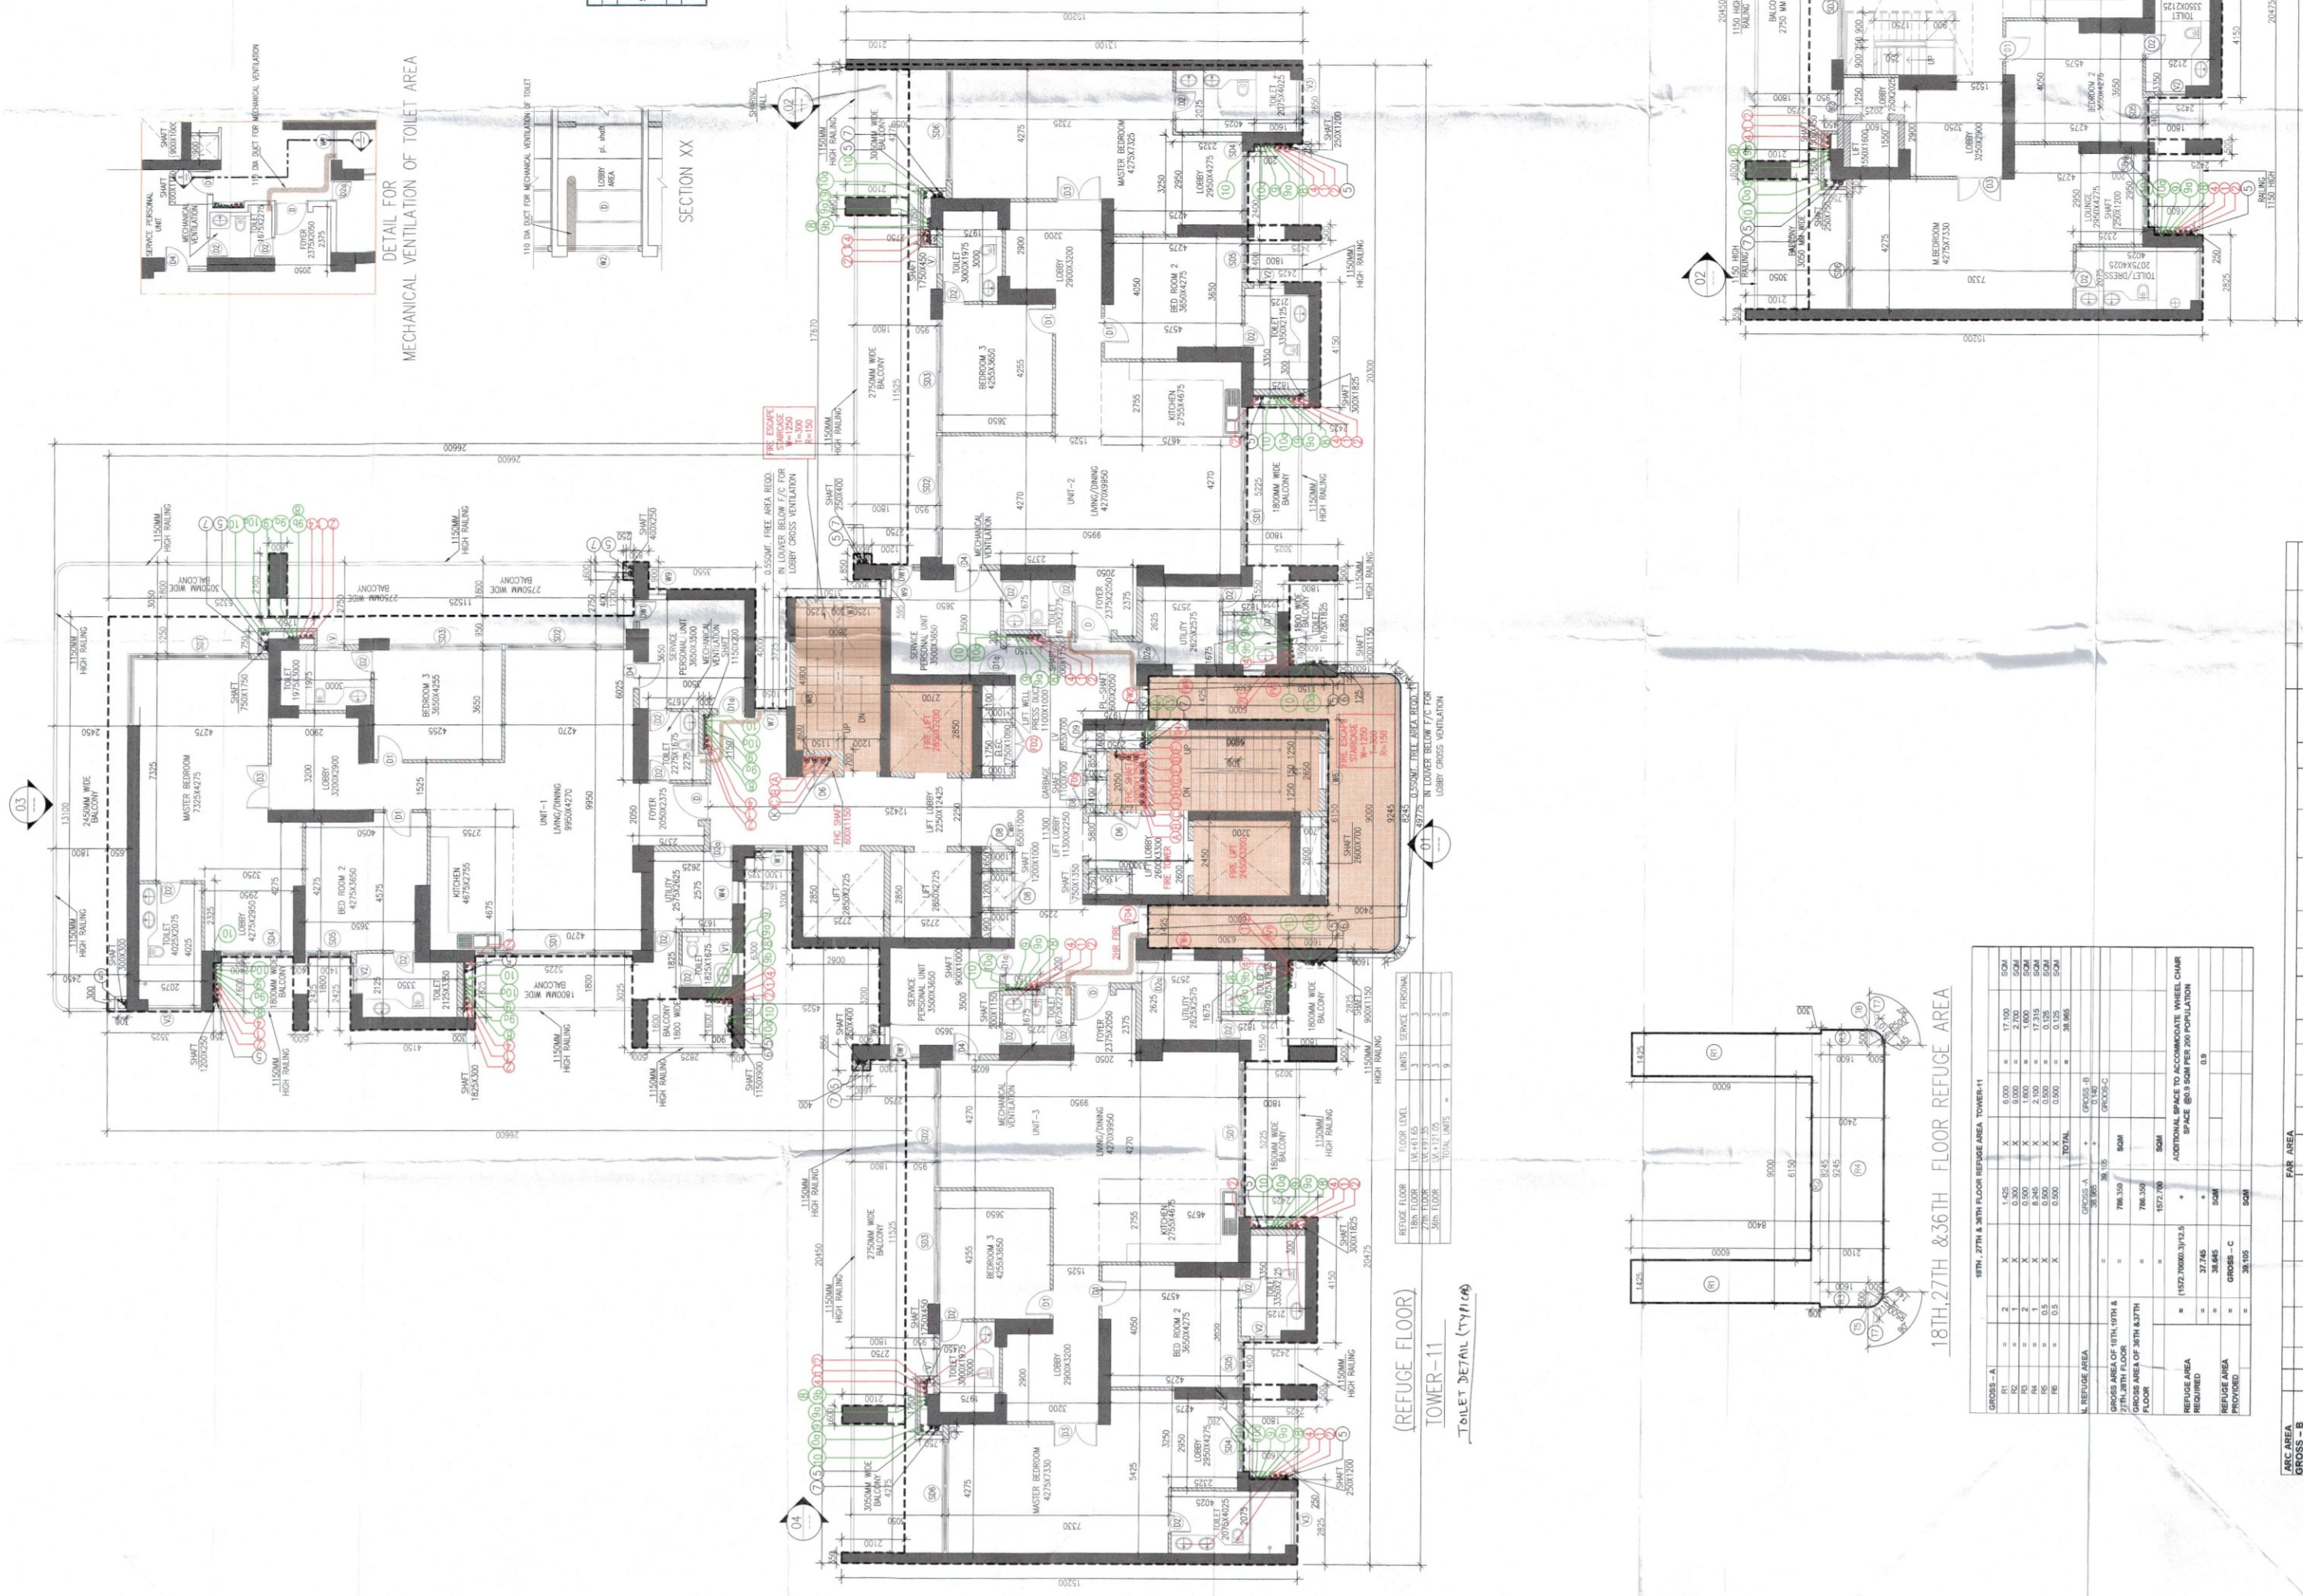

SITE: 27th & 17th RESURF. AREA, TOWER-11									
GRASS: A	=	2	0.42	0.84	0.00	=	17.92	524	
GRASS: B	=	1	0.00	0.00	0.00	=	0.00	0	
GRASS: C	=	1	0.00	0.00	0.00	=	0.00	0	
GRASS: D	=	1	0.00	0.00	0.00	=	0.00	0	
GRASS: E	=	1	0.00	0.00	0.00	=	0.00	0	
GRASS: F	=	1	0.00	0.00	0.00	=	0.00	0	
GRASS: G	=	1	0.00	0.00	0.00	=	0.00	0	
GRASS: H	=	1	0.00	0.00	0.00	=	0.00	0	
GRASS: I	=	1	0.00	0.00	0.00	=	0.00	0	
GRASS: J	=	1	0.00	0.00	0.00	=	0.00	0	
GRASS: K	=	1	0.00	0.00	0.00	=	0.00	0	
GRASS: L	=	1	0.00	0.00	0.00	=	0.00	0	
GRASS: M	=	1	0.00	0.00	0.00	=	0.00	0	
GRASS: N	=	1	0.00	0.00	0.00	=	0.00	0	
GRASS: O	=	1	0.00	0.00	0.00	=	0.00	0	
GRASS: P	=	1	0.00	0.00	0.00	=	0.00	0	
GRASS: Q	=	1	0.00	0.00	0.00	=	0.00	0	
GRASS: R	=	1	0.00	0.00	0.00	=	0.00	0	
GRASS: S	=	1	0.00	0.00	0.00	=	0.00	0	
GRASS: T	=	1	0.00	0.00	0.00	=	0.00	0	
GRASS: U	=	1	0.00	0.00	0.00	=	0.00	0	
GRASS: V	=	1	0.00	0.00	0.00	=	0.00	0	
GRASS: W	=	1	0.00	0.00	0.00	=	0.00	0	
GRASS: X	=	1	0.00	0.00	0.00	=	0.00	0	
GRASS: Y	=	1	0.00	0.00	0.00	=	0.00	0	
GRASS: Z	=	1	0.00	0.00	0.00	=	0.00	0	
GRASS: AA	=	1	0.00	0.00	0.00	=	0.00	0	
GRASS: AB	=	1	0.00	0.00	0.00	=	0.00	0	
GRASS: AC	=	1	0.00	0.00	0.00	=	0.00	0	
GRASS: AD	=	1	0.00	0.00	0.00	=	0.00	0	
GRASS: AE	=	1	0.00	0.00	0.00	=	0.00	0	
GRASS: AF	=	1	0.00	0.00	0.00	=	0.00	0	
GRASS: AG	=	1	0.00	0.00	0.00	=	0.00	0	
GRASS: AH	=	1	0.00	0.00	0.00	=	0.00	0	
GRASS: AI	=	1	0.00	0.00	0.00	=	0.00	0	
GRASS: AJ	=	1	0.00	0.00	0.00	=	0.00	0	
GRASS: AK	=	1	0.00	0.00	0.00	=	0.00	0	
GRASS: AL	=	1	0.00	0.00	0.00	=	0.00	0	
GRASS: AM	=	1	0.00	0.00	0.00	=	0.00	0	
GRASS: AN	=	1	0.00	0.00	0.00	=	0.00	0	
GRASS: AO	=	1	0.00	0.00	0.00	=	0.00	0	
GRASS: AP	=	1	0.00	0.00	0.00	=	0.00	0	
GRASS: AQ	=	1	0.00	0.00	0.00	=	0.00	0	
GRASS: AR	=	1	0.00	0.00	0.00	=	0.00	0	
GRASS: AS	=	1	0.00	0.00	0.00	=	0.00	0	
GRASS: AT	=	1	0.00	0.00	0.00	=	0.00	0	
GRASS: AU	=	1	0.00	0.00	0.00	=	0.00	0	
GRASS: AV	=	1	0.00	0.00	0.00	=	0.00	0	
GRASS: AW	=	1	0.00	0.00	0.00	=	0.00	0	
GRASS: AX	=	1	0.00	0.00	0.00	=	0.00	0	
GRASS: AY	=	1	0.00	0.00	0.00	=	0.00	0	
GRASS: AZ	=	1	0.00	0.00	0.00	=	0.00	0	
GRASS: BA	=	1	0.00	0.00	0.00	=	0.00	0	
GRASS: BB	=	1	0.00	0.00	0.00	=	0.00	0	
GRASS: BC	=	1	0.00	0.00	0.00	=	0.00	0	
GRASS: BD	=	1	0.00	0.00	0.00	=	0.00	0	
GRASS: BE	=	1	0.00	0.00	0.00	=	0.00	0	
GRASS: BF	=	1	0.00	0.00	0.00	=	0.00	0	
GRASS: BG	=	1	0.00	0.00	0.00	=	0.00	0	
GRASS: BH	=	1	0.00	0.00	0.00	=	0.00	0	
GRASS: BI	=	1	0.00	0.00	0.00	=	0.00	0	
GRASS: BJ	=	1	0.00	0.00	0.00	=	0.00	0	
GRASS: BK	=	1	0.00	0.00	0.00	=	0.00	0	
GRASS: BL	=	1	0.00	0.00	0.00	=	0.00	0	
GRASS: BM	=	1	0.00	0.00	0.00	=	0.00	0	
GRASS: BN	=	1	0.00	0.00	0.00	=	0.00	0	
GRASS: BO	=	1	0.00	0.00	0.00	=	0.00	0	
GRASS: BP	=	1	0.00	0.00	0.00	=	0.00	0	
GRASS: BQ	=	1	0.00	0.00	0.00	=	0.00	0	
GRASS: BR	=	1	0.00	0.00	0.00	=	0.00	0	
GRASS: BS	=	1	0.00	0.00	0.00	=	0.00	0	
GRASS: BT	=	1	0.00	0.00	0.00	=	0.00	0	
GRASS: BU	=	1	0.00	0.00	0.00	=	0.00	0	
GRASS: BV	=	1	0.00	0.00	0.00	=	0.00	0	
GRASS: BW	=	1	0.00	0.00	0.00	=	0.00	0	
GRASS: BX	=	1	0.00	0.00	0.00	=	0.00	0	
GRASS: BY	=	1	0.00	0.00	0.00	=	0.00	0	
GRASS: BZ	=	1	0.00	0.00	0.00	=	0.00	0	
GRASS: CA	=	1	0.00	0.00	0.00	=	0.00	0	
GRASS: CB	=	1	0.00	0.00	0.00	=	0.00	0	
GRASS: CC	=	1	0.00	0.00	0.00	=	0.00	0	
GRASS: CD	=	1	0.00	0.00	0.00	=	0.00	0	
GRASS: CE	=	1	0.00	0.00	0.00	=	0.00	0	
GRASS: CF	=	1	0.00	0.00	0.00	=	0.00	0	
GRASS: CG	=	1	0.00	0.00	0.00	=	0.00	0	
GRASS: CH	=	1	0.00	0.00	0.00	=	0.00	0	
GRASS: CI	=	1	0.00	0.00	0.00	=	0.00	0	
GRASS: CJ	=	1	0.00	0.00	0.00	=	0.00	0	
GRASS: CK	=	1	0.00	0.00	0.00	=	0.00	0	
GRASS: CL	=	1	0.00	0.00	0.00	=	0.00	0	
GRASS: CM	=	1	0.00	0.00	0.00	=	0.00	0	
GRASS: CN	=	1	0.00	0.00	0.00	=	0.00	0	
GRASS: CO	=	1	0.00	0.00	0.00	=	0.00	0	
GRASS: CP	=	1	0.00	0.00	0.00	=	0.00	0	
GRASS: CQ	=	1	0.00	0.00	0.00	=	0.00	0	
GRASS: CR	=	1	0.00	0.00	0.00	=	0.00	0	
GRASS: CS	=	1	0.00	0.00	0.00	=	0.00	0	
GRASS: CT	=	1	0.00	0.00	0.00	=	0.00	0	
GRASS: CU	=	1	0.00	0.00	0.00	=	0.00	0	
GRASS: CV	=	1	0.00	0.00	0.00	=	0.00	0	
GRASS: CW	=	1	0.00	0.00	0.00	=	0.00	0	
GRASS: CX	=	1	0.00	0.00	0.00	=	0.00	0	
GRASS: CY	=	1	0.00	0.00	0.00	=	0.00	0	
GRASS: CZ	=	1	0.00	0.00	0.00	=	0.00	0	
GRASS: DA	=	1	0.00	0.00	0.00	=	0.00	0	
GRASS: DB	=	1	0.00	0.00	0.00	=	0.00	0	
GRASS: DC	=	1	0.00	0.00	0.00	=	0.00	0	
GRASS: DD	=	1	0.00	0.00	0.00	=	0.00	0	
GRASS: DE	=	1	0.00	0.00	0.00	=	0.00	0	
GRASS: DF	=	1	0.00	0.00	0.00	=	0.00	0	
GRASS: DG	=	1	0.00	0.00	0.00	=	0.00	0	
GRASS: DH	=	1	0.00	0.00	0.00	=	0.00	0	
GRASS: DI	=	1	0.00	0.00	0.00	=	0.00	0	
GRASS: DJ	=	1	0.00	0.00	0.00	=	0.00	0	
GRASS: DK	=	1	0.00	0.00	0.00	=	0.00	0	
GRASS: DL	=	1	0.00	0.00	0.00	=	0.00	0	
GRASS: DM	=	1	0.00	0.00	0.00	=	0.00	0	
GRASS: DN	=	1	0.00	0.00	0.00	=	0.00	0	
GRASS: DO	=	1	0.00	0.00	0.00	=	0.00	0	
GRASS: DP	=	1	0.00	0.00	0.00	=	0.00	0	
GRASS: DQ	=	1	0.00	0.00	0.00	=	0.00	0	
GRASS: DR	=	1	0.00	0.00	0.00	=	0.00	0	
GRASS: DS	=	1	0.00	0.00	0.00	=	0.00	0	
GRASS: DT	=	1	0.00	0.00	0.00	=	0.00	0	
GRASS: DU	=	1	0.00	0.00	0.00	=	0.00	0	
GRASS: DV	=	1	0.00	0.00	0.00	=	0.00	0	
GRASS: DW	=	1	0.00	0.00	0.00	=	0.00	0	
GRASS: DX	=	1	0.00	0.00	0.00	=	0.00	0	
GRASS: DY	=	1	0.00	0.00	0.00	=	0.00	0	
GRASS: DZ	=	1	0.00	0.00	0.00	=	0.00	0	
GRASS: EA	=	1	0.00	0.00	0.00	=	0.00	0	
GRASS: EB	=	1	0.00	0.00	0.00	=	0.00	0	
GRASS: EC	=	1	0.00	0.00	0.00	=	0.00	0	
GRASS: ED	=	1	0.00	0.00	0.00	=	0.00	0	
GRASS: EE	=	1	0.00	0.00	0.00	=	0.00	0	
GRASS: EF	=	1	0.00	0.00	0.00	=	0.00	0	
GRASS: EG	=	1	0.00	0.00	0.00	=	0.00	0	
GRASS: EH	=	1	0.00	0.00	0.00	=	0.00	0	
GRASS: EI	=	1	0.00	0.00	0.00	=	0.00	0	
GRASS: EJ	=	1	0.00	0.00	0.00	=	0.00	0	
GRASS: EK	=	1	0.00	0.00	0.00	=	0.00	0	
GRASS: EL	=	1	0.00	0.00	0.00	=	0.00	0	
GRASS: EM	=	1	0.00	0.00	0.00	=	0.00	0	
GRASS: EN	=	1	0.00	0.00	0.00	=	0.00	0	
GRASS: EO	=	1	0.00	0.00	0.00	=	0.00	0	
GRASS: EP	=	1	0.00	0.00	0.00	=	0.00	0	
GRASS: EQ	=	1	0.00	0.00	0.00	=	0.00	0	
GRASS: ER	=	1	0.00	0.00	0.00	=	0.00	0	
GRASS: ES	=	1	0.00	0.00	0.00	=	0.00	0	
GRASS: ET	=	1	0.00	0.00	0.00	=	0.00	0	
GRASS: EU	=	1	0.00	0.00	0.00	=	0.00	0	
GRASS: EV	=	1	0.00	0.00	0.00	=	0.00	0	
GRASS: EW	=	1	0.00	0.00	0.00	=	0.00	0	
GRASS: EX	=	1	0.00	0.00	0.00	=	0.00	0	
GRASS: EY	=	1	0.00	0.00	0.00	=	0.00	0	
GRASS: EZ	=	1	0.00	0.00	0.00	=	0.00	0	
GRASS: FA	=	1	0.00	0.00	0.00	=	0.00	0	
GRASS: FB	=	1	0.00	0.00	0.00	=	0.00	0	
GRASS: FC	=	1	0.00	0.00	0.00	=	0.00	0	
GRASS: FD	=	1	0.00	0.00	0.00	=	0.00	0	
GRASS: FE	=	1	0.00	0.00	0.00	=	0.00	0	
GRASS: FF	=	1	0.00	0.00	0.00	=	0.00	0	
GRASS: FG	=	1	0.00	0.00	0.00	=	0.00	0	
GRASS: FH	=	1	0.00	0.00	0.00	=	0.00	0	
GRASS: FI	=	1	0.00	0.0					

[illegible]

39TH LOWER PENT HOUSE FLOOR PLAN

$$\underline{\text{LVL}+130.95}$$

NO OF SERVICE PERSONAL-3

TOWER- 11

PROJECT: ADDITIONAL & REVISED BUILDING PLANS FOR GROUP HOUSING COLONY UNDER MIX LAND USE IN TPO ZONE (99% GH COMPONENT + 01% COMMERCIAL COMPONENT) WITH 350 FAR (LICENCE NO 80 OF 2012 DATED 17/08/2012) OVER AN AREA MEASURING 24.10 ACRES FALLING IN SECTOR 106, GURURAM BEING DEVELOPED BY ELAN AVENUE LTD AND OTHER'S (EARLIER KNOWN AS AIRMD DEVELOPERS LTD.)

ER'S SEAL
GNATURE

S SEA
LIFE

Dr. Ravinder Kumar
CA/2012/55971

Checked and found ok for Public Health
 (C) Service only subject to comments in
 the forwarding letter No. 204123, dtd 23/07/2024

JUNE, -2024.

Scale: 1:100

Drawing No:—

39TH FLOOR PLAN

39TH FLOOR PLAN