

PLUMBING LEGEND:-

- 100V/100 SOL PIPE
- 100V/100 WASTE PIPE
- 100V/100 WASTE PIPE FOR UTILITY BALCONY
- 100V/100 WASTE PIPE FOR TERRACE
- 100V/100 WASTE PIPE FOR TERRACE
- 100V/100 RAIN WATER PIPE FOR TERRACE
- 100V/100 RAIN WATER PIPE FOR TERRACE
- 100V/100 RAIN WATER PIPE FOR TERRACE
- DOMESTIC WATER SUPPLY (BOOSTER) (TOP 5X FLOORS)
- DOMESTIC WATER SUPPLY (BY GRAVITY) 5X TO GROUND FLOOR
- FLUSHING WATER SUPPLY (BY GRAVITY) 14 TO 4TH FLOOR
- FLUSHING WATER SUPPLY RISER FOR C/L TANK
- FLUSHING WATER SUPPLY RISER FOR C/L TANK

PLUMBING LEGEND:-

- 100V/100 SOL PIPE
- 100V/100 WASTE PIPE
- 100V/100 WASTE PIPE FOR UTILITY BALCONY
- 100V/100 WASTE PIPE FOR TERRACE
- 100V/100 WASTE PIPE FOR TERRACE
- 100V/100 RAIN WATER PIPE FOR TERRACE
- 100V/100 RAIN WATER PIPE FOR TERRACE
- 100V/100 RAIN WATER PIPE FOR TERRACE
- DOMESTIC WATER SUPPLY (BOOSTER) (TOP 5X FLOORS)
- DOMESTIC WATER SUPPLY (BY GRAVITY) 5X TO GROUND FLOOR
- FLUSHING WATER SUPPLY (BY GRAVITY) 14 TO 4TH FLOOR
- FLUSHING WATER SUPPLY RISER FOR C/L TANK
- FLUSHING WATER SUPPLY RISER FOR C/L TANK


PLUMBING LEGEND:-

- 100V/100 SOL PIPE
- 100V/100 WASTE PIPE
- 100V/100 WASTE PIPE FOR UTILITY BALCONY
- 100V/100 WASTE PIPE FOR TERRACE
- 100V/100 WASTE PIPE FOR TERRACE
- 100V/100 RAIN WATER PIPE FOR TERRACE
- 100V/100 RAIN WATER PIPE FOR TERRACE
- 100V/100 RAIN WATER PIPE FOR TERRACE
- DOMESTIC WATER SUPPLY (BOOSTER) (TOP 5X FLOORS)
- DOMESTIC WATER SUPPLY (BY GRAVITY) 5X TO GROUND FLOOR
- FLUSHING WATER SUPPLY (BY GRAVITY) 14 TO 4TH FLOOR
- FLUSHING WATER SUPPLY RISER FOR C/L TANK
- FLUSHING WATER SUPPLY RISER FOR C/L TANK

Typical Mechanical Ventilation Calculation for WC

S. No.	LOCATIONS	Toilet Dimension in (mtr)	Toilet Area in (Sq Mtr)	Toilet Height in (mtr)	Toilet Volume in (Cuft)	Toilet Design Volume in (CFM)	Selected Exhaust Fan	Fan Size LxBxH (mm)	Exhaust Duct Size Diameter (mm)
1	Typical Mechanical Ventilation Calculation for WC								
1.1	ENTRANCE TOILET	2.275	1.675	3.81	41.08	2.70	8.86	364	73
							14100 CFM, inline Fan	300x250x180	110 (OD)



SECTION XX

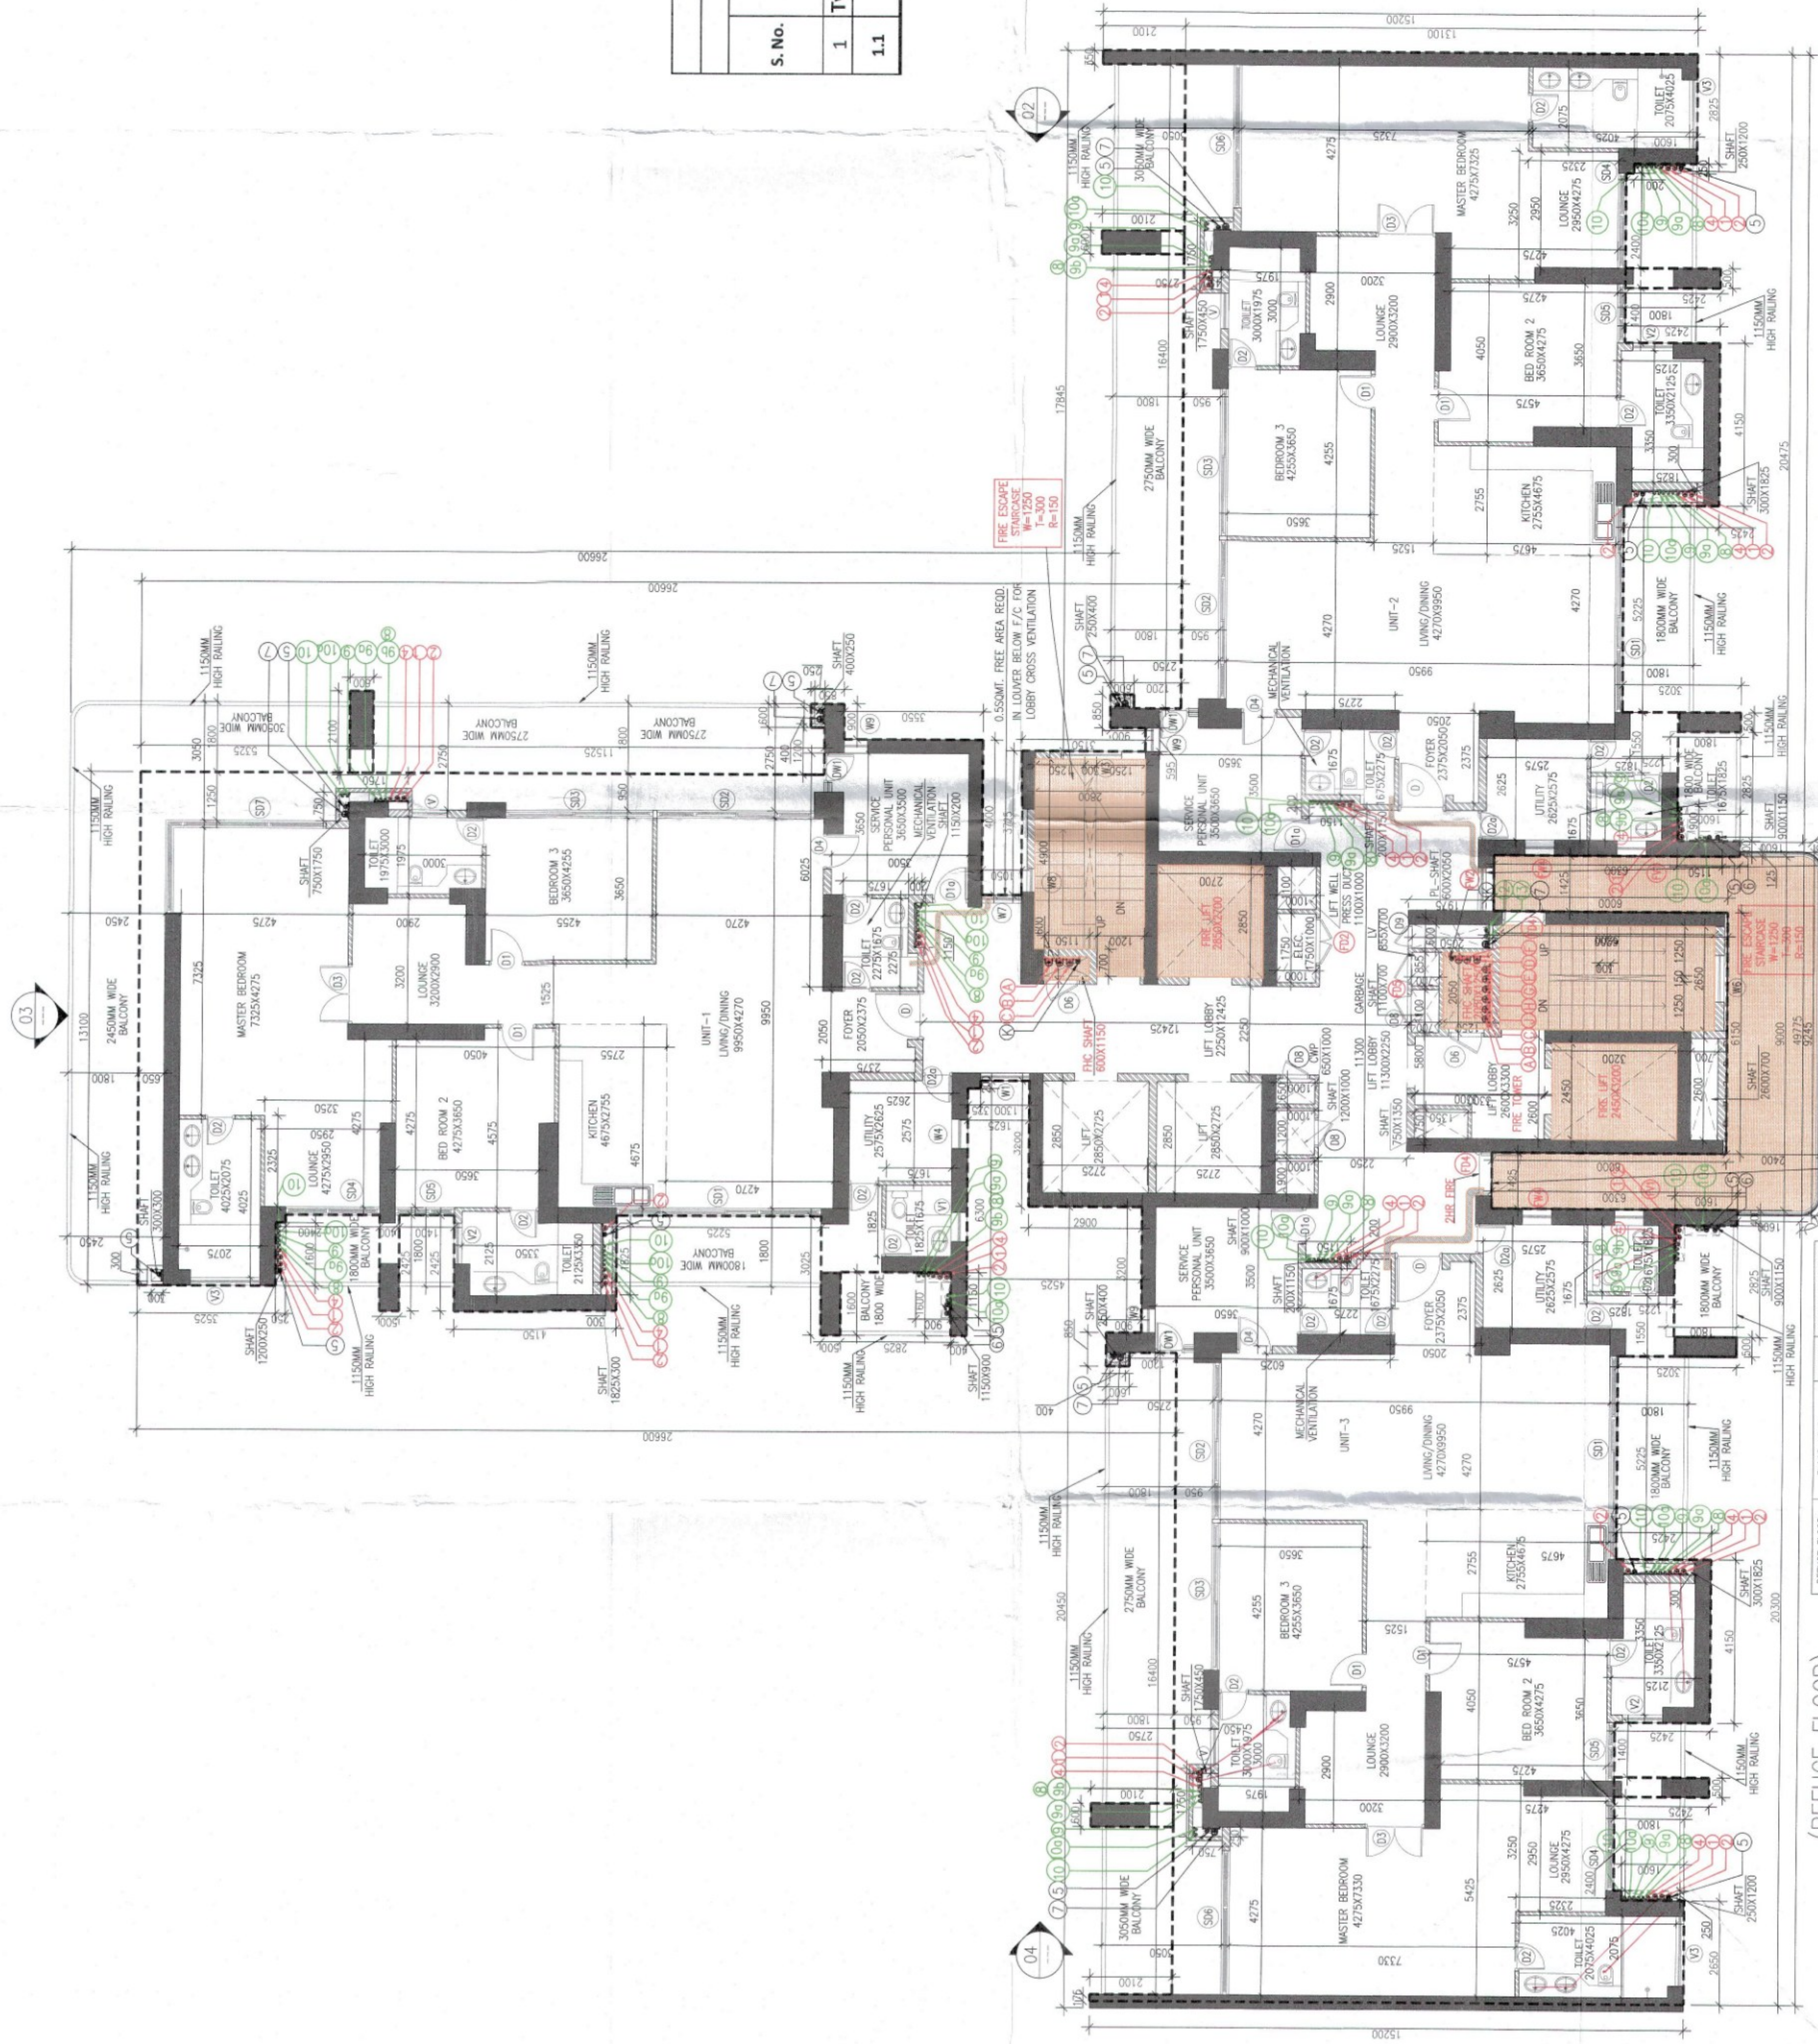

(REFUGE FLOOR)
TOWER-12
TOILET DETAIL (TYPICAL)

SCHEDULE OF DOORS & WINDOWS

TYPE	SIZE	LOCATION	DESCRIPTION	ALL LIN	LEVEL
D1	1200x2400	UNIT ENTRY	FIRE DOOR (2 HR)	100	2400
D2	900x2400	BED ROOM	MOULDED DOOR	100	2400
D3	700x2400	SERVICE PERSONAL	FIRE DOOR (1 HR)	100	2400
D4	700x2400	TOILET/STAIR	MOULDED DOOR	100	2400
D5	700x2400	BED ROOM	MOULDED DOOR	100	2400
D6	700x2400	ENTRANCE SHIRT	MOULDED DOOR	100	2400
D7	700x2400	UTILITY ROOM	FIRE DOOR (1 HR)	100	2400
D8	700x2400	DOWNWIND METAL DOOR	DOWNWIND METAL DOOR	100	2400
D9	700x2400	DOWNWIND METAL DOOR	DOWNWIND METAL DOOR	100	2400
D10	700x2400	DOWNWIND METAL DOOR	DOWNWIND METAL DOOR	100	2400
D100	700x2400	DOWNWIND METAL DOOR	DOWNWIND METAL DOOR	100	2400

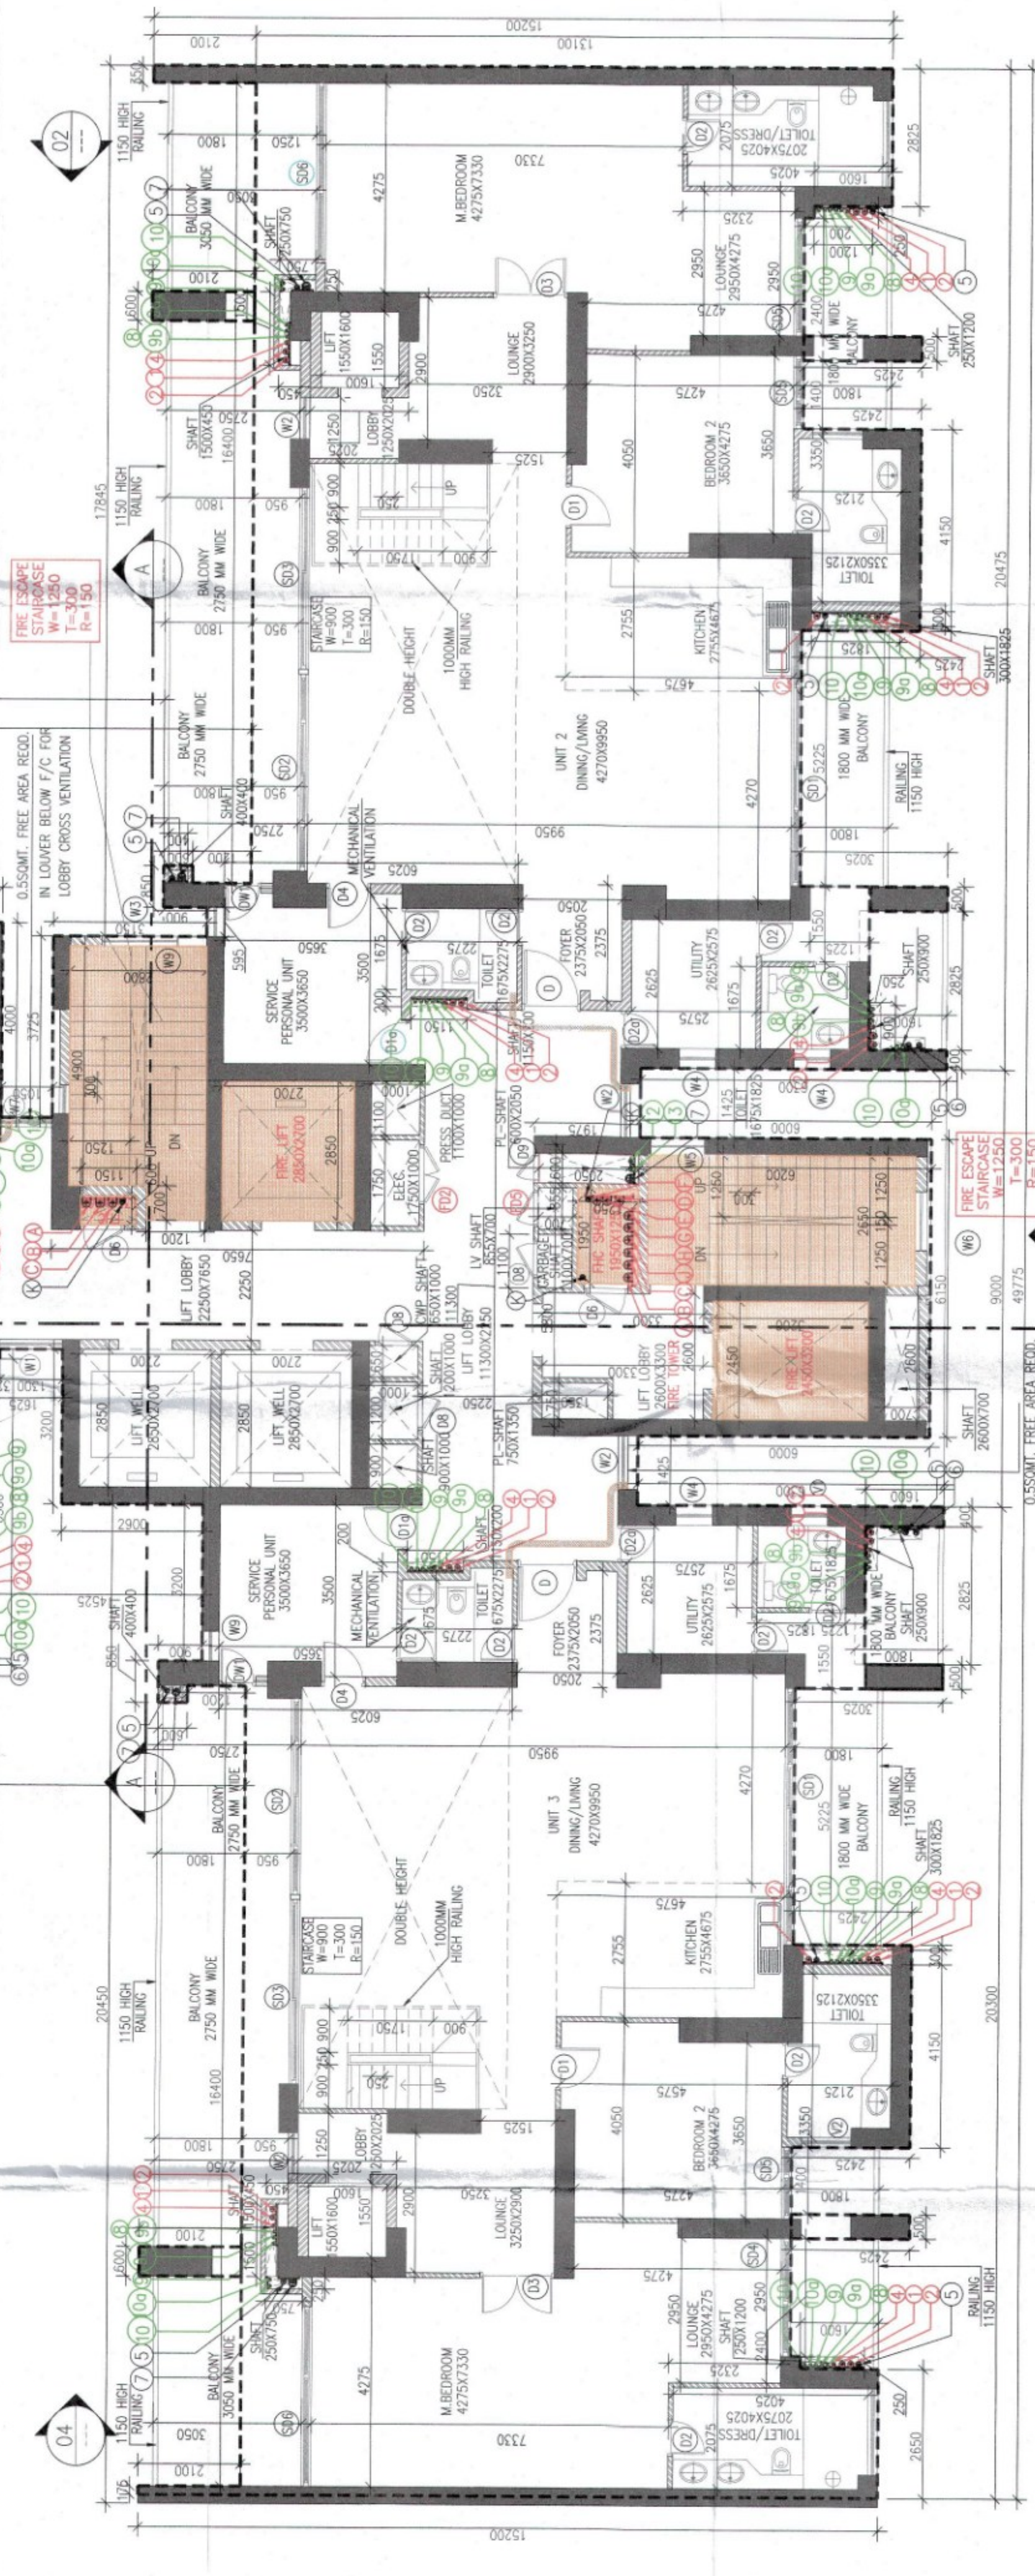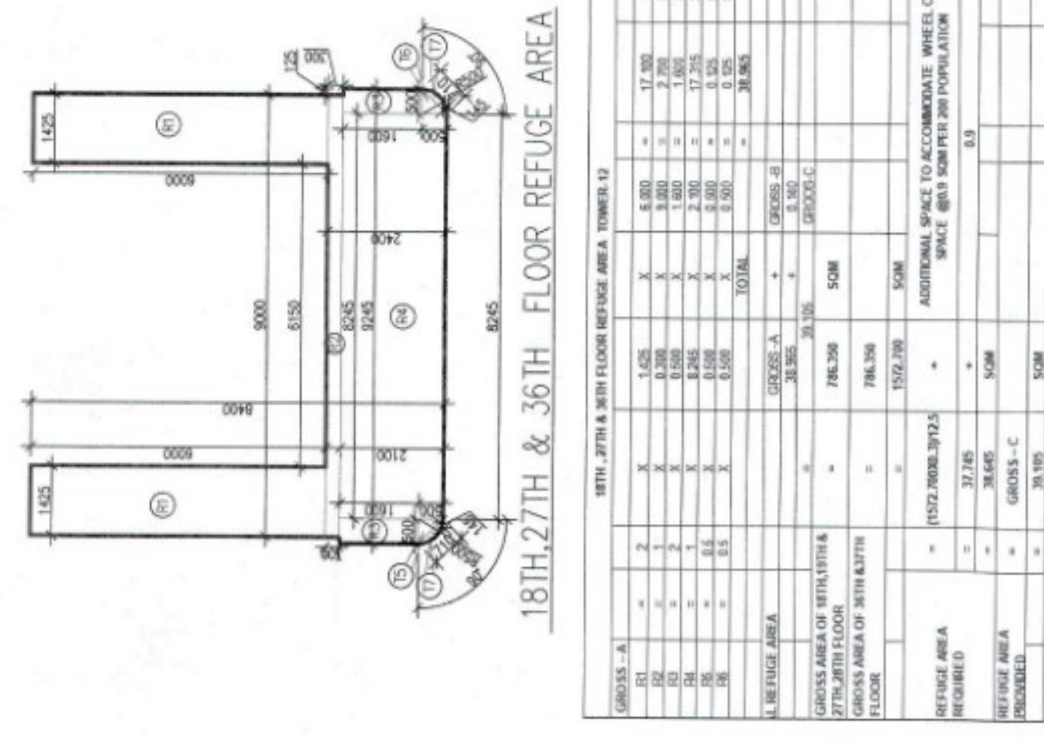

39TH LOWER PENT HOUSE FLOOR PLAN
LVL+130.95
NO. OF UNITS-3
NO. OF SERVICE PERSONAL-3
TOWER- 12

1. BUILDING HAS AUTOMATIC SPRINKLER SYSTEM WHEREVER REQUIRED BY NBC
2. BUILDING WILL BE DESIGNED (STRUCTURES) AS PER RELEVANT IS CODES FOR EARTH QUAKE RESISTANCE
3. MC SHALL BE MECHANICALLY LIGHT & VENTILATED WHEREVER REQUIRED



TO BE SIGNED BY THE OFFICE
DATE: 22.08.2021
A. S. Raghav Kumar
24423



PROJECT: ADDITIONAL & REVISED BUILDING PLANS FOR GROUP HOUSING COLONY UNDER MIX LAND USE IN TD ZONE (99% GH COMPONENT + 01% COMMERCIAL COMPONENT) WITH 350 FAR (LICENCE NO 80 OF 2012 DATED 17.08.2012) OVER AN AREA MEASURING 24.10 ACRES FALLING IN SECTOR 106, GURUGRAM BEING DEVELOPED BY ELAN AVENUE LTD AND OTHERS (EARLIER KNOWN AS AIRMD DEVELOPERS LTD.)

OWNER'S SEAL & SIGNATURE

Elan Avenue Limited
Authorised Signatory

ARCHITECT'S SEAL & SIGNATURE

A. S. Raghav Kumar
24423

Checked and found ok for Public Health
Scale: 1:100
APRIL-2024
Drawing No:-
TOWER-12
REUSE FLOOR PLAN FOR TOWER-12