

Note:-

1. BUILDING HAS AUTOMATIC SPRINKLER SYSTEM WHEREVER REQUIRED BY NBC

2. BUILDING WILL BE DESIGNED (STRUCTURES) AS PER RELEVANT IS CODES FOR EARTH QUAKE RESISTANCE.

3. WC SHALL BE MECHANICALLY LIGHT & VENTILATED WHEREVER REQUIRED



TO BE USED FOR THE PURPOSE OF INVITING OBJECTIONS FROM THE GENERAL PUBLIC

DATE: 22.04.2024

SIGNATURE: Ar. Rajender Kumar


PROJECT NO: 22/23/24/106

TO BE USED FOR THE PURPOSE OF INVITING OBJECTIONS FROM THE GENERAL PUBLIC

DATE: 22.04.2024

SIGNATURE: Ar. Rajender Kumar

PROJECT NO: 22/23/24/106

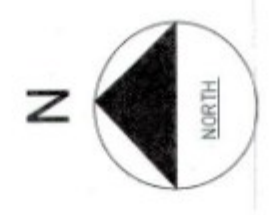

PROJECT: ADDITIONAL & REVISED BUILDING PLANS FOR GROUP HOUSING COLONY UNDER MIX LAND USE IN TDZ ZONE (99% GH COMPONENT + 01% COMMERCIAL COMPONENT) WITH 350 FAR (LICENCE NO 80 OF 2012 DATED 17.08.2012) OVER AN AREA MEASURING 24.10 ACRES FALLING IN SECTOR 106, GURUGRAM BEING DEVELOPED BY ELAN AVENUE LTD AND OTHER'S (EARLIER KNOWN AS AIRMID DEVELOPERS LTD.)

OWNER'S SEAL & SIGNATURE

Elan Avenue Limited

Authorized Signatory

ARCHITECT'S SEAL & SIGNATURE

Ar. Rajender Kumar
CNCAS 1256971

Sealed & signed off for Public Health (Minimum) Service only subject to comments in the drawing.

Scale : 1:100

Drawing No:- TOWER-12

DATE: 22.04.2024

APRIL-2024.

Scale : 1:100

Drawing No:- TOWER-12

DATE: 22.04.2024


PROJECT NO: 22/23/24/106

PLUMBING LEGEND:-


1	1000/7150 SBL PIPE
2	1000/7150 WASTE PIPE
3	1000/7150 WASTE PIPE FOR UTILITY BALCONY
4	1000/7150 WASTE PIPE FOR WATER PIPE
5	750 VENT PIPE
6	1000/7150 RAIN WATER PIPE FOR TERRACE
7	1500/900 RAIN WATER PIPE FOR TERRACE
8	DOMESTIC WATER SUPPLY (BOOSTED) (TOP SIX FLOORS)
9	DOMESTIC WATER SUPPLY (BY GRAVITY) (TO GROUND FLOOR)
10	DOMESTIC WATER SUPPLY (BY GRAVITY) (TO 4TH FLOOR)
11	DOMESTIC WATER SUPPLY (BY GRAVITY) (TO 4TH FLOOR)
12	DOMESTIC WATER SUPPLY (BY GRAVITY) (TO 4TH FLOOR)

PLUMBING LEGEND:-

1	DOMESTIC WATER SUPPLY
2	MULTI FLOOR TRAP
3	WATER SUPPLY
4	WATER SUPPLY
5	WATER SUPPLY
100	WATER SUPPLY

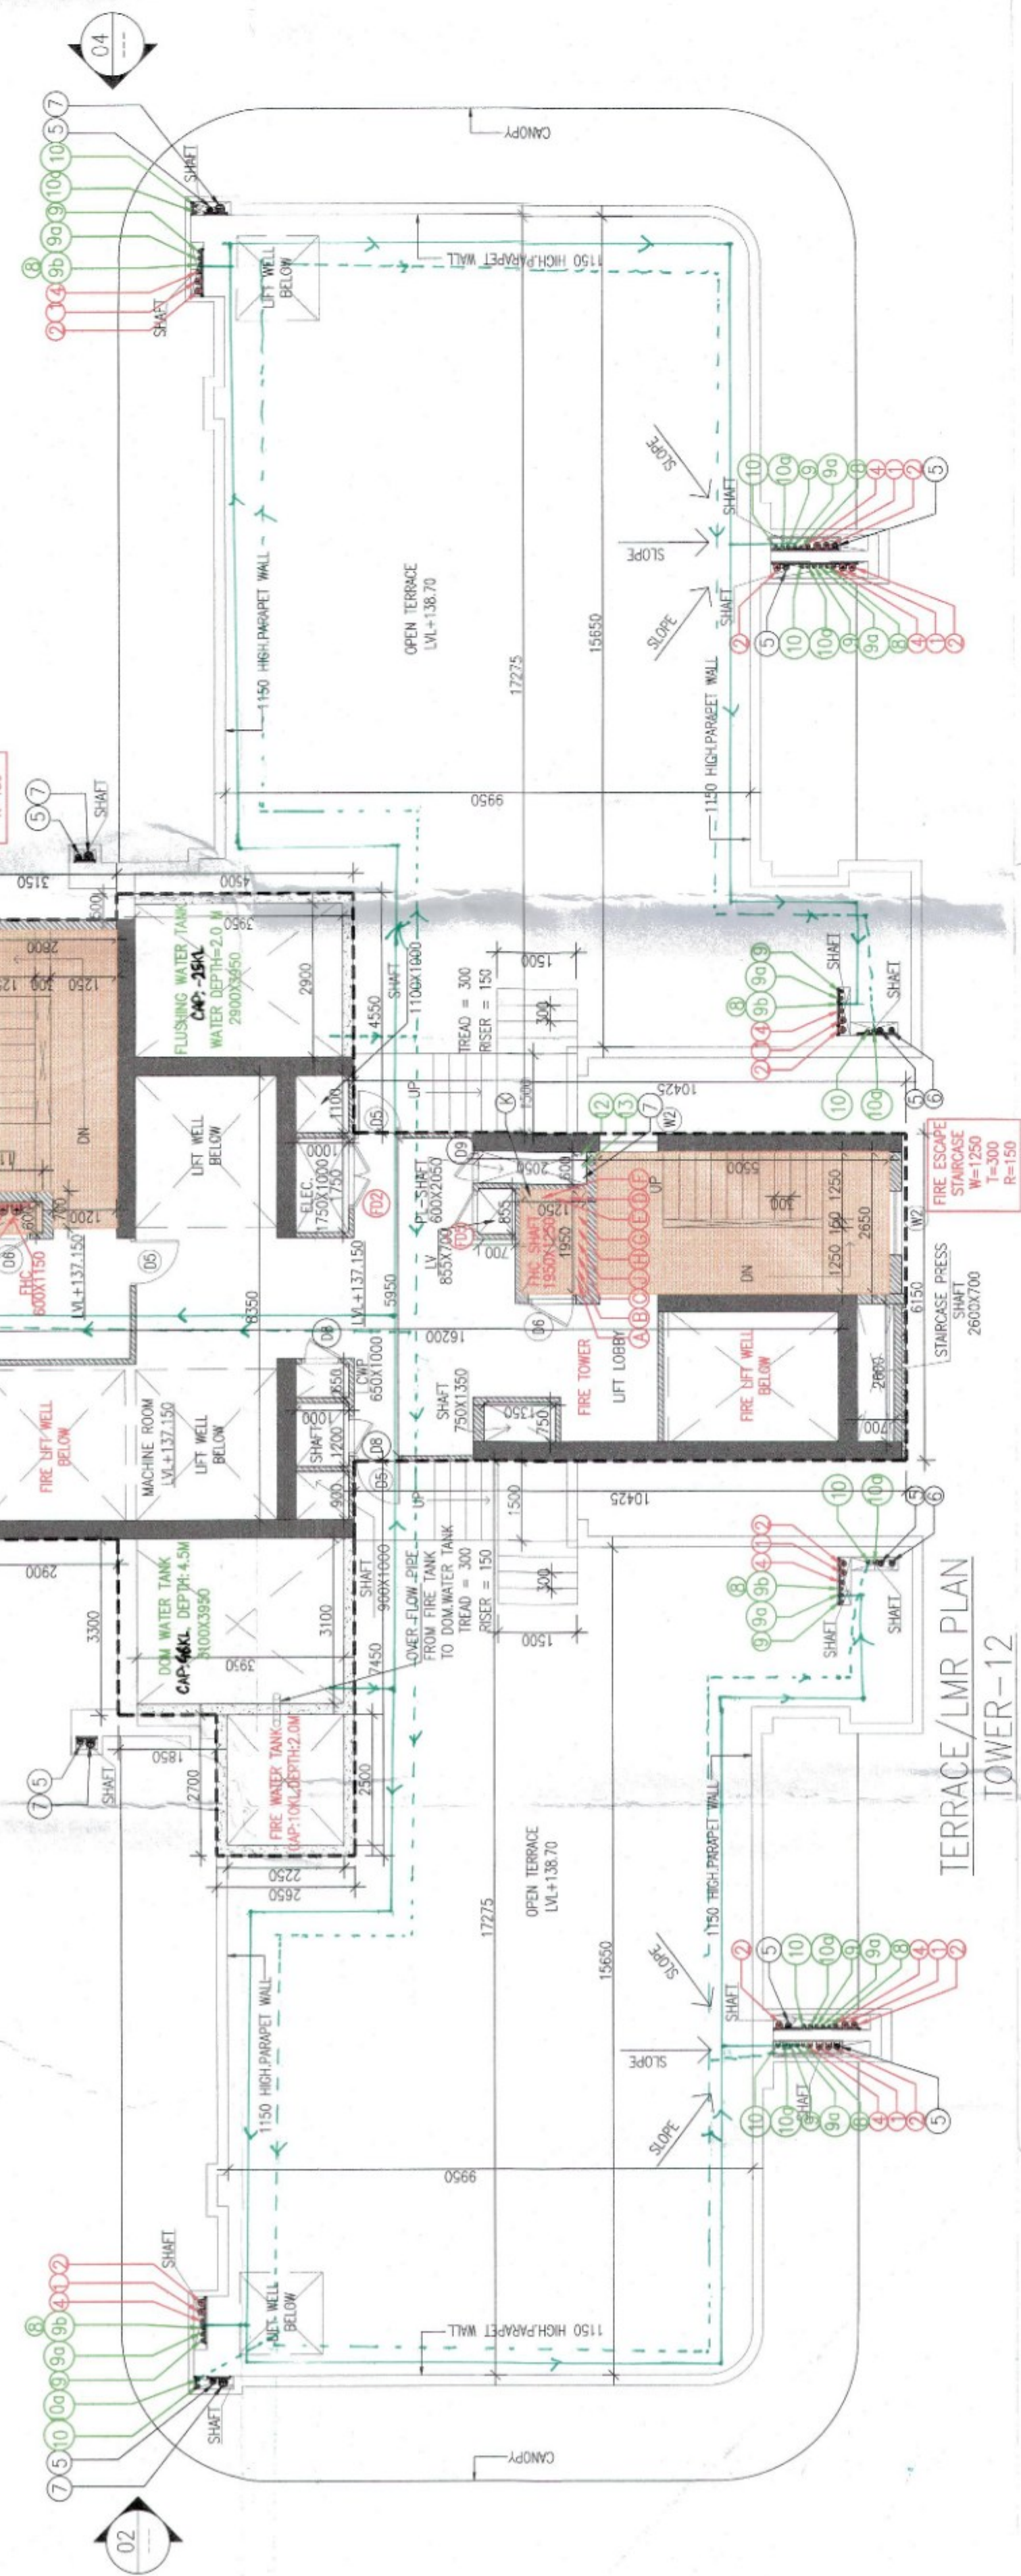

0.1

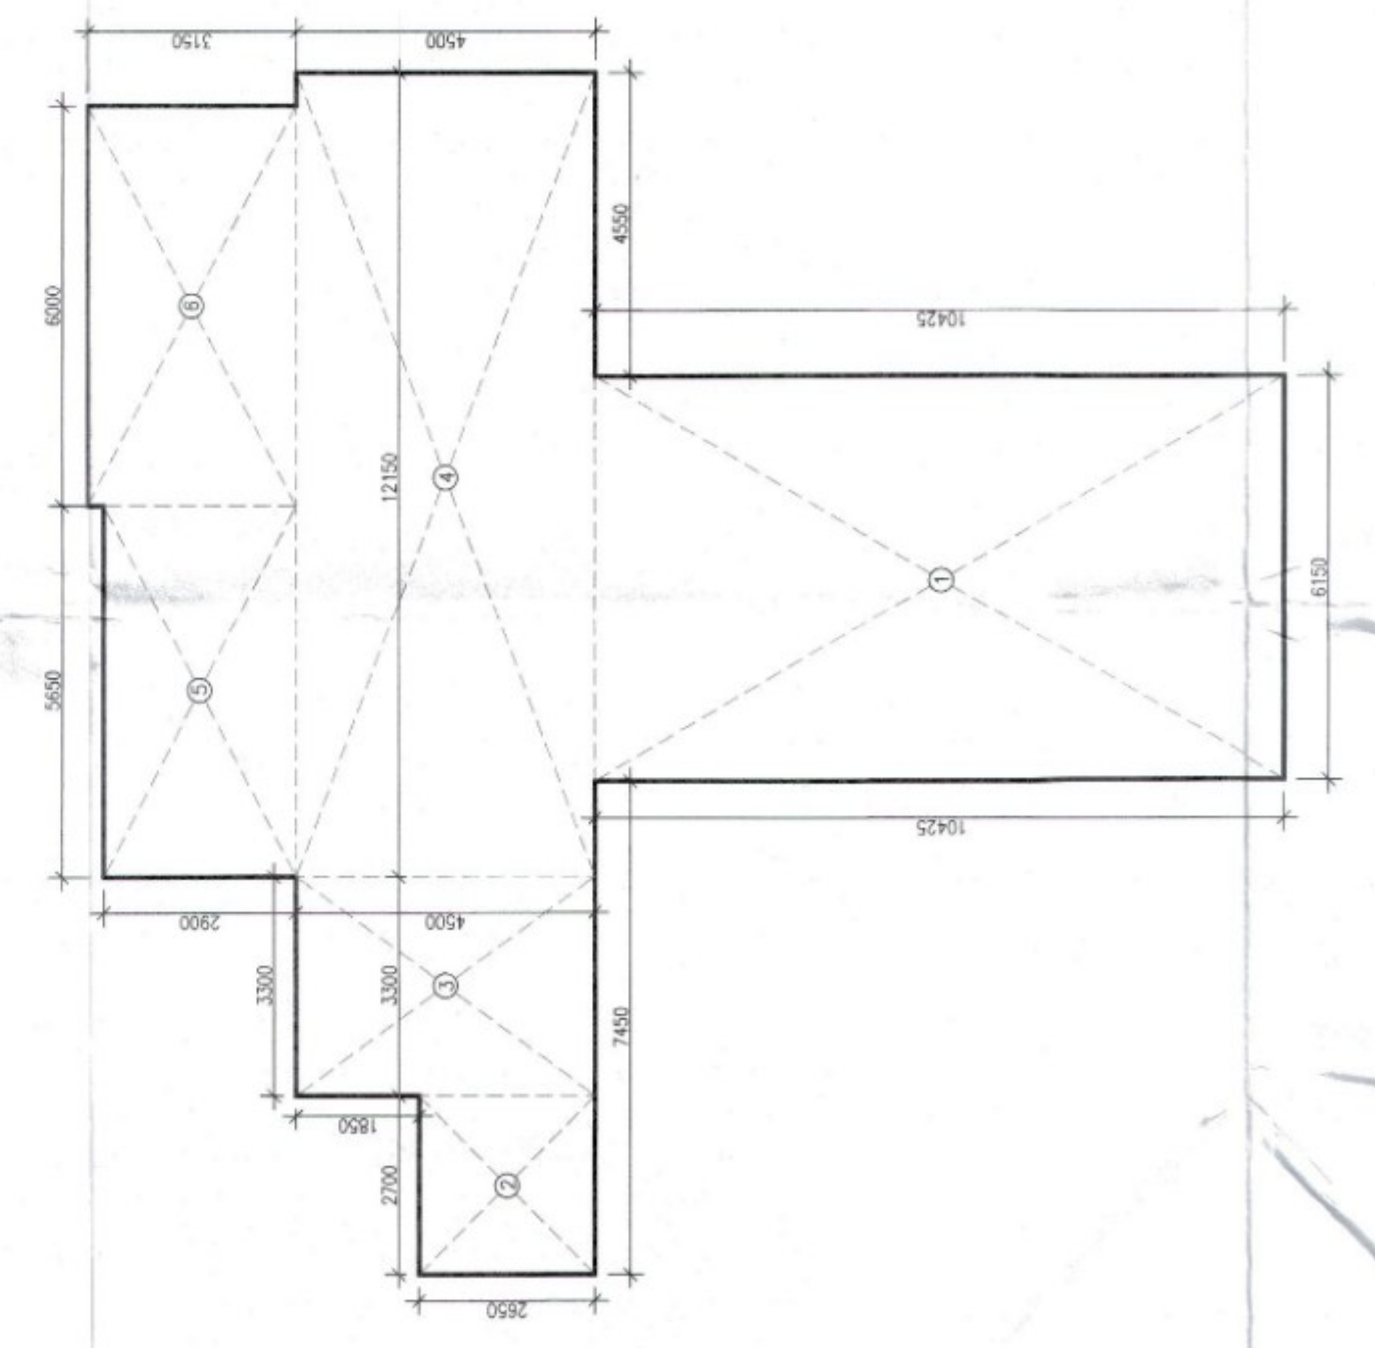

MUMMY & MACHINE ROOM AREA DIAGRAM TOWER-12

MUMMY & MACHINE ROOM AREA DIAGRAM TOWER-12

ROOMS	AREA	PERIMETER	VOLUME	AREA	PERIMETER	VOLUME
1	10.00	10.00	10.00	10.00	10.00	10.00
2	10.00	10.00	10.00	10.00	10.00	10.00
3	10.00	10.00	10.00	10.00	10.00	10.00
100	10.00	10.00	10.00	10.00	10.00	10.00