

Note :-

1. BUILDING HAS AUTOMATIC SPRINKLER SYSTEM WHEREVER REQUIRED BY NBC
2. BUILDING WILL BE DESIGNED (STRUCTURES) AS PER RELEVANT IS CODES FOR EARTH QUAKE RESISTANCE.
3. WC SHALL BE MECHANICALLY LIGHT & VENTILATED WHEREVER REQUIRED



TO BE READ WITH THIS OFFICE MEMO NO. JG(HQ) DATED :

TO BE READ WITH THIS OFFICE MEMO NO. JG(HQ) DATED :



PROJECT: ADDITIONAL & REVISED BUILDING PLANS FOR GROUP HOUSING COLONY UNDER MIX LAND USE IN TOD ZONE (98% GH COMPONENT + 01% COMMERCIAL COMPONENT) WITH 350 FAR (LICENCE NO 80 OF 2012 DATED 17.08.2012) OVER AN AREA MEASURING 24.10 ACRES FALLING IN SECTOR 106, GURUGRAM BEING DEVELOPED BY ELAN AVENUE LTD AND OTHERS (EARLIER KNOWN AS ARMD DEVELOPERS LTD.)

OWNER'S SEAL & SIGNATURE

Elan Avenue Limited
Authorized Signatory

ARCHITECT'S SEAL & SIGNATURE



Ar. Rajender Kumar
CA/20155571

JUNE-2024, 11/06/2024

Drawing Title: TOWER-17
Drawing No: 17/06/2024

PLUMBING LEGEND:-	
1	100W/100W SOIL PIPE
2A	100W/100W SOIL PIPE
3	100W/100W KITCHEN WASTE PIPE
4	75W WOT PIPE
5	100W/100W RAIN WATER PIPE FOR BALCONY
6	100W/100W RAIN WATER PIPE FOR TERRACE
7	100W/100W RAIN WATER PIPE FOR TERRACE
8	DOMESTIC WATER SUPPLY (GRANITE) (TOP SIX FLOORS)
9	DOMESTIC WATER SUPPLY (GRANITE) (TOP SIX FLOORS)
10	FLUSHING WATER SUPPLY (BY GRAVITY) (TIE TO GROUND FLOOR)
11	DOMESTIC WATER SUPPLY (BY GRAVITY) (TIE TO GROUND FLOOR)
12	FLUSHING WATER SUPPLY (BY GRAVITY) (TIE TO GROUND FLOOR)

PLUMBING LEGEND:-	
1	100W/100W SOIL PIPE
2A	100W/100W SOIL PIPE
3	100W/100W KITCHEN WASTE PIPE
4	75W WOT PIPE
5	100W/100W RAIN WATER PIPE FOR BALCONY
6	100W/100W RAIN WATER PIPE FOR TERRACE
7	100W/100W RAIN WATER PIPE FOR TERRACE
8	DOMESTIC WATER SUPPLY (GRANITE) (TOP SIX FLOORS)
9	DOMESTIC WATER SUPPLY (GRANITE) (TOP SIX FLOORS)
10	FLUSHING WATER SUPPLY (BY GRAVITY) (TIE TO GROUND FLOOR)
11	DOMESTIC WATER SUPPLY (BY GRAVITY) (TIE TO GROUND FLOOR)
12	FLUSHING WATER SUPPLY (BY GRAVITY) (TIE TO GROUND FLOOR)

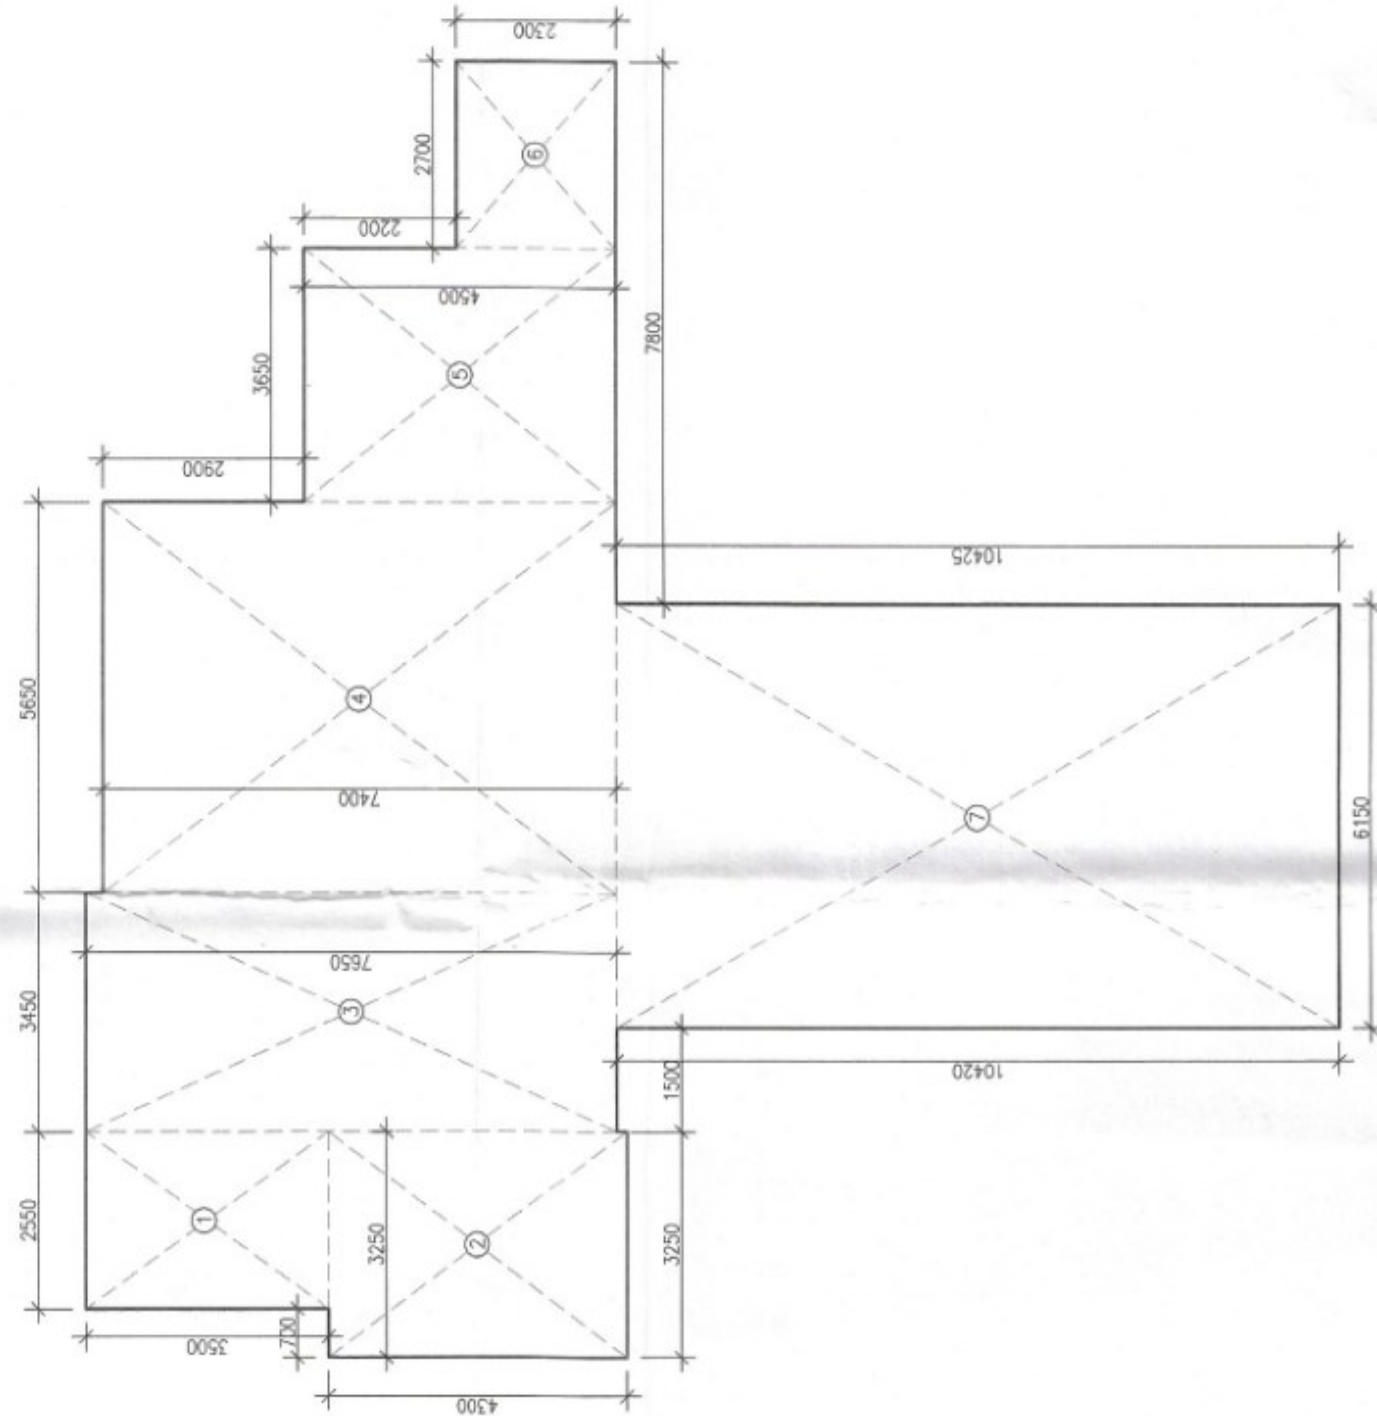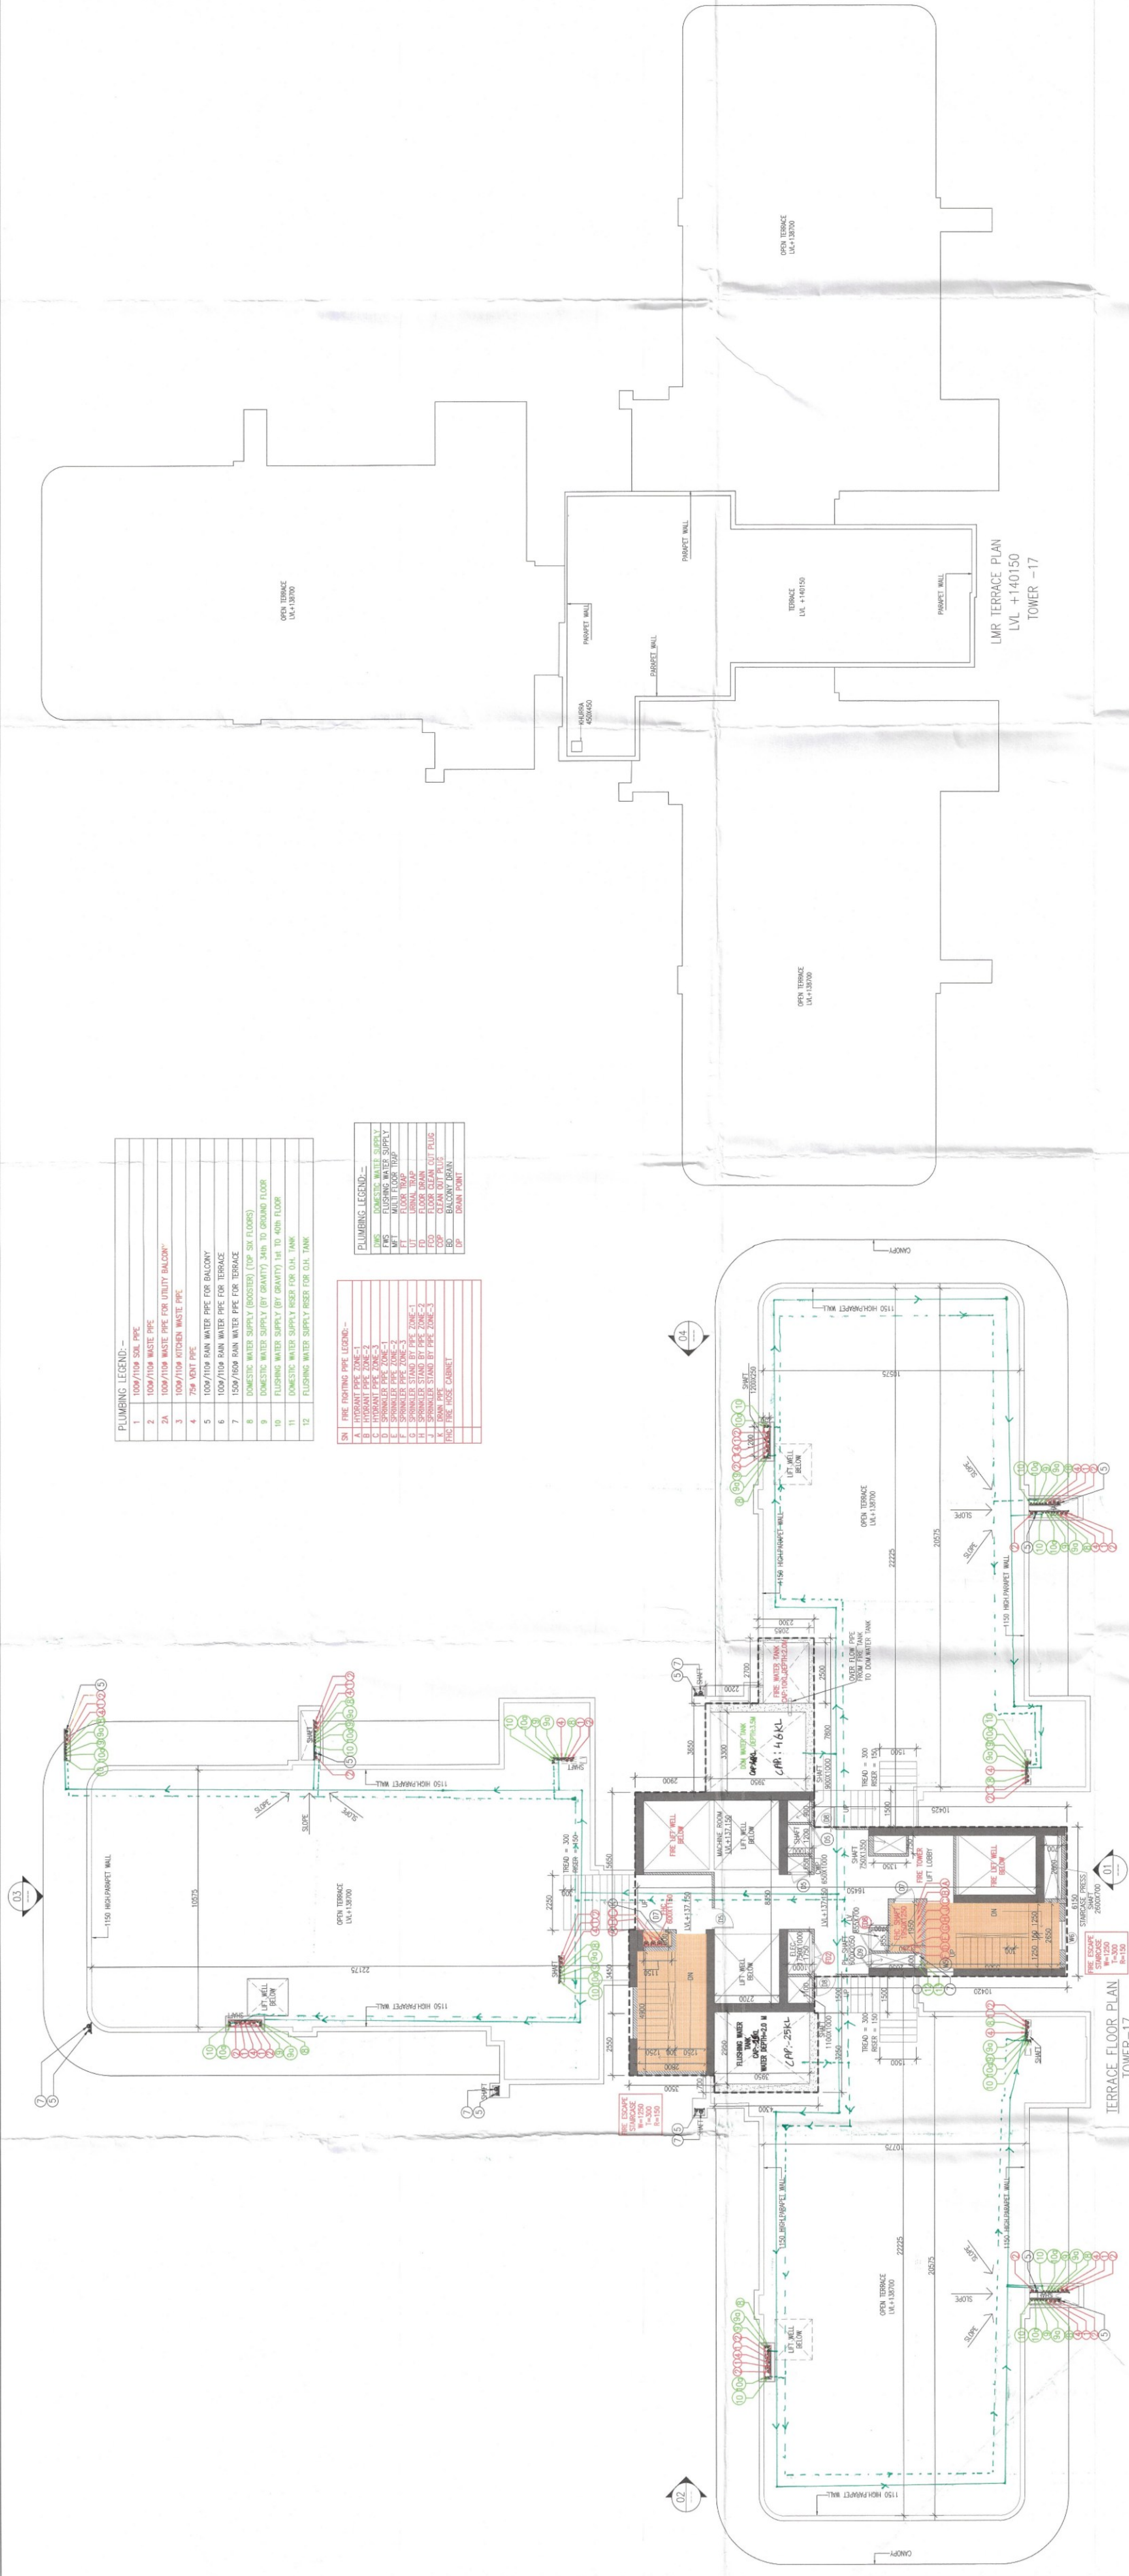

MUMMY & MACHINE ROOM AREA TOWER-17

MUMMY & MACHINE ROOM AREA TOWER-17	
1	100W/100W SOIL PIPE
2A	100W/100W SOIL PIPE
3	100W/100W KITCHEN WASTE PIPE
4	75W WOT PIPE
5	100W/100W RAIN WATER PIPE FOR BALCONY
6	100W/100W RAIN WATER PIPE FOR TERRACE
7	100W/100W RAIN WATER PIPE FOR TERRACE
8	DOMESTIC WATER SUPPLY (GRANITE) (TOP SIX FLOORS)
9	DOMESTIC WATER SUPPLY (GRANITE) (TOP SIX FLOORS)
10	FLUSHING WATER SUPPLY (BY GRAVITY) (TIE TO GROUND FLOOR)
11	DOMESTIC WATER SUPPLY (BY GRAVITY) (TIE TO GROUND FLOOR)
12	FLUSHING WATER SUPPLY (BY GRAVITY) (TIE TO GROUND FLOOR)