


Phase - 3

Phase - 2

Phase - 1

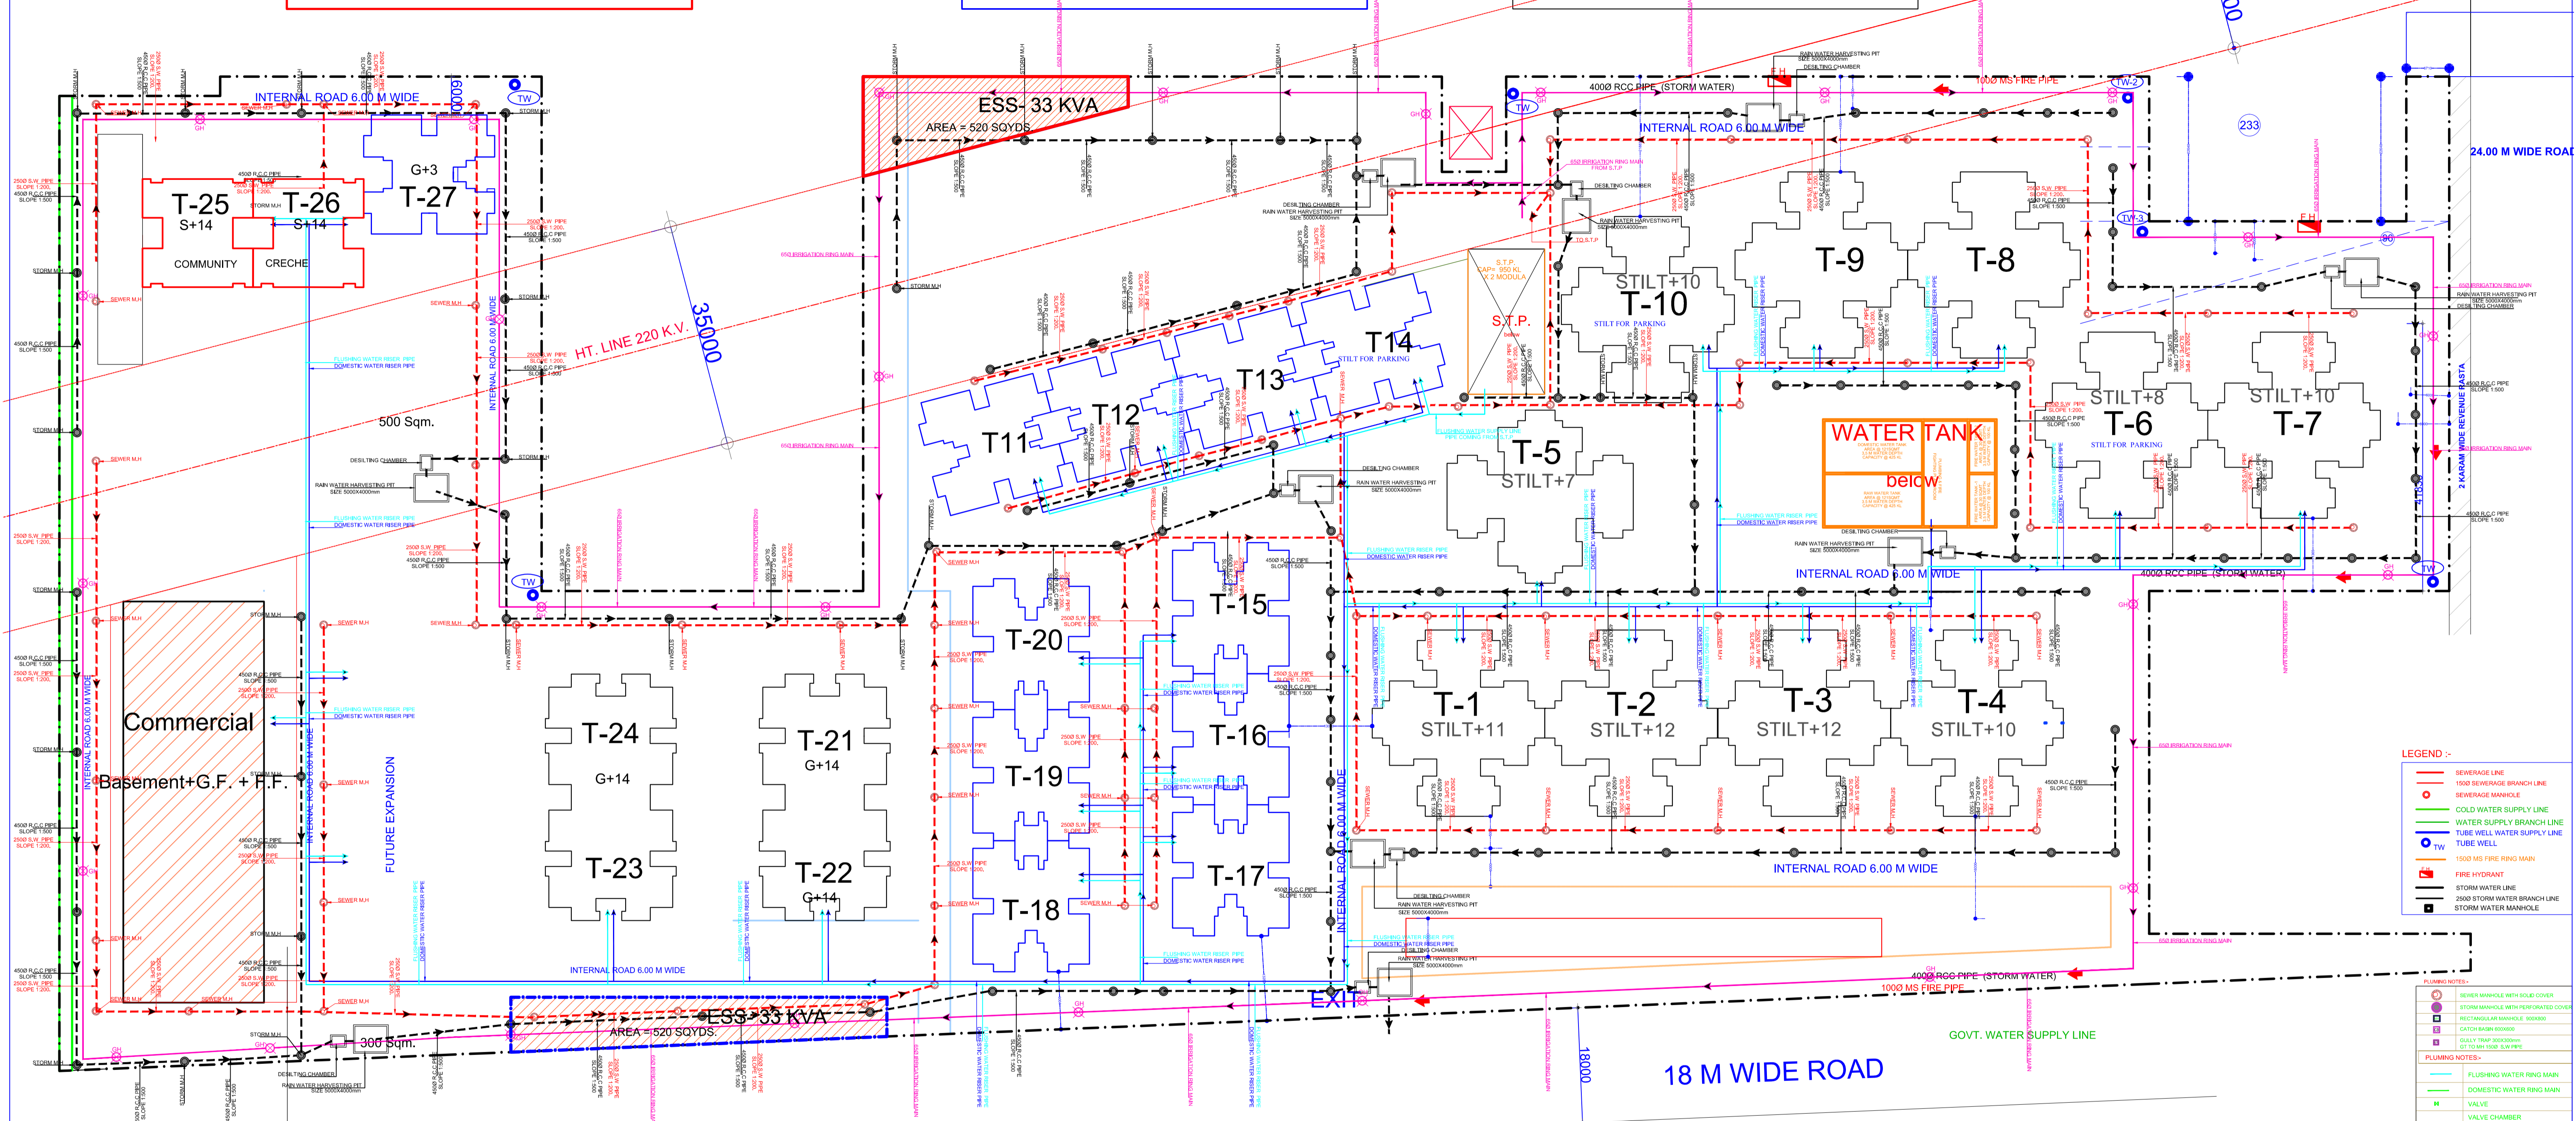

- LEGEND :-**
- SEWERAGE LINE
  - 1500 SEWERAGE BRANCH LINE
  - SEWERAGE MANHOLE
  - COLD WATER SUPPLY LINE
  - TUBE WELL WATER SUPPLY LINE
  - TW
  - 1000 MS FIRE RING MAIN
  - FIRE HYDRANT
  - STORM WATER LINE
  - 2500 STORM WATER BRANCH LINE
  - STORM WATER MANHOLE

- PLUMBING NOTES:-**
- SEWER MANHOLE WITH SOLID COVER
  - STORM MANHOLE WITH PERFORATED COVER
  - RECTANGULAR MANHOLE - 900X600
  - CATCH BASIN 600X600
  - SUMP TANK 900X600X900
  - 1000 MS FIRE RING MAIN
  - 1000 MS FIRE PIPE
- PLUMBING NOTES:-**
- FLUSHING WATER RING MAIN
  - DOMESTIC WATER RING MAIN
  - VALVE
  - VALVE CHAMBER
  - GARDEN HYDRANT

# SITE PLAN

Title	SERVICES PLAN	Drawing No.	sls/01/86/2017	Scale	1:100	Date	APRIL 19
Signature							
Project	ARCHITECT AUTH. SIGNATORY/OWNER						
Promoters	<p><b>Happy Homes,</b> GROUP-HOUSING, SECTOR - 86, FARIDABAD, HARYANA.</p> <p>M/s. ADORE REALTECH PVT. LTD. 1F- 24-26, OZONE CENTER, SEC-12, FBD.</p>						
Planners	<p><b>PLANNERS CLUB</b> 131, Sai Park, Sector-87, Faridabad, Ph. 8800092099, narenbhadana@gmail.com</p> <p>Master planning Environmental Architectural Valuation Project management</p>						

ADDITIONAL/ REVISED BUILDING PLAN OF AFFORDABLE GROUP- HOUSING SCHEME MEASURING 2.653125 Acres (License no. 46 of 2018) IN ALREADY LICENSED GRANTED AGH MEASURING 9.125 Acres, (License no. 108 of 2014 & 29 of 2016). TOTAL AREA 11.778125 Acs. IN SECTOR-86,FBD. BEING DEVELOPED BY M/s. ADORE REALTECH PVT.LTD. & OTHERS