




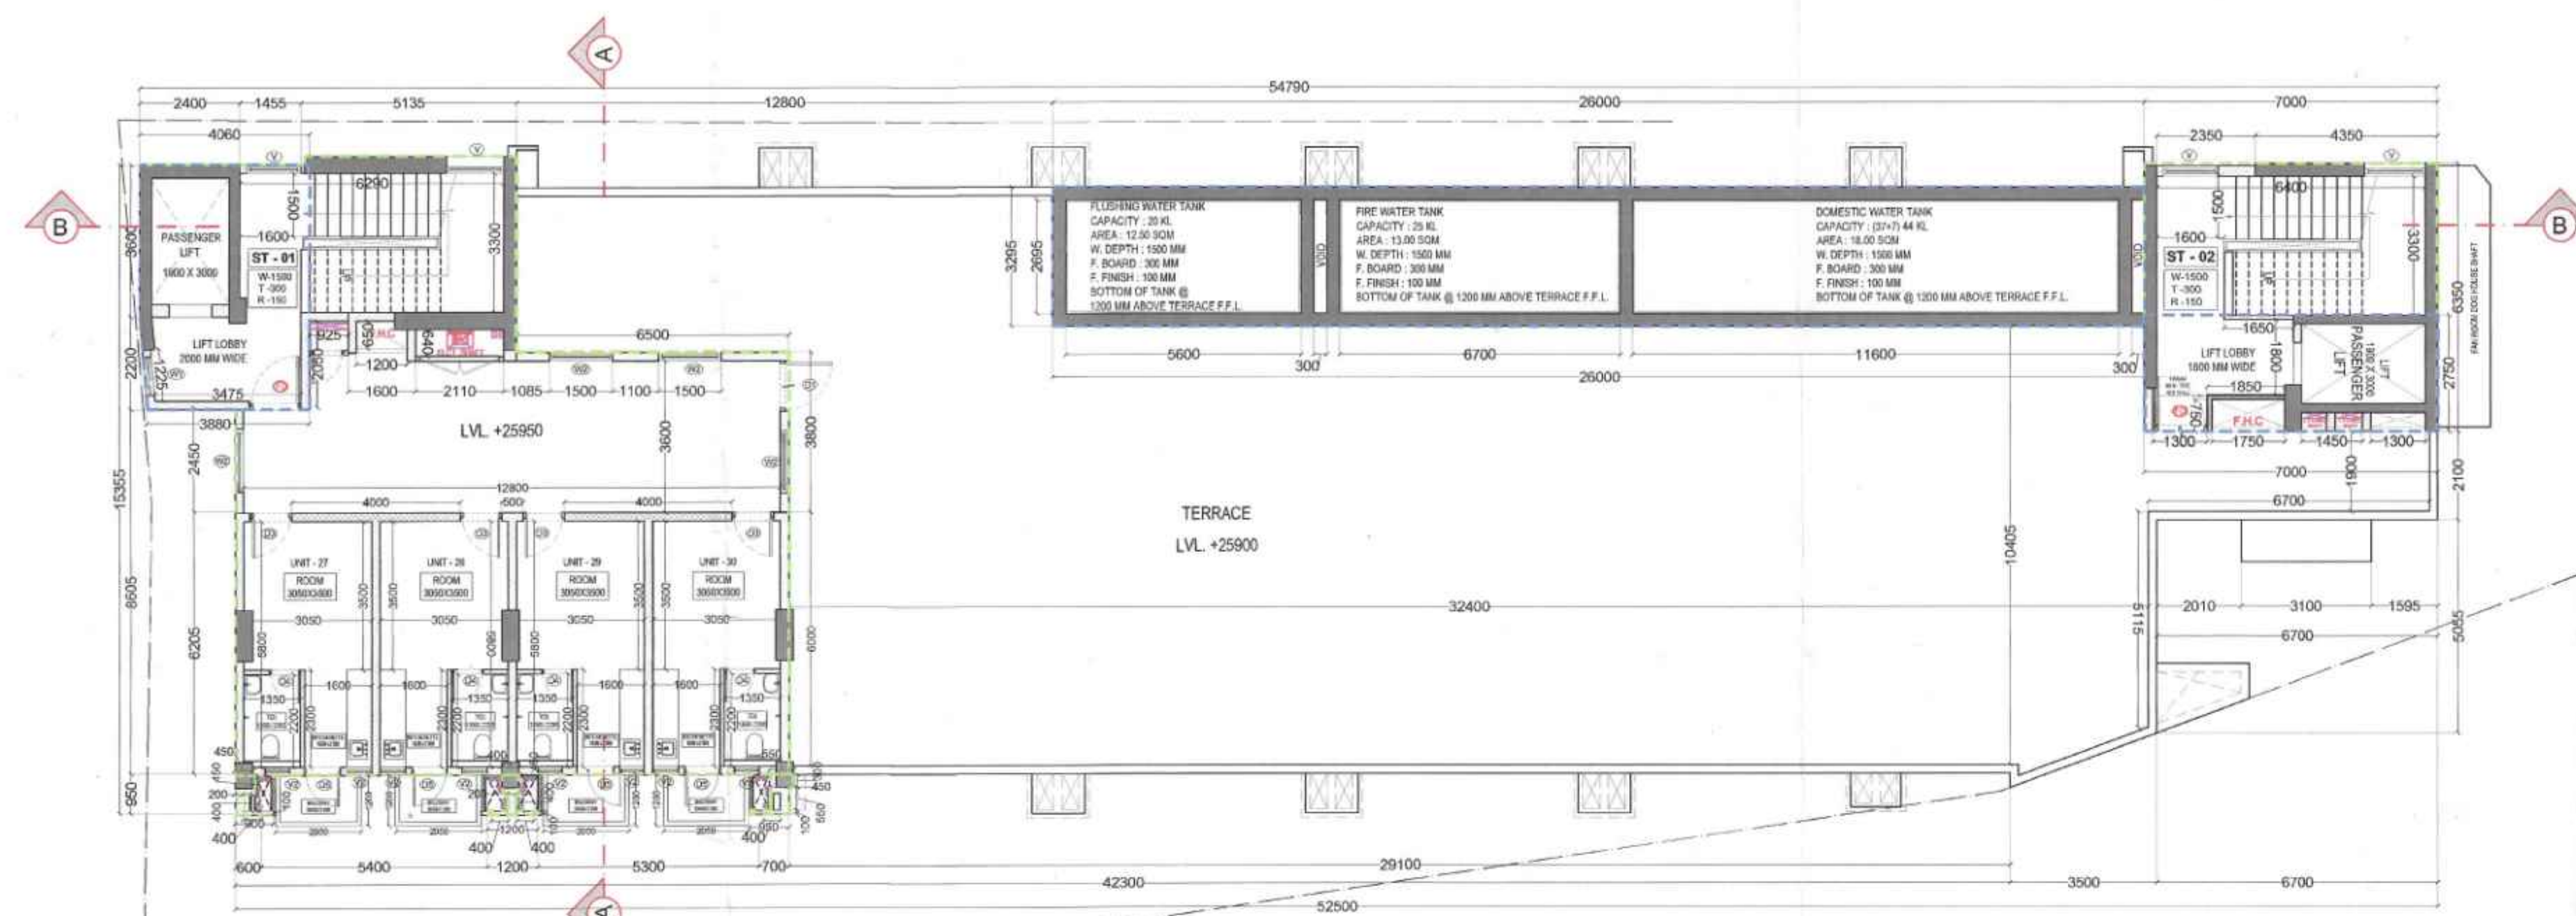



TERRACE PLAN

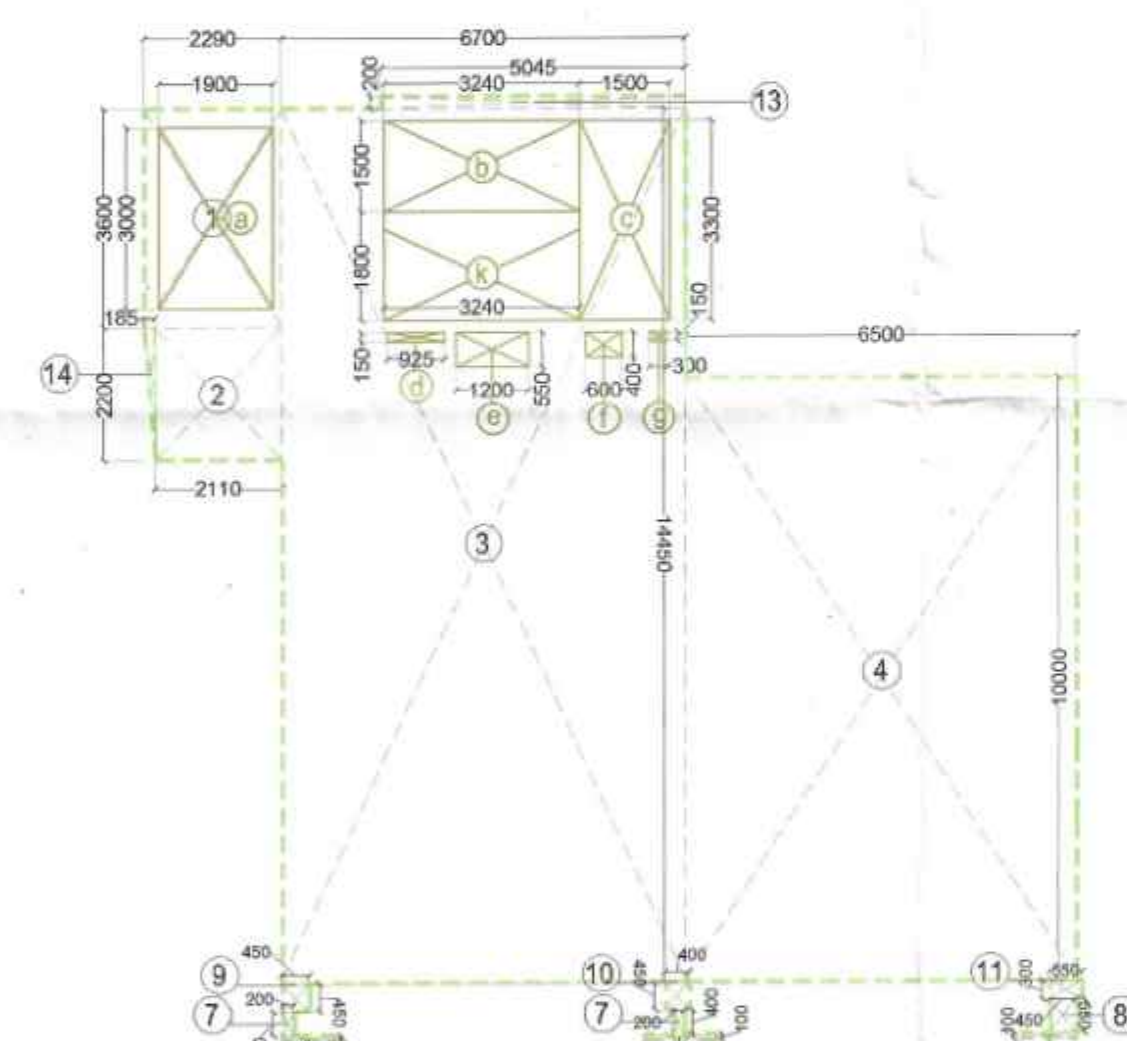

FAR AREA OF TERRACE

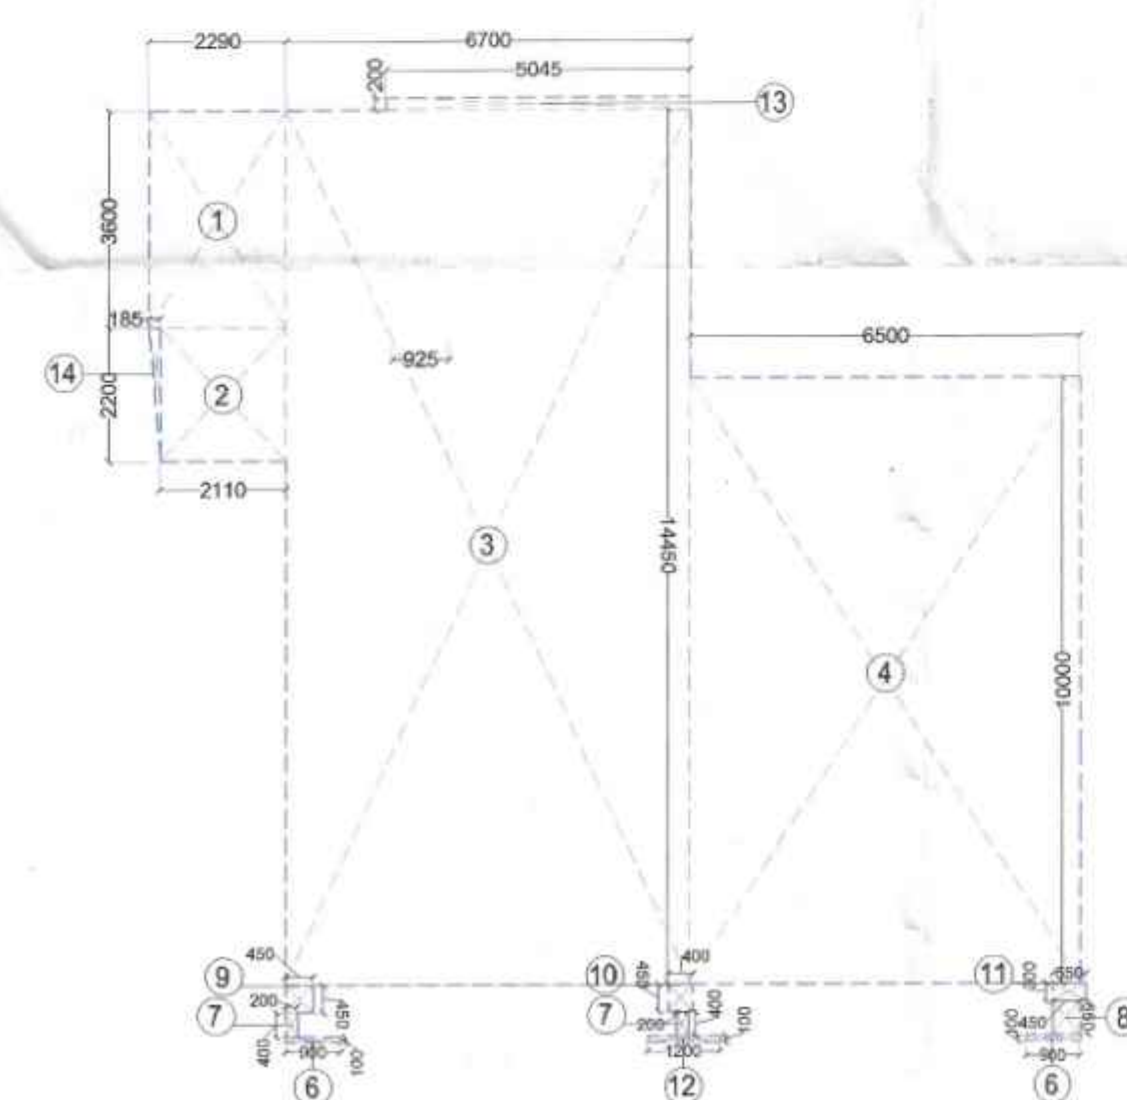

TERRACE - BUILT - UP

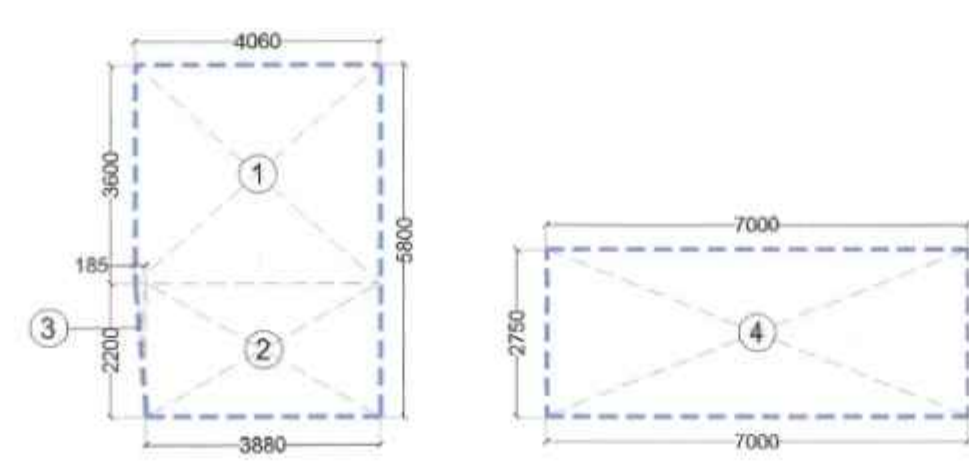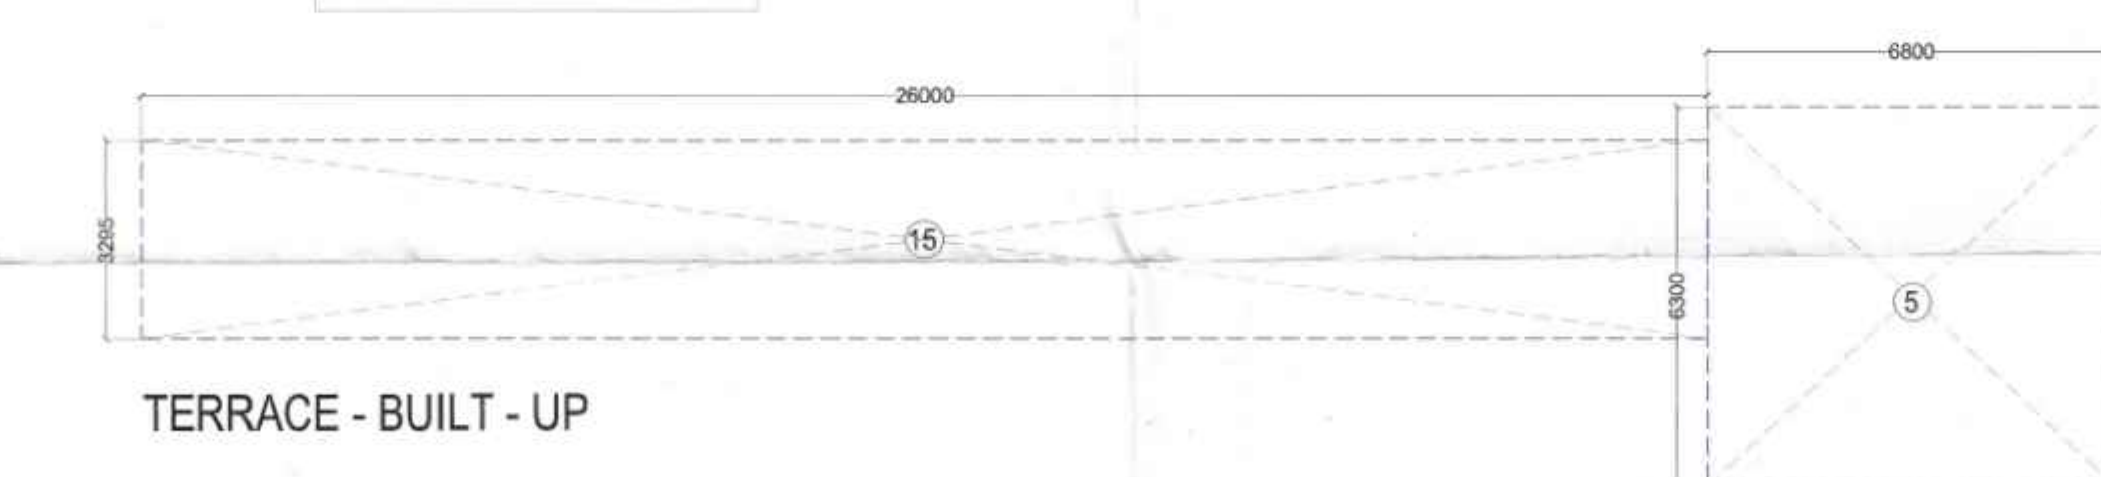

MACHINE ROOM - BUILT - UP

PLUMBING NOTES:

1. WASH BASIN TO FLOOR TRAP (FT) AS UPVC PIPE
2. PWC FLEXIBLE WASTE PIPE
3. FLOOR DRAIN (FD) TO FLOOR TRAP (FT) AS UPVC PIPE
4. 110 OD UPVC PIPE USED FOR SOIL & WASTE
5. 110 OD UPVC PIPE USED FOR TERRACE RAIN WATER
6. 110 OD UPVC PIPE USED FOR BALCONY

PLUMBING LEGEND:

LEGEND DESCRIPTION

1. 110 OD P.P. SOIL PIPE & VENT PIPE
2. 110 OD P.P. WASTE PIPE ADJUTANT
3. 110 OD P.P. WASTE PIPE FOR KITCHEN & UTILITY BALCONY
4. 110 OD UPVC ANTI-SIPHONAGE PIPE
5. 110 OD UPVC TERRACE RAIN WATER PIPE
6. 110 OD UPVC BALCONY RAIN WATER PIPE
7. DOMESTIC WATER SUPPLY SUN TRAP PIPE
8. FLUSHING WATER SUPPLY SUN TRAP PIPE
9. DOMESTIC WATER SUPPLY RISER
10. FLUSHING WATER SUPPLY RISER
11. DOMESTIC WATER SUPPLY SUN TRAP PIPE
12. FLOOR DRAIN (FD) TO FLOOR TRAP (FT) AS UPVC PIPE
13. 110 OD UPVC PIPE USED FOR TERRACE RAIN WATER
14. 110 OD UPVC PIPE USED FOR BALCONY
15. 110 OD UPVC PIPE USED FOR TERRACE RAIN WATER
16. 110 OD UPVC PIPE USED FOR BALCONY
17. 110 OD UPVC PIPE USED FOR TERRACE RAIN WATER
18. 110 OD UPVC PIPE USED FOR BALCONY
19. 110 OD UPVC PIPE USED FOR TERRACE RAIN WATER
20. 110 OD UPVC PIPE USED FOR BALCONY

MACHINE ROOM BUILT-UP

S.No	TYPE	WIDTH	HEIGHT	SILL HT	LOCATION
1	W	2050	2400	1100	SCHOOL SPACES
2	W1	900	2400	1100	EWS LOBBY
3	W2	1500	2400	1100	EWS LOBBY AND CORRIDOR
4	V	1300	BOB	1350	STAIRCASE LOUVERED WINDOW
5	V2	600	BOB	1350	SCHOOL TOI/TYPICAL FLOOR TOI/KITCHEN

DOOR WINDOW SCHEDULE (EWS)

S.NO	DOOR TAG'S	WIDTH	INTEL	SILL HT	FIRE RT	LOCATION
1.	D1	1200	2400	-	-	SCHOOL SPACES
2.	D2	1250	2400	-	2HR	SCHOOL ENTRANCE
3.	D3	1000	2400	-	-	SCHOOL TOILET
4.	D4	750	2400	-	-	EWS LOBBY
5.	D5	850	2400	-	-	EWS BALCONY
6.	D6	1200	2400	-	2HR	SCHOOL HANDICAP TOI
7.	FD	1300	2400	-	2HR	EWS LOBBY
8.	DW	3050	2400	-	-	EWS LOBBY ENTRANCE
9.	DW1	2150	2400	-	-	SCHOOL MAIN ENTRY
10.	DW2	2400	2400	-	-	EWS LOBBY EXIT

FAR AREA OF TERRACE (EWS)

S.No	TYPE	WIDTH	HEIGHT	SILL HT	LOCATION
1.	W	2050	2400	1100	SCHOOL SPACES
2.	W1	900	2400	1100	EWS LOBBY
3.	W2	1500	2400	1100	EWS LOBBY AND CORRIDOR
4.	V	1300	BOB	1350	STAIRCASE LOUVERED WINDOW
5.	V2	600	BOB	1350	SCHOOL TOI/TYPICAL FLOOR TOI/KITCHEN

BUILT-UP AREA OF TERRACE FLOOR

S.No	TYPE	WIDTH	HEIGHT	SILL HT	LOCATION
1.	W	2050	2400	1100	SCHOOL SPACES
2.	W1	900	2400	1100	EWS LOBBY
3.	W2	1500	2400	1100	EWS LOBBY AND CORRIDOR
4.	V	1300	BOB	1350	STAIRCASE LOUVERED WINDOW
5.	V2	600	BOB	1350	SCHOOL TOI/TYPICAL FLOOR TOI/KITCHEN

NOTE :-
This is a "PROVISIONAL BUILDING PLAN" approved only for the purpose of inviting Objections from the general public.

KEY PLAN

PROJECT :-
Revised Building Plans for TOD Group Housing Colony Measuring 10.744 acres Land (Licence no. 4 of 2013 dated 18-02-2013 in Sector 112, Gurgaon, Manesar, Urban Complex, Gurgaon, Haryana, being developed by Sh. Ajit Singh and Others in Collaboration with EMAAR INDIA LTD.

STRUCTURE :-
DUCON CONSULTANTS PRIVATE LIMITED
A-101, 10th Floor, Sector 112, Gurgaon, Haryana
PH: 40073196, 65410630, 65410631

MEP :-
PARADISE CONSULTANTS
PLOT NO. 129, POCKET-2, BASEMENT JASOLA VIHAR, NEW DELHI-110025
PH: 011- 46132800, 41030619
E-mail: mep@paradiseconsultants.com

ARCHITECTS :-
ARCOP
ARCOP ASSOCIATES PVT LTD
Plot No. 36B, Sector-32, Institutional Area, Gurugram, Haryana. 122001, India
Tel.: 91-124-4595500
91-124-4595550
Fax: 91-124-4595550

ARCHITECT'S SEAL & SIGNATURE
OWNER'S SEAL & SIGNATURE

DATE:- 06-09-2024
SCALE:- 1:120

DRAWING TITLE:- TERRACE FLOOR PLAN AREA CALCULATION
DRAWING NO. EWS-05