



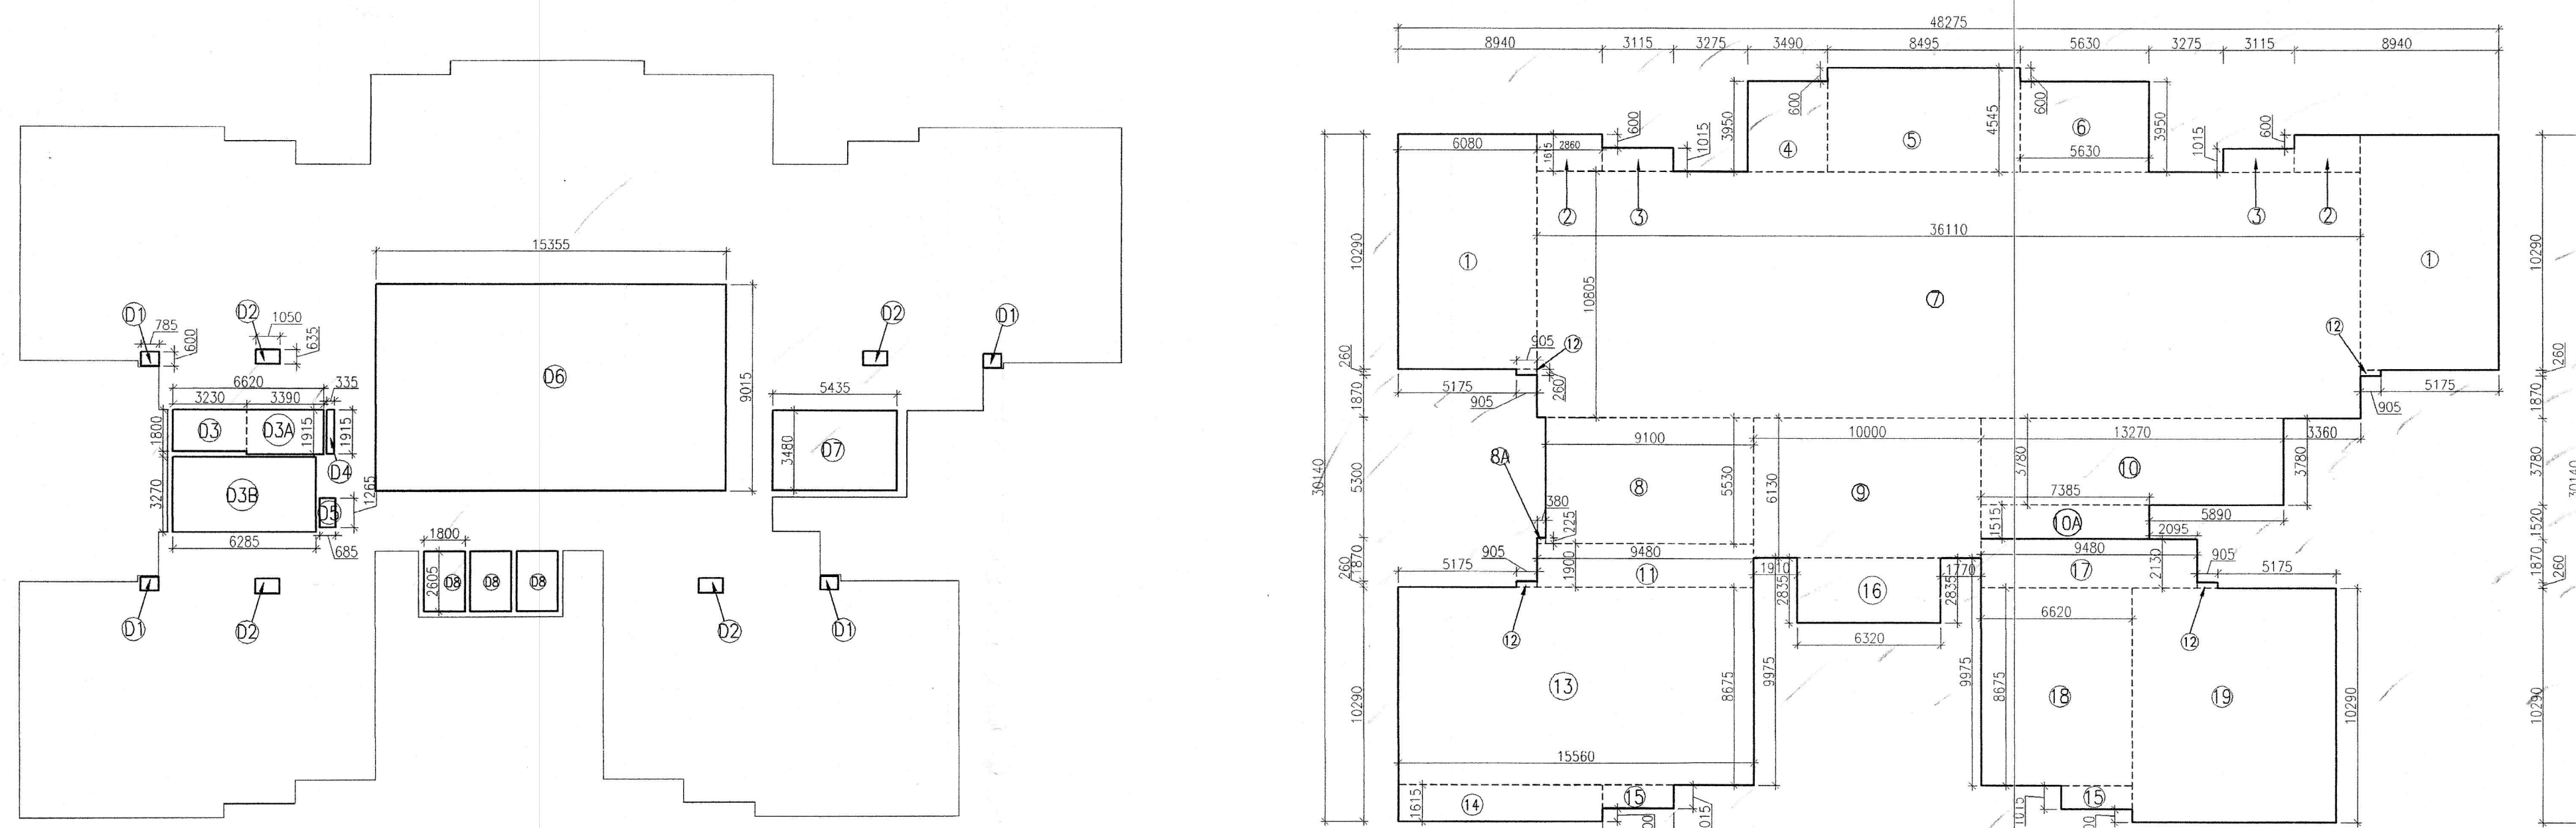

3RD FLOOR DEDUCTION AREA DIAGRAM
(SCALE:- 1:200)

3RD FLOOR AREA DIAGRAM
(SCALE:- 1:200)

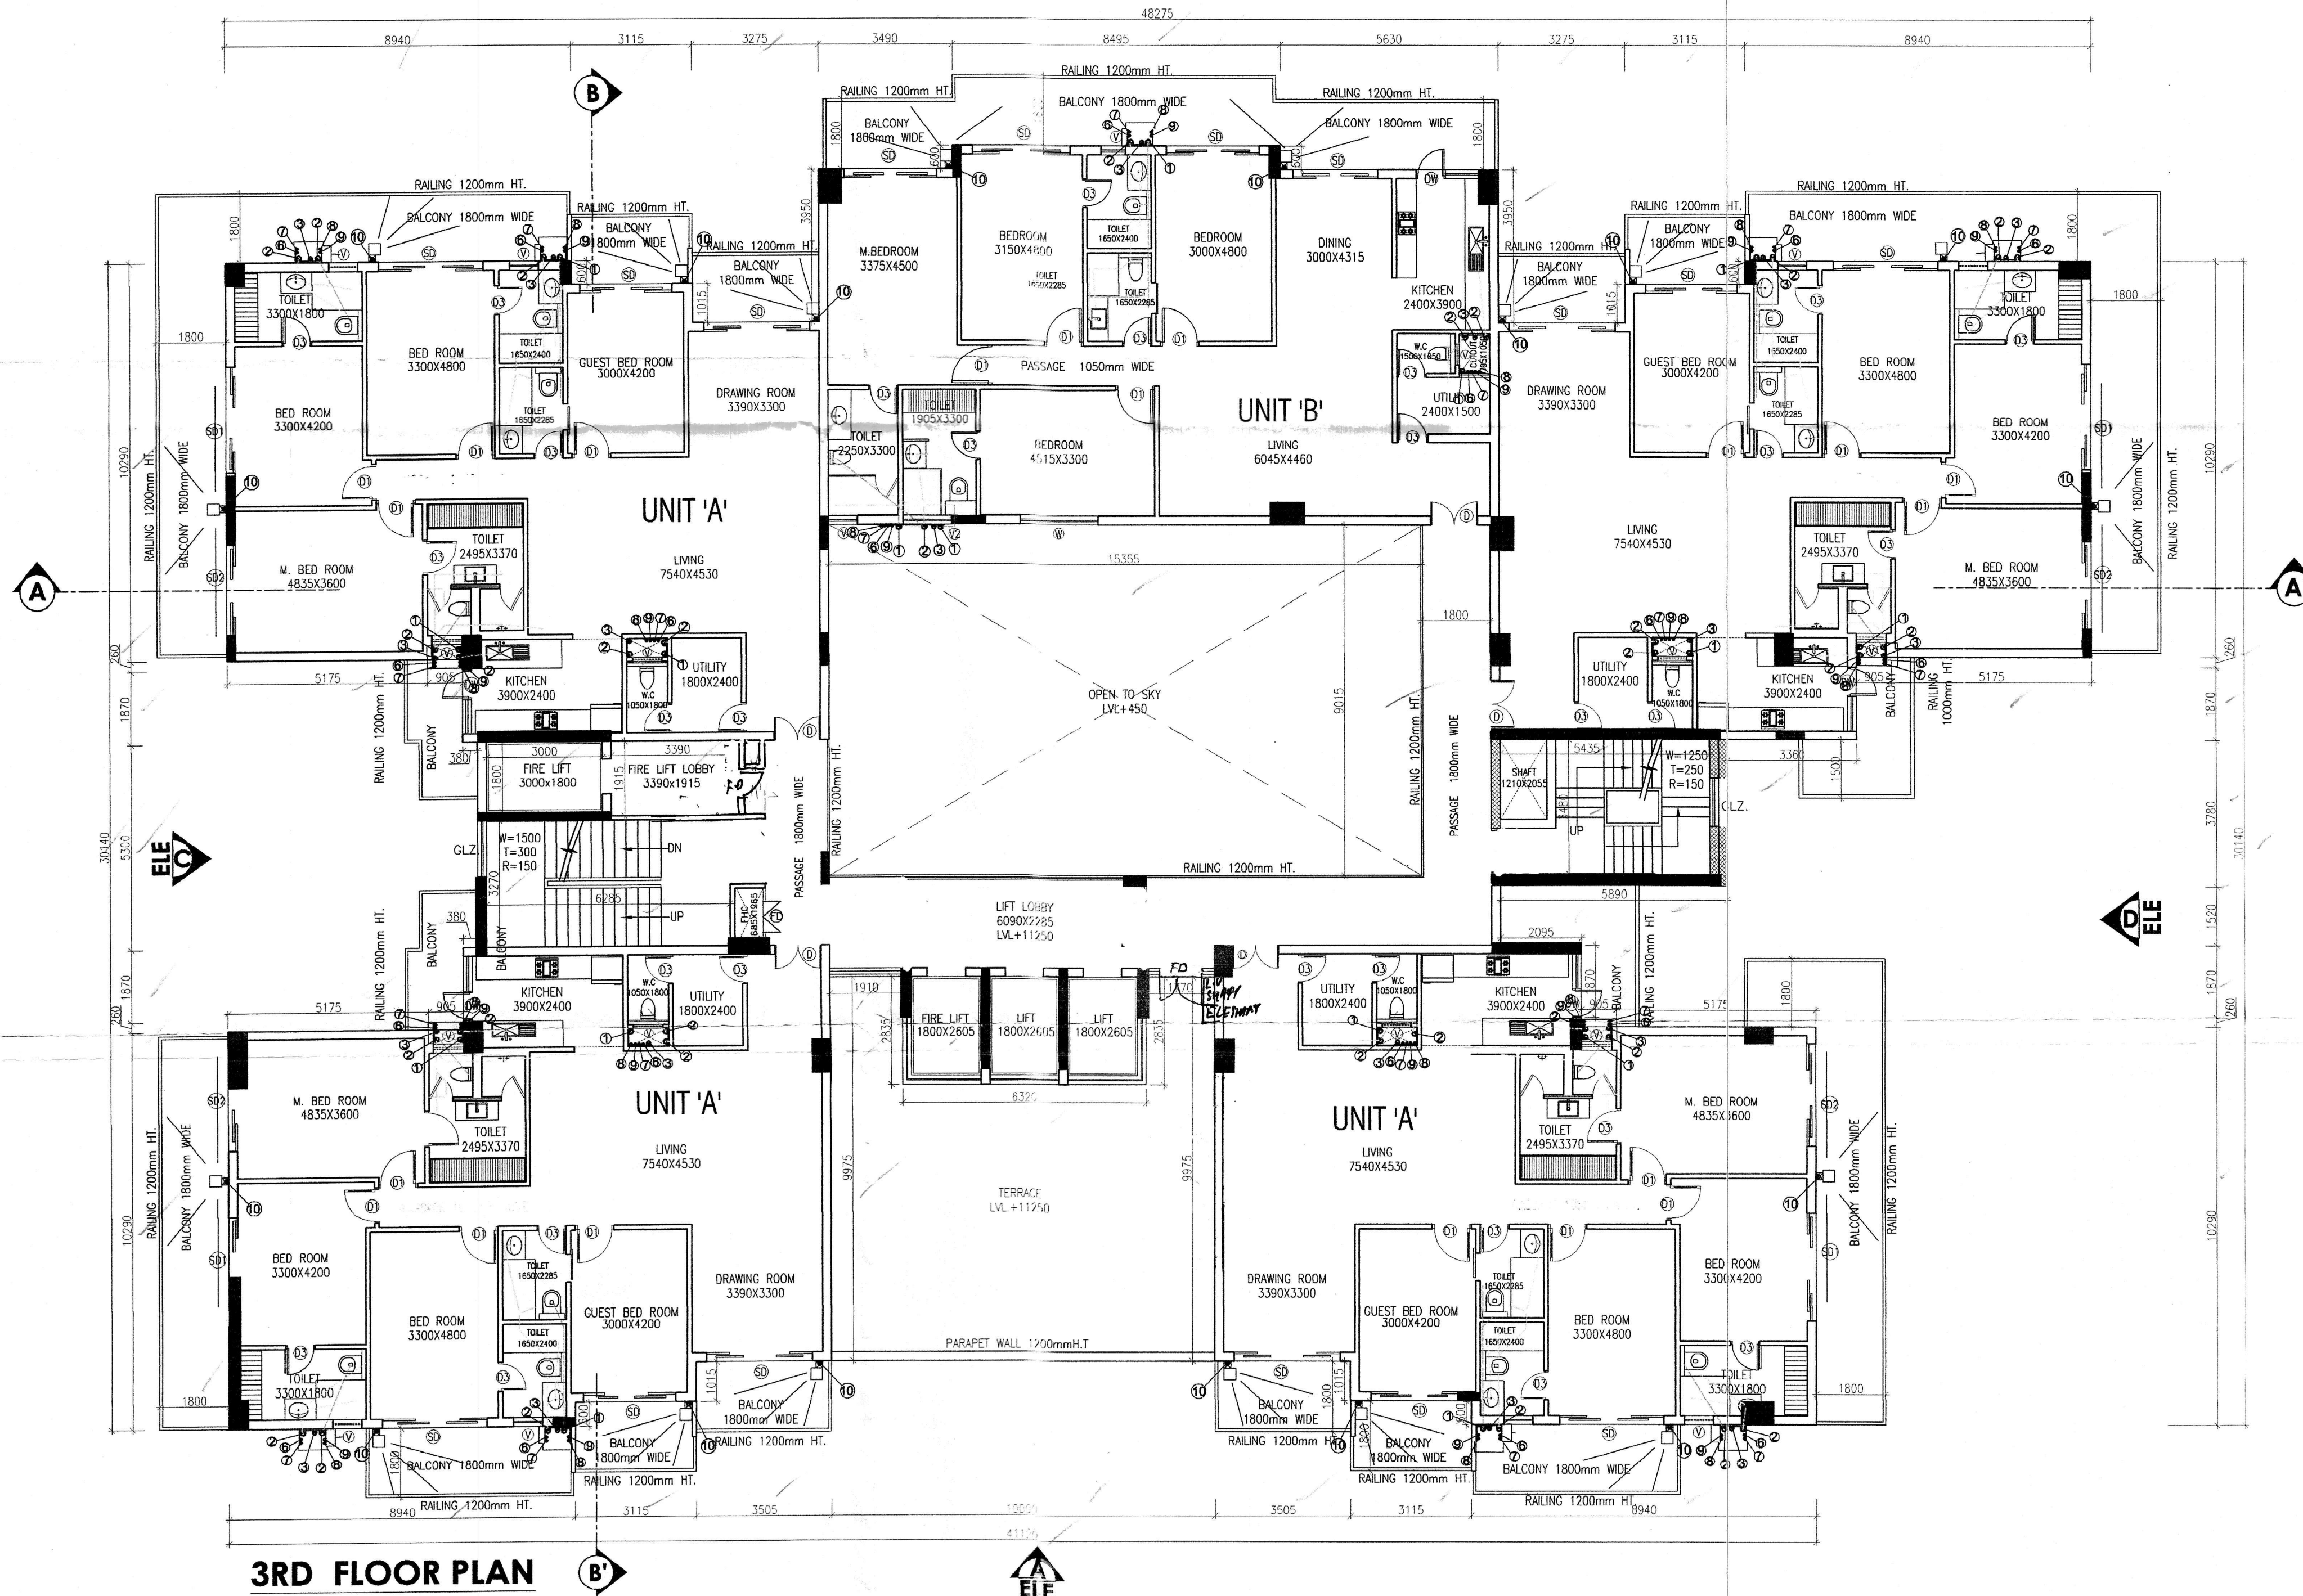

3RD FLOOR PLAN

3RD FLOOR AREA CALCULATIONS					
NO.	COEFF.	BREADTH	LENGTH	NO.S	AREA (SQ.M)
ADDITIONS					
1	1	6.080	10.290	2	125.126
2	1	2.860	1.615	2	9.238
3	1	3.115	1.015	2	6.323
4	1	3.490	3.950	1	13.786
5	1	8.495	4.545	1	38.610
6	1	5.630	3.950	1	22.239
7	1	36.110	10.805	1	390.169
8	1	9.100	5.530	1	50.323
8A	1	0.380	0.225	1	0.086
9	1	10.000	6.130	1	61.300
10	1	13.270	3.780	1	50.161
10A	1	7.385	1.515	1	11.188
11	1	9.480	1.900	1	18.012
12	1	0.905	0.260	4	0.941
13	1	15.560	8.675	1	134.983
14	1	8.940	1.615	1	14.438
15	1	3.115	1.015	2	6.323
16	1	6.320	2.835	1	17.917
17	1	9.480	2.130	1	20.192
18	1	6.620	8.675	1	57.429
19	1	8.940	10.290	1	91.993
TOTAL AREA (C1)					1140.776
DEDUCTIONS					
D1	1	0.785	0.600	4	1.884
D2	1	1.050	0.635	4	2.667
D3	1	3.230	1.800	1	5.814
D3A	1	3.390	1.915	1	6.492
D3B	1	6.285	3.270	1	20.552
D4	1	0.335	1.915	1	0.642
D5	1	0.685	1.265	1	0.867
D6	1	15.355	9.015	1	138.425
D7	1	5.435	3.480	1	18.914
D8	1	1.800	2.605	3	14.067
TOTAL DEDUCTIONS (B1)					210.323
NET FAR = (A1 + C1) - B1					930.453

NOTE:-
BUILDING BLOCK ARE MECHANICALLY VENTILATED
FULLY AIR CONDITIONED WITH 100 % POWER BACK UP.

262967 30/9/24

Superintending Engineer(HQ)
O/o Chief Engineer-I/II,
HSVP, Panchkula.

SANCTIONED
Vide Memo No. 7.111/24 Dated 1.0.11/24

DTP (HQ) Member Secretary BPAC
STP (HQ) Member BPAC
CTE Chairman BPAC

Suraj Bhan J.D.
JD (H)
DTP (H)
STP (H) (MEMBER) (B.P.A.C.)

DDA (HQ)
Member
BPAC

SYMBOL	DESCRIPTION
①	1000 SOIL & VENT PIPE
②	1000 WASTE & VENT PIPE
③	750 ANTISYPHONAGE PIPE
④	DWS RISER TO OHT (DOMESTIC WATER)
⑤	FWS RISER TO OHT (FLUSHING WATER)
⑥	DWS ON TAKE FOR GR TO 6th FLOOR
⑦	DWS ON TAKE FOR 7th TO 13th FLOOR
⑧	DWS ON TAKE FOR 14th TO 15th FLOOR (HYDRO SYSTEM)
⑨	FWS ON TAKE FOR FLUSHING SYSTEM
⑩	90 OD UPVC SWR RAIN WATER PIPE FOR BALCONY
⑪	110 OD UPVC SWR RAIN WATER PIPE FOR TERRACE
⑫	1500 MS FIRE PIPE
⑬	1500 MS SPRINKLER PIPE
⑭	800 SPRINKLER DRAIN PIPE

SCHEDULE OF OPENING					
S.R	TYPE	SIZE	S.L.	L.L.	
1	FD	1800 X 2400	00	2400	
2	D	1200 X 2400	00	2400	
3	D1	1000 X 2400	00	2400	
4	D2	750 X 2400	00	2400	
5	SD	2800 X 2400	00	2400	
6	SD1	2800 X 2400	00	2400	
7	SD2	2550 X 2400	00	2400	
8	SD3	2440 X 2400	00	2400	
9	SD4	750 X 2400	00	2400	
10	W	1900 X 1500	900	2400	
11	W1	1250 X 1500	900	2400	
12	V	750 X 900	1500	2400	
13	V1	550 X 900	1500	2400	
14	V2	550 X 900	1500	2400	
15	GLZ.	AS PER SITE			

PROJECT:-
PROPOSED BUILDING PLAN OF GROUP HOUSING SITE NO. GH26A, IN SECTOR-56, AREA MEASURING - 0.85 ACRE, URBAN ESTATE GURUGRAM - II BELONGINGS TO - M/S MNB BUILD FAB PVT. LTD. TH. PARTNER MR. MOHIT BAJAJ S/o MR. CHANDER BHUSHAN BAJAJ

ARCHITECTS:-
SACHDEVA CONSULTANTS.
Parnami Tower, 3rd Floor, S.C.O. 50-51, Old Judicial Complex, Civil Lines, Gurgaon - 122001.
Tel:- 0124-4081801, 4081802
email : saccon1953@gmail.com

ARCHITECT'S SEAL & SIGNATURE

OWNER'S SEAL & SIGNATURE

Scale : 1 : 100
Drawing Title:- **3RD FLOOR PLAN & AREA CALCULATION**
Drawing No:- **08**