



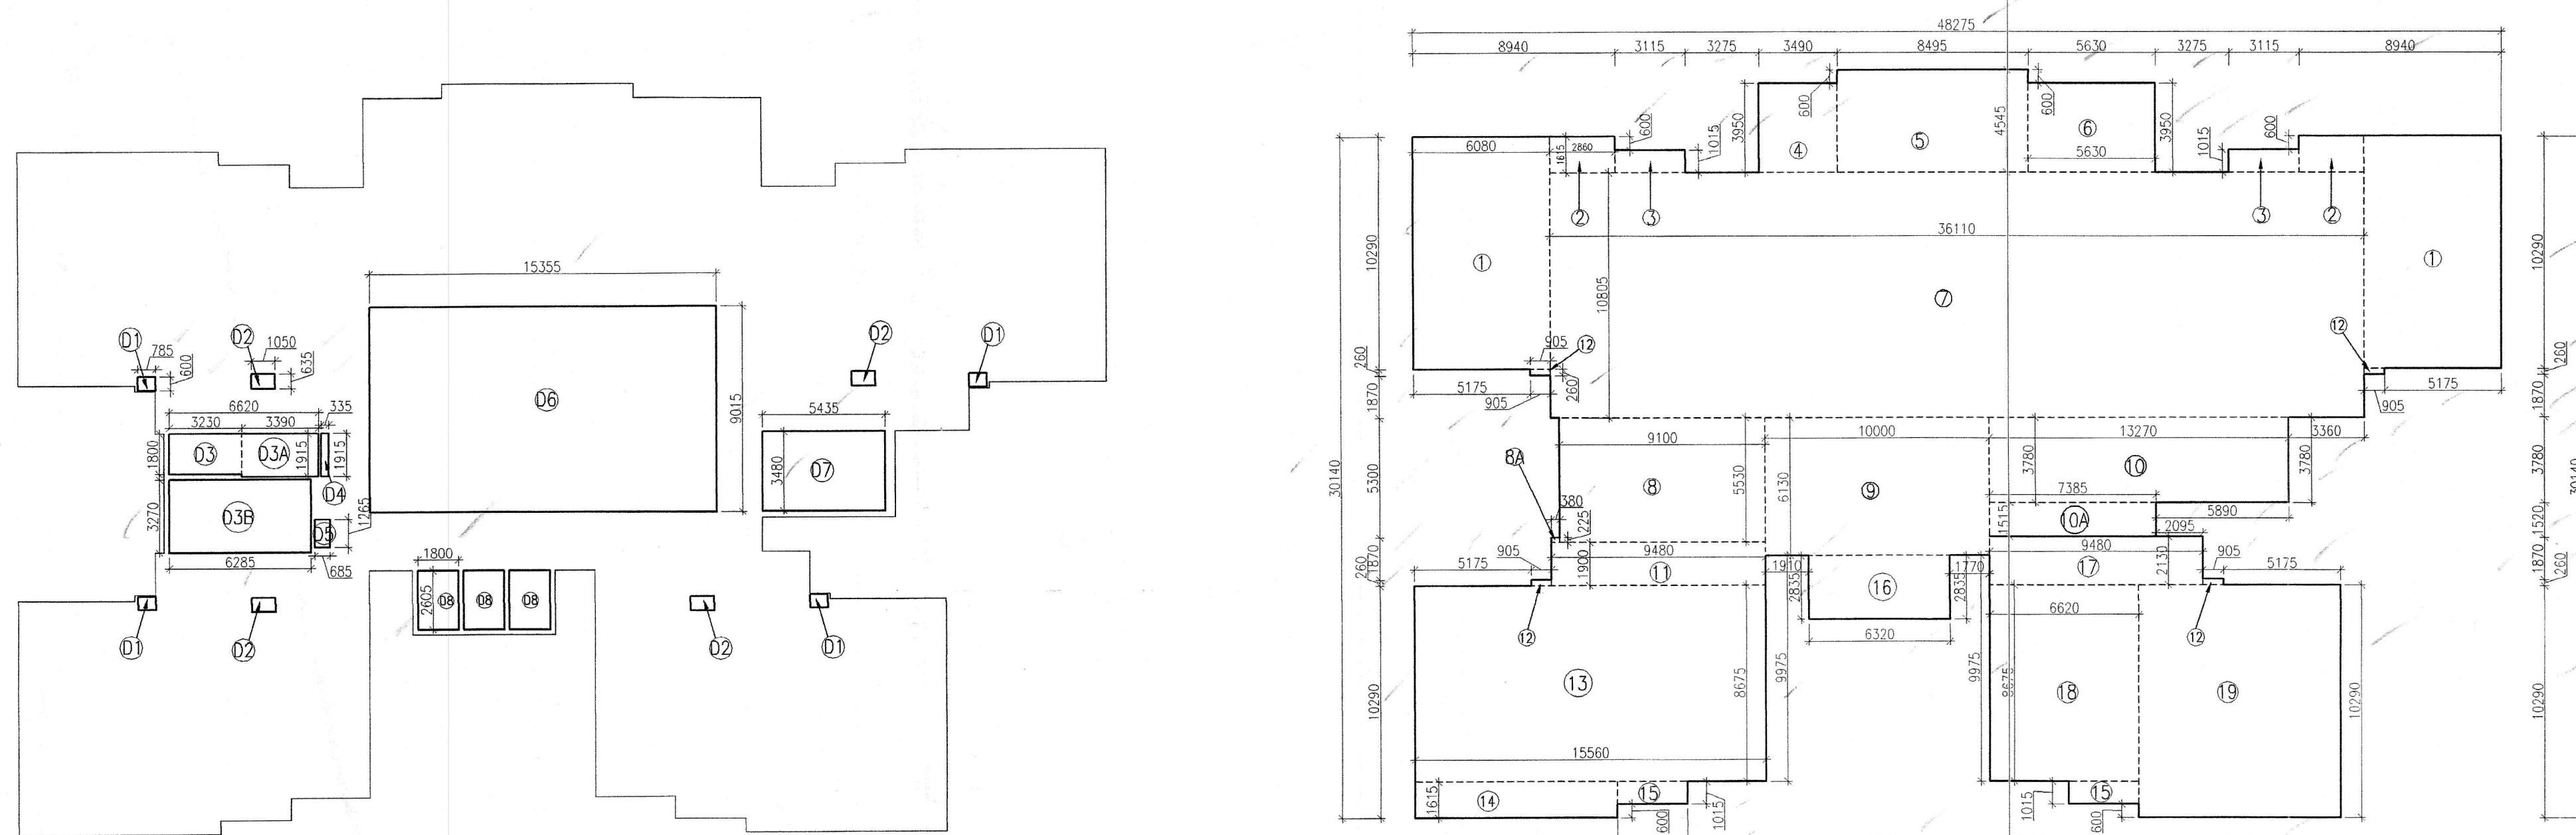

4TH TO 14TH FLOOR DEDUCTION AREA DIAGRAM
(SCALE:- 1:200)

4TH TO 14 FLOOR AREA DIAGRAM
(SCALE:- 1:200)

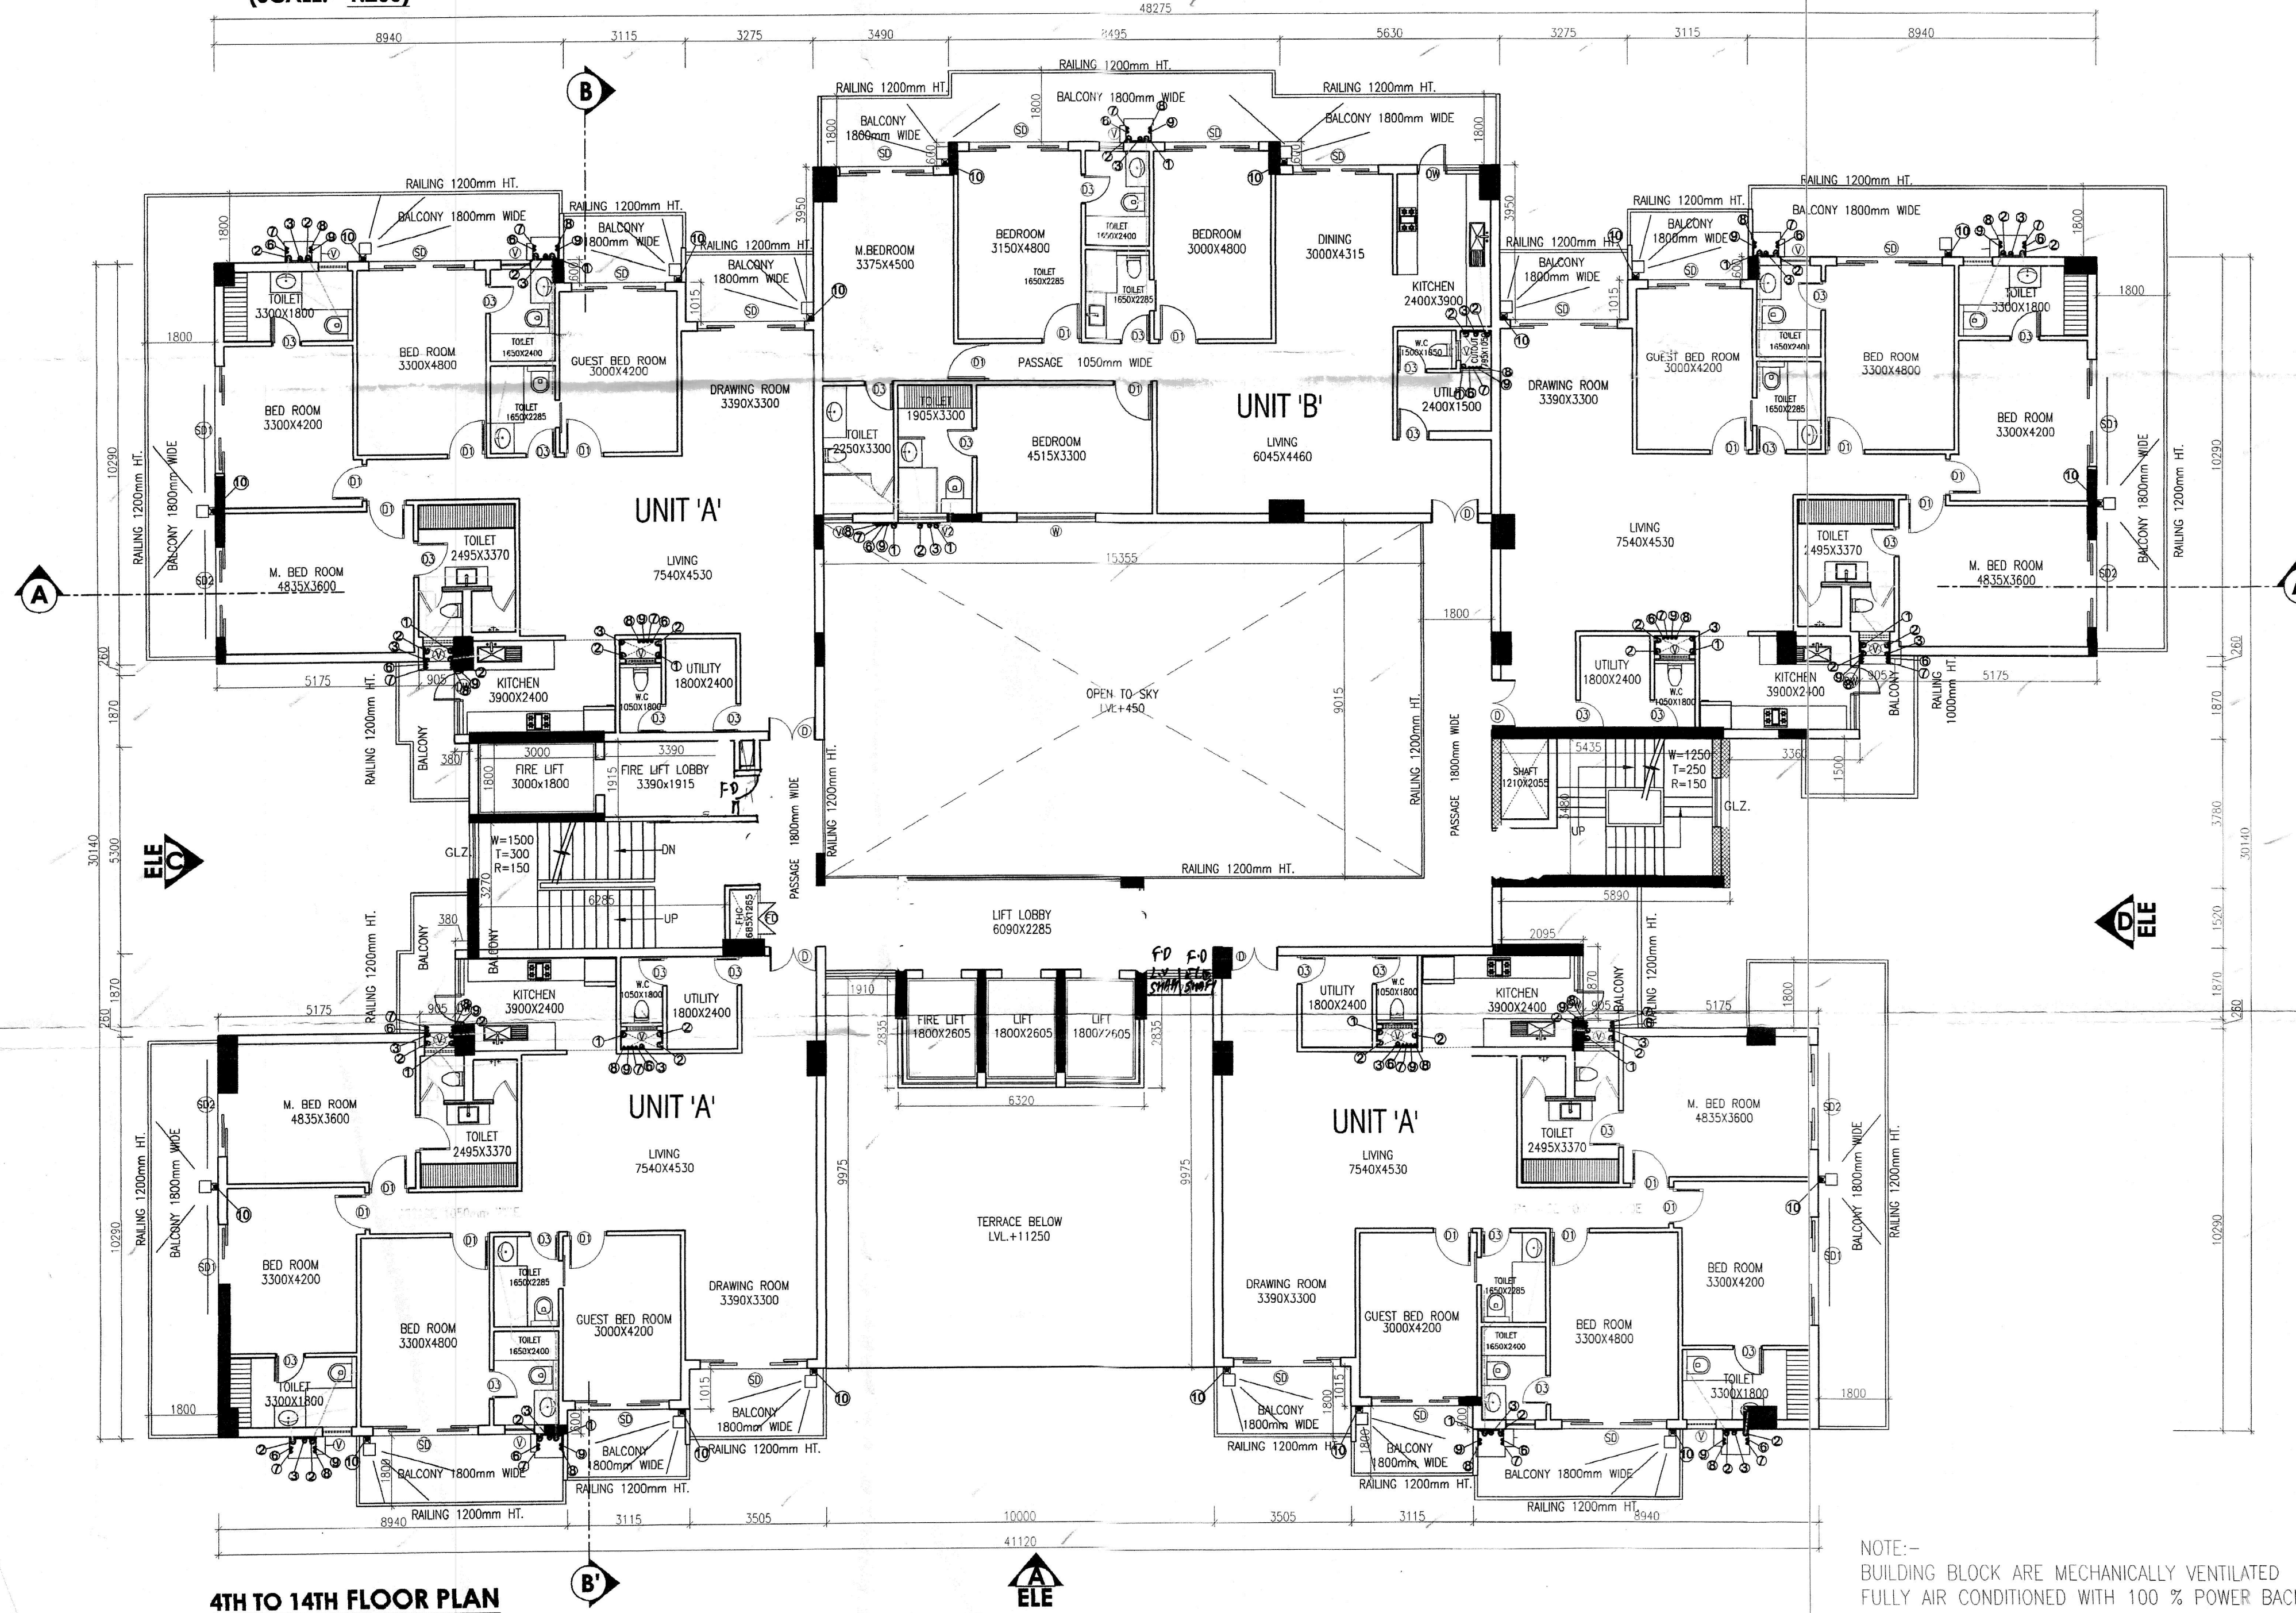

4TH TO 14TH FLOOR PLAN

TYP 4TH TO 14TH FLOOR AREA CALCULATIONS					
NO.	COEFF.	BREADTH	LENGTH	NO.s	AREA (SQ.M)
ADDITIONS					
1	1	6.080	10.290	2	125.126
2	1	2.860	1.615	2	9.238
3	1	3.115	1.015	2	6.323
4	1	3.490	3.950	1	13.786
5	1	8.495	4.545	1	38.610
6	1	5.630	3.950	1	22.239
7	1	36.110	10.805	1	390.169
8	1	9.100	5.530	1	50.323
8A	1	0.380	0.225	1	0.086
9	1	10.000	6.130	1	61.300
10	1	13.270	3.780	1	50.161
10A	1	7.385	1.515	1	11.188
11	1	9.480	1.900	1	18.012
12	1	0.905	0.260	4	0.941
13	1	15.560	8.675	1	134.983
14	1	8.940	1.615	1	14.438
15	1	3.115	1.015	2	6.323
16	1	6.320	2.835	1	17.917
17	1	9.480	2.130	1	20.192
18	1	6.620	8.675	1	57.429
19	1	8.940	10.290	1	91.993
TOTAL AREA (C1)					1140.776
DEDUCTIONS					
D1	1	0.785	0.600	4	1.884
D2	1	1.050	0.635	4	2.667
D3	1	3.230	1.800	1	5.814
D3A	1	3.390	1.915	1	6.492
D3B	1	6.285	3.270	1	20.552
D4	1	0.335	1.915	1	0.642
D5	1	0.685	1.265	1	0.867
D6	1	15.355	9.015	1	138.425
D7	1	5.435	3.480	1	18.914
D8	1	1.800	2.605	3	14.067
TOTAL DEDUCTIONS (B1)					210.323
NET FAR = (A1 + C1) - B1					930.453

FLOORS	LVL.
4TH. FLOOR	14550
5TH. FLOOR	17850
6TH. FLOOR	21150
7TH. FLOOR	24450
8TH. FLOOR	27750
9TH. FLOOR	31050
10TH. FLOOR	34350
11TH. FLOOR	37650
12TH. FLOOR	40950
13TH. FLOOR	44250
14TH. FLOOR	47550

NOTE:-
BUILDING BLOCK ARE MECHANICALLY VENTILATED
FULLY AIR CONDITIONED WITH 100 % POWER BACK UP.

Superintending Engineer (H.C.)
O/o Ch. Engineer-I/I.
H.V.P., Anchkul.

SANCTIONED
Vide Memo No. 271175 Dated 1.11.24

JD (H) DTP (H) STP (H)
(MEMBER)
(B.P.A.C.)

DD (H) (C)
Member
BPAC
DTP (HQ) STP (H) CTP
Member Secretary Member BPAC Chairman BPAC
Suraj Bhan J.D.

SYMBOL	DESCRIPTION
①	1000 SOIL & VENT PIPE
②	1000 WASTE & VENT PIPE
③	750 ANTISIPHONAGE PIPE
④	DWS RISER TO CHT (DOMESTIC WATER)
⑤	FWS RISER TO CHT (FLUSHING WATER)
⑥	DWS DN TAKE FOR GR TO 8th FLOOR
⑦	DWS DN TAKE FOR 7th TO 15th FLOOR
⑧	DWS DN TAKE FOR 14th TO 15th FLOOR (HYDRO SYSTEM)
⑨	FWS DN TAKE FOR FLUSHING SYSTEM
⑩	90 OD uPVC SWR RAIN WATER PIPE FOR BALCONY
⑪	110 OD uPVC SWR RAIN WATER PIPE FOR TERRACE
⑫	1500 MS FIRE PIPE
⑬	1500 MS SPRINKLER PIPE
⑭	800 SPRINKLER DRAIN PIPE

SCHEDULE OF OPENING					
S.R.	TYPE	SIZE	S.L.	L.L.	
1	FD	1800 X 2400	00	2400	
2	D	1200 X 2400	00	2400	
3	D1	1000 X 2400	00	2400	
4	D2	750 X 2400	00	2400	
5	SD	2900 X 2400	00	2400	
6	SD1	2800 X 2400	00	2400	
7	SD2	2550 X 2400	00	2400	
8	SD3	2440 X 2400	00	2400	
9	SD4	750 X 2400	00	2400	
10	W	1800 X 1500	900	2400	
11	W1	1250 X 1500	900	2400	
12	V	750 X 900	1500	2400	
13	V1	550 X 900	1500	2400	
14	V2	550 X 900	1500	2400	
15	GLZ.	AS PER SITE			


PROJECT:-
PROPOSED BUILDING PLAN OF
GROUP HOUSING SITE NO. GH26A, IN
SECTOR-56, AREA MEASURING - 0.85
ACRE, URBAN ESTATE GURUGRAM - II
BELONGINGS TO - M/S MNB BUILD
FAB PVT. LTD. TH. PARTNER MR. MOHIT
BAJAJ S/o MR. CHANDER BHUSHAN
BAJAJ

ARCHITECTS:-

SACHDEVA CONSULTANTS.

Parnami Tower, 3rd Floor, S.C.O. 50-51,
Old Judicial Complex, Civil Lines,
Gurgaon - 122001
Tel.: 0124-4081801, 4081802
email : soccon1953@gmail.com

ARCHITECT'S SEAL
& SIGNATURE

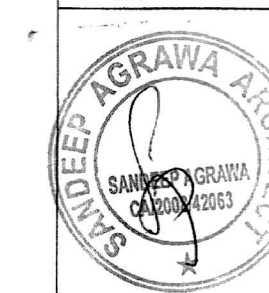

Scale :-

Drawing Title:-

4TH TO 14TH FLOOR PLAN
& AREA CALCULATION

OWNER'S SEAL
& SIGNATURE



Scale :-

Drawing No:-

09