



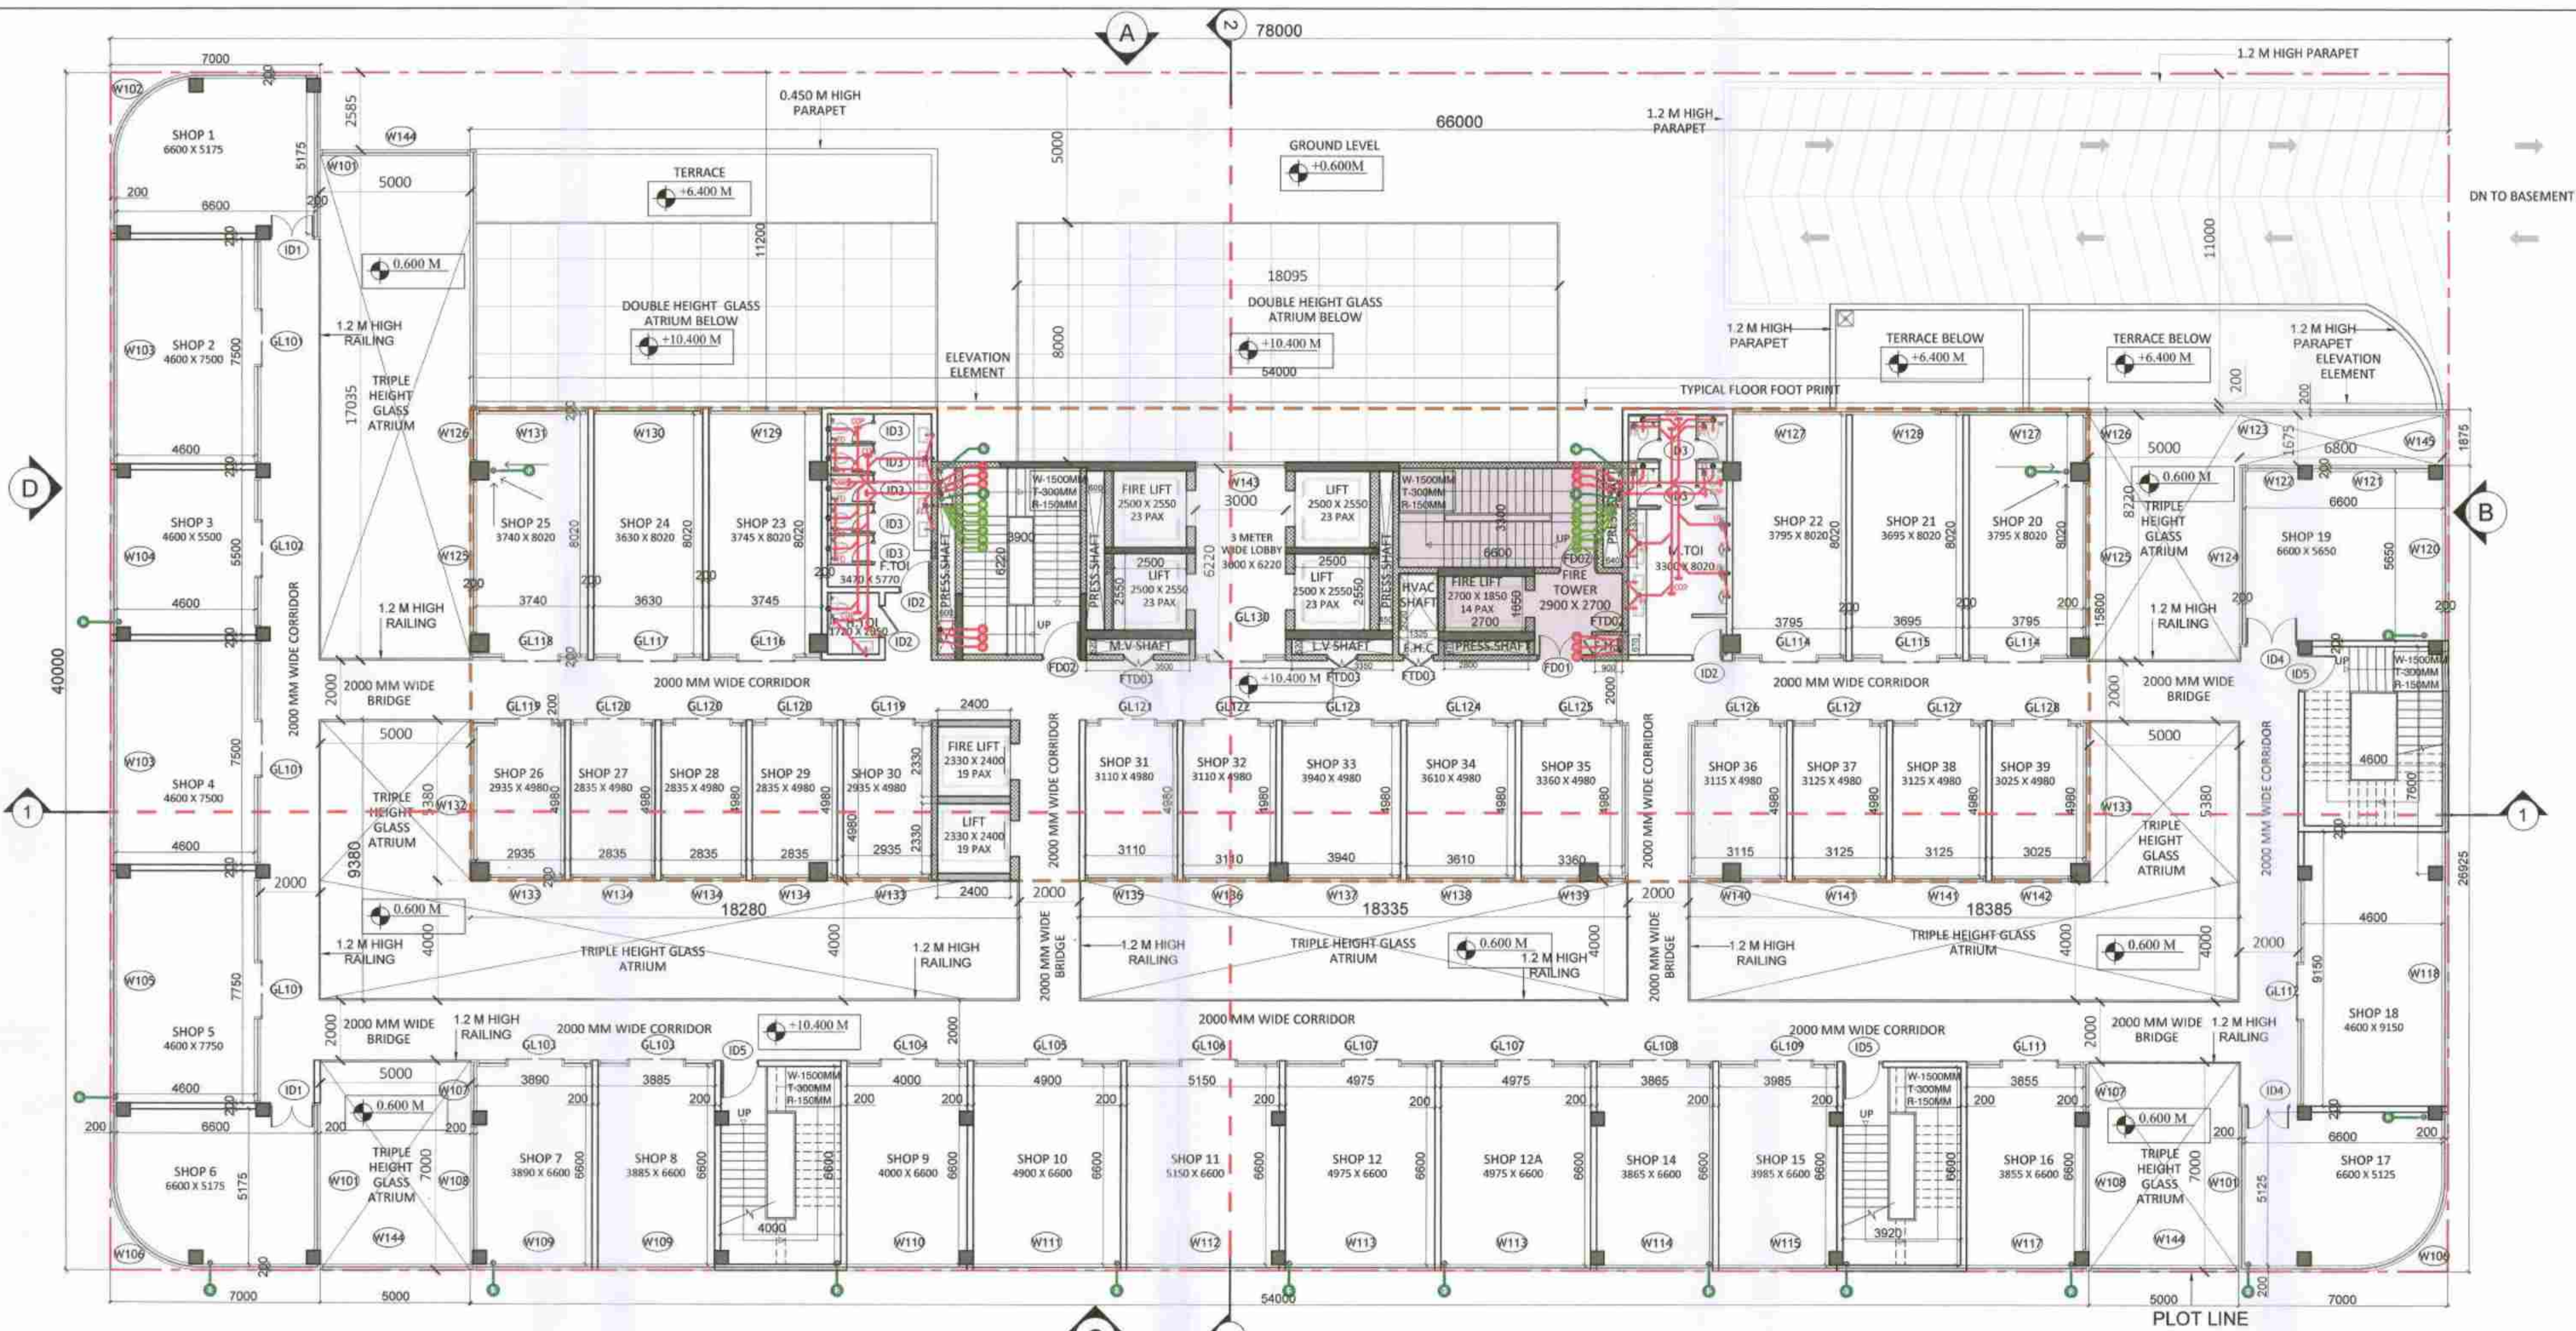

SECOND FLOOR PLAN (1:150) +10.400 M LVL

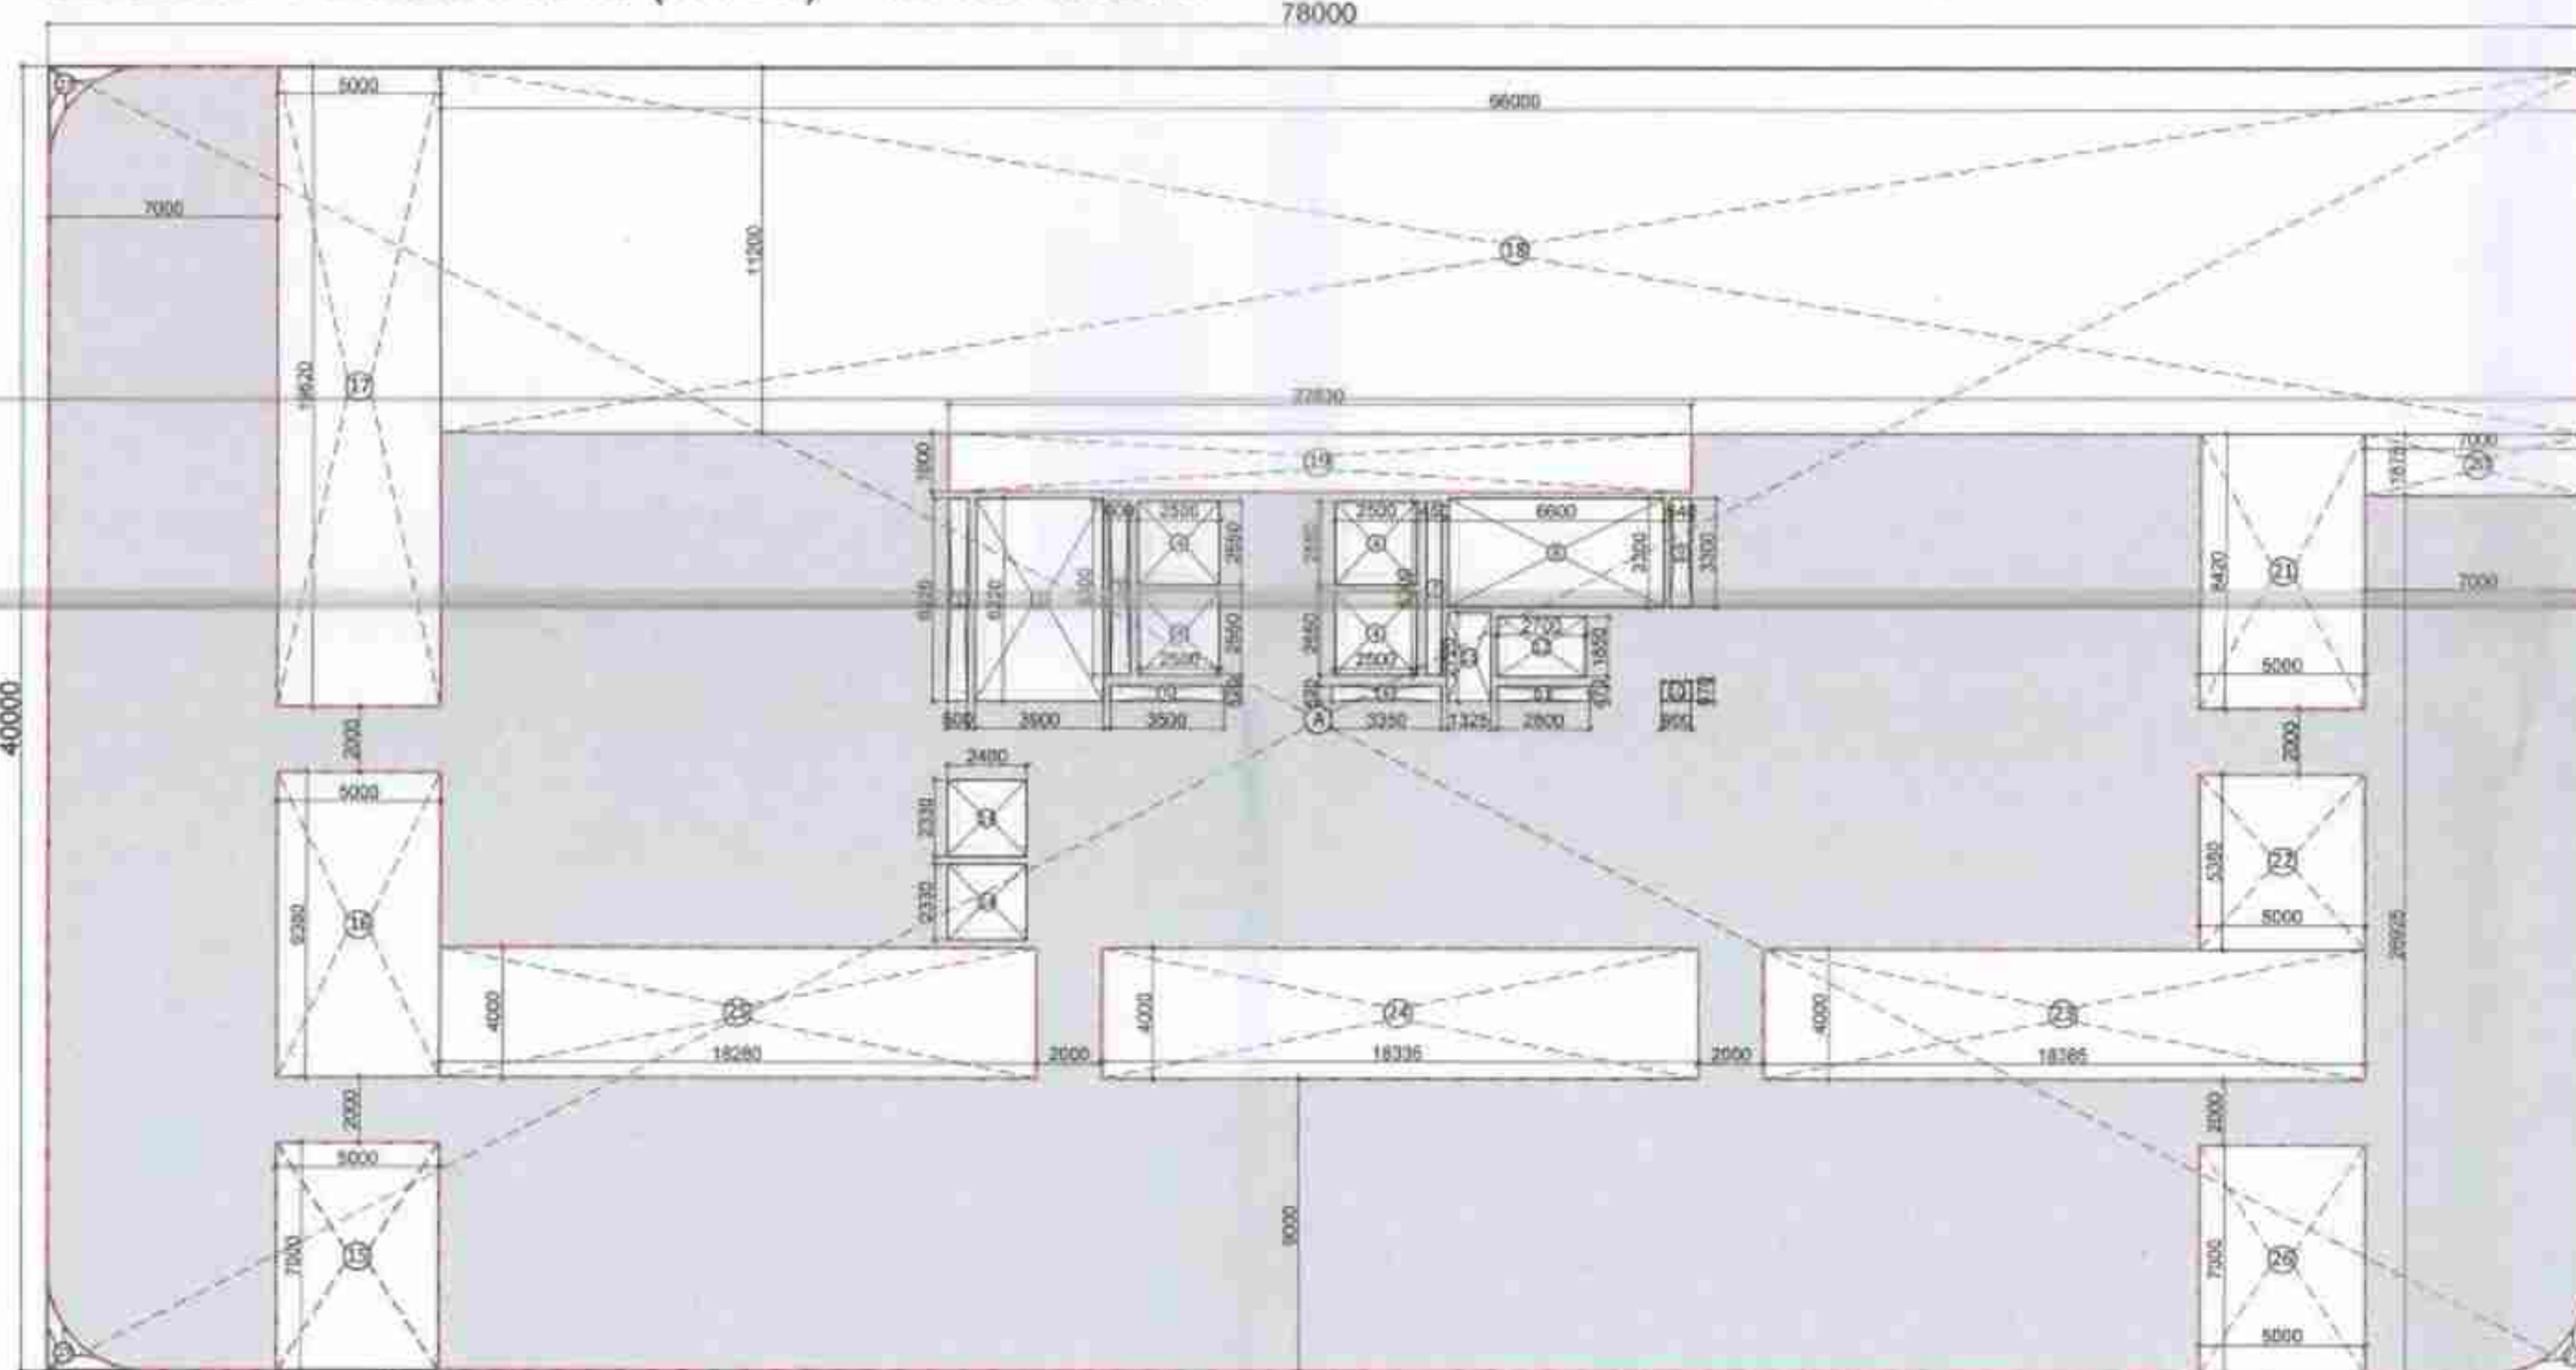

AREA DIAGRAM (1:300)

SECOND FLOOR SANITARY FIXTURE CALCULATION									
TOTAL COVERED AREA									
TOTAL POPULATION @ 80 MT/PERSON									
TOTAL POPULATION @ 80 MT/PERSON									
TOTAL POPULATION @ 80 MT/PERSON									
TOTAL POPULATION @ 80 MT/PERSON									
TOTAL POPULATION @ 80 MT/PERSON									
TOTAL POPULATION @ 80 MT/PERSON									
TOTAL POPULATION @ 80 MT/PERSON									
TOTAL POPULATION @ 80 MT/PERSON									

SECOND FLOOR									
INTERNAL DOOR SCHEDULE									
INTERNAL DOOR SCHEDULE									
CARPET AREA DIAGRAM (1:300)									
CARPET AREA DIAGRAM (1:300)									
FAR SF				
S.NO.	NO.s	Length(in mm)	Breadth(in mm)	Area(in sqm)
ADDITION				
1	1	78000	40000	3120.00
TOTAL AREA(A)				
SUBTRACTION				
1	1	600	6220	3.73
2	1	3900	6220	24.26
3	1	600	5300	3.18
4	1	2500	2550	25.50
5	1	3500	520	1.82
6	1	3350	520	1.74
7	1	450	5300	2.39
8	1	6600	3300	21.78
9	1	640	3300	2.11
10	1	900	670	0.60
11	1	2800	470	1.32
12	1	2700	1850	5.00
13	1	1325	2720	3.60
14	2	2400	2330	11.18
15	1	5000	7000	35.00
16	1	5000	9380	46.90
17	1	5000	19520	98.10
18	1	86000	11200	739.20
19	1	22300	1800	41.09
20	1	7000	1875	13.13
21	1	5000	8420	42.10
22	1	5000	5380	26.90
23	1	18385	4000	73.54
24	1	18335	4000	73.34
25	1	18280	4000	73.12
26	1	5000	7000	35.00
27	3	AS PER SHAPE		5.79
TOTAL SUBTRACTION (B)				1411.42
C. FAR (A-B)				1708.58

AREA FREE FROM FAR				
S.NO.	NO.s	Length(in mm)	Breadth(in mm)	Area(in sqm)
ADDITION (X)				
2	1	3900	6220	24.26
8	1	6600	3300	21.78
TOTAL ADDITION				46.04
TOTAL COVERED AREA (C + D)				1754.62

CARPET AREA SECOND FLOOR				
S.NO.	NO.s	Length(in mm)	Breadth(in mm)	Area(in sqm)
1	1	AS PER SHAPE		32.47
2	1	4800	7750	35.69
3	1	4600	7500	34.50
4	1	4600	5500	25.30
5	1	4600	7500	34.50
6	1	AS PER SHAPE		32.47
7	1	3740	8020	29.99
8	1	3630	8020	29.11
9	1	3745	8020	30.03
10	1	2935	4980	14.62
11	1	2835	4980	14.12
12	1	2835	4980	14.12
13	1	2835	4980	14.12
14	1	2935	4980	14.62
15	1	3110	4980	15.49
16	1	3110	4980	15.49
17	1	3940	4980	19.62
18	1	3610	4980	17.98
19	1	3360	4980	16.73
20	1	3115	4980	15.51
21	1	3125	4980	15.59
22	1	3125	4980	15.59
23	1	3025	4980	15.06
24	1	3795	8020	30.44
25	1	3695	8020	29.63
26	1	3795	8020	30.44
27	1	6600	5650	37.25
28	1	4600	9150	42.05
29	1	AS PER SHAPE		32.14
30	1	3855	6600	25.44
31	1	3855	6600	25.44
32	1	3855	6600	25.44
33	1	4975	6600	32.84
34	1	4975	6600	32.84
35	1	5150	6600	33.99
36	1	4900	6600	32.34
37	1	4000	6600	26.40
38	1	3885	6600	25.64
39	1	3890	6600	25.67
CARPET AREA				991.62


Authority Signatory

 M. S. Srinivasan
 J. D. H.
 D. P. H.
 S. P. H.

LEGEND FOR PLUMBING	
1	100/150mm CUTOUT IN GLASS FOR WC UT & FT
2	100/150 C.I. SOIL & VENT PIPE
3	100/150 C.I. SOIL & VENT PIPE
4	100/150 C.I. WASTE & VENT PIPE
5	100/150 C.I. WASTE & VENT PIPE
6	100/150 C.I. WASTE & VENT PIPE
7	750 C.I. ANTI-SYPHONIC PIPE
8	DOMESTIC WATER SUPPLY FOR 25th to 15th FLOOR DOWN TAKE PIPE
9	FLUSHING WATER SUPPLY FOR 25th to 15th FLOOR DOWN TAKE PIPE
10	DOMESTIC WATER SUPPLY FOR 14th to 7th FLOOR DOWN TAKE PIPE
11	FLUSHING WATER SUPPLY FOR 14th to 7th FLOOR DOWN TAKE PIPE
12	DOMESTIC WATER SUPPLY FOR 6th to GROUND FLOOR DOWN TAKE PIPE
13	FLUSHING WATER SUPPLY FOR 6th to GROUND FLOOR DOWN TAKE PIPE
14	650 DOMESTIC WATER SUPPLY FOR 6th to GROUND FLOOR DOWN TAKE PIPE
15	650 DOMESTIC WATER SUPPLY FOR 6th to GROUND FLOOR DOWN TAKE PIPE
16	100/ODUPVC RAIN WATER PIPE FOR TERRACE
17	100/ODUPVC RAIN WATER PIPE FOR TERRACE
18	100/ODUPVC RAIN WATER PIPE FOR TERRACE
100	100/ODUPVC RAIN WATER PIPE FOR TERRACE

PLUMBING NOTES:-
 * W.C. TO HORIZONTAL SOIL PIPE 1000 SOIL PIPE
 * F.T. TO HORIZONTAL WASTE PIPE 1000 WASTE PIPE
 * U.T. TO HORIZONTAL SOIL PIPE 1000 SOIL PIPE
 * FLOOR DRAIN TO FLOOR TRAP 320 WASTE PIPE
 * WASH BASIN TO FLOOR TRAP 320 WASTE PIPE
 * BINK TO FLOOR TRAP 400 WASTE PIPE

- NOTE:
- THE BUILDING WILL BE MECHANICALLY VENTILATED.
 - SPRINKLERS ARE INCORPORATED AS/NBC.

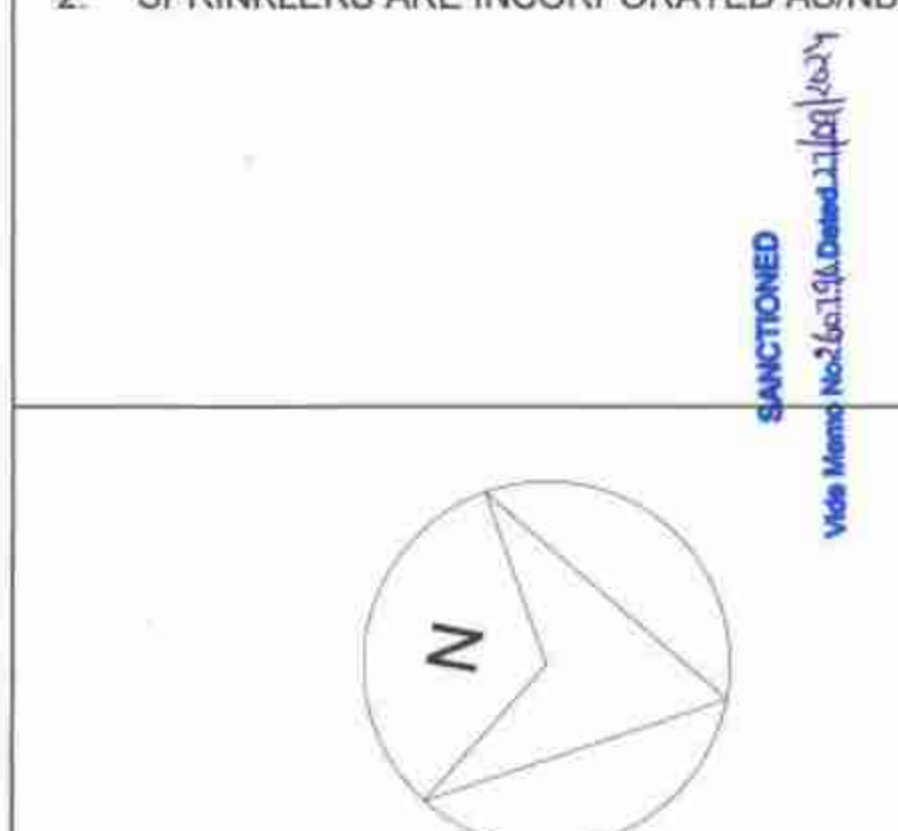

Architects :

OWNER SIGN
 ARCHITECT SIGN
 For ESSEL INFRA LLP
 Designed/Pattern/Sign.

Clients:
 ESSEL INFRA LLP


Project Title :
 COMMERCIAL COMPLEX SITE C2 IN SHOPPING CENTRE SECTOR -43, GURUGRAM.

Drawing Title :
 SUBMISSION DRAWINGS


2ND FLOOR

Scale :
 Date : JUN-2024


Drawing No : C2_FP-03
 Checked By : A.S.
 Sheet Size : A1

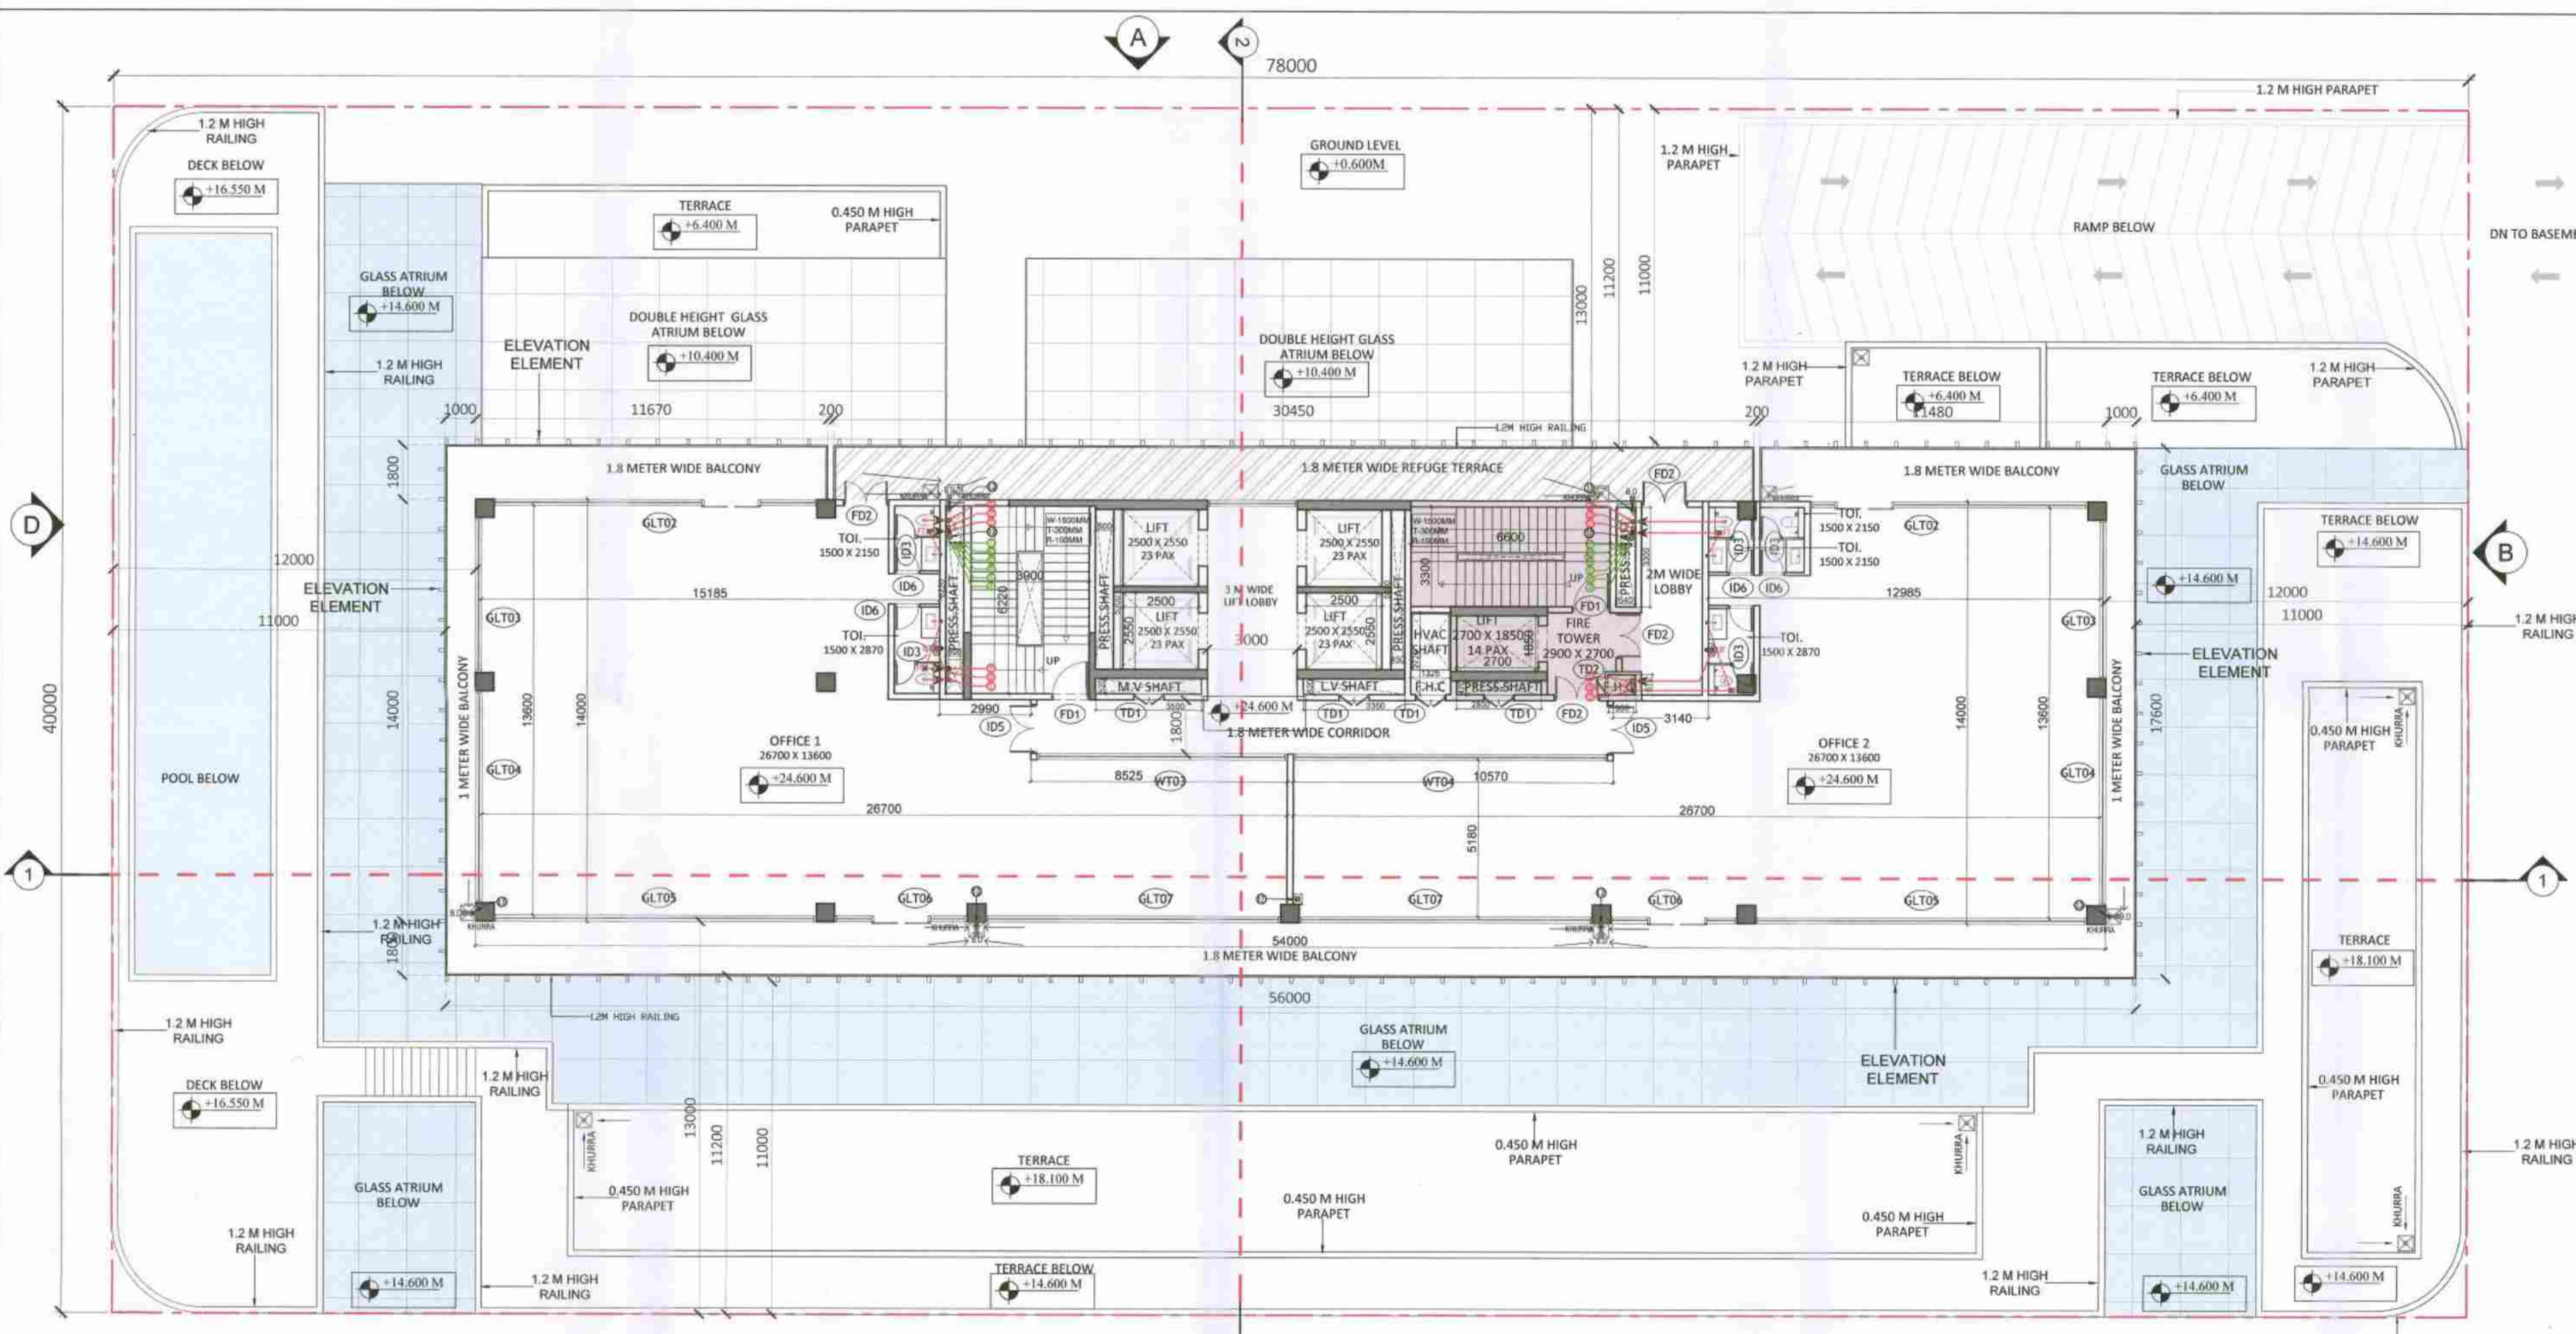


TYPICAL REFUGE FLOOR PLAN (1:150), (5th, 8th, 12th & 15th)

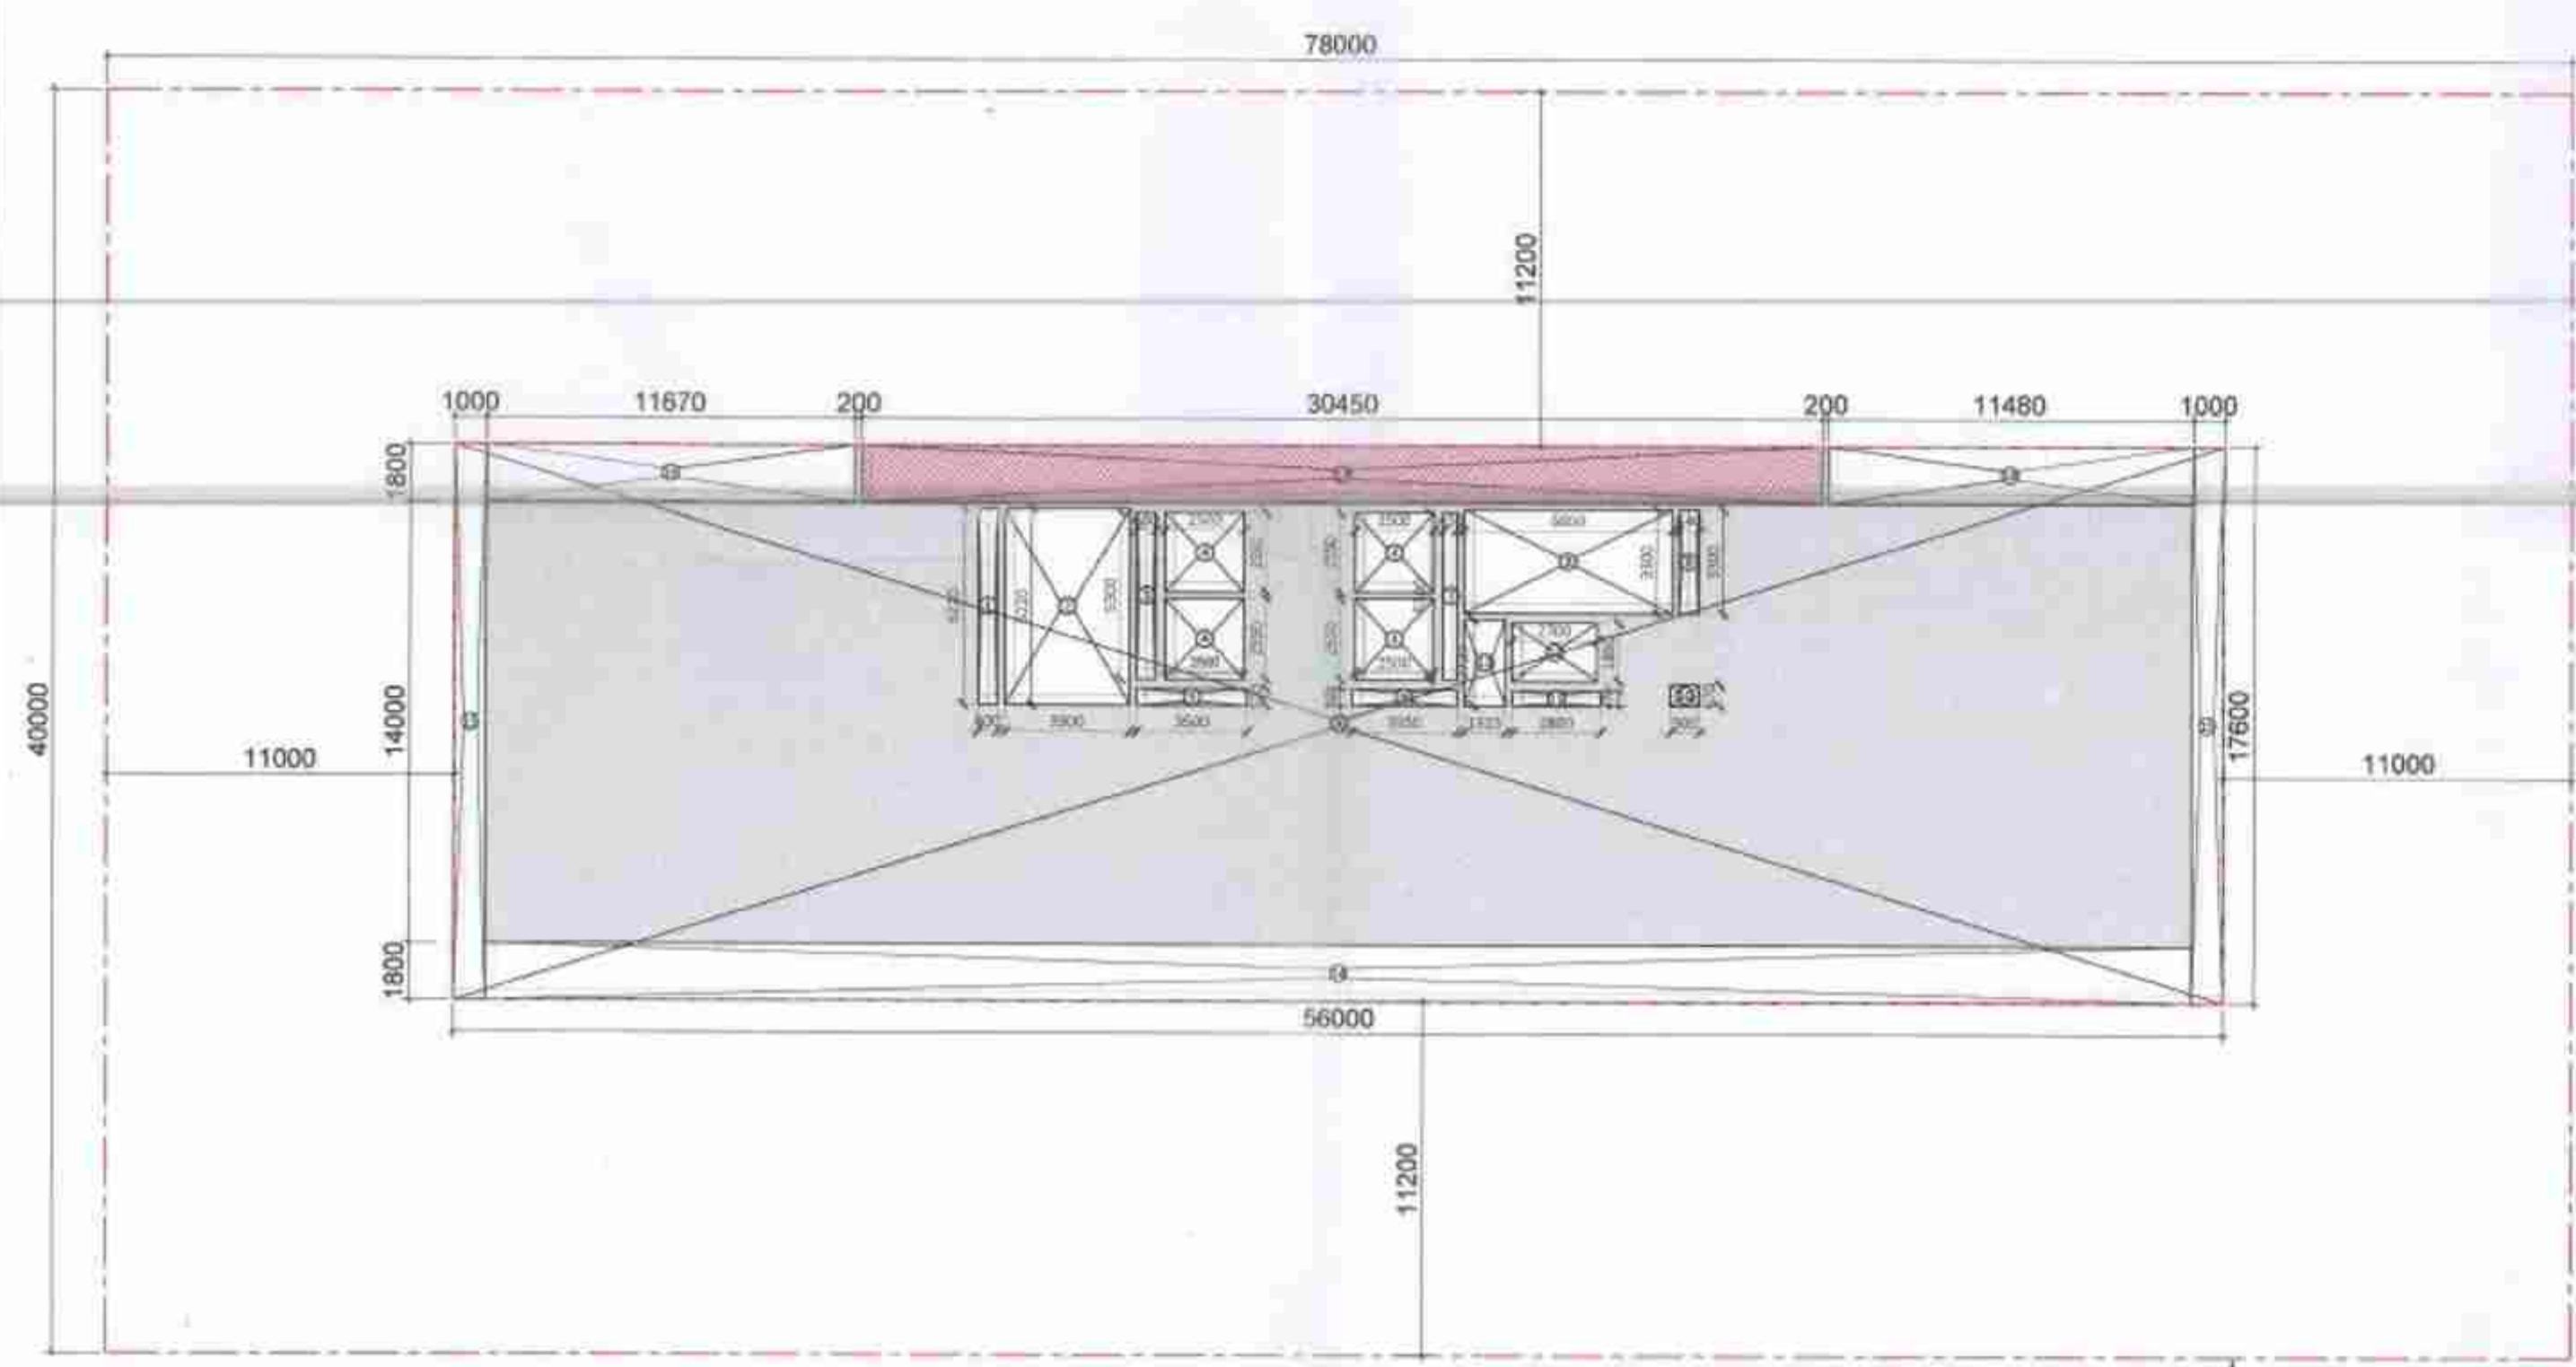

AREA DIAGRAM (1:300)

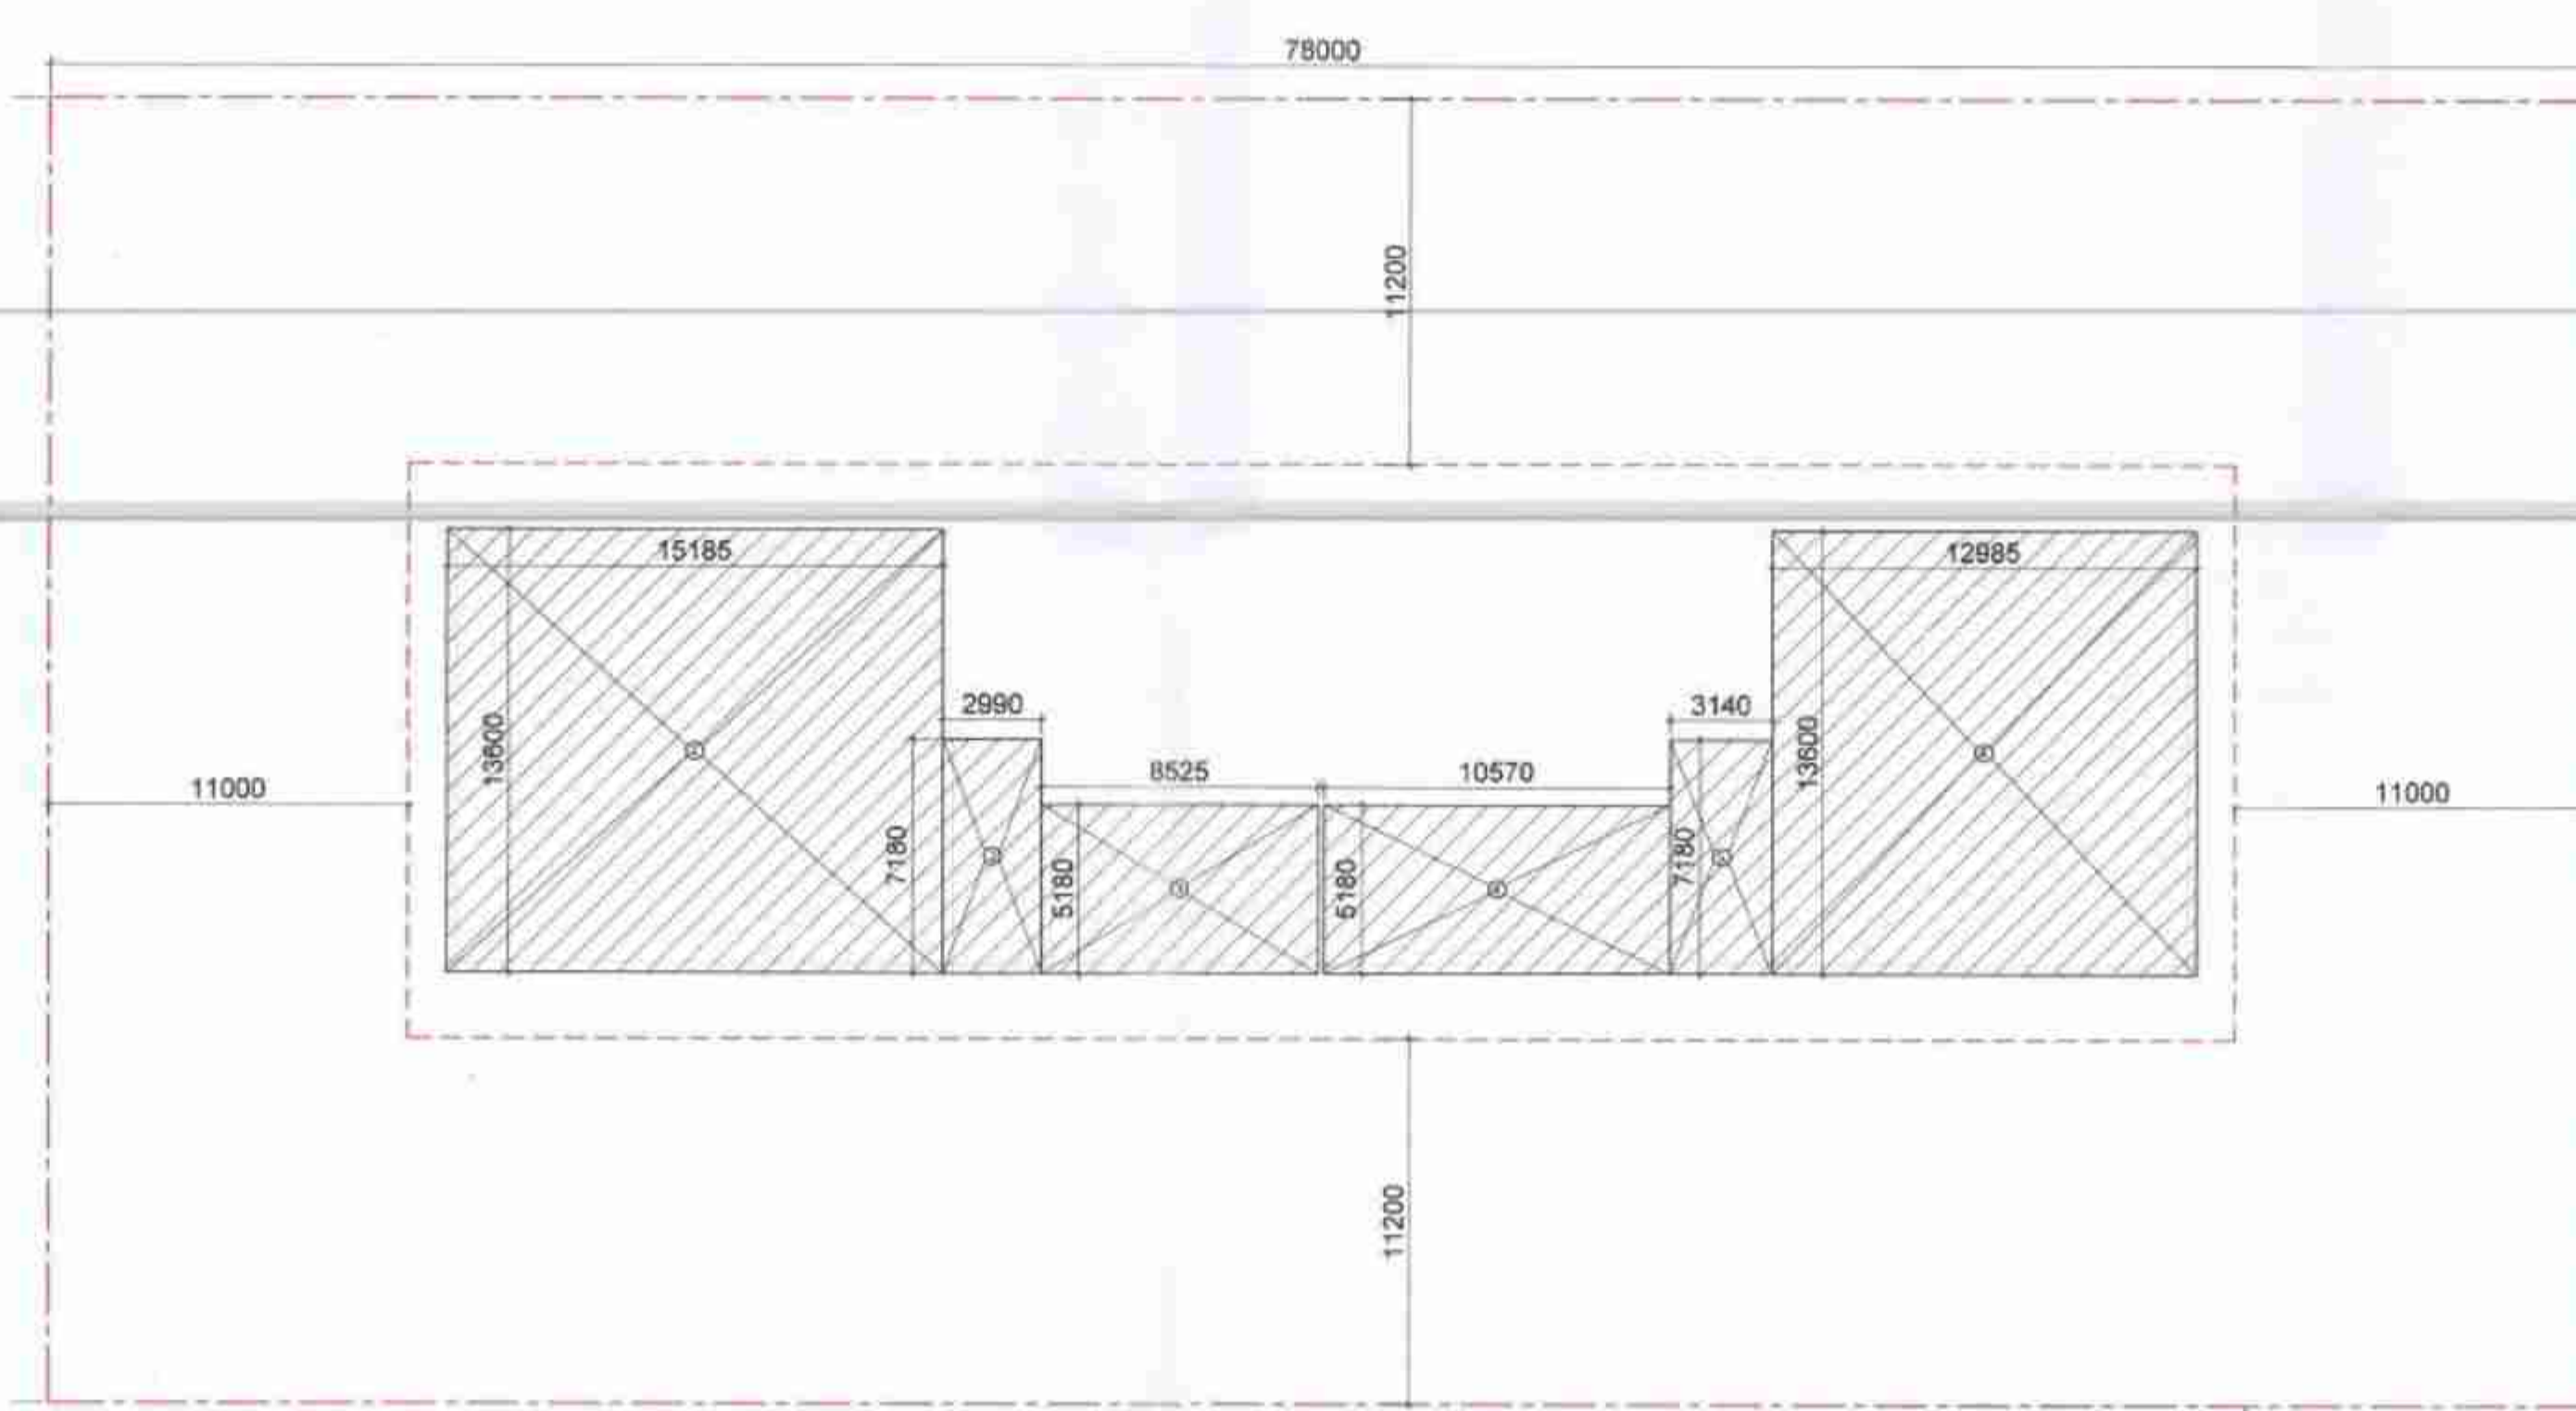

CARPET AREA DIAGRAM (1:300)

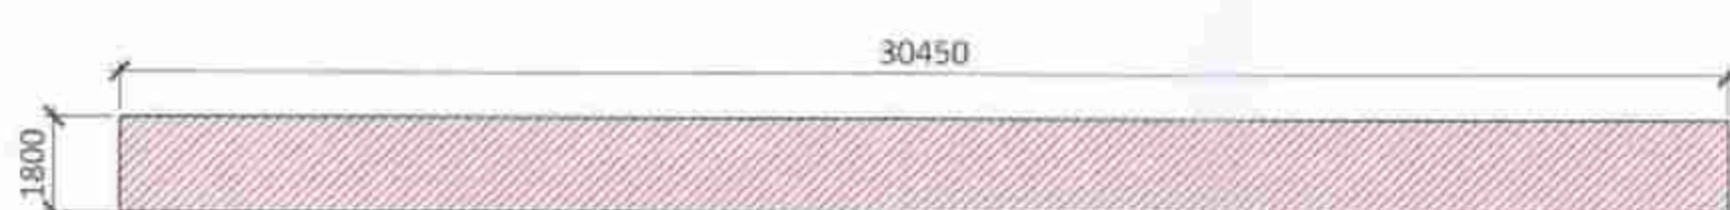

REFUGE AREA DIAGRAM (1:200)

REFUGE AREA CALCULATION				
S.NO.	NO.s	Length(in mm)	Breadth(in mm)	Area(in sqm)
17	1	30450	1800	54.81
TOTAL AREA				54.81

REFUGE AREA CALCULATION						
FLOOR	HT (in M)	Area of two consecutive floors (sqm)	Total area (sqm)	Occupant Load @ 10sqm/PERSON	Area equi. @ 0.3sqm/PERSON (sqm)	Additional area for wheelchair requirement (sqm)
FIFTH FLOOR	24.975	658.97	1317.95	132	39.54	0.9
EIGHTH FLOOR	38.475	658.97	1317.95	132	39.54	0.9
12TH FLOOR	56.100	523.17	1182.15	118	35.46	0.9
15TH FLOOR	64.600	658.97	1317.95	132	39.54	0.9
Service FLOOR	86.100	658.97	1317.95	132	39.54	0.9

TYPICAL REFUGE FLOOR		
S.NO	FLOOR	FLOOR LEVEL
1.	FIFTH FLOOR	+24.600 M
2.	EIGHTH FLOOR	+38.100 M
3.	FOURTEEN FLOOR	+65.100 M
4.	SEVENTEEN FLOOR	+79.600 M

TYPICAL REFUGE FLOOR SANITARY FIXTURE CALCULATION				
TOTAL COVERED AREA		:	658.97 SQ.M.	
TOTAL POPULATION @ 10 SQ.MT/PERSON		:	66	
(REFER Clause 4.3 & 4.4.2.1, Table 3 OCCUPANT LOAD (AS PER NBC 2016-PART-08 BUILDING SERVICES))				
MALE @1/2 OF VISITOR'S POPULATION		:	33	
FEMALE @1/2 OF VISITOR'S POPULATION		:	33	

SANITARY FIXTURE CALCULATION				
VISITOR		PROVIDED		
FIXTURE	REQUIRED	MALE	FEMALE	
WC	2	3	2	3
WB	2	3	2	3
URINAL	1	-	2	

(REFER Clause 4.2.5.1, Table 1 OFFICE BUILDING (AS PER NBC 2016-PART-08 BUILDING SERVICES))

FAR				
S.NO.	NO.s	Length(in mm)	Breadth(in mm)	Area(in sqm)
ADDITION				
A	1	56000	17600	985.60
TOTAL AREA(A)				
SUBTRACTION				
S.NO.	NO.s	Length(in mm)	Breadth(in mm)	Area(in sqm)
1	1	600	6220	3.73
2	1	3900	6220	24.26
3	1	600	5300	3.18
4	4	2500	2550	25.50
5	1	3500	520	1.82
6	1	3350	520	1.74
7	1	450	5300	2.39
8	1	6600	3300	21.78
9	1	640	3300	2.11
10	1	900	670	0.60
11	1	2800	470	1.32
12	1	2700	1850	5.00
13	1	1325	2720	3.60
14	2	54000	1800	194.40
15	2	1000	17600	35.20
TOTAL SUBTRACTION (B)				326.83
C. FAR (A-B)				658.97

AREA FREE FROM FAR				
S.NO.	NO.s	Length(in mm)	Breadth(in mm)	Area(in sqm)
2	1	3900	13600	24.26
8	1	6600	3300	21.78
14	1	54000	1800	97.20
15	2	1000	17600	35.20
16	1	11670	1800	21.01
17	1	30450	1800	54.81
18	1	11480	1800	20.66
D. TOTAL NON FAR				274.92

TOTAL Covered Area (C +D)				
933.89				

CARPET AREA				
S.NO.	NO.s	Length(in mm)	Breadth(in mm)	Area(in sqm)
1	1	15185	13600	206.52
2	1	2990	7180	21.47
3	1	8525	5180	44.16
4	1	10570	5180	54.75
5	1	3140	7180	22.55
6	1	12985	13600	176.80
CARPET AREA				526.04

TYPICAL REFUGE FLOOR				
SL.NO.	TAG.	Width	Height	REMARKS
INTERNAL DOOR SCHEDULE				
1	ID3	750	2450	TOILET
2	ID6	825	2450	TOILET
3	ID7	1650	2450	OFFICE
FIRE DOOR SCHEDULE (2HR FIRE RATED)				
1	FD1	1250	2450	STAIRCASE, LIFT LOBBY
2	FD2	1500	2450	STAIRCASE, LIFT LOBBY
3	FD3	2000	2450	STAIRCASE, LIFT LOBBY
SERVICE DOOR SCHEDULE				
1	TD1	1000	2450	ELECTRICAL SHAFT
2	TD2	600	2450	FHC
3				
WINDOW SCHEDULE				
1	WT01	3000	3750	LIFT LOBBY
2	WT02	1800	3750	OFFICE
3	WT03	8525	3750	OFFICE
4	WT04	10625	3750	OFFICE
GLAZING SCHEDULE				
1	GLT01	1770	3750	OFFICE
2	GLT02	10715	3750	OFFICE
3	GLT02A	9585	3750	OFFICE
4	GLT02	5150	3750	OFFICE
5	GLT02	7050	3750	OFFICE
6	GLT02	10715	3750	OFFICE
7	GLT02	4400	3750	OFFICE
8	GLT02	9785	3750	OFFICE


Authority Signatory

For ESSEL INFRA LLP
Designated Partner/Author Sign.

LEGEND FOR PLUMBING	
10	150x150mm CUTOUT IN SLAB FOR WC/UT & FT
11	1000 C.I. SOIL & VENT PIPE
12	1500 C.I. SOIL & VENT PIPE
13	1000 C.I. WASTE & VENT PIPE
14	1500 C.I. WASTE & VENT PIPE
15	750 C.I. ANTI-SYPHONIC PIPE
16	DOMESTIC WATER SUPPLY FOR 25th to 15th FLOOR DOWN TAKE PIPE
17	FLUSHING WATER SUPPLY FOR 25th to 15th FLOOR DOWN TAKE PIPE
18	DOMESTIC WATER SUPPLY FOR 14th to 7th FLOOR DOWN TAKE PIPE
19	FLUSHING WATER SUPPLY FOR 14th to 7th FLOOR DOWN TAKE PIPE
20	DOMESTIC WATER SUPPLY FOR 6th to GROUND FLOOR DOWN TAKE PIPE
21	FLUSHING WATER SUPPLY FOR 6th to GROUND FLOOR DOWN TAKE PIPE
22	600 DOMESTIC WATER SUPPLY O.H. TANK FILLING PIPE
23	500 FLUSHING WATER SUPPLY O.H. TANK FILLING PIPE
24	100/ODUPVC RAIN WATER PIPE FOR TERRACE
25	110/ODUPVC RAIN WATER PIPE FOR TERRACE
26	D.W.S. FLUSHING WATER SUPPLY
27	F.W.S. FLUSHING WATER SUPPLY
28	VALVE
29	FLOOR TRAP
30	FLOOR DRAIN
31	CLEAN OUT PLUG
32	FLOOR CLEAN OUT

PLUMBING NOTES:-
* W.C. TO HORIZONTAL SOIL PIPE 1000 SOIL PIPE
* F.T. TO HORIZONTAL WASTE PIPE 1000 WASTE PIPE
* U.T. TO HORIZONTAL SOIL PIPE 1000 SOIL PIPE
* FLOOR DRAIN TO FLOOR TRAP 500 WASTE PIPE
* WASH BASIN TO FLOOR TRAP 300 WASTE PIPE
* SINK TO FLOOR TRAP 400 WASTE PIPE

- NOTE:
1. THE BUILDING WILL BE MECHANICALLY VENTILATED.
2. SPRINKLERS ARE INCORPORATED AS/NBC.

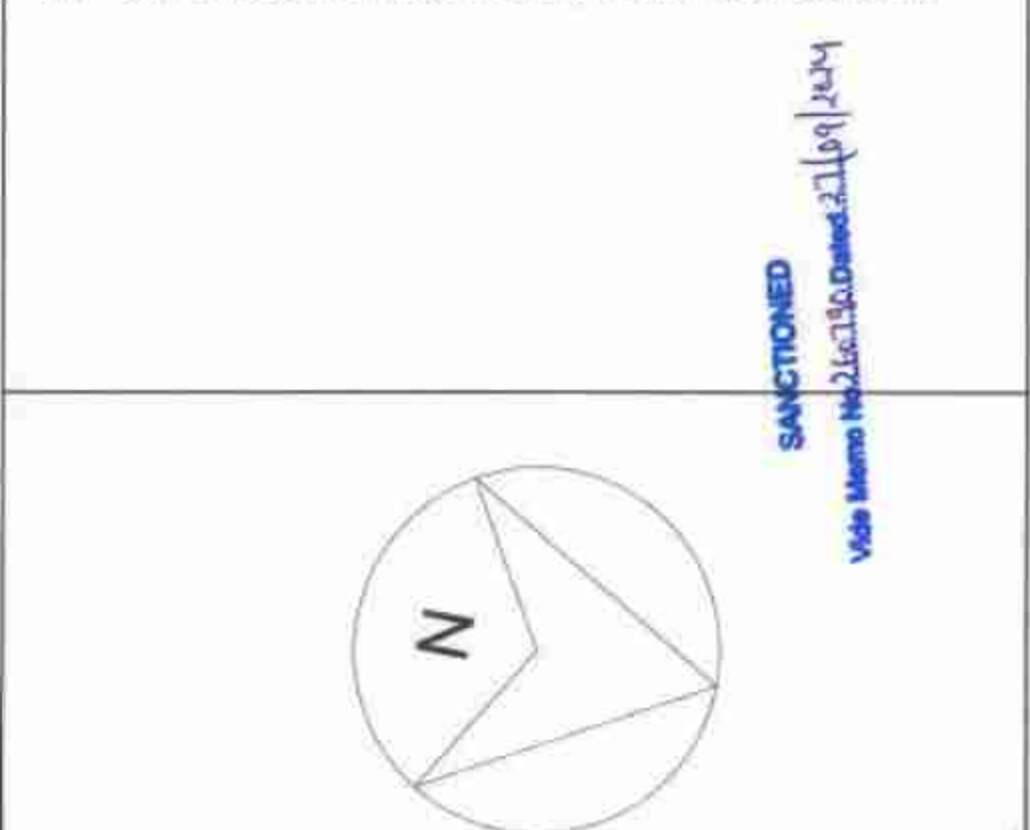

Architects :

OWNER SIGN

ARCHITECT SIGN

For ESSEL INFRA LLP
Designated Partner/Author Sign.

Clients:
ESSEL INFRA LLP


Project Title :
COMMERCIAL COMPLEX SITE C2 IN SHOPPING CENTRE
SECTOR -43, GURUGRAM.

Drawing Title :
SUBMISSION DRAWINGS

TYPICAL REFUGE FLOOR
(5th, 8th, 12th & 15th)


Scale :
Date : JUN-2024
Drawn By : P.K.
Checked By : A.S.
Sheet Size : A1

Drawing No : C2_FP-06

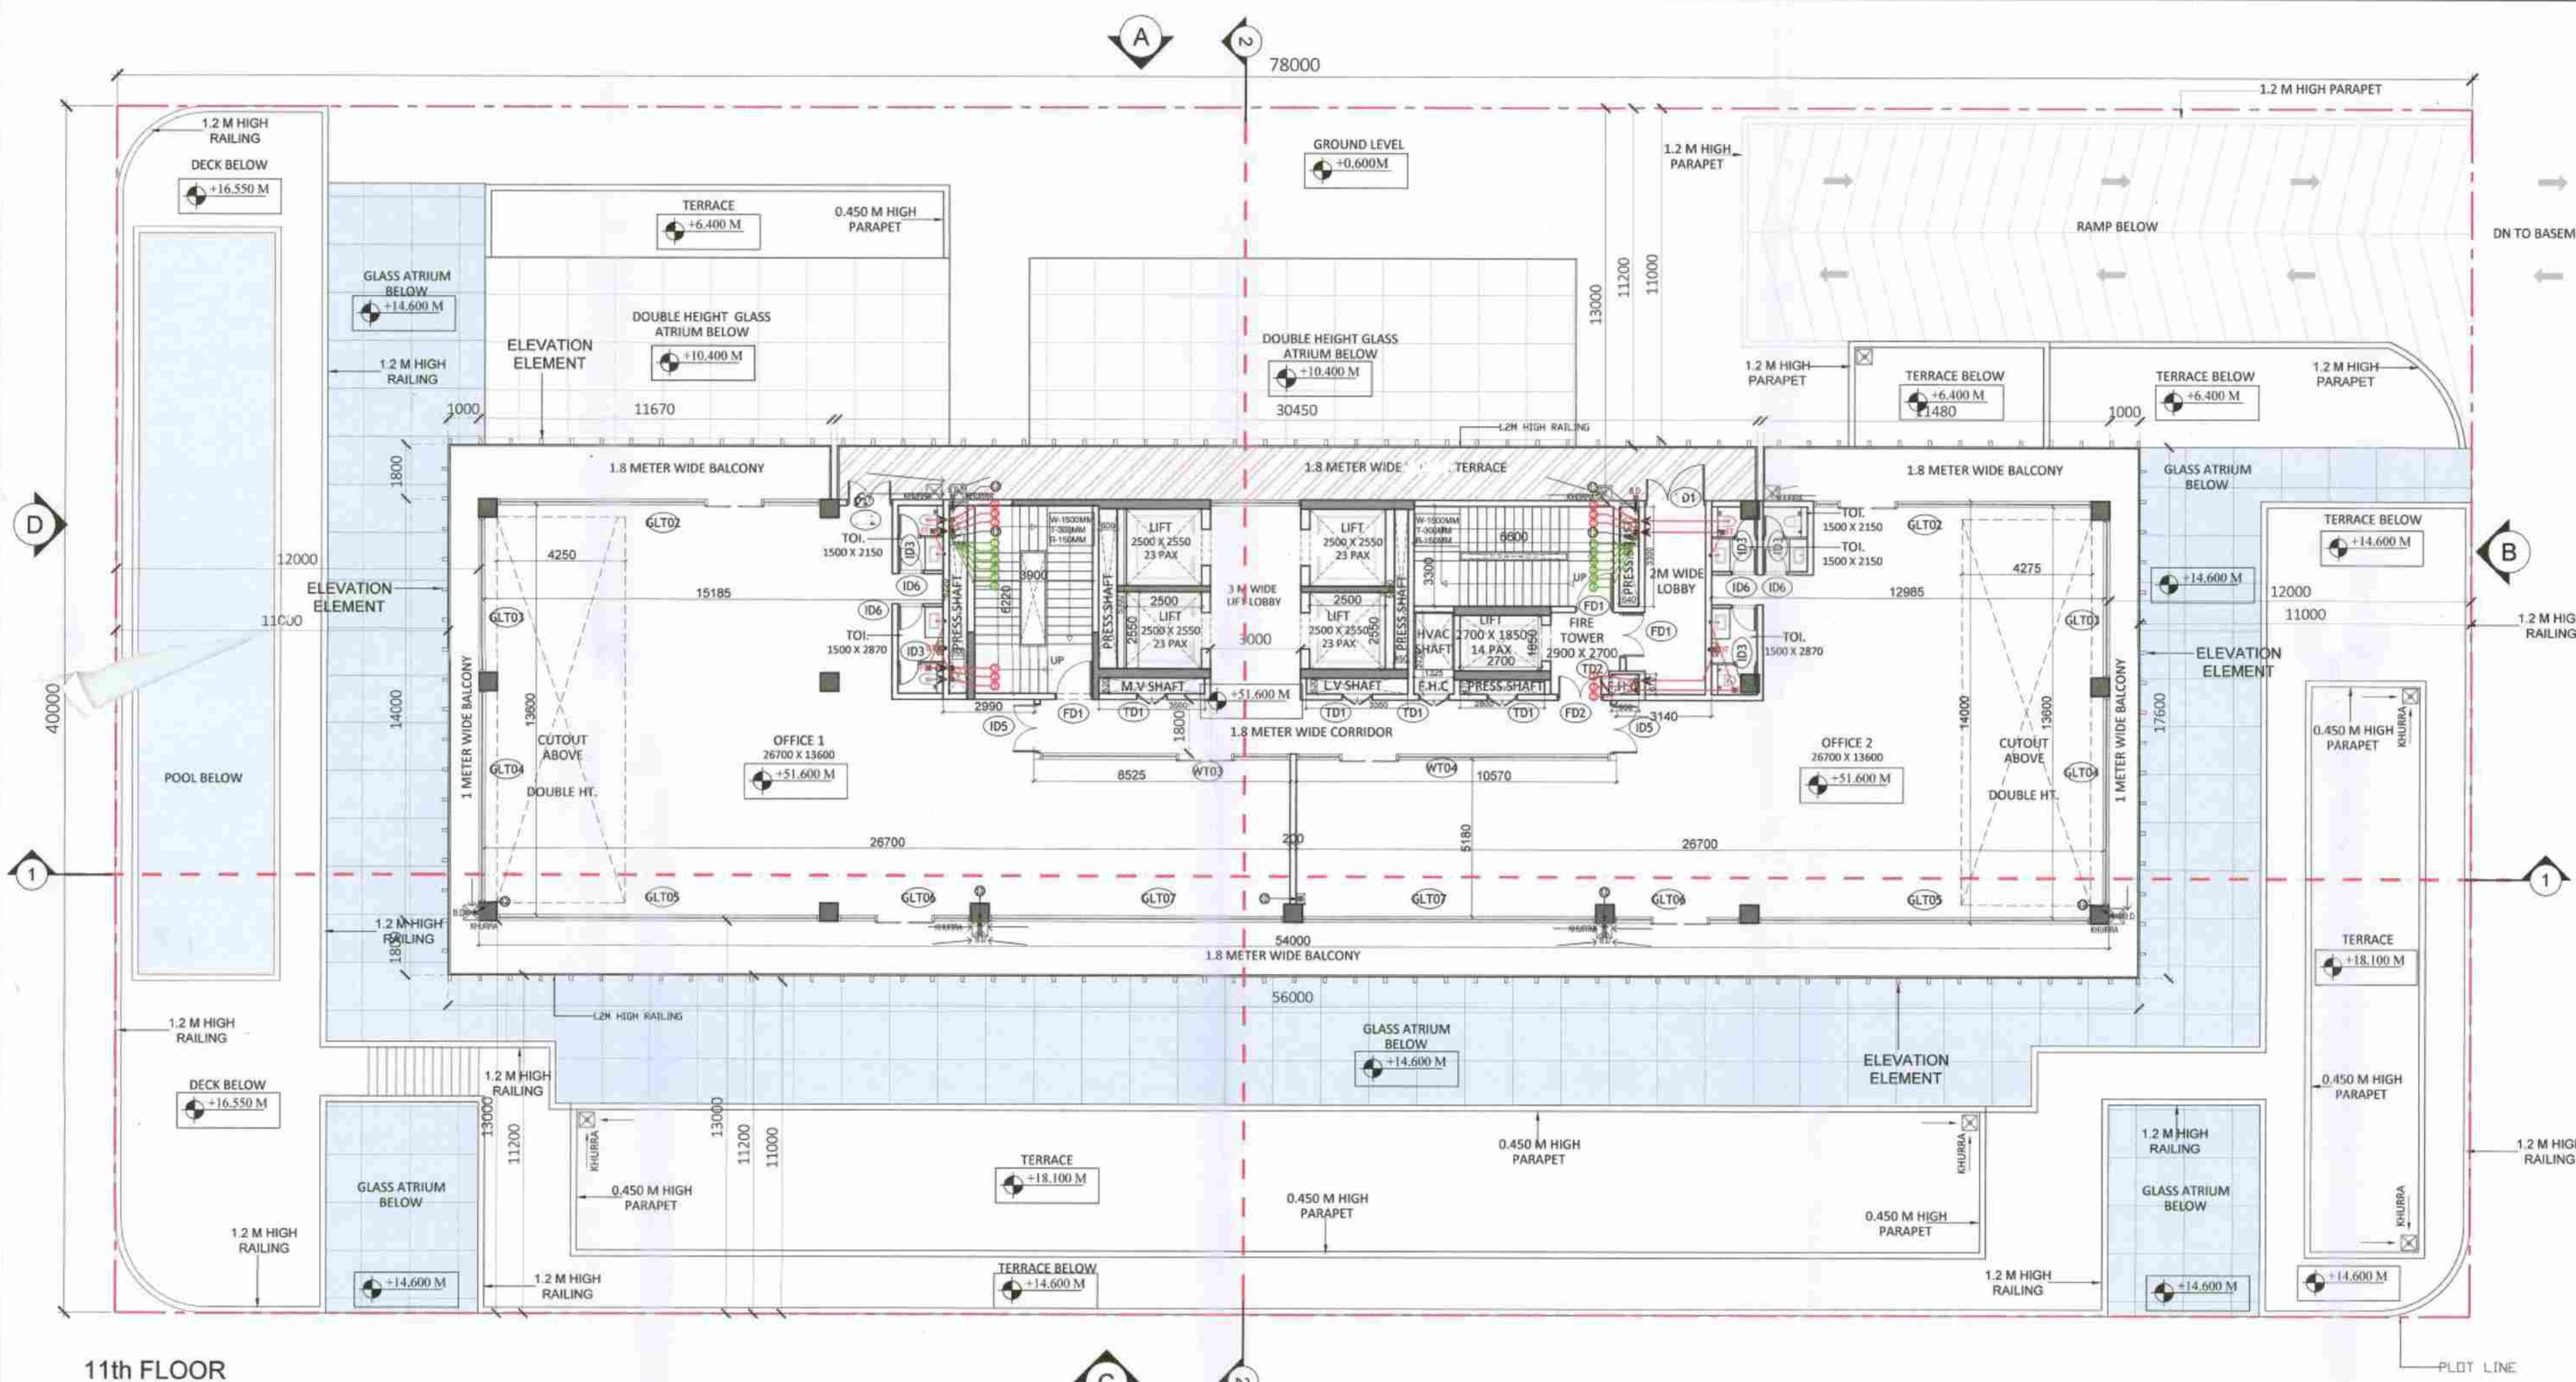


11th FLOOR
+51.600 M LVL


Note: Refuge Floor given At 12th Floor Level of 11th Floor.

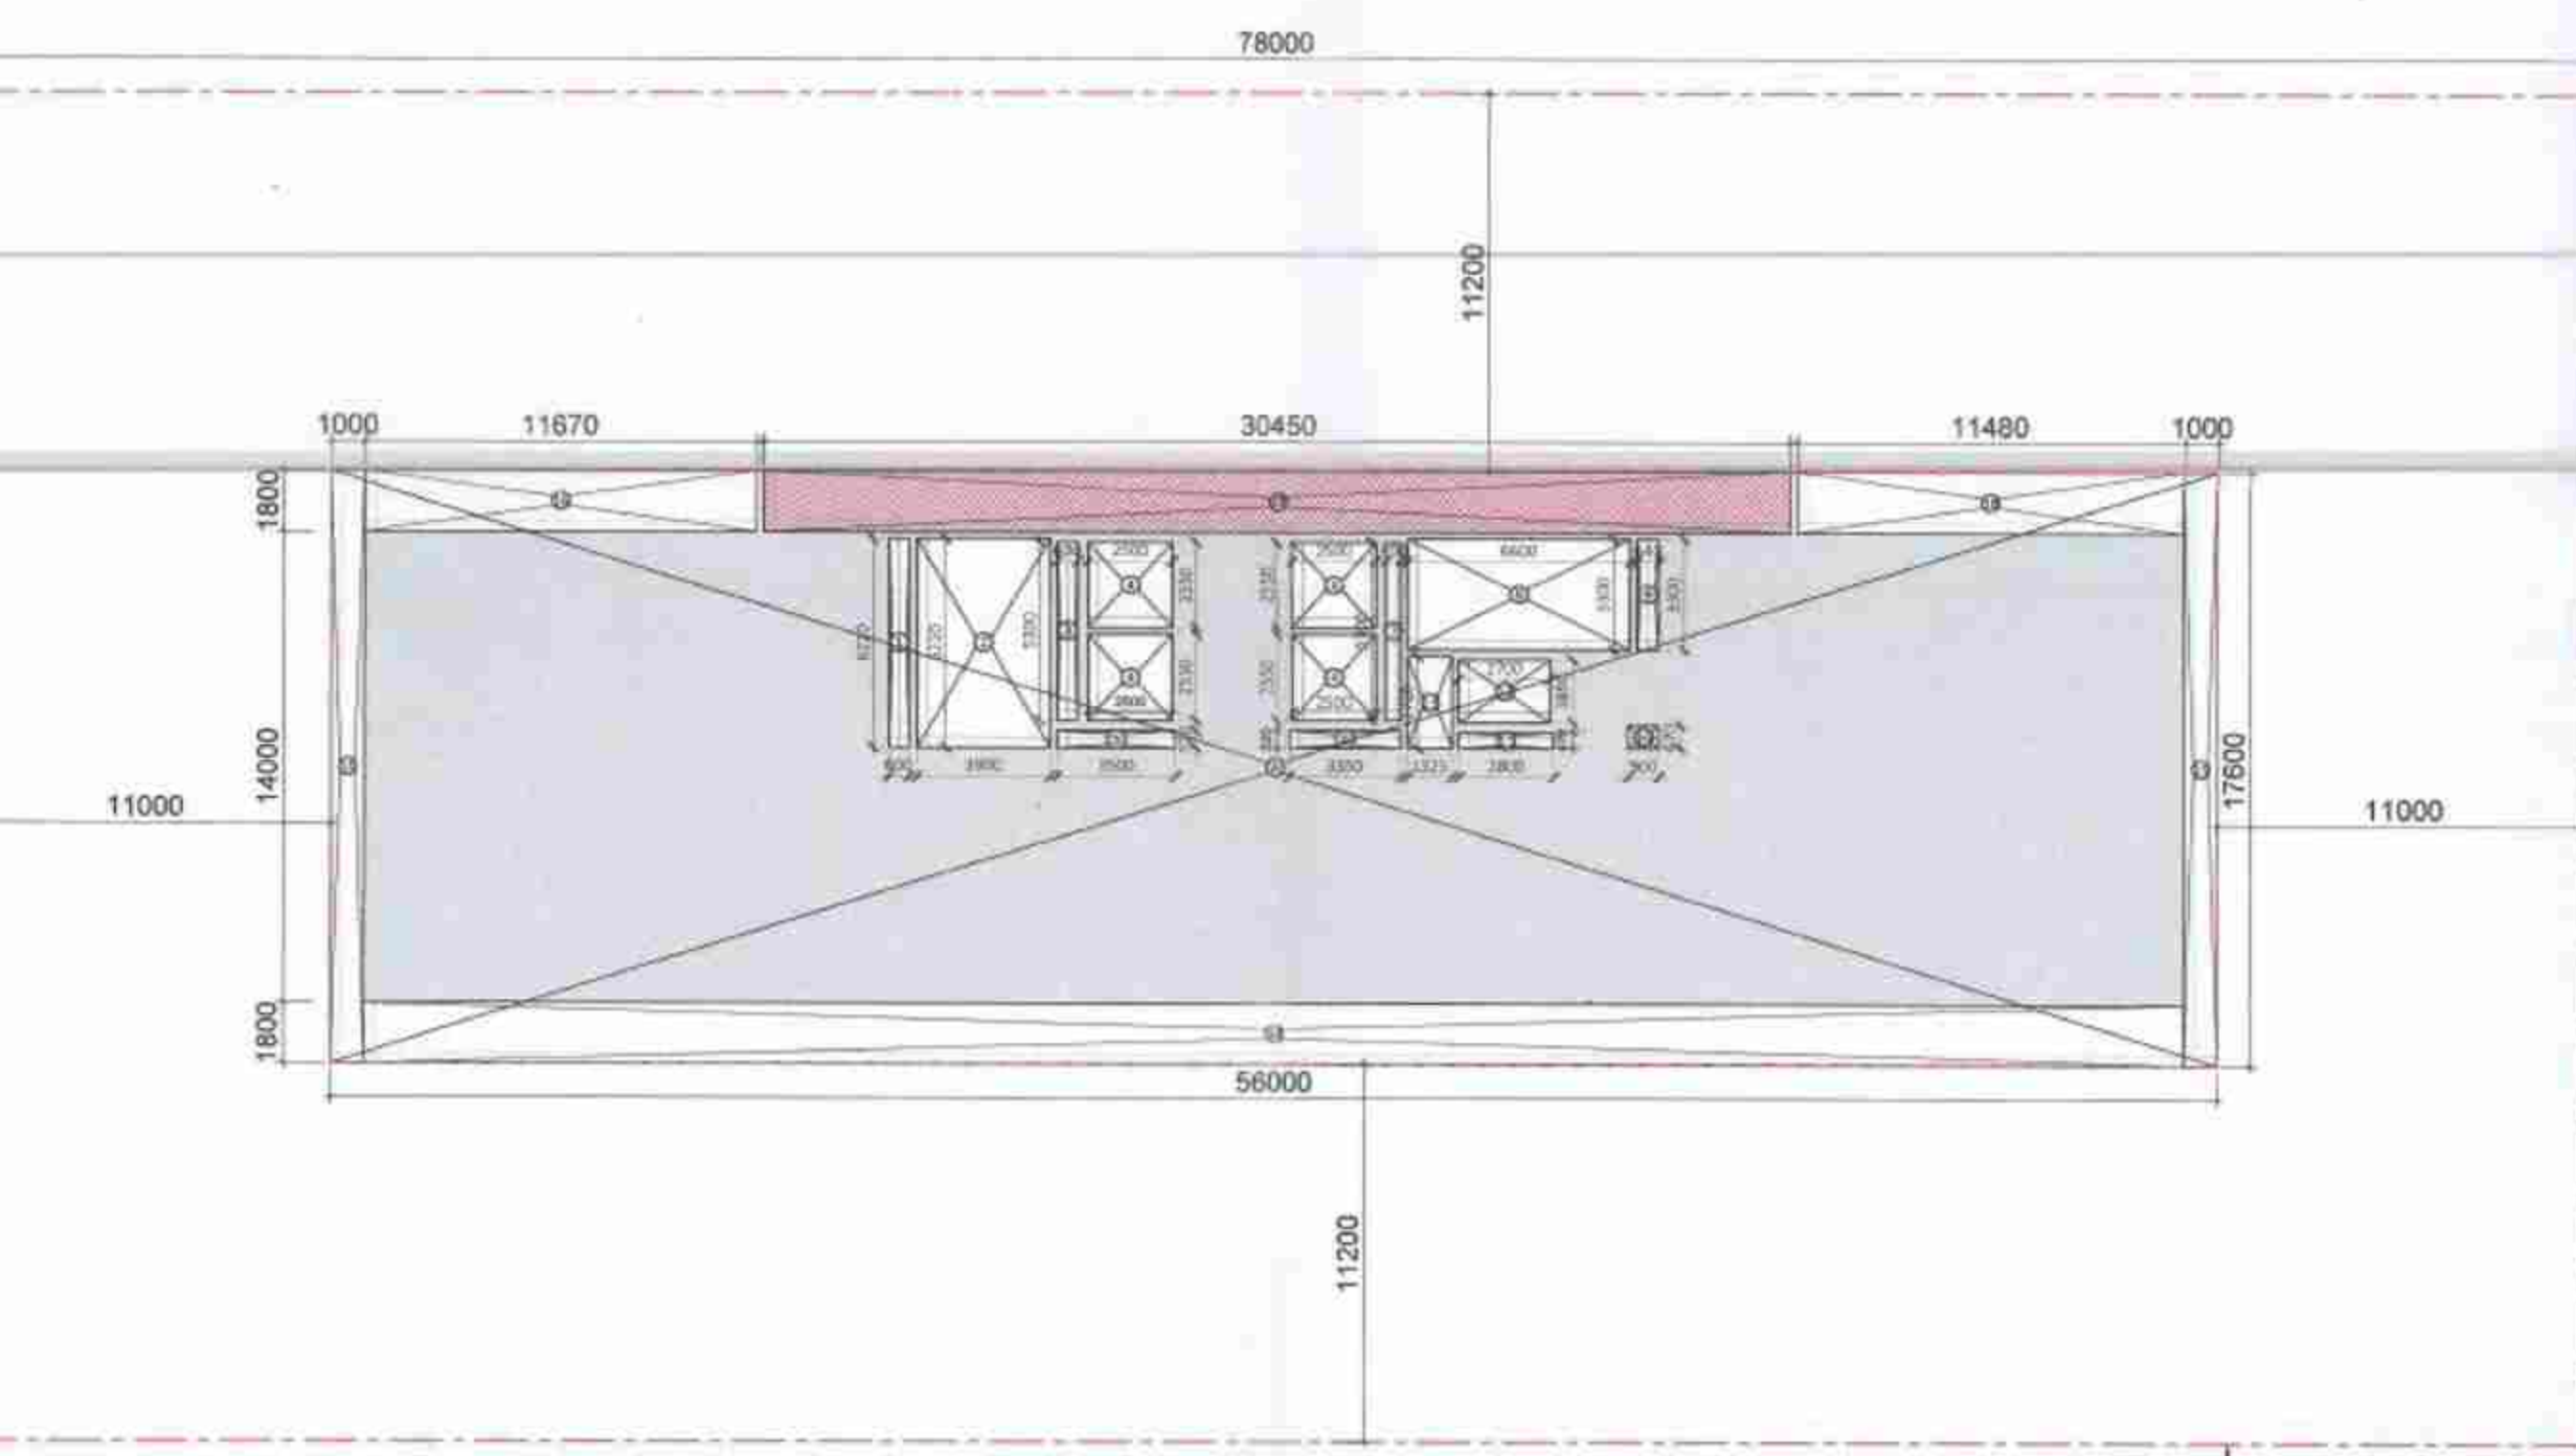

AREA DIAGRAM (1:300)

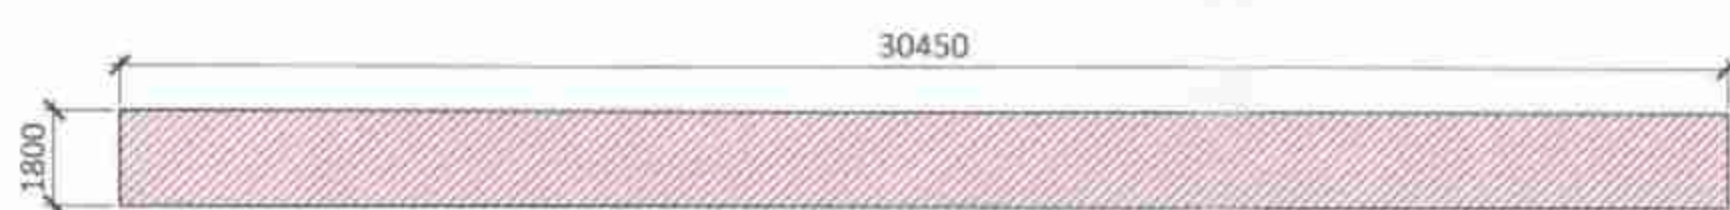

REFUGE AREA DIAGRAM (1:200)

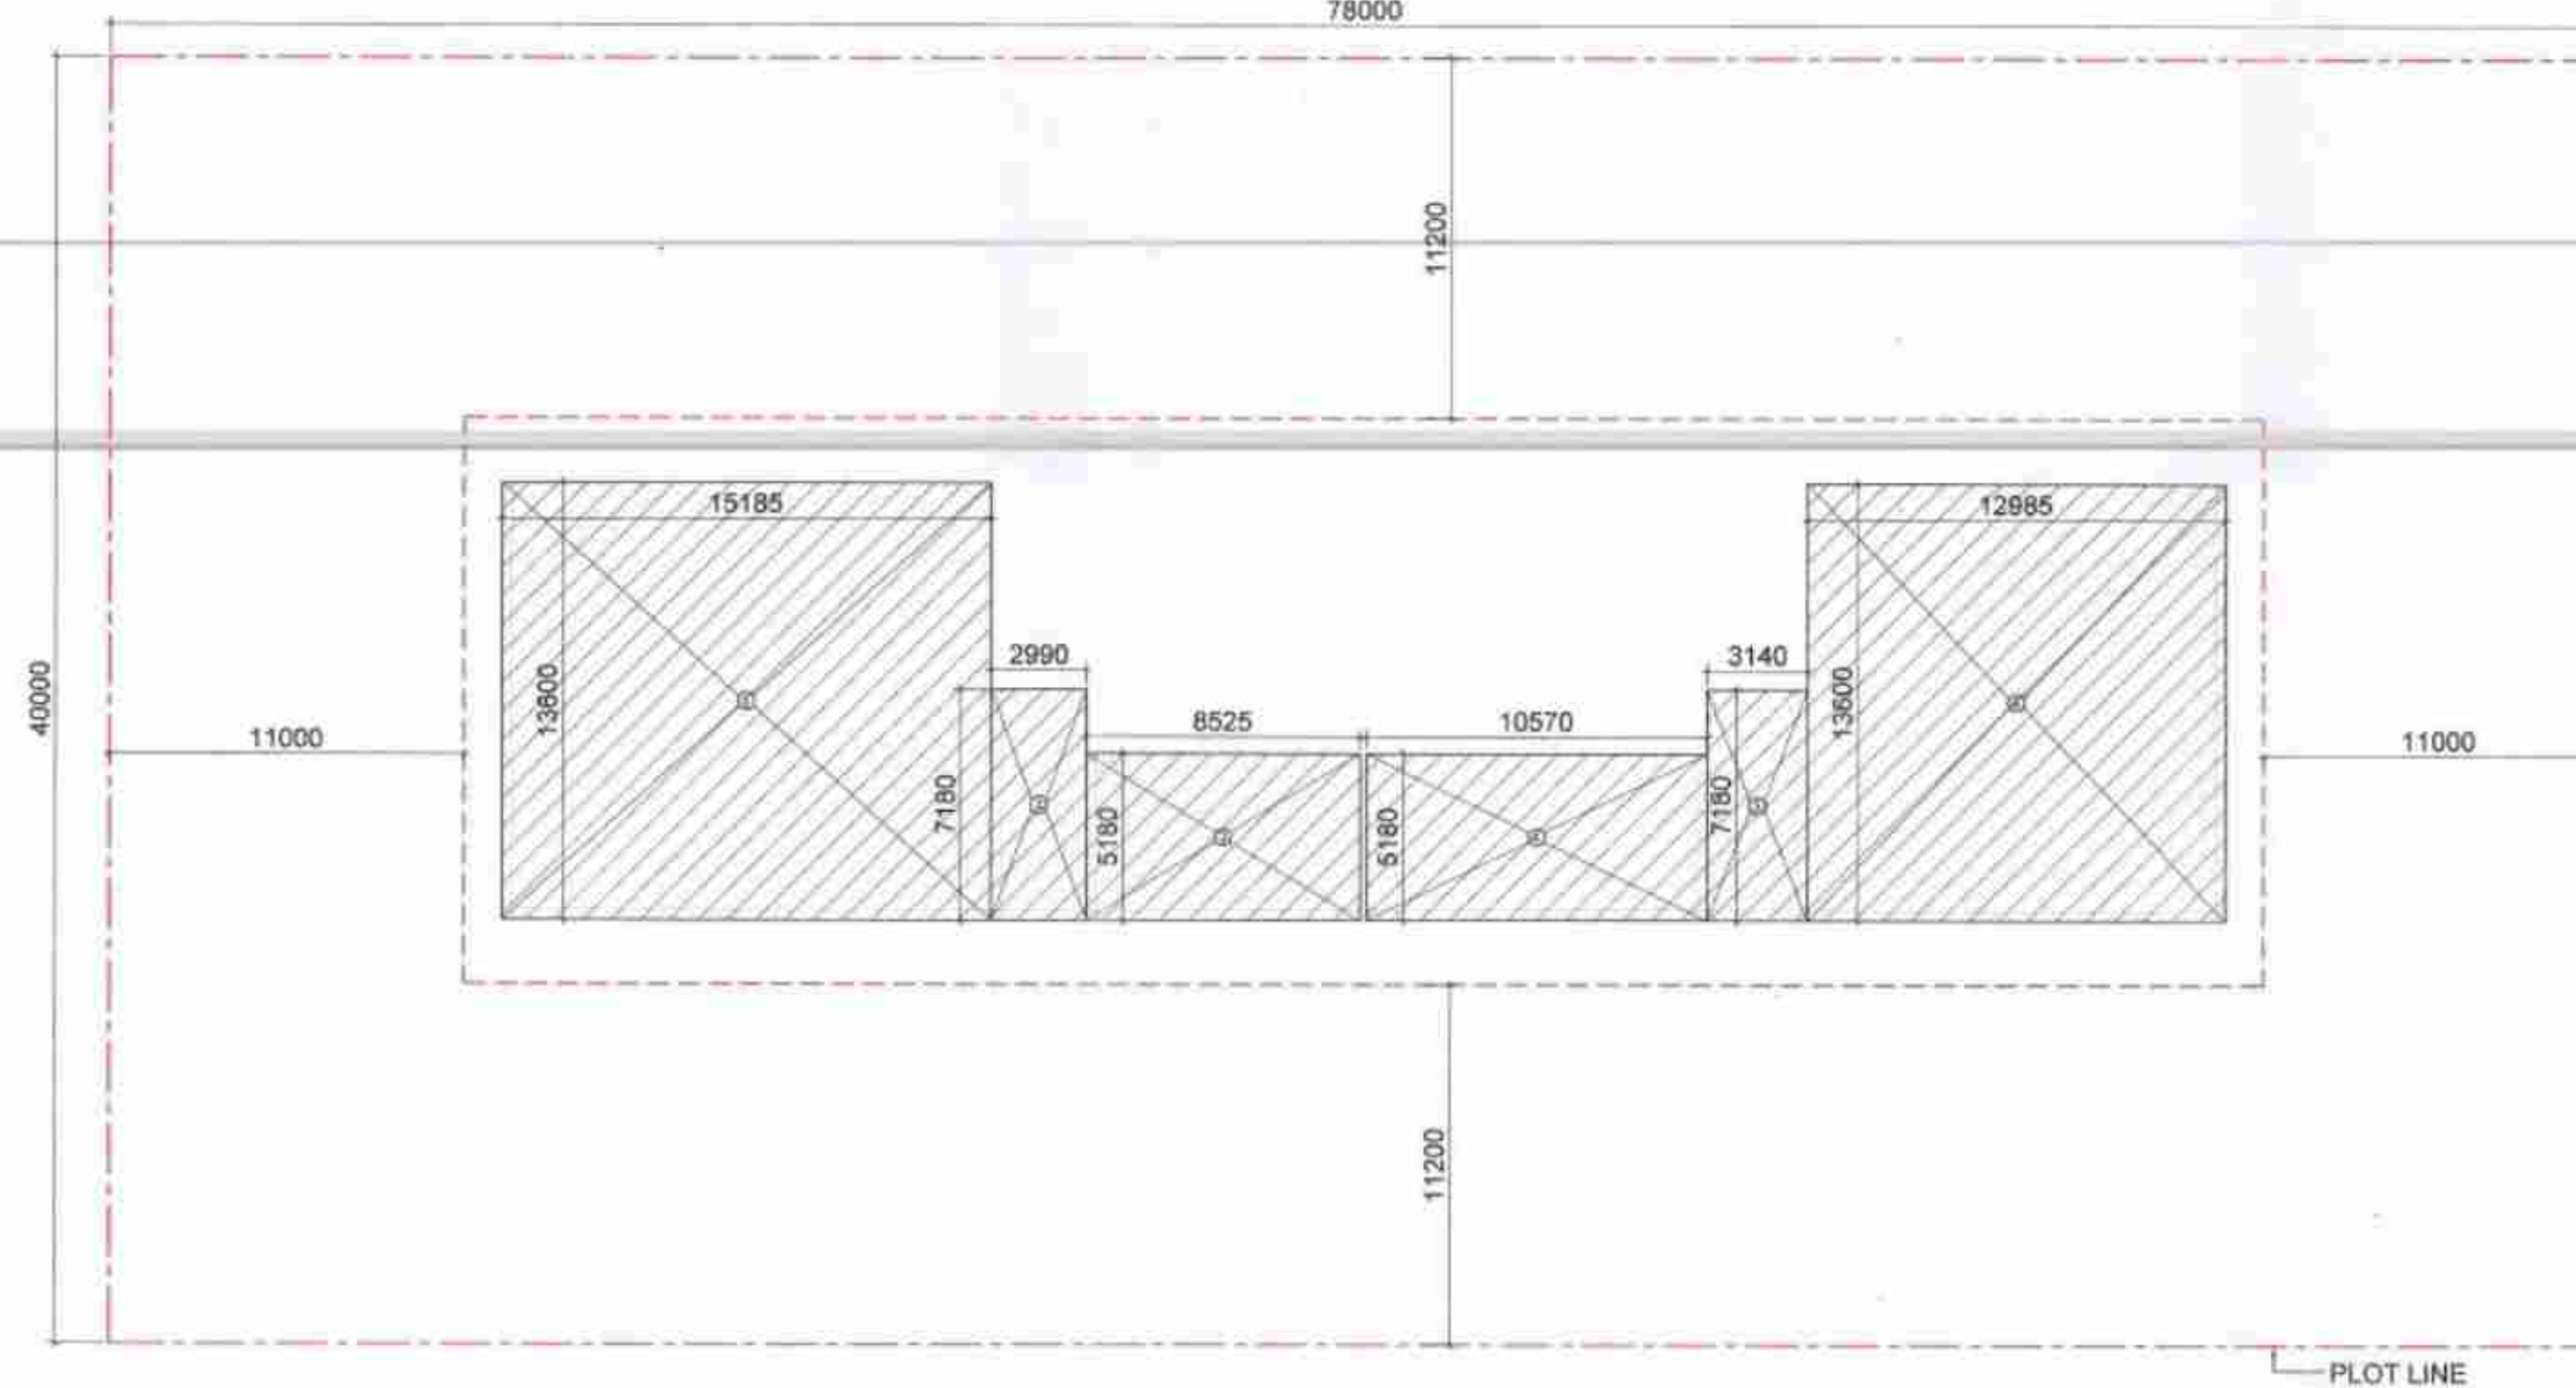

CARPET AREA DIAGRAM (1:300)

REFUGE AREA CALCULATION			
S.NO.	NO.s	Length(in mm)	Breadth(in mm)
17	1	30450	1800
TOTAL AREA			54.81

REFUGE AREA CALCULATION							
FLOOR	HT (in M)	Area of two consecutive floors (sqm)	Total area (sqm)	Occupant Load @ 10sqm/PERSON	Area equi. @ 0.3sqm/PERSON (sqm)	Additional area for wheelchair requirement (sqm)	Area provided (sqm)
FIFTH FLOOR	24.975	658.97	1317.95	132	39.54	0.9	54.81
EIGHTH FLOOR	38.475	658.97	1317.95	132	39.54	0.9	54.81
TWELFTH FLOOR	56.160	658.97	1317.95	132	39.54	0.9	54.81
THIRTEENTH FLOOR	69.660	658.97	1317.95	132	39.54	0.9	54.81
SERVICES FLOOR	85.160	658.97	1317.95	132	39.54	0.9	54.81

FAR				
S.NO.	NO.s	Length(in mm)	Breadth(in mm)	Area(in sqm)
ADDITION				
A	1	56000	17600	985.60
SUBTRACTION				
S.NO.	NO.s	Length(in mm)	Breadth(in mm)	Area(in sqm)
1	1	600	6220	3.73
2	1	3900	6220	24.26
3	1	600	5300	3.18
4	4	2500	2550	25.50
5	1	3500	520	1.82
6	1	3500	520	1.74
7	1	450	5300	2.39
8	1	6600	3300	21.78
9	1	640	3300	2.11
10	1	900	670	0.60
11	1	2800	470	1.32
12	1	2700	1850	5.00
13	1	1325	2720	3.60
14	2	54000	1800	194.40
15	2	1000	17600	35.20
TOTAL SUBTRACTION (B)				326.63
C. FAR (A-B)				658.97

AREA FREE FROM FAR				
S.NO.	NO.s	Length(in mm)	Breadth(in mm)	Area(in sqm)
2	1	3900	6220	24.26
8	1	6600	3300	21.78
14	1	54000	1800	97.20
15	2	1000	17600	35.20
16	1	1070	1800	21.01
17	1	30450	1800	54.81
18	1	11480	1800	20.66
D. TOTAL NON FAR				274.92

TOTAL Covered Area (C + D) 933.89

CARPET AREA				
S.NO.	NO.s	Length(in mm)	Breadth(in mm)	Area(in sqm)
1	1	15185	13600	206.52
2	1	2990	7180	21.47
3	1	8525	5180	44.16
4	1	10570	5180	54.75
5	1	3140	7180	22.55
65	1	12685	13600	176.60
CARPET AREA				526.04

TYPICAL REFUGE FLOOR				
S.NO.	TAG.	Width	Height	REMARKS
INTERNAL DOOR SCHEDULE				
1	ID3	750	2450	TOILET
2	ID6	825	2450	TOILET
FIRE DOOR SCHEDULE (2HR FIRE RATED)				
1	FD1	1250	2450	STAIRCASE, LIFT LOBBY
2	FD2	1500	2450	STAIRCASE, LIFT LOBBY
3	FD3	2000	2450	STAIRCASE, LIFT LOBBY
SERVICE DOOR SCHEDULE				
1	TD1	1000	2450	ELECTRICAL SHAFT
2	TD2	600	2450	FHC
3				
WINDOW SCHEDULE				
1	WT01	3000	3750	LIFT LOBBY
2	WT02	1800	3750	OFFICE
3	WT03	8525	3750	OFFICE
4	WT04	10625	3750	OFFICE
GLAZING SCHEDULE				
1	GLT01	1770	3750	OFFICE
2	GLT02	10715	3750	OFFICE
3	GLT02A	9585	3750	OFFICE
4	GLT02	5150	3750	OFFICE
5	GLT02	7050	3750	OFFICE
6	GLT02	10715	3750	OFFICE
7	GLT02	4400	3750	OFFICE
8	GLT02	9785	3750	OFFICE

TYPICAL REFUGE FLOOR SANITARY FIXTURE CALCULATION				
TOTAL COVERED AREA				
TOTAL POPULATION @ 10 SQ.M/PERSON				658.97 SQ.M.
(REFER Clause 4.3 & 4.4.2.1, Table 3 OCCUPANT LOAD (AS PER NBC 2016-PART-08 BUILDING SERVICES))				66
MALE @1/2 OF VISITORS POPULATION				33
FEMALE @1/2 OF VISITORS POPULATION				33
SANITARY FIXTURE CALCULATION				
FIXTURE		REQUIRED		PROVIDED
		MALE	FEMALE	
WC		2	3	3
WB		2	3	3
URINAL		1	-	2

(REFER Clause 4.2.5.1, Table 1 OFFICE BUILDING (AS PER NBC 2016-PART-08 BUILDING SERVICES))

Authority Signatory

For ESSEL INFRA LLP
Vikram Chandra Goyal
H.No. 7037, P.O. Gurugram

LEGEND FOR PLUMBING	
150x150mm CUTOUT IN SLAB FOR WC, UT & FT	
1500 C.I. SOIL & VENT PIPE	
1500 C.I. SOIL & VENT PIPE	
1500 C.I. WASTE & VENT PIPE	
1500 C.I. WASTE & VENT PIPE	
750 C.I. ANTI-SYPHONIC PIPE	
DOMESTIC WATER SUPPLY FOR 25th to 15th FLOOR DOWN TAKE PIPE	
FLUSHING WATER SUPPLY FOR 25th to 15th FLOOR DOWN TAKE PIPE	
DOMESTIC WATER SUPPLY FOR 14th to 7th FLOOR DOWN TAKE PIPE	
FLUSHING WATER SUPPLY FOR 14th to 7th FLOOR DOWN TAKE PIPE	
DOMESTIC WATER SUPPLY FOR 6th to GROUND FLOOR DOWN TAKE PIPE	
FLUSHING WATER SUPPLY FOR 6th to GROUND FLOOR DOWN TAKE PIPE	
500 DOMESTIC WATER SUPPLY O.H. TANK FILLING PIPE	
500 FLUSHING WATER SUPPLY O.H. TANK FILLING PIPE	
1500/OD/PVC RAIN WATER PIPE FOR TERRACE	
110/OD/PVC RAIN WATER PIPE FOR TERRACE	
DOMESTIC WATER SUPPLY	
FLUSHING WATER SUPPLY	
VALVE	
FLOOR TRAP	
FLOOR DRAIN	
CLEAN OUT PLUG	
FLOOR CLEAN OUT	

PLUMBING NOTES:
* W.C. TO HORIZONTAL SOIL PIPE 1500 SOIL PIPE
* F.T. TO HORIZONTAL WASTE PIPE 1500 WASTE PIPE
* U.T. TO HORIZONTAL SOIL PIPE 1500 SOIL PIPE
* FLOOR DRAIN TO FLOOR TRAP AND WASTE PIPE
* WASH BASIN TO FLOOR TRAP 300 WASTE PIPE
* SINK TO FLOOR TRAP 400 WASTE PIPE

NOTE:
1. THE BUILDING WILL BE MECHANICALLY VENTILATED.
2. SPRINKLERS ARE INCORPORATED AS/NBC.

Architects:

OWNER SIGN

ARCHITECT SIGN

For ESSEL INFRA LLP
Vikram Chandra Goyal
H.No. 7037, P.O. Gurugram

Clients:
ESSEL INFRA LLP


Project Title :
COMMERCIAL COMPLEX SITE C2 IN SHOPPING CENTRE
SECTOR - 43, GURUGRAM.

Drawing Title :
SUBMISSION DRAWINGS


11TH FLOOR

Scale :
Date : JUN-2024
Drawn By : P.K.
Checked By : A.S.
Sheet Size : A1


Drawing No : C2_FP-06

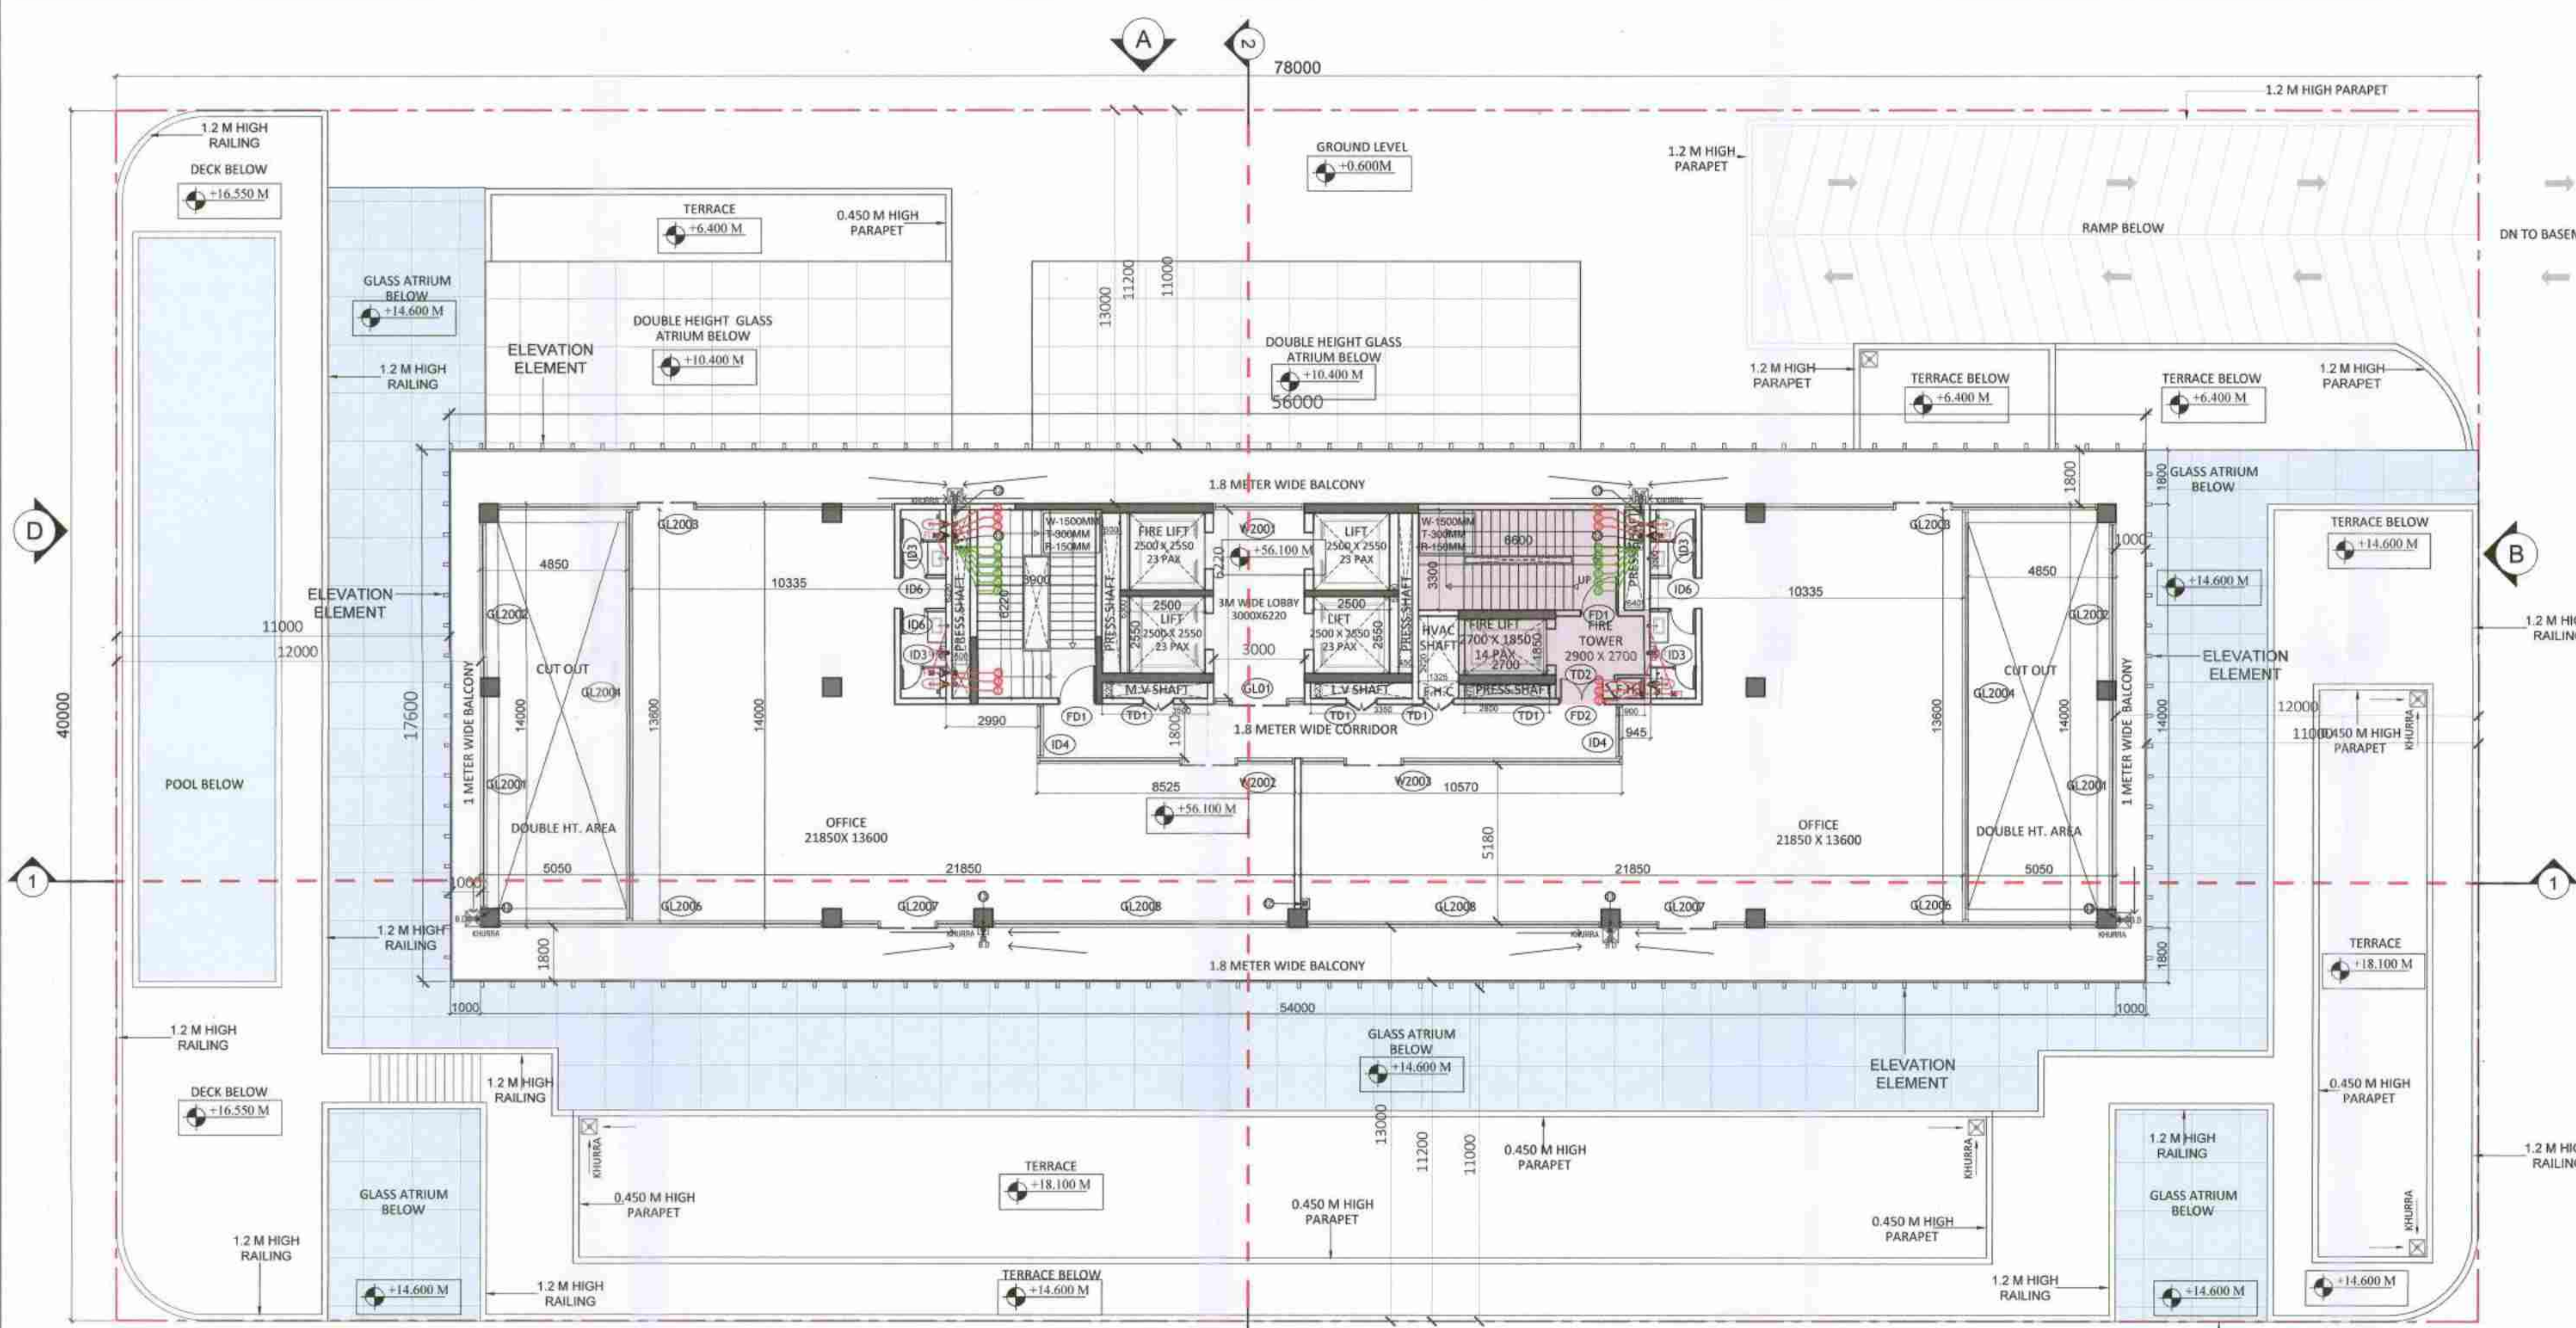

17. TH FLOOR PLAN (1:150) +79.600 M. LVL.
+88.600 M. LVL.

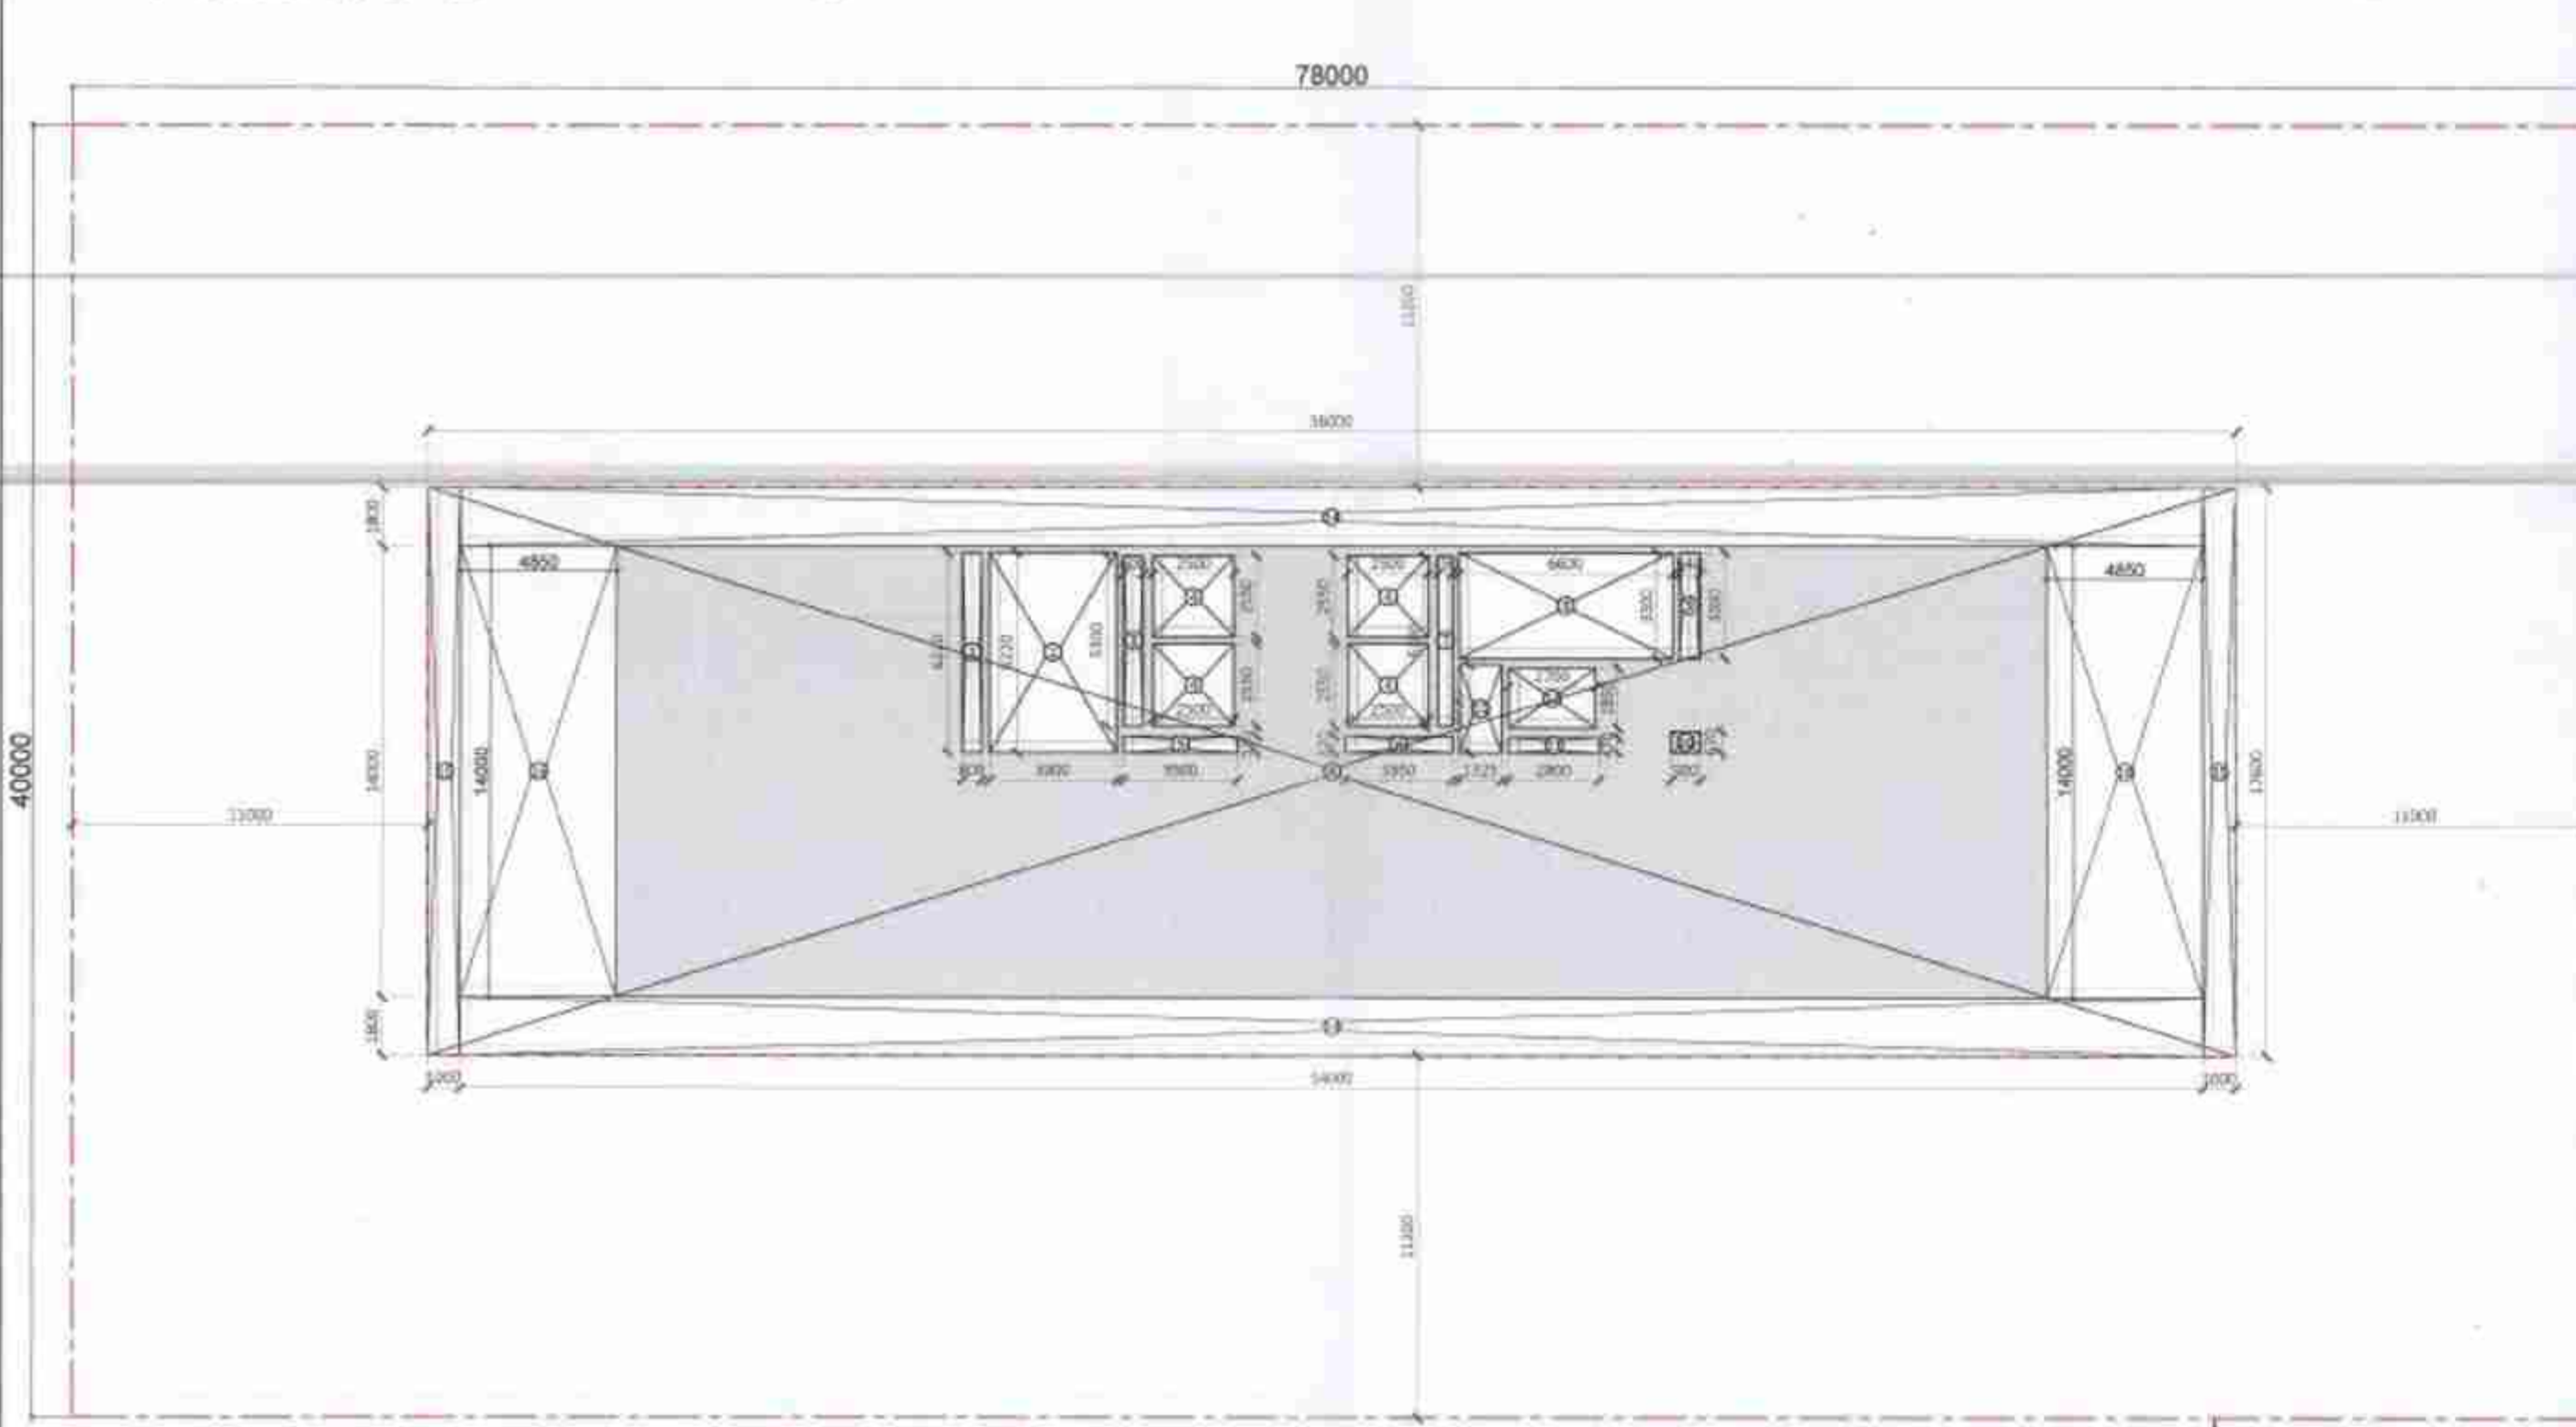

AREA DIAGRAM (1:300)

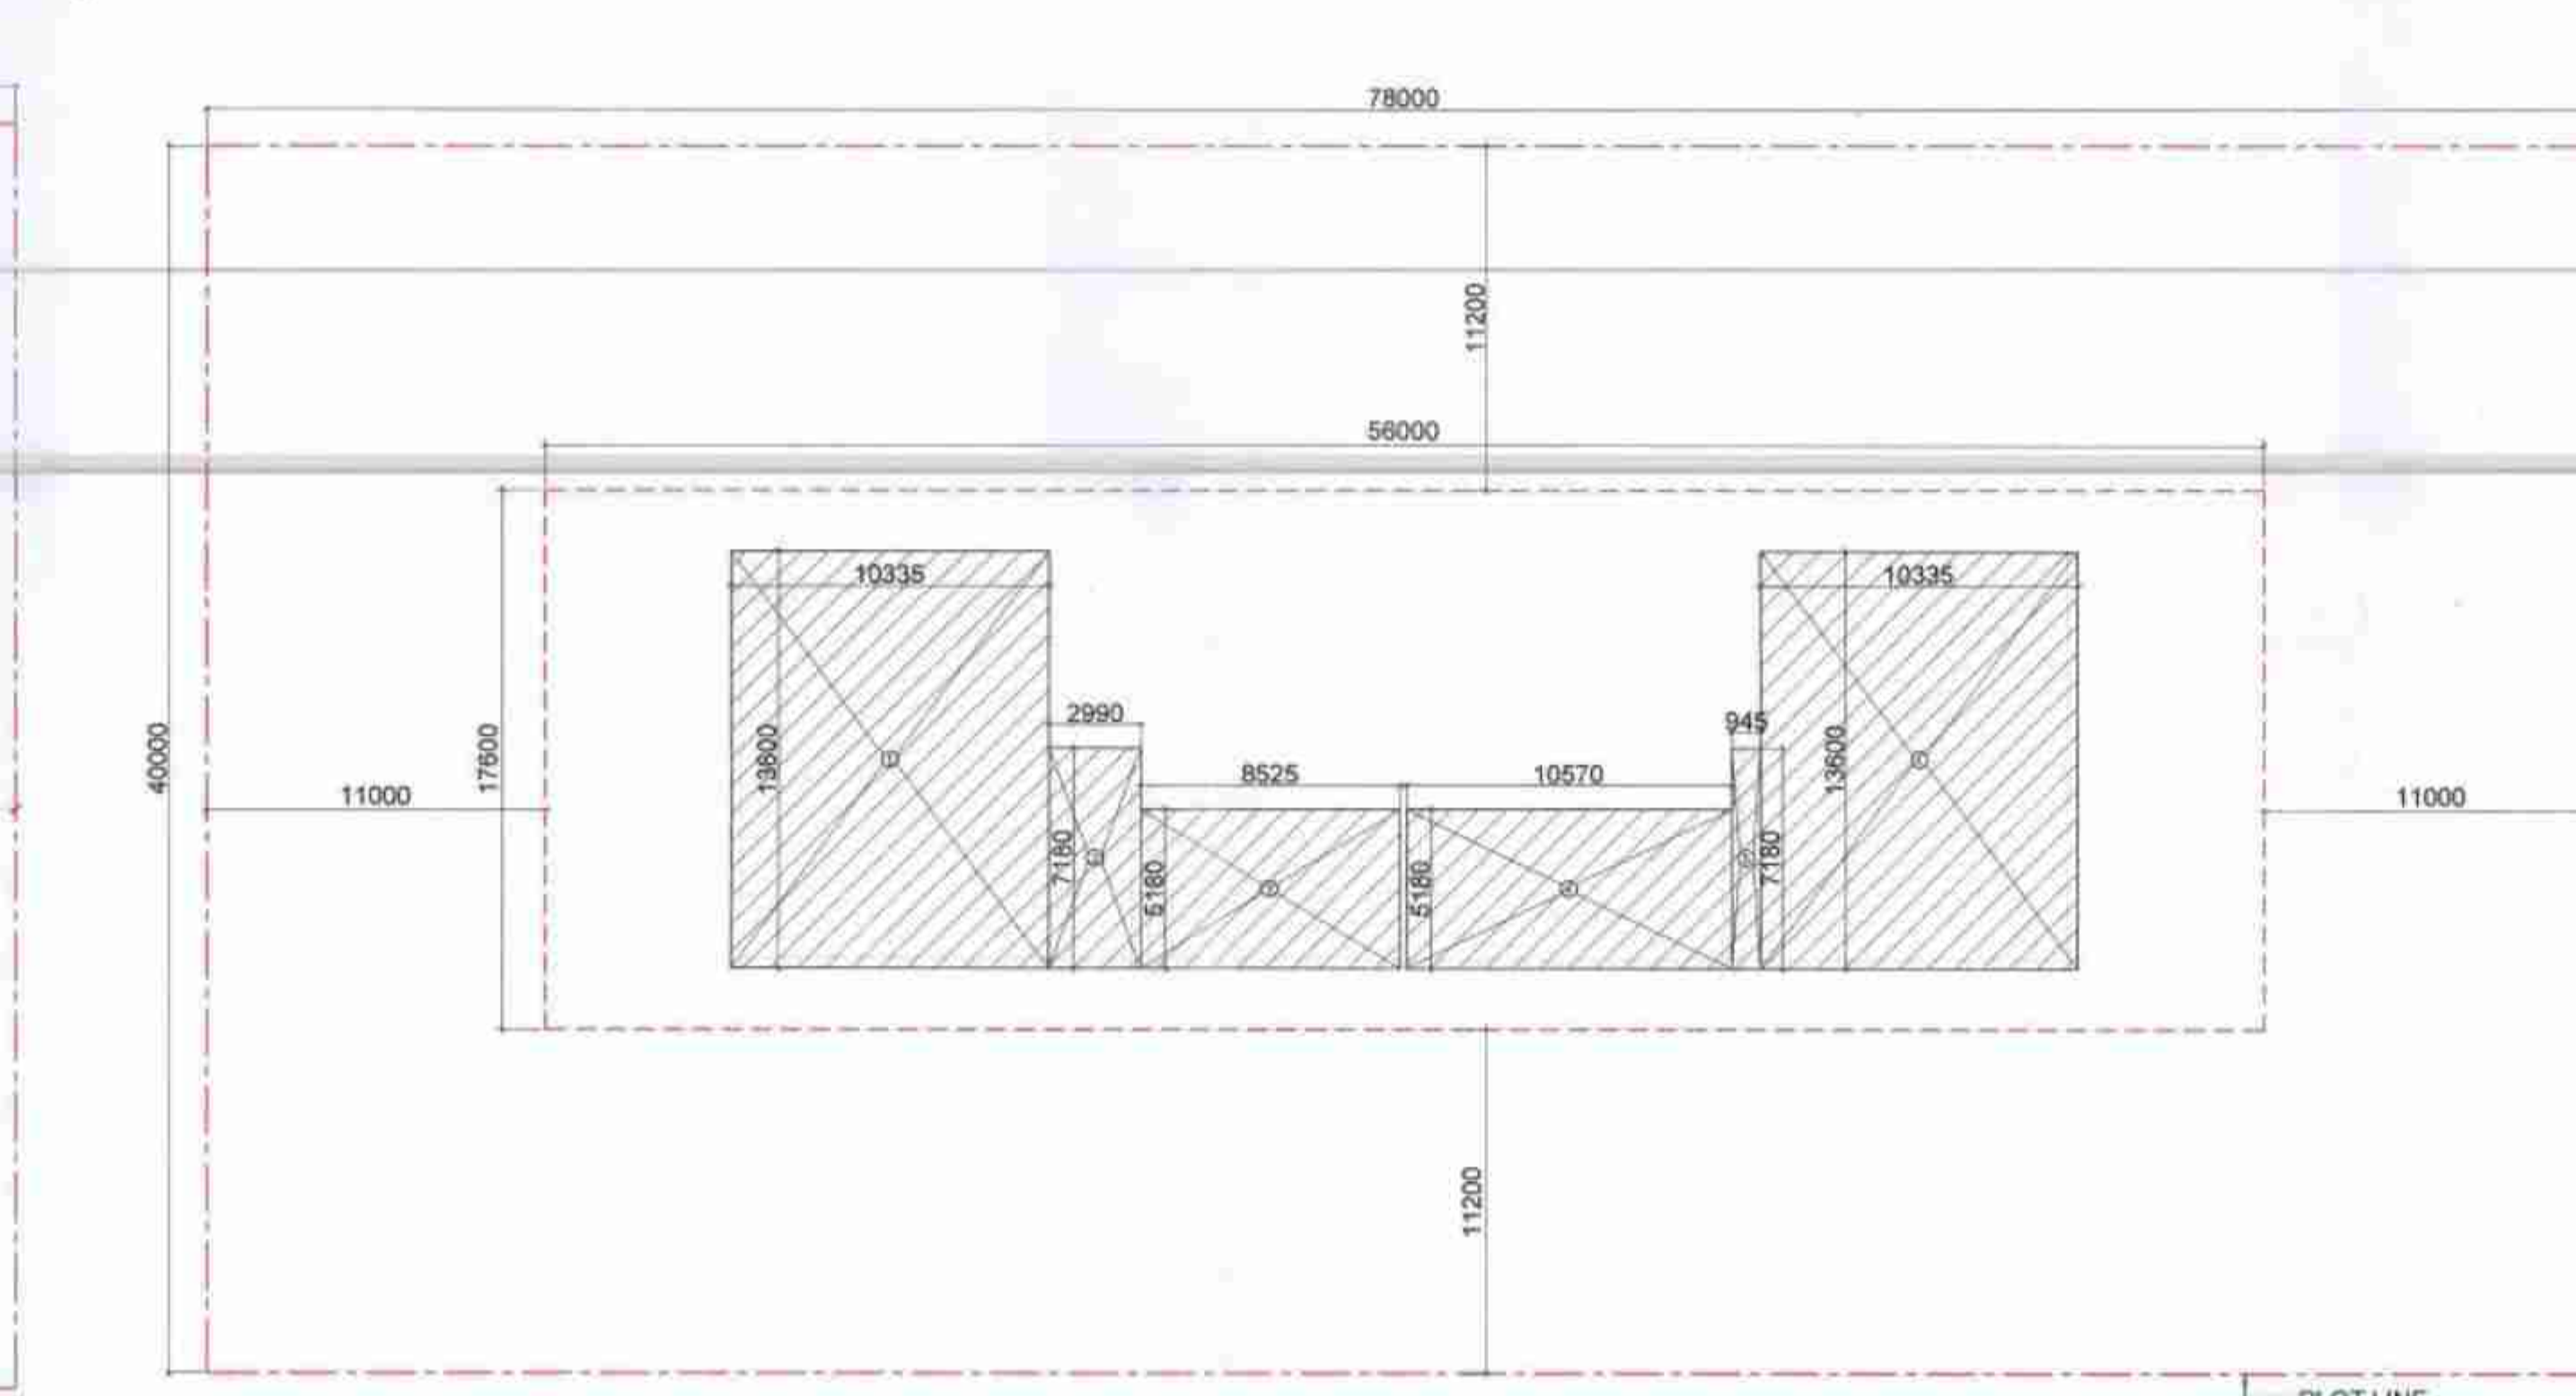

CARPET AREA DIAGRAM (1:300)

FAR				
S.NO.	NO.s	Length(in mm)	Breadth(in mm)	Area(in sqm)
ADDITION				
A	1	56000	17600	985.60
TOTAL AREA(A)				985.60
SUBTRACTION				
S.NO.	NO.s	Length(in mm)	Breadth(in mm)	Area(in sqm)
1	1	600	6220	3.73
2	1	3900	6220	24.26
3	1	600	5300	3.18
4	4	2500	2550	25.50
5	1	3500	520	1.82
6	1	3350	520	1.74
7	1	450	5300	2.39
8	1	6600	3300	21.78
9	1	640	3300	2.11
10	1	900	670	0.60
11	1	2800	470	1.32
12	1	2700	1850	5.00
13	1	1325	2720	3.60
14	2	54000	1800	194.40
15	2	1000	17600	35.20
16	2	4850	14000	135.80
TOTAL SUBTRACTION (B)				462.43
C. FAR (A-B)				523.17

AREA FREE FROM FAR				
S.NO.	NO.s	Length(in mm)	Breadth(in mm)	Area(in sqm)
2	1	3900	6220	24.26
8	1	6600	3300	21.78
14	2	54000	1800	194.40
15	2	1000	17600	35.20
16	2	4850	14000	135.80
D. TOTAL NON FAR				411.44

TOTAL Covered Area (C + D)				934.61
----------------------------	--	--	--	--------

CARPET AREA				
S.NO.	NO.s	Length(in mm)	Breadth(in mm)	Area(in sqm)
1	2	10335	13600	281.11
2	1	2960	7180	21.47
3	1	8525	5180	44.16
4	1	10570	5180	54.75
5	1	945	7180	6.79
CARPET AREA				408.28

17 TH FLOOR				
SL.NO.	TAG.	Rough Opening		REMARKS
		Width	Height	
INTERNAL DOOR SCHEDULE				
1	ID3	750	2450	TOILET
2	ID4	1800	2450	OFFICE
2	ID6	825	2450	TOILET
FIRE DOOR SCHEDULE (2HR FIRE RATED)				
1	FD1	1250	2450	STAIRCASE, LIFT LOBBY
2	FD2	1500	2450	STAIRCASE, LIFT LOBBY
3	FD3	2000	2450	STAIRCASE, LIFT LOBBY
SERVICE DOOR SCHEDULE				
1	TD1	1000	2450	ELECTRICAL SHAFT
2	TD2	600	2450	FHC
3				
WINDOW SCHEDULE				
1	W2001	3000	3750	OFFICE
2	W2002	20955	3750	OFFICE
3	W2003	4780	3750	OFFICE
GLAZING SCHEDULE				
1	GL2001	7050	3750	OFFICE
2	GL2002	13600	3750	OFFICE
3	GL2003	7885	3750	OFFICE
4	GL2004	13600	3750	OFFICE
4	GL2005	10715	3750	OFFICE
4	GL2006	11015	3750	OFFICE
4	GL2007	4400	3750	OFFICE
4	GL2008	9780	3750	OFFICE
4	GL2009	9695	3750	OFFICE
2	GL1202	10375	3750	OFFICE

17 TH FLOOR SANITARY FIXTURE CALCULATION				
TOTAL COVERED AREA		:	523.17 SQ.M.	
TOTAL POPULATION @ 10 SQ.M/PERSON		:	52	
(REFER Clause 4.3 & 4.4.2.1, Table 3 OCCUPANT LOAD (AS PER NBC 2016-PART-08 BUILDING SERVICES))				
MALE @ 1/2 OF VISITORS POPULATION		:	26	
FEMALE @ 1/2 OF VISITORS POPULATION		:	26	
SANITARY FIXTURE CALCULATION				
VISITOR				
FIXTURE	REQUIRED		PROVIDED	
	MALE	FEMALE	MALE	FEMALE
WC	2	2	2	2
WB	2	2	2	2
URINAL	2	-	2	-
(REFER Clause 4.2.5.1, Table 1 OFFICE BUILDING (AS PER NBC 2016-PART-08 BUILDING SERVICES))				

Authority Signatory

DTP (HQ)
Member Secretary
SPV

STP (HQ)
Member Secretary
SPV

STP (H)
Member Secretary
SPV


LEGEND FOR PLUMBING	
150x150mm CUTOUT IN SLAB FOR WCUT & FT	
1000 C.I. SOIL & VENT PIPE	
1500 C.I. SOIL & VENT PIPE	
1000 C.I. WASTE & VENT PIPE	
1500 C.I. WASTE & VENT PIPE	
750 C.I. ANTI-SYPHONIC PIPE	
DOMESTIC WATER SUPPLY FOR 25th to 15th FLOOR DOWN TAKE PIPE	
FLUSHING WATER SUPPLY FOR 25th to 15th FLOOR DOWN TAKE PIPE	
DOMESTIC WATER SUPPLY FOR 14th to 7th FLOOR DOWN TAKE PIPE	
FLUSHING WATER SUPPLY FOR 14th to 7th FLOOR DOWN TAKE PIPE	
DOMESTIC WATER SUPPLY FOR 8th to GROUND FLOOR DOWN TAKE PIPE	
FLUSHING WATER SUPPLY FOR 8th to GROUND FLOOR DOWN TAKE PIPE	
650 DOMESTIC WATER SUPPLY D.H. TANK FILLING PIPE	
500 FLUSHING WATER SUPPLY D.H. TANK FILLING PIPE	
1600DWPVC RAIN WATER PIPE FOR TERRACE	
1100DWPVC RAIN WATER PIPE FOR TERRACE	
DOMESTIC WATER SUPPLY	
FLUSHING WATER SUPPLY	
VALVE	
FLOOR TRAP	
FLOOR DRAIN	
CLEAN OUT PLUG	
FLOOR CLEAN OUT	

PLUMBING NOTES:-

- * W.C. TO HORIZONTAL SOIL PIPE 1000 SOIL PIPE
- * F.T. TO HORIZONTAL WASTE PIPE 1000 WASTE PIPE
- * U.T. TO HORIZONTAL SOIL PIPE 1000 SOIL PIPE
- * FLOOR DRAIN TO FLOOR TRAP 500 WASTE PIPE
- * WASH BASIN TO FLOOR TRAP 520 WASTE PIPE
- * SINK TO FLOOR TRAP 400 WASTE PIPE

NOTE:

- THE BUILDING WILL BE MECHANICALLY VENTILATED.
- SPRINKLERS ARE INCORPORATED AS/NBC.

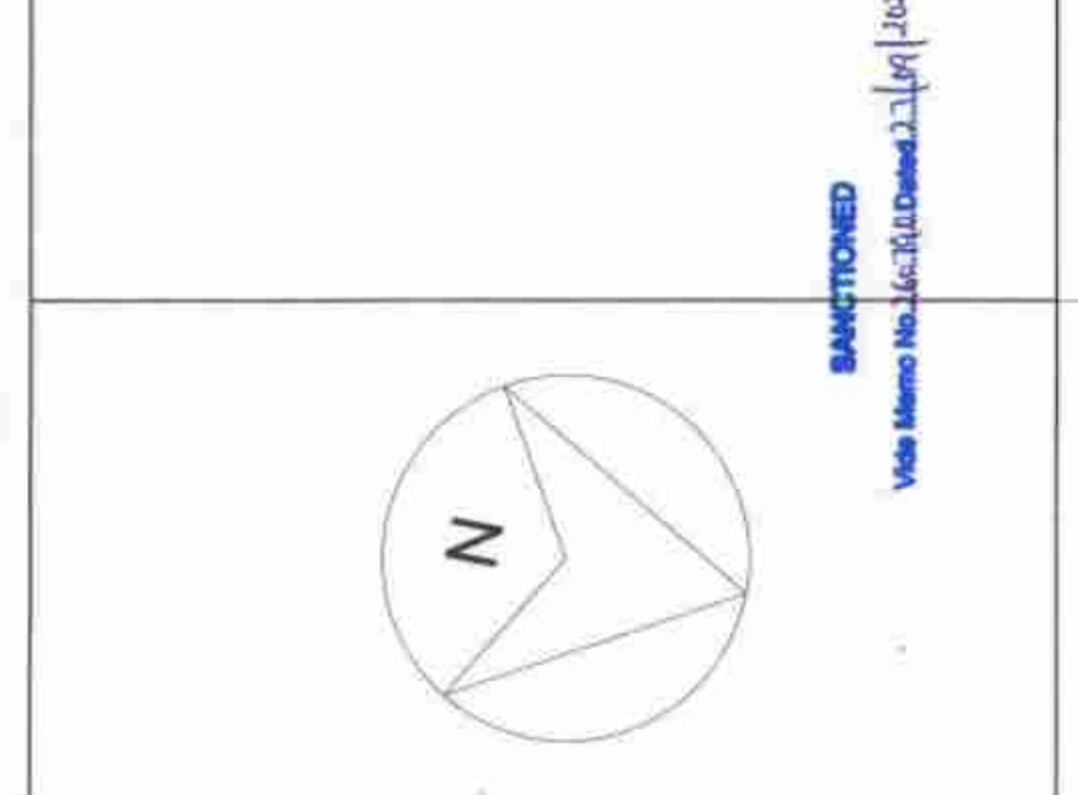

Architects :

OWNER SIGN

ARCHITECT SIGN

For ESSEL INFRA LLP

Designed/Partnership Sign.

ESSEL INFRA LLP

Project Title :

COMMERCIAL COMPLEX SITE C2 IN SHOPPING CENTRE SECTOR -43, GURUGRAM.

Drawing Title :

SUBMISSION DRAWINGS

17TH FLOOR

Scale :


Date : JUN-2024

Drawn By : P.K.


Checked By : A.S.

Sheet Size : A1


Drawing No : C2_FP-07

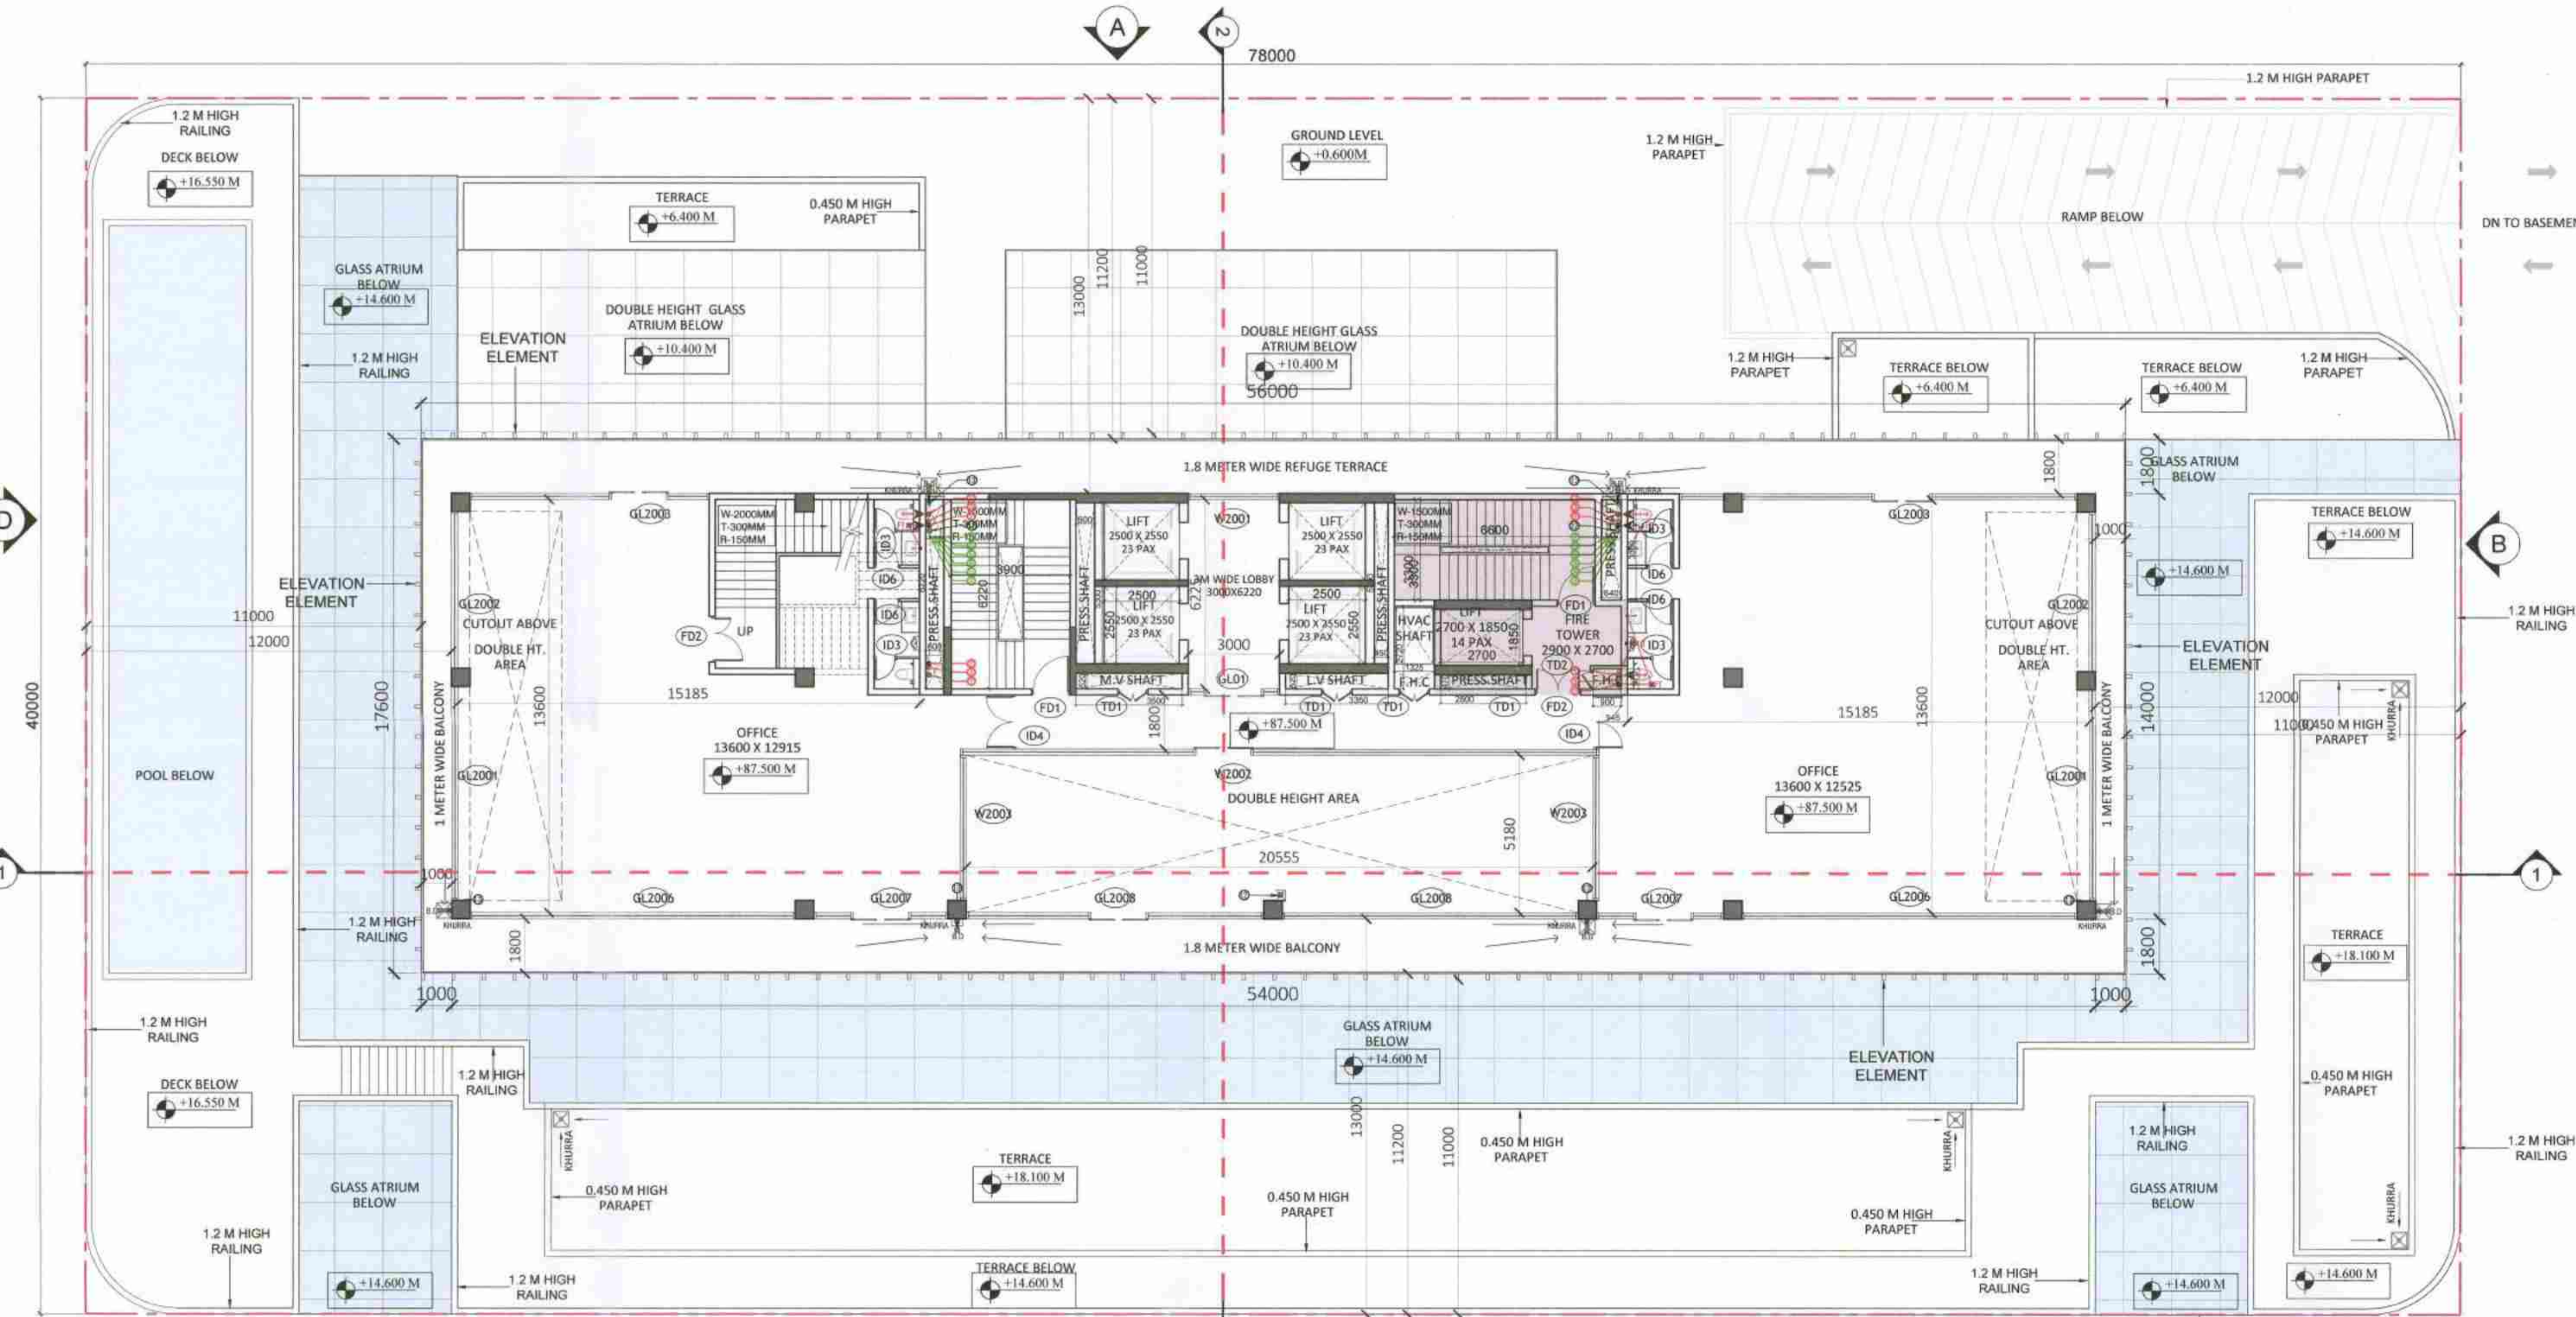

19TH FLOOR (1:150)
+87.500 M LVL

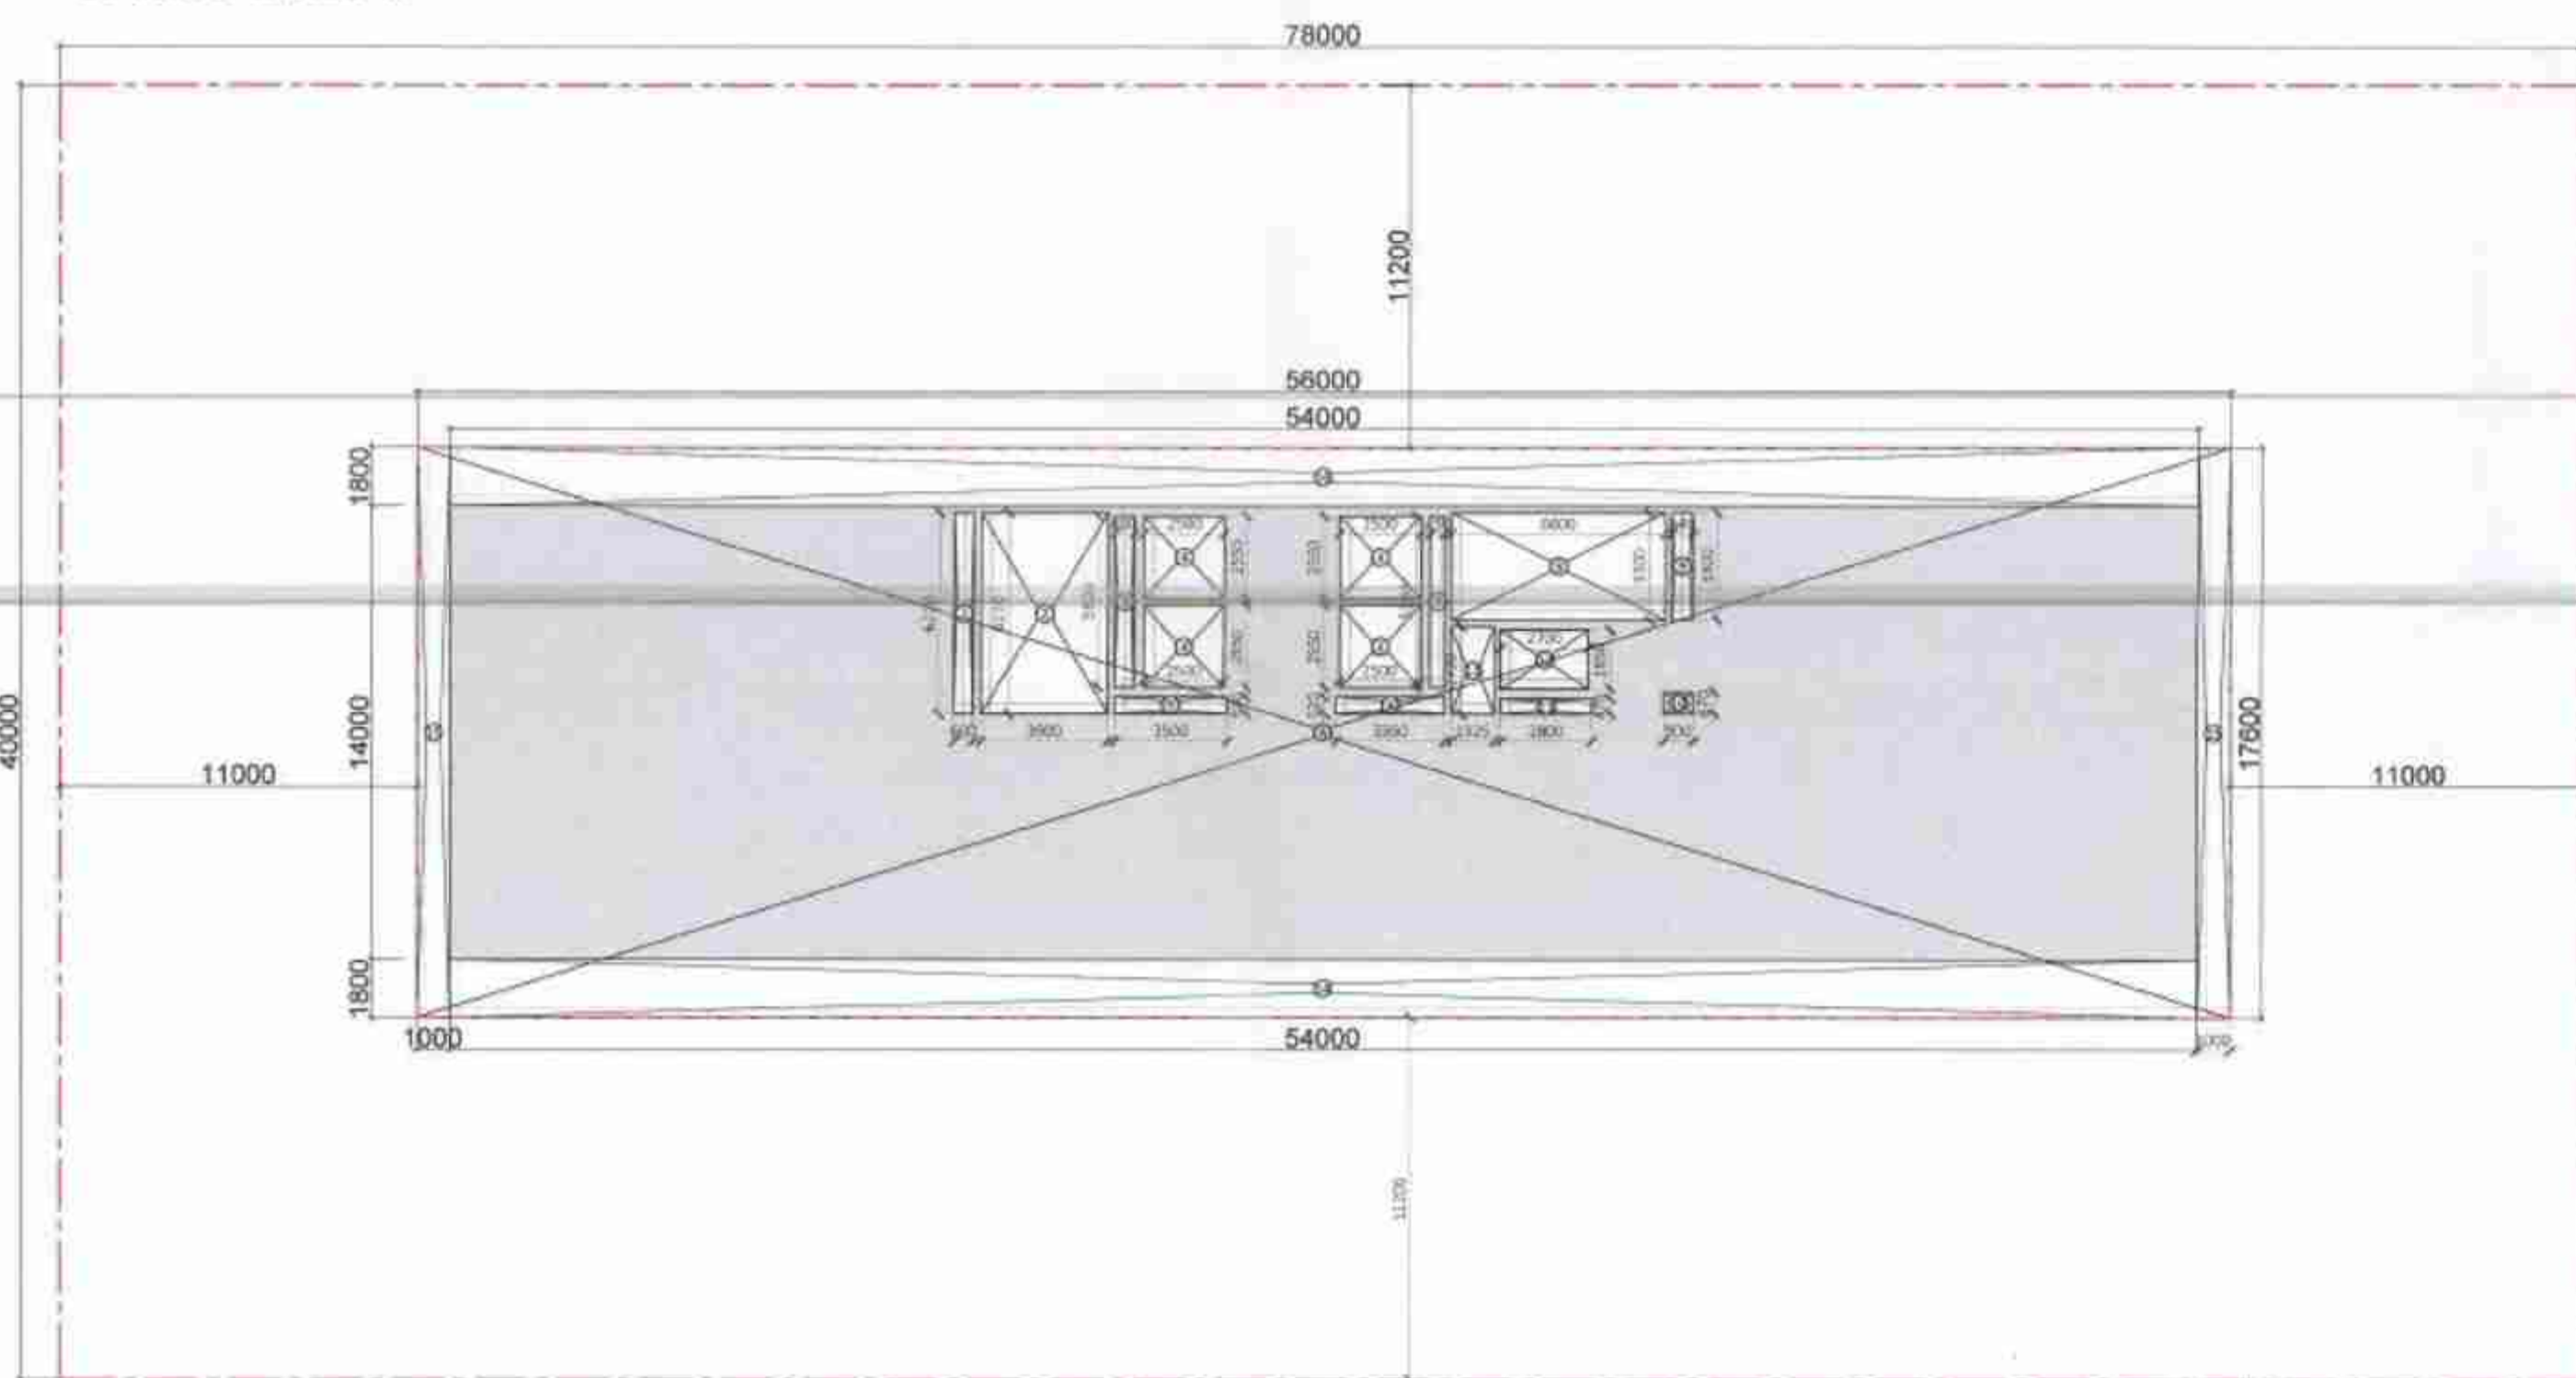

AREA DIAGRAM (1:300)

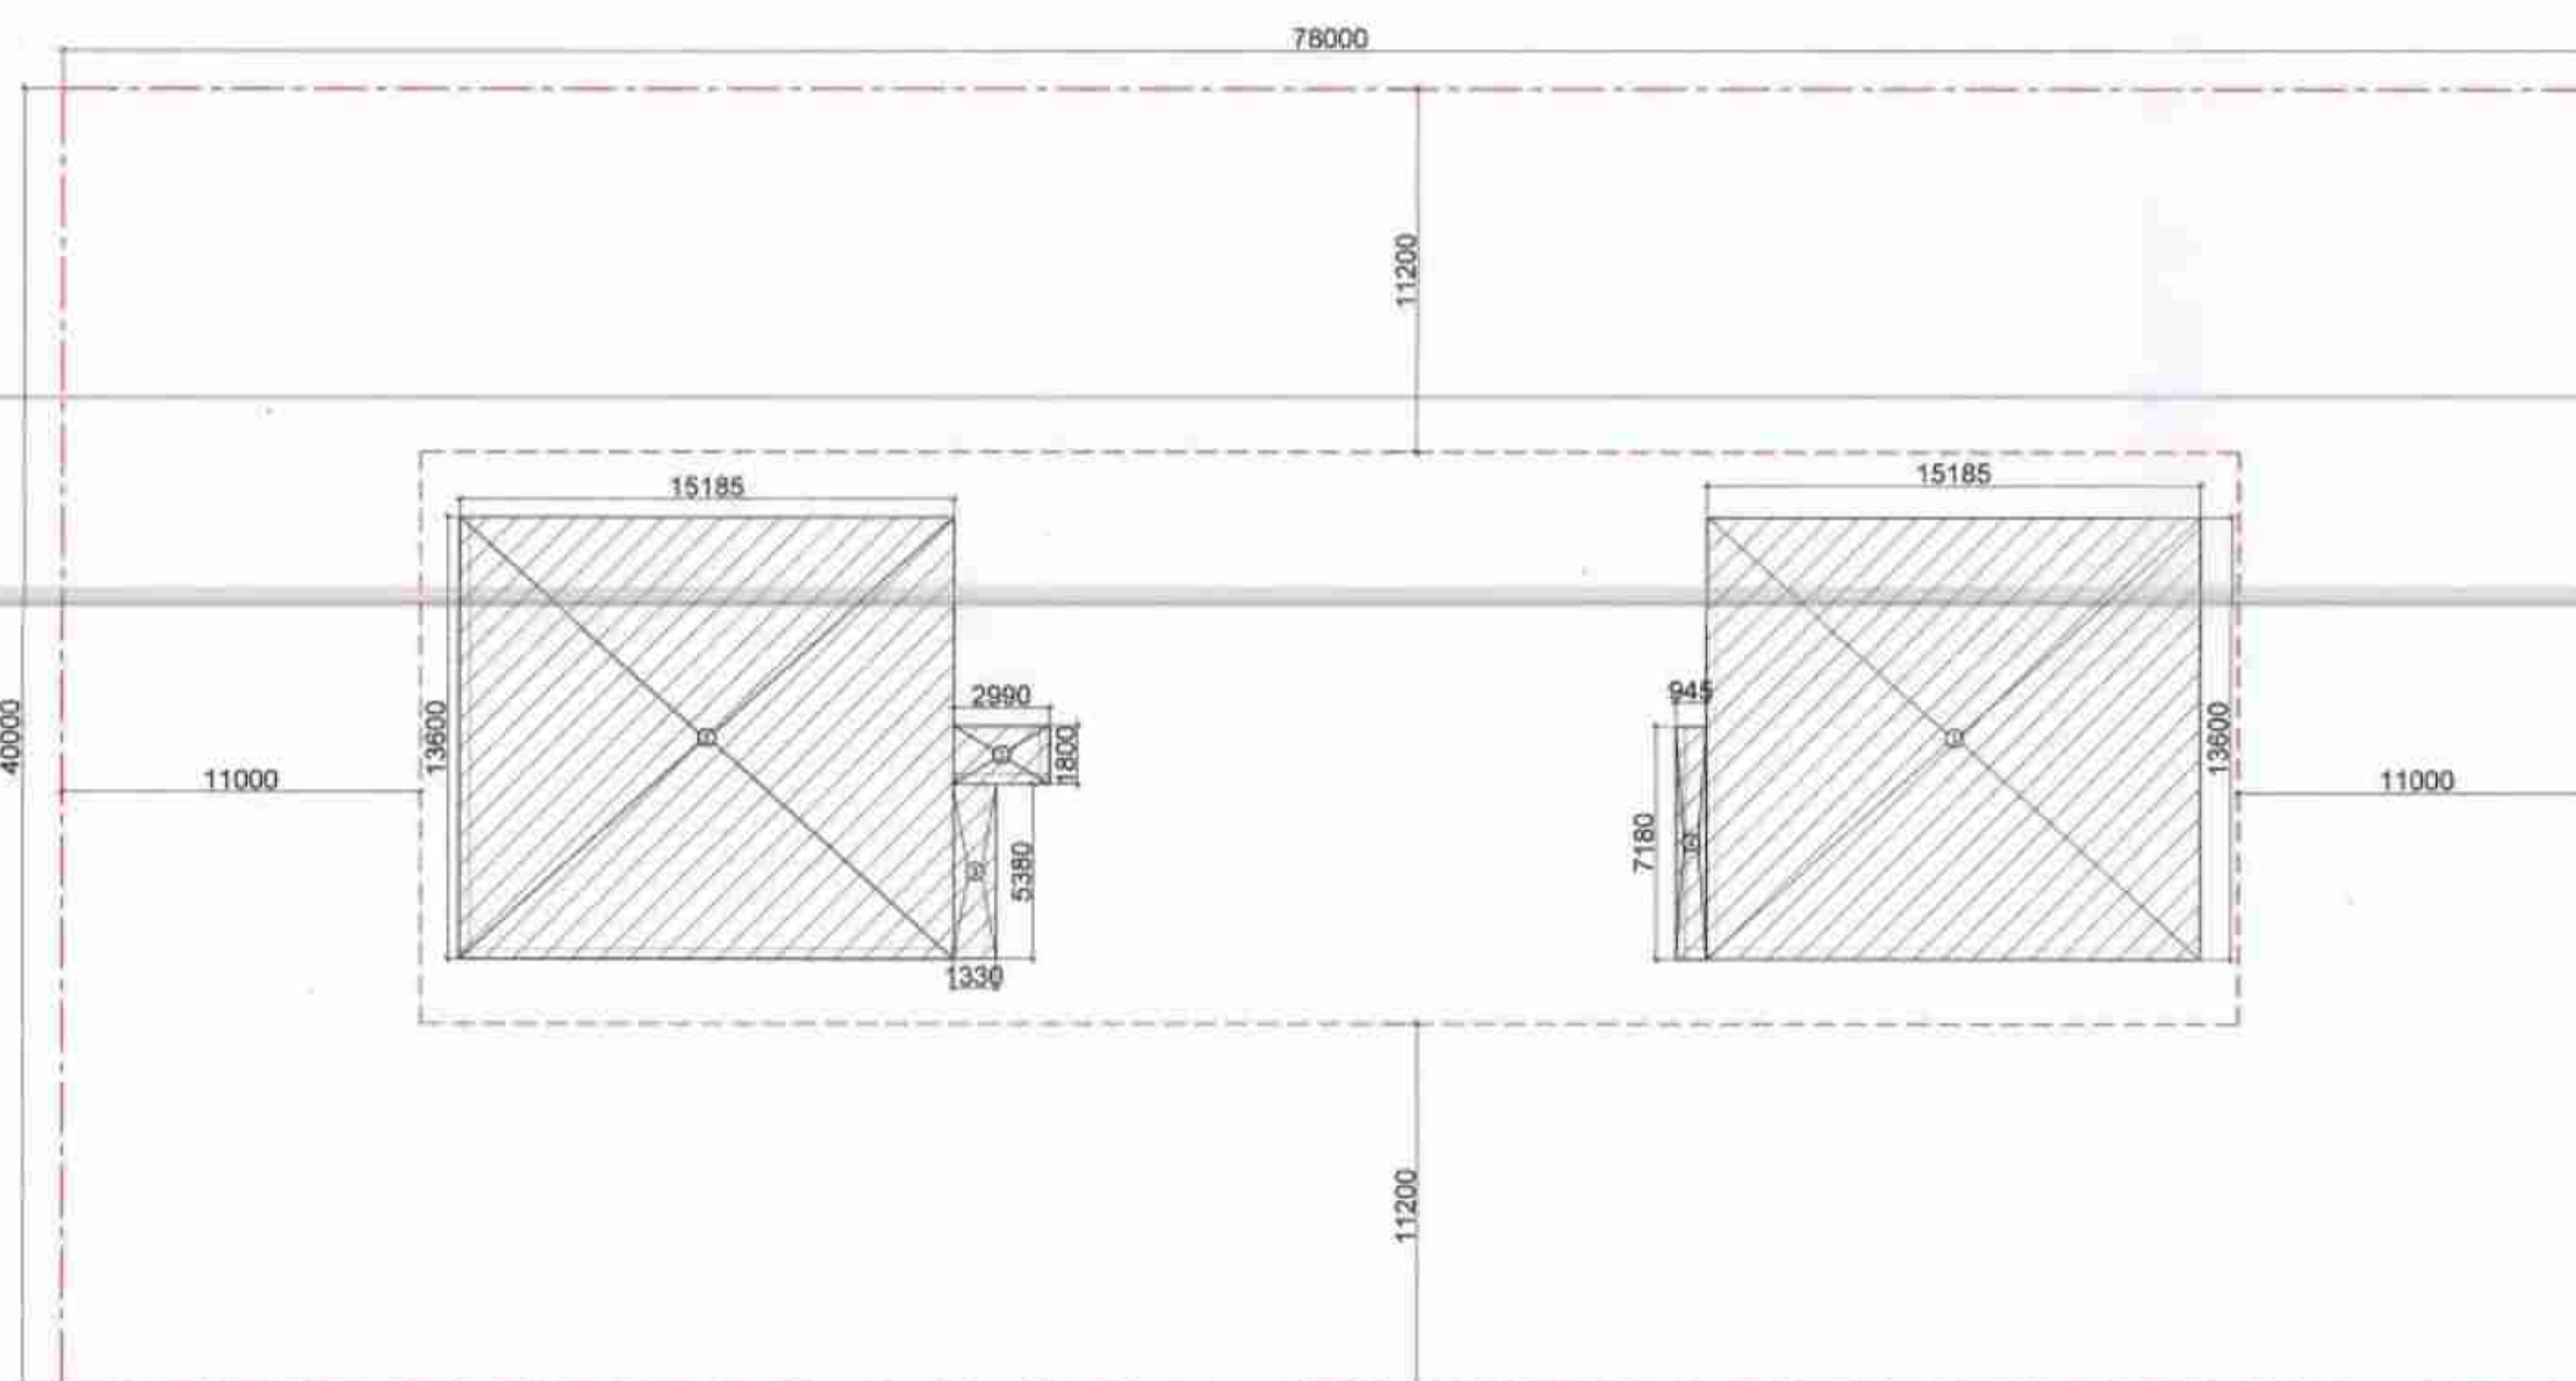

CARPET AREA DIAGRAM (1:300)

FAR				
S.NO.	NO.s	Length(in mm)	Breadth(in mm)	Area(in sqm)
ADDITION				
A	1	56000	17600	985.60
TOTAL AREA(A)				985.60
SUBTRACTION				
S.NO.	NO.s	Length(in mm)	Breadth(in mm)	Area(in sqm)
1	1	800	6220	3.73
2	1	3900	6220	24.26
3	1	600	5300	3.18
4	4	2500	2550	25.50
5	1	3500	520	1.82
6	1	3350	520	1.74
7	1	450	5300	2.39
8	1	6600	3300	21.78
9	1	640	3300	2.11
10	1	900	670	0.60
11	1	2800	470	1.32
12	1	2700	1850	5.00
13	1	1325	2720	3.60
14	2	54000	1800	194.40
15	2	1000	17600	35.20
TOTAL SUBTRACTION (B)				325.63
C. FAR (A-B)				658.97

AREA FREE FROM FAR				
S.NO.	NO.s	Length(in mm)	Breadth(in mm)	Area(in sqm)
1	1	3900	6220	24.26
8	1	6600	3300	21.78
14	2	54000	1800	194.40
15	2	1000	17600	35.20
D. TOTAL NON FAR				275.64

TOTAL Covered Area (C + D) 934.61

CARPET AREA				
S.NO.	NO.s	Length(in mm)	Breadth(in mm)	Area(in sqm)
1	2	15185	13600	413.03
2	1	2990	1800	5.38
3	1	1330	5380	7.16
4	1	945	7180	6.79
CARPET AREA				432.35

19TH FLOOR				
SLNO.	TAG.	Width	Height	REMARKS
INTERNAL DOOR SCHEDULE				
1	ID3	750	2450	TOILET
2	ID4	1800	2450	OFFICE
2	ID6	825	2450	TOILET
FIRE DOOR SCHEDULE (2HR FIRE RATED)				
1	FD1	1250	2450	STAIRCASE, LIFT LOBBY
2	FD2	1500	2450	STAIRCASE, LIFT LOBBY
3	FD3	2000	2450	STAIRCASE, LIFT LOBBY
SERVICE DOOR SCHEDULE				
1	TD1	1000	2450	ELECTRICAL SHAFT
2	TD2	600	2450	FHC
3				
WINDOW SCHEDULE				
1	W2001	3000	3750	OFFICE
2	W2002	20955	3750	OFFICE
3	W2003	4780	3750	OFFICE
GLAZING SCHEDULE				
1	GL2001	7050	3750	OFFICE
2	GL2002	13600	3750	OFFICE
3	GL2003	7885	3750	OFFICE
4	GL2004	13600	3750	OFFICE
4	GL2005	10715	3750	OFFICE
4	GL2006	11015	3750	OFFICE
4	GL2007	4400	3750	OFFICE
4	GL2008	9780	3750	OFFICE
4	GL2009	9695	3750	OFFICE

TWENTIETH FLOOR SANITARY FIXTURE CALCULATION				
TOTAL COVERED AREA	:	658.97 SQ. M.		
TOTAL POPULATION @ 10 SQ. MT/PERSOI	:	66		
(REFER Clause 4.3 & 4.4.2.1, Table 3 OCCUPANT LOAD (AS PER NBC 2016-PART-08 BUILDING SERVICES))				
MALE @1/2 OF VISITOR'S POPULATION	:	33		
FEMALE @1/2 OF VISITOR'S POPULATION	:	33		

SANITARY FIXTURE CALCULATION				
VISITOR				
FIXTURE	REQUIRED		PROVIDED	
	MALE	FEMALE	MALE	FEMALE
WC	2	3	2	3
WB	2	3	2	3
URINAL	1	-	2	

(REFER Clause 4.2.5.1, Table 1 OFFICE BUILDING (AS PER NBC 2016-PART-08 BUILDING SERVICES))

Authority Signatory

DTP (HQ) STP (HQ) CTP

LEGEND FOR PLUMBING	
150x150mm CUTOUT IN SLAB FOR WC UT & FT	
1000 G.I. SOIL & VENT PIPE	
1500 G.I. SOIL & VENT PIPE	
1500 G.I. WASTE & VENT PIPE	
750 G.I. ANTI-SYPHONIC PIPE	
DOMESTIC WATER SUPPLY FOR 25th to 15th FLOOR DOWN TAKE PIPE	
FLUSHING WATER SUPPLY FOR 25th to 15th FLOOR DOWN TAKE PIPE	
DOMESTIC WATER SUPPLY FOR 14th to 7th FLOOR DOWN TAKE PIPE	
FLUSHING WATER SUPPLY FOR 14th to 7th FLOOR DOWN TAKE PIPE	
DOMESTIC WATER SUPPLY FOR 6th to GROUND FLOOR DOWN TAKE PIPE	
FLUSHING WATER SUPPLY FOR 6th to GROUND FLOOR DOWN TAKE PIPE	
650 DOMESTIC WATER SUPPLY O.H. TANK FILLING PIPE	
150/ODUPVC RAIN WATER PIPE FOR TERRACE	
110/ODUPVC RAIN WATER PIPE FOR TERRACE	
D.W.S. DOMESTIC WATER SUPPLY	
F.W.S. FLUSHING WATER SUPPLY	
VALVE	
FT FLOOR TRAP	
FD FLOOR DRAIN	
COP CLEAN OUT PLUG	
FCO FLOOR CLEAN OUT	

PLUMBING NOTES:-
 * W.C. TO HORIZONTAL SOIL PIPE 1000 SOIL PIPE
 * F.T. TO HORIZONTAL WASTE PIPE 1000 WASTE PIPE
 * U.T. TO HORIZONTAL SOIL PIPE 1000 SOIL PIPE
 * FLOOR DRAIN TO FLOOR TRAP 300 WASTE PIPE
 * WASH BASIN TO FLOOR TRAP 300 WASTE PIPE
 * SINK TO FLOOR TRAP 400 WASTE PIPE

- NOTE:
- THE BUILDING WILL BE MECHANICALLY VENTILATED.
 - SPRINKLERS ARE INCORPORATED AS/NBC.

Architects :

OWNER SIGN

ARCHITECT SIGN

For ESSEL INFRA LLP

AC VIKRAM GOYAL

ESSEL INFRA LLP

Project Title :
COMMERCIAL COMPLEX SITE C2 IN SHOPPING CENTRE SECTOR -43, GURUGRAM

Drawing Title :

SUBMISSION DRAWINGS

19TH FLOOR


Scale : Drawing No : C2_FP-10

Date : JUN-2024


Drawn By : P.K.

Checked By : A.S.

Sheet Size : A1

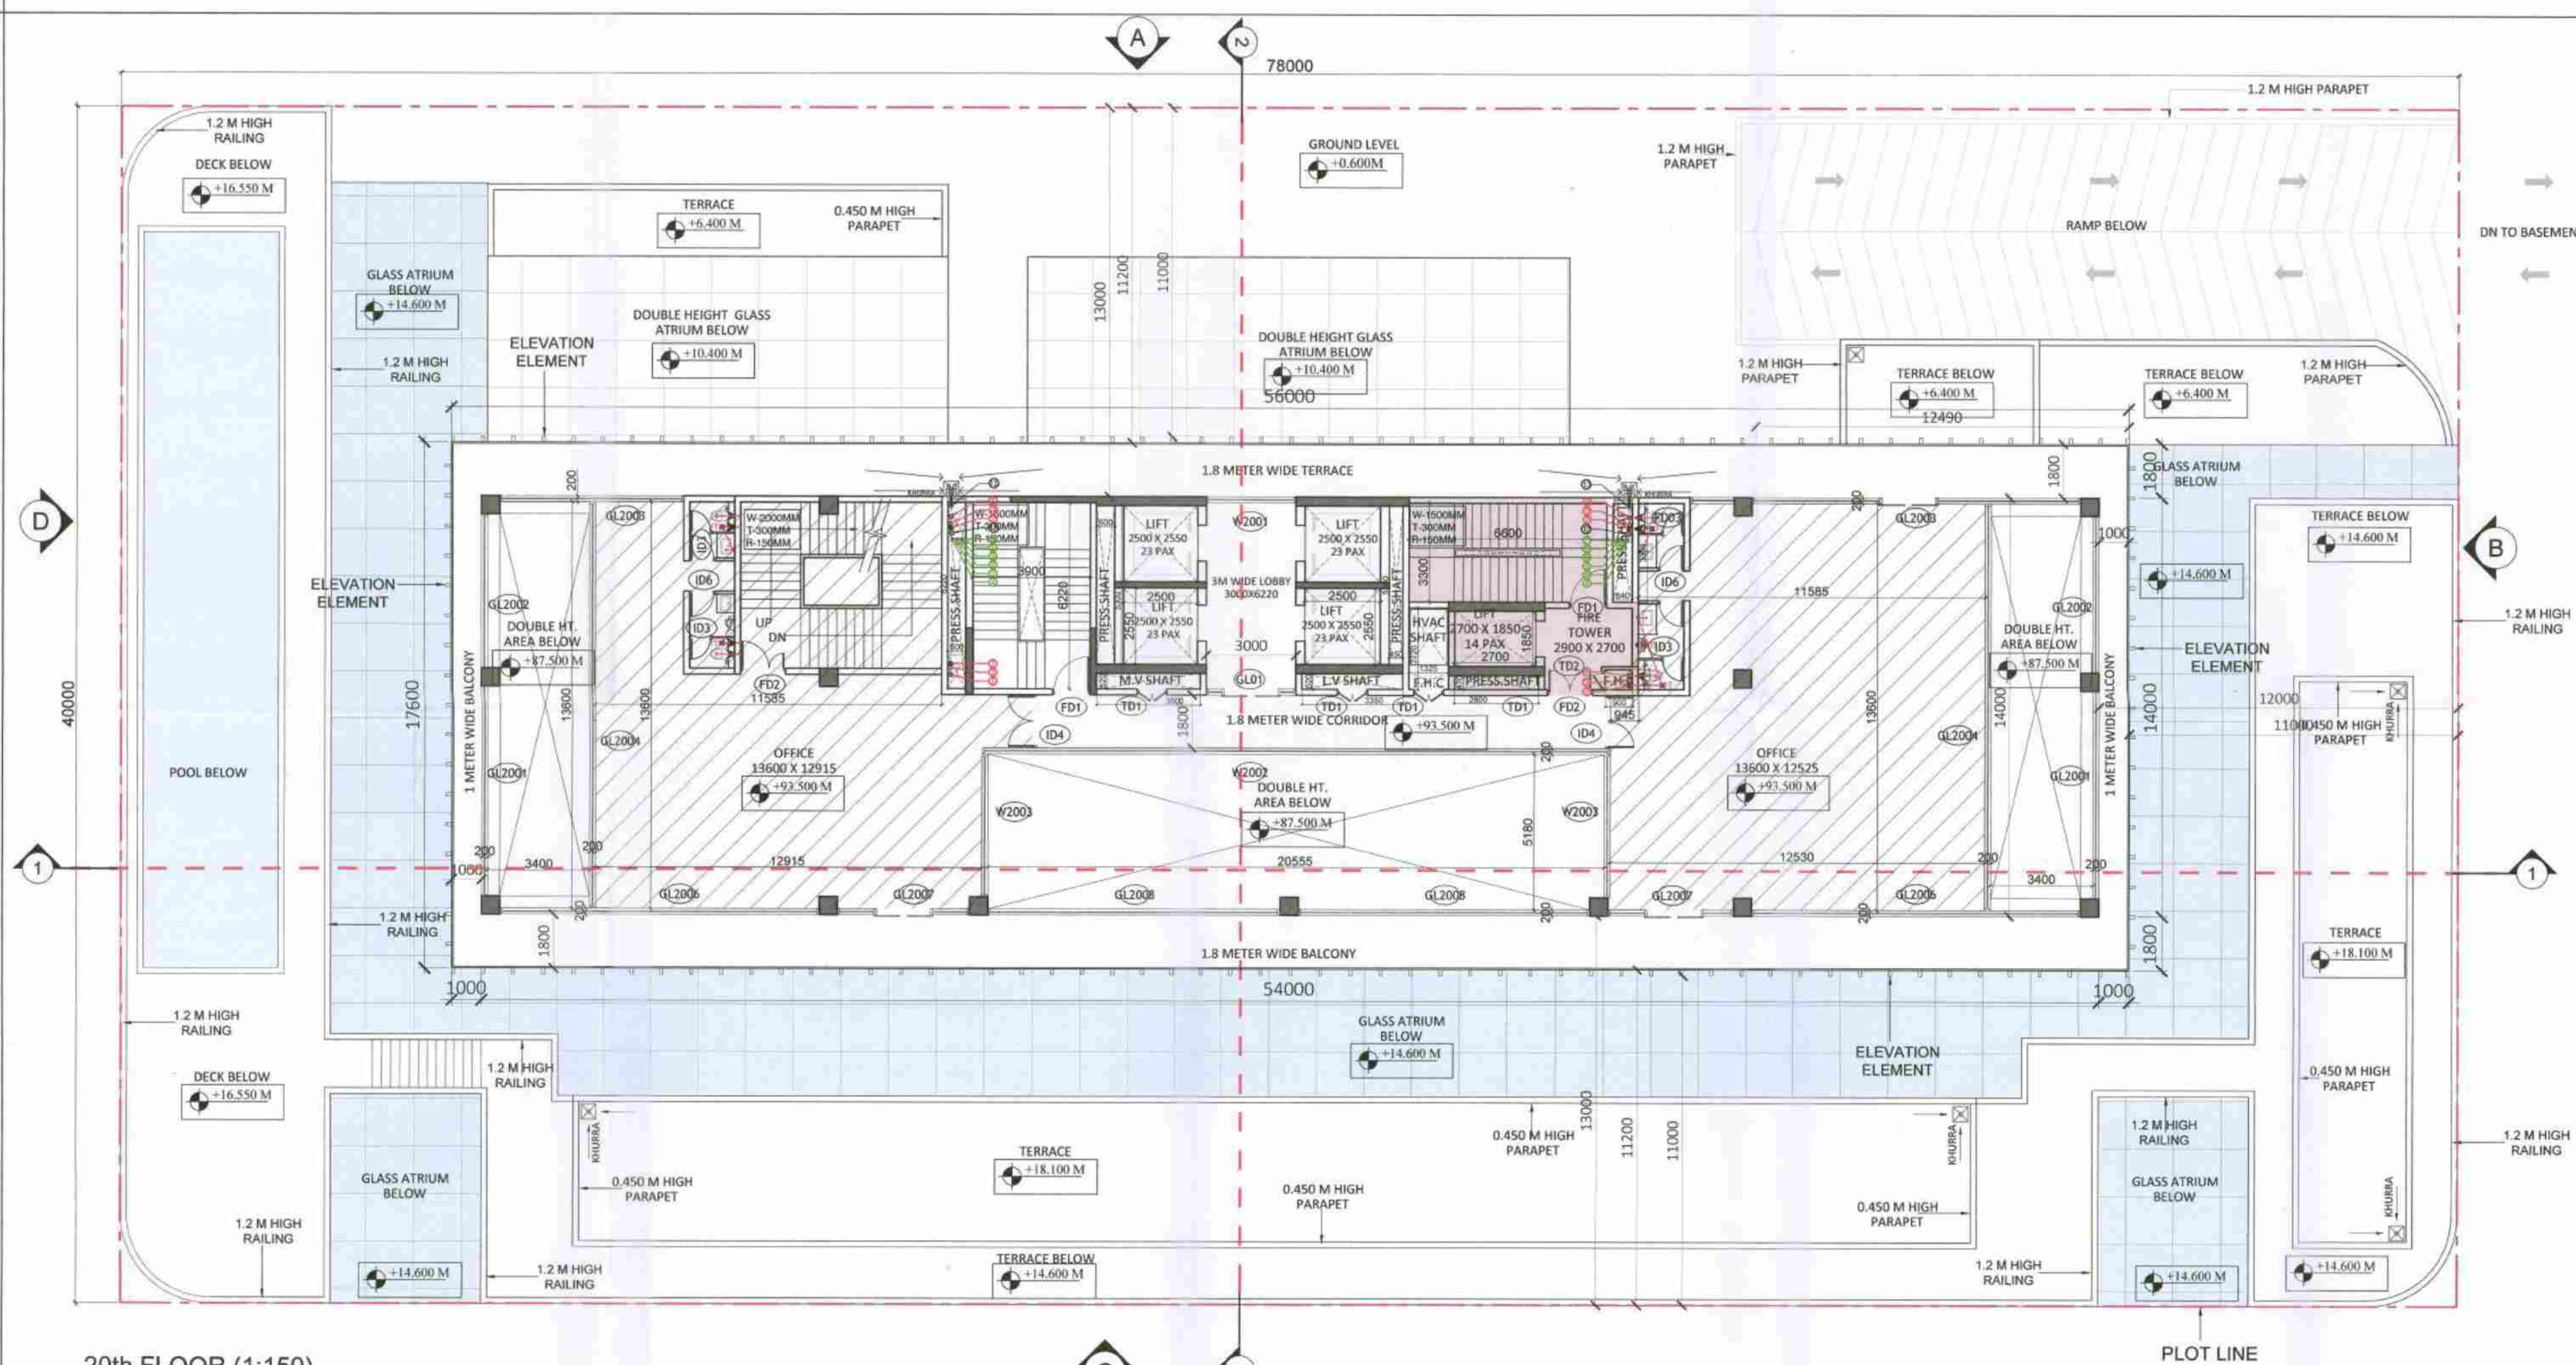

20th FLOOR (1:150)
+93.500 M LVL

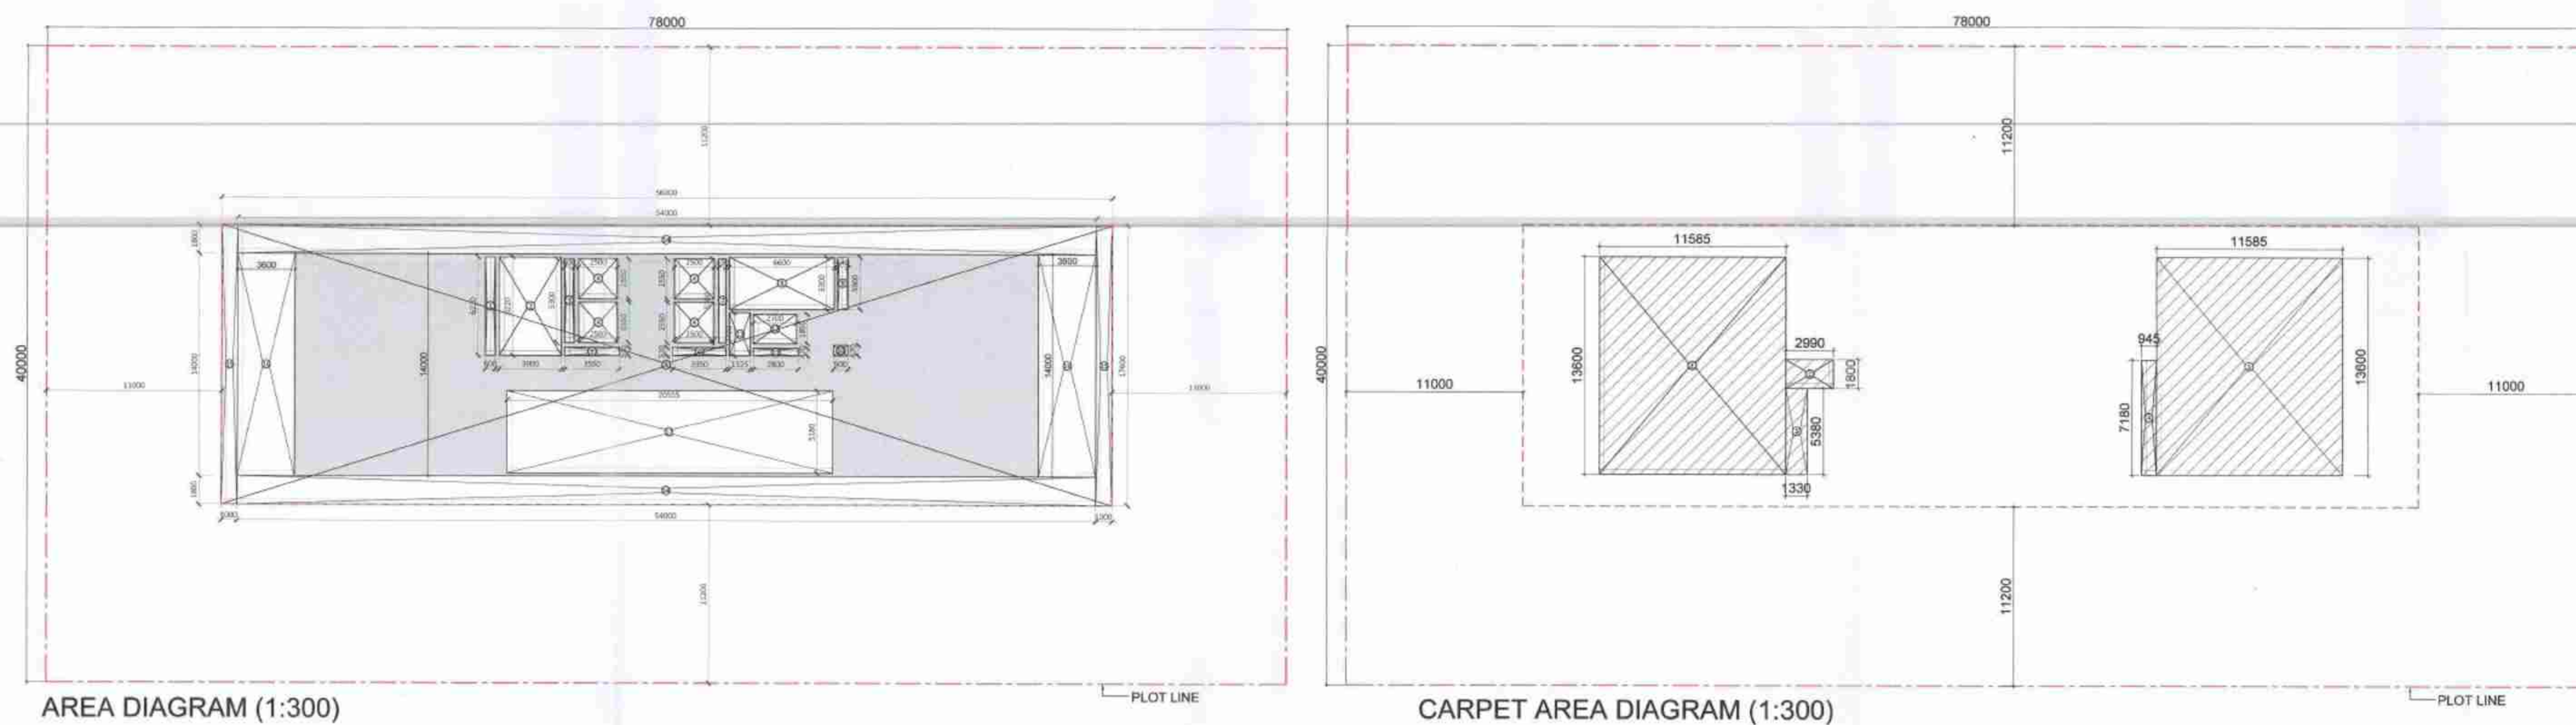

AREA DIAGRAM (1:300)

CARPET AREA DIAGRAM (1:300)

FAR				
S.NO.	NO.s	Length(in mm)	Breadth(in mm)	Area(in sqm)
ADDITION				
A	1	56000	17600	985.80
TOTAL AREA(A)				985.80
SUBTRACTION				
S.NO.	NO.s	Length(in mm)	Breadth(in mm)	Area(in sqm)
1	1	600	6220	3.73
2	1	3900	6220	24.26
3	1	600	5300	3.18
4	4	2500	2550	25.50
5	1	3500	520	1.82
6	1	3350	520	1.74
7	1	450	5300	2.38
8	1	6600	3300	21.78
9	1	640	3300	2.11
10	1	900	670	0.60
11	1	2800	470	1.32
12	1	2700	1850	5.00
13	1	1325	2720	3.60
14	2	54000	1800	194.40
15	2	1000	17600	35.20
16	2	3600	14000	100.80
17	1	20555	5180	106.47
TOTAL SUBTRACTION (B)				533.80
C. FAR (A-B)				451.70

AREA FREE FROM FAR				
S.NO.	NO.S	Length(n mm)	Breadth(n mm)	Area(n sqm)
ADDITION (X)				
2	1	3900	6220	24.26
8	1	8600	3300	21.78
14	2	54000	1800	194.40
15	2	1000	17600	35.20
D. TOTAL NON FAR				275.64

TOTAL Covered Area (C + D)				727.34
------------------------------	--	--	--	--------

CARPET AREA				
S.NO.	NO.s	Length(in mm)	Breadth(in mm)	Area(in sqm)
1	2	11585	13600	315.11
2	1	2990	1800	5.38
3	1	1330	5380	7.16
4	1	945	7180	6.79
CARPET AREA				334.43

20TH FLOOR				
SL.NO	TAG	Rough Opening		REMARKS
		Width	Height	
INTERNAL DOOR SCHEDULE				
1	ID3	750	2450	TOILET
2	ID4	1800	2450	OFFICE
2	ID6	825	2450	TOILET
FIRE DOOR SCHEDULE (2HR FIRE RATED)				
1	FD1	1250	2450	STAIRCASE, UFT LOBBY
2	FD2	1500	2450	STAIRCASE, UFT LOBBY
3	FD3	2000	2450	STAIRCASE, UFT LOBBY
SERVICE DOOR SCHEDULE				
1	TD1	1000	2450	ELECTRICAL SHAFT
2	TD2	600	2450	FHC
3				
WINDOW SCHEDULE				
1	W2001	3000	3750	OFFICE
2	W2002	20955	3750	OFFICE
3	W2003	4780	3750	OFFICE
GLAZING SCHEDULE				
1	GL2001	7050	3750	OFFICE
2	GL2002	13600	3750	OFFICE
3	GL2003	7885	3750	OFFICE
4	GL2004	13600	3750	OFFICE
4	GL2005	10715	3750	OFFICE
4	GL2006	11015	3750	OFFICE
4	GL2007	4400	3750	OFFICE
4	GL2008	9780	3750	OFFICE
4	GL2009	9695	3750	OFFICE

TWENTY FIRST FLOOR SANITARY FIXTURE CALCULATION				
TOTAL COVERED AREA		:	451.70 SQ.M	
TOTAL POPULATION @ 10 SQ.MT/PERSON		:	45	
(REFER Clause 4.3 & 4.4.2.1, Table 3 OCCUPANT LOAD (AS PER NBC 2016-PART-08 BUILDING SERVICES))				
MALE @1/2 OF VISITORS POPULATION		:	23	
FEMALE @1/2 OF VISITORS POPULATION		:	23	
SANITARY FIXTURE CALCULATION				
	VISITOR			
FIXTURE	REQUIRED		PROVIDED	
	MALE	FEMALE	MALE	FEMALE
WC	1	2	2	2
WB	1	2	2	2
URINAL	1	-	2	
(REFER Clause 4.2.5.1, Table 1 OFFICE BUILDING (AS PER NBC 2016-PART-08 BUILDING SERVICES))				

Authority Signatory


 Suraj Bhan
 J.D.

 DTP (H) Member Secretary BPAC	 STP (H) Member BPAC	 CTP Chairman BPAC
--	--	--


 JD (H)


 DTP (H)


 STP (H)
 (MEMBER)
 (B.P.A.C.)

LEGEND FOR PLUMBING	
SE	150/150mm C/D/OUT IN SLAB FOR WC/UT & FT
①	1000 C.I. SOIL & VENT PIPE
②	1500 C.I. SOIL & VENT PIPE
③	1000 C.I. WASTE & VENT PIPE
④	1500 C.I. WASTE & VENT PIPE
⑤	750 C.I. ANTI-SYPHONIC PIPE
⑥	DOMESTIC WATER SUPPLY FOR 25th to 15th FLOOR DOWN TAKE PIPE
⑦	FLUSHING WATER SUPPLY FOR 25th to 15th FLOOR DOWN TAKE PIPE
⑧	DOMESTIC WATER SUPPLY FOR 14th to 7th FLOOR DOWN TAKE PIPE
⑨	FLUSHING WATER SUPPLY FOR 14th to 7th FLOOR DOWN TAKE PIPE
⑩	DOMESTIC WATER SUPPLY FOR 6th to GROUND FLOOR DOWN TAKE PIPE
⑪	FLUSHING WATER SUPPLY FOR 6th to GROUND FLOOR DOWN TAKE PIPE
⑫	650 DOMESTIC WATER SUPPLY O/H TANK FILLING PIPE
⑬	650 FLUSHING WATER SUPPLY O/H TANK FILLING PIPE
12	1000DUPVC RAIN WATER PIPE FOR TERRACE
13	1100DUPVC RAIN WATER PIPE FOR TERRACE
F.W.S	DOMESTIC WATER SUPPLY
F.W.S	FLUSHING WATER SUPPLY
<V>	VALVE
FT	FLOOR TRAP
FD	FLOOR DRAIN
CF	CLEAN OUT PLUG
FOF	FLOOR CLEAN OUT

PLUMBING NOTES:-

- * W.C TO HORIZONTAL SOIL PIPE 1000 SOIL PIPE
- * F.T TO HORIZONTAL WASTE PIPE 1000 WASTE PIPE
- * U.T TO HORIZONTAL SOIL PIPE 1000 SOIL PIPE
- * FLOOR DRAIN TO FLOOR TRAP 500 WASTE PIPE
- * WASH BASIN TO FLOOR TRAP 320 WASTE PIPE
- * SINK TO FLOOR TRAP 400 WASTE PIPE

NOTE:

1. THE BUILDING WILL BE MECHANICALLY VENTILATED.
2. SPRINKLERS ARE INCORPORATED AS/NBC.

Architects :

OWNER SIGN

ARCHITECT SIGN

For ESSEL INFRA LLP

Designated Partner/Auth. Sign.

Ar. VINEMRA GOYAL
CA/2019/114552
[No. 7222, P. 10, 10th floor, Gurugram]

Clients:

ESSEL INFRA LLP

Project Title :
COMMERCIAL COMPLEX SITE C2 IN SHOPPING CENTRE
SECTOR -43, GURUGRAM.

Superintending Engineer(HQ)
O/o Chief Engineer-I/I
HSVP, Panchkula. 

Drawing Title :

SUBMISSION DRAWINGS

20th FLOOR

Scale :	Drawing No : C2_FP-11
Date : JUN-2024	
Drawn By : P.K	
Checked By : A.S	
Sheet Size : A1	