


2ND FLOOR PLAN
@ LVL.+10100MM

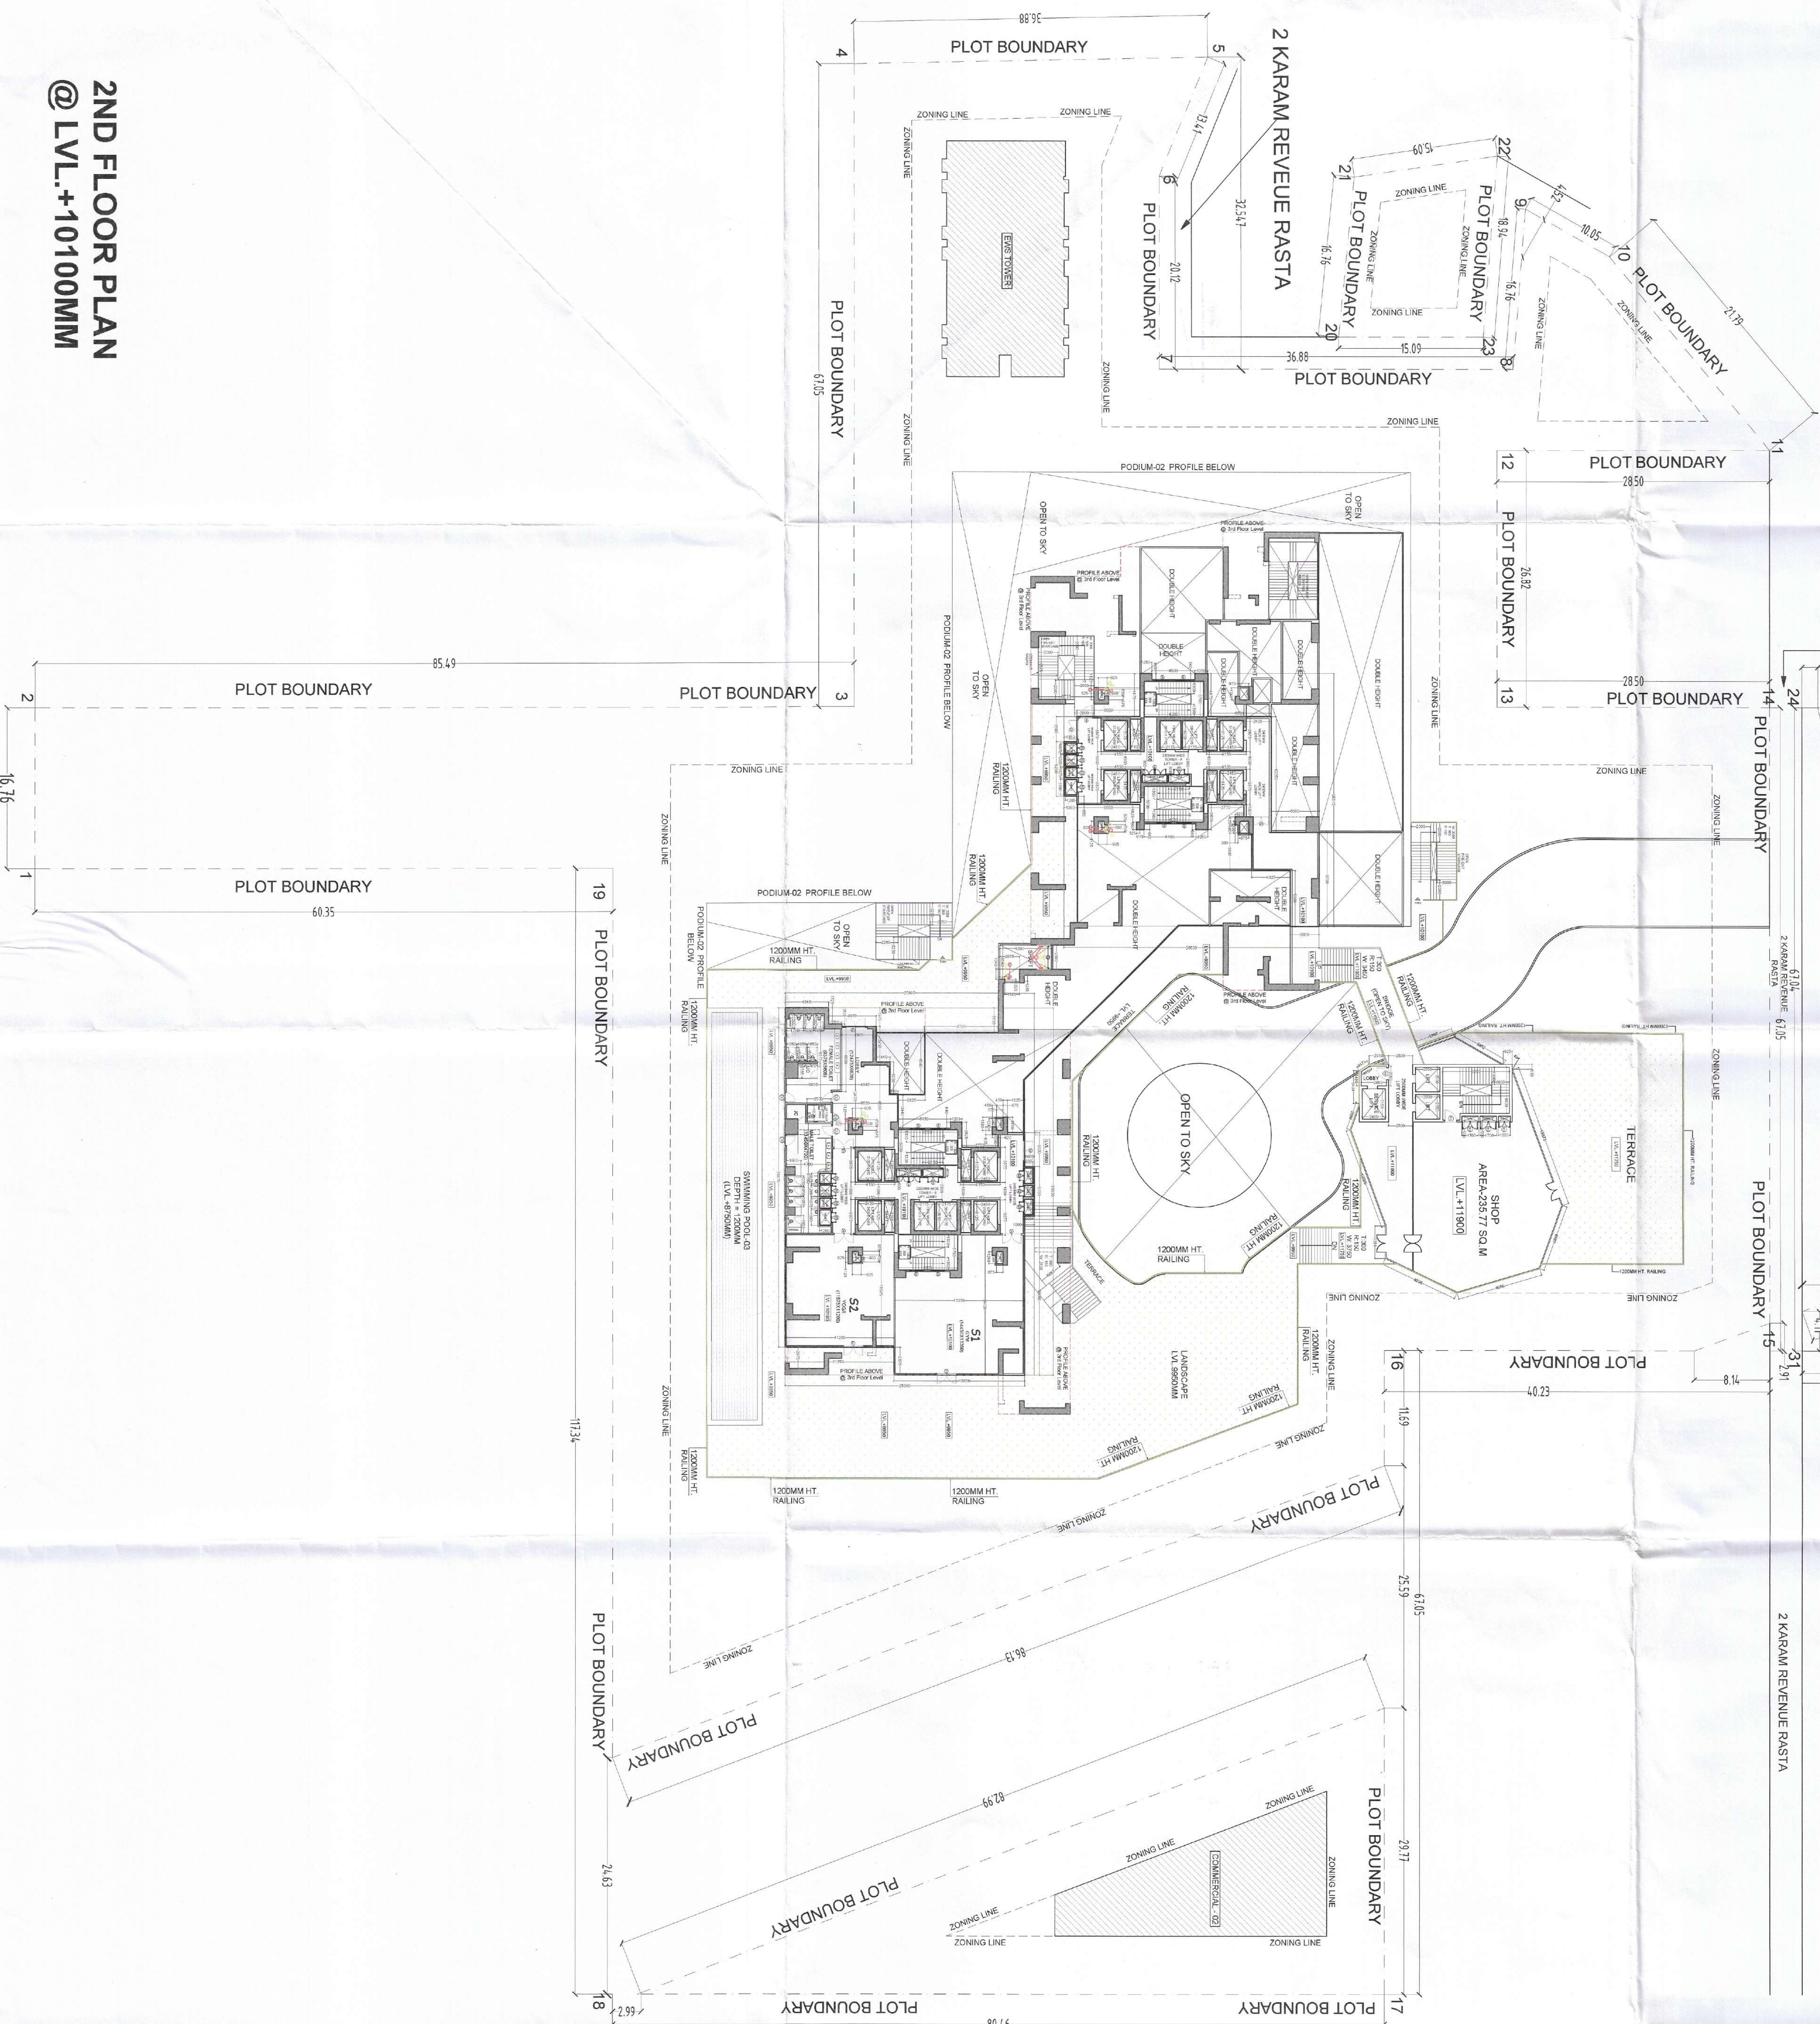

RAM REVENUE RASTA

2 KARAM REVEUE RASTA

2 KARAM REVENUE RASTA

LEGEND:—

	PLUMBING LEGEND
①	110ø OD uPVC SP STACK
②	110ø OD uPVC WP STACK
③	160ø OD uPVC SP STACK
④	110ø OD uPVC R.W.P
⑤	160ø OD uPVC R.W.P

DOOR WINDOW SCHEDULE FOR 2ND FLOOR					
S.No.	TYPE	SIZE	S.L.	L.L.	FIRE RATED (HRS.)
1	D1	2000 X 2700	0	2700	
2	D2	1050 X 2400	0	2400	
3	D3	900 X 2400	0	2400	
4	D4	1675 X 2700	0	2700	
5	SH1	1200 X 2400	0	2400	2 HRS
6	SH2	2400 X 2100	300	2400	2 HRS
7	SH3	1075 X 2100	300	2400	
8	FD	1300 X 2700	0	2700	2 HRS
11	W1	1500 X 1650	1050	2700	

STAIRCASE EXIT CALCULATION (2ND FLOOR)			
SPACE	AREA (sq.m)	Occupant load (in no.)	
RECREATIONAL LOBBY & CORR @ 12.5 sqm per person	292.01	23.36	
STAIRCASE EXIT REQUIRED @ 10mm per person		233.61	
Staircases Provided = (1300+1300+1300+1300) CLUB AVENUE/FIT @ 7.4 sqm per person	731.648	522.61	
SWIMMING POOL @ 2.7 sqm per person	204	75.56	
TOTAL OCCUPANT LOAD		598.16	
STAIRCASE EXIT REQUIRED @ 10mm per person		598.161	
Staircases Provided = (2350+2000+2000)		6420	

GENERAL NOTES :

- [illegible]

MODARCHINDIA
ADDRESS: B-99, SECTOR-63, NOIDA 201307
UTTAR PRADESH, INDIA

CONSULTING STRUCTURAL ENGINEER

MANISH CONSULTANTS
F19, SOUTH CITY 2, SECTOR 50
GURGAON 122018

+91-124-4144714

CECPL

Tel 0120 - 2303500 (30 Lines)

**CONSULTING LANDSCAPE
SANJU BOSE LANDSCAPE
CONSULTANTS**
E - 47, Panchsheel Park
New Delhi 110017

PROJECT DETAIL:

PROPOSED GROUP HOUSING OF MIXED LAND USE COLONY (90% RESIDENTIAL COMPONENT & 10% COMMERCIAL COMPONENT) UNDER TOD POLICY ON THE AREA MEASURING 4.6875 ACRES (LICENSE NO. 49 OF 2024 DATED 14.03.2024) IN VILLAGE HAYATPUR, SECTOR-84, GURUGRAM MANESAR URBAN COMPLEX BEING DEVELOPED BY FOREVER BUILDTech PVT. LTD.

For FOREVER BUILDTech PRIVATE LIMITED

ARCHITECT'S SIGNATURE In forwarding letter No. 187149 Dt. 04/10/2018

ARCHITECT'S SIGNATURE In forwarding letter No. 187149 Dt. 04/10/2018

AMIT KUMAR
C108922706
BARCHINITY

Superintending Engineer (HQ)
for Civil Engineering
MSRP, Ranchi
in

Drawing Title

Drawing No.
DWG-FBPL-3

Issued By

Scale

North

