

SUBMISSION DRAWING


Notes:

- Dimensions are not to be scaled.
- All window & ventilation are operable


FOR OFFICE USE ONLY

No. Date By Description


- Notes:
- Rear open spaces will be combined and will be shared.
 - Pocket A is a Gated Complex.
 - VAV system is being provided.
 - Full DG power back up is being provided.
 - Tables are mechanical ventilated.

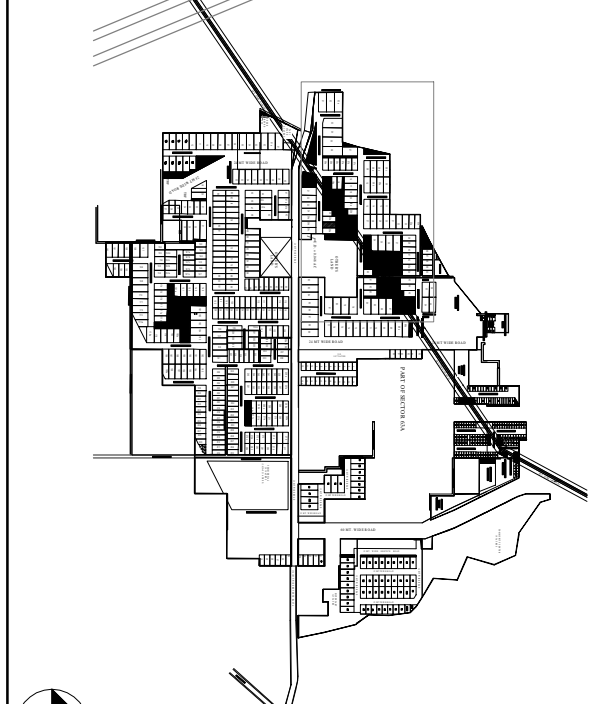

KEY PLAN (Scale: 1:500)

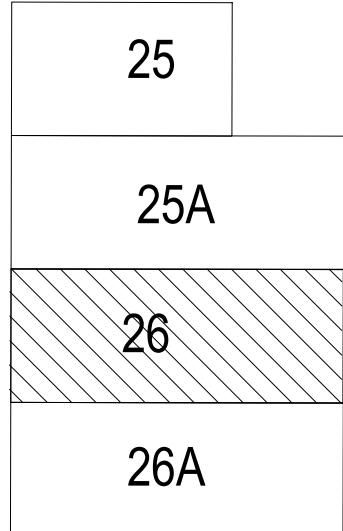

MIDDLE TYPOLOGY-III

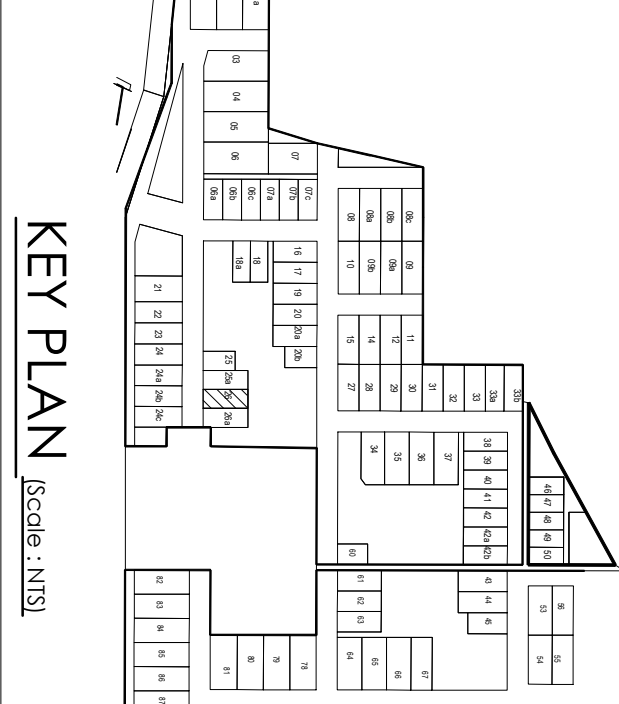

KEY PLAN (Scale: 1:500)

MIDDLE TYPOLOGY-III
PLOT 275/91 SQ.MTS TYPE-F1
POCKET - A

Sanctioned & Valid For Two Years
Architect
ARCOP Associates Pvt. Ltd.
Plot No. 589, Sector 26, Gurgaon-122001

Architects:
ARCOP Associates Pvt. Ltd.
Plot No. 589, Sector 26, Gurgaon-122001
Building Services (MEP) Consultants:

SNC
Sunil Noyyar Consulting Engineers LLP
Head Office : 202, 203A & 203B-205B, 2nd & 3rd floor,
Sector-26, Gurgaon-122001 (Haryana) (India)
Tel : +91-124-4803800 (30 Lines)
E-mail : srinag@snce.com

PROJECT TITLE:
AVANA PROJECTS LLP
PART OF RESIDENTIAL PLOT NO. CO. 19
IN SECTOR-63A, GURGRAM - 110, 202/75
ACRES
(100.268 ACRES UNDER LICENSE NO.119
OF 2011 + 7.6625 ACRES ADDITIONAL
LICENSE NO.271 OF 2014 +2.09125 ACRES
ADDITIONAL LICENSE NO.104 OF 2019)

OWNER SIGNATURE ARCH. SIGNATURE

SUIT FLOOR PLAN FIRST FLOOR PLAN
FOURTH FLOOR PLAN TERRACE PLAN, MINITY
PLAN, ELEVATIONS, SECTION
SCALE: 1:100 DATE: JULY/2024
DRAWING NO. A-26

