

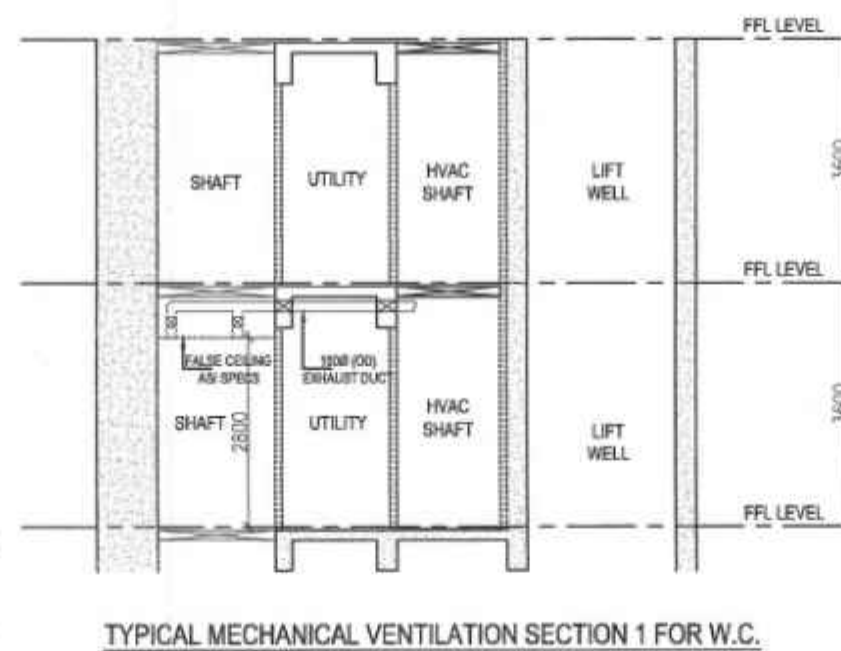


LOWER PENTHOUSE 39TH FLOOR AREA CALCULATION						
ADDITION AREA						
S. No.	COEFF.	Dim (m)	X	Dim (m)	Nos.	Area (SQM)
F1	0.667	1.120	X	0.380	12	3.40
F2	0.5	1.040	X	0.815	6	2.54
F3	(4.975+5.550)/2	X	0.575		4	12.10
F4	1	5.550	X	1.350	4	29.97
F5	1	10.400	X	5.775	1	60.06
F5A	1	0.700	X	0.300	2	0.42
F6B	1	0.200	X	0.300	1	0.21
F7	1	9.525	X	1.925	2	36.67
F8	(1.925+1.350)/2	X	0.575		2	1.87
F8	1	2.525	X	5.775	3	43.74
F8A	1	2.225	X	5.775	2	25.69
F9	1	6.875	X	8.150	1	56.03
F10	1	4.175	X	1.875	3	23.85
F11	(4.310+4.700)/2	X	0.400		1	0.48
F12	0.5	7.400	X	18.490	1	68.41
F13	0.5	4.875	X	15.830	1	38.58
F14	0.5	8.160	X	18.490	1	75.43
F15	0.5	15.675	X	4.985	1	39.07
F16	(2.415+1.630)/2	X	8.175		1	16.53
F17	1	15.050	X	8.150	2	245.31
F18	(2.170+1.625)/2	X	8.175		2	24.51
FA	0.667	0.815	X	0.160	3	0.26
TOTAL ADDITION AREA (A)						829.33
DEDUCTION AREA						
S. No.	COEFF.	Dim (m)	X	Dim (m)	Nos.	Area (SQM)
D1	1	1.825	X	0.450	2	1.64
D1A	1	1.825	X	1.775	1	3.23
D2	1	0.325	X	1.750	2	1.13
D3	1	0.325	X	0.425	1	0.13
D3	1	2.125	X	1.675	3	10.67
D4	1	2.025	X	1.525	3	9.26
D5	0.5	1.070	X	1.850	1	0.99
D6	1	2.175	X	2.200	6	28.71
D7	0.5	1.090	X	1.915	1	1.04
D8	1	1.200	X	0.400	1	0.48
D9	1	1.570	X	0.400	1	0.62
D10	(3.175+3.700)/2	X	1.405		1	4.83
D11	0.5	2.110	X	1.230	1	1.29
D12	0.5	2.110	X	1.055	1	1.11
D13	(1.200+1.500)/2	X	0.520		1	0.70
D14	0.5	2.005	X	1.155	1	1.15
D15	(1.155+1.875)/2	X	1.250		1	1.59
D16	(2.660+1.410)/2	X	6.020		1	12.25
D17	0.5	6.120	X	3.040	1	9.30
D18	0.5	2.100	X	1.210	2	2.54
D19	(2.560+4.790)/2	X	3.860		1	14.18
D20	(1.230+4.790)/2	X	2.060		1	6.20
D21	(1.520+2.600)/2	X	0.620		1	1.27
D22	1	2.400	X	2.095	1	5.04
D23	1	2.100	X	3.200	1	6.72
D24	(1.755+1.195)/2	X	0.975		1	1.43
D25	0.5	1.120	X	1.945	1	1.08
D26	0.5	1.775	X	1.025	1	0.91
D27	0.5	1.850	X	1.070	1	0.99
D28	1	5.050	X	5.150	2	52.01
D29	0.5	5.050	X	2.525	1	12.75
D30	1	2.625	X	1.350	1	3.54
D30	(5.150+4.575)/2	X	0.575		3	8.38
D31	0.5	6.260	X	3.035	1	9.50
D31	(0.650+4.415)/2	X	5.800		1	14.68
D32	1	0.300	X	4.415	1	1.32
D33	0.5	5.960	X	2.980	1	8.88
TOTAL DEDUCTION AREA (D)						242.38
TOTAL NET F.A.R. AREA (F1 - D1) = F						586.94
TOTAL NON FAR AREA (N)						59.14
TOTAL BUILDUP AREA (F + N)						646.08

39TH FLOOR NON FAR AREA CALCULATION									
D10	(3.175+3.700)/2	X	1.405		1	4.830			
D11	0.5	2.110	X	1.230	1	1.298			
D12	0.5	2.110	X	1.055	1	1.113			
D13	(1.200+1.500)/2	X	0.520		1	0.702			
D16	(2.660+1.410)/2	X	6.020		1	12.251			
D17	0.5	6.120	X	3.040	1	9.302			
D18	0.5	2.100	X	1.210	2	2.541			
D19	(2.560+4.790)/2	X	3.860		1	14.186			
D20	(1.230+4.790)/2	X	2.060		1	6.201			
D21	(1.520+2.600)/2	X	0.620		1	1.277			
D22	1	2.600	X	2.095	1	5.447			
TOTAL NON FAR AREA (N)						59.147			

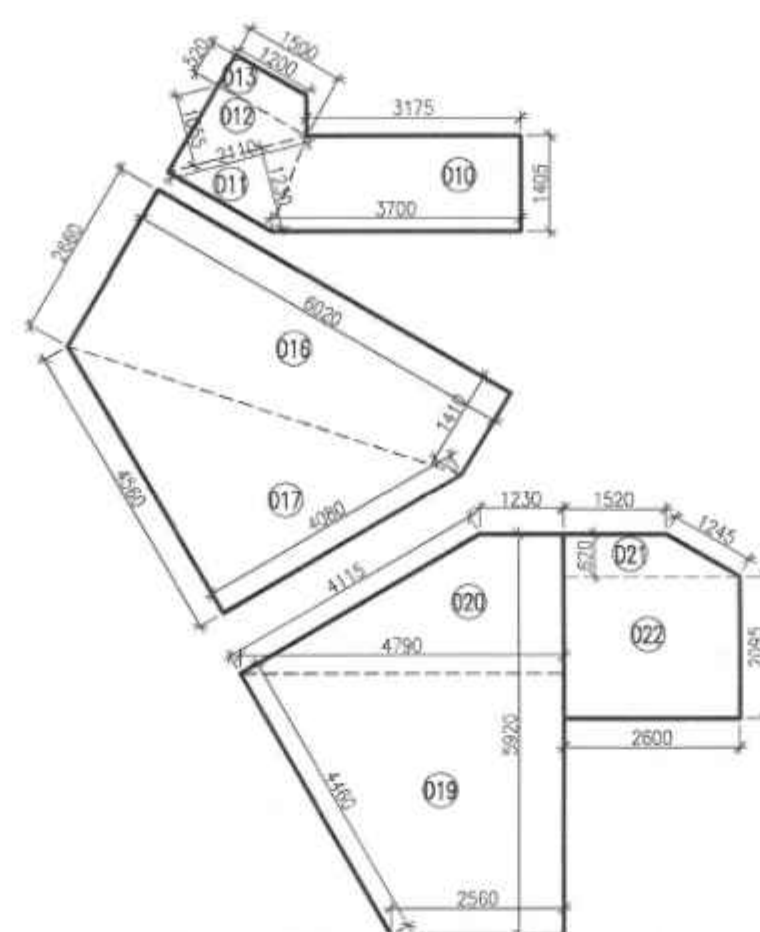

LOWER PENTHOUSE 39TH FLOOR AREA DIAGRAM

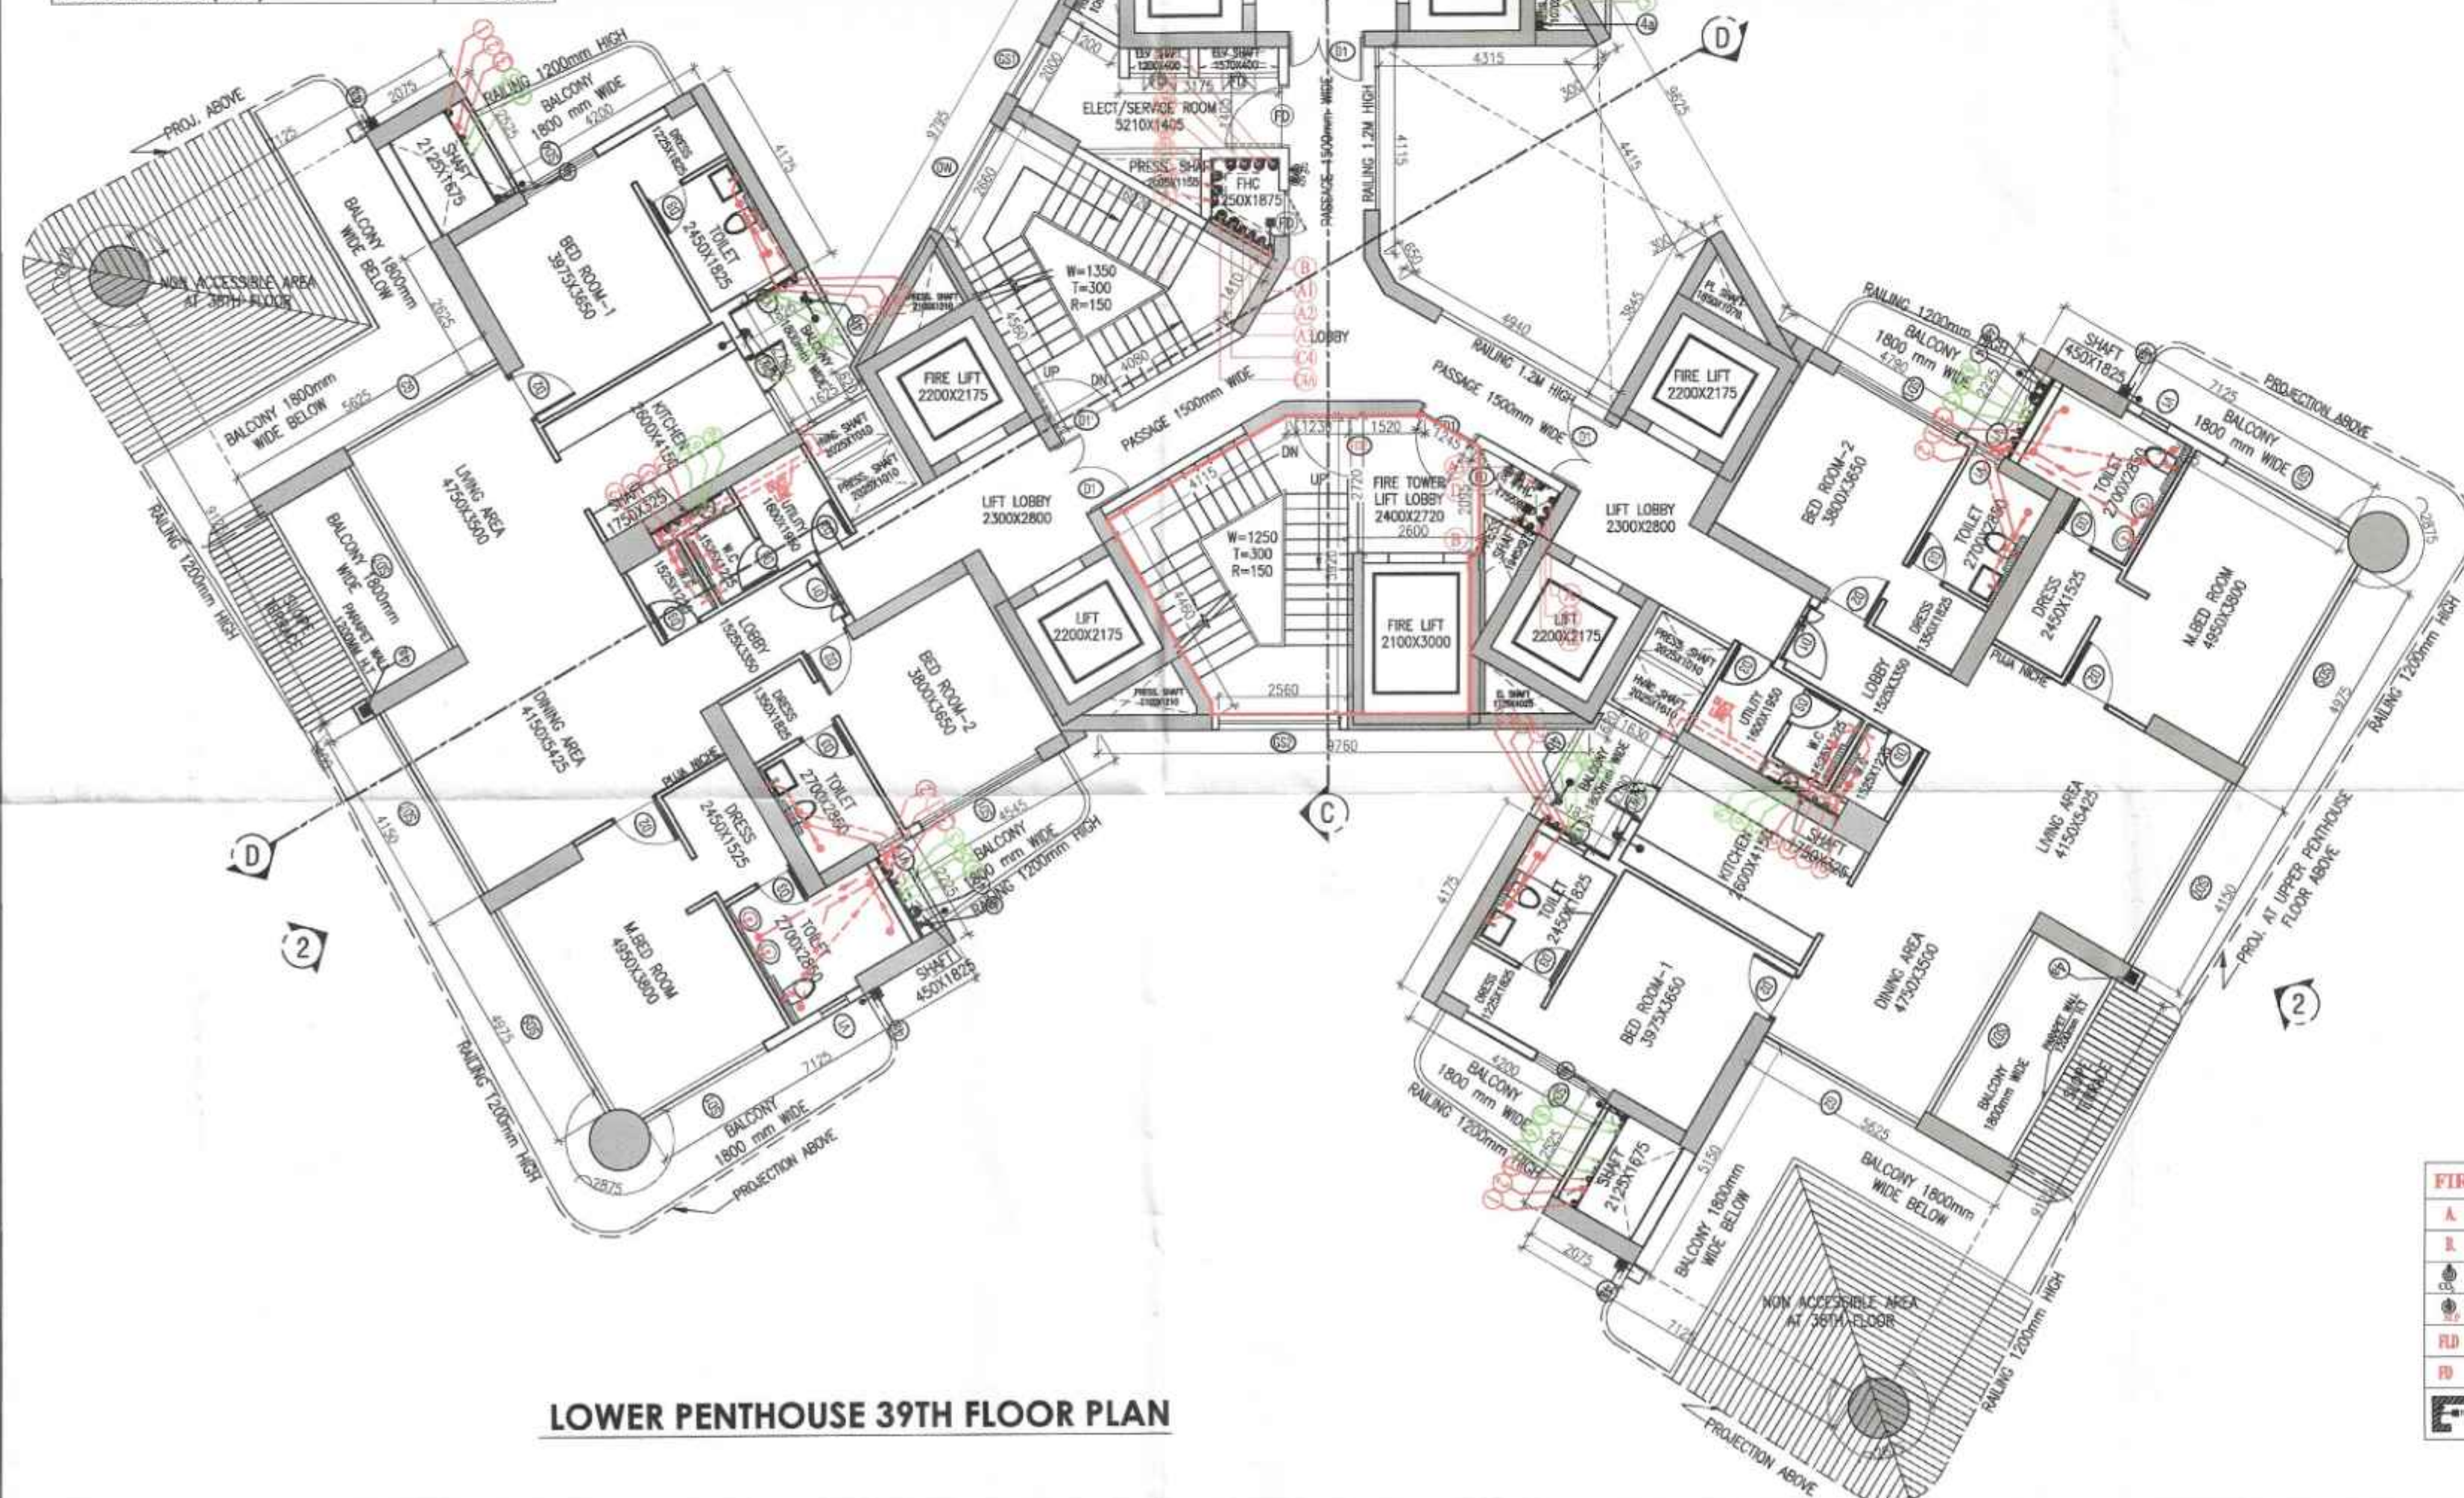

LOWER PENTHOUSE 39TH FLOOR PLAN

FIRE LEGEND:-	
A	1000 FIRE RETARDANT PIPE L/W 300L
B	500 FIRE RETARDANT PIPE L/W 150L
C	CO TYPE FIRE EXTINGUISHERS 4.5KG
D	5 Ltr. B.F. TYPE CO. FIRE EXTINGUISHER
E	FLOOR DRAIN PIPE
F	FIRE HOSE
G	FIRE HOSE CANNOPY (F.H.C.)

LEGEND:-	
DESCRIPTION	SYMBOL
1000 A.P.C. RAIL & TIGHT PIPE	1
500 A.P.C. RAIL & TIGHT PIPE	2
1000 A.P.C. RAIL & TIGHT PIPE	3
500 A.P.C. RAIL & TIGHT PIPE	4
1000 A.P.C. RAIL & TIGHT PIPE	5
500 A.P.C. RAIL & TIGHT PIPE	6
1000 A.P.C. RAIL & TIGHT PIPE	7
500 A.P.C. RAIL & TIGHT PIPE	8
1000 A.P.C. RAIL & TIGHT PIPE	9
500 A.P.C. RAIL & TIGHT PIPE	10
1000 A.P.C. RAIL & TIGHT PIPE	11
500 A.P.C. RAIL & TIGHT PIPE	12
1000 A.P.C. RAIL & TIGHT PIPE	13
500 A.P.C. RAIL & TIGHT PIPE	14
1000 A.P.C. RAIL & TIGHT PIPE	15
500 A.P.C. RAIL & TIGHT PIPE	16
1000 A.P.C. RAIL & TIGHT PIPE	17
500 A.P.C. RAIL & TIGHT PIPE	18
1000 A.P.C. RAIL & TIGHT PIPE	19
500 A.P.C. RAIL & TIGHT PIPE	20
1000 A.P.C. RAIL & TIGHT PIPE	21
500 A.P.C. RAIL & TIGHT PIPE	22
1000 A.P.C. RAIL & TIGHT PIPE	23
500 A.P.C. RAIL & TIGHT PIPE	24
1000 A.P.C. RAIL & TIGHT PIPE	25
500 A.P.C. RAIL & TIGHT PIPE	26
1000 A.P.C. RAIL & TIGHT PIPE	27
500 A.P.C. RAIL & TIGHT PIPE	28
1000 A.P.C. RAIL & TIGHT PIPE	29
500 A.P.C. RAIL & TIGHT PIPE	30
1000 A.P.C. RAIL & TIGHT PIPE	31
500 A.P.C. RAIL & TIGHT PIPE	32
1000 A.P.C. RAIL & TIGHT PIPE	33
500 A.P.C. RAIL & TIGHT PIPE	34
1000 A.P.C. RAIL & TIGHT PIPE	35
500 A.P.C. RAIL & TIGHT PIPE	36
1000 A.P.C. RAIL & TIGHT PIPE	37
500 A.P.C. RAIL & TIGHT PIPE	38
1000 A.P.C. RAIL & TIGHT PIPE	39
500 A.P.C. RAIL & TIGHT PIPE	40
1000 A.P.C. RAIL & TIGHT PIPE	41
500 A.P.C. RAIL & TIGHT PIPE	42
1000 A.P.C. RAIL & TIGHT PIPE	43
500 A.P.C. RAIL & TIGHT PIPE	44
1000 A.P.C. RAIL & TIGHT PIPE	45
500 A.P.C. RAIL & TIGHT PIPE	46
1000 A.P.C. RAIL & TIGHT PIPE	47
500 A.P.C. RAIL & TIGHT PIPE	48
1000 A.P.C. RAIL & TIGHT PIPE	49
500 A.P.C. RAIL & TIGHT PIPE	50

TYPICAL DOOR WINDOW SCHEDULE				
NAME	WIDTH	HEIGHT	CILL	LINTEL
D1	1500	2400	0	2400
D2	1000	2400	0	2400
D3	800	2400	0	2400
D4	1600	1800	600	2400
D5	600	1200	1200	2400
D6	2750	2400	0	2400
D7	4300	2400	0	2400
D8	1350	2400	0	2400
D9	1675	2400	0	2400
D10	4575	2400	0	2400
D11	3500	2400	0	2400
D12	4150	2400	0	2400
D13	1750	2400	00/1050	2400
D14	4150	2400	0	2400
D15	3500	2400	0	2400
D16	4300	2400	0	2400
D17	2800	2400	0	2400
D18	4575	2400	0	2400
D19	4110	5100	0	5100
D20	1200	2400	0	2400
D21	1250	2400	0	2400
D22	1500	2400	0	2400
D23	900	2400	0	2400
D24	2400	1500	0	2400

ALL MAIN UNIT DOOR - ONE HR FIRE RATING

PROJECT NAME:-
TRINITY SKY PALAZZOS

PROPOSED BUILDING PLAN OF GROUP HOUSING MEASURING 10.84375 ACRES (LICENCE NO. 130 OF 2024 DATED 24.10.2024) IN SECTOR-88B, GURUGRAM MANESAR URBAN COMPLEX BEING DEVELOPED BY FIDATOCITY HOMES PVT. LTD. AND OTHER'S IN COLLABORATION WITH FIDATOCITY HOMES PVT. LTD.

PRINCIPAL ARCHITECTS:-
ACPL
ACPL Design Ltd.

CONSULTING ARCHITECTS:-
SACHDEVA CONSULTANTS.

ARCHITECT'S SEAL & SIGNATURE
OWNER'S SEAL & SIGNATURE

For Fidatocity Homes Pvt. Ltd.
Director/Authorised Signatory

Scale:-
Drawing Title:-
Drawing No:-

LOWER PENTHOUSE 39TH FLOOR PLAN TOWER-C&D

23