


FIRST FLOOR AREA CALCULATION						
S. No.	COEFF.	Dim (m)	X	Dim (m)	Nos.	Area (SQM)
F1	0.667	1.120	X	0.380	12	3.407
F2	0.5	1.040	X	0.815	6	2.543
F3	(4.975+5.550)/2	X	0.575		3	9.078
F4	1	5.550	X	1.350	1	22.478
F5	1	10.400	X	5.775	1	60.060
F5A	1	0.400	X	0.300	3	0.360
F6	1	9.525	X	1.925	3	55.007
F7	(1.925+1.350)/2	X	0.575		3	2.825
F8	1	2.525	X	5.775	3	43.746
F8A	1	2.225	X	5.775	2	25.699
F9	1	6.875	X	8.150	1	56.031
F10	1	4.175	X	1.825	3	22.858
F11	(4.510+4.000)/2	X	8.175		1	34.785
F12	0.5	7.400	X	18.490	1	68.413
F13	0.5	4.875	X	15.830	1	38.586
F14	0.5	8.160	X	18.490	1	75.439
F15	0.5	15.675	X	4.985	1	39.070
F16	(2.415+1.630)/2	X	8.175		1	16.534
F17	1	15.050	X	8.150	2	245.315
F18	(2.170+1.625)/2	X	8.175		1	15.512
FA	0.667	0.815	X	0.160	3	0.261
TOTAL ADDITION AREA (A)						838.004

DEDUCTION AREA						
S. No.	COEFF.	Dim (m)	X	Dim (m)	Nos.	Area (SQM)
D1	1	1.825	X	0.450	3	2.464
D2	1	0.325	X	1.750	3	1.706
D3	1	2.125	X	1.675	3	10.678
D4	1	0.890	X	1.525	3	4.072
D5	0.5	1.070	X	1.850	1	0.990
D6	1	2.175	X	2.200	6	28.710
D7	0.5	1.090	X	1.915	1	1.044
D8	1	1.200	X	0.400	1	0.480
D9	1	1.570	X	0.400	1	0.628
D10	(3.175+3.700)/2	X	1.405		1	4.830
D11	0.5	2.110	X	1.230	1	1.298
D12	0.5	2.110	X	1.055	1	1.113
D13	(1.200+1.500)/2	X	0.520		1	0.702
D14	0.5	2.005	X	1.155	1	1.158
D15	(1.155+1.875)/2	X	1.250		1	1.894
D16	(2.660+1.410)/2	X	6.020		1	12.251
D17	0.5	6.120	X	3.040	1	9.302
D18	0.5	2.100	X	1.210	2	2.541
D19	(2.560+4.790)/2	X	3.860		1	14.186
D20	(1.230+4.790)/2	X	2.060		1	6.201
D21	(1.520+2.600)/2	X	0.620		1	1.277
D22	1	2.600	X	2.095	1	5.447
D23	1	2.100	X	3.200	1	6.720
D24	(1.755+1.195)/2	X	0.975		1	1.438
D25	0.5	1.120	X	1.945	1	1.089
D26	0.5	1.775	X	1.025	1	0.910
D27	0.5	1.850	X	1.070	1	0.990
D28	1	5.050	X	5.150	3	78.023
D29	(5.150+4.575)/2	X	0.575		3	8.388
D30	0.5	6.260	X	3.035	1	9.500
D31	(0.650+4.415)/2	X	5.800		1	14.689
D32	1	0.100	X	4.415	1	0.442
D33	0.5	5.960	X	2.980	1	8.880
TOTAL DEDUCTION AREA (D)						244.037
TOTAL NET F.A.R. AREA (F1-D1) = F						593.968

NON FAR AREA DIAGRAM


1ST. FLOOR NON FAR AREA CALCULATION						
D10	(3.175+3.700)/2	X	1.405			4.830
D11	0.5	2.110	X	1.230		1.298
D12	0.5	2.110	X	1.055		1.113
D13	(1.200+1.500)/2	X	0.520			0.702
D16	(2.660+1.410)/2	X	6.020			12.251
D17	0.5	6.120	X	3.040		9.302
D18	0.5	2.100	X	1.210	2	2.541
D19	(2.560+4.790)/2	X	3.860			14.186
D20	(1.230+4.790)/2	X	2.060			6.201
D21	(1.520+2.600)/2	X	0.620			1.277
D22	1	2.600	X	2.095		5.447
TOTAL NON FAR AREA (N)						59.147

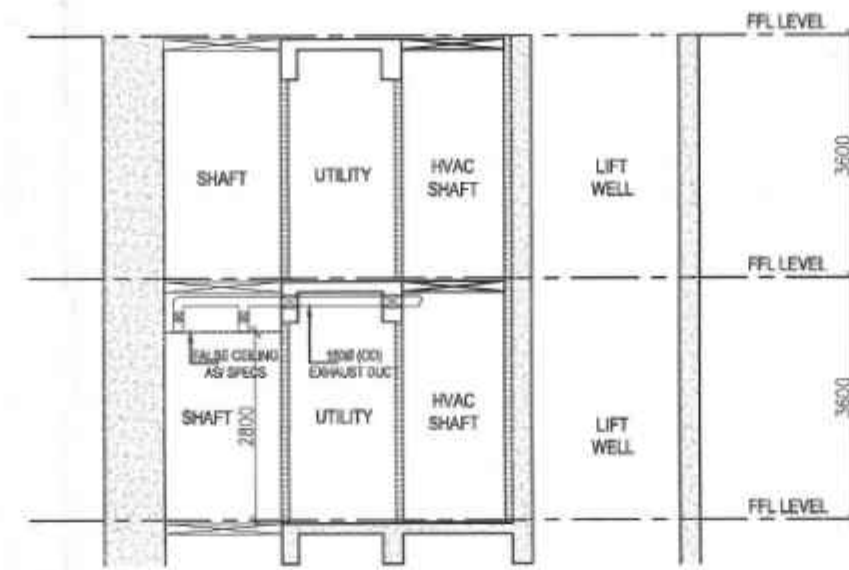

TYPICAL MECHANICAL VENTILATION SECTION 1 FOR W.C.

TYPICAL MECHANICAL VENTILATION CALCULATION FOR W.C.									
S.NO.	LOCATION	AREA	HEIGHT	VOLUME	DESIGN CFM	SELECTED EXHAUST FAN	FAN SIZE	EXHAUST DUCT SIZE	
		(Sq.ft.)	(ft.)	(Cu.ft.)	CFM		LXBXH (mm)	DIAMETER (mm)	
1	TYPICAL MECHANICAL VENTILATION FOR W.C.								
1.1	1 W.C.	20.1	9.2	184.9	50	1# 100 cfm cassette inline fan	270x270x171	150 (OD)	
1.2	2 W.C.	20.1	9.2	184.9 x 2	50 x 2	1# 100 cfm cassette inline fan	270x270x171	150 (OD)	

FIRST FLOOR AREA DIAGRAM

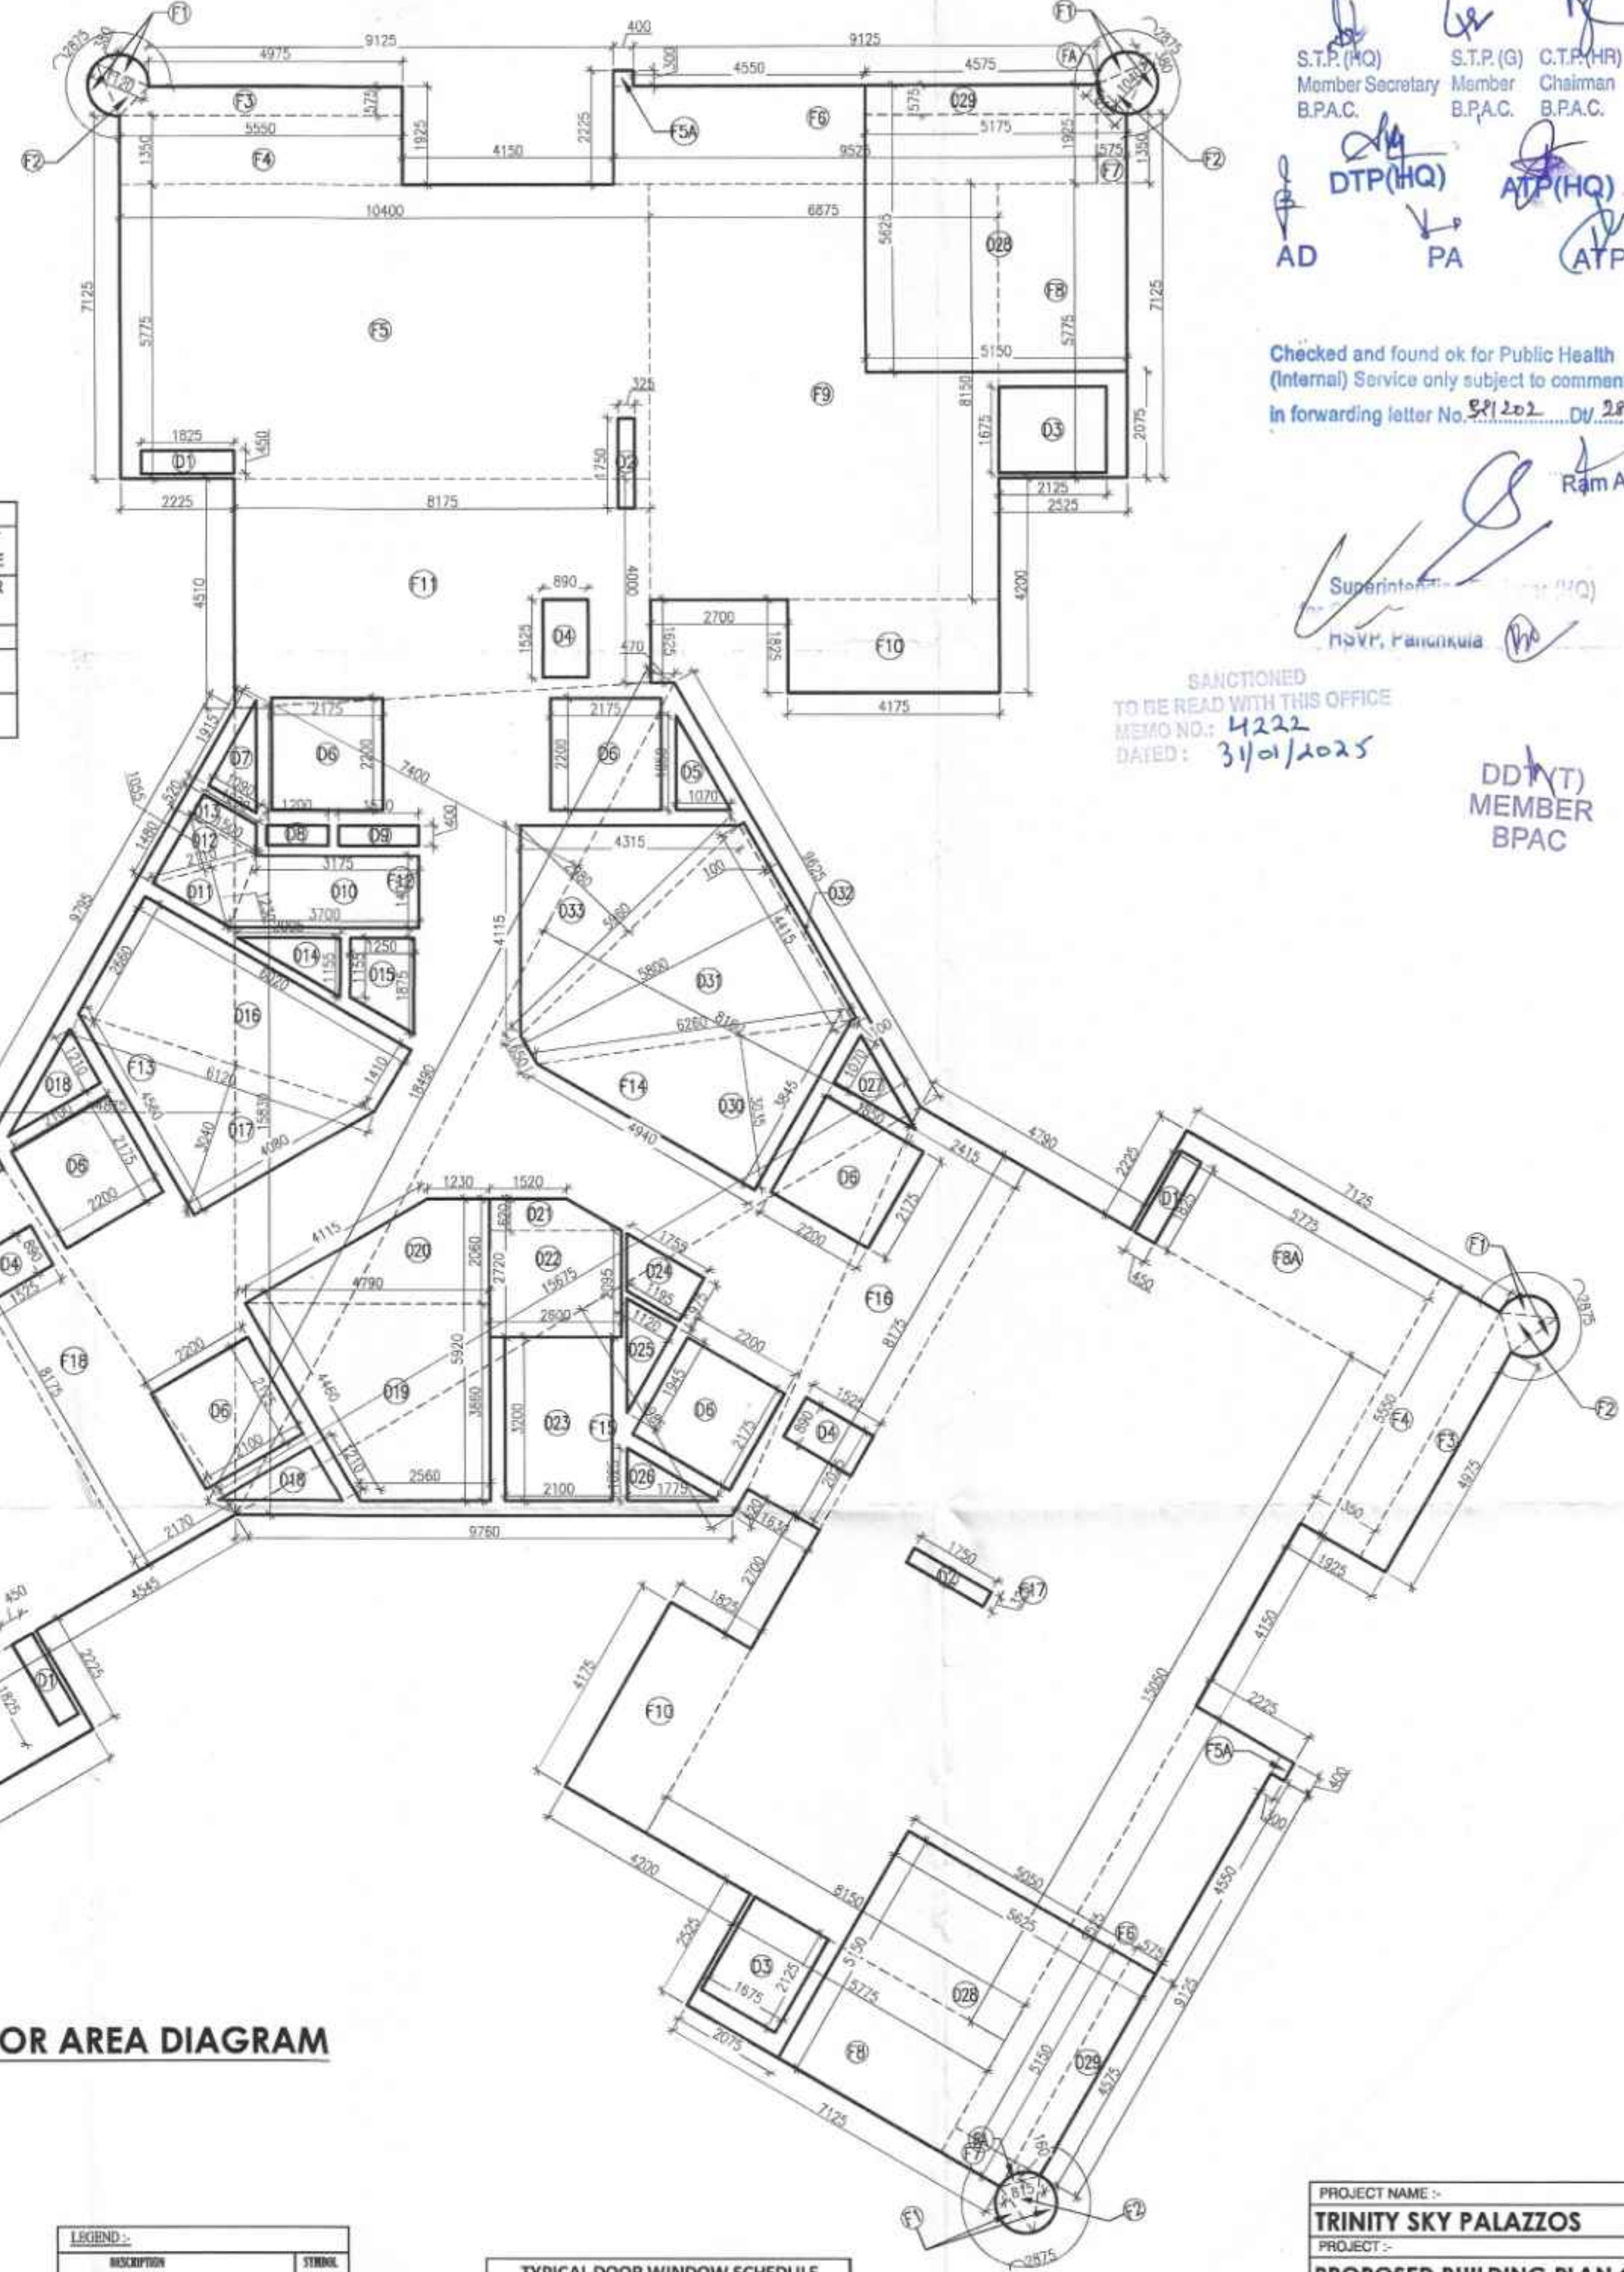

S.T.P.(HQ) S.T.P.(G) C.T.P.(HQ)
Member Secretary Member Chairman
B.P.A.C. B.P.A.C. B.P.A.C.

Checked and found ok for Public Health
(Internal) Service only subject to comments in
in forwarding letter No. 891202, Dtd. 28/11/24

Ram Avtar Bassi
JD(HQ)

Supervisor
Navyr, Panjvalia

SANCTIONED
TO BE READ WITH THIS OFFICE
MEMO NO. 4222
DATED: 31/01/2025

DD(T)
MEMBER
BPAC

DETAIL SECTION - A

FIRST FLOOR PLAN

FIRE LEGEND:-	
A	100% FIRE RESISTANT PIPE LOW DOME
B	RAMP DRAIN PIPE
C	CO. TYPE FIRE EXTINGUISHERS 4.5KG
D	9 Ltr. M.F. TYPE CO. FIRE EXTINGUISHER
E	FLOOR DRAIN PIPE
F	FIRE ALARM
G	FIRE HOSE CABINET (FHC)

LEGEND:-	
DESCRIPTION	SYMBOL
110mm A.P.C. COIL & TEST PIPE	1
110mm A.P.C. WASTE & TEST PIPE	2
110mm A.P.C. EXTERIOR WASTE & TEST PIPE	3a
110mm A.P.C. EXTERIOR WASTE & TEST PIPE	3b
110mm A.P.C. COIL & TEST PIPE	4
110mm A.P.C. WASTE PIPE	5
110mm A.P.C. WASTE PIPE	6
110mm A.P.C. WASTE PIPE	7
110mm A.P.C. WASTE PIPE	100

TYPICAL DOOR WINDOW SCHEDULE					
NAME	WIDTH	HEIGHT	CHL	LINTEL	
D1	1500	2400	0	2400	
D2	1000	2400	0	2400	
D3	800	2400	0	2400	
W1	1600	1800	600	2400	
V1	600	1200	1200	2400	
SD1	2750	2400	0	2400	
SD2	4300	2400	0	2400	
SD3	1350	2400	0	2400	
SD4	1675	2400	0	2400	
SD5	4575	2400	0	2400	
SD6	3500	2400	0	2400	
SD7	4150	2400	0	2400	
DW1	1750	2400	00/1050	2400	
G1	4150	2400	0	2400	
G2	3500	2400	0	2400	
G3	4300	2400	0	2400	
G4	2800	2400	0	2400	
G5	4575	2400	0	2400	
GD1	4110	5100	0	5100	
FD1	1200	2400	0	2400	
FD2	1250	2400	0	2400	
FD3	1500	2400	0	2400	
FH	900	2400	0	2400	
GS	2400	1500	0	2400	

ALL MAIN UNIT DOOR -
ONE HR FIRE RATING

PROJECT NAME:-
TRINITY SKY PALAZZOS

PROPOSED BUILDING PLAN OF GROUP
HOUSING MEASURING 10.84375
ACRES (LICENCE NO. 130 OF 2024
DATED 24.10.2024) IN SECTOR-88B,
GURUGRAM MANESAR URBAN
COMPLEX BEING DEVELOPED BY
FIDATOCITY HOMES PVT. LTD. AND
OTHER'S IN COLLABORATION WITH
FIDATOCITY HOMES PVT. LTD.

PRINCIPAL ARCHITECTS:-
ACPL
ACPL Design Ltd.
CONSULTING ARCHITECTS
SACHDEVA CONSULTANTS.

ARCHITECT'S SEAL & SIGNATURE: _____ OWNER'S SEAL & SIGNATURE: _____

For Fidatocity Homes Pvt. Ltd.
Director/Authorized Signatory

Scale: 1:100
Drawing Title: **FIRST FLOOR PLANS (TYP. TOWER C&D)** Drawing No: 16