



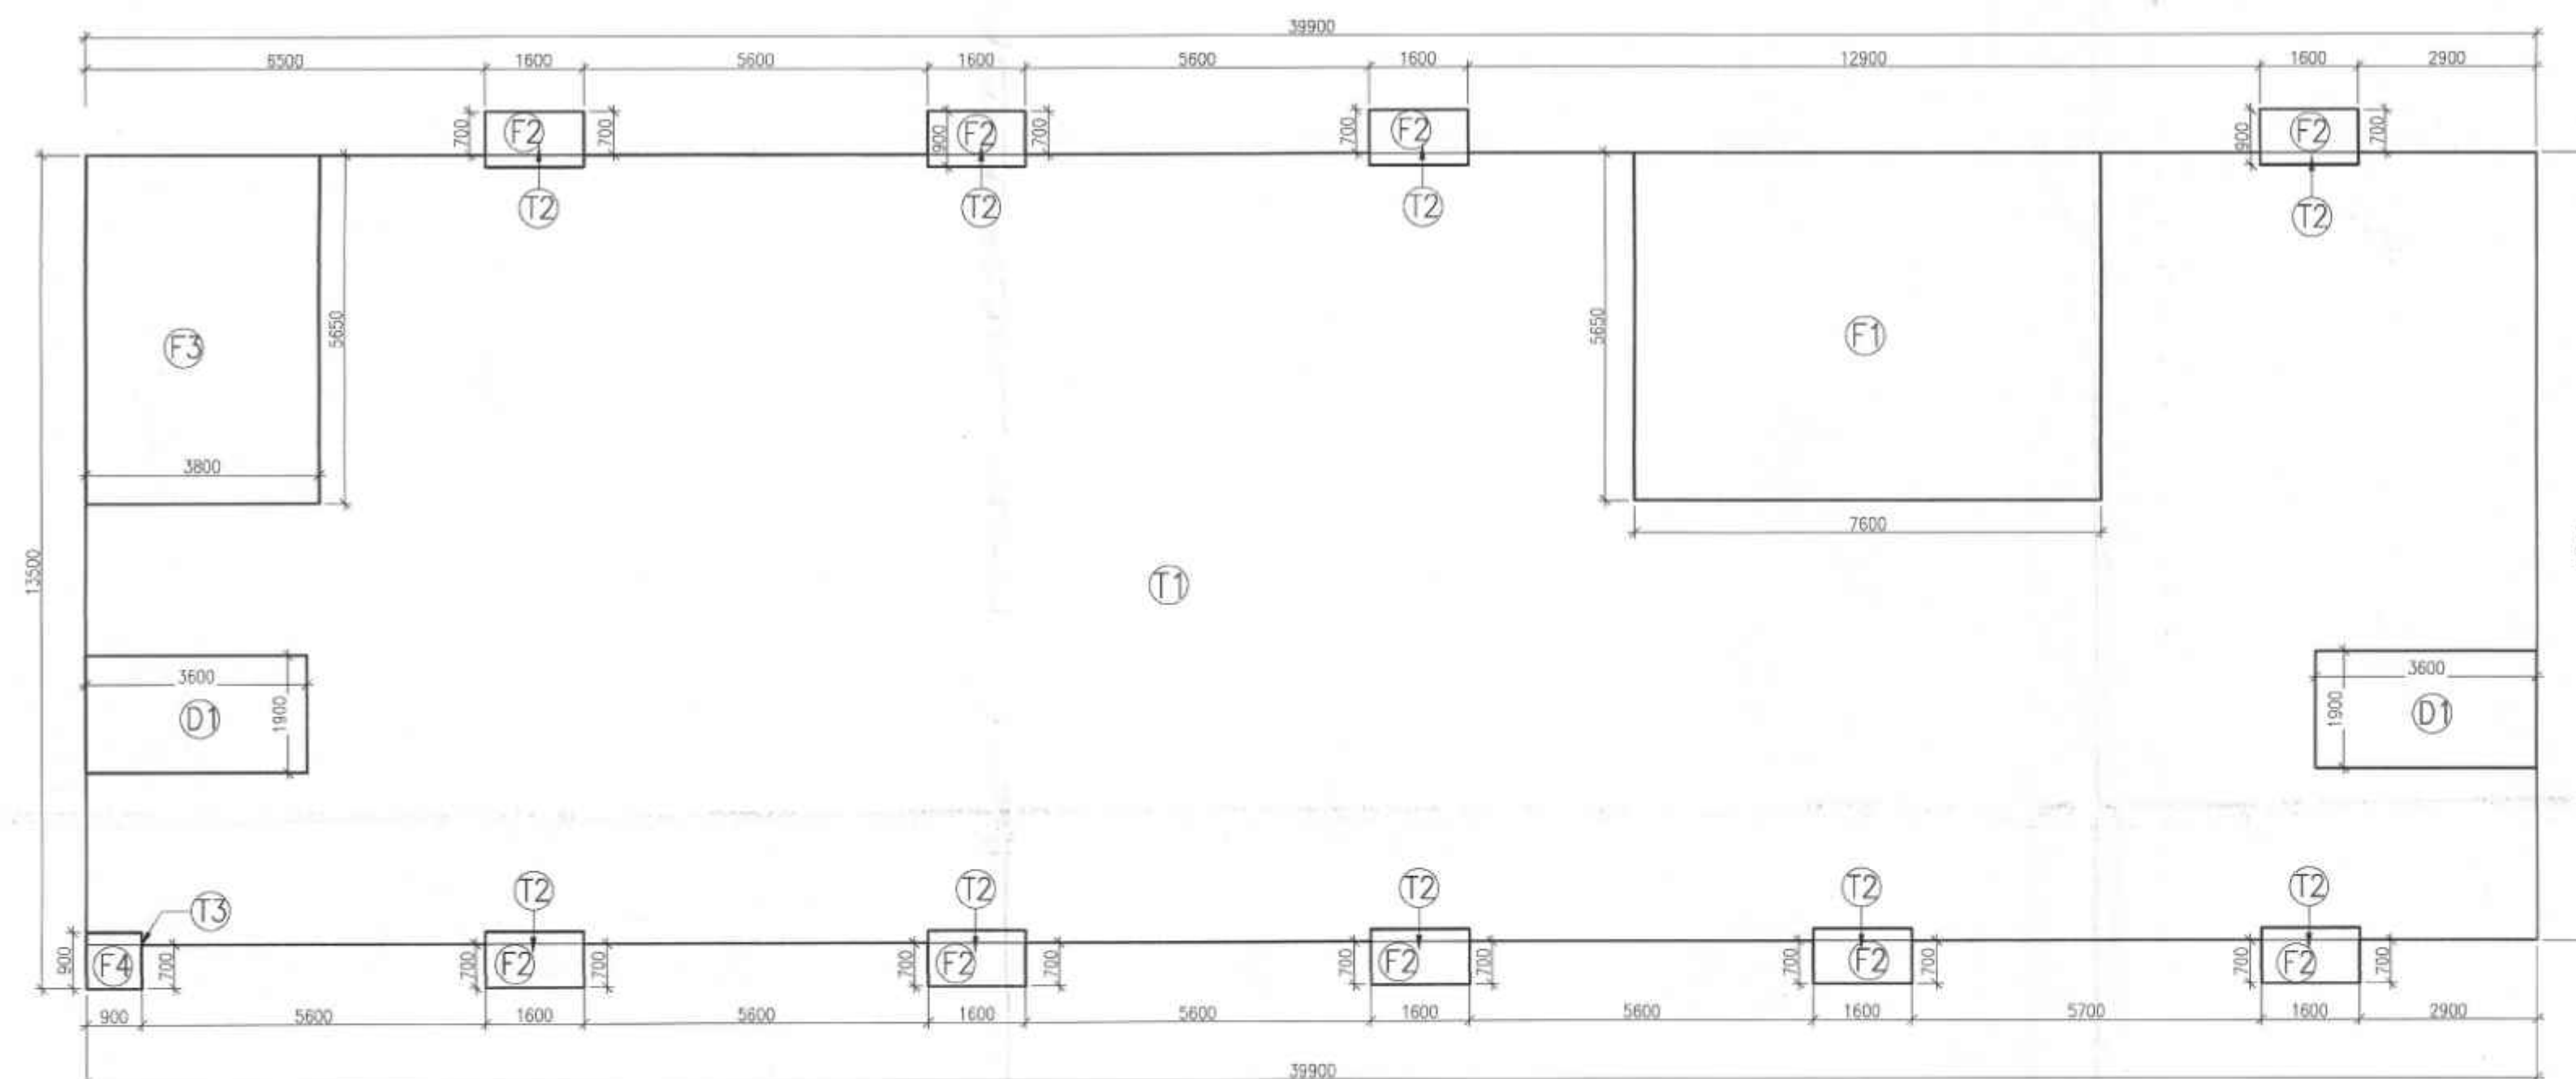

STILT FLOOR AREA DIAGRAM

STILT FLOOR AREA DIAGRAM

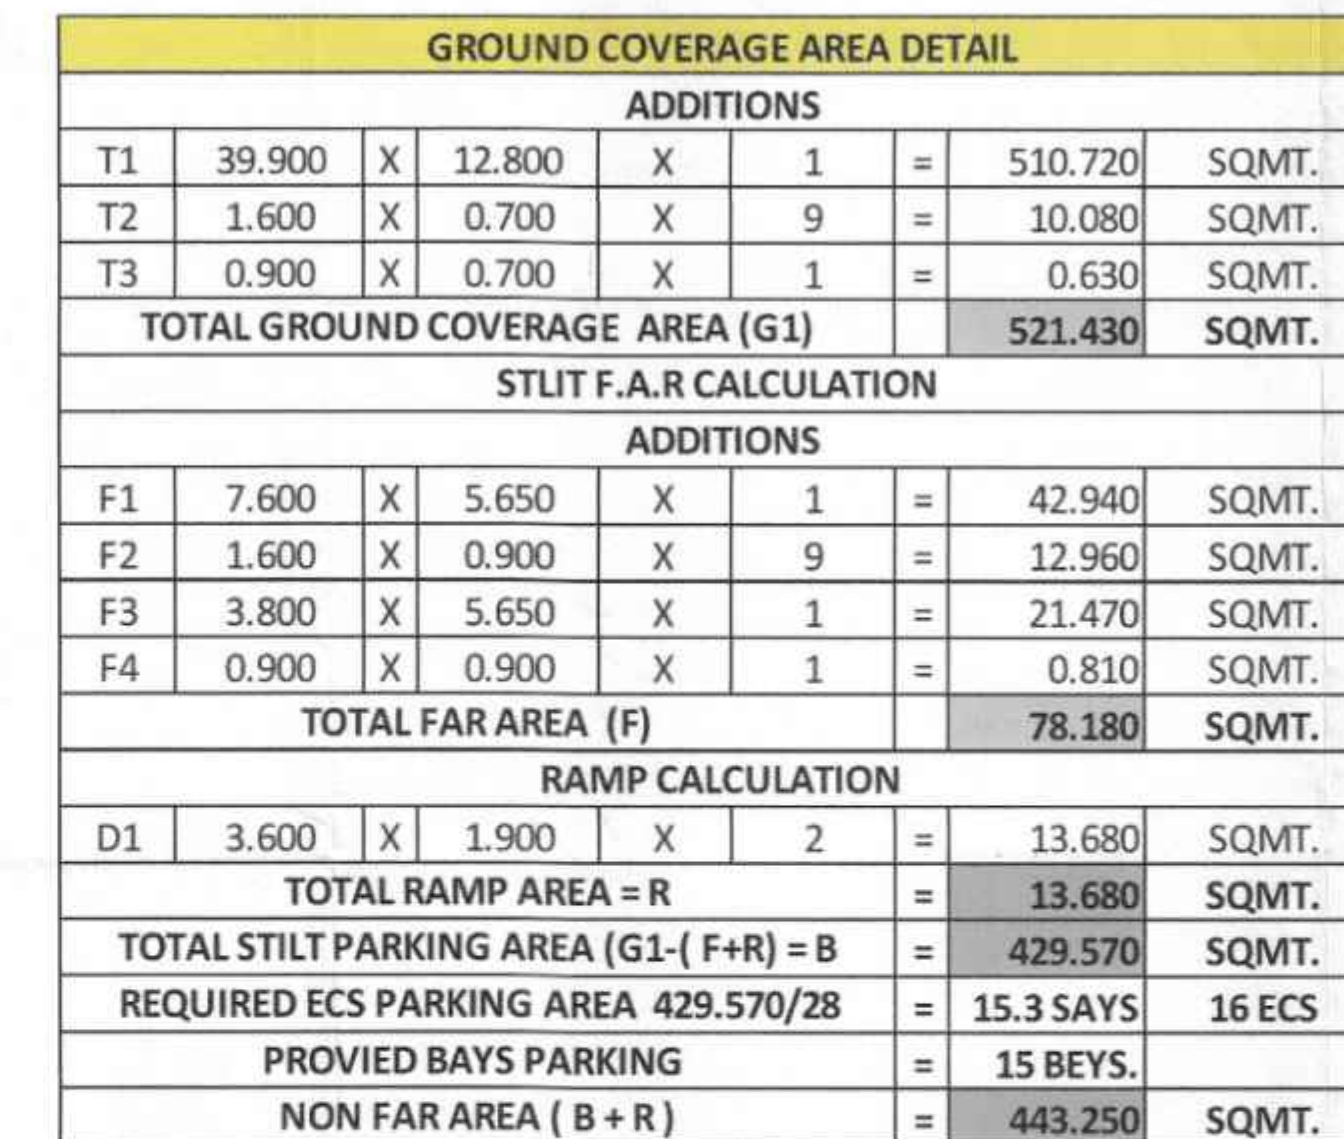


 S.T.P. (HQ)
 S.T.P. (G)
 C.T.P. (HR)
 Member Secretary Member Chairman
 B.P.A.C. B.P.A.C.
 DTP (HQ)
 AD
 PA
 ATP

 Ram Avtar Bassi
 JD(HQ)

DDT (T)
MEMBER
BPAC

 
LEGEND	SYMBOL
SEWAGE MAIN	
100 ØPVC SOIL & VENT PIPE	
100 ØPVC WASTE & VENT PIPE	
100 ØPVC KITCHEN WASTE & VENT PIPE	
75 ØPVC PIPE (V2)	
160 ØPVC RAIN WATER PIPE	
100 ØBIBBITY & BALCONY RAIN WATER PIPE	
100 ØFLEXIBLY BALCONY RAIN WATER PIPE	
DOMESTIC WATER SUPPLY ON TAP	
FLOODING WATER SUPPLY ON TAP	
DOMESTIC WATER SUPPLY ROOF	
FLOODING WATER SUPPLY ROOF	
PWS DROP	
FLOOR DRAIN (FD)	
FLOOR TRAP (FT)	
BALCONY DRAIN (BD)	
BALCONY DRAIN PIPE	
DOMESTIC WATER SUPPLY (PWS)	
HYDRO-PNEUMATIC DOMESTIC WATER (H2O/W)	
FLOODING WATER SUPPLY (PWS)	
FLOODING WATER SUPPLY ROOF	
DOMESTIC WATER SUPPLY ROOF	
100Ø SOIL PIPE	
100Ø WASTE PIPE	
75Ø VENT PIPE	
RAIN WATER PIPE	
HEALTH FACILET	
ACCESS ROOF (AR)	
DRAIN VALVE / INTERFERRY VALVE	

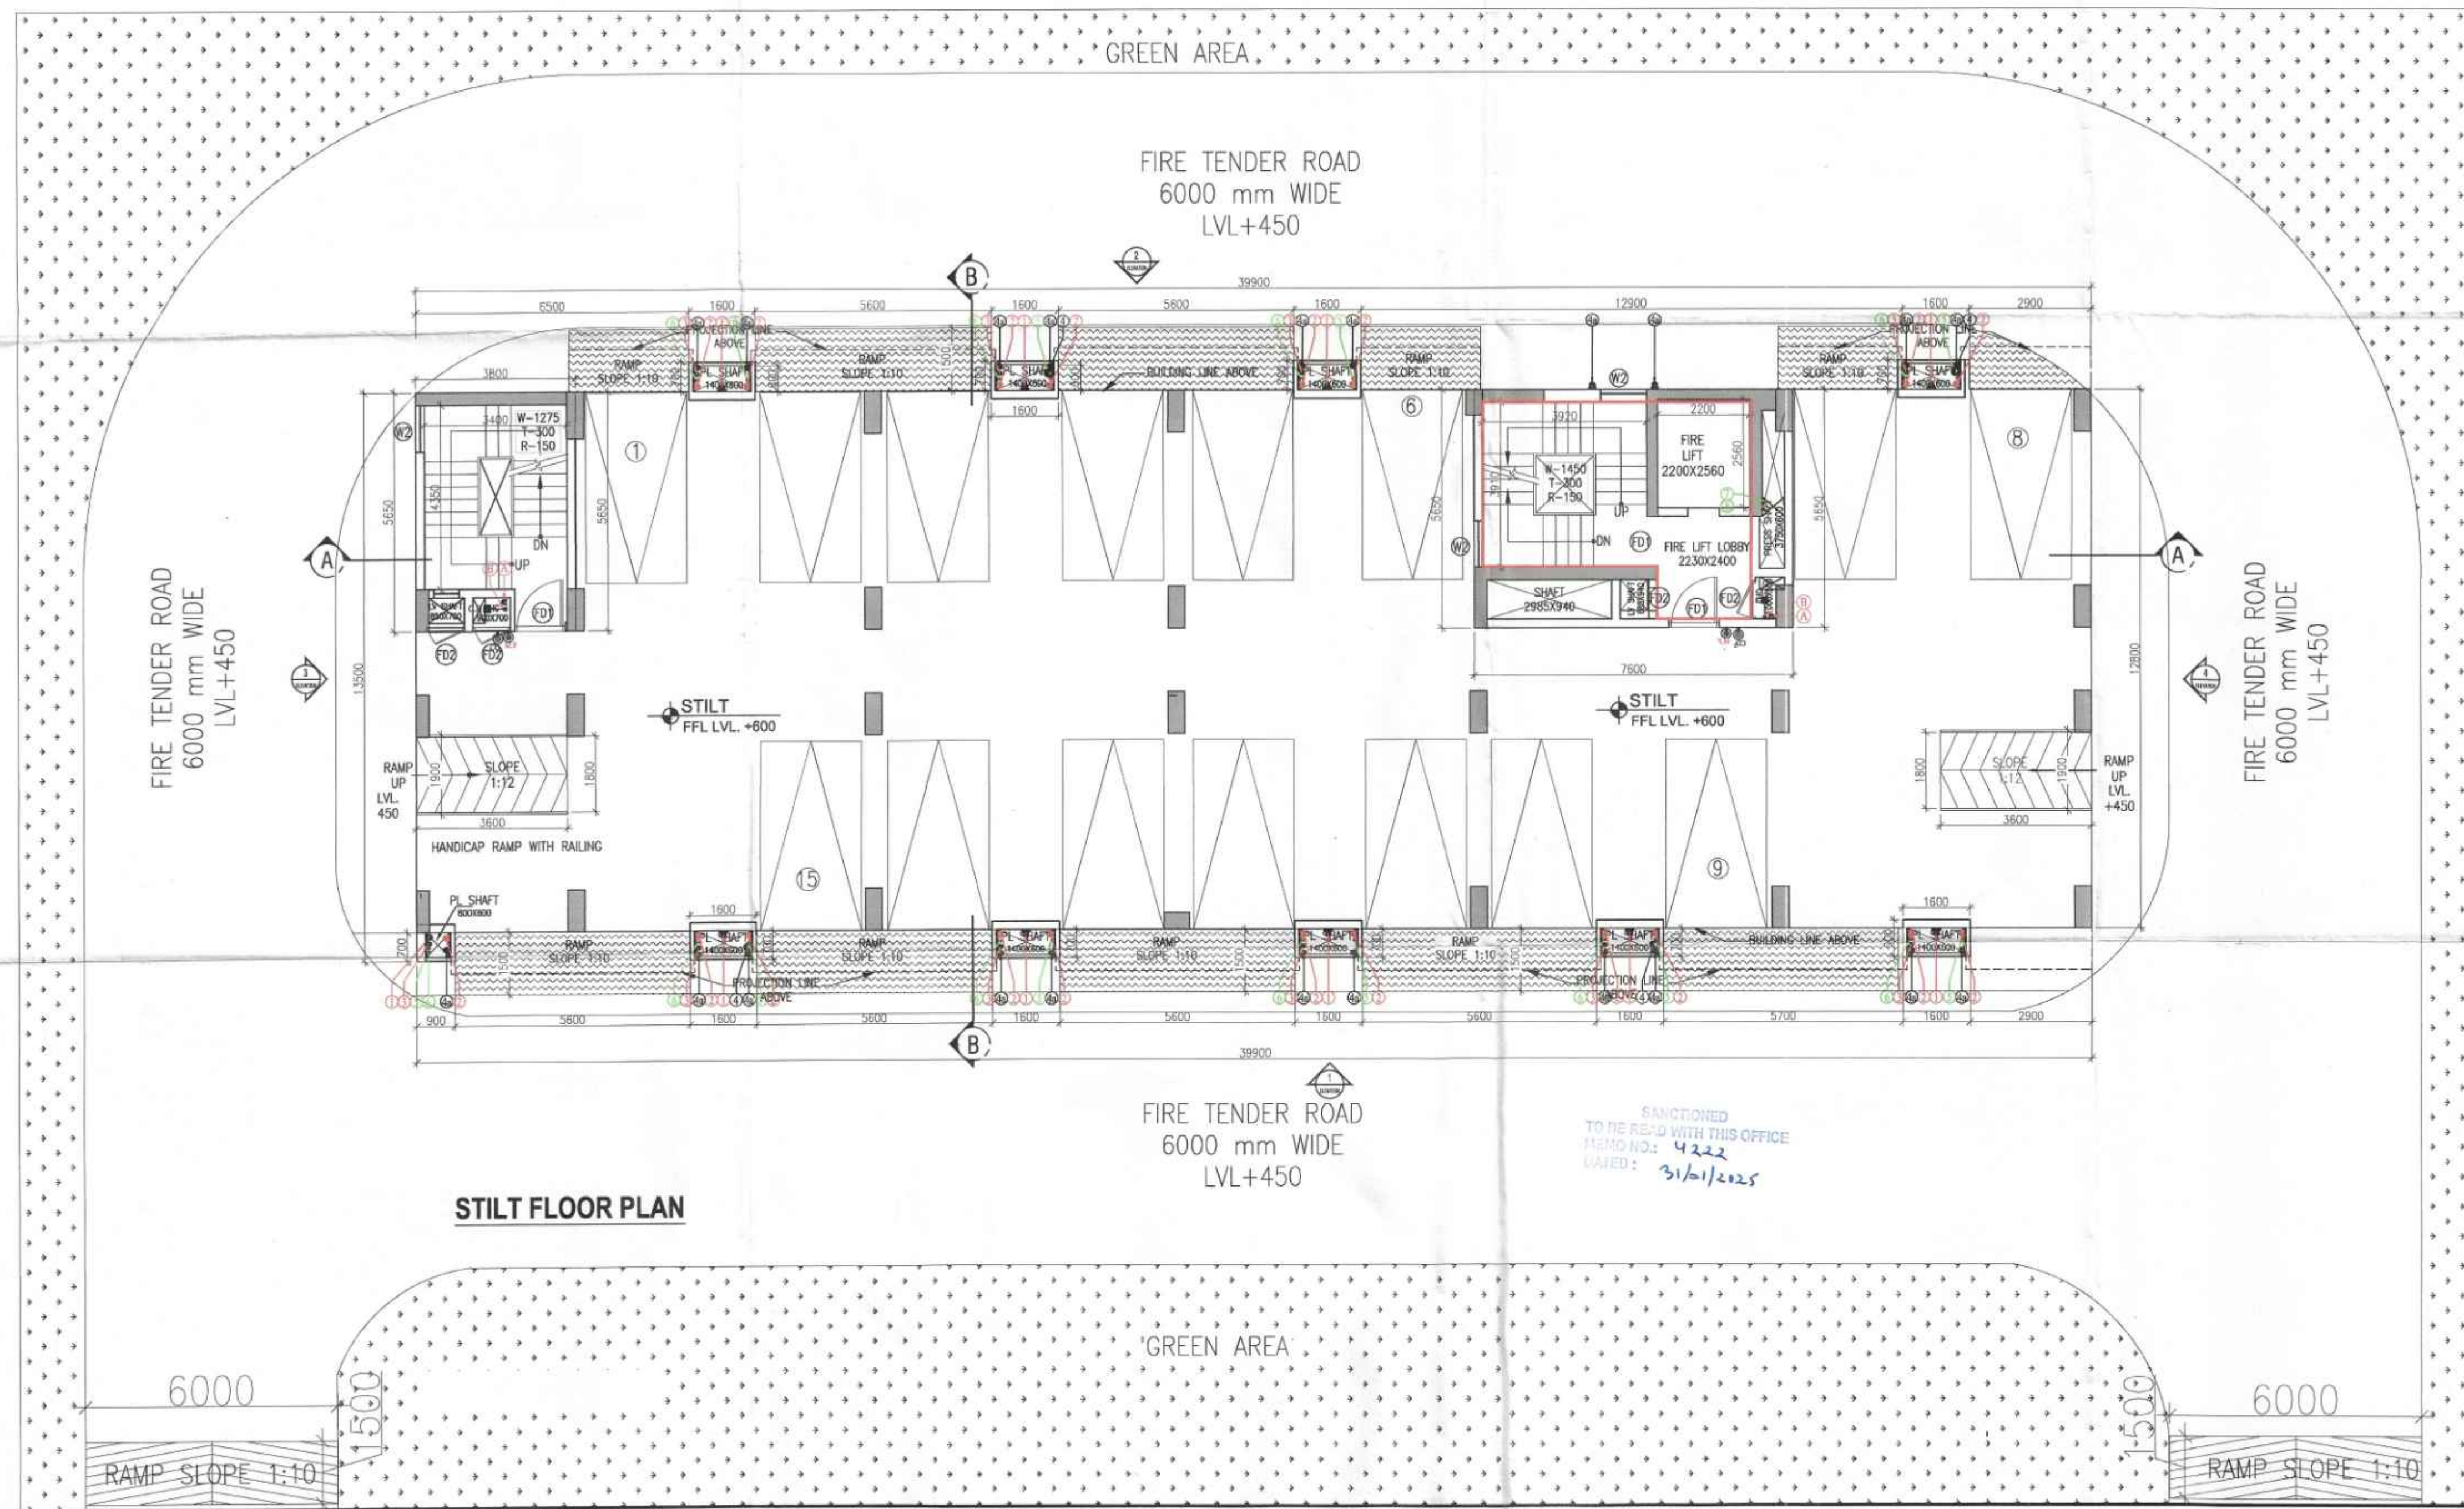

STILT FLOOR PLAN

SANCTIONED
TO BE READ WITH THIS OFFICE
MEMO NO: 4222
DATED: 31/01/2025

FIRE LEGEND:-	
A.	100# FIRE HYDRANT PIPE LOW ZONE.
B.	800 DRAIN PIPE
	CO ₂ TYPE FIRE EXTINGUISHERS 4.5KG.
	9 Ltr. M.F. TYPE CO ₂ FIRE EXTINGUISHER
FLD	FLOOR DRAIN PIPE
FD	FIRE DOOR
	FIRE HOSE CABINET (FHC).

PROJECT NAME :-	
TRINITY SKY PALAZZOS	
PROJECT :-	
PROPOSED BUILDING PLAN OF GROUP HOUSING DEVELOPMENT 10.84375 ACRES (LICENCE NO. 130 OF 2024 DATED 24.10.2024) IN SECTOR-88B, GURUGRAM MANESAR URBAN COMPLEX BEING DEVELOPED BY FIDATOCITY HOMES PVT. LTD. AND OTHER'S IN COLLABORATION WITH FIDATOCITY HOMES PVT. LTD.	
PRINCIPAL ARCHITECTS :-	
 ACPL ACPL Design Ltd REGD. OFFICE Architects/Engineers Planning 110, Sector-88B New Manesar (Gurgaon) India Pin Code - 122008 E-mail: info@acplindia.com P: 0124-2561200	
CONSULTING ARCHITECTS	
SACHDEVA CONSULTANTS.	
ARCHITECT'S SEAL & SIGNATURE	OWNER'S SEAL & SIGNATURE
 MEET SACHDEVA ARCHITECT CA/97621743	 For Fidatocity Homes Pvt Ltd Director/Authorised Signatory
Scale :	1 : 100
Drawing Title:-	Drawing No:-
GROUND FLOOR (TOWER-EWS)	
26	