



PLUMBING LEGEND :-	
①	110 (OD) UPVC SOIL & VENT PIPE
②	110 (OD) UPVC WASTE & VENT PIPE
③	110 (OD) UPVC RAIN WATER DN TAKE PIPE
④	75 (OD) UPVC RAIN WATER DN TAKE PIPE
⑤	DOMESTIC WATER SUPPLY DN TAKE PIPE
⑥	FLUSHING WATER SUPPLY DN TAKE PIPE
⑦	400 DOM. WATER SUPPLY RISER TO OHT.
⑧	320 FLU. WATER SUPPLY RISER TO OHT.
FLUSHING WATER SUPPLY LINE	
DOMESTIC WATER SUPPLY LINE	
MOTORIZED VALVE	
BALL VALVE	
FLOOR TRAP (100x100)MM	
FLOOR DRAIN (100x50)MM	
CUTOUT IN SLAB WALL	
R.W KHURRA 450x450mm	

DOOR WINDOW SCHEDULE				
NAME	WIDTH	CHL	LINTEL	LOCATION
FD	1250	00	2100	STAIRCASE 1100 FIRE RATING
FH	900	00	2100	FHC
D1	1000	00	2100	UNIT ENTRY
D2	750	00	2100	TOILET
D3	1250	00	2100	STAIRCASE
DW1	1750	00/900	2400	BALCONY
W1	1200	900	2400	STAIRCASE
V1	600	1200	2400	TOILET

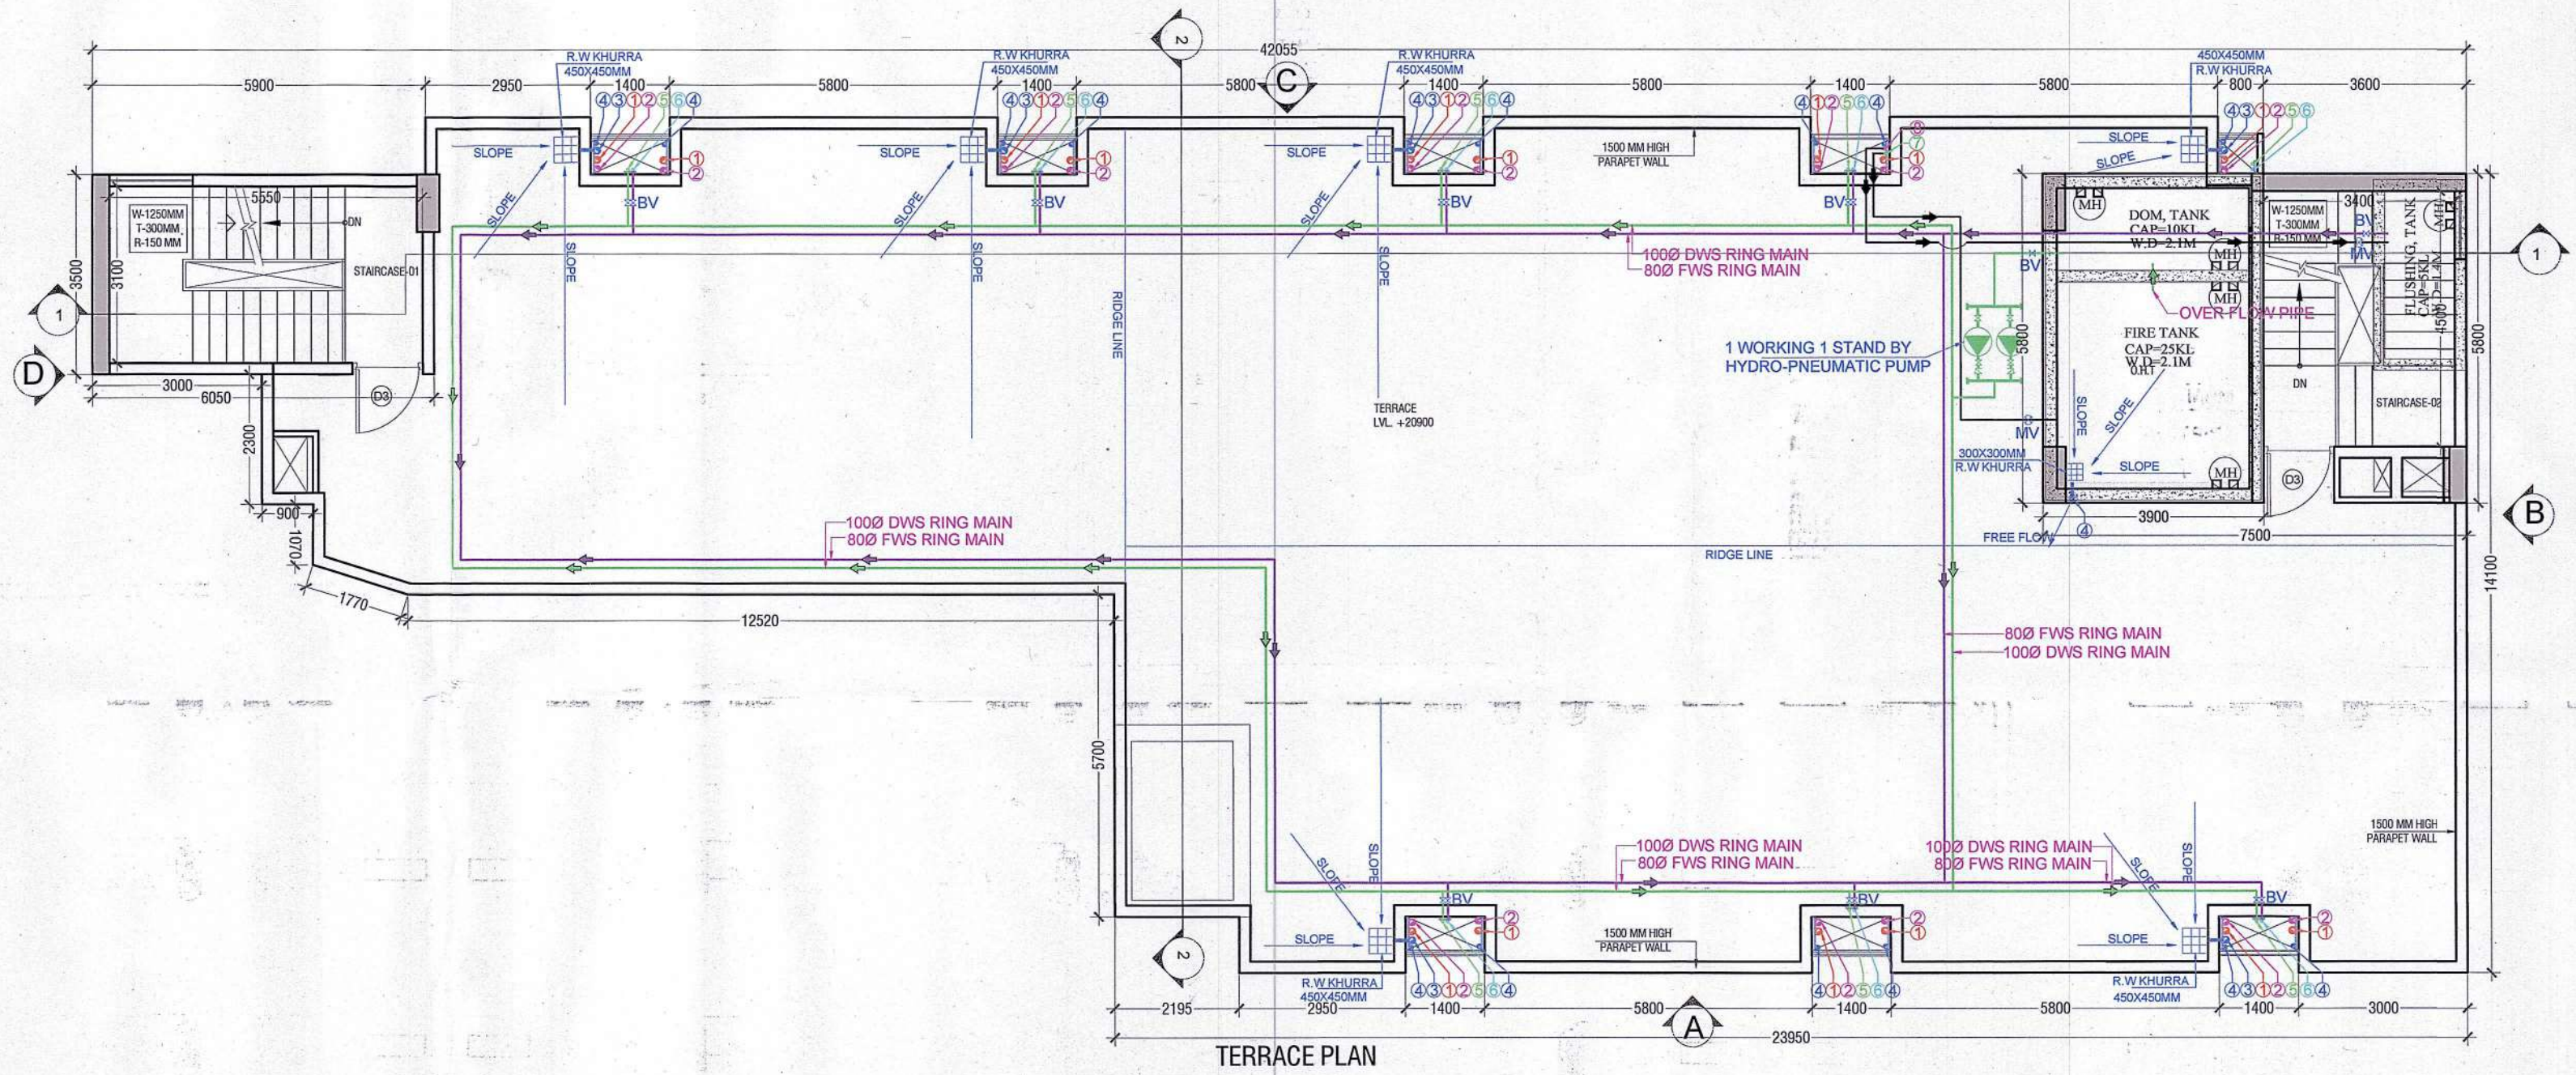

MUMTY & OHT AREA CALCULATIONS				
S. No.	DESCRIPTION	WIDTH	LENGHT	AREA IN SQMT
1	A1	7.500	5.800	43.500
2	A2	6.050	3.500	21.175
TOTAL ADDITION (A)				64.675

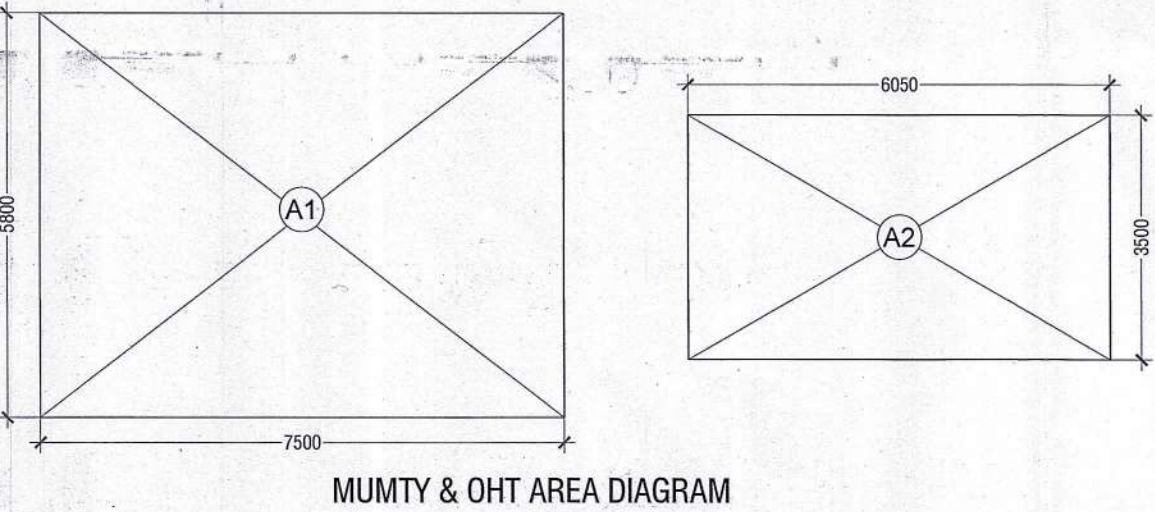

SANCTIONED
TO BE READ WITH THIS OFFICE
MEMO NO.:
DATED :

S.T.P. (HQ) Member Secretary B.P.A.C.
S.T.P. (G) Member B.P.A.C.
C.T.P. (H.R) Chairman B.P.A.C.

DTP (HQ) AD
PA
ATP (HQ) ATP

Ram Ahar Bansi
JD (HQ) DDT (T) MEMBER BPAC


Checked and found ok for Public Health
(Internal) Service only subject to comments in
in forwarding letter No. 165341...DU.20/06/2024

Superintendent Engineer (HQ)
for Chief Engineer-1
HSPV, Panchkula


PLUMBING LEGEND :-

FLUSHING WATER SUPPLY LINE	→
DOMESTIC WATER SUPPLY LINE	→
MOTORIZED VALVE	⊗ MV
BALL VALVE	⊗ BV

SUBMISSION DRAWING

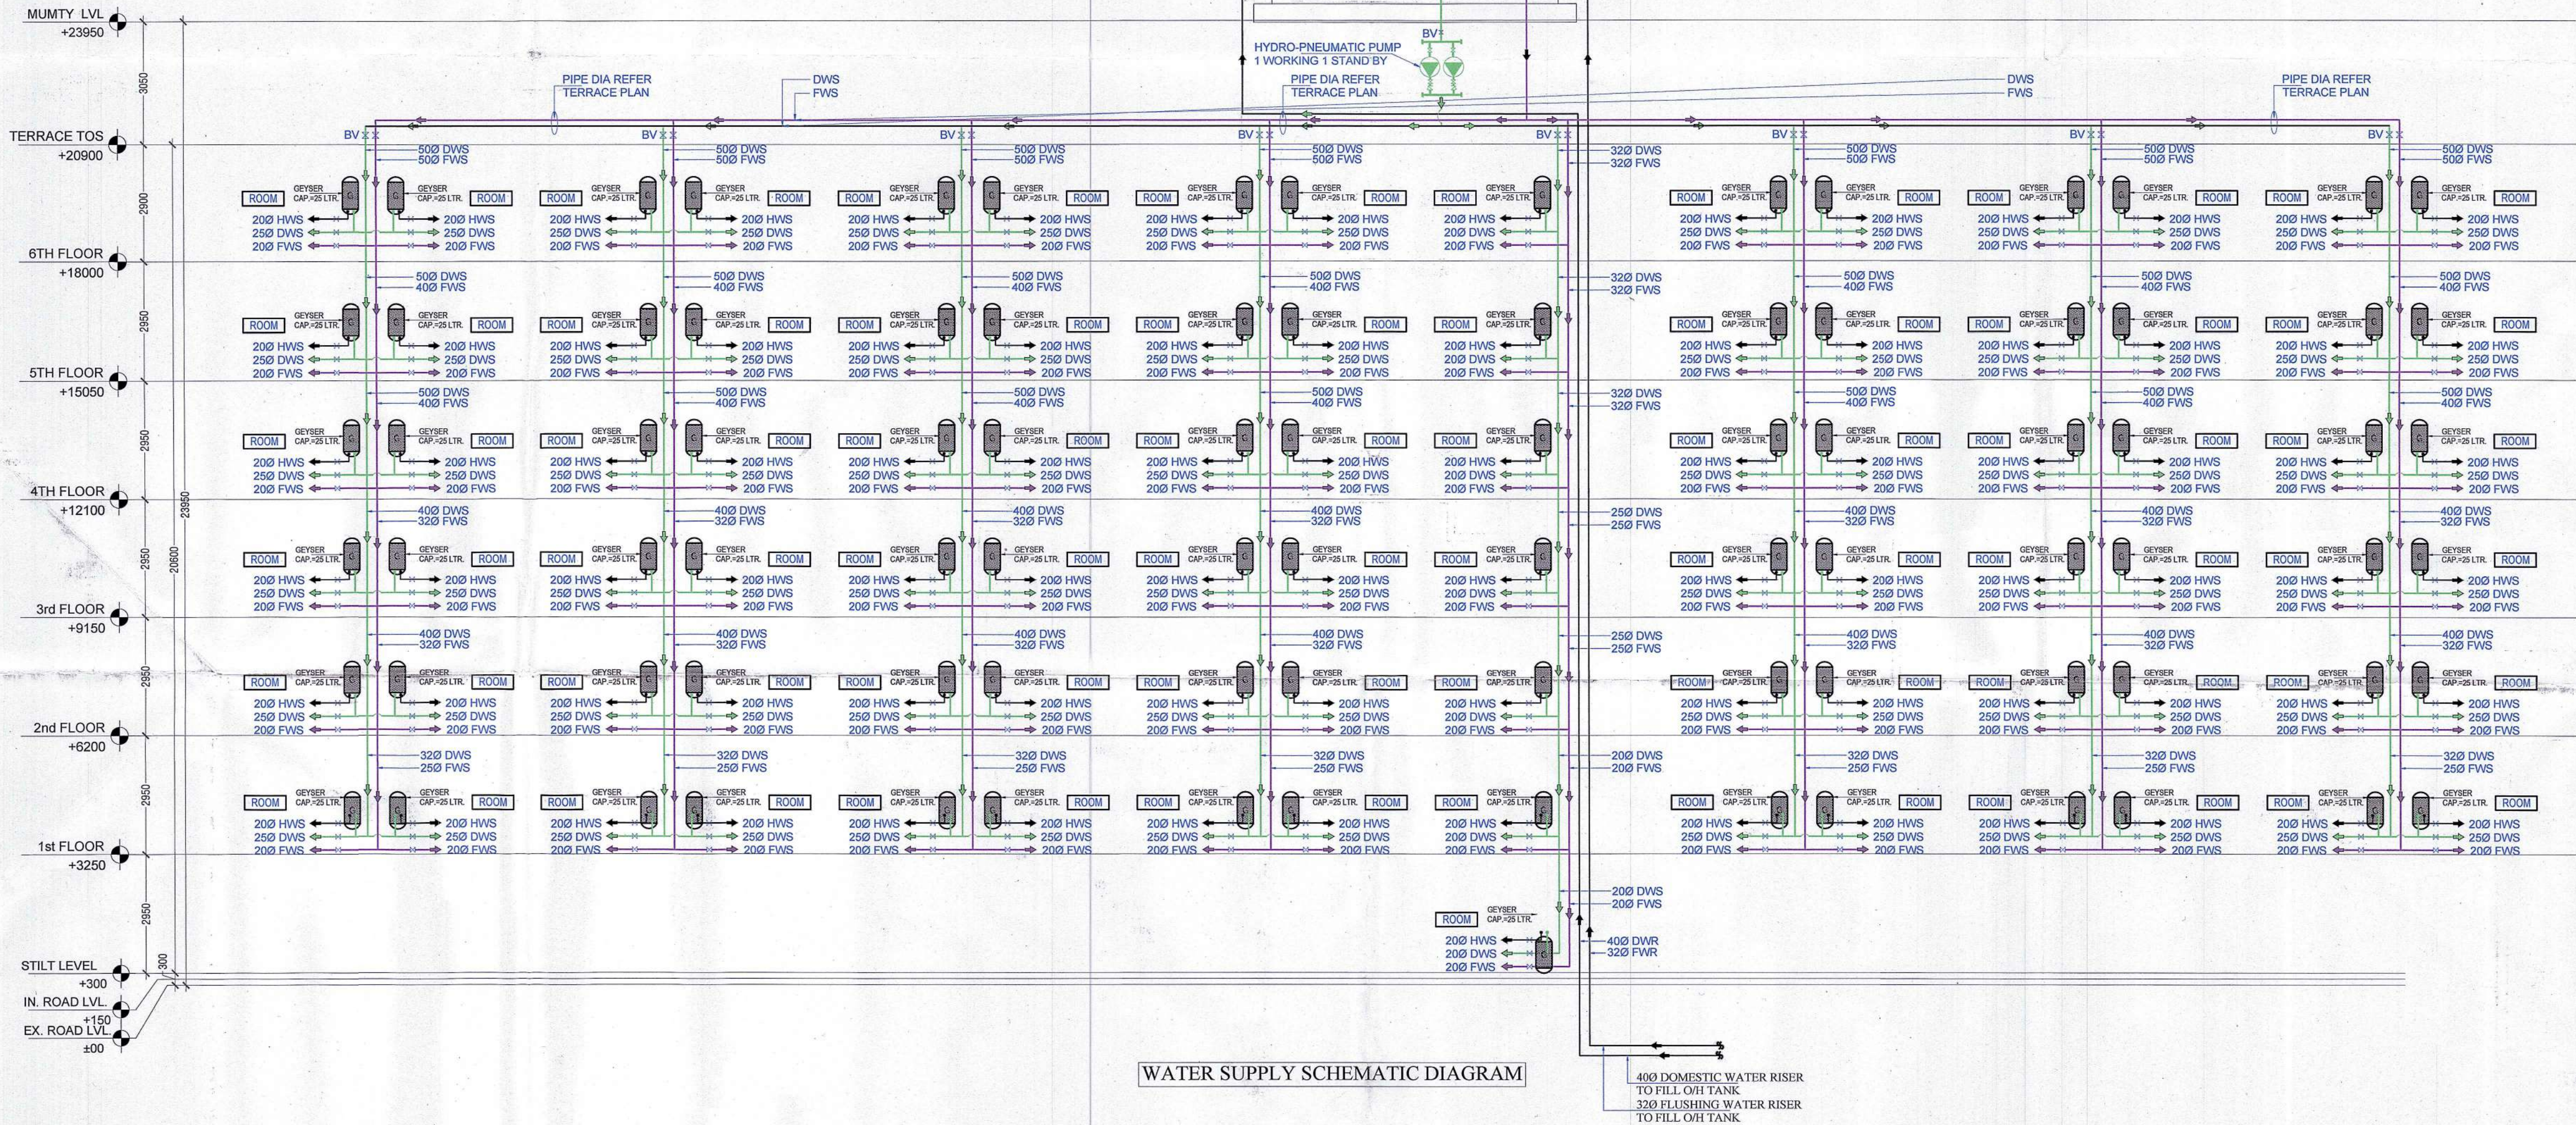

KEY PLAN

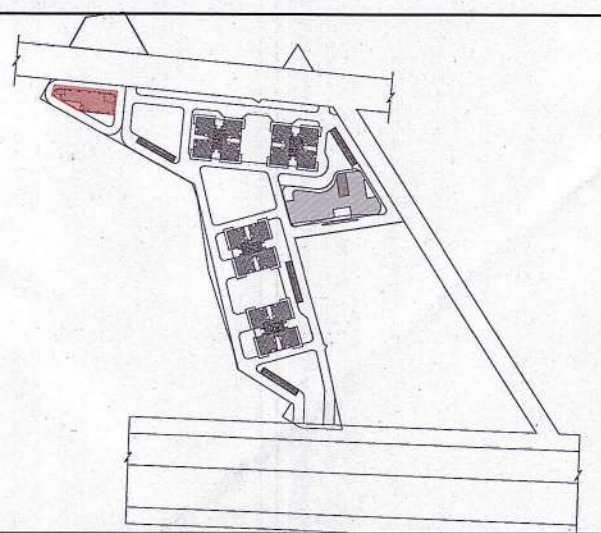

PRINCIPAL ARCHITECT

ACPL ISO 9001:2015
Architecture
Management
Planning
ACPL Design Ltd E-24 South Extension - II, 1st Flr, 24622105
New Delhi 110049, India. +91 11 24645058
E: contact@acplindia.com; +91 11 24645058

CLIENT

NORTH STAR TOWERS PRIVATE LIMITED

PROJECT

PROPOSED BUILDING PLAN OF MIXED LAND USE COLONY UNDER
TOD POLICY (96% RESIDENTIAL AND 4% COMMERCIAL) FOR AN
AREA MEASURING 6.4166 ACRES (LICENCE NO. 265 OF 2023
DATED 19/12/2023) IN THE REVENUE ESTATE OF VILLAGE BADHA
& NAWADA FATEHPUR, SECTOR-90, GURUGRAM, BEING
DEVELOPED BY NORTH STAR TOWERS PRIVATE LIMITED.

For North Star Towers Pvt. Ltd.
KULMEET SHANGAR
ARCHITECT
19/07/2024
Authorised Signatory

OWNER/AUTH. SIGNATURE ARCHITECT'S SIGNATURE

DRAWING TITLE EWS (TERRACE PLAN, MUMTY, MACHINE ROOM
AREA DIAGRAM & AREA DETAILS) & SLD

DRAWING NO. A-23 SCALE : 1:100