



FIRE LINE	
---	EXTERNAL FIRE LINE
---	INTERNAL FIRE LINE
PLUMBING NOTE	
---	STORM WARE
---	STORM LINE
---	DOMESTIC WATER SUPPLY LINE
---	FLUSHING WATER SUPPLY LINE
---	TANKER WATER SUPPLY LINE
---	MUNICIPAL WATER SUPPLY LINE
---	IRRIGATION WATER SUPPLY LINE

REVISIONS
MEMO NO. 3474
DATE: 27/11/23

NOTES

1. THIS DRAWING SHALL BE READ IN CONJUNCTION WITH THE RELEVANT ARCHITECTURAL, STRUCTURAL, MECHANICAL, ELECTRICAL, PLUMBING, AND SANITARY DRAWINGS. ALL DIMENSIONS SHALL BE BROUGHT TO THE NOTICE OF THE ARCHITECT IMMEDIATELY. THE DRAWING SHALL NOT BE SCALED, ONLY WRITTEN DIMENSIONS SHALL BE USED.
2. THE FINISHED FLOOR LEVELS GIVEN IN THIS DRAWING ARE WITH RESPECT TO THE CENTRE LINE OF THE FRONT ROAD AT THE MOBILE PHASE-1.
3. PLEASE FOLLOW SERVICES DRAWING FOR ELECTRICAL AND SERVICES SHAFT DETAIL.
4. FOR STAIRCASE, LIFT LOBBY, TOILET, KITCHEN, RAILING AND BALCONY PLEASE FOLLOW DETAIL DRAWING.

KEY PLAN

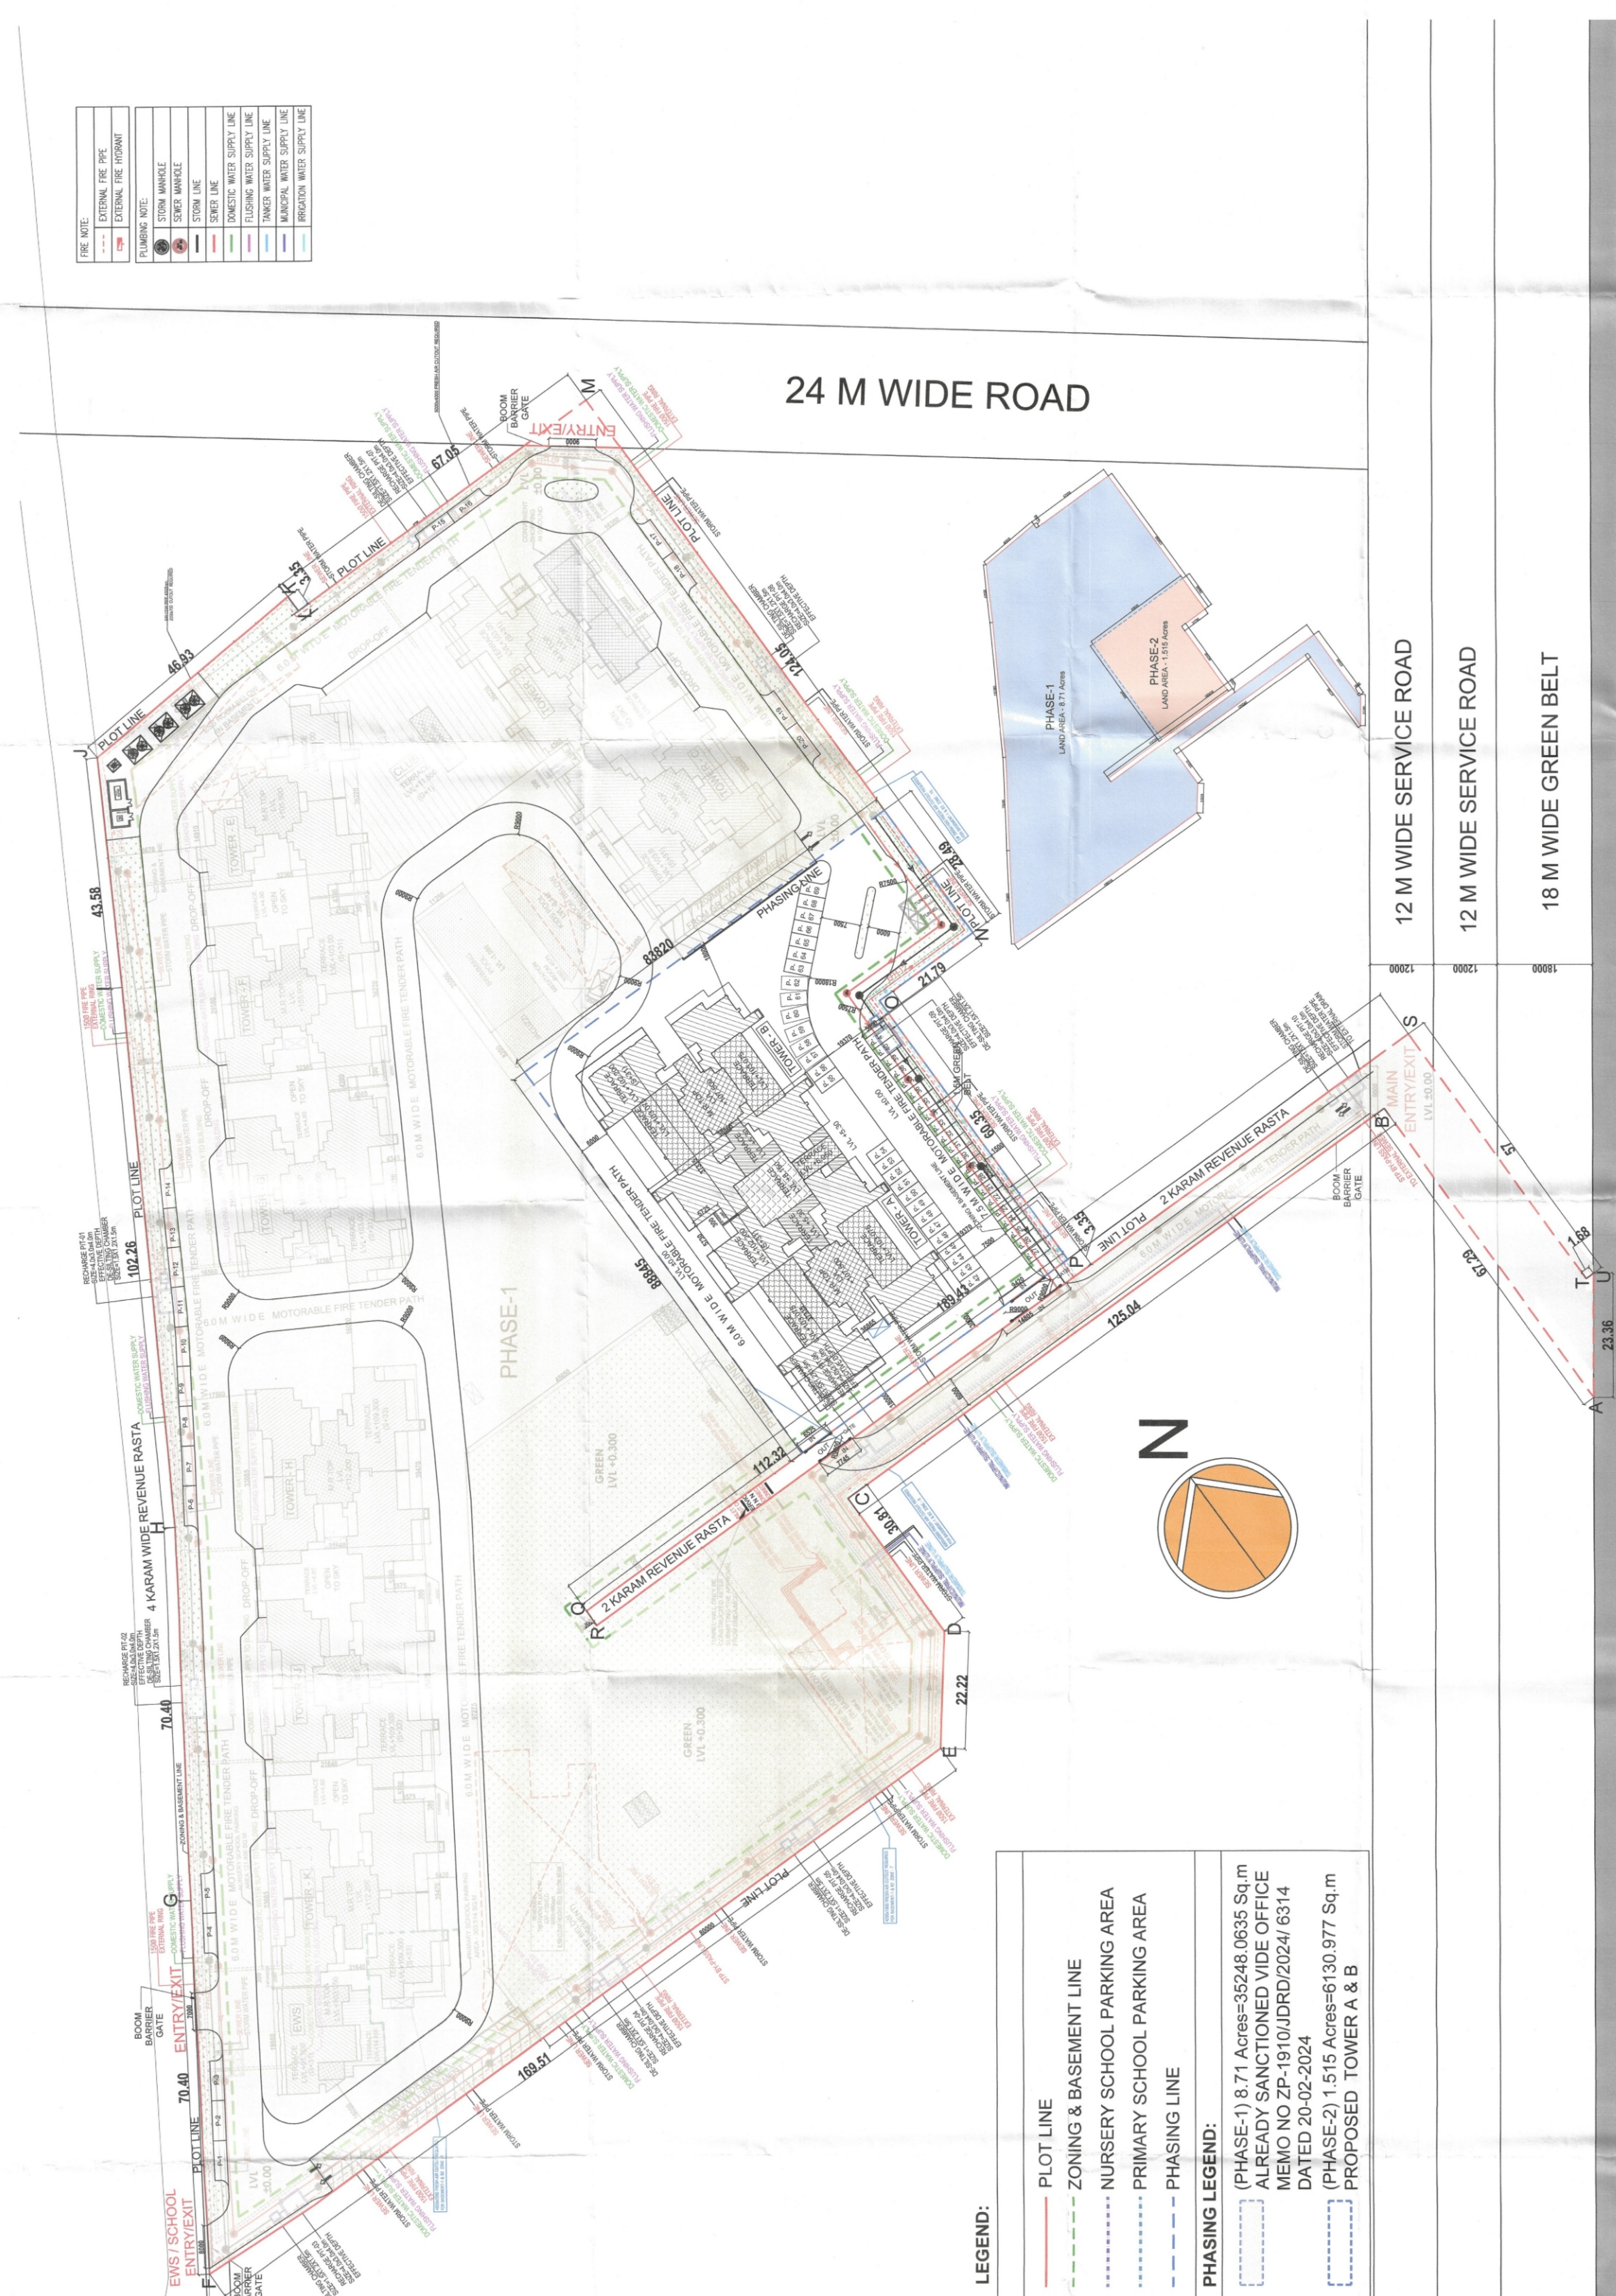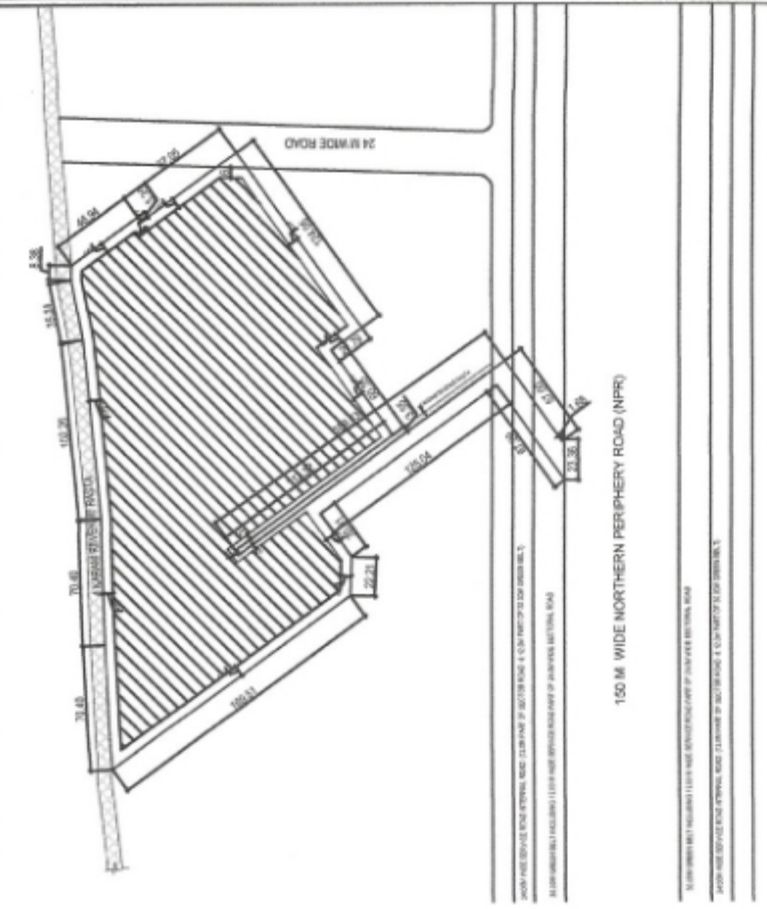

LEGEND:

---	PLOT LINE
---	ZONING & BASEMENT LINE
---	NURSERY SCHOOL PARKING AREA
---	PRIMARY SCHOOL PARKING AREA
---	PHASING LINE
PHASING LEGEND:	
[]	(PHASE-1) 8.71 Acres=35248.0635 Sq.m ALREADY SANCTIONED VIDE OFFICE MEMO NO ZP-1910/JDRD/2024/ 6314 DATED 20-02-2024
[]	(PHASE-2) 1.515 Acres=6130.977 Sq.m PROPOSED TOWER A & B

12 M WIDE SERVICE ROAD

12 M WIDE SERVICE ROAD

18 M WIDE GREEN BELT

Owner:

Union Buildmart Pvt.Ltd, Vibrant Infratech Pvt. Ltd,
Targe Buildcon Pvt in Collaboration with
Union Buildmart Pvt. Ltd

Architect:

GAN P. MATHUR AND ASSOCIATES (P) LTD.
C-10, 1ST FLOOR, SECTOR-113, GURUGRAM
T: 011-46698861 E: 011-46698813
P: 011-46698813 E: info@gpmada.com W: www.gpmada.com

Project Title:

PROPOSED BUILDING PLAN OF PHASE - 2
GROUP HOUSING COLONY (MIX LAND USE
RESIDENTIAL 99.5% AND 0.5% COMMERCIAL)
ON THE AREA MEASURING 10.225 ACRES
(LICENCE NO. 229 OF 2023 DATED 02-11-2023)
IN SECTOR -113, GURUGRAM

Status:

SUBMISSION DRAWING

Sheet Title

SITE PLAN
WITH SERVICES

Owner's Sign

Architect's Sign

Scale: 1:500

DWG. No.

DATE:

SD/ARM/3M-113A/SITE/102