
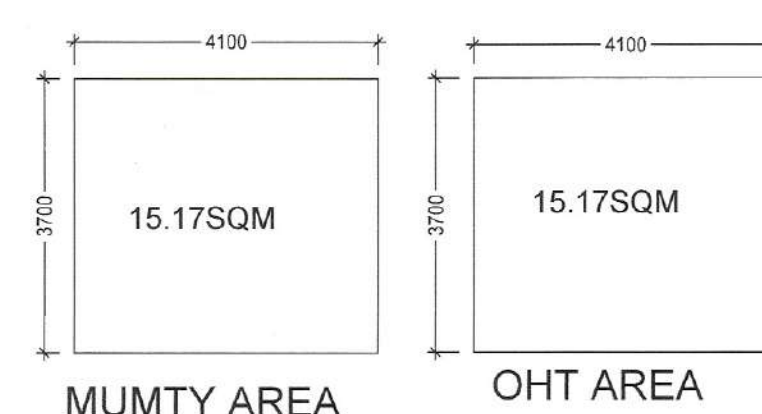
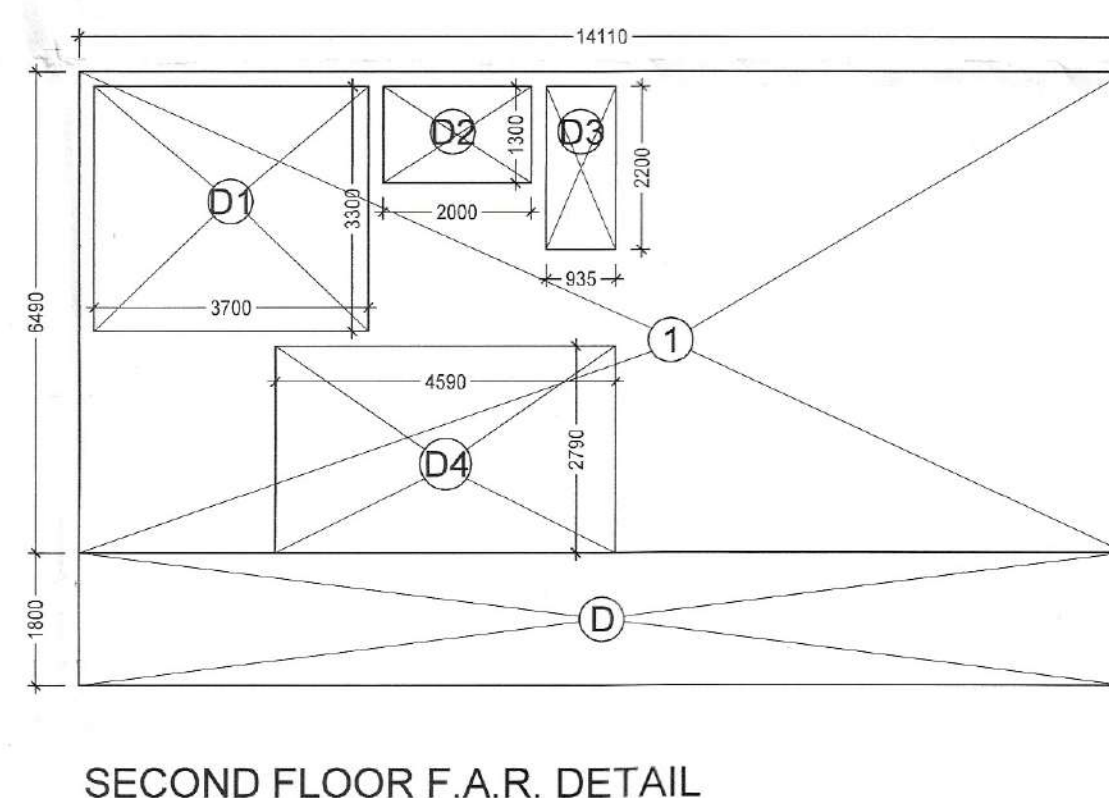
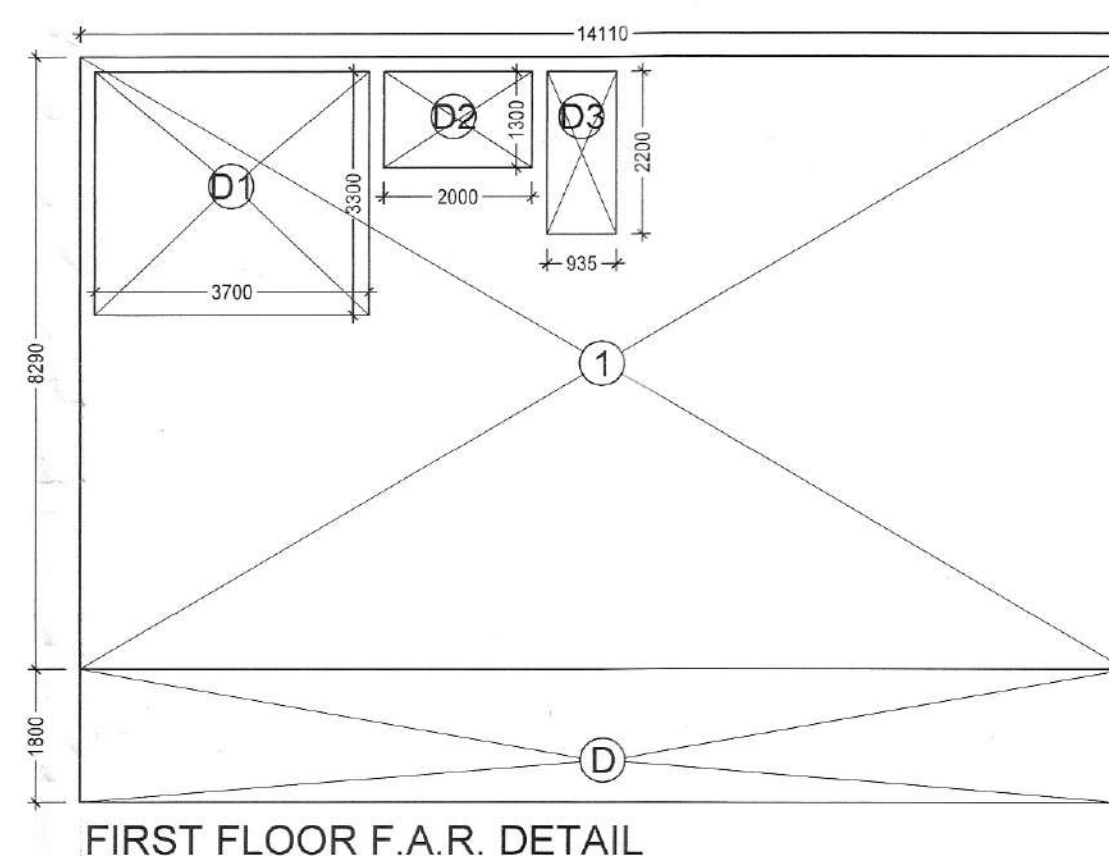
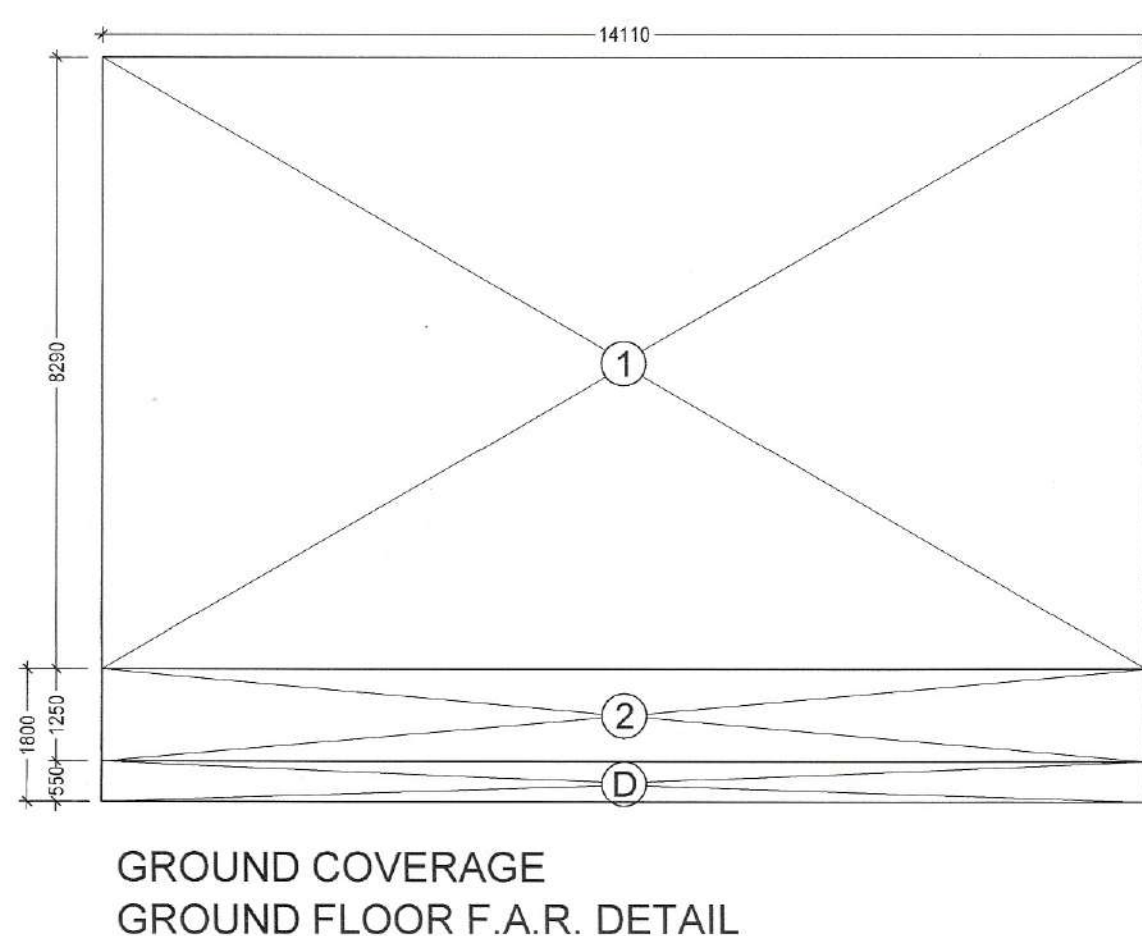
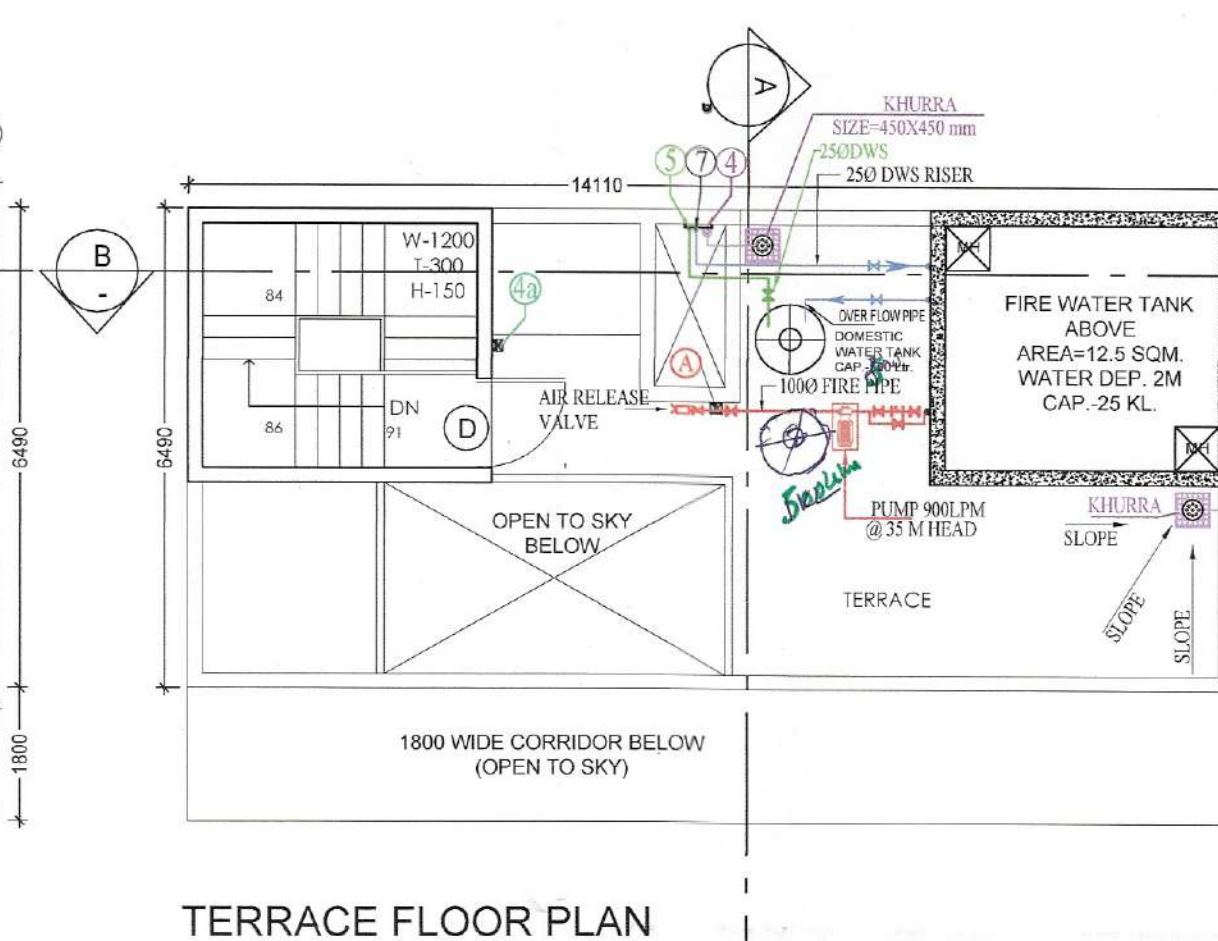
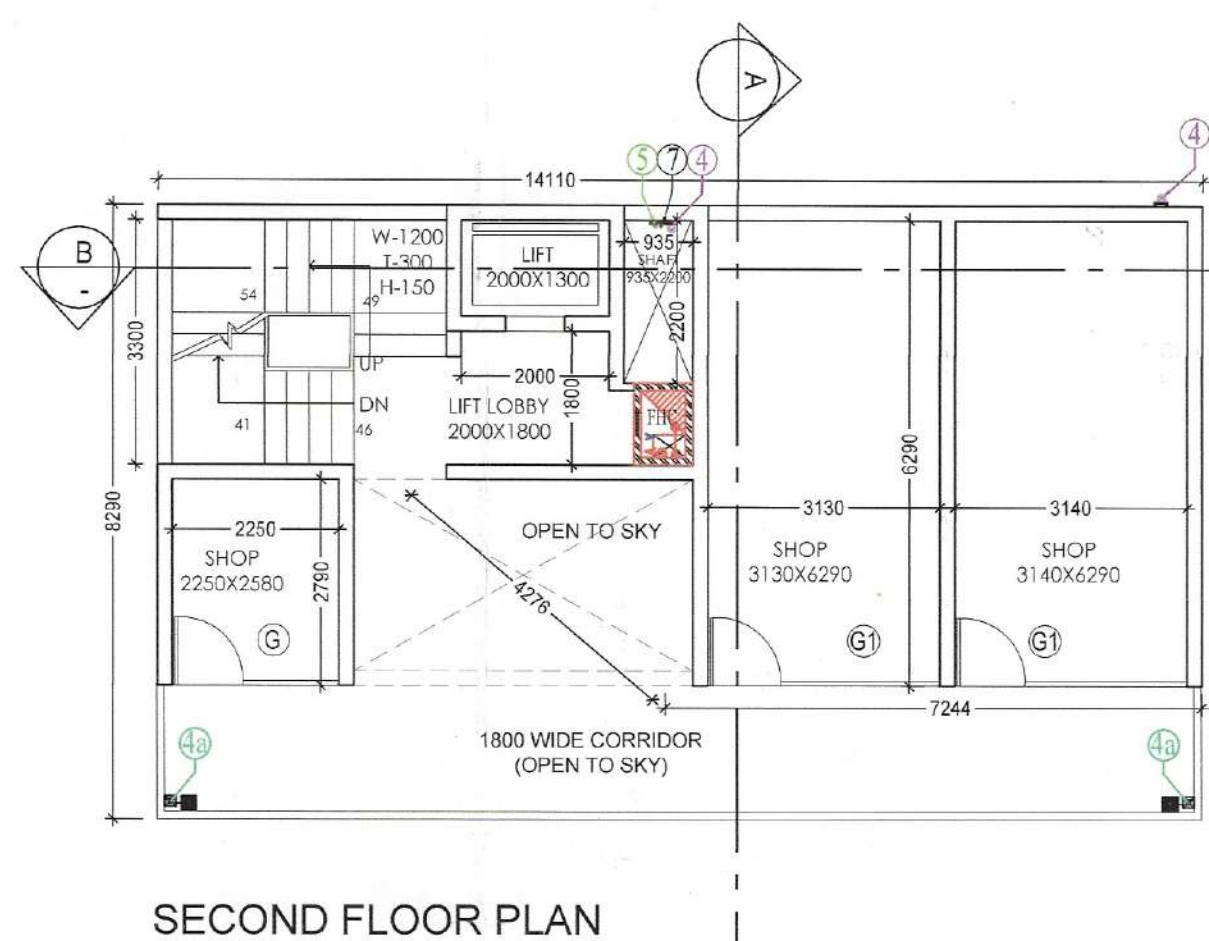
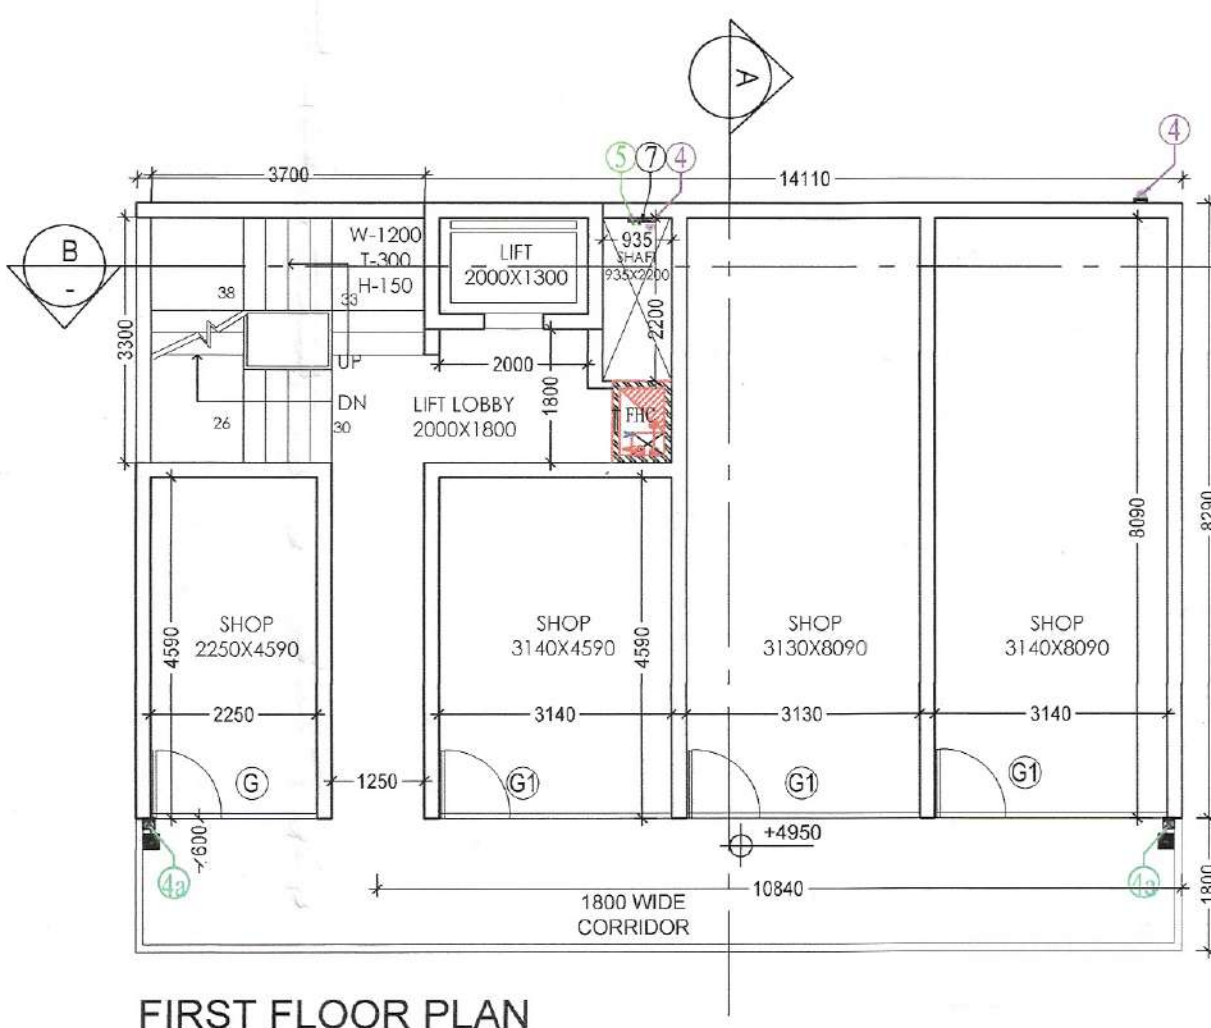


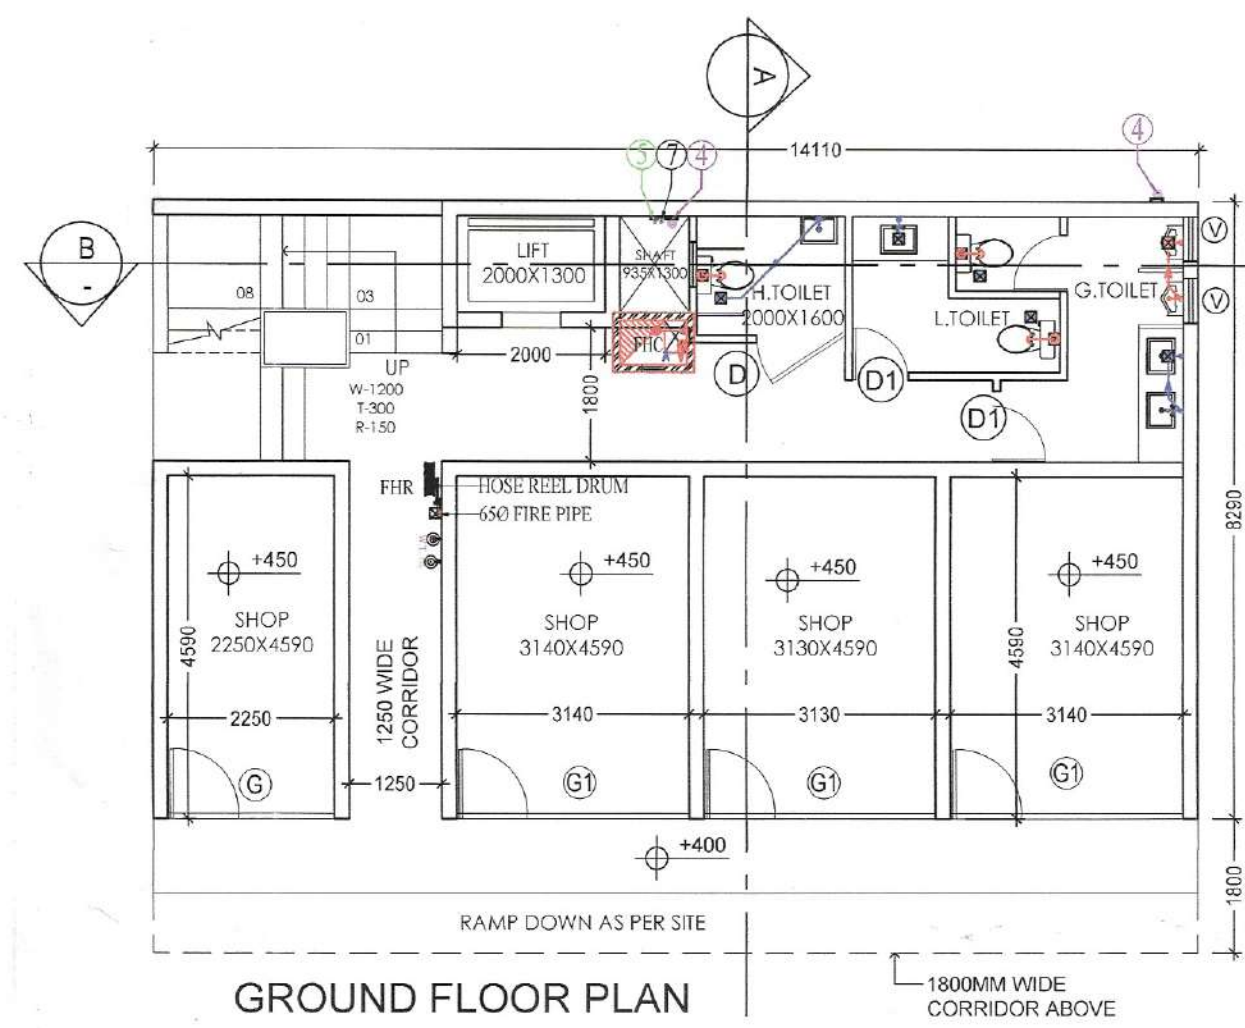

SCHEDULE OF OPENINGS				
S.NO.	TYPE	SIZE	C.I.	L.L.
1	G	2250X4050	0	4050
2	G1	3130X4050	0	4050
3	D	1000X2100	0	2100
4	D1	750X2100	0	2100
5	V	600X300	2100	2400





GROUND COVERAGE & GR. FLOOR F.A.R. DETAIL							
ITEM	WIDTH		LENGTH		FACTOR	NOS	AREA
1	14.110	X	8.290	X	1	X	116.972
2	14.110	X	1.250	X	1	X	17.638
TOTAL GROUND FLOOR FAR & G.C. AREA (A)							134.609

FIRST FLOOR F.A.R. DETAIL							
ITEM	WIDTH		LENGTH		FACTOR	NOS	AREA
1	14.100	X	8.290	X	1	X	116.889
TOTAL AREA (M ²)							116.889

DEDUCTIONS (D)						
ITEM	WIDTH	LENGTH	FACTOR	NOS	AREA	
D	14.100	X 1.200	X 1	X 1	16.920	
D1	3.700	X 3.300	X 1	X 1	12.210	
D2	2.000	X 1.300	X 1	X 1	2.600	
D3	0.935	X 2.200	X 1	X 1	2.057	
TOTAL NON FAR AREA =						33.787
TOTAL IV (D1+D2+D3) = FIRST FLOOR FAR AREA						100.022

SECOND FLOOR F.A.R. DETAIL (Z)						
ITEM	WIDTH	LENGTH	FACTOR		NOS	AREA
1	14.100	6.490	1	X	1	91.509
TOTAL AREA (Z)						91.509

DEDUCTIONS (D1)						
ITEM	WIDTH		LENGTH	FACTOR	NOS	AREA
D1	14.100	X	1.800	X	1	25.380
D1	3.700	X	3.300	X	1	12.210
D2	2.000	X	1.300	X	1	2.600
D3	0.935	X	2.200	X	1	2.057
D4	4.590	X	3.180	X	1	14.596
TOTAL NON FAR AREA =						56.843
TOTAL (2-D1+D2+D3+D4) = SECOND FLOOR FAR AREA						60.046
MUMPTY AREA						
ITEM	WIDTH		LENGTH	FACTOR	NOS	AREA
A	4.100	X	3.700	X	1	15.170
TOTAL MUMPTY NON FAR AREA =						15.170

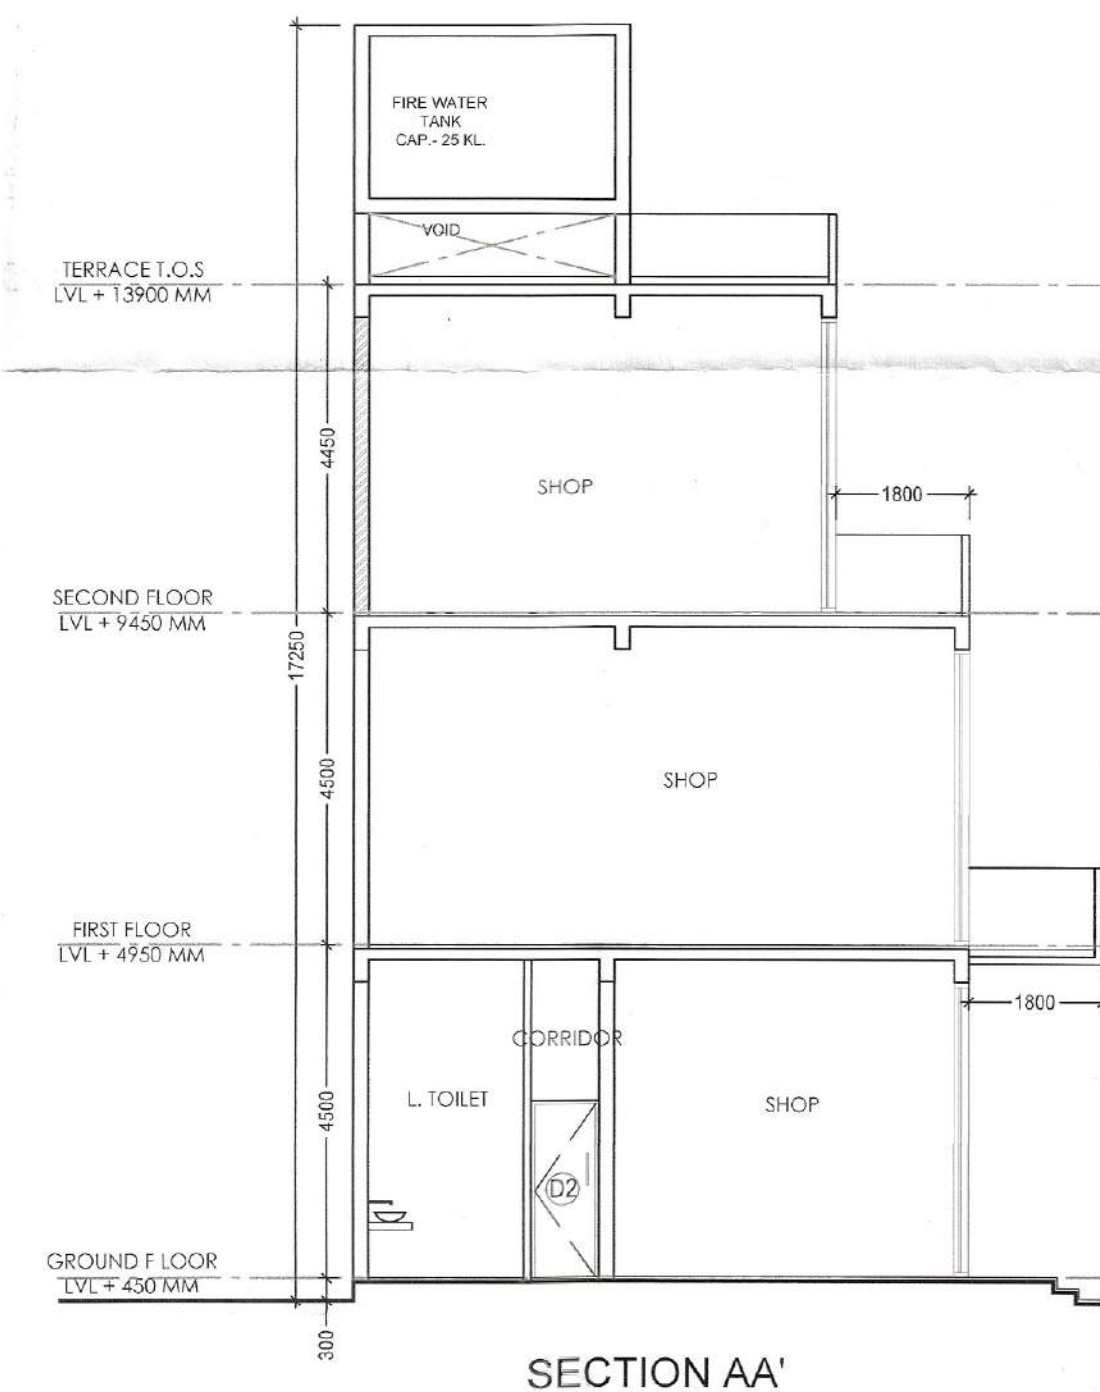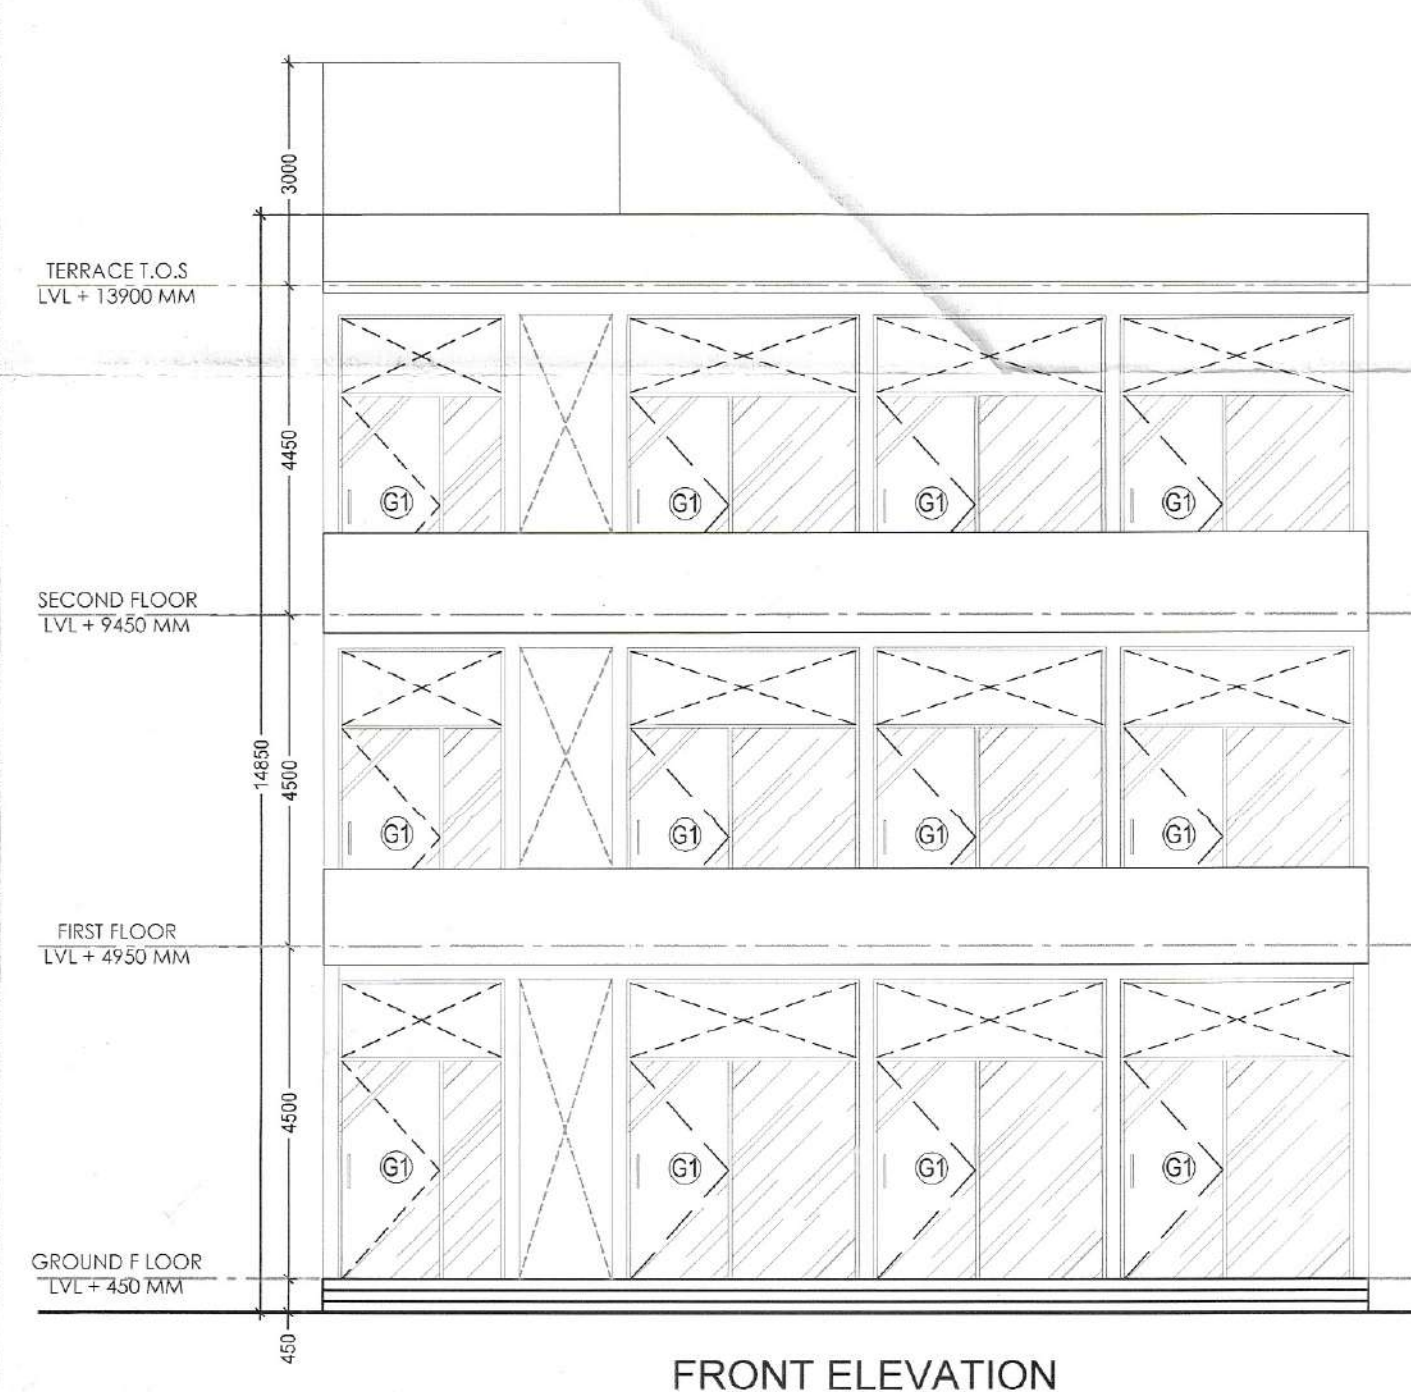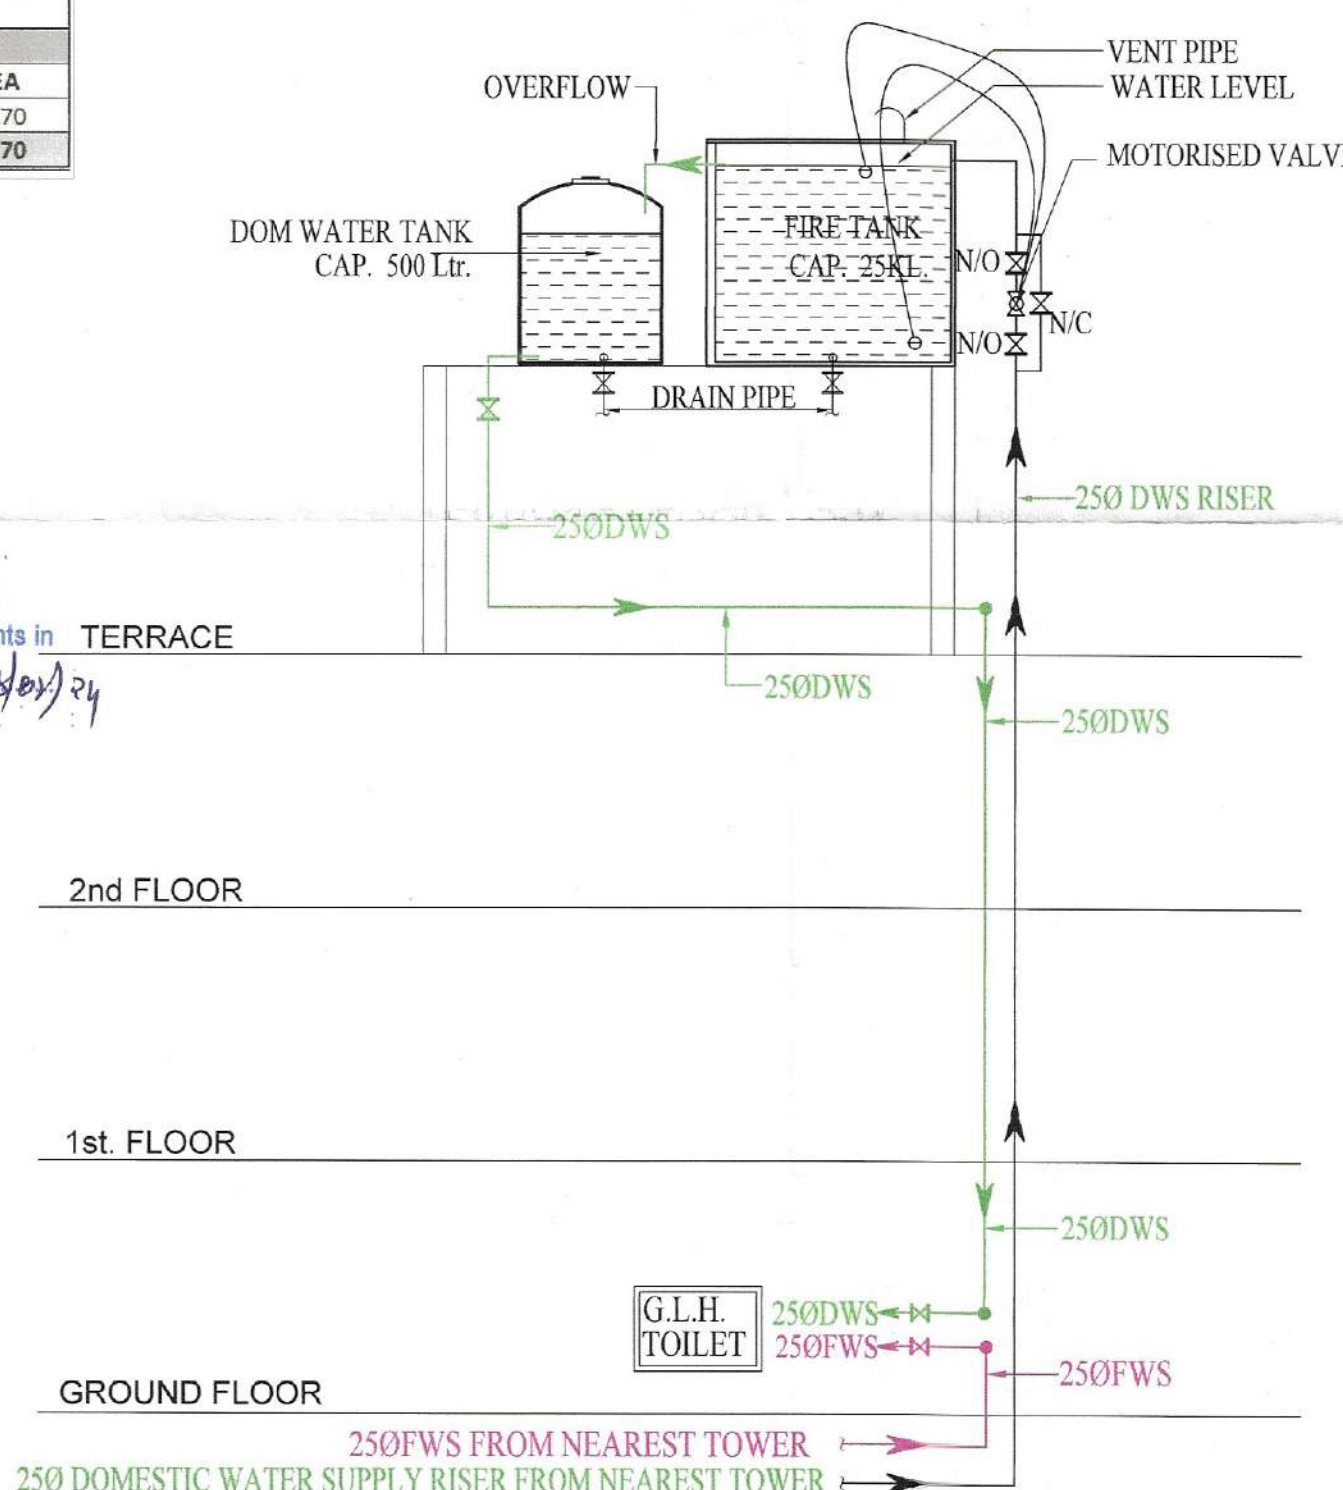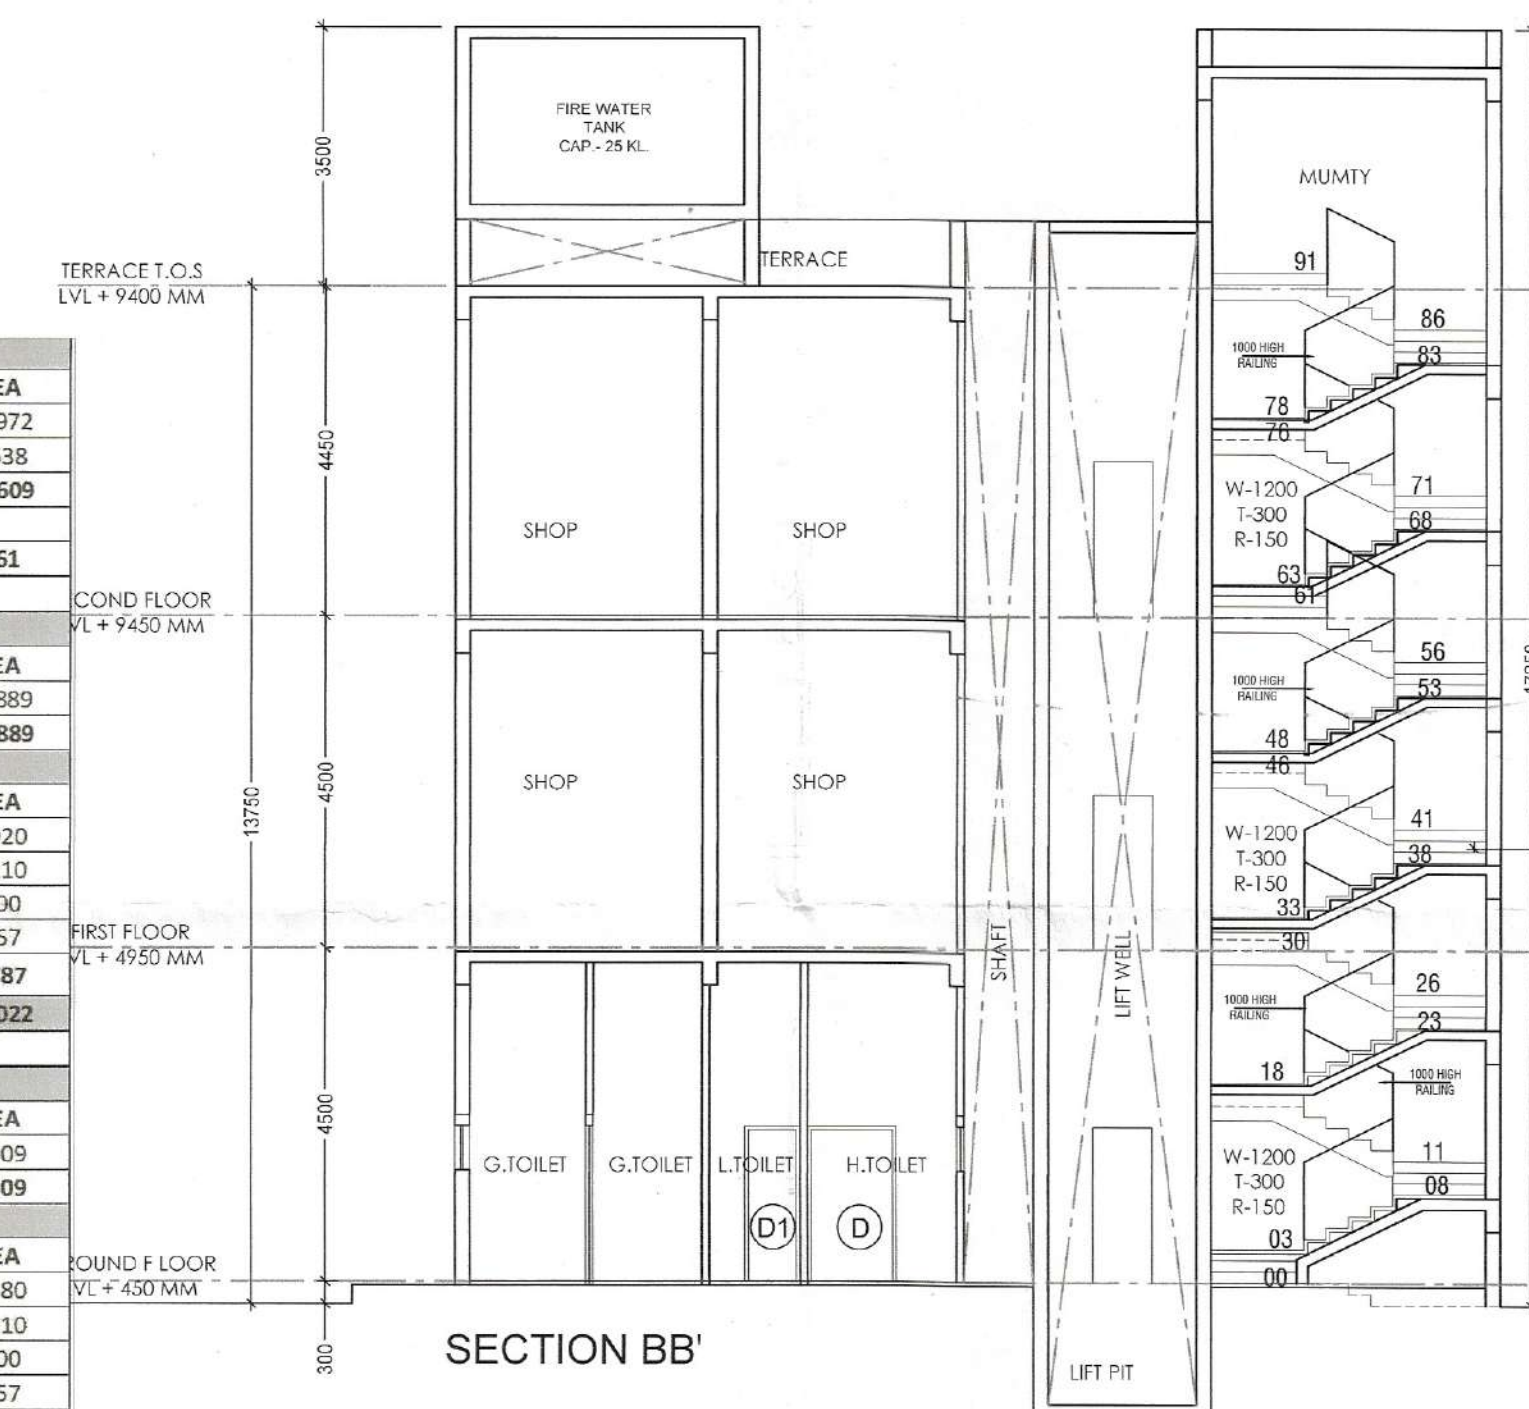

Checked and found ok for Public Health
(Internal) Service only subject to comments in TERRACE
in forwarding letter No. 1210.90....DV.05/01/21.

Superintending Engineer (HQ)
for Chief Engineer-I
HSVP, Panchkula

LEGEND	
	VALVE
	MOTORISED VALVE
	NON-RETURN VALVE
	STRAINER
	DOMESTIC WATER SUPPLY
	FLUSHING WATER SUPPLY
	AIR RELEASE VALVE
	PRESSURE REDUCING VALVE
	DOMESTIC WATER SUPPLY PIPE
	FLUSHING WATER SUPPLY PIPE
	NORMALLY CLOSED
	NORMALLY OPEN

DRAWING TITLE:
COMMERCIAL -2
FLOOR PLANS, ELEVATION,
SECTIONS & AREA DETAIL
WATER SUPPLY SCHEMATIC DIAGRAM

DDT (T) DRAWING NO.:
MEMBER S34
BPAC

GRAM TO BE READ WITH THIS OFFICE
MEMO NO.:
DATED:

LEGEND :-	
DESCRIPTION	SYMBOL
110 OD uPVC RAIN WATER PIPE FOR TERRACE	4
75 OD BALCONY DRAIN PIPE	4
DOMESTIC WATER SUPPLY DN. TAKE	* 5
FLUSHING WATER SUPPLY DN. TAKE	* 6
DOMESTIC WATER SUPPLY RISER	* 7
FLUSHING WATER SUPPLY RISER	* 8
PIPE DROP	
FLOOR DRAIN (FD)	
FLOOR TRAP (FT)	
URINAL TRAP (UT)	
DOMESTIC WATER SUPPLY	DWS
FLUSHING WATER SUPPLY	FWS
BALCONY DRAIN PIPE	
DOMESTIC WATER SUPPLY (DWS)	
FLUSHING WATER SUPPLY (FWS)	
FLUSHING WATER SUPPLY RISER	
DOMESTIC WATER SUPPLY RISER	
100G SOIL PIPE	
100G WASTE PIPE	
RAIN WATER PIPE	

FIRE LEGEND:

GENERAL NOTES:

1. DRAWINGS IN P.L. 6 FT SERIES REPRESENTS PLUMBING AND FUEL SUPPRESSION SYSTEM.
2. IN CASE OF ANY DISCREPANCY IT SHOULD BE BROUGHT TO THE NOTICE OF ARCHITECT / PROJECT MANAGER / CONSULTANT.
3. DRAWING SHOULD NOT BE SCALED. ONLY WRITTEN DIMENSIONS TO BE FOLLOWED.
4. THIS DRAWING SHOULD BE READ IN CONJUNCTION WITH RELEVANT ARCHITECTURAL, LAND SCAPING, STRUCTURAL AND OTHER SERVICES DRAWING.
5. ALL SERVICES SHIFTS WILL BE SEALED AT EVERY FLOOR / LEVEL AFTER INSTALLING SERVICES.

FIRE LEGEND:

A.	1000 DOWNCOMER
B.	800 DRAIN PIPE
FHC	FIRE HOSE CABINET

FIRE LEGEND:

A.	65Ø DOWNCOMER
FHR	HOSE REEL DRUM

PRINCIPAL ARCHITECT:

ACPL

ISO 9001:2015

Architecture
Management
Planning

ACPL Design Ltd

E-24 South Extension -1
New Delhi 110049, India
E: contact@scionline.com

PROJECT:-

PROPOSED RESIDENTIAL GROUP HOUSING COLONY
UNDER TOD SCHEME AREA MEASURING 9.16875 ACRE
LAND AT SECTOR 70, GURGAON (HARYANA) UNDER
LICENCE NO. 21 OF 2024 DATED 07.02.2024 BEING
DEVELOPED BY M/S TULIP INFRA TECH PVT. LTD.

OWNER'S/AUTHORIZED SIGN.

ARCHITECT'S SIGN.

DRAWING TITLE:
COMMERCIAL BUILDING-02
FLOOR PLANS, ELEVATION, SECTIONS
AND AREA DETAIL
WATER SUPPLY SCHEMATIC DIAGRAM

DRAWING NO.	S3
-------------	----

SCALE: 1:100