
 


TOTAL NON F.A.R. AREA (Y)	=	130.988
---------------------------	---	---------

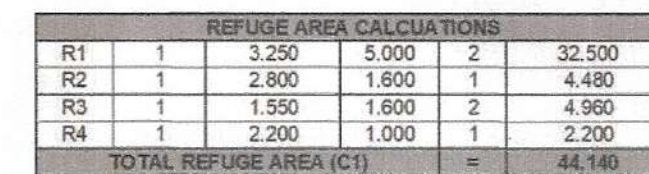



SERVICE PERSONNEL ROOM/BED ROOM-04 VENTILATION OPENING CALCULATIONS					
ROOM CARPET AREA					
S. No.	COEFF.	WIDTH	LENGHT	NOS.	AREA IN SQM
	1	2.790	3.650	1	10.184
				=	10.184

SCHEDULE OF OPENINGS					
S.NO.	TYPE	WIDTH	HEIGHT	S.L.	REMARK
1	FD	1200	2400	00	2 HOUR FIRE RATED
2	FD1	1350	2400	00	2 HOUR FIRE RATED
3	D	1350	2000	00	1 HOUR FIRE RATED
4	D1	1050	2400	00	
5	D2	800	2400	00	
6	W	1825	1200	1200	
7	W1	900	1200	1200	
8	W2	600	1200	1200	
9	W3	1200	1000	1200	
10	W4	450	1200	1200	
11	SD1	3000	2500	00	
11	SD2	1800	2400	00	



100



GENERAL NOTES :

DRAWINGS IN P, & FF SERIES REPRESENTS PLUMBING AND FIRE SUPPRESSION SYSTEM.

IN CASE OF ANY DISCREPANCY IT SHOULD BE BROUGHT TO THE NOTICE OF ARCHITECT / PROJECT MANAGER / CONSULTANT.

DRAWINGS SHOULD NOT BE SCALED.

ONLY WRITTEN DIMENSIONS TO BE FOLLOWED.

THIS DRAWING SHOULD BE READ IN CONJUNCTION WITH RELEVANT ARCHITECTURAL LAID SCOPING, STRUCTURAL AND OTHER SERVICES DRAWING.

ALL SERVICES SHAKTS WILL BE SEALED AT EVERY FLOOR LEVEL AFTER INSTALLING SERVICES.

Superintending Engineer (HQ)
for Chief Engineer-I
HSVP, Panchkula



PRINCIPAL ARCHITECT:

ACPI Design Ltd

PROJECT:-

PROPOSED RESIDENTIAL GROUP HOUSING COLONY
UNDER TOD SCHEME AREA MEASURING 9.16875 ACRE
LAND AT SECTOR 70, GURGAON (HARYANA) UNDER
LICENCE NO. 21 OF 2024 DATED 07.02.2024 BEING
DEVELOPED BY M/S TULIP INFRATECH PVT. LTD.

For TULIP INFRATECH PVT. LTD.

OWNER'S/AUTHORIZED SIGN.

DRAWING TITLE:

TOWER - C / E
REFUGE FLOOR PLANS & AREA DETAILS
(16TH & 24TH)

DRAWING NO. S22

ARCHITECT'S SIGN.



SCALE: 1:150