

Building Plans Sanction and Plans will be valid for five years only To be read with Memo No. 1344 Dated 17/01/25



Building Plans Approved by Supervising Committee (HOD):

Chairman Building Plan Committee cum Senior Town Planner HSDCC, M.T. Member

Recommended for Sanction HOD: D/MAN

PLUMBING LEGEND:	
1	TOTAL VALVE
2	WATER RELEASE VALVE
3	PROTECTOR REDUCING STATION
4	DOMESTIC WATER SUPPLY
5	DOMESTIC WATER SUPPLY
6	DOMESTIC WATER SUPPLY
100	DOMESTIC WATER SUPPLY

TOWER-B FLUSHING WATER SCHEMATIC

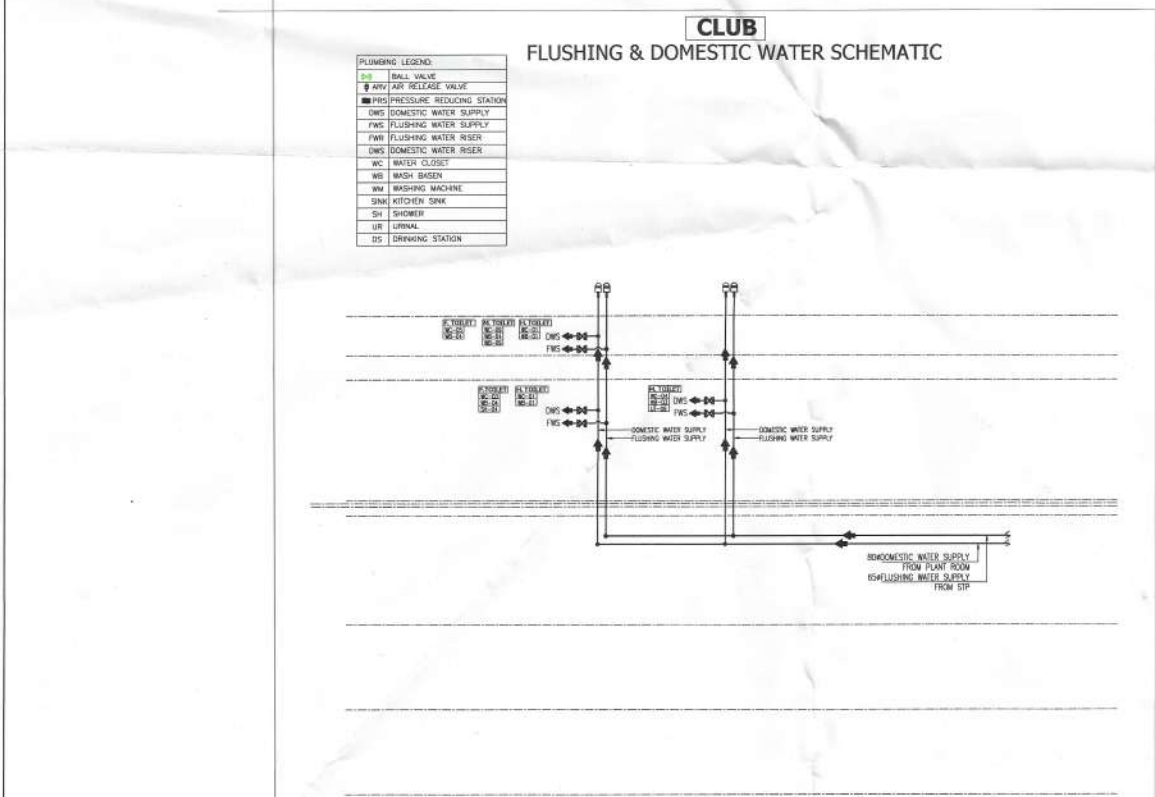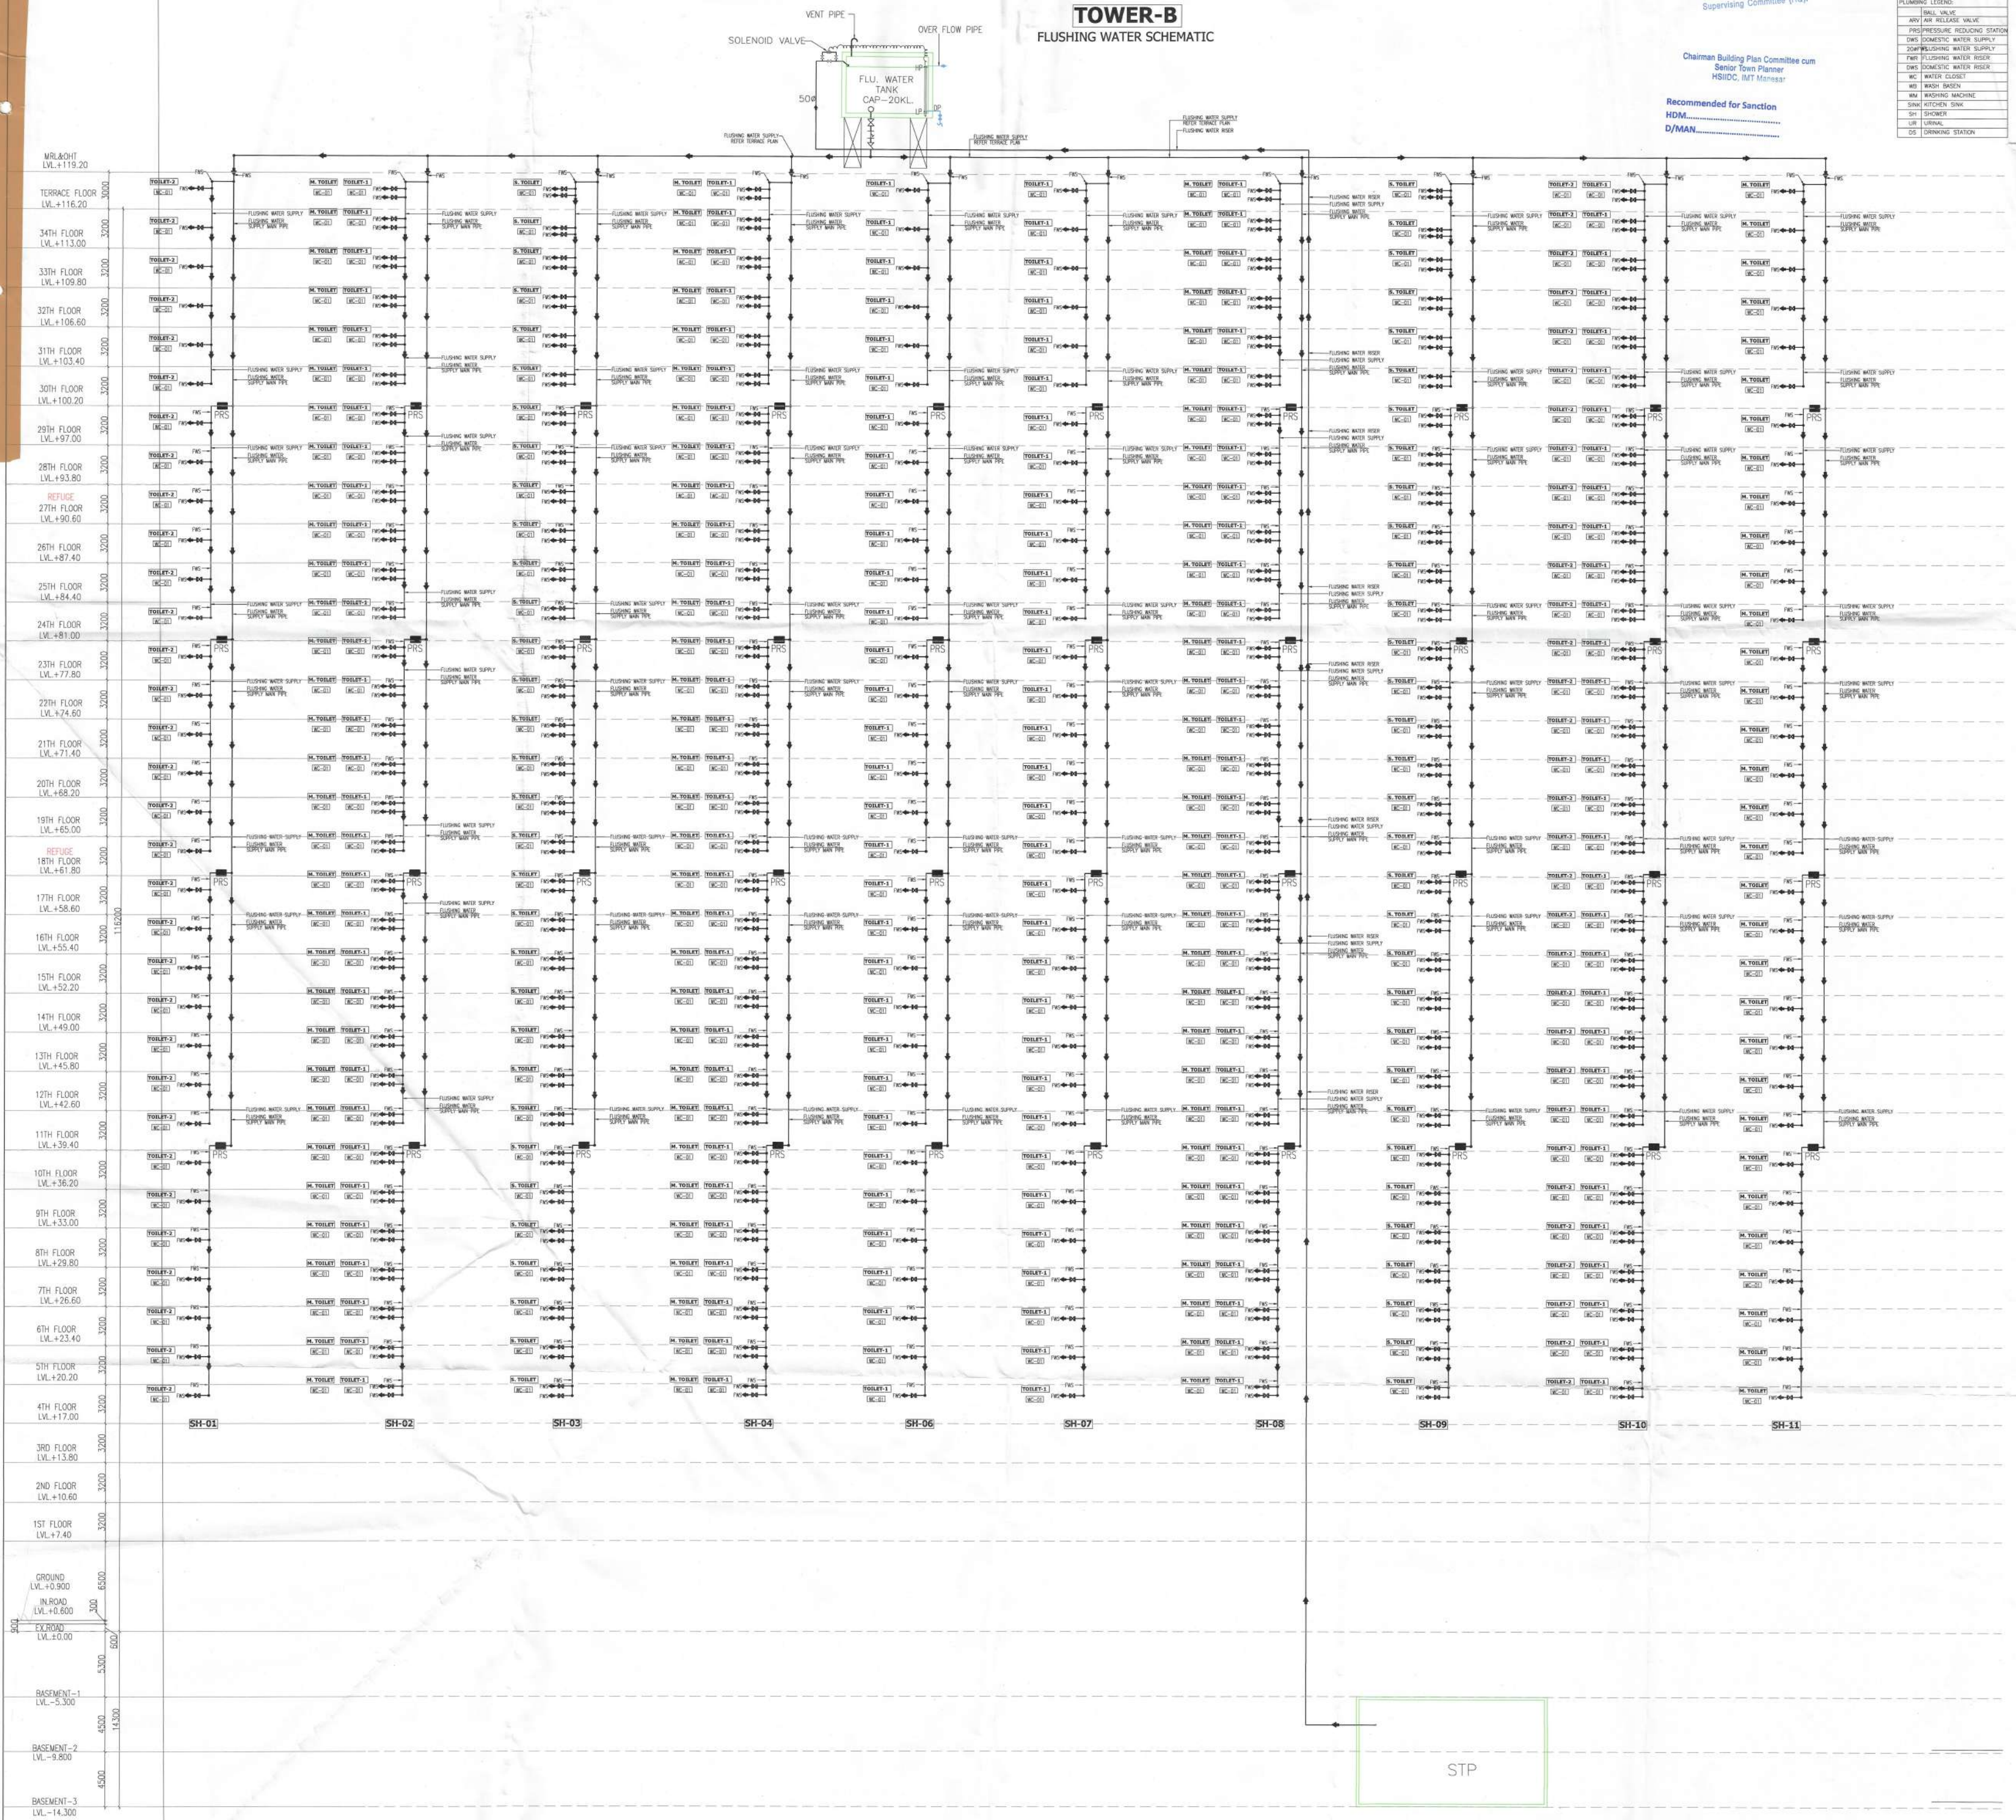

Note:-

1. BUILDING HAS AUTOMATIC SPRINKLER SYSTEM WHEREVER REQUIRED BY NBC.
2. BUILDING WILL BE DESIGNED (STRUCTURES) AS PER RELEVANT IS CODES FOR EARTH QUAKE RESISTANCE.
3. POWER BACKUP/ MECHANICAL VENTILATED SHAFTS.

PROJECT:

PROPOSED BUILDING PLAN OF GROUP HOUSING AT SITE NO. GH-03 SITUATED AT SECTOR-80 (RESIDENTIAL), MANESAR-MEASURING 22501.0 SQM.

ASSOCIATE ARCHITECTS



PLOT NO-40B SEC-37C GURGAON (PH-9560794794)

OWNER'S SEAL & SIGNATURE



ARCHITECT'S SEAL & SIGNATURE

A. Ravinder Kumar
CA/2012/55971
Mob: 9871004573

DEC-2024

Scale -1:100

Drawing Title:-

TOWER-B
FLUSHING WATER SCHEMATIC DIAGRAM

Drawing No:-

SD-04