


PLUMBING VERTICAL PIPES SCHEDULES—

1		100Ø SOIL PIPE
2		100Ø WASTE PIPE
3		75Ø VENT PIPE
4		DOMESTIC WATER SUPPLY MAIN PIPE
4A		DOMESTIC BOOSTER WATER SUPPLY PIPE
5		DOMESTIC WATER SUPPLY BRANCH PIPE
6		FLUSHING WATER SUPPLY BRANCH PIPE
7		FLUSHING WATER SUPPLY MAIN PIPE
8		DOMESTIC WATER RISER TO OHT
9		FLUSHING WATER RISER TO OHT
R		100Ø ROOF RAIN WATER PIPE
R1		75Ø BALCONY RAIN WATER PIPE
		(FD) FLOOR DRAIN
		(FT) FLOOR TRAP
		(BD) BALCONY DRAIN PIPE


PLUMBING LEGEND—

S.NO	ABBREVIATION	SYMBOL	DISCRPTION
1	WP		100Ø WASTE PIPE
2	WP		FD TO FT 50Ø WASTE PIPE
3	WP		32Ø WASTE PIPE
4	SP		100Ø SOIL PIPE
5	DWS		DOMESTIC WATER SUPPLY
6	FWS		FLUSHING WATER SUPPLY
7	BV/BTV		BALL/BUTTER FLY VALVE


WATER SUPPLY

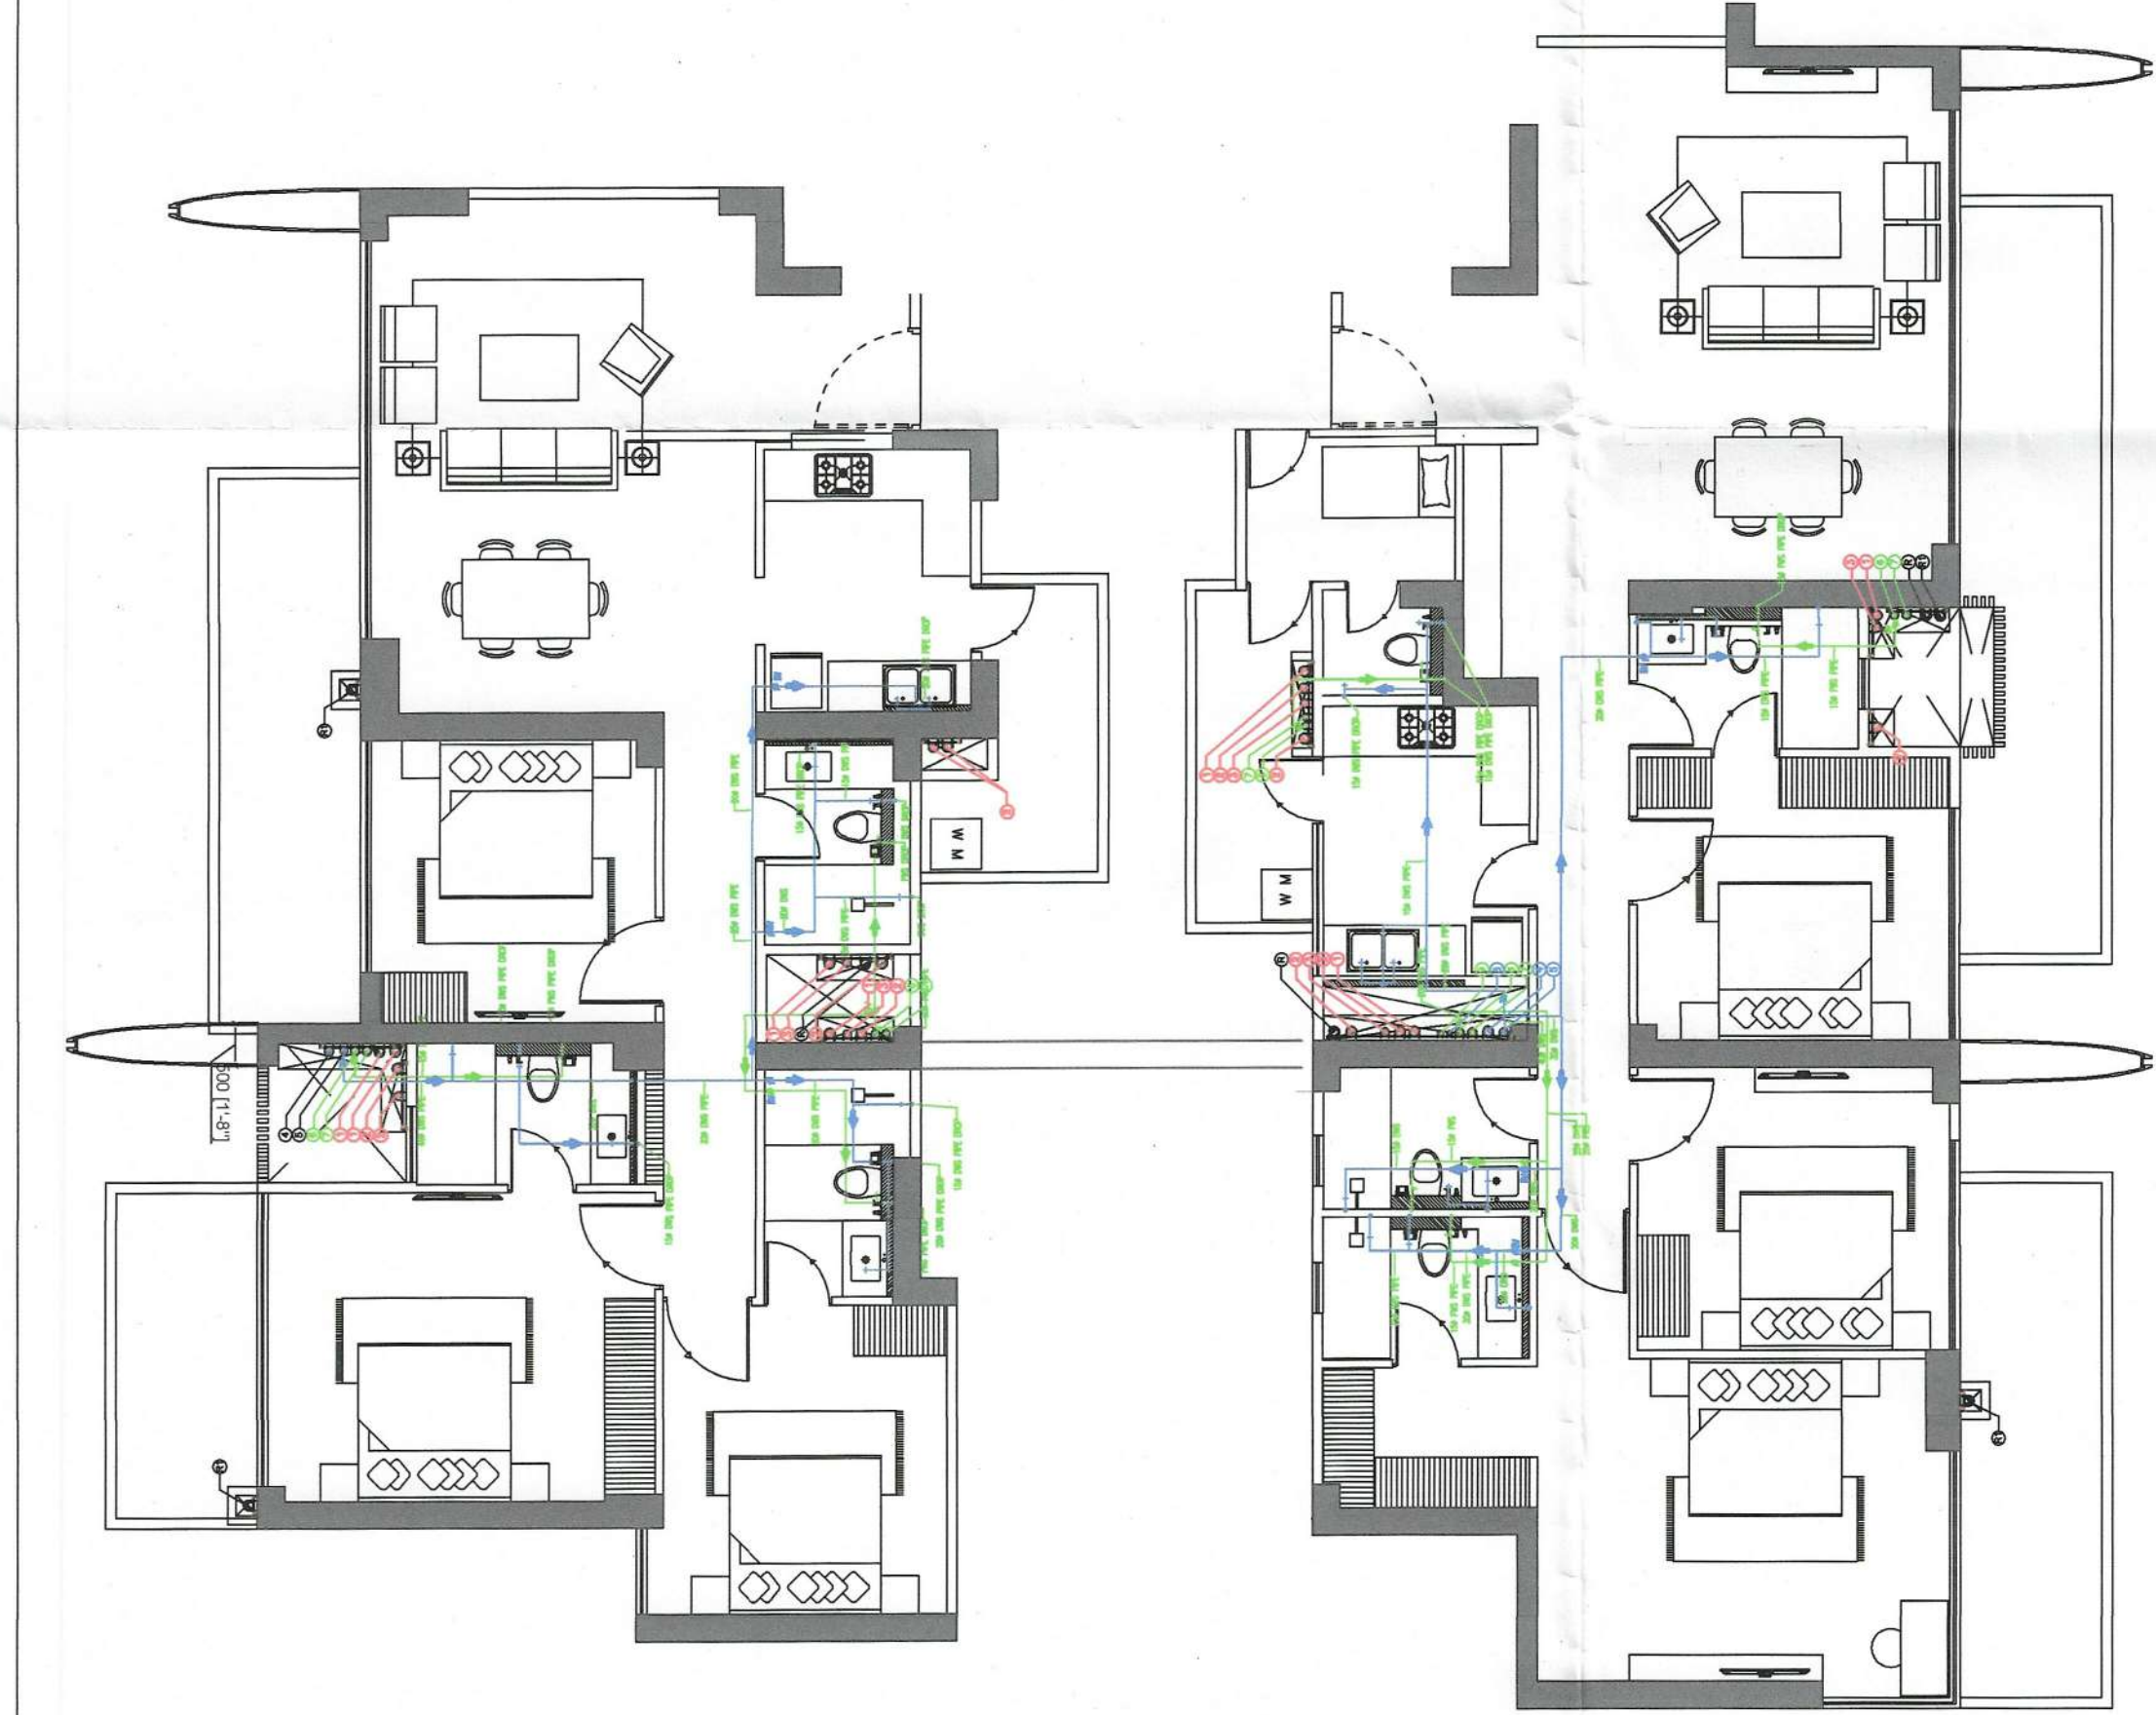

DRAINAGE

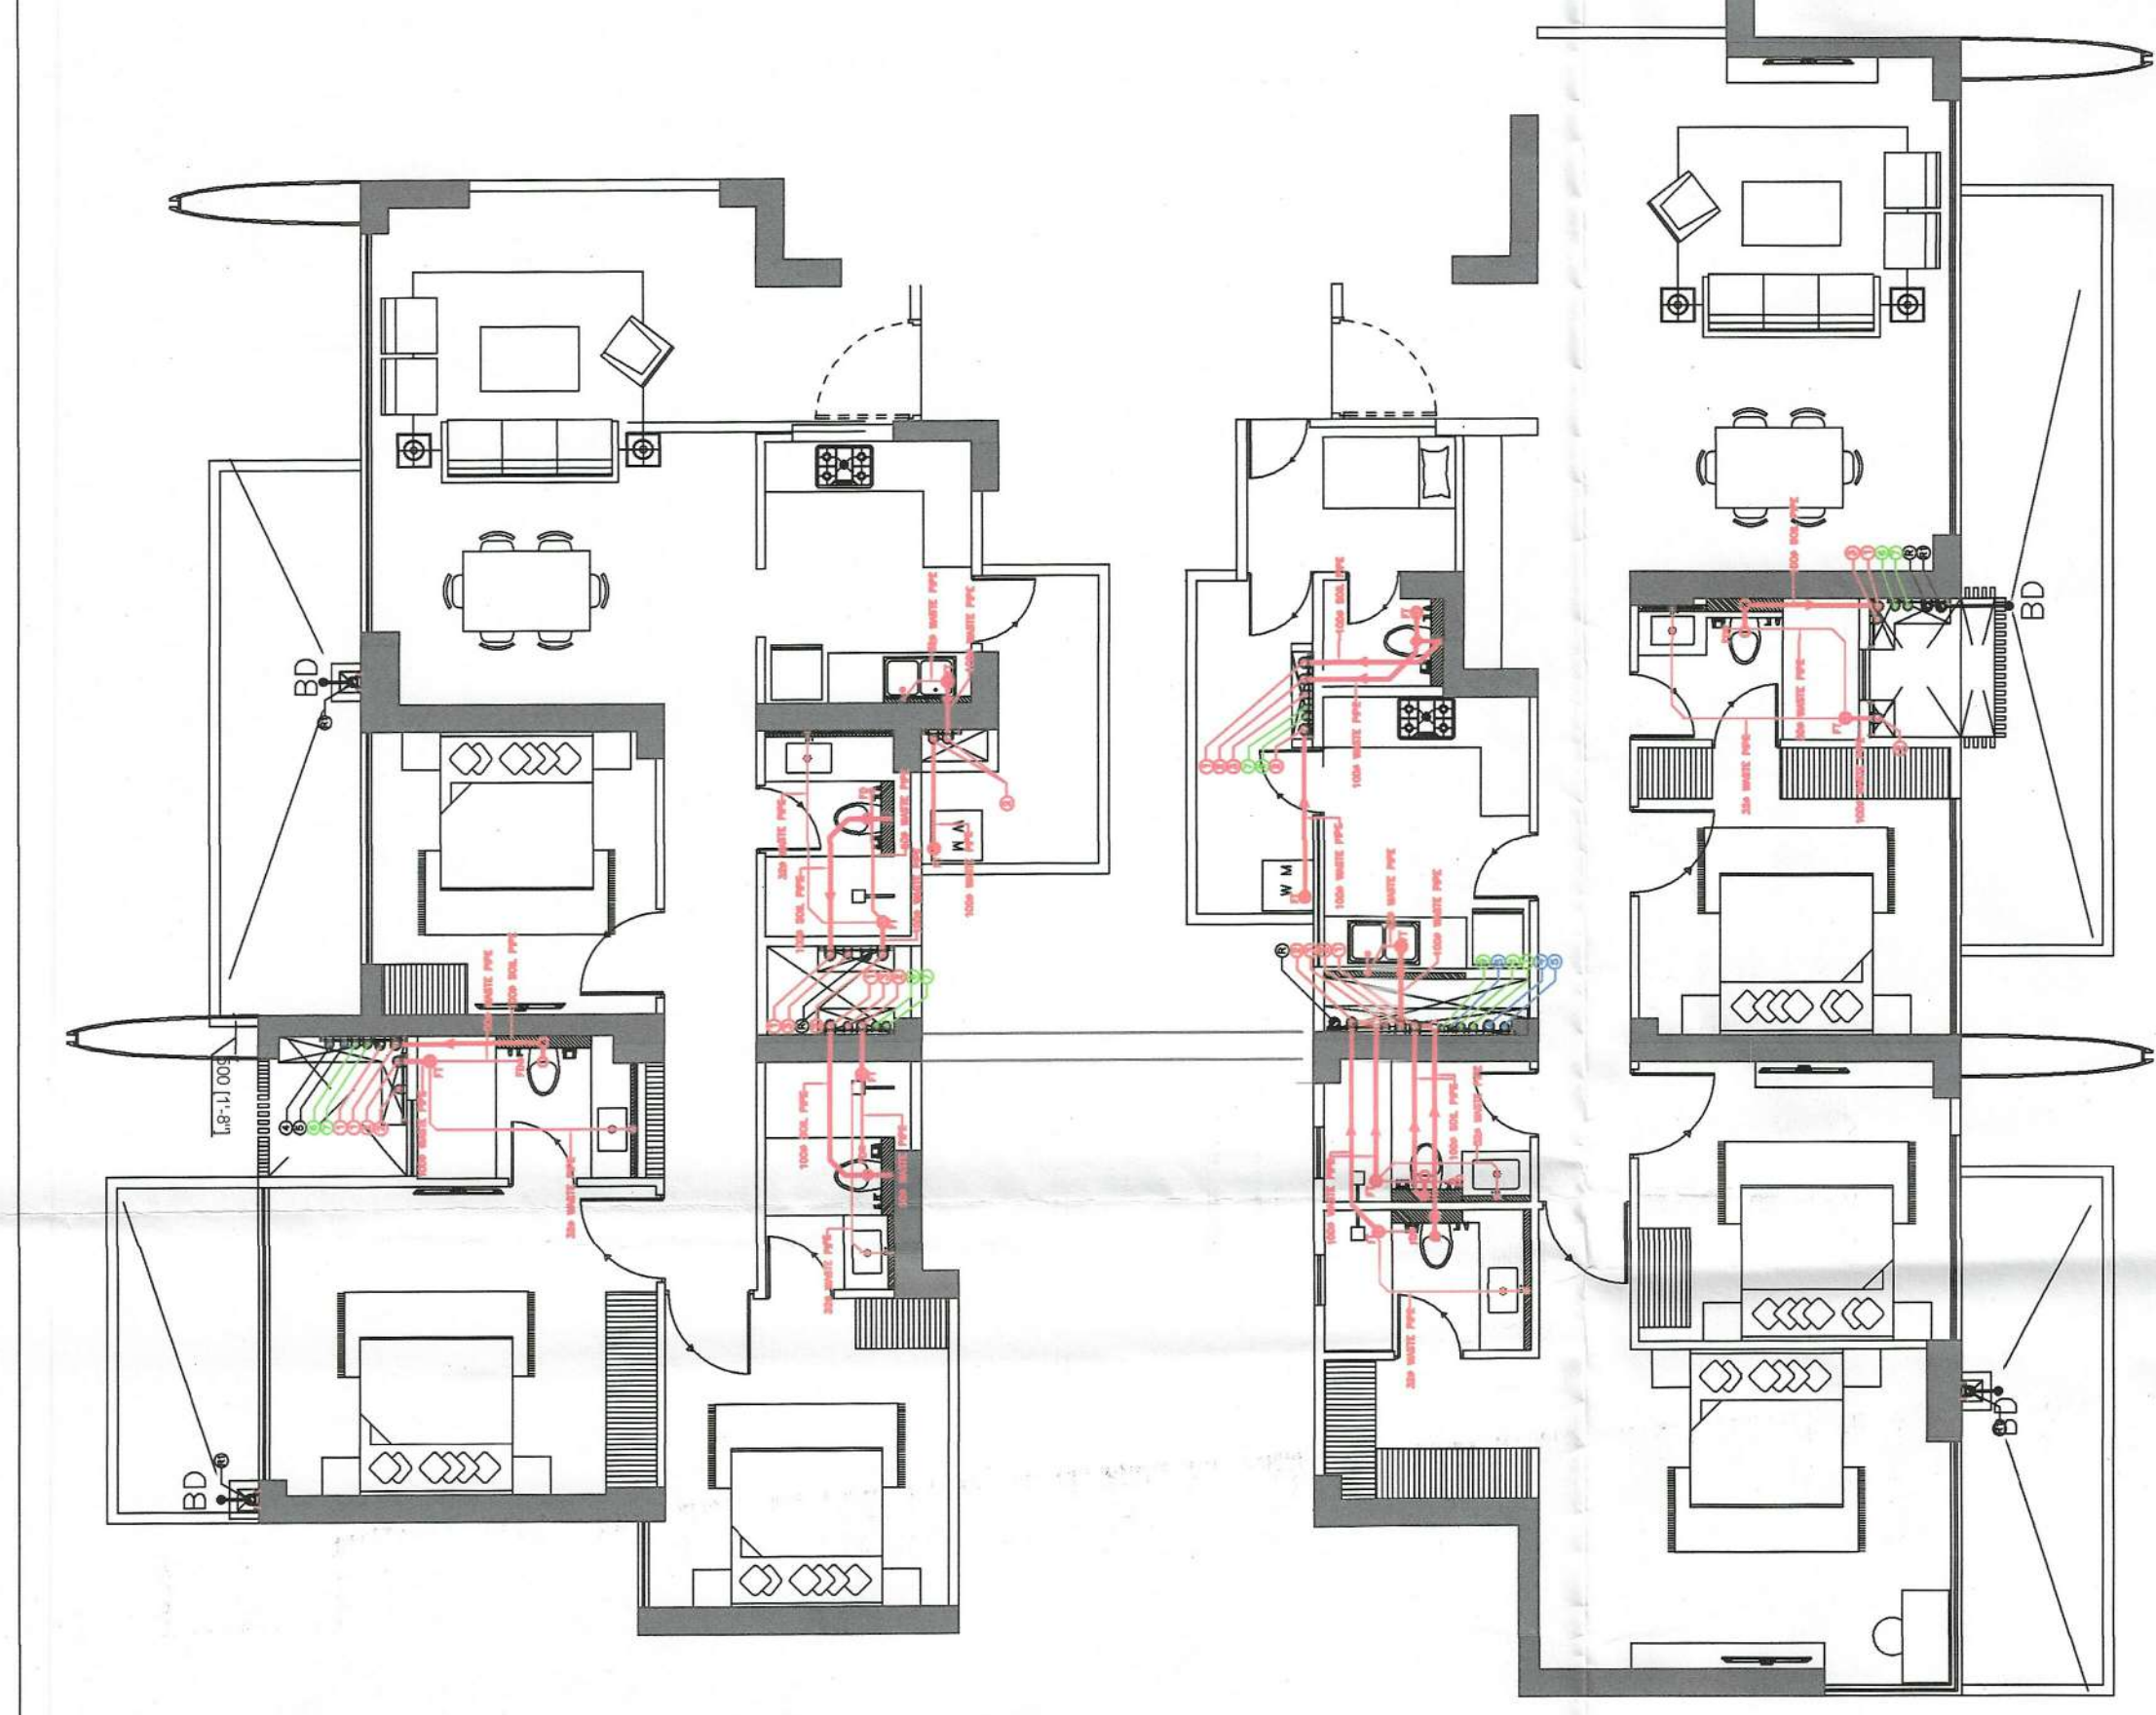

DRAINAGE

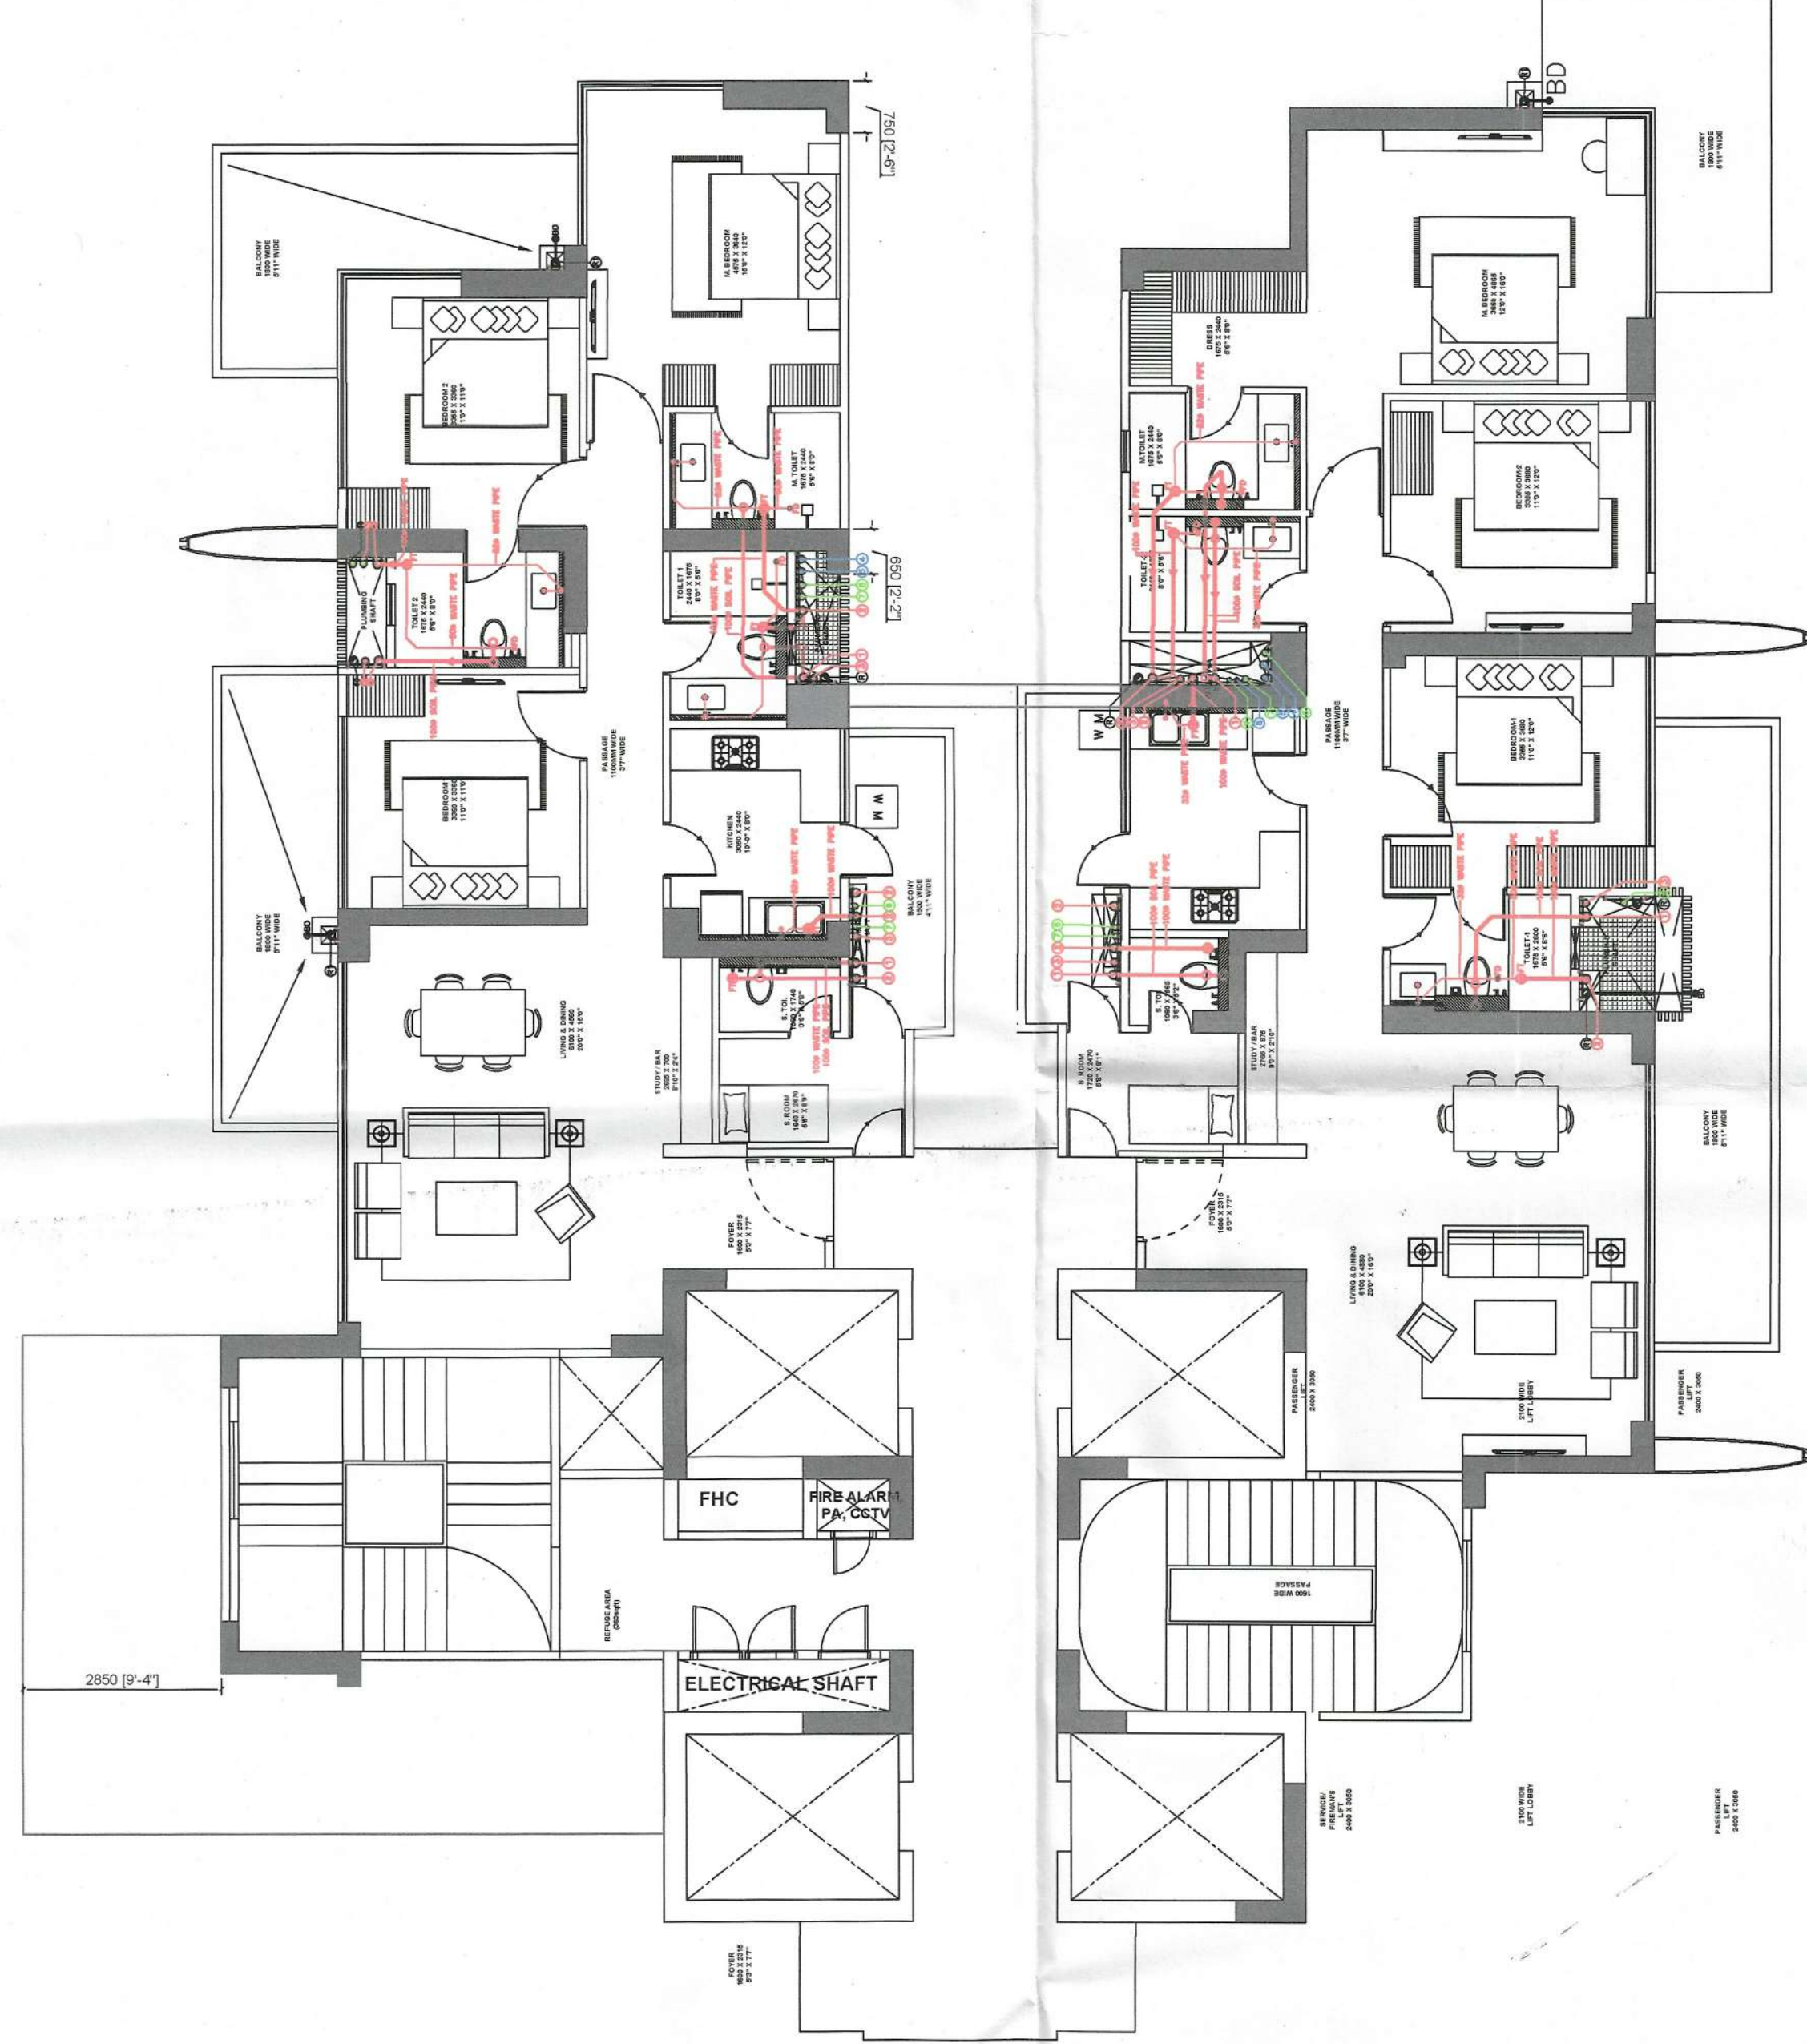

WATER SUPPLY



TOWER A TYPICAL TOILET DETAIL

Building Plans Sanction and Plans will
be valid for five year only
To be renewed after five year
Dated: 17/07/2024

Building Plans Approved by
Supervising Committee (H&S)

Charima Building Plan Committee cum
H&S Committee Member
H&SDC, MT, PUNE

Recommended for Sanction
H&S
D/N/A


Note:-

1. BUILDING HAS AUTOMATIC SPRINKLER SYSTEM
WHEREVER REQUIRED BY NBC.
2. BUILDING WILL BE DESIGNED (STRUCTURES)
AS PER RELEVANT IS CODES FOR EARTHQUAKE RESISTANCE.
3. POWER BACKUP/ MECHANICAL VENTILATED SHAFTS.

PROJECT:

PROPOSED BUILDING PLAN OF
GROUP HOUSING AT SITE NO. GH-03
SITUATED AT SECTOR-80 (RESIDENTIAL),
MANESAR-MEASURING 22501.0 SQM.

ASSOCIATE ARCHITECTS

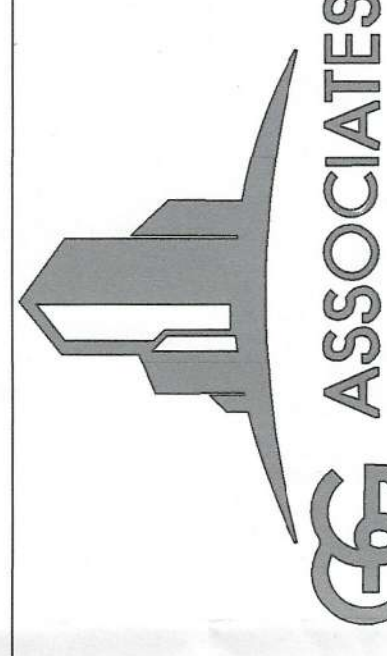

PLOT NO-408 SEC-37C GURGAON (PH-9560794794)

OWNER'S SEAL
& SIGNATURE



ARCHITECT'S SEAL
& SIGNATURE

Ar. Ravinder Kumar
Charima Building Plan Committee cum
H&S Committee Member
H&SDC, MT, PUNE

DEC-2024 Scale : 1:100

Drawing Title:-

TOILET DETAIL
TOWER-A

Drawing No:-

TD-01