



PLUMBING VERTICAL PIPES SCHEDULES--		
1		100ø SOIL PIPE
2		100ø WASTE PIPE
3		75ø VENT PIPE
4		DOMESTIC WATER SUPPLY MAIN PIPE
4A		DOMESTIC BOOSTER WATER SUPPLY PIPE
5		DOMESTIC WATER SUPPLY BRANCH PIPE
6		FLUSHING WATER SUPPLY BRANCH PIPE
7		FLUSHING WATER SUPPLY MAIN PIPE
8		DOMESTIC WATER RISER TO OHT
9		FLUSHING WATER RISER TO OHT
R		100ø ROOF RAIN WATER PIPE
R1		75ø BALCONY RAIN WATER PIPE
		(FD) FLOOR DRAIN
		(FT) FLOOR TRAP
		(BD) BALCONY DRAIN PIPE


PLUMBING LEGEND--		
S.NO/ABBREVIATION	SYMBOL	DISCRPTION
1		WP
2		WP
3		WP
4		SP
5		DWS
6		FWS
7		BV/BFV

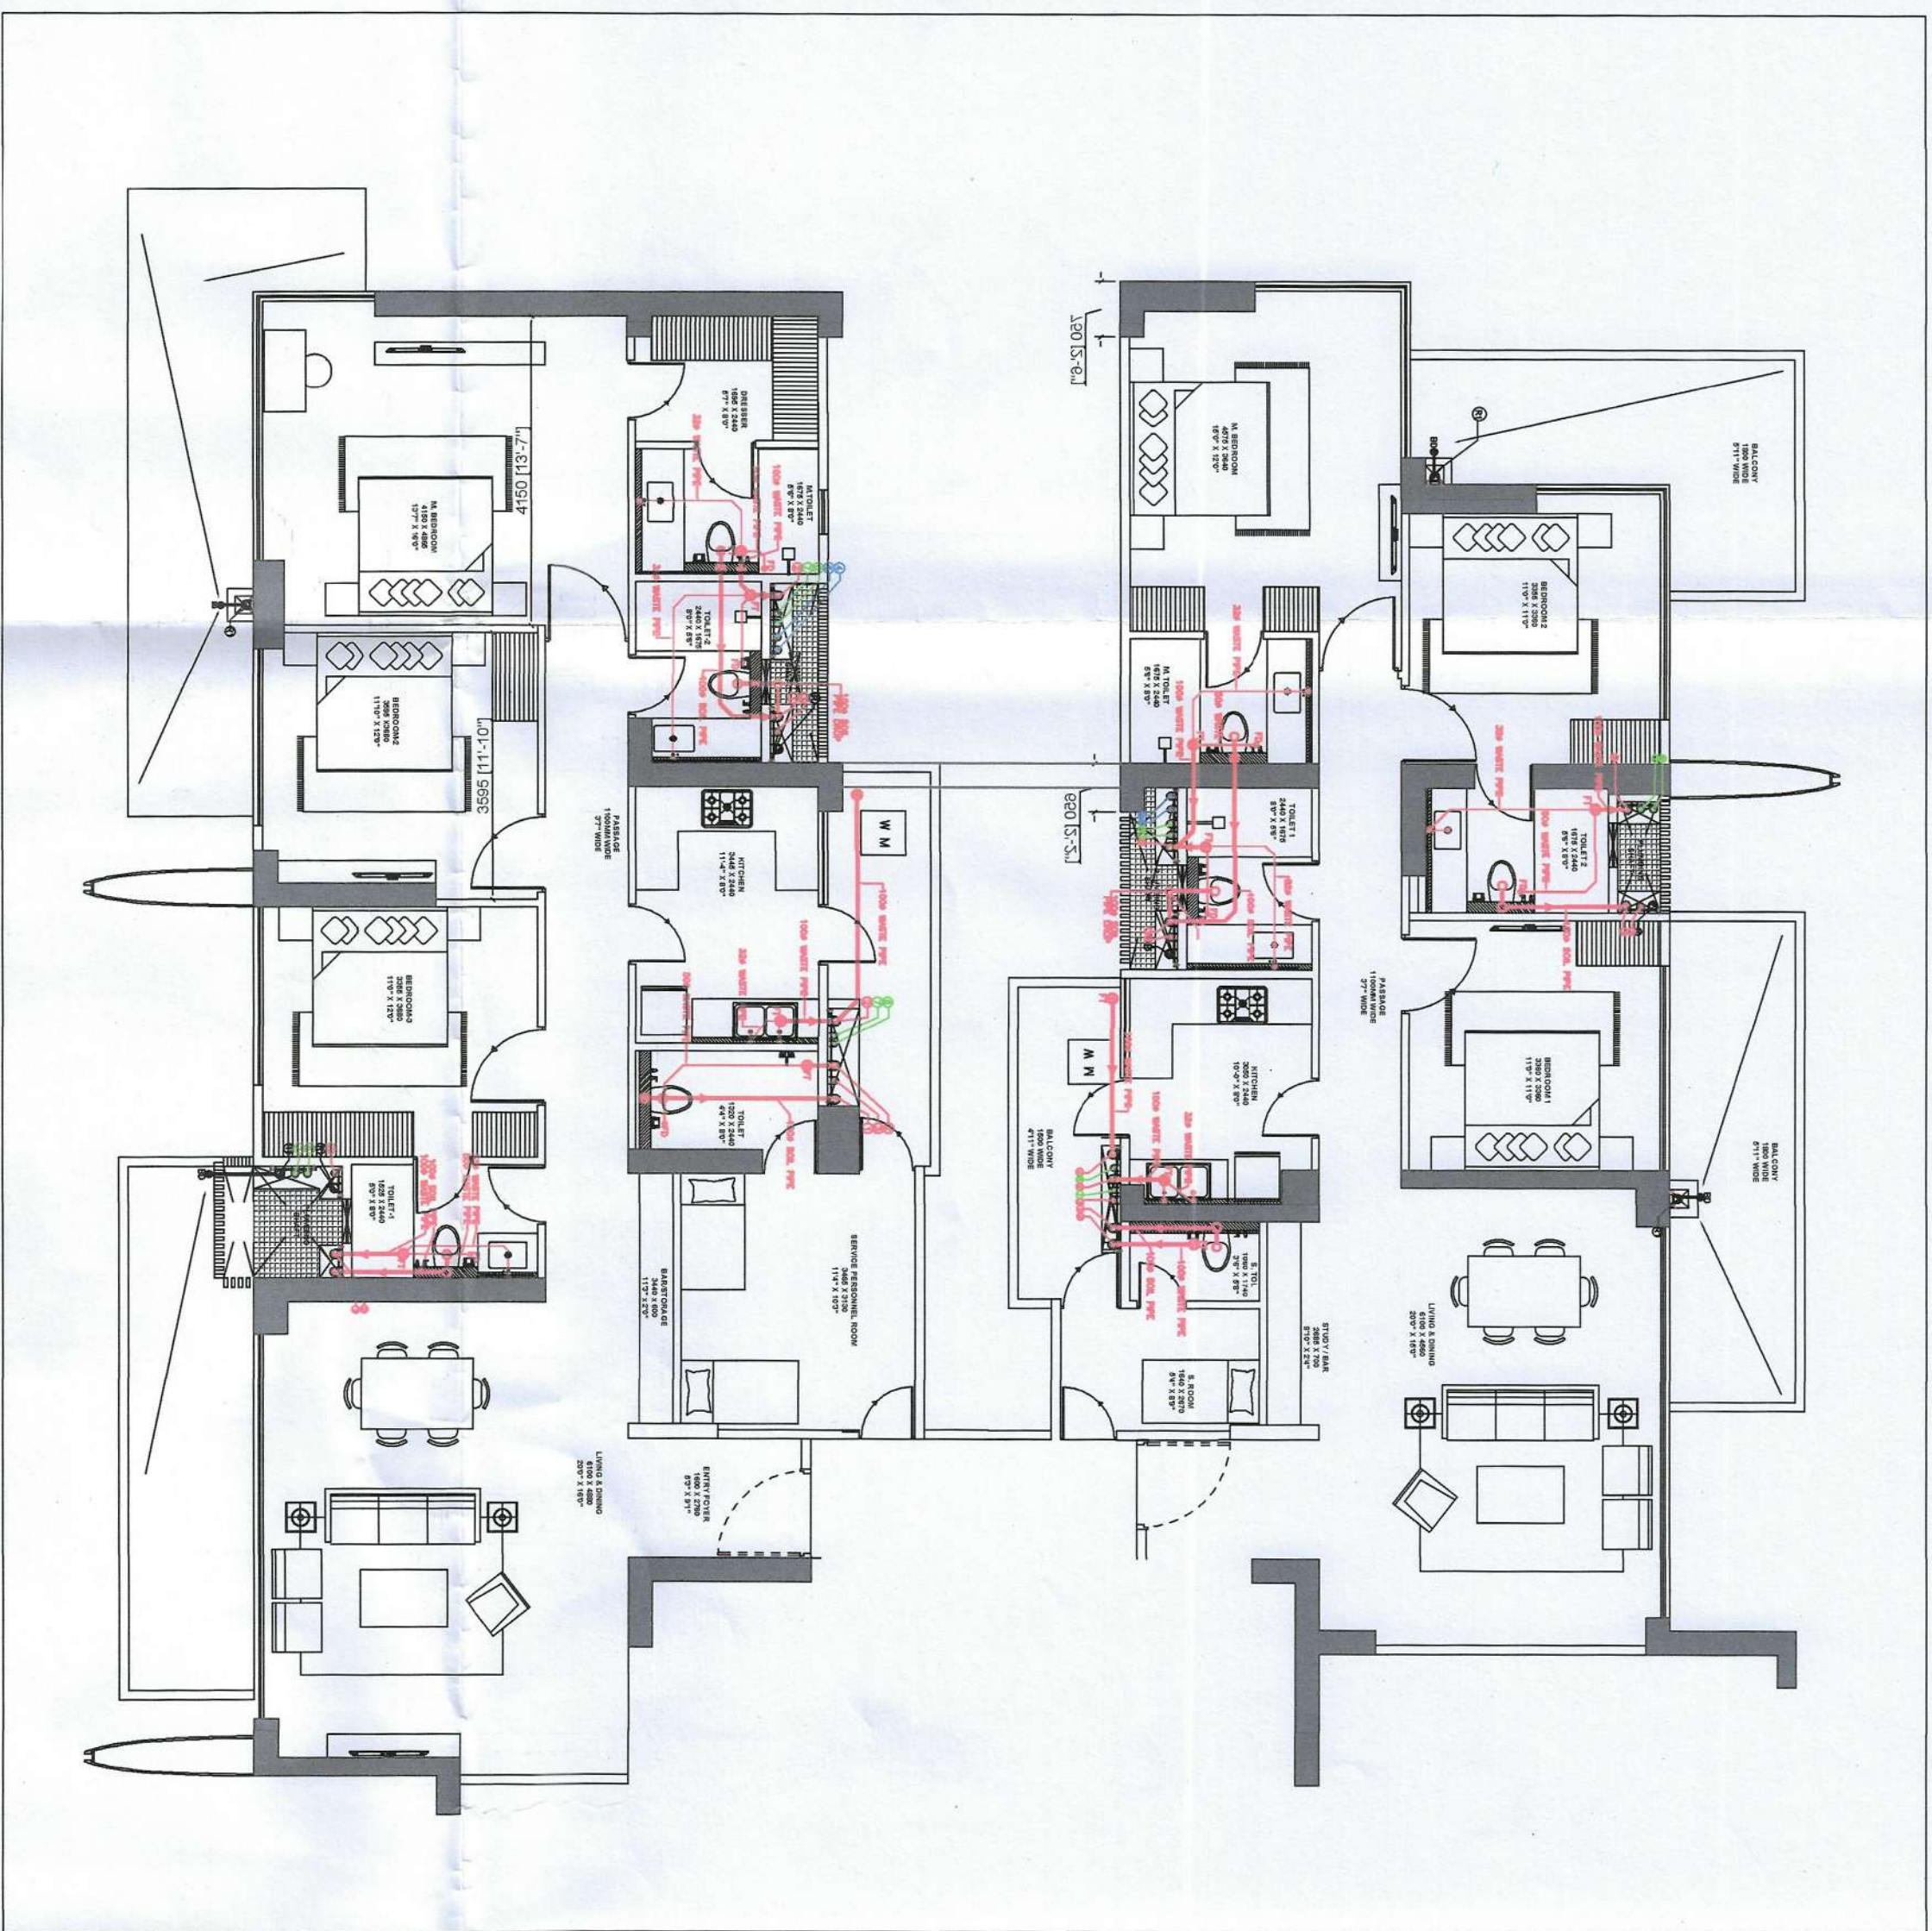


DRAINAGE

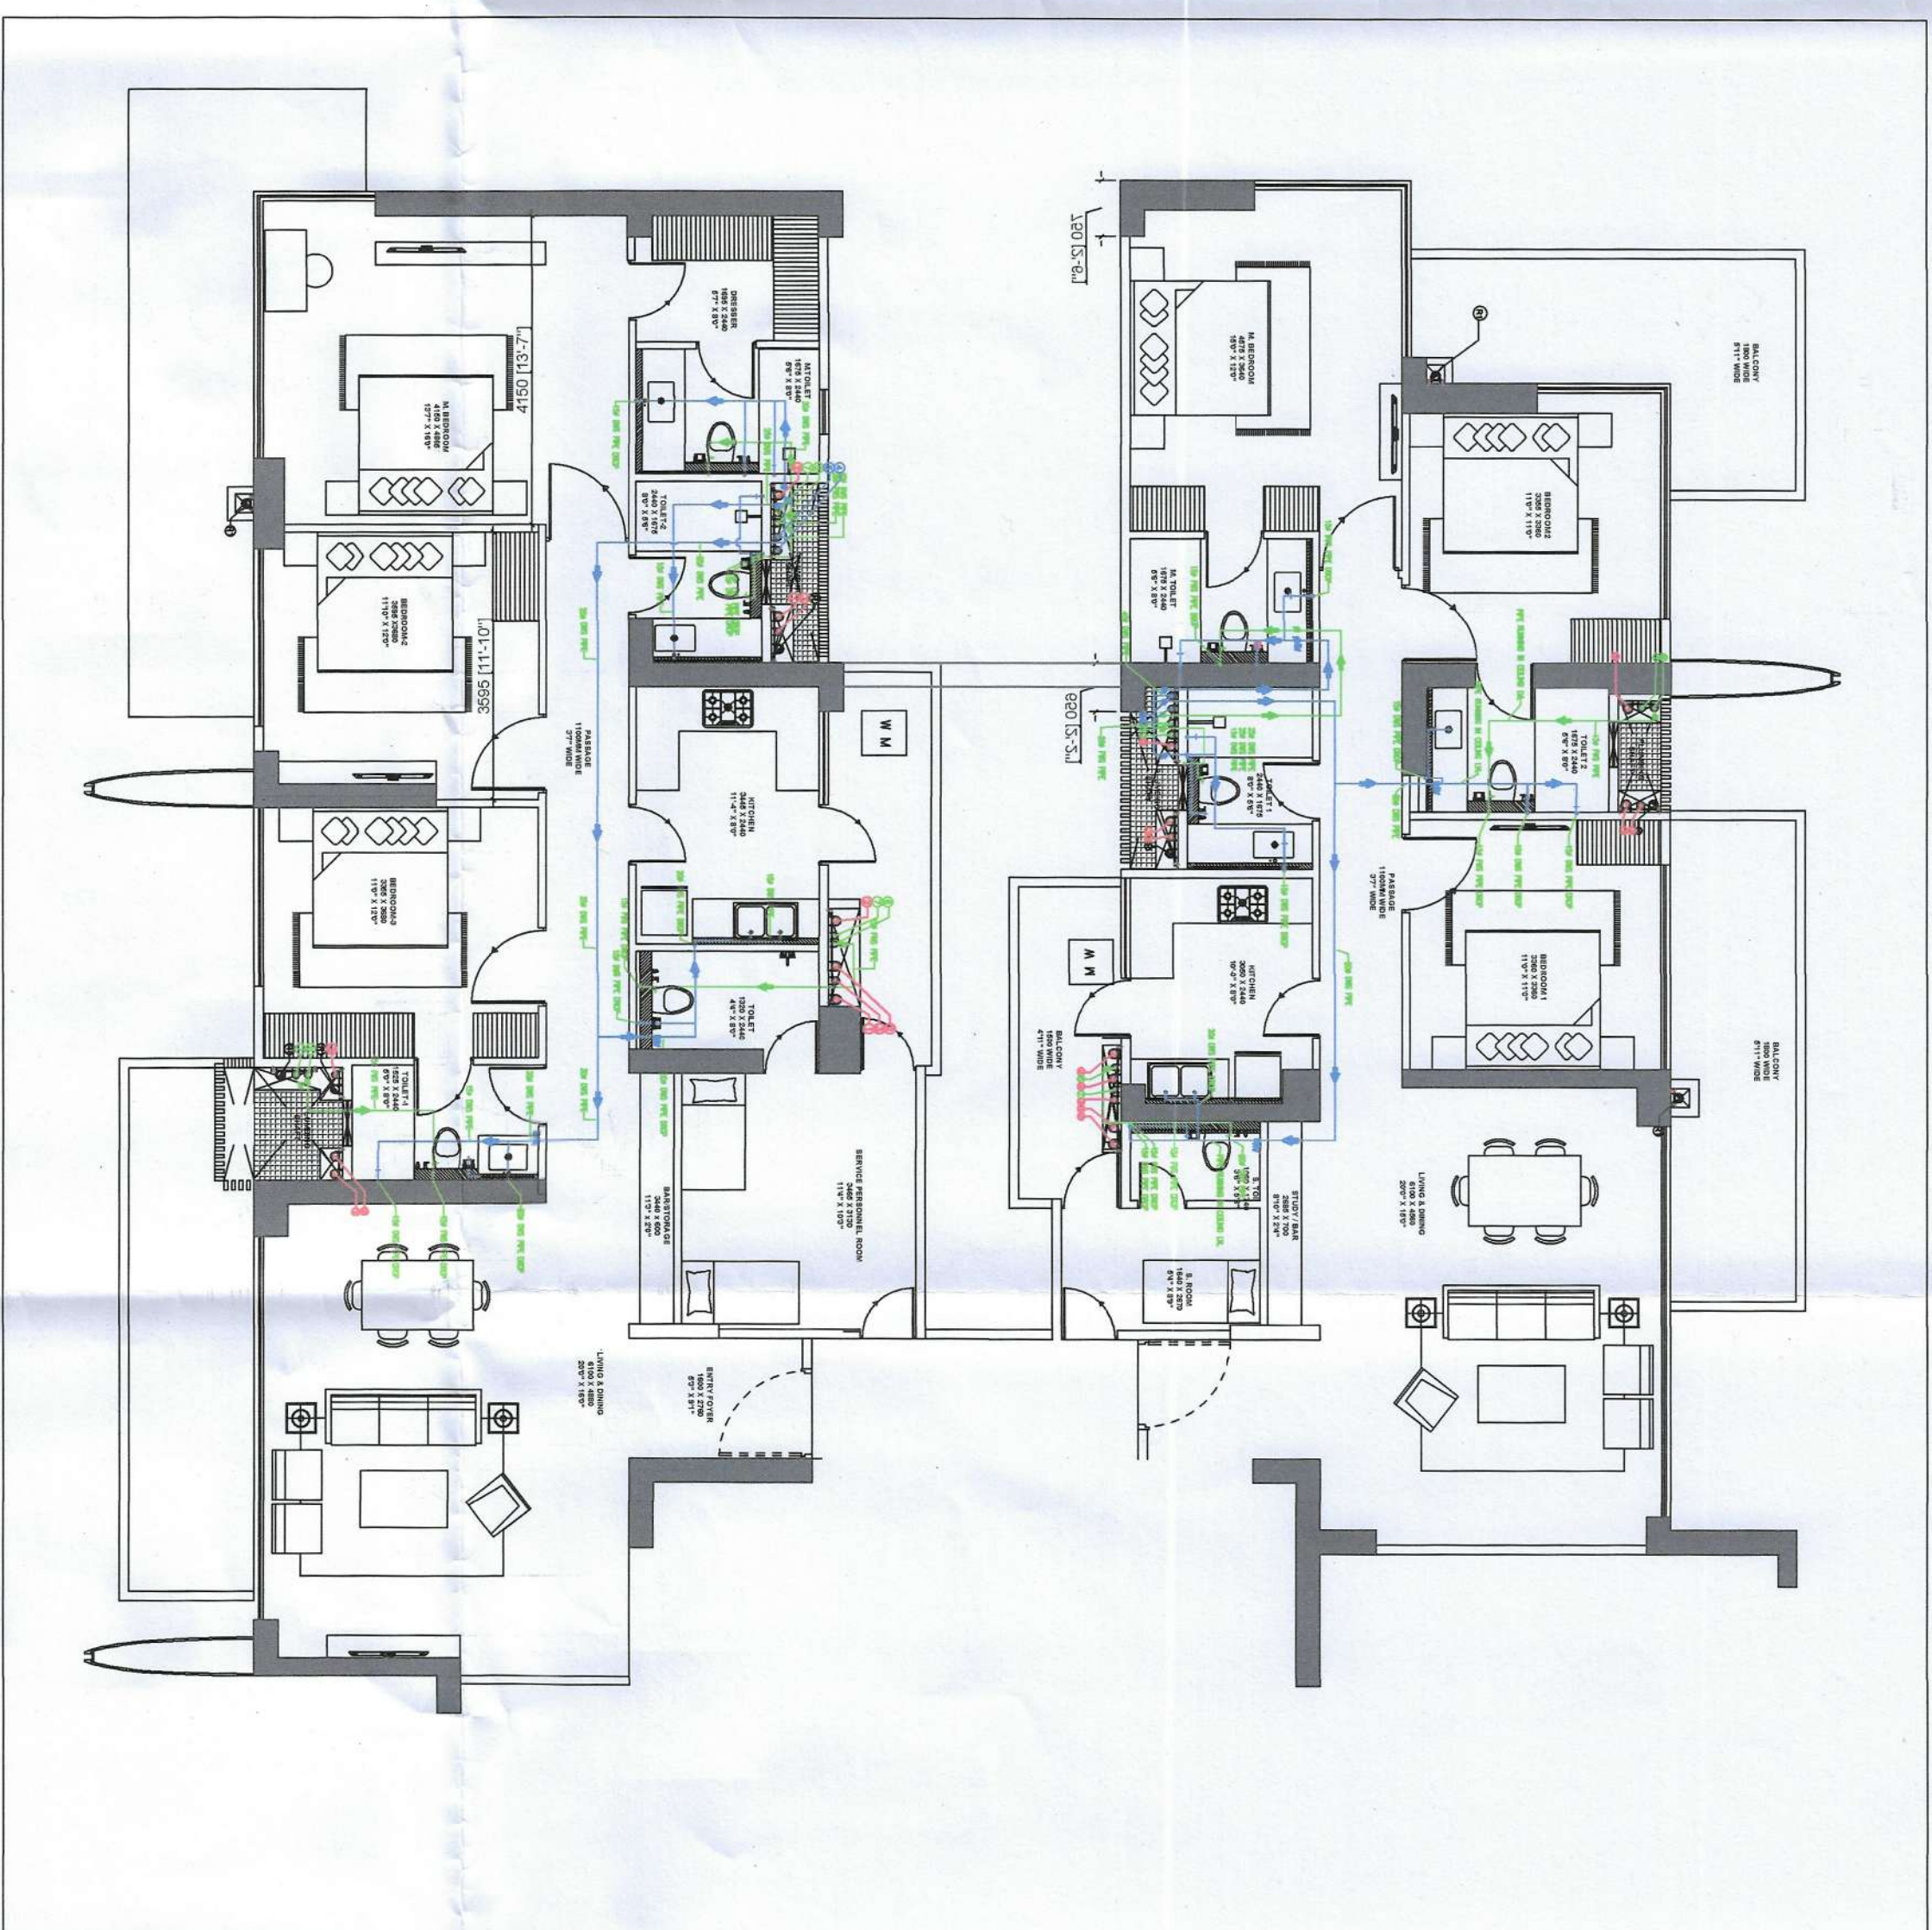

WATER SUPPLY

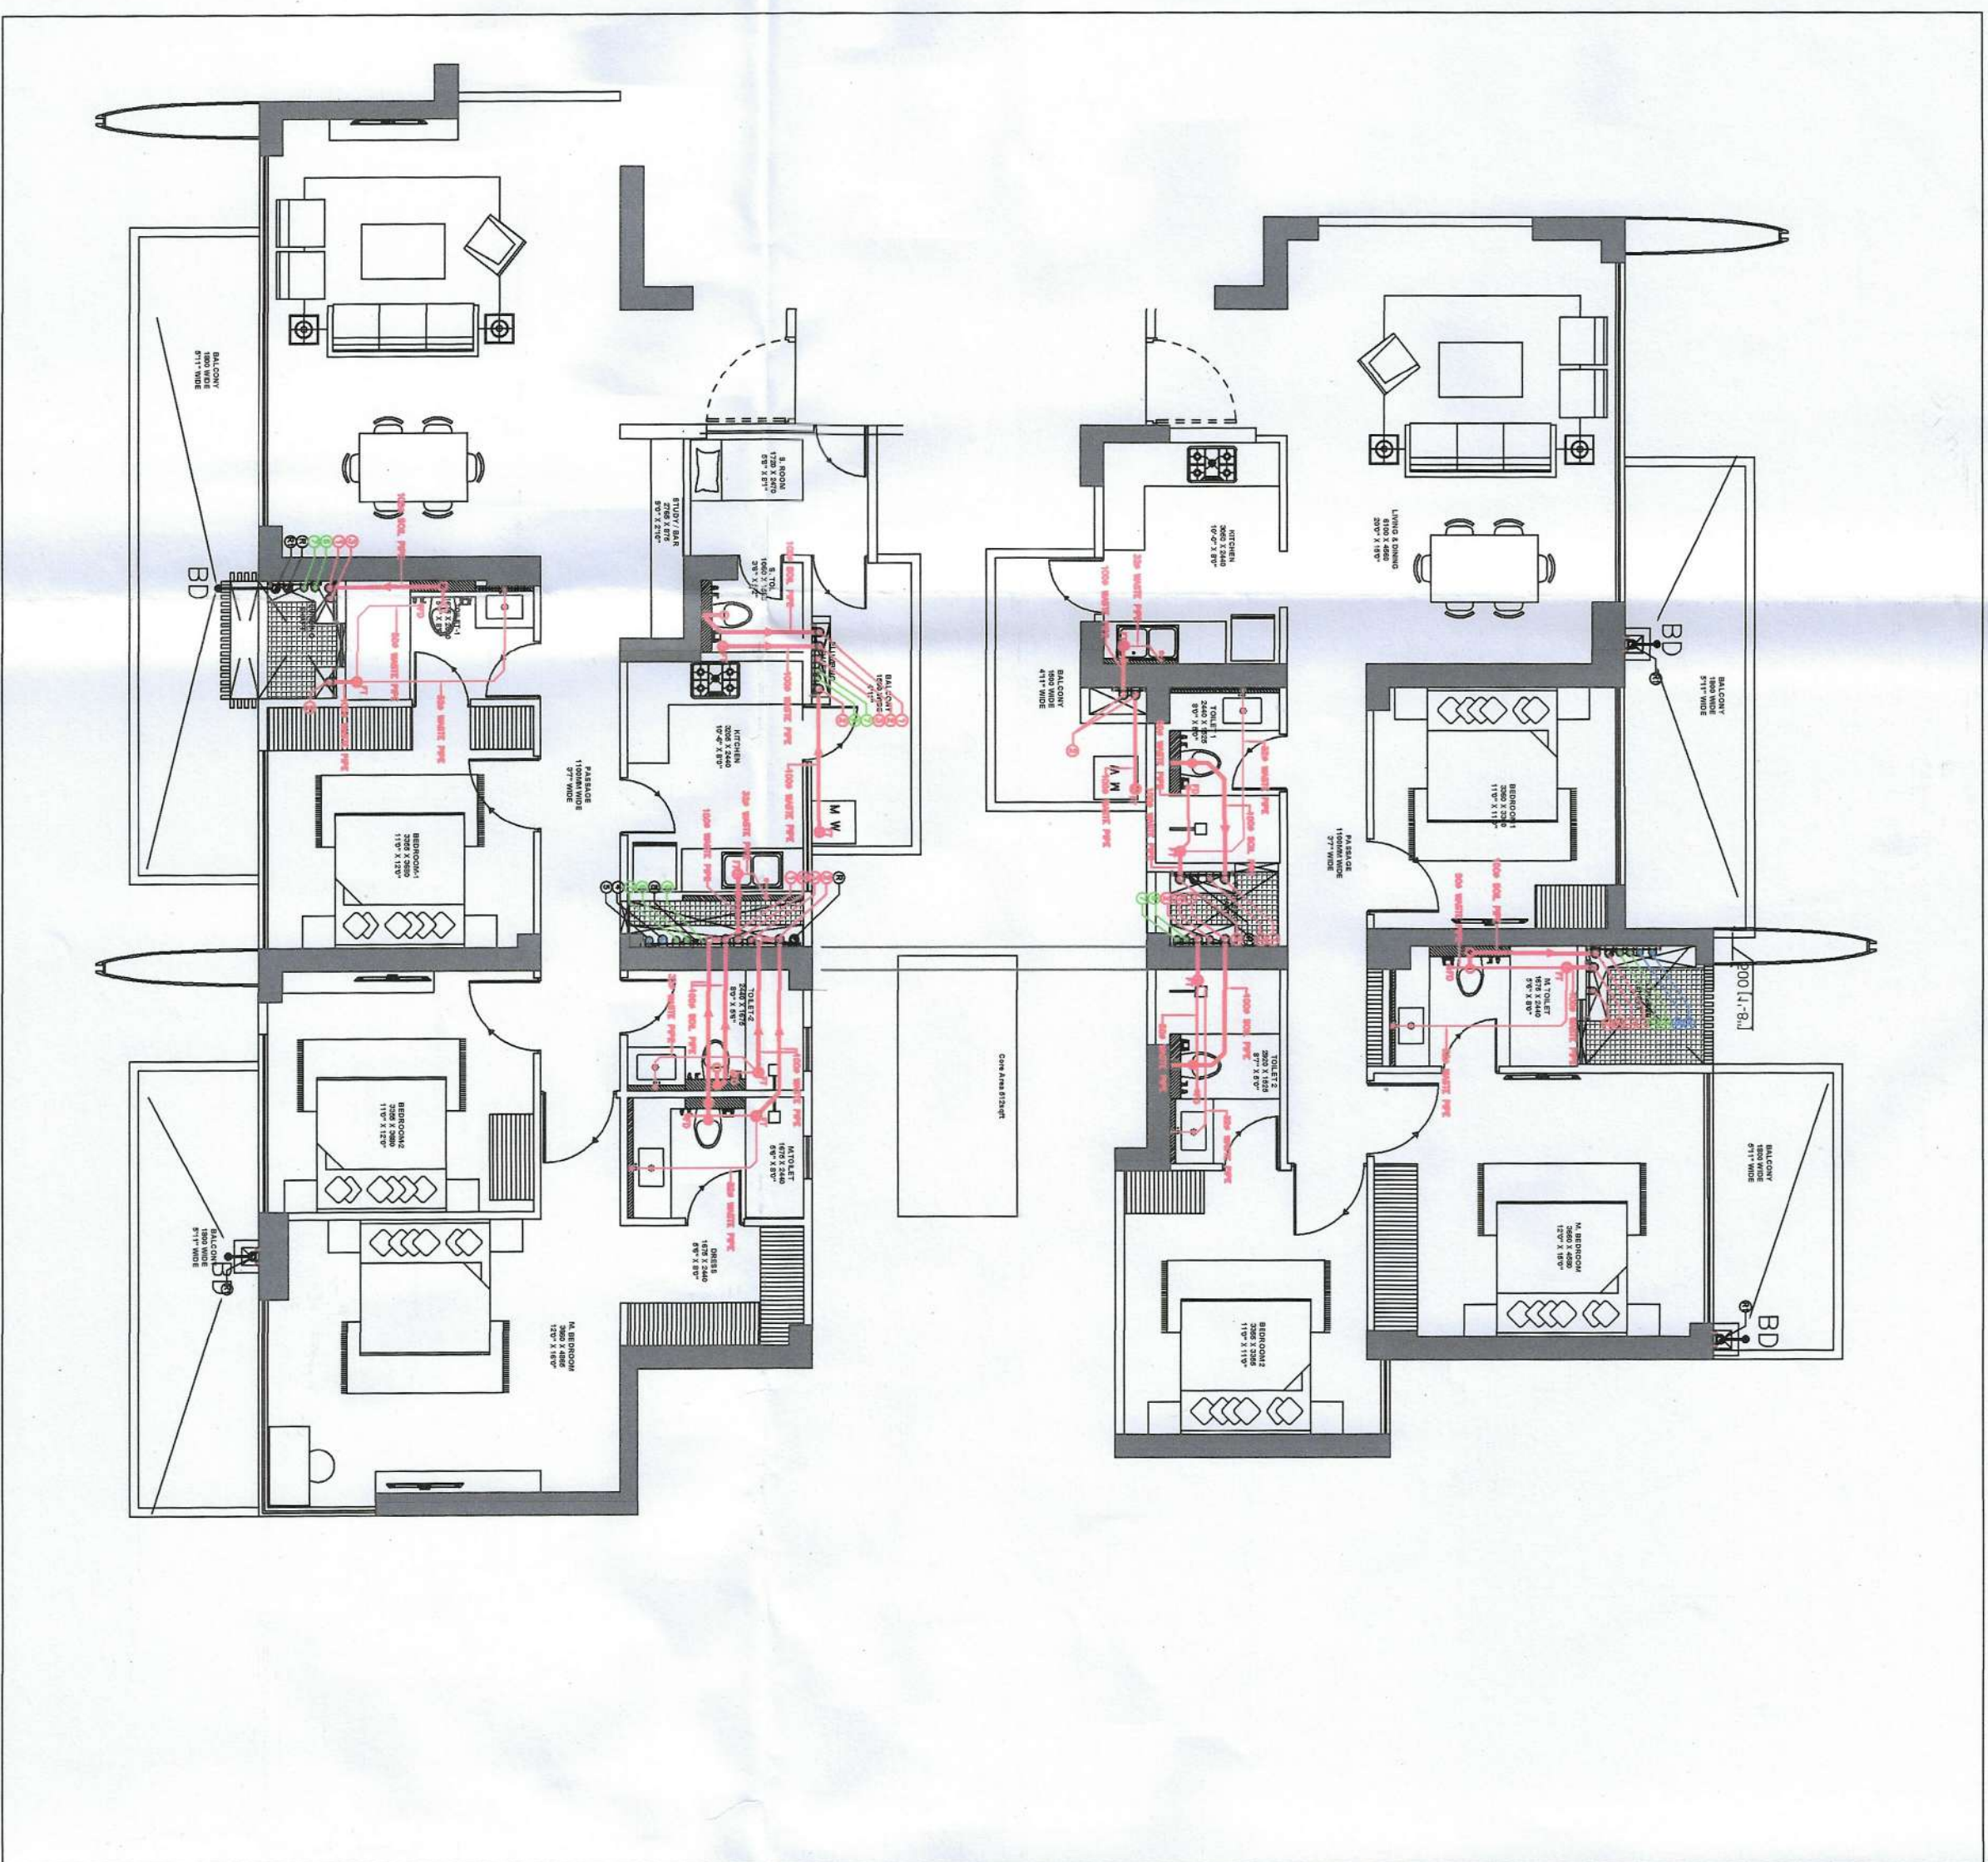

DRAINAGE

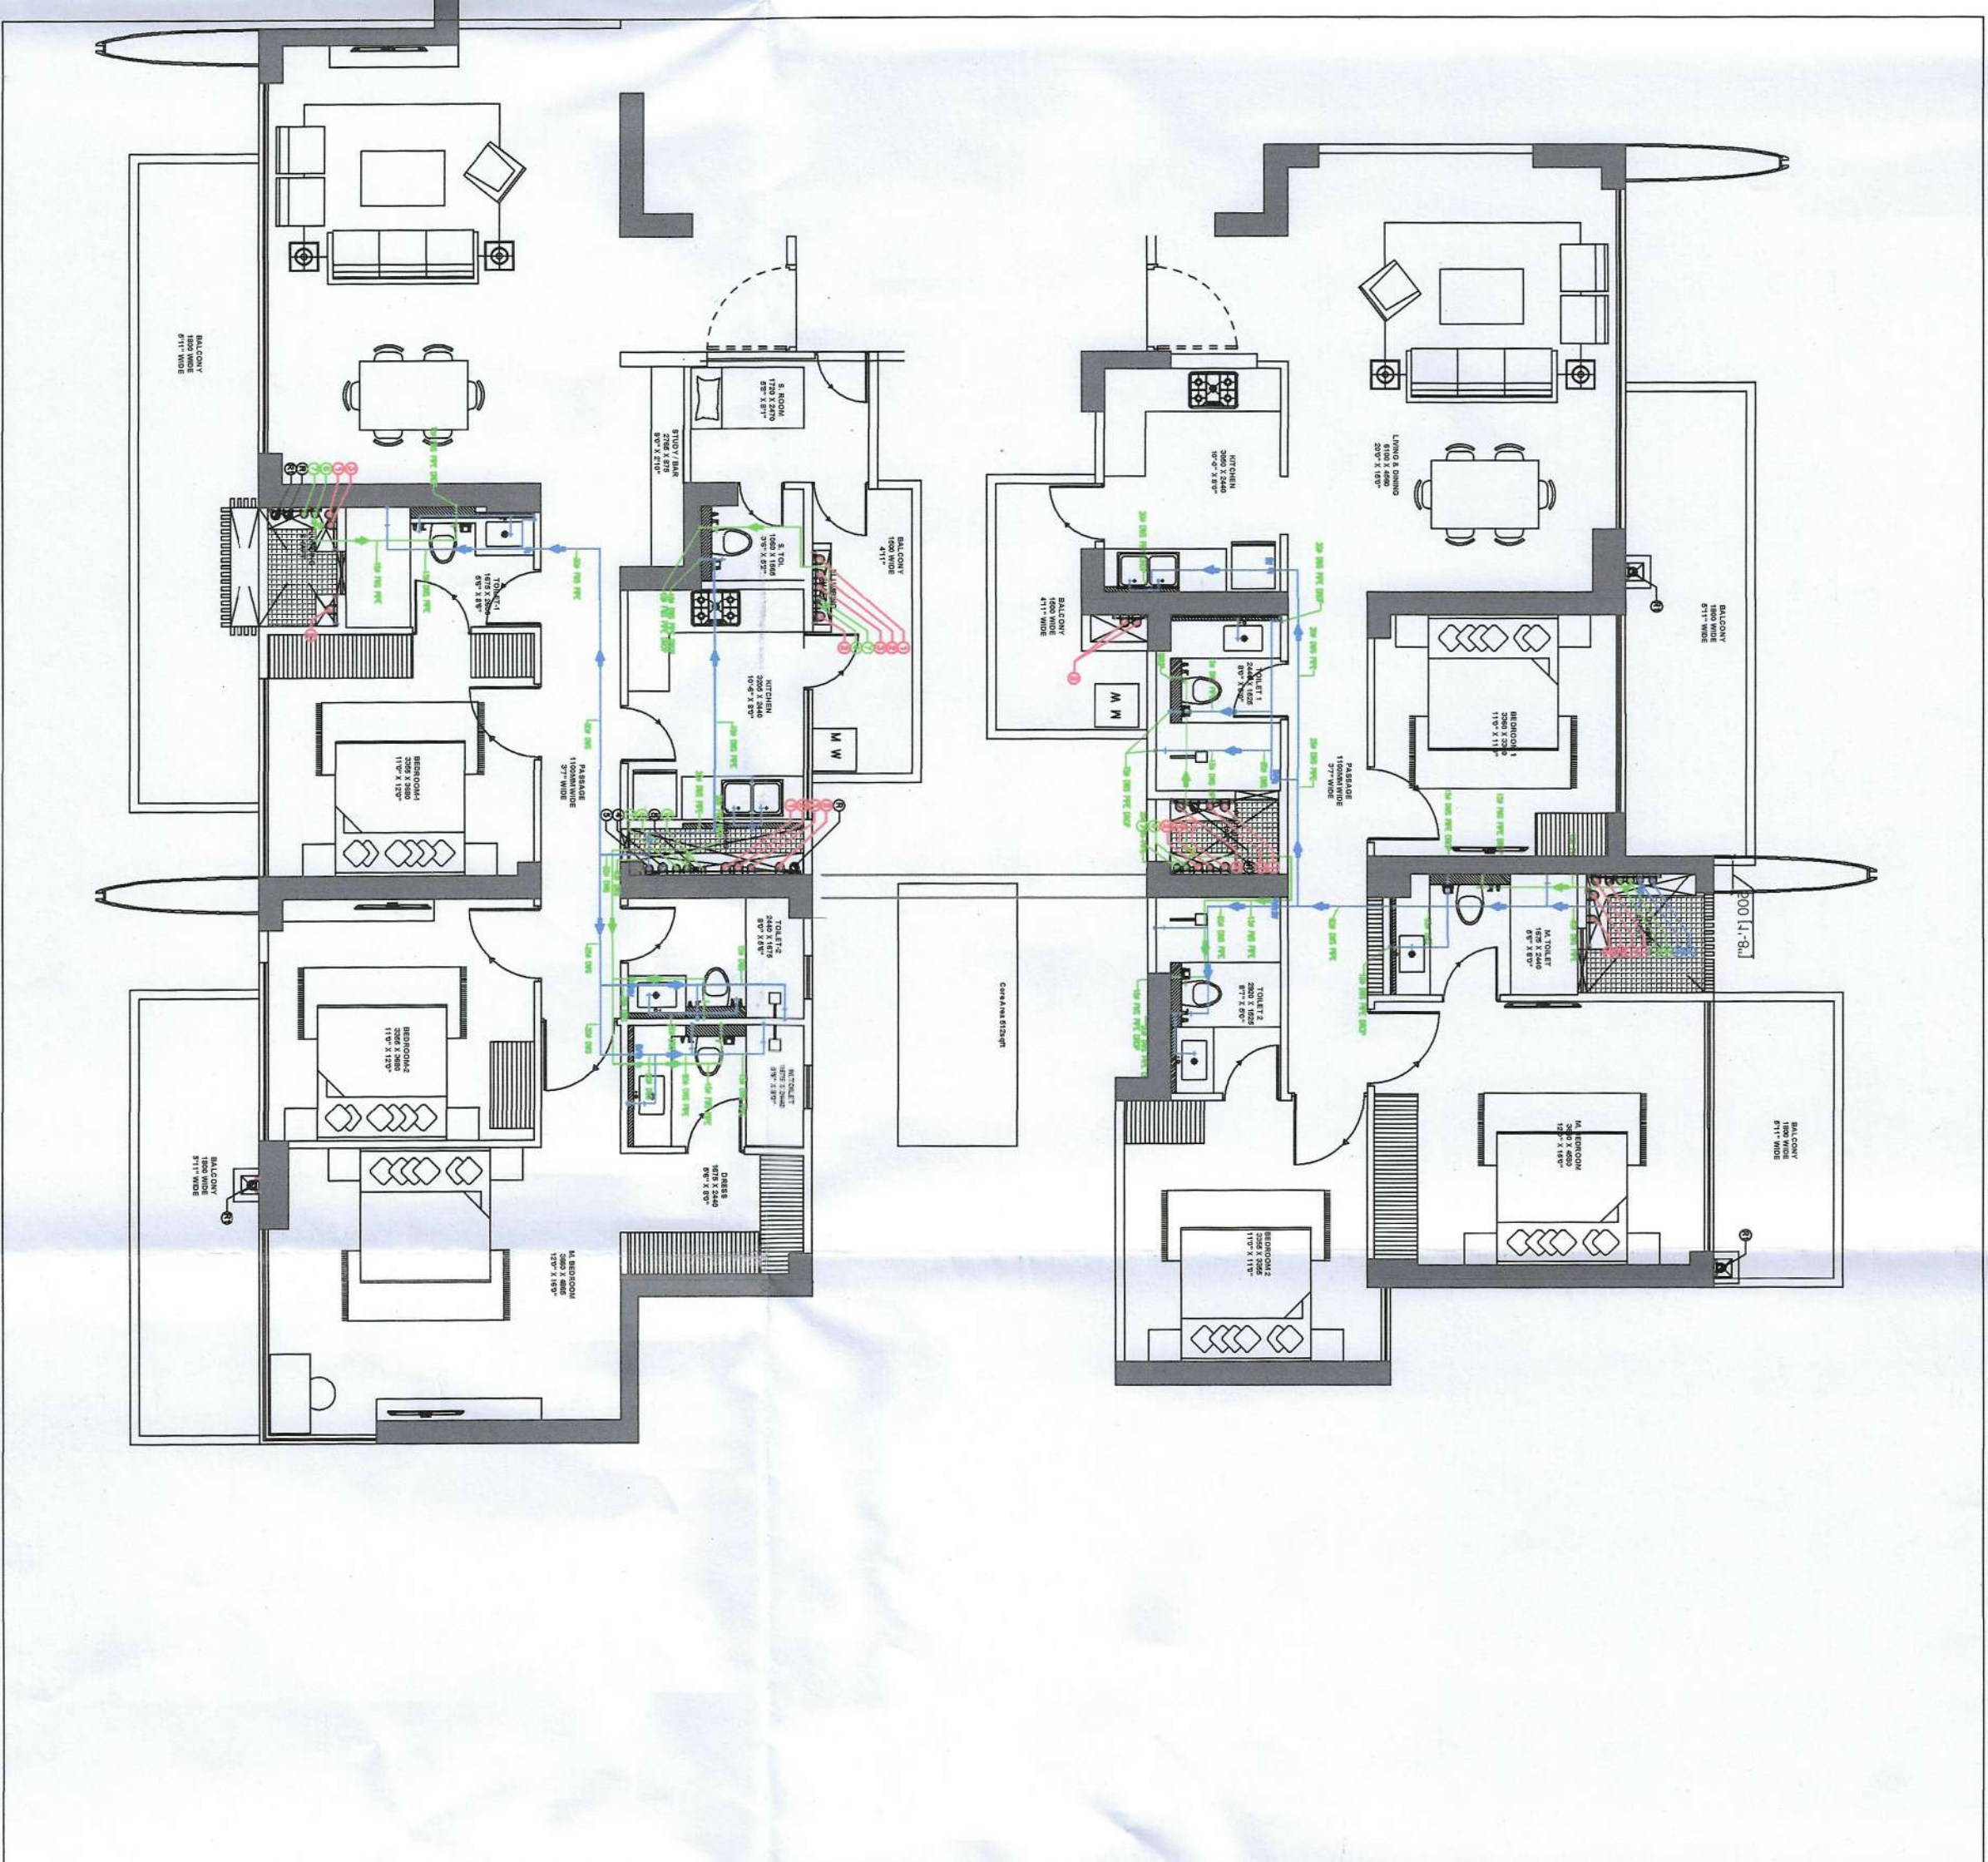

WATER SUPPLY

TOWER B TYPICAL TOILET DETAIL

Building Plans Section and Plans will be valid for five year only. To be read with accompanying documents.

Date: 19/01/2024

Building Plans Approved by Supervising Committee (VCD).

Chairman Building Plan Committee cum Senior Town Planner HSDC, IIT Madras

Recommended for sanction HOD, P/MAA

Note:

1. BUILDING HAS AUTOMATIC SPRINKLER SYSTEM WHEREVER REQUIRED BY NBC.

2. BUILDING WILL BE DESIGNED (STRUCTURES) AS PER RELEVANT IS CODES FOR EARTH QUAKE RESISTANCE.

3. POWER BACKUP/ MECHANICAL VENTILATED SHAFTS.

PROJECT:

PROPOSED BUILDING PLAN OF GROUP HOUSING AT SITE NO. GH-03 SITUATED AT SECTOR-80 (RESIDENTIAL), MANESAR-MEASURING 22601.0 SQM.

ASSOCIATE ARCHITECTS

ASSOCIATES

PLOT NO-408 SEC-37C GURGAON (PH-9560794794)

OWNER'S SEAL & SIGNATURE

ARCHITECT'S SEAL & SIGNATURE

As Reviewed/Seal
CA201255871
Mob. 9871004473

AUGUST-2024 **Scale : 1:100**

Drawing Title:- **Drawing No:-**

TOILET DETAIL TOWER-8 **TD-02**