


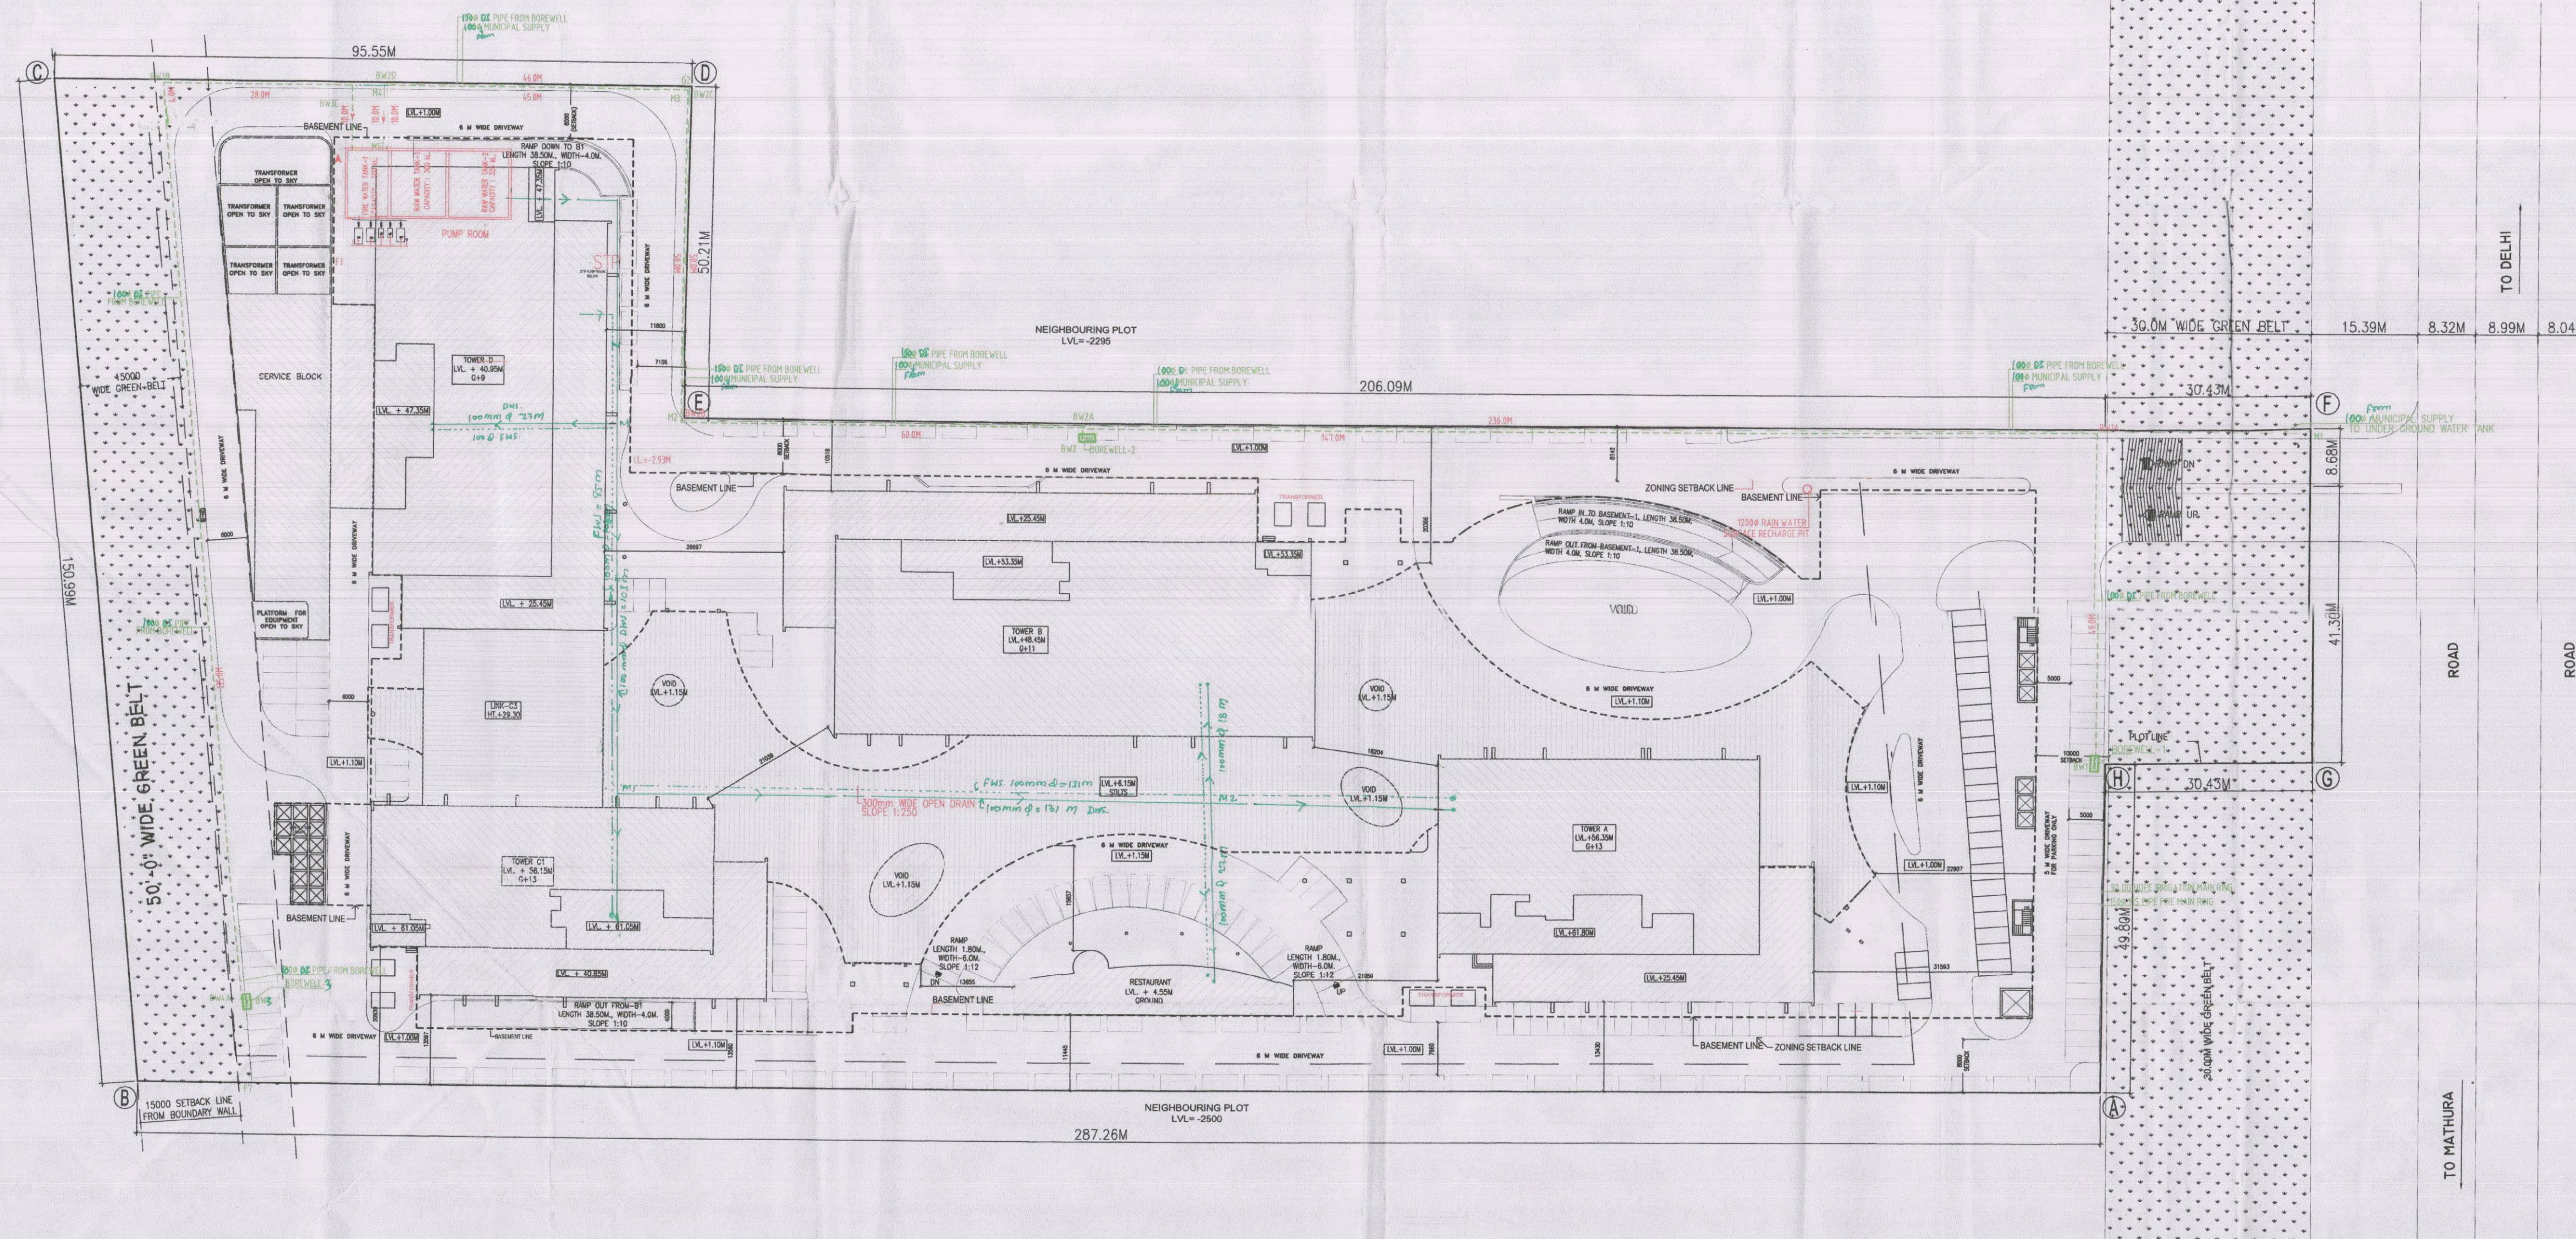

Note:-

1. BUILDING HAS AUTOMATIC SPRINKLER SYSTEM WHEREVER REQUIRED BY NBC
2. BUILDING WILL BE DESIGNED (STRUCTURES) AS PER RELEVANT IS CODES FOR EARTH QUAKE RESISTANCE
3. BUILDING IS ARTIFICIALLY LIGHTED MECHANICALLY VENTILATED & CENTRALLY AIRCONDITIONED

LEGEND:-

1. 1000 Ø SOIL & VENT PIPE
 2. 1000 Ø WASTE & VENT PIPE
 3. 750 Ø ANTI SYPHONAGE VENT PIPE(SOIL)
 4. 750 Ø ANTI SYPHONAGE VENT PIPE(WASTE)
 5. 1000 Ø SOIL PIPE
 6. 1000 Ø WASTE PIPE
 7. 750 Ø WASTE PIPE
 8. 500 Ø ANTI SYPHONAGE PIPE(SOIL)
 9. 500 Ø ANTI SYPHONAGE PIPE(WASTE)
 10. 500 Ø WASTE PIPE
 11. 400 Ø SOIL/WASTE PIPE
 12. 320 Ø WASTE PIPE
 13. COLD WATER SUPPLY(DOMESTIC) DN. TAKE PIPE 13TH TO 7TH FLOOR
 14. COLD WATER SUPPLY(DOMESTIC) DN. TAKE PIPE 6TH TO GROUND FLOOR
 15. COLD WATER SUPPLY(FLUSHING) DN. TAKE PIPE 13TH TO 7TH FLOOR
 16. COLD WATER SUPPLY(FLUSHING) DN. TAKE PIPE 6TH TO GROUND FLOOR
 17. COLD WATER SUPPLY(DOMESTIC) RISER TO OHT
 18. COLD WATER SUPPLY(FLUSHING) RISER TO OHT 19. COLD WATER SUPPLY(SOFT WATER) RISER TO OHT
- RWP 2000 RWP

Project

REVISED BUILDING PLAN OF I.T. PARK MEASURING 8.793 ACRES (LICENCE NO. 1133 OF DATED 22.9.2006) IN SECTOR-27 B FARIDABAD BEING DEVELOPED BY M/S VATIKA IT PARK PVT. LTD. PREVIOUSLY KNOWN AS HIND ENTERPRISES PVT. LTD.

Associate Architects

RISIMS
ARCHITECTS

RSMS ARCHITECTS PVT. LTD.

59, Naga Niwas, Bhawani Kunj
(Behind D2), Vasant Kunj,
New Delhi-110070.
Tel: 011-26898616, 26898617
www.rsms-arch.com

Checked subject to comments
in forwarding letter No. 155/2012
dated 15.07.12 and notes attached
with the estimate

For Vatika IT Park Pvt. Ltd.
Authorised Signatory

ARCHITECT'S SEAL & SIGNATURE	OWNER'S SEAL & SIGNATURE
JULY, 2012	Scale: 1:400
Drawing Title:- SITE PLAN WATER SUPPLY	Drawing No:- ST-02

For VATIKA LIMITED
Authorised Signatory