


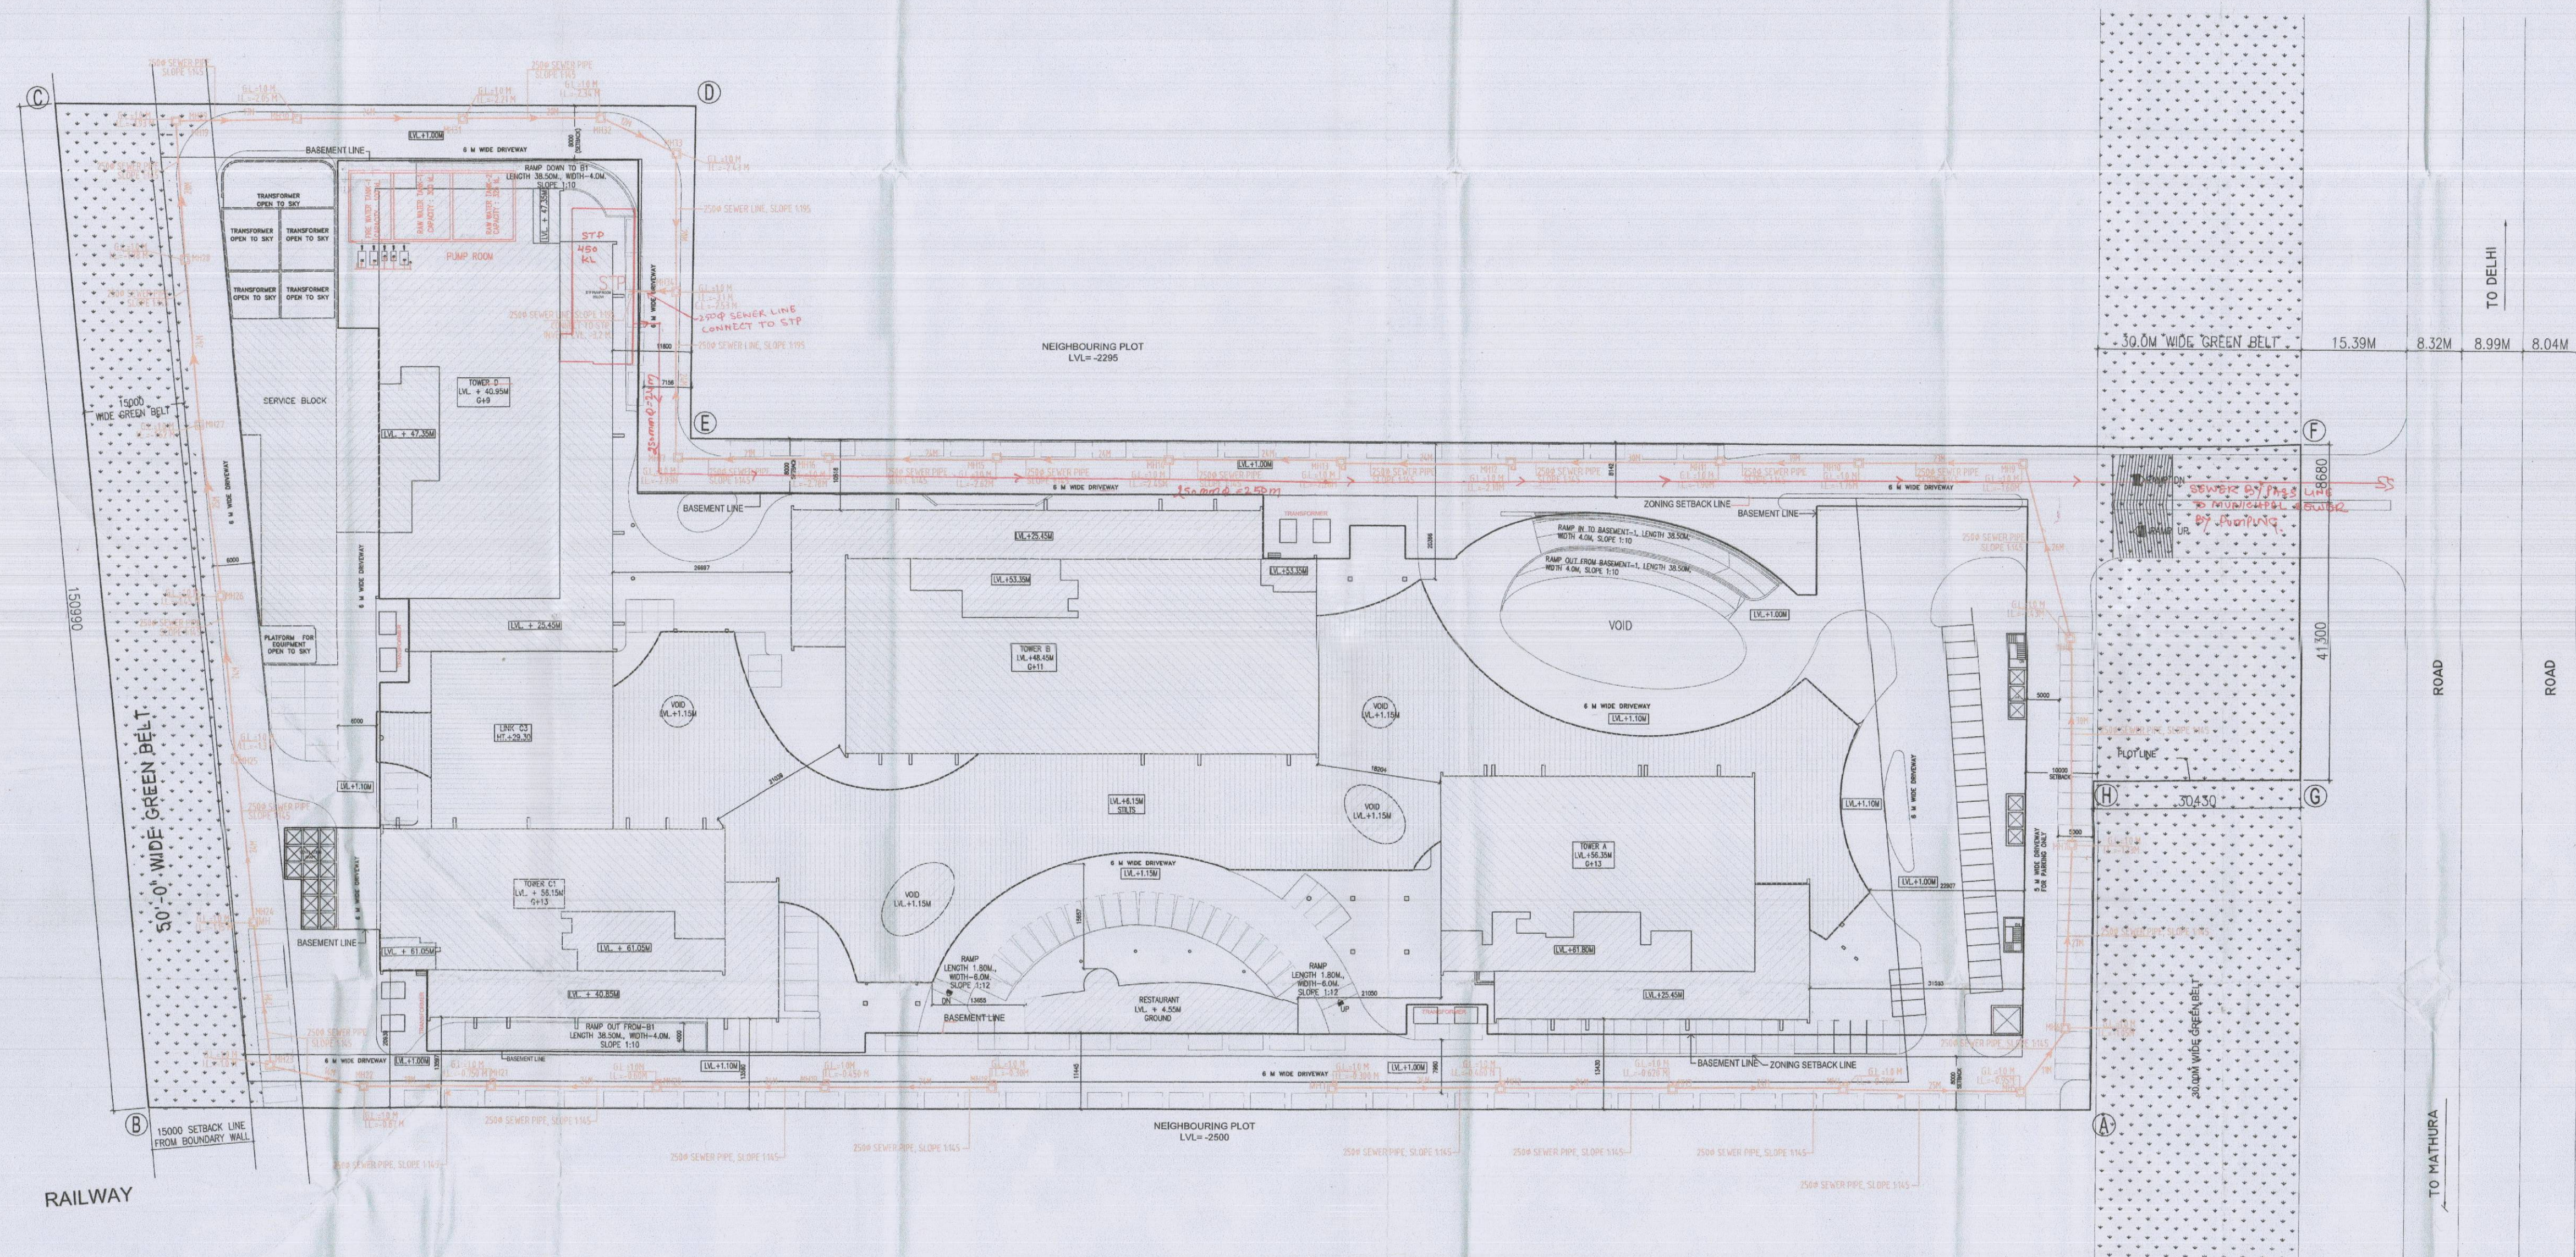

Note:-
 1. BUILDING HAS AUTOMATIC SPRINKLER SYSTEM WHEREVER REQUIRED BY NBC
 2. BUILDING WILL BE DESIGNED (STRUCTURES) AS PER RELEVANT IS CODES FOR EARTHQUAKE RESISTANCE
 3. BUILDING IS ARTIFICIALLY LIGHTED MECHANICALLY VENTILATED & CENTRALLY AIR-CONDITIONED

- LEGEND:-
1. 1000 SOIL & VENT PIPE
 2. 1000 WASTE & VENT PIPE
 3. 750 ANTI-SYPHONAGE VENT PIPE(SOIL)
 4. 750 ANTI-SYPHONAGE VENT PIPE(WASTE)
 5. 1000 SOIL PIPE
 6. 1000 WASTE PIPE
 7. 750 WASTE PIPE
 8. 500 ANTI-SYPHONAGE PIPE(SOIL)
 9. 500 ANTI-SYPHONAGE PIPE(WASTE)
 10. 500 WASTE PIPE
 11. 400 SOIL/WASTE PIPE
 12. 300 WASTE PIPE
 13. COLD WATER SUPPLY(DOMESTIC) DN TAKE PIPE 13TH TO 7TH FLOOR
 14. COLD WATER SUPPLY(DOMESTIC) DN TAKE PIPE 6TH TO GROUND FLOOR
 15. COLD WATER SUPPLY(FLUSHING) DN TAKE PIPE 13TH TO 7TH FLOOR
 16. COLD WATER SUPPLY(FLUSHING) DN TAKE PIPE 6TH TO GROUND FLOOR
 17. COLD WATER SUPPLY(DOMESTIC) RISER TO OHT
 18. COLD WATER SUPPLY(FLUSHING) RISER TO OHT
 19. COLD WATER SUPPLY(SOFT WATER) RISER TO OHT
- RWP 2000 RWP

Project:
 REVISED BUILDING PLAN OF LT PARK MEASURING 8.793 ACRES (LICENCE NO. 1133 OF DATED 22.9.2006) IN SECTOR-27 B FARIDABAD BEING DEVELOPED BY M/S VATIKA IT PARK PVT. LTD. PREVIOUSLY KNOWN AS HIND ENTERPRISES PVT. LTD.

Associate Architects
RISMS ARCHITECTS
 RMS ARCHITECTS PVT. LTD.
 69, Nara Niwas, Bhawan Kunj (Behind D2), Vasant Kunj, New Delhi-110070.
 Tel.: 011-26898616, 26898617
 www.rsms-arch.com

Scale: 1:400
 Date: 10/07/2012
 Checked by: [Signature]
 Drawn by: [Signature]

ARCHITECT'S SEAL & SIGNATURE [Signature] Executive Engineer (W) for Civil Engineering HUDA Panchsila Faridabad		OWNER'S SEAL & SIGNATURE [Signature] For Vatika IT Park Pvt. Ltd. Authorised Signatory For Vatika IT Park Pvt. Ltd.	
JULY, 2012 Drawing Title: SITE PLAN SEWERAGE PLAN		Scale: 1:400 Drawing No: ST-03	

For VATIKA LIMITED
 Authorised Signatory
 [Signature]