
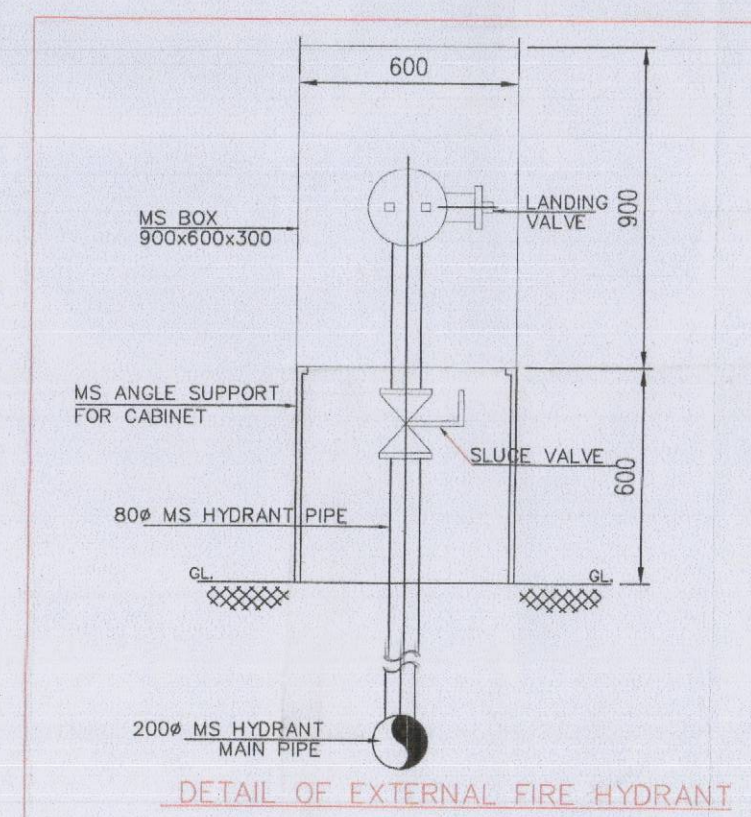


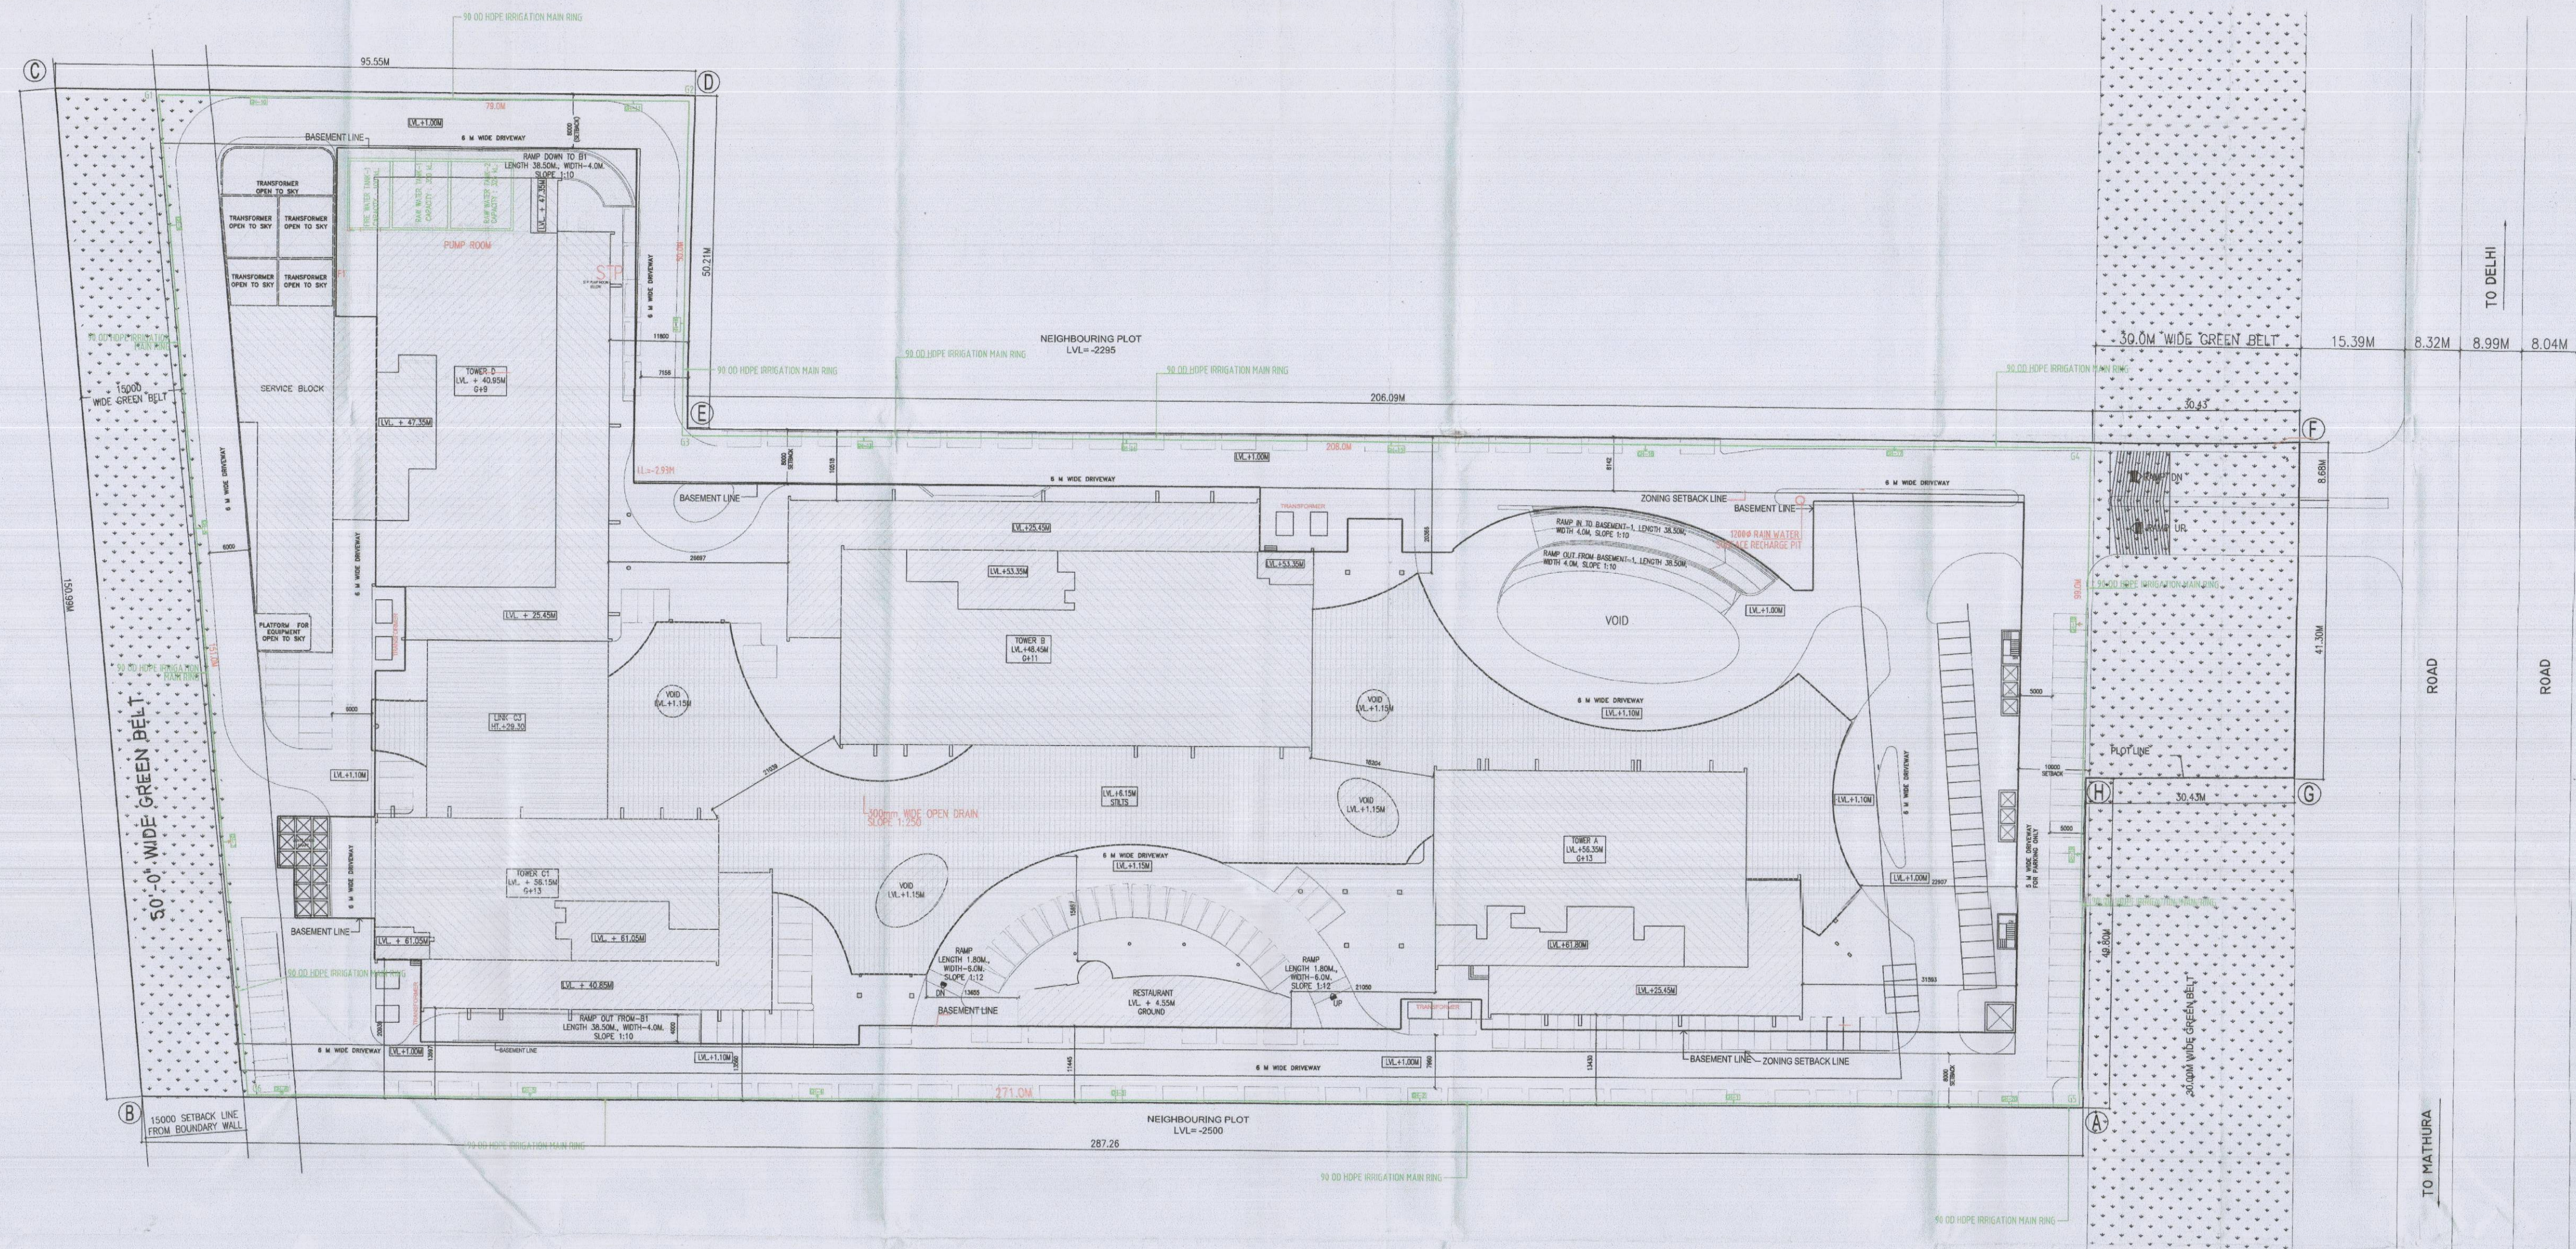

Checked subject to correction
In accordance with the
DL 34/2011 and other attached
with the estimate

Executive Engineer (W)
for Chief Engineer
HUDA Panchsukh
Gurgaon
Director General
Town & Country Planning
Haryana, Chandigarh

Note:-

1. BUILDING HAS AUTOMATIC SPRINKLER SYSTEM WHEREVER REQUIRED BY NBC
2. BUILDING WILL BE DESIGNED (STRUCTURES) AS PER RELEVANT IS CODES FOR EARTH QUAKE RESISTANCE
3. BUILDING IS ARTIFICIALLY LIGHTED MECHANICALLY VENTILATED & CENTRALLY AIRCONDITIONED

LEGEND:-

LEGEND:-

1. 1000 SOIL & VENT PIPE
2. 1000 WASTE & VENT PIPE
3. 750 ANTI SYPHONAGE VENT PIPE(SOIL)
4. 750 ANTI SYPHONAGE VENT PIPE(WASTE)
5. 1000 SOIL PIPE
6. 1000 WASTE PIPE
7. 750 WASTE PIPE
8. 500 ANTI SYPHONAGE PIPE(SOIL)
9. 500 ANTI SYPHONAGE PIPE(WASTE)
10. 500 WASTE PIPE
11. 400 SOIL/WASTE PIPE
12. 320 WASTE PIPE
13. COLD WATER SUPPLY(DOMESTIC) DN TAKE PIPE 13TH TO 7TH FLOOR
14. COLD WATER SUPPLY(DOMESTIC) DN TAKE PIPE 8TH TO GROUND FLOOR
15. COLD WATER SUPPLY(FLUSHING) DN TAKE PIPE 13TH TO 7TH FLOOR
16. COLD WATER SUPPLY(FLUSHING) DN TAKE PIPE 6TH TO GROUND FLOOR
17. COLD WATER SUPPLY(DOMESTIC) RISER TO OHT
18. COLD WATER SUPPLY(FLUSHING) RISER TO OHT 19. COLD WATER SUPPLY(SOFT WATER) RISER TO OHT

RWP 2000 RWP

Project

REVISED BUILDING PLAN OF I.T. PARK MEASURING 8.793 ACRES (LICENCE NO. 1133 OF DATED 22.9.2006) IN SECTOR-27 B FARIDABAD BEING DEVELOPED BY M/S VATIKA IT PARK PVT. LTD. PREVIOUSLY KNOWN AS HIND ENTERPRISES PVT. LTD.

Associate Architects

RISMS
ARCHITECTS

RISMS ARCHITECTS PVT. LTD.

69, Nara Niwas Bhawanij Kunj
(Behind D2), Vasant Kunj,
New Delhi-110070.
Tel.: 011-26898616, 26898617
www.risms-arch.com

SAINTED

To be used in connection with
the plan No. 1133 of dated 22.9.2006

For Vatika IT Park Panchsukh
For Vatika IT Park Panchsukh
For Vatika IT Park Panchsukh

ARCHITECT'S SEAL & SIGNATURE	OWNER'S SEAL & SIGNATURE
Executive Engineer HUDA Division No. 3 Faridabad	For Vatika IT Park Panchsukh Authorized Signatory For Vatika IT Park Panchsukh
DATE: JULY 2012	Scale: 1:400
SITE PLAN IRRIGATION PLAN	Drawing No.: ST-05

For VATIKA LIMITED

Authorised Signatory