


DRG. NO.- 2723/F-05
PROJECT:
PROPOSED GROUP HOUSING (GH1)
BUILDING PLAN AN AREA MEASURING
0.75989 ACRES IN SECTOR-23 & 23A,
GURUGRAM, BEING DEVELOPED BY:-
M/S META DESIGN SOLUTIONS PVT. LTD.

Fire Fighting Scheme Approval
Visa letter No. 1339/2022
Dated: 22.07.2022
As per H.O. Part IV, Revised 2015
Certified that Fire Fighting Scheme is
as per H.O. Part IV, Revised 2015
FSG
Gurugram
Deputy Director (R&D)

OPENING SCHEDULE		
S.NO	TYPE	WIDTH IN MM
1	D1	1500
2	D2	850
3	D3	850
4	D4	1200
5	D5	1500
6	FD1	1250
7	FD2	1500
8	W1	1500
9	W2	1800
10	W3	1500
11	W4	1200
12	W5	1500
13	W6	1500
14	W7	1500
15	W8	1500
16	W9	1500
17	W10	1500
18	W11	1500
19	W12	1500
20	W13	1500
21	W14	1500
22	W15	1500

LEGEND	
	SPRINKLER (PENDENT TYPE)
	SPRINKLER HEAD (SIDE WALL TYPE)
	SPRINKLER HEAD (UPRIGHT TYPE)
	FD1 = FIRE SMOKE CHECK DOOR SIZE = 1.2X2.1M HT.
	FD2 = FIRE SMOKE CHECK DOOR SIZE = 1.3X2.1M HT.
	FD3 = FIRE SMOKE CHECK DOOR SIZE = 0.6X2.1M HT. (FOR L.V. SHAFT & ELEC. SHAFT)
	1500 BUTTERFLY VALVE
	FLOW SWITCH
	FD = FIRE DOOR 1HR RATED MAIN UNIT DOOR OF FLATS SIZE = 1.2X2.1M HT.
	4KG ABC FIRE EXTINGUISHER
	4.5KG CO2 FIRE EXTINGUISHER
	MANUAL CALL POINT
	HOOTER
	1500 WET RISER WITH SINGLE HYDRANT VALVE, BRANCH PIPE, 2 NOS RRL HOSE (1.5M LENGTH), 30M LENGTH HOSE REEL (25M DIA) AND FIRE MAN AXES

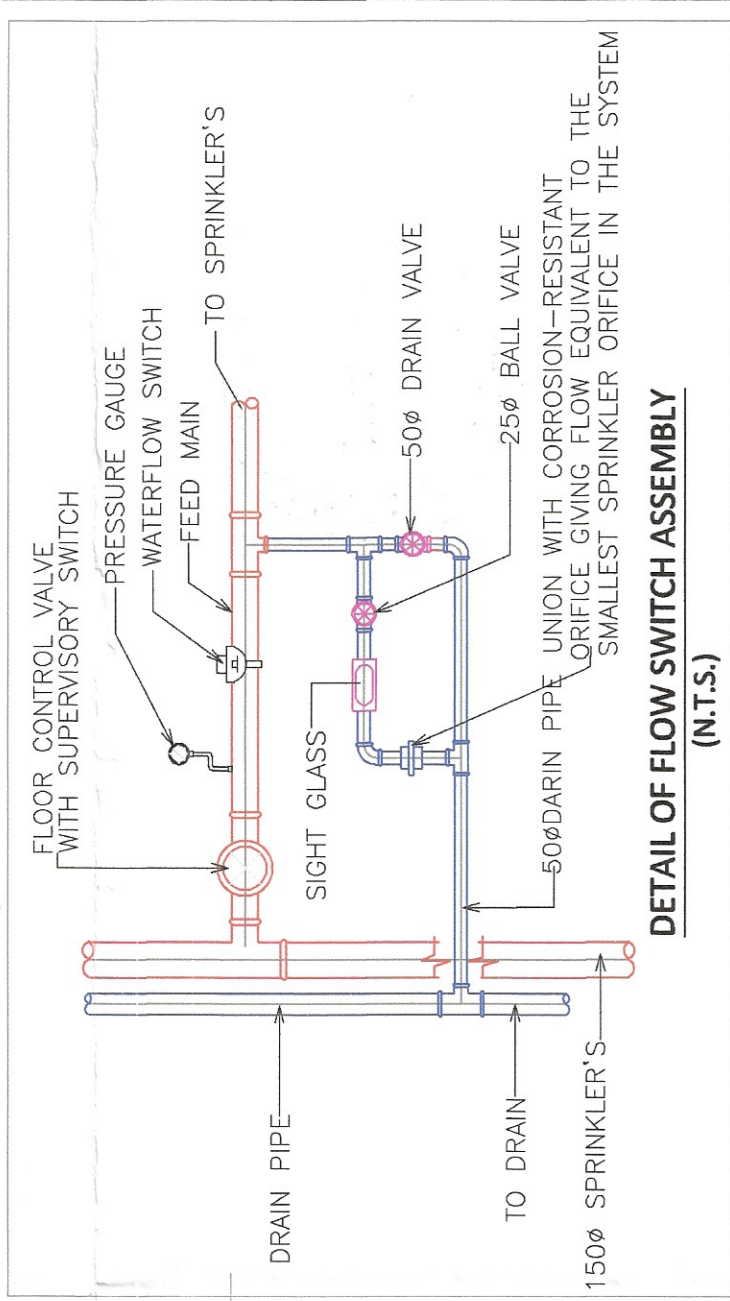

IT IS CERTIFIED THAT DRAWINGS ARE AS PER
ORIGINAL DRAWING APPROVED BY BUILDING PLAN
COMMITTEE GROUP HOUSING SOCIETIES HSPV
CIRCLE GURUGRAM

MEMO NO. - 7268
DATED -08/07/2024

aDesign Solutions Pvt. Ltd.

Director

ARCHITECTS SIGN
OWNER'S SIGN
OWNER'S SIGNATURE

aDesign Solutions Pvt. Ltd.

Director

ARCHITECTS SIGNATURE




FIRE CONSULTANT'S SIGNATURE


Ef. RAMKUNWAR
CONSULTING ENGINEERING SERVICES
Civil, Mechanical, Electrical & Mechanical Ventilation System
100, Indira Colony-1, Sector-32, Gurugram (Hr.)
Mob: 9899004192

FIRE PROTECTION CONSULTANT
RAMKUNWAR & ASSOCIATES
CONSULTING ENGINEERING SERVICES
100, G.F. INDRA COLONY-1
SECTOR-32, GURUGRAM.
MOB. 9899004192


DRG. NO. 2723/F-05
DATE JULY 2024
FIRE SUBMISSION
3RD FLOOR TO 9TH FLOOR PLAN
SCALE 1:150
DRAWN BY- SWEETY
A1

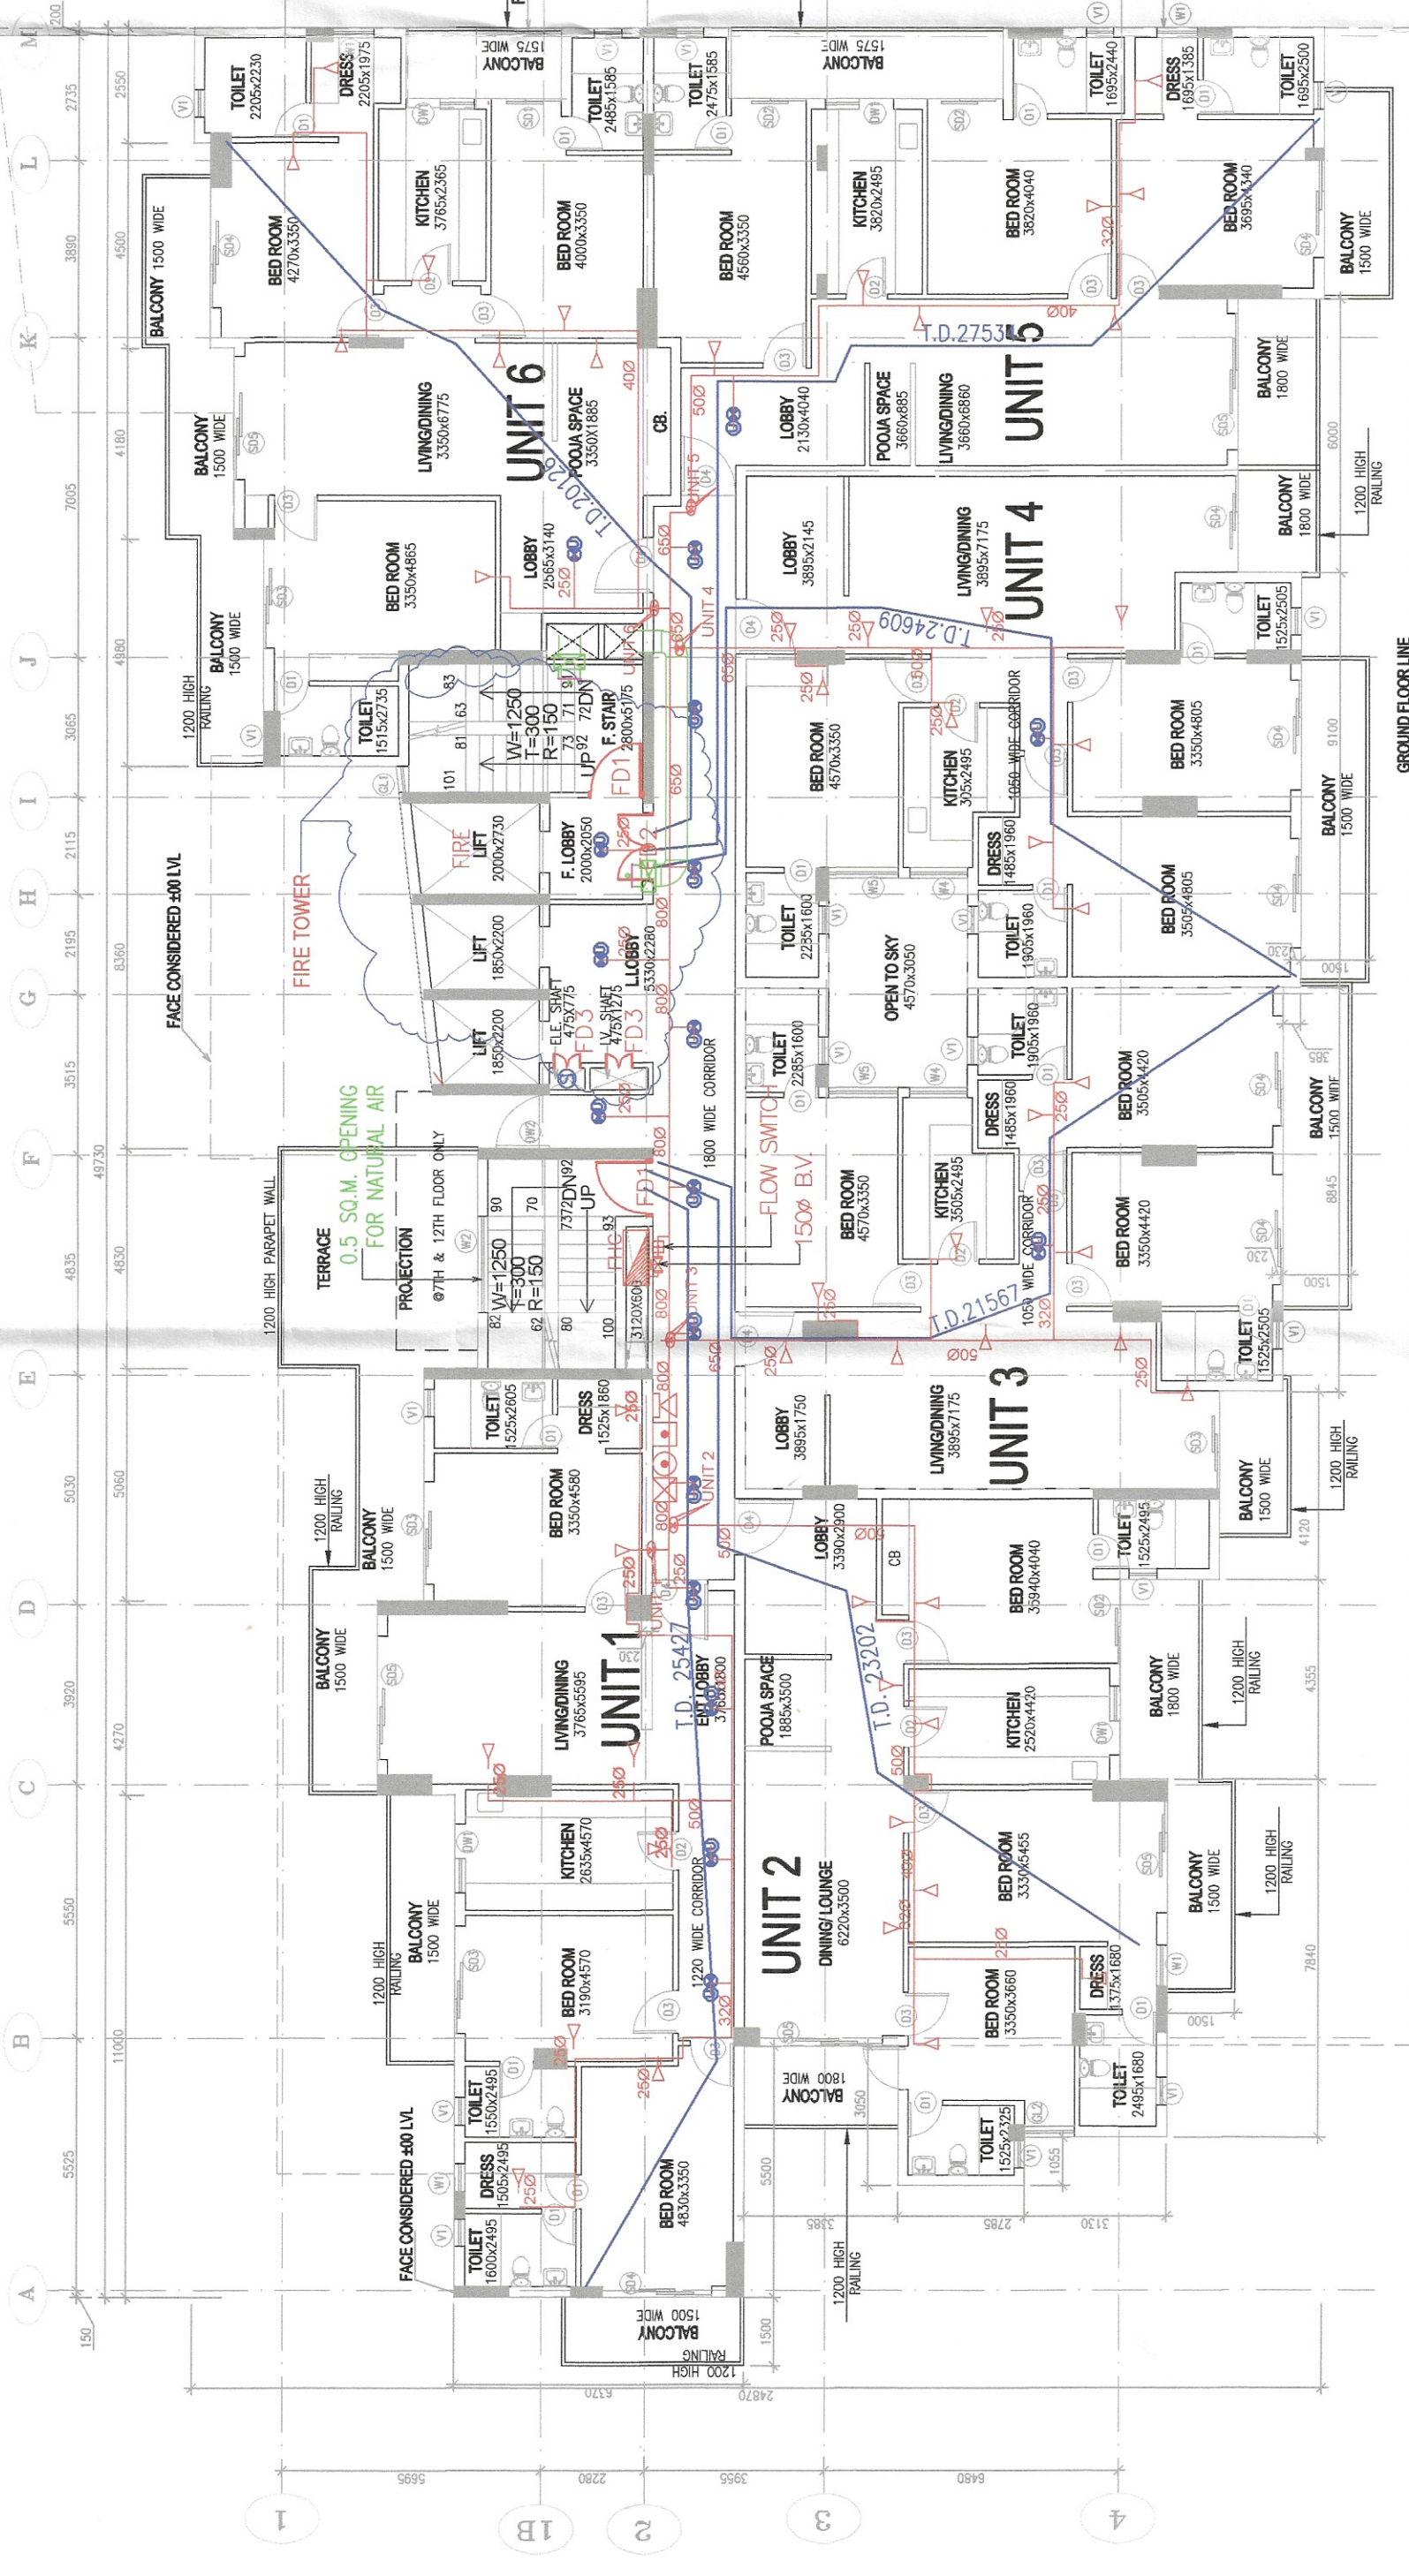

3RD FLOOR PLAN

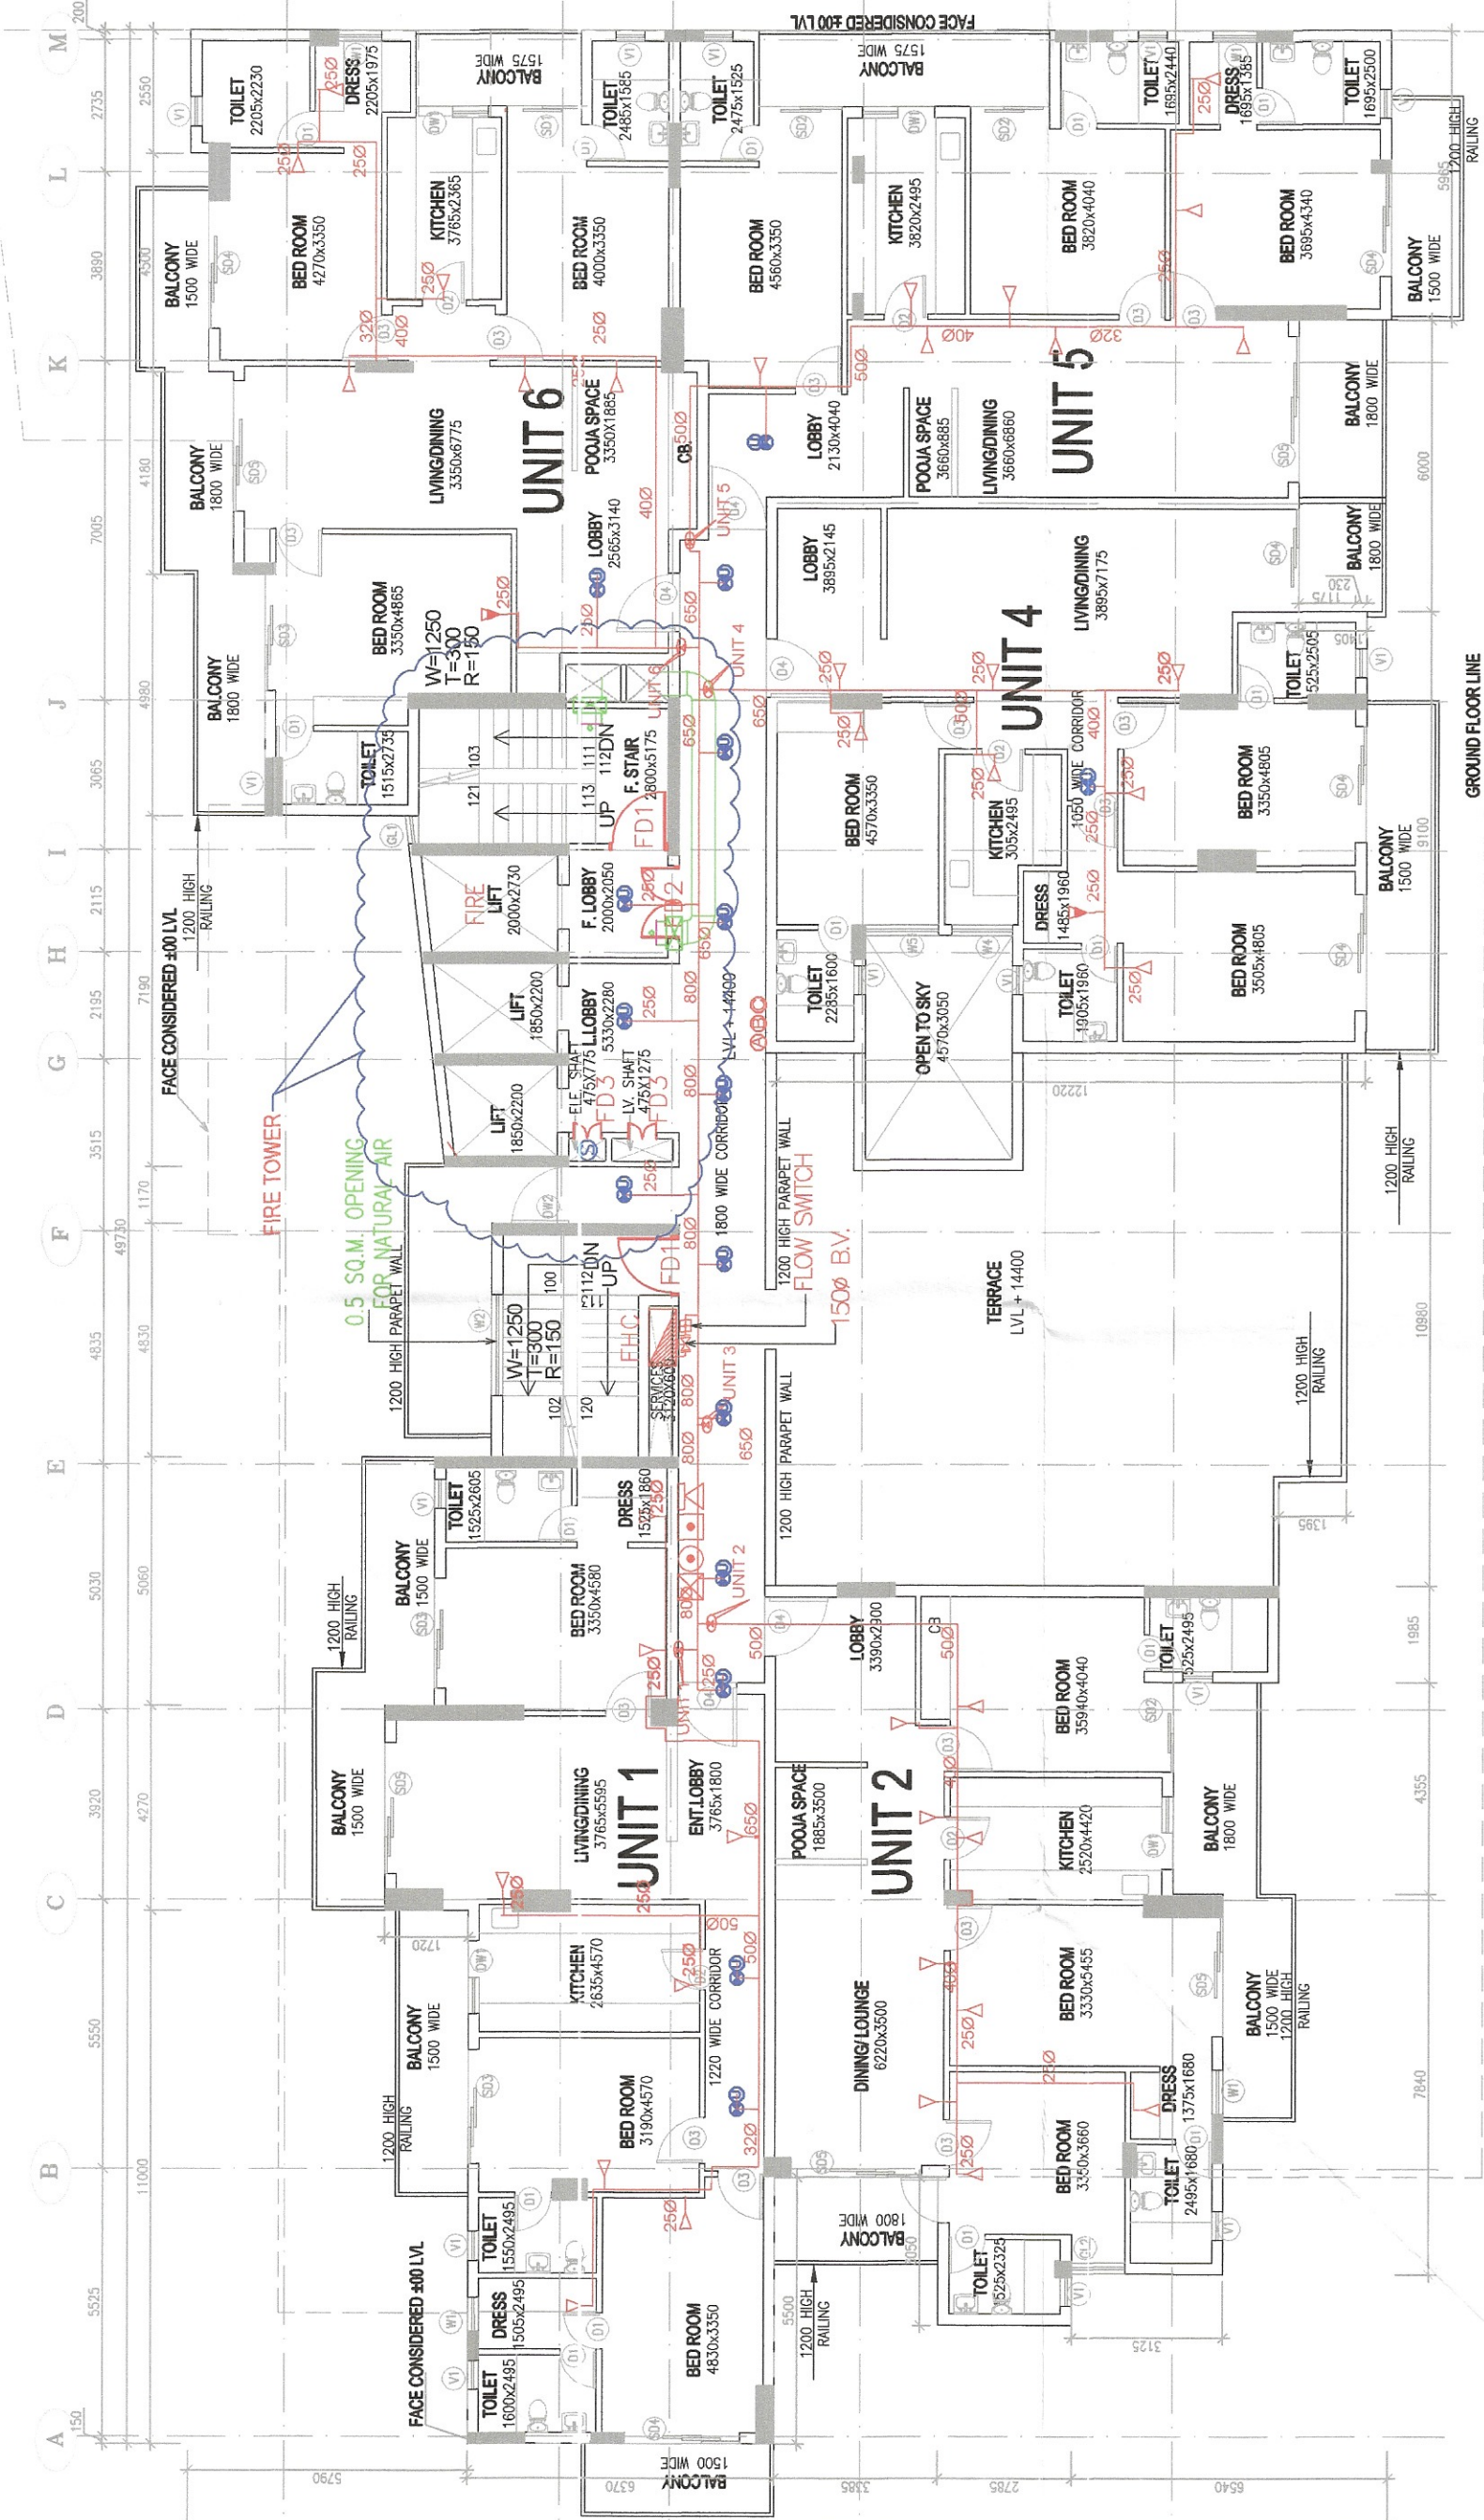

4TH FLOOR PLAN

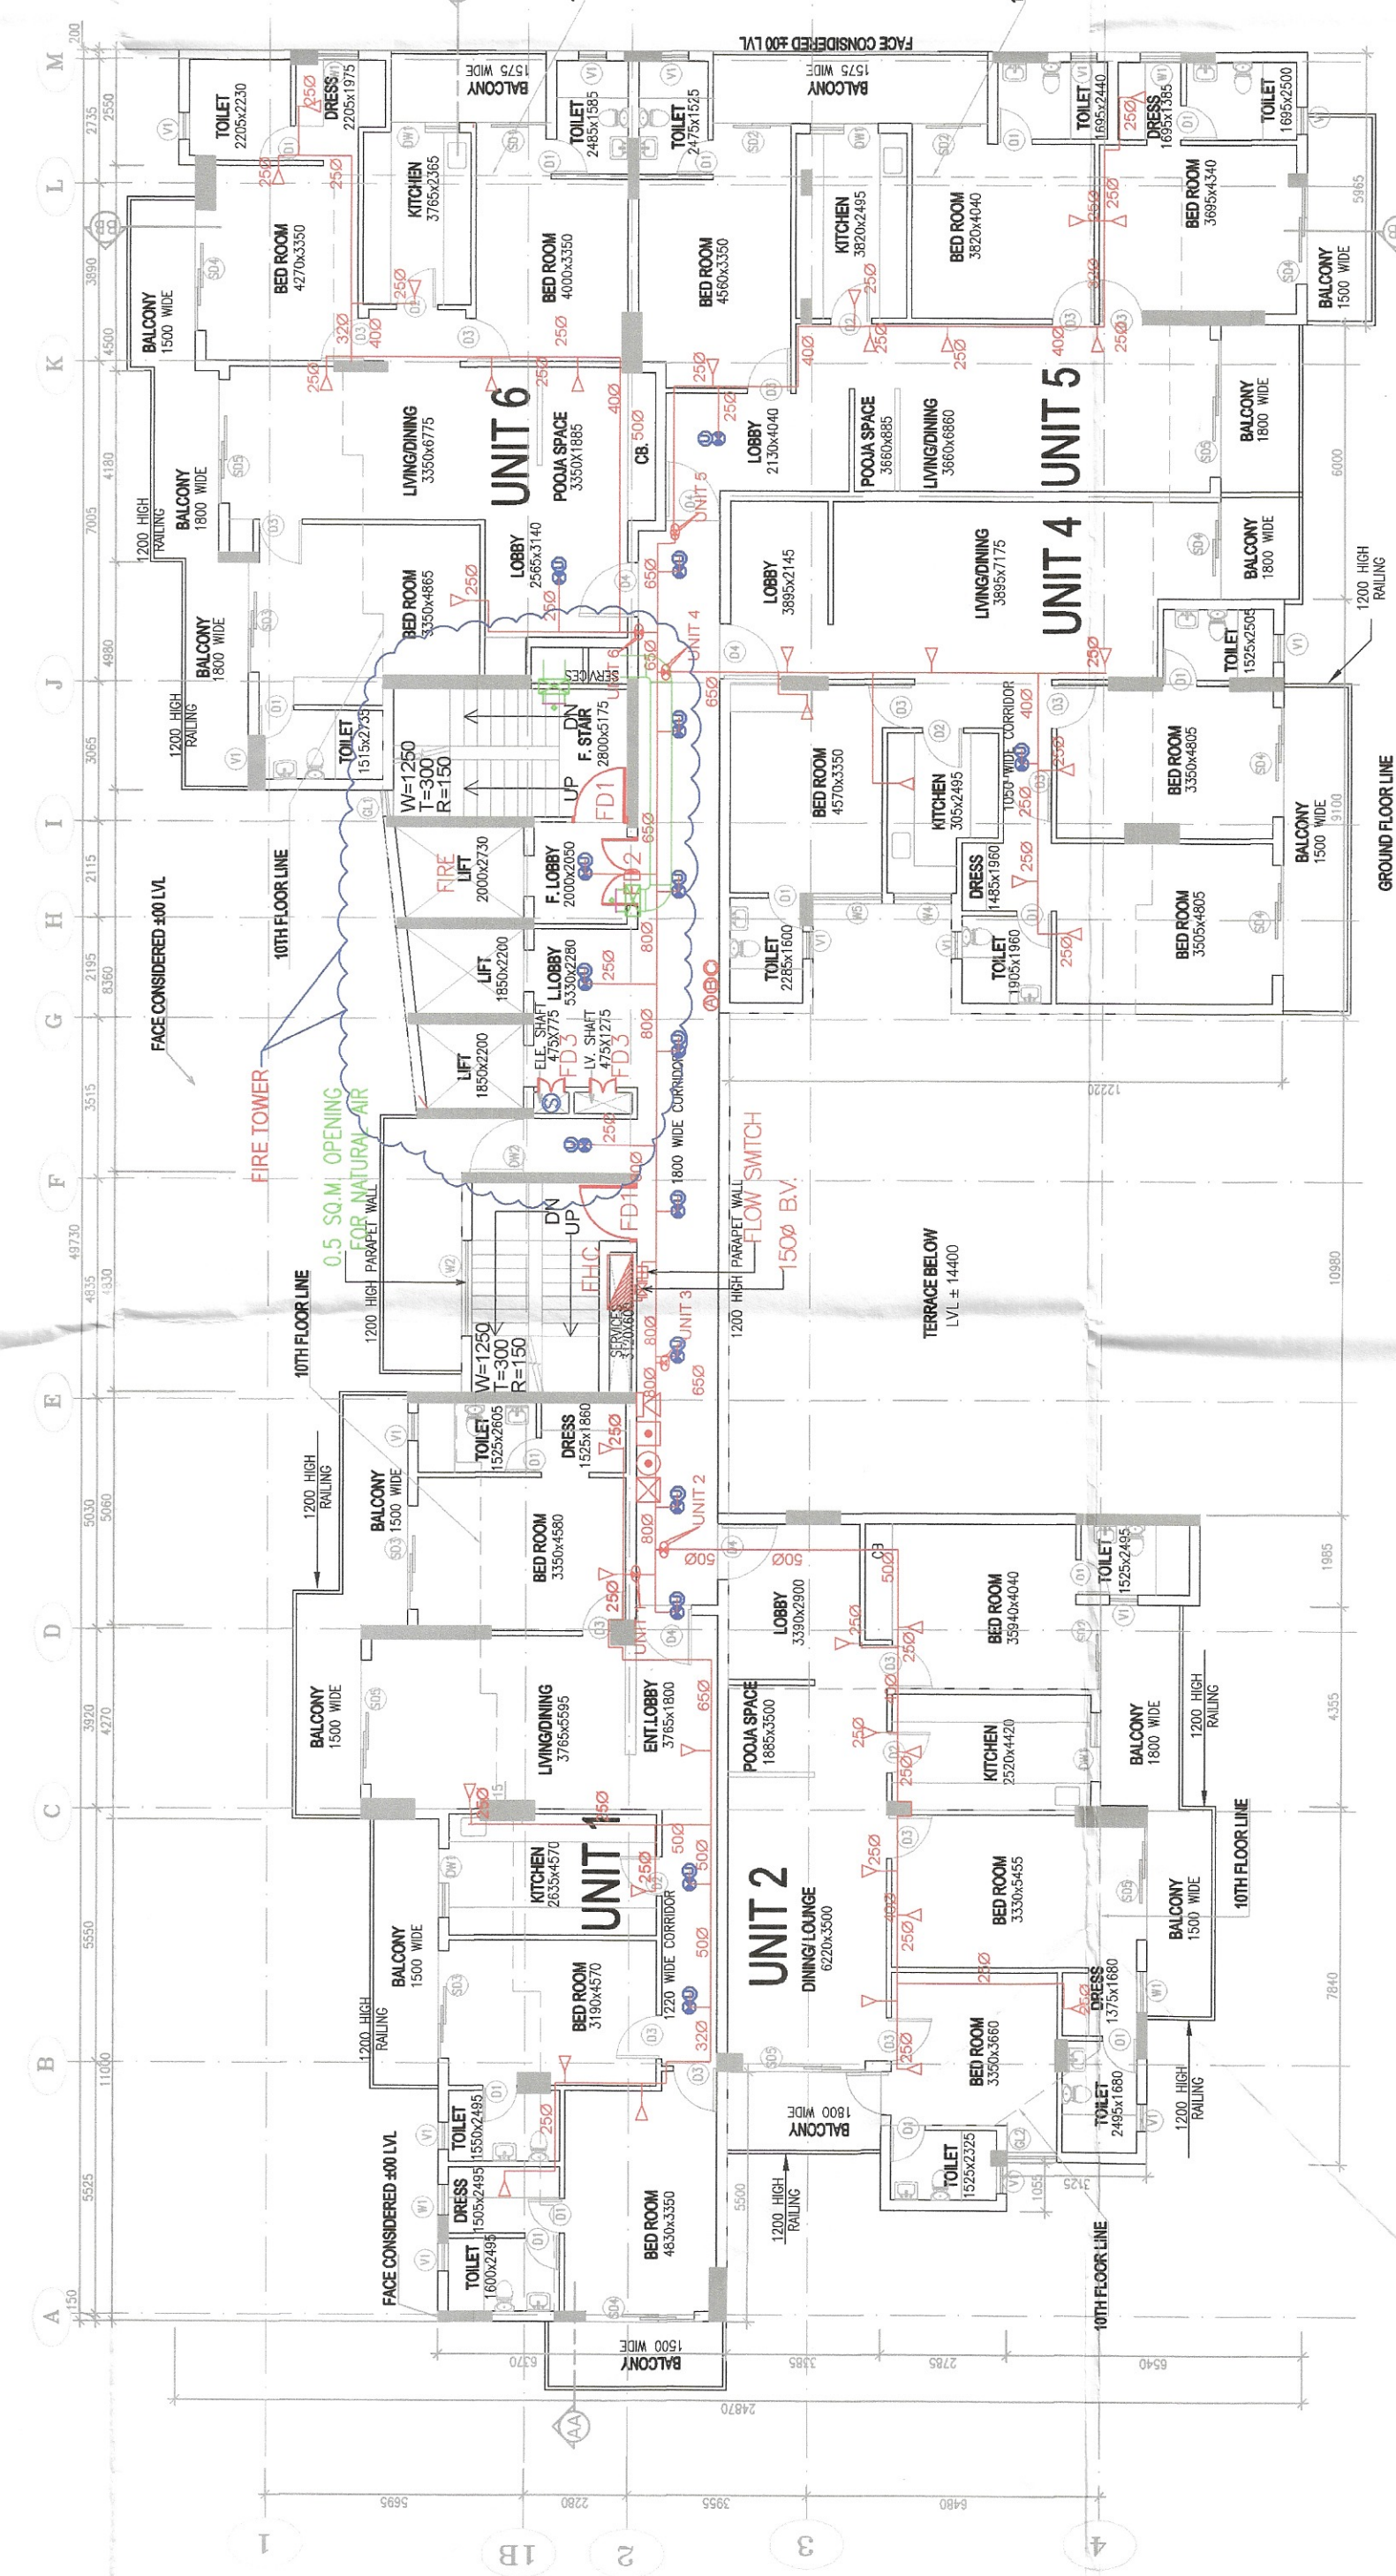

5TH FLOOR TO 9TH FLOOR PLAN