


PROJECT:
PROPOSED GROUP HOUSING (GH1)
BUILDING PLAN AN AREA MEASURING
0.75989 ACRES IN SECTOR-23 & 23A,
GURUGRAM, BEING DEVELOPED BY:-
MS META DESIGN SOLUTIONS PVT. LTD.

Certified that the Fire Fighting Scheme
as per N.B.C. Part IV, revised 2017

S.NO	TYPE	WIDTH IN MM	HEIGHT IN MM
1	D1	1500	2100
2	D2	850	2100
3	D3	950	2100
4	D4	1200	2100
5	D5	1500	2100
6	FD1	1250	2100
7	FD2	1500	2100
8	FD3	1500	2100
9	W2	1800	1350
10	W3	1500	1350
11	W4	1200	1350
12	W5	1500	2250
13	SD1	1500	2400
14	SD2	1800	2400
15	SD3	2400	2400
16	SD4	2700	2400
17	SD5	3000	2400
18	SD6	3000	2400
19	DM1	1500	2400
20	DM2	1170	2400
21	GL1	550	1500
22	GL1	570	2400

Fire Fighting Scheme Approved
Via letter No. FSP/23/1365
Dated: 23.05.2024
Deputy Director (Tech.)

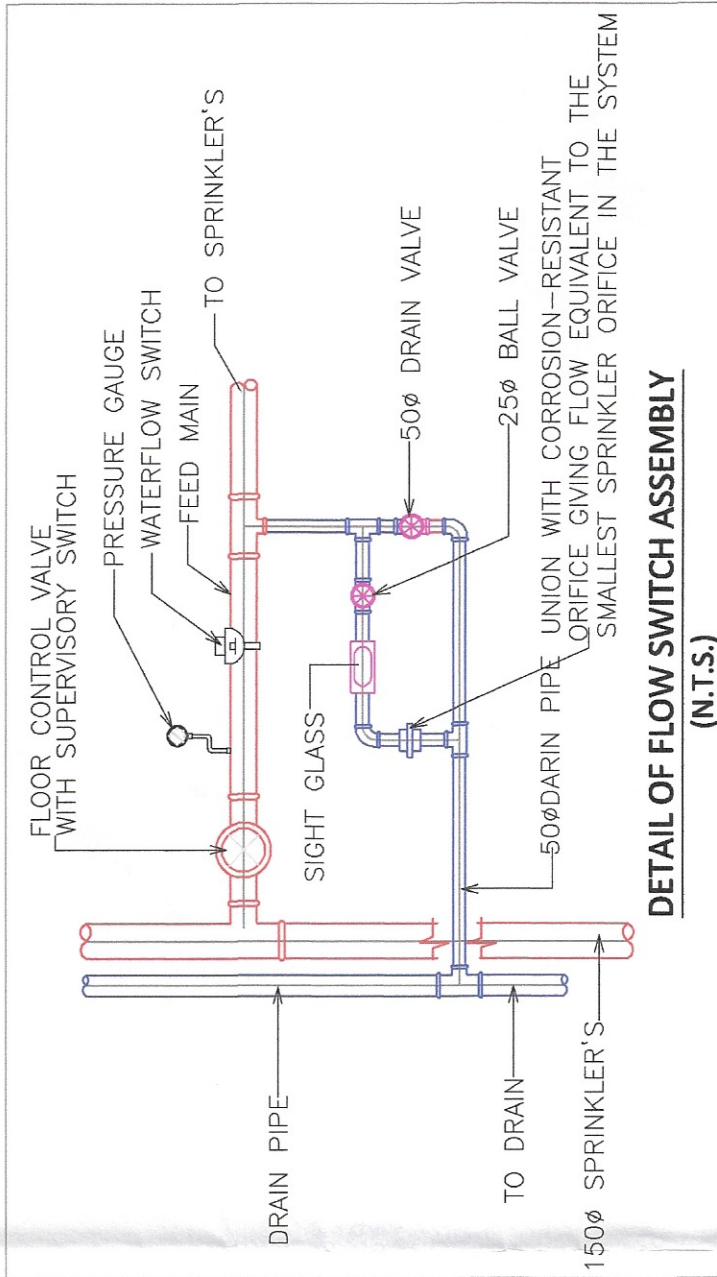


LEGEND

	SPRINKLER (PENDENT TYPE)
	SPRINKLER HEAD (SIDE WALL TYPE)
	NORMAL THROW
	SPRINKLER HEAD (UPRIGHT TYPE)
	FD1 = FIRE SMOKE CHECK DOOR SIZE = 1.25X2.1M HT.
	FD2 = FIRE SMOKE CHECK DOOR SIZE = 1.5X2.1M HT.
	FD3 = FIRE SMOKE CHECK DOOR SIZE = 0.6X2.1M HT.
	FD3 = FIRE SMOKE CHECK DOOR SIZE = 0.6X2.1M HT. (FOR L.V. SHAFT & ELEC. SHAFT)
	150mm BUTTERFLY VALVE
	FLOW SWITCH
	FD = FIRE DOOR
	HR RATED MAIN UNIT DOOR OF FLATS SIZE = 1.2X2.10M HT.
	4KG ABC FIRE EXTINGUISHER
	4.5KG CO2 FIRE EXTINGUISHER
	MANUAL CALL POINT
	HOOTER
	150mm WET RISER WITH SINGLE HYDRANT VALVE, BRANCH PIPE, 2 NOS RRL HOSE REEL (30M LENGTH), HOSE REEL (25M DIA) AND FIRE MAN AXES


LEGEND	FLOOR LEVEL
	FLR = 0.000
	1ST = +0.600
	2ND = +1.600
	3RD = +2.600




10TH FLOOR PLAN

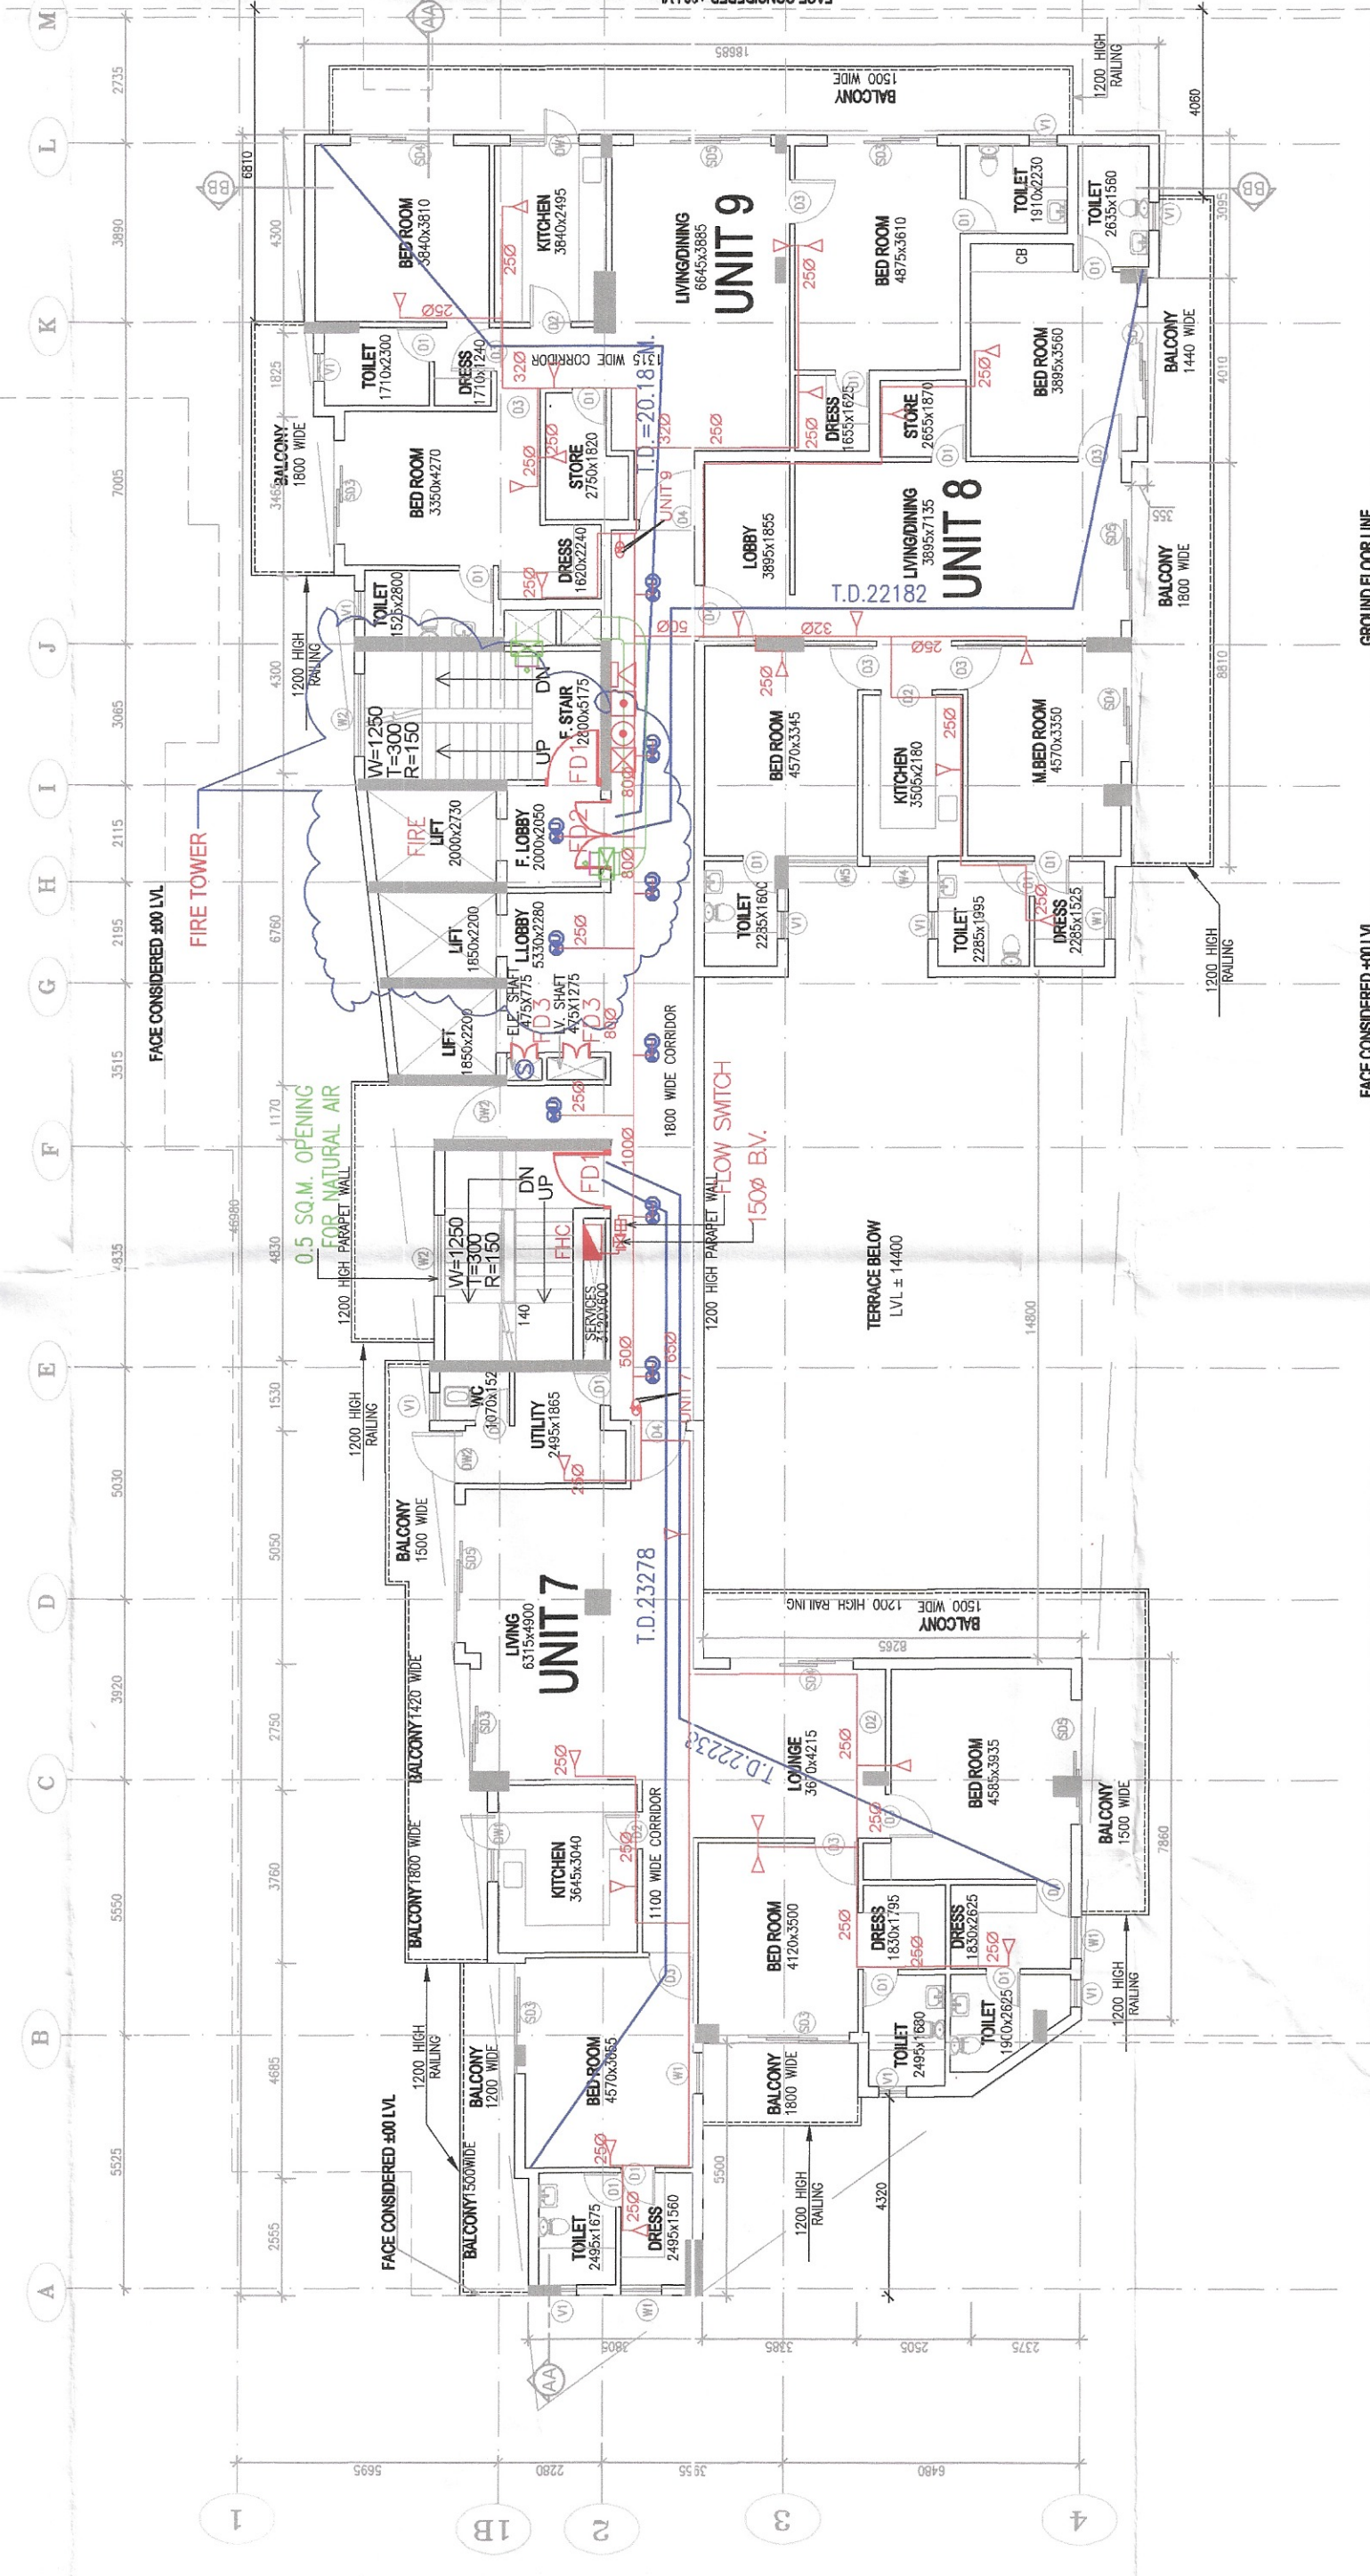


11TH FLOOR TO 14TH FLOOR PLAN

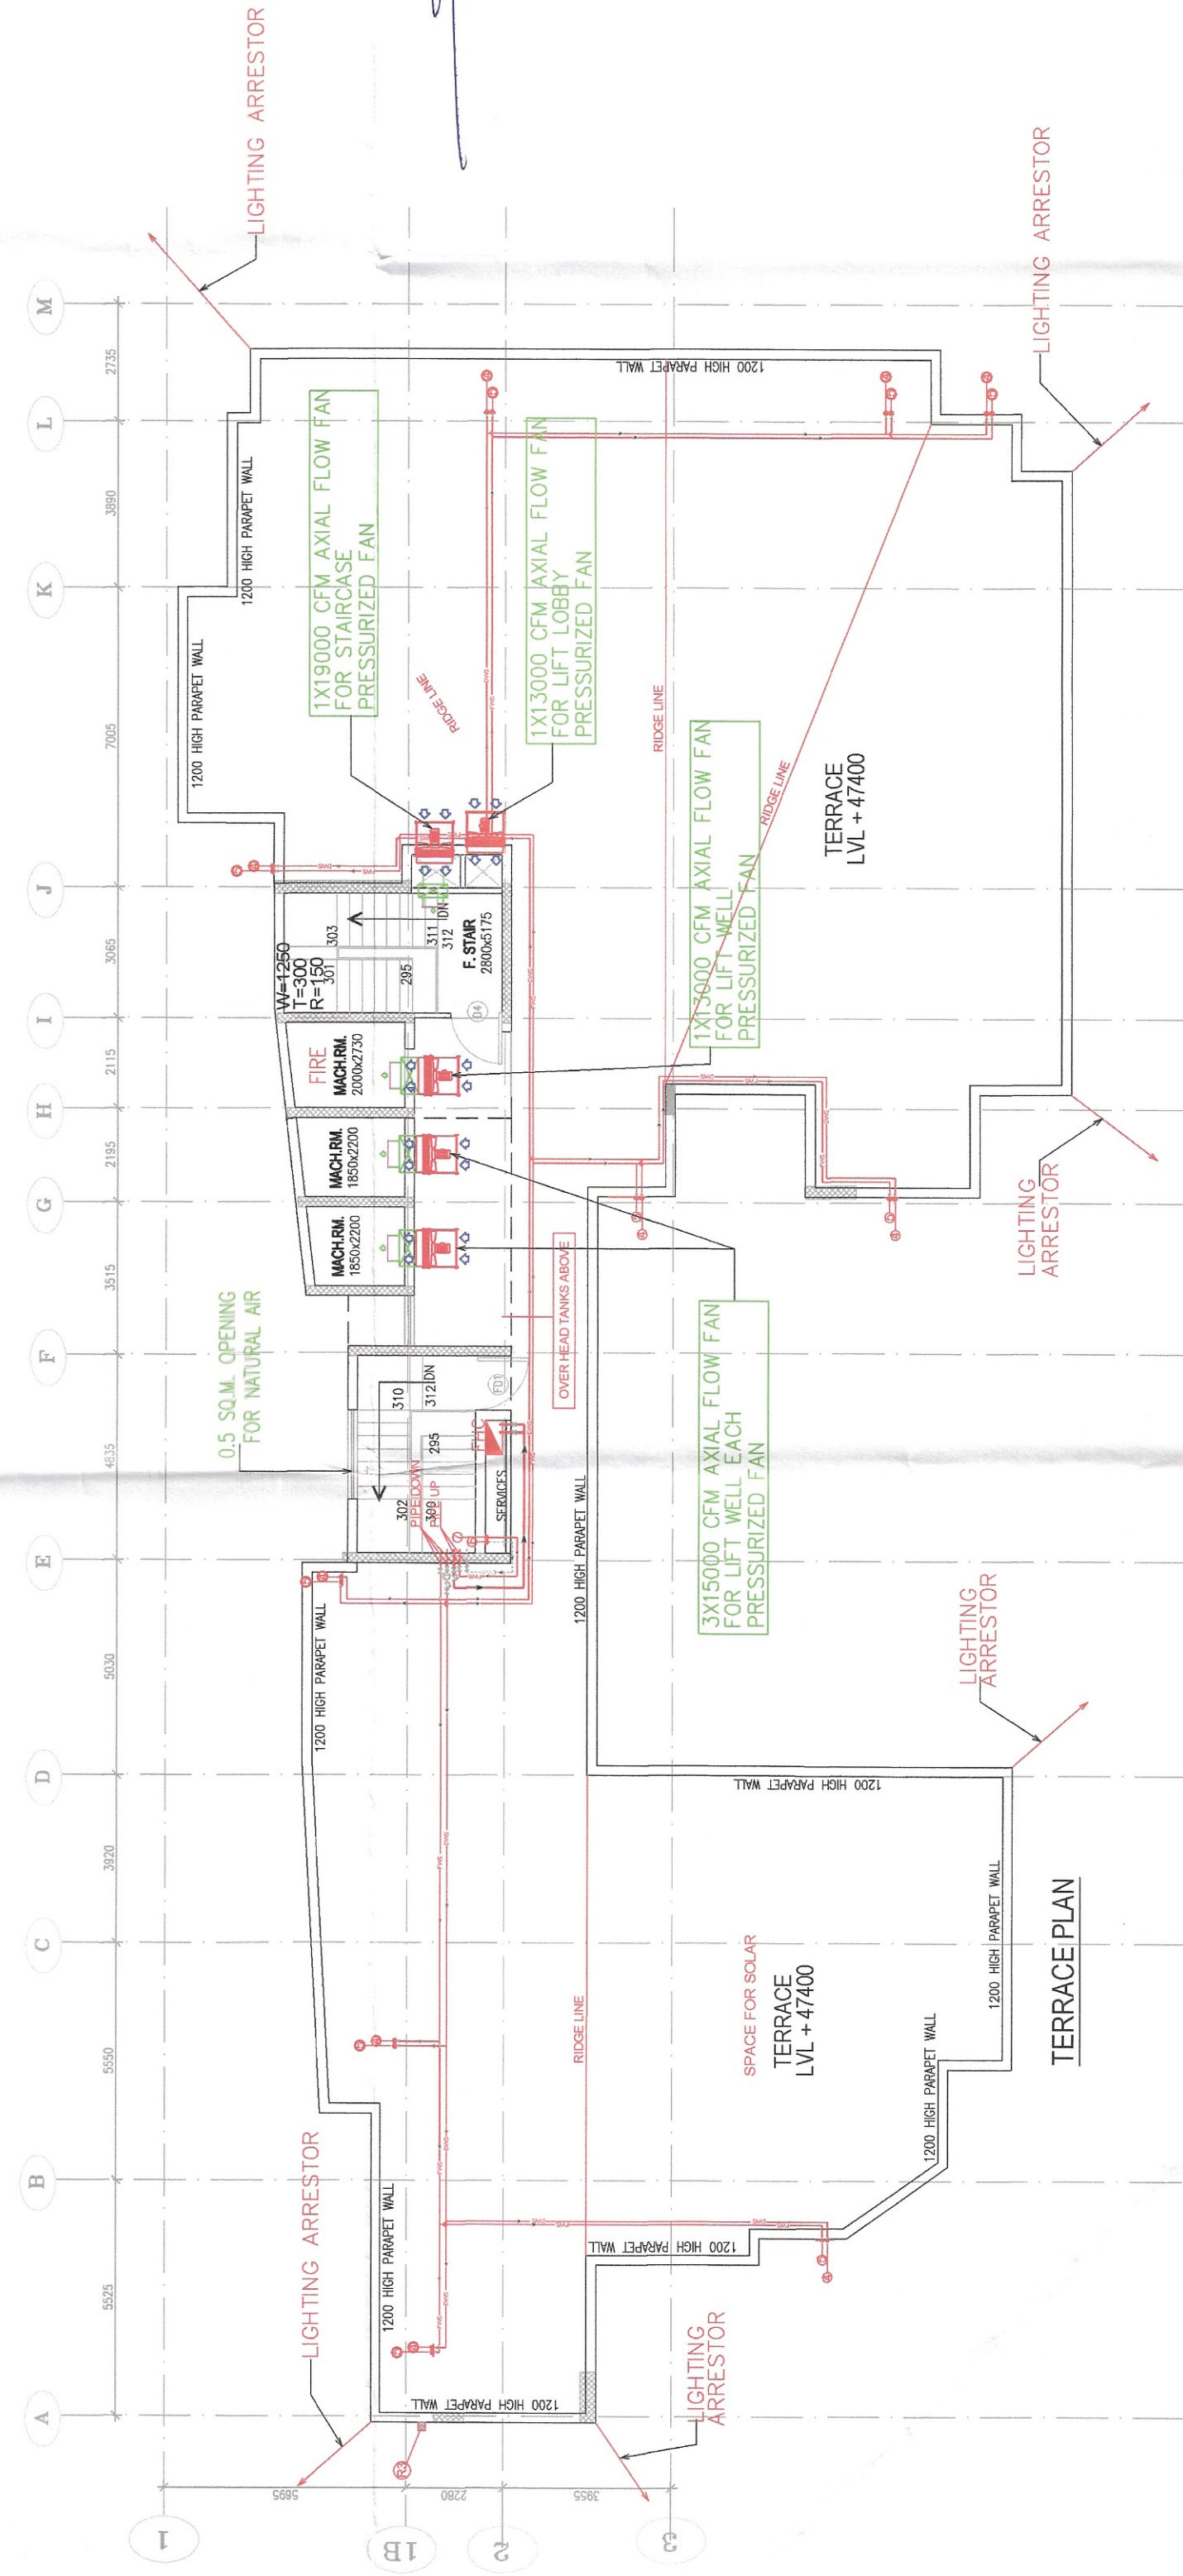

TERRACE PLAN

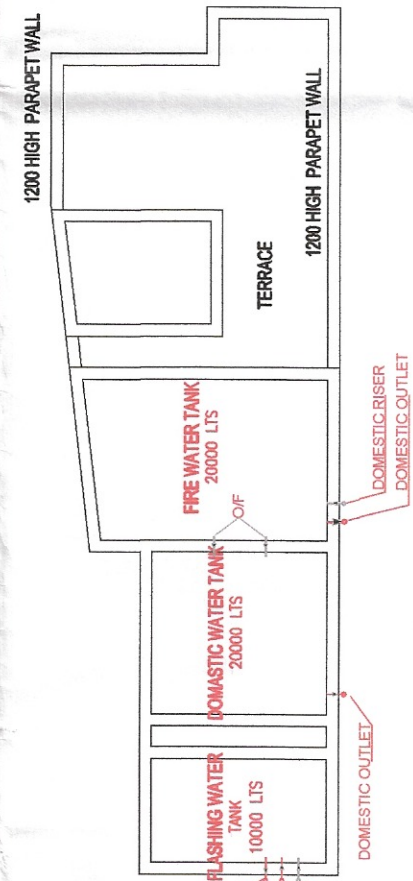

OVERHEAD WATER TANK PLAN

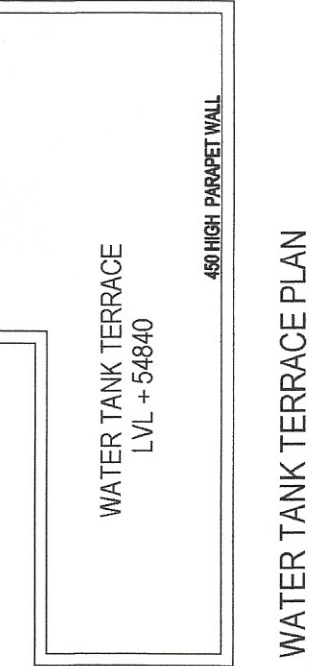

WATER TANK TERRACE PLAN

IT IS CERTIFIED THAT DRAWINGS ARE AS PER
PROPOSED GROUP HOUSING (GH1) BUILDING PLAN
COMMITTEE GROUP HOUSING SOCIETIES HSP
CIRCLE GURUGRAM

MEMO NO. - 7268
DATED 05/07/2024

MS MetaDesign Solutions Pvt. Ltd.

Director

ARCHITECT'S SIGN

OWNER'S SIGNATURE

OWNER'S SIGN

MS MetaDesign Solutions Pvt. Ltd.
Director

ARCHITECT'S SIGNATURE



FIRE CONSULTANT'S SIGNATURE

Signature of Fire Consultant

Dr. RANJANVAR
RANJANVAR & ASSOCIATES
CONSULTING ENGINEERING SERVICES
Fire Protection, Fire Alarm
& Detection, Lift & Escalator
100, G.F. INDIRA COLONY-1
Sector-52, GURUGRAM
Mob.: 9899004192

FIRE PROTECTION CONSULTANT
RANJANVAR AND ASSOCIATES
CONSULTING ENGINEERING SERVICES
100, G.F. INDIRA COLONY-1
SECTOR-52, GURUGRAM.
MOB. 9899004192

DRG. NO.	2723/F-06
DATE	JULY/2024
SCALE	1:150
DRAWN BY:	SWEETY
SIZE	A1