

DRG. NO:- 2723/F-07

PROJECT:


PROPOSED GROUP HOUSING (GH1)
BUILDING PLAN AN AREA MEASURING
0.75989 ACRES IN SECTOR-23 & 23A,
GURUGRAM, BEING DEVELOPED BY:-
M/S META DESIGN SOLUTIONS PVT. LTD.

Fire Fighting Scheme Approval
Vide letter No. ES/243/1283
Dated.....24/11/2024

Confirmed that the Fire Fighting Scheme is
as per H.C. Part IV, revised 2016

Deputy Director (Tech)

ES/243/1283
24/11/2024
DD(T)
Gurugram
Gurugram

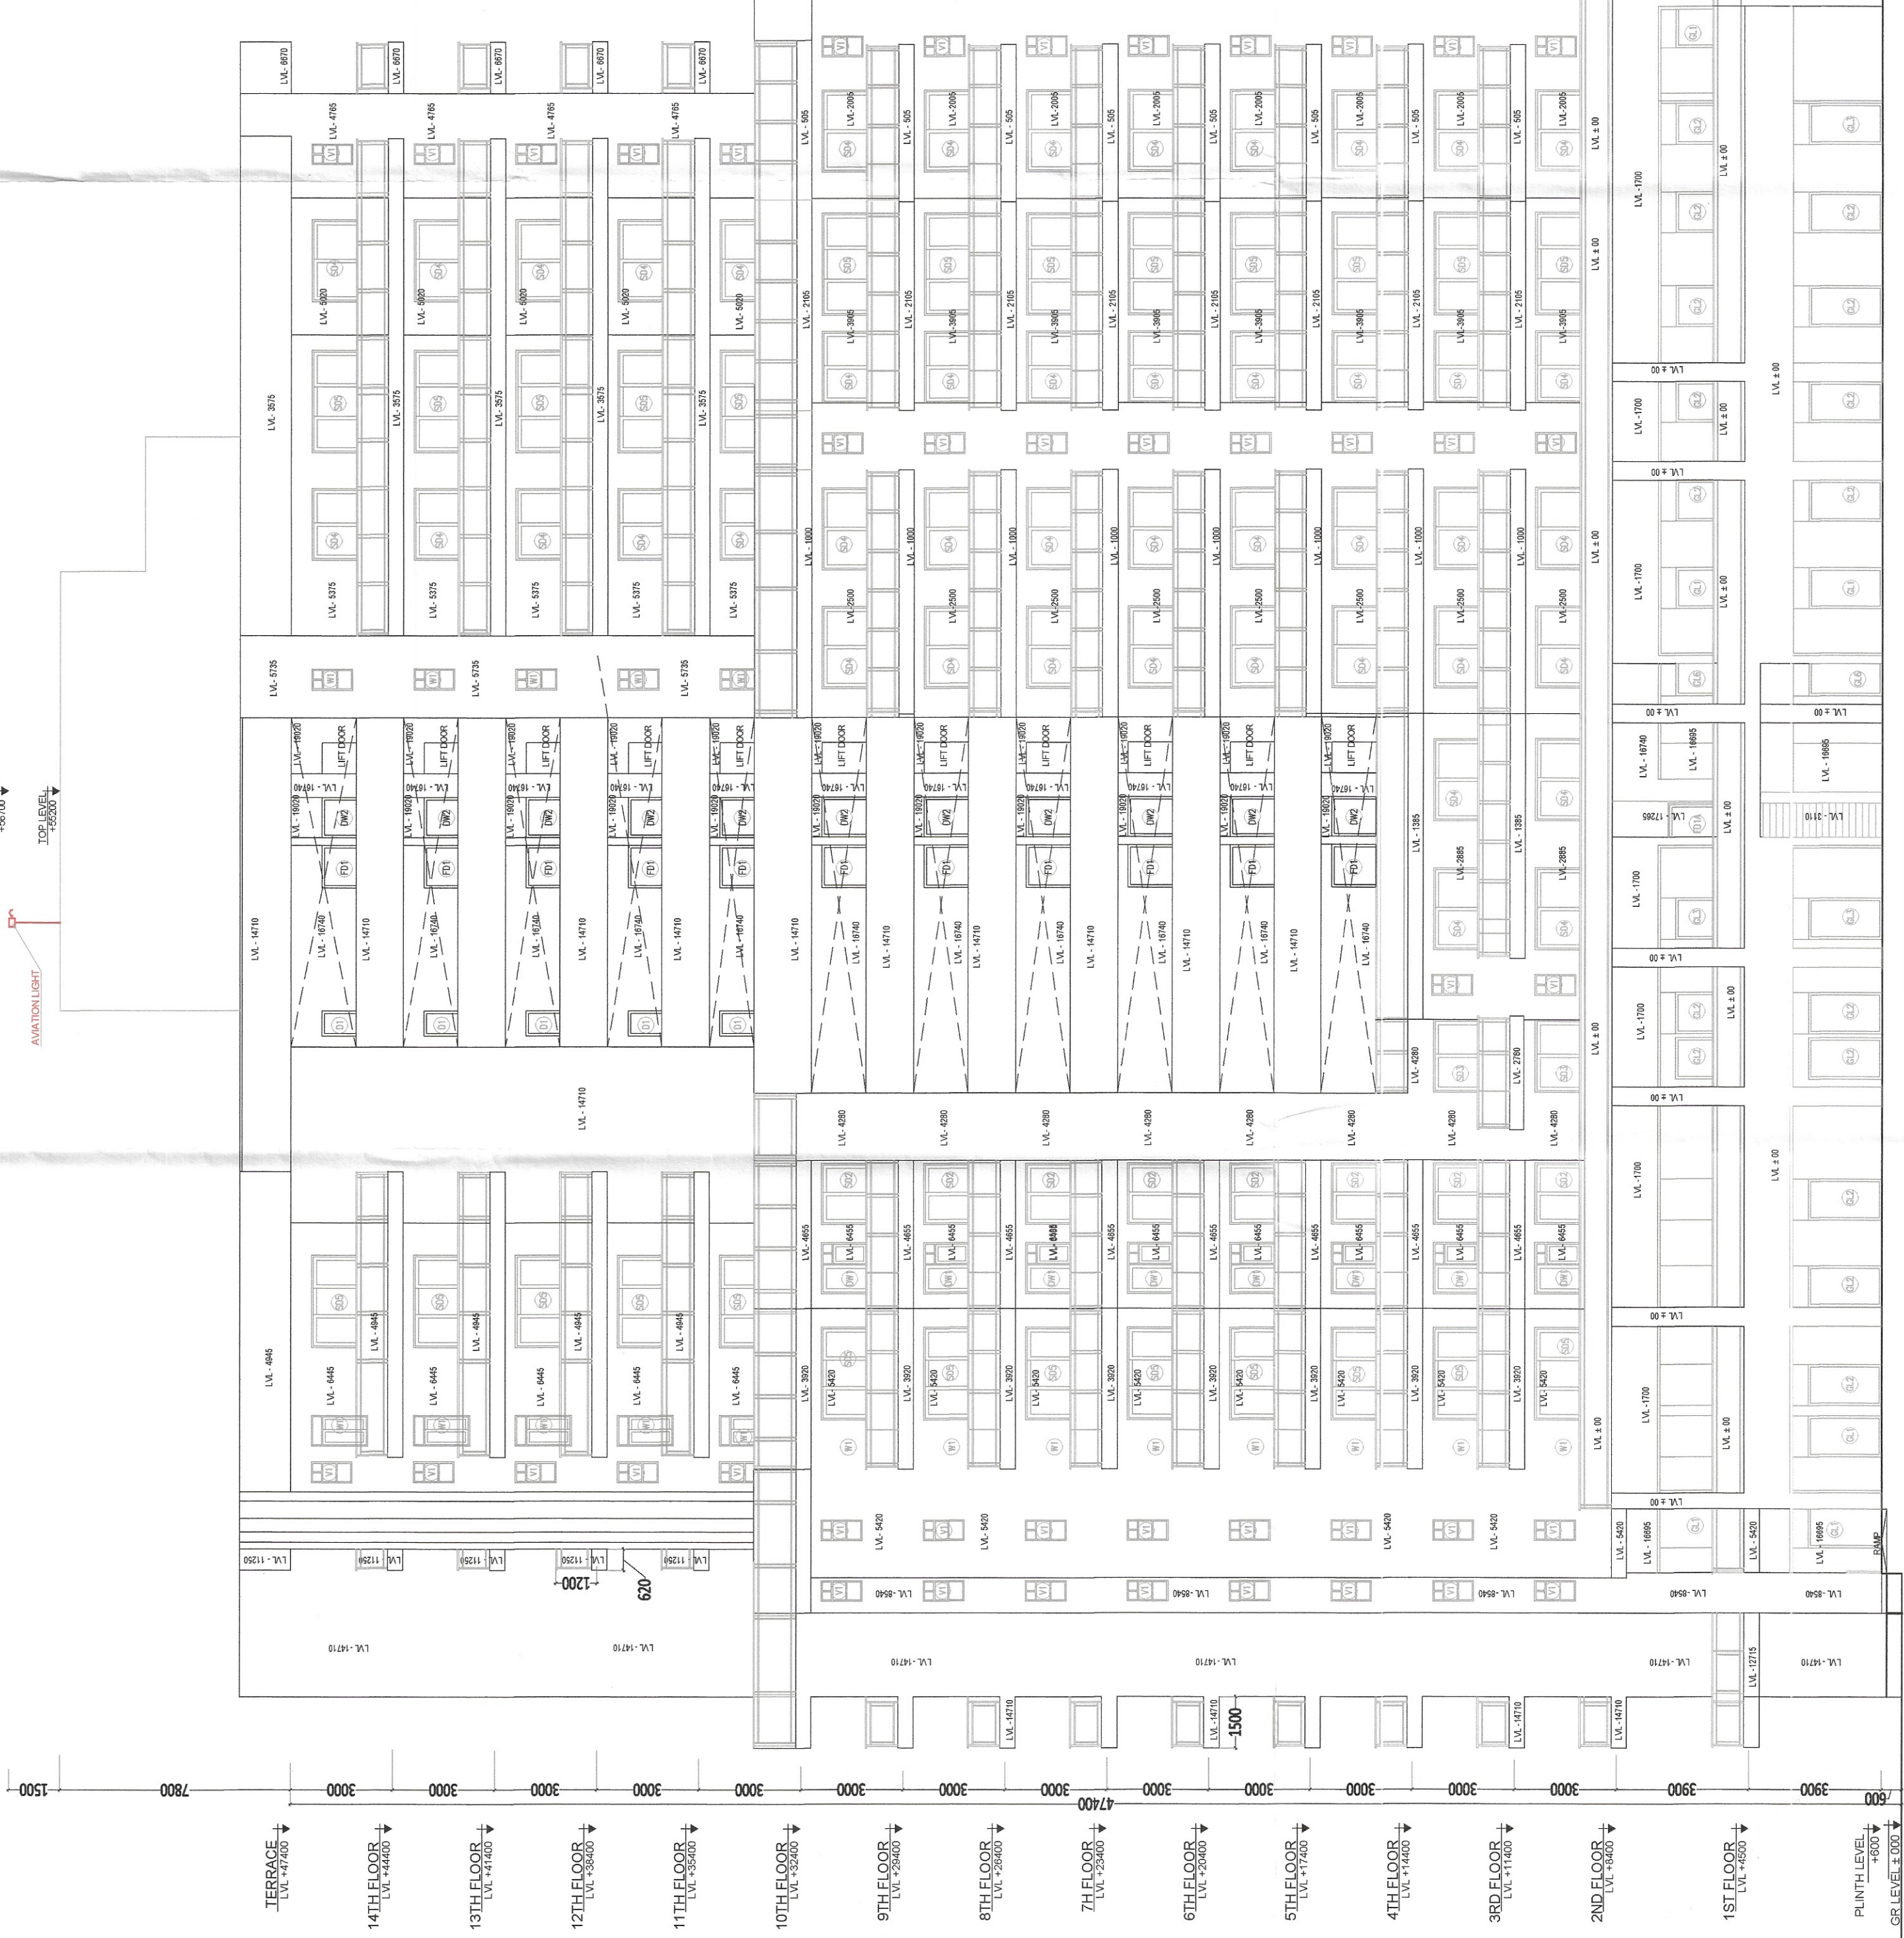

SOUTH EAST ELEVATION



NORTH EAST ELEVATION

IT IS CERTIFIED THAT DRAWINGS ARE AS PER
COMMITMENT APPROVED BY BUILDING PLAN
COMMITTEE GROUP HOUSING SOCIETIES HSYP
CIRCLE GURUGRAM

MEMO NO.- 7268
DATED -06/07/2024

MetaDesign Solutions Pvt. Ltd.

Director

OWNER'S SIGN

ARCHITECT'S SIGN

OWNER'S SIGNATURE

MetaDesign Solutions Pvt. Ltd.

Director

ARCHITECT'S SIGNATURE



FIRE CONSULTANTS SIGNATURE

E. RAIKUNVAR
RAIKUNVAR & ASSOCIATES
CONSULTING ENGINEERING SERVICES
& Mechanical Ventilation System
103, Indraprastha, Sector-23, Gurugram (Hr.)
Mob.: 9899004192

FIRE PROTECTION CONSULTANT
RAIKUNVAR & ASSOCIATES
CONSULTING ENGINEERING SERVICES
100, G.F. INDRA COLONY-1
SECTOR-52, GURUGRAM.
MOB. 09899004192

DRG. NO.	DATE	DRG. NO.
2723/F-07	JULY 2024	2723/F-07
SCALE	SIZE	SIZE
1:150	A1	A1