


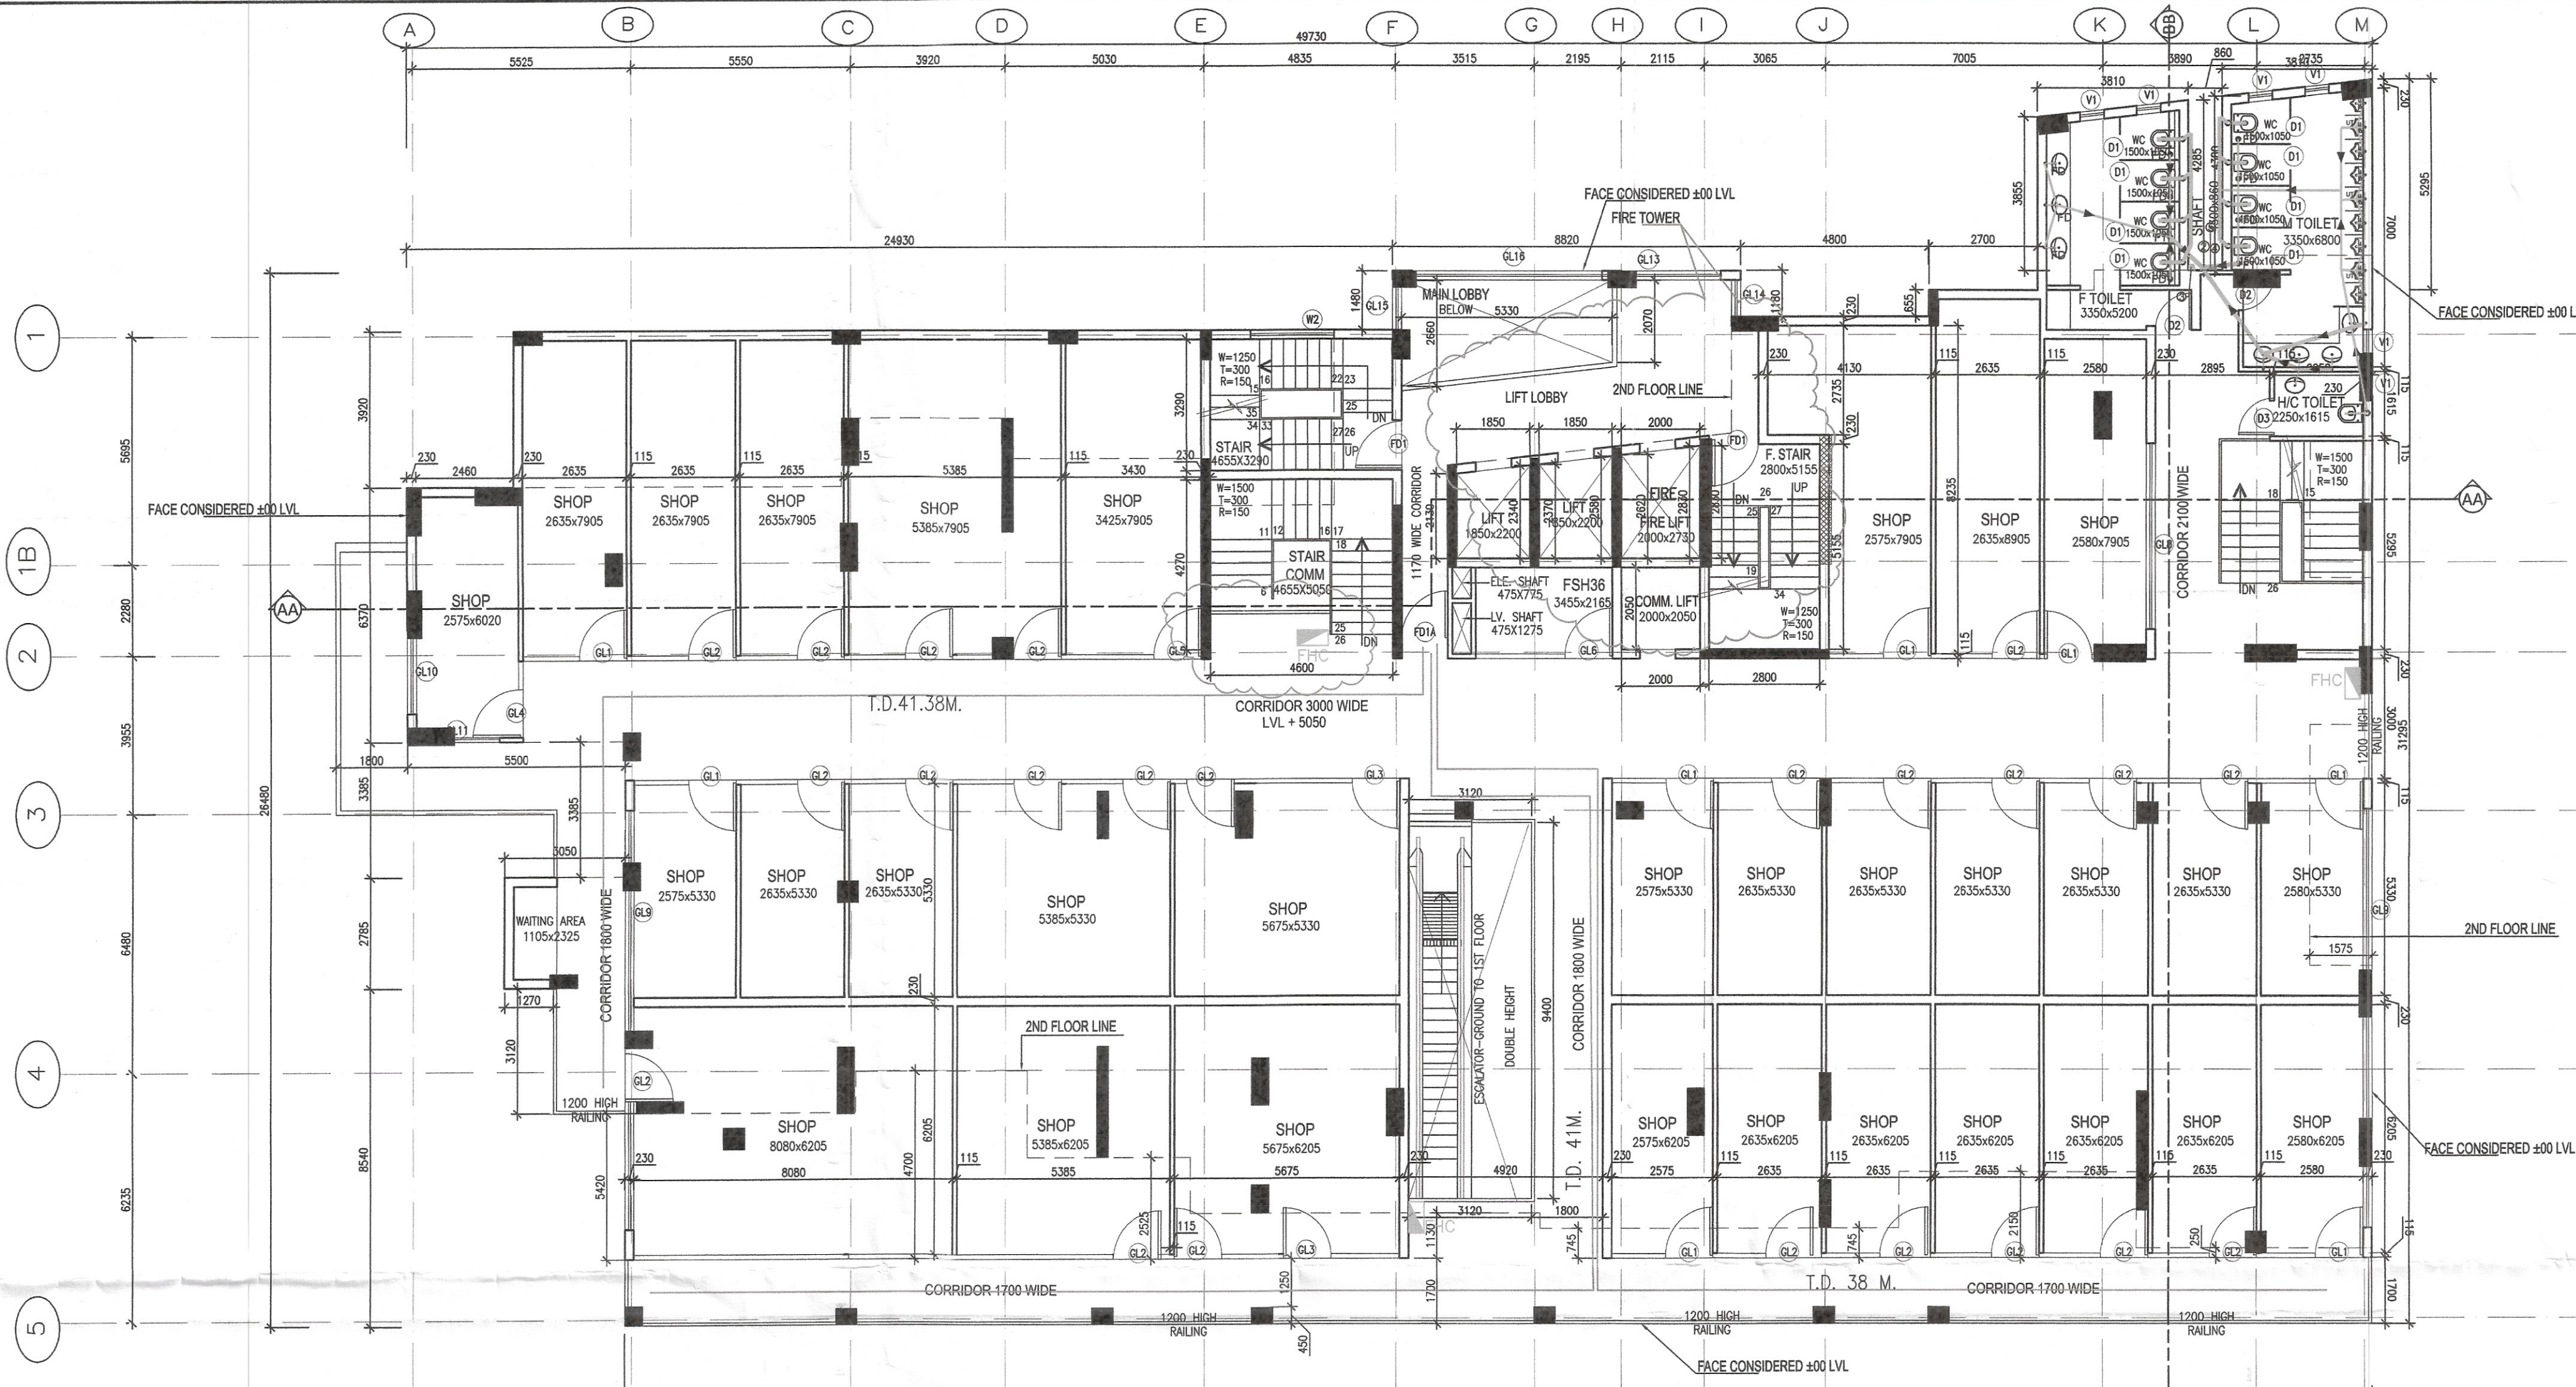

LEGEND

SYMBOL	DESCRIPTION
①	1000 SOIL & VENT PIPE
②	1000 WASTE & VENT PIPE
③	1000 ANTISYPHONAGE PIPE
④	DOMESTIC WATER SUPPLY
⑤	FLASHING WATER SUPPLY
⑥	DOMESTIC WATER RISER
⑦	SUPPLY TO OVER HEAD TANK
⑧	FLUSHING WATER RISER
⑨	1500 MS FIRE LINE
⑩	1500 MS SPRINKLER LINE
⑪	800 DRAIN PIPE
⑫	75 OD RAIN WATER PIPE
⑬	90 OD RAIN WATER PIPE
⑭	110 OD RAIN WATER PIPE
⑮	150 OD RAIN WATER PIPE

LEGEND

SYMBOL	DESCRIPTION
→	1000 SOIL & VENT PIPE
→	1000 WASTE & VENT PIPE
→	1000 ANTISYPHONAGE PIPE
→	DOMESTIC WATER SUPPLY
→	FLASHING WATER SUPPLY
→	DOMESTIC WATER RISER
→	SUPPLY TO OVER HEAD TANK
→	FLUSHING WATER RISER
→	1500 MS FIRE LINE
→	1500 MS SPRINKLER LINE
→	800 DRAIN PIPE
→	75 OD RAIN WATER PIPE
→	90 OD RAIN WATER PIPE
→	110 OD RAIN WATER PIPE
→	150 OD RAIN WATER PIPE

CHAIRMAN
Building Plan Committee
Group Housing Societies
HSVP Circle, Gurugram

SANCTIONED
Valid For Five Years
Sub. To Condition of Allotment Letter

For ESTATE OFFICER
HSVP GURUGRAM

HORIZONTAL PIPE CONNECTIONS SHALL BE AS FOLLOWS:

FROM WASH BASIN TO FT	3200GI PIPE
FROM FD TO FT	5000GI PIPE
FROM URINAL TO UT	4000 PIPE
FROM FT TO VERTICAL STACK	1000 PIPE
FROM WC TO VERTICAL STACK	1000 PIPE
FROM UT TO VERTICAL STACK	1000 PIPE


OPENING SCHEDULE

1	GL1	2575	2700
2	GL2	2635	2700
3	GL3	2930	2700
4	GL4	1915	2700
5	GL5	3425	2700
6	GL6	5330	2700
7	GL7	5940	2700
8	GL8	4660	2400
9	GL9	12250	2400
10	GL10	2100	1950
11	GL11	1500	1950
12	GL12	2575	2700
13	GL13	4045	2700
14	GL14	925	7200
15	GL15	1250	7200
16	GL16	4800	7200

FIRST FLOOR AREA - FAR

S.NO	CODE	LENGTH IN M	WIDTH IN M	CALCULATION	AREA IN SQM
1	G1	49.730	26.480	49.730x26.480	1316.850
2	G2	(3.855+4.285)/2	3.810	(3.855+4.285)/2x3.810	15.507
3	G3	(4.380+4.815)/2	3.810	(4.380+4.815)/2x3.810	17.516
TOTAL= G					1349.873
DEDUCTIONS					
1	1	4.800	1.180	4.800x1.180	5.664
2	2	24.930	1.480	24.930x1.480	36.896
3	3	2.690	3.920	2.690x3.920	10.545
4	4	5.500	3.385	5.500x3.385	18.618
5	5	2.450	2.785	2.450x2.785	6.823
6	6	3.720	3.120	3.720x3.120	11.606
7	7	5.520	5.420	5.520x5.420	29.918
8	D1	2.700	0.525	2.700x0.525	1.418
9	D2	4.600	3.290	4.600x3.290	15.134
10	D3	4.600	4.27	4.600x4.270	19.642
11	D4	3.120	9.400	3.120x9.40	29.328
12	D5	(2.660+2.070)/2	5.330	(2.660+2.070)/2x5.330	12.605
13	D6	(2.130+2.340)/2	1.850	(2.130+2.340)/2x1.850	4.135
14	D7	(2.370+2.580)/2	1.850	(2.370+2.580)/2x1.850	4.579
15	D8	(2.620+2.830)/2	2.000	(2.620+2.830)/2x2.000	5.450
16	D9	2.050	2.000	2.050x2.000	4.100
17	D10	2.800	5.155	2.800x5.155	14.434
18	S1	0.475	0.775	0.475x0.775	0.368
19	S2	0.475	1.275	0.475x1.275	0.606
TOTAL = D					231.869
NET FAR OF FIRST FLOOR (FA)=G-D					1118.004

FIRST FLOOR AREA -COVERED AREA					
1	FAR ON FIRST FLOOR =FA				1118.004
ADDITION -STAIRS					
1	D2	4.600	3.290	4.600x3.290	15.134
2	D3	4.600	4.270	4.600x4.270	19.642
3	D10	2.800	5.155	2.800x5.155	14.434
TOTAL ADDITIONS A1					49.210
TOTAL COVERED AREA ON FIRST FLOOR=FA+A1					1167.214

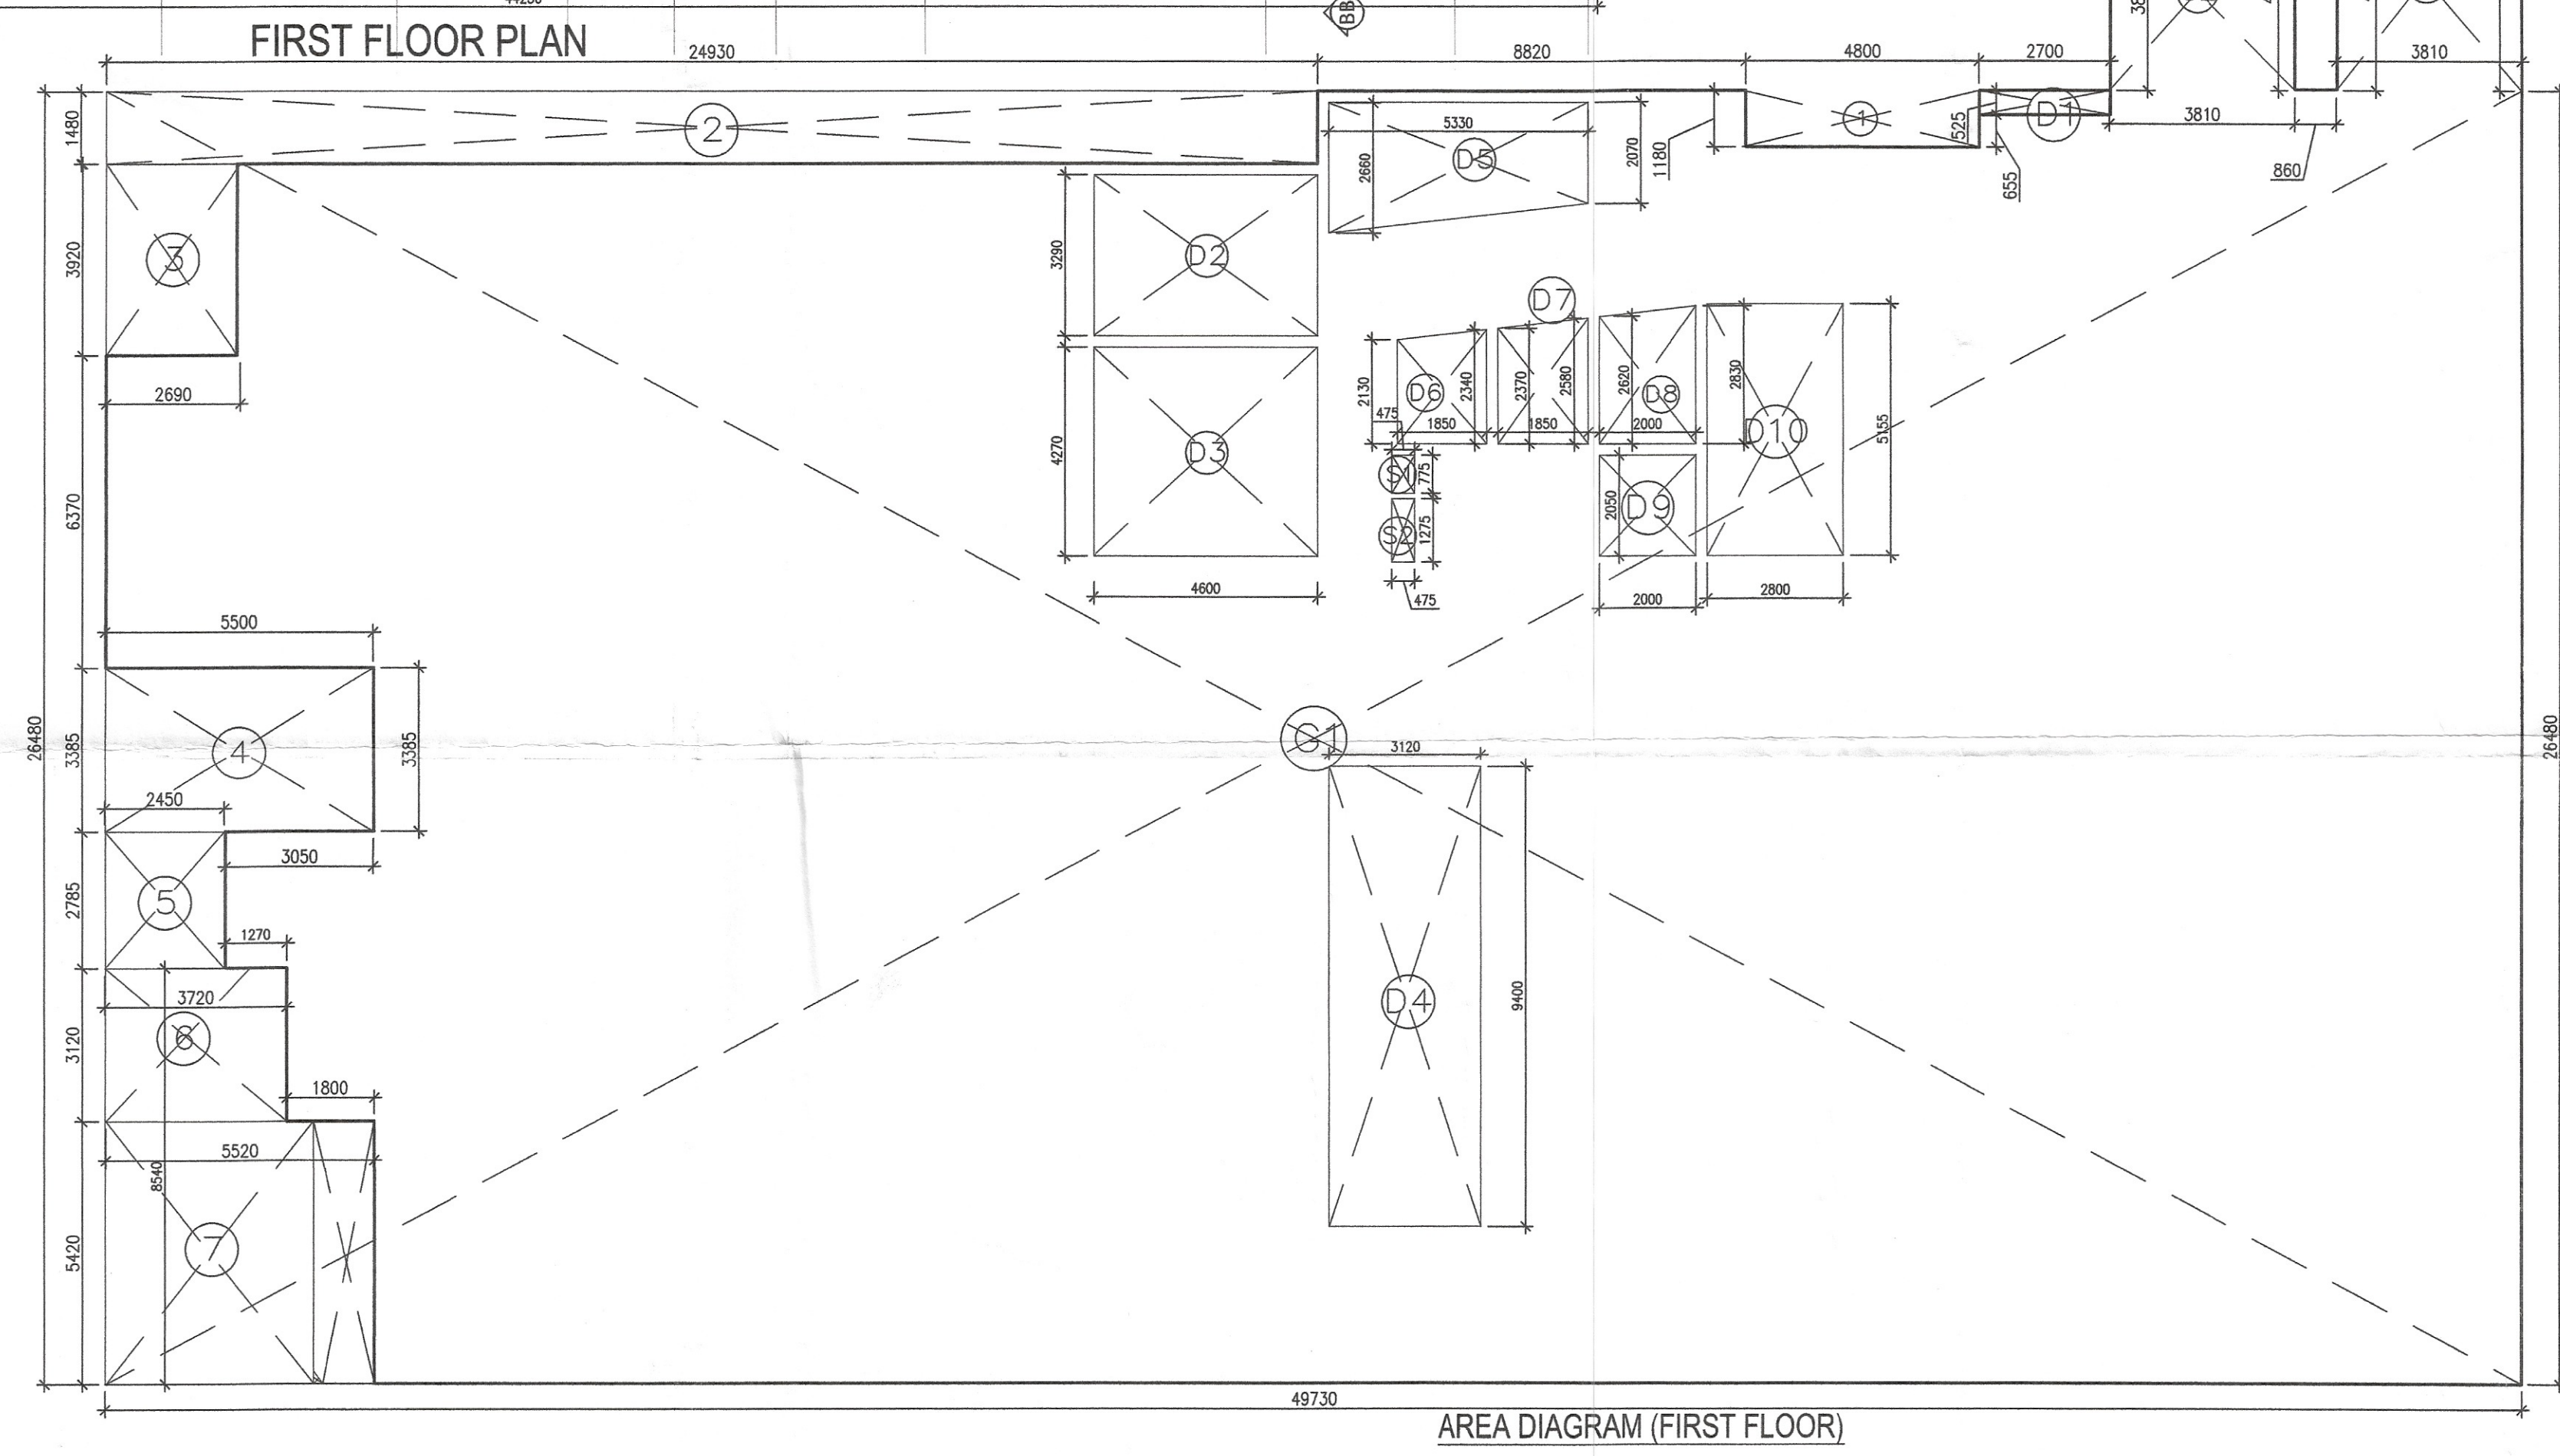

SUBMISSION DRAWING

BUILDING PLAN FOR GROUP HOUSING (GH1) AREA MEASURING 0.75989 ACRES IN SEC-23 & 23A, GURUGRAM BEING DEVELOPED BY M/S META DESIGN SOLUTIONS PVT. LTD.

DAULAT & PUNEET ARCHITECTS LLP.
408, Fourth Floor, Sun City Trade Tower,
Sector - 21, Gurugram - 122016,
E-MAIL: info@daulatpuneetarchitects.com, Phone: +91-124-4576444

DAULAT & PUNEET ARCHITECTS LLP.
DAULAT ARCHITECTS LLP
PUNEET ARCHITECTS LLP
Architecture Interior Planning Visual

SCALE 1:100
DATE ISSUED 29/01/2024
DRAWN BY VAIBHAV
CHECKED BY DAULAT GARG

FIRST FLOOR PLAN
MDS/03