


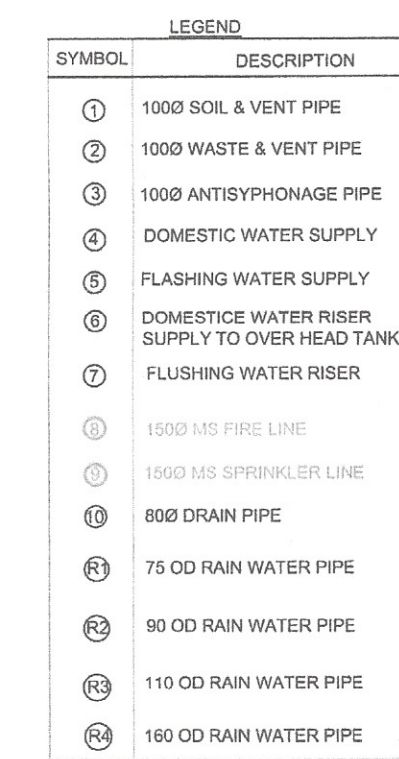

SYMBOL	DESCRIPTION
	1000 SOIL & VENT PIPE
	1000 WASTE & VENT PIPE
	FLOOR TRAP 100x180 DAA WITH 125mm GRATING
	FLOOR DRAIN 100x60mmDAA WITH GRATING
	URINAL TRAP 100x180 DAA WITH 125mm GRATING
	FLOOR CLEAN OUTLET

HORIZONTAL PIPE CONNECTIONS SHALL BE AS FOLLOWS	
FROM WASH BASIN TO FT	320GI PIPE
FROM FD TO FT	502GI PIPE
FROM URINAL TO UT	402 PIPE
FROM FT TO VERTICAL STACK	1002 PIPE
FROM WC TO VERTICAL STACK	1002 PIPE
FROM UT TO VERTICAL STACK	1002 PIPE

CHAIRMAN
Building Plan Committee
Group Housing Societies
HSVP Circle, Gurugram


E.O. S.E. S.T.P.
HSVP HSVP HSVP
GURUGRAM

SANCTIONED
Valid For Five Years
Sub. To Condition of Allotment Letter

ESTATE OFFICER
VP GURUGRAM

OPENING SCHEDULE				
1	GL1		2575	2700
2	GL2		2635	2700
3	GL3		2930	2700
4	GL4		1915	2700
5	GL5		3425	2700
6	GL6		5330	2700
7	GL7		5940	2700
8	GL8		4660	2400
9	GL9		12250	2400
10	GL10		2100	1950
11	GL11		1500	1950
12	GL12		2575	2700
13	GL13		4045	2700
14	GL14		925	7200
15	GL15		1250	7200
16	GL16		4800	7200
17	FD		1200	2400

GROUND FLOOR AREA - FAR & COVERED AREA				
S.NO	CODE	LENGTH IN M	WIDTH IN M	AREA IN SQM
1	G1	49.730	26.480	49.730x26.480
2	G2	(3.855+4.285)/2	3.810	(3.855+4.285)/2x3.810
3	G3	(4.380+4.815)/2	3.810	(4.380+4.815)/2x3.810
TOTAL = G				1349.87
DEDUCTIONS				
1	1	4.800	1.180	4.800x1.180
2	2	24.930	1.480	24.93x1.480
3	3	2.690	3.920	2.690x3.920
4	4	5.500	3.385	5.500x3.385
5	5	2.450	2.785	2.450x2.785
6	6	3.720	3.120	3.720x3.120
7	7	5.520	5.420	5.520x5.420
8	8	2.700	0.525	2.700X0.525
TOTAL = D				121.488
NET GROUND COVERED AREA			G-D	1228.385

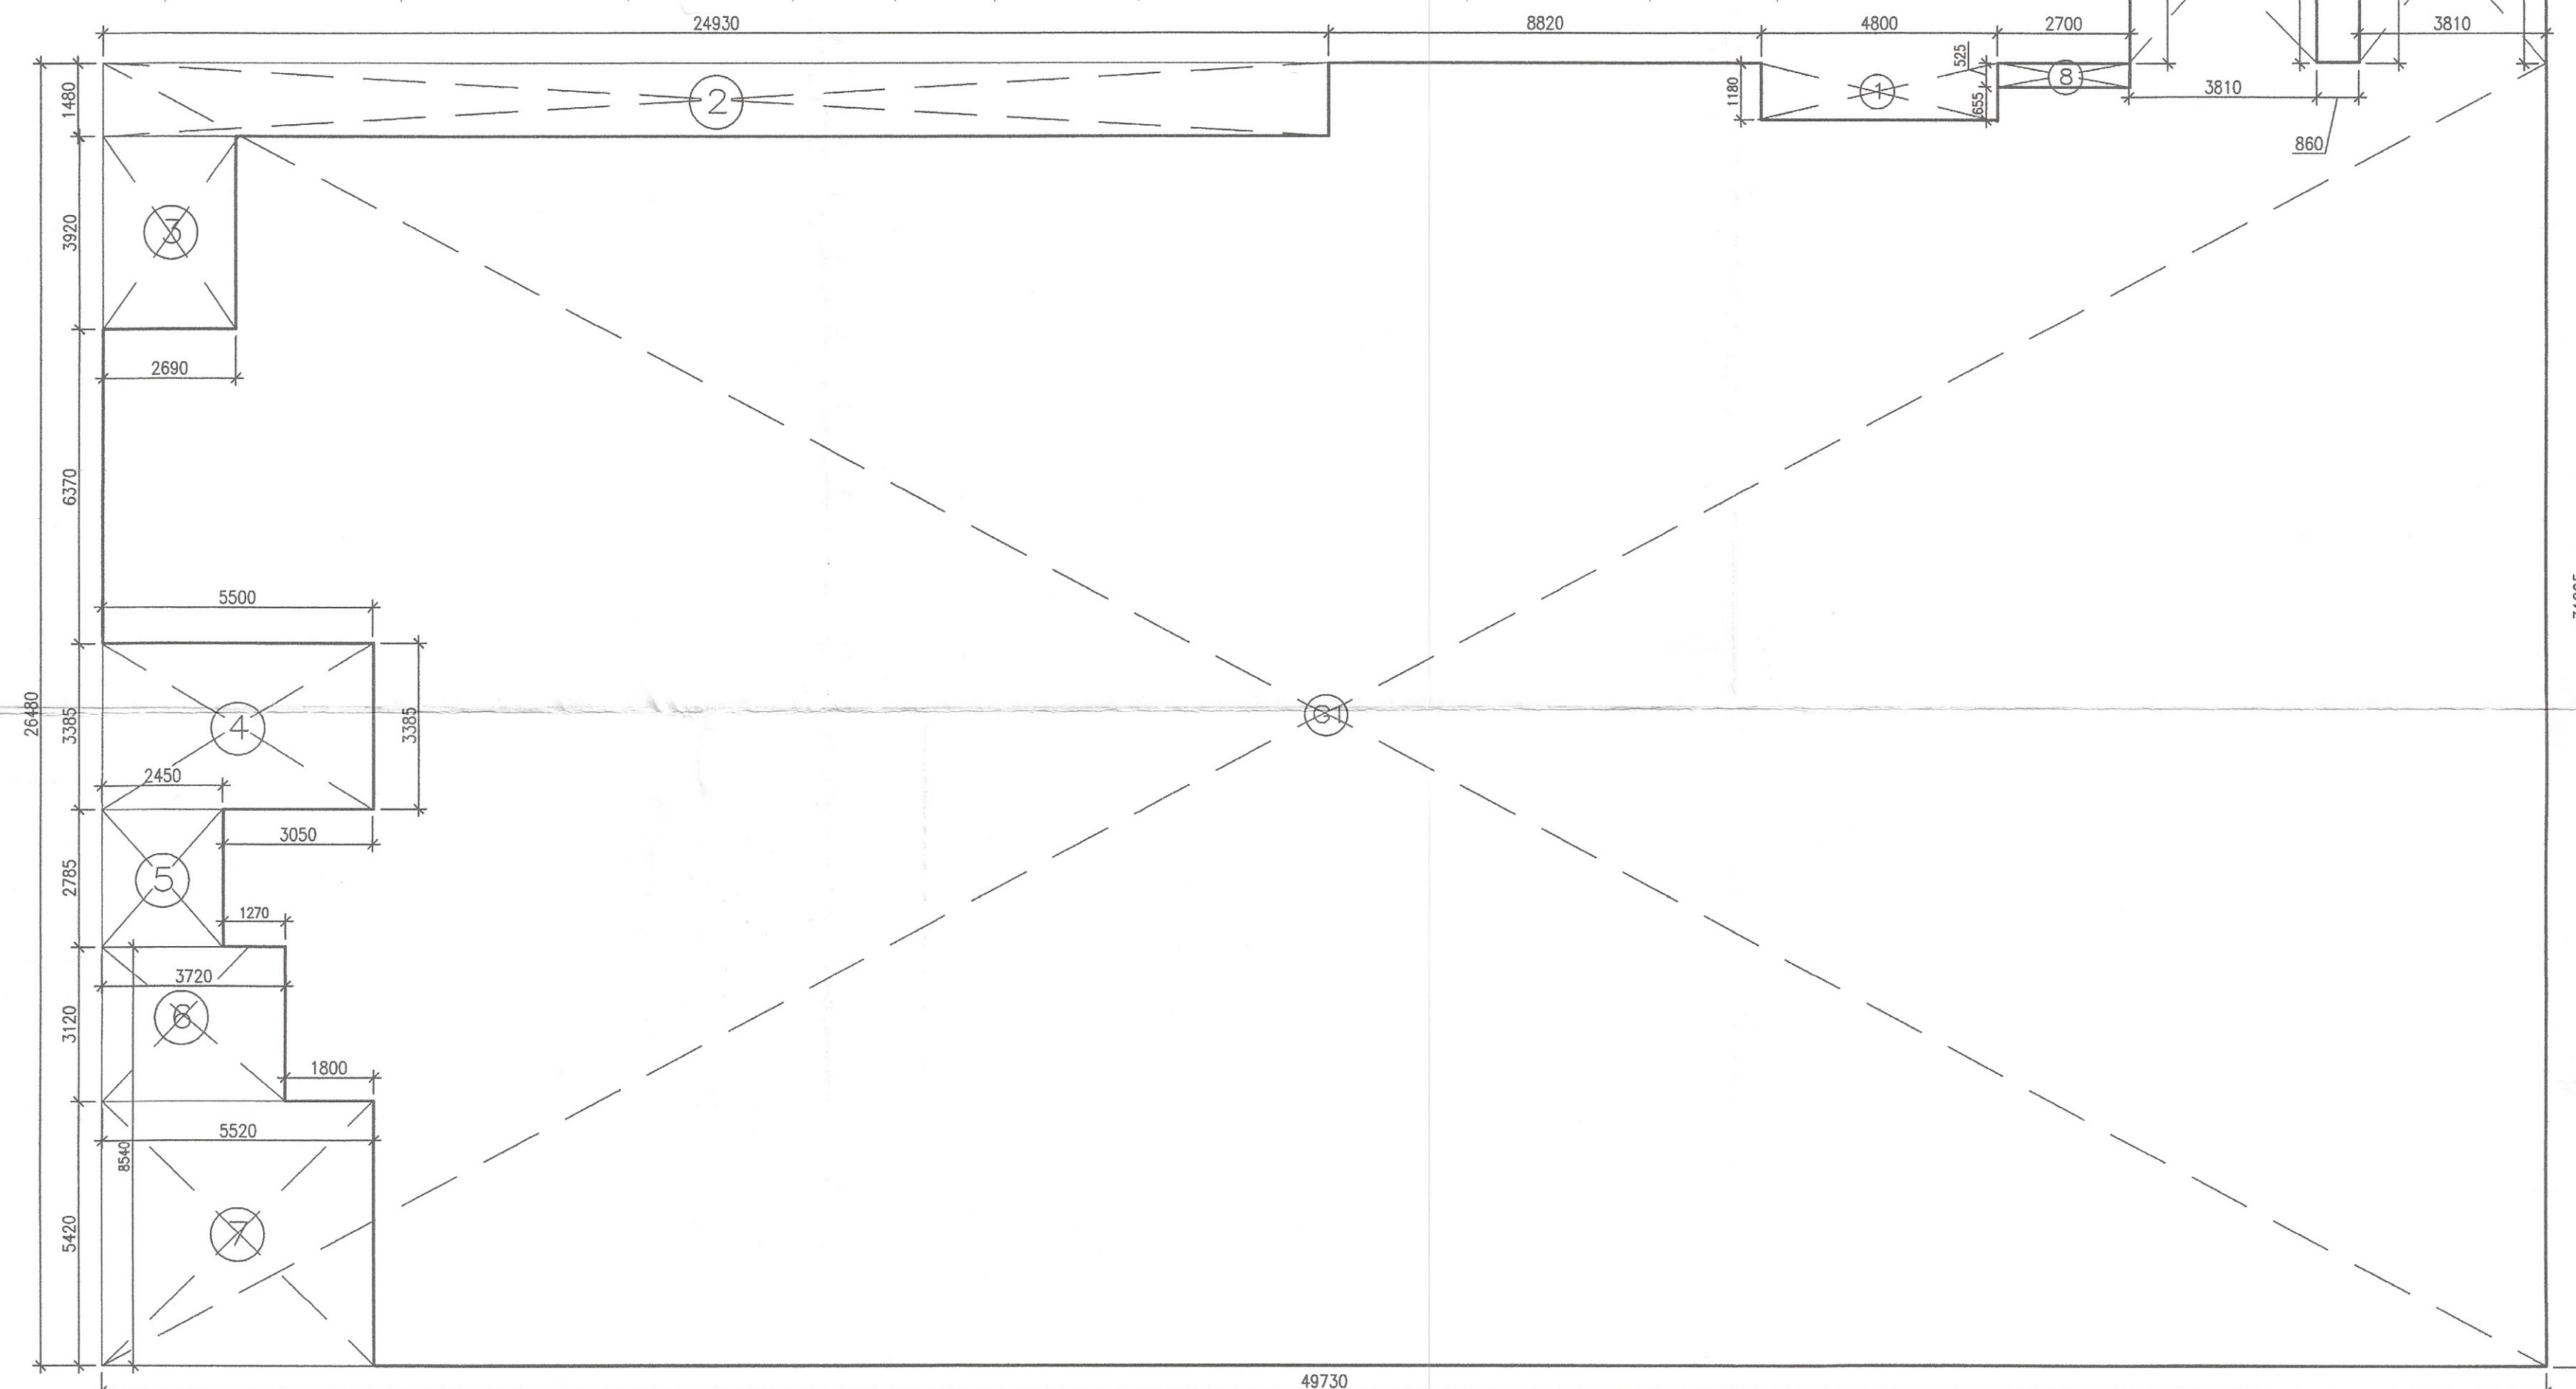

AREA DIAGRAM (GROUND FLOOR)

SUBMISSION DRAWING

PROJECT	BUILDING PLAN FOR GROUP HOUSING (GH1) AREA MEASURING 0.75989 ACRES IN SEC-23 & 23A, GURUGRAM BEING DEVELOPED BY M/S META DESIGN SOLUTIONS PVT. LTD.

DAULAT & PUNEET ARCHITECTS LLP
 408, Fourth Floor, Sun City Trade Tower
 Sector - 21, Gurugram - 122016
 E-MAIL: info@dparchitects.com, Phone : +91-724-4376466

Architecture	Interior	Planning	Vastu
--------------	----------	----------	-------

	Design Solutions Pvt. Ltd. Director
ARCHITECT RAJESH KUMAR & PUNEET ARCHITECTS VASANT NAGAR GATE NO. 40833 (INDIAN COMPANY) CHITRAKOOT	OWNER

SCALE	1:100
DATE ISSUED	29/01/2024
DRAWN BY	VAIBHAV
CHECKED BY	DAULAT GAR

GROUND FLOOR PLAN

MDS/02