


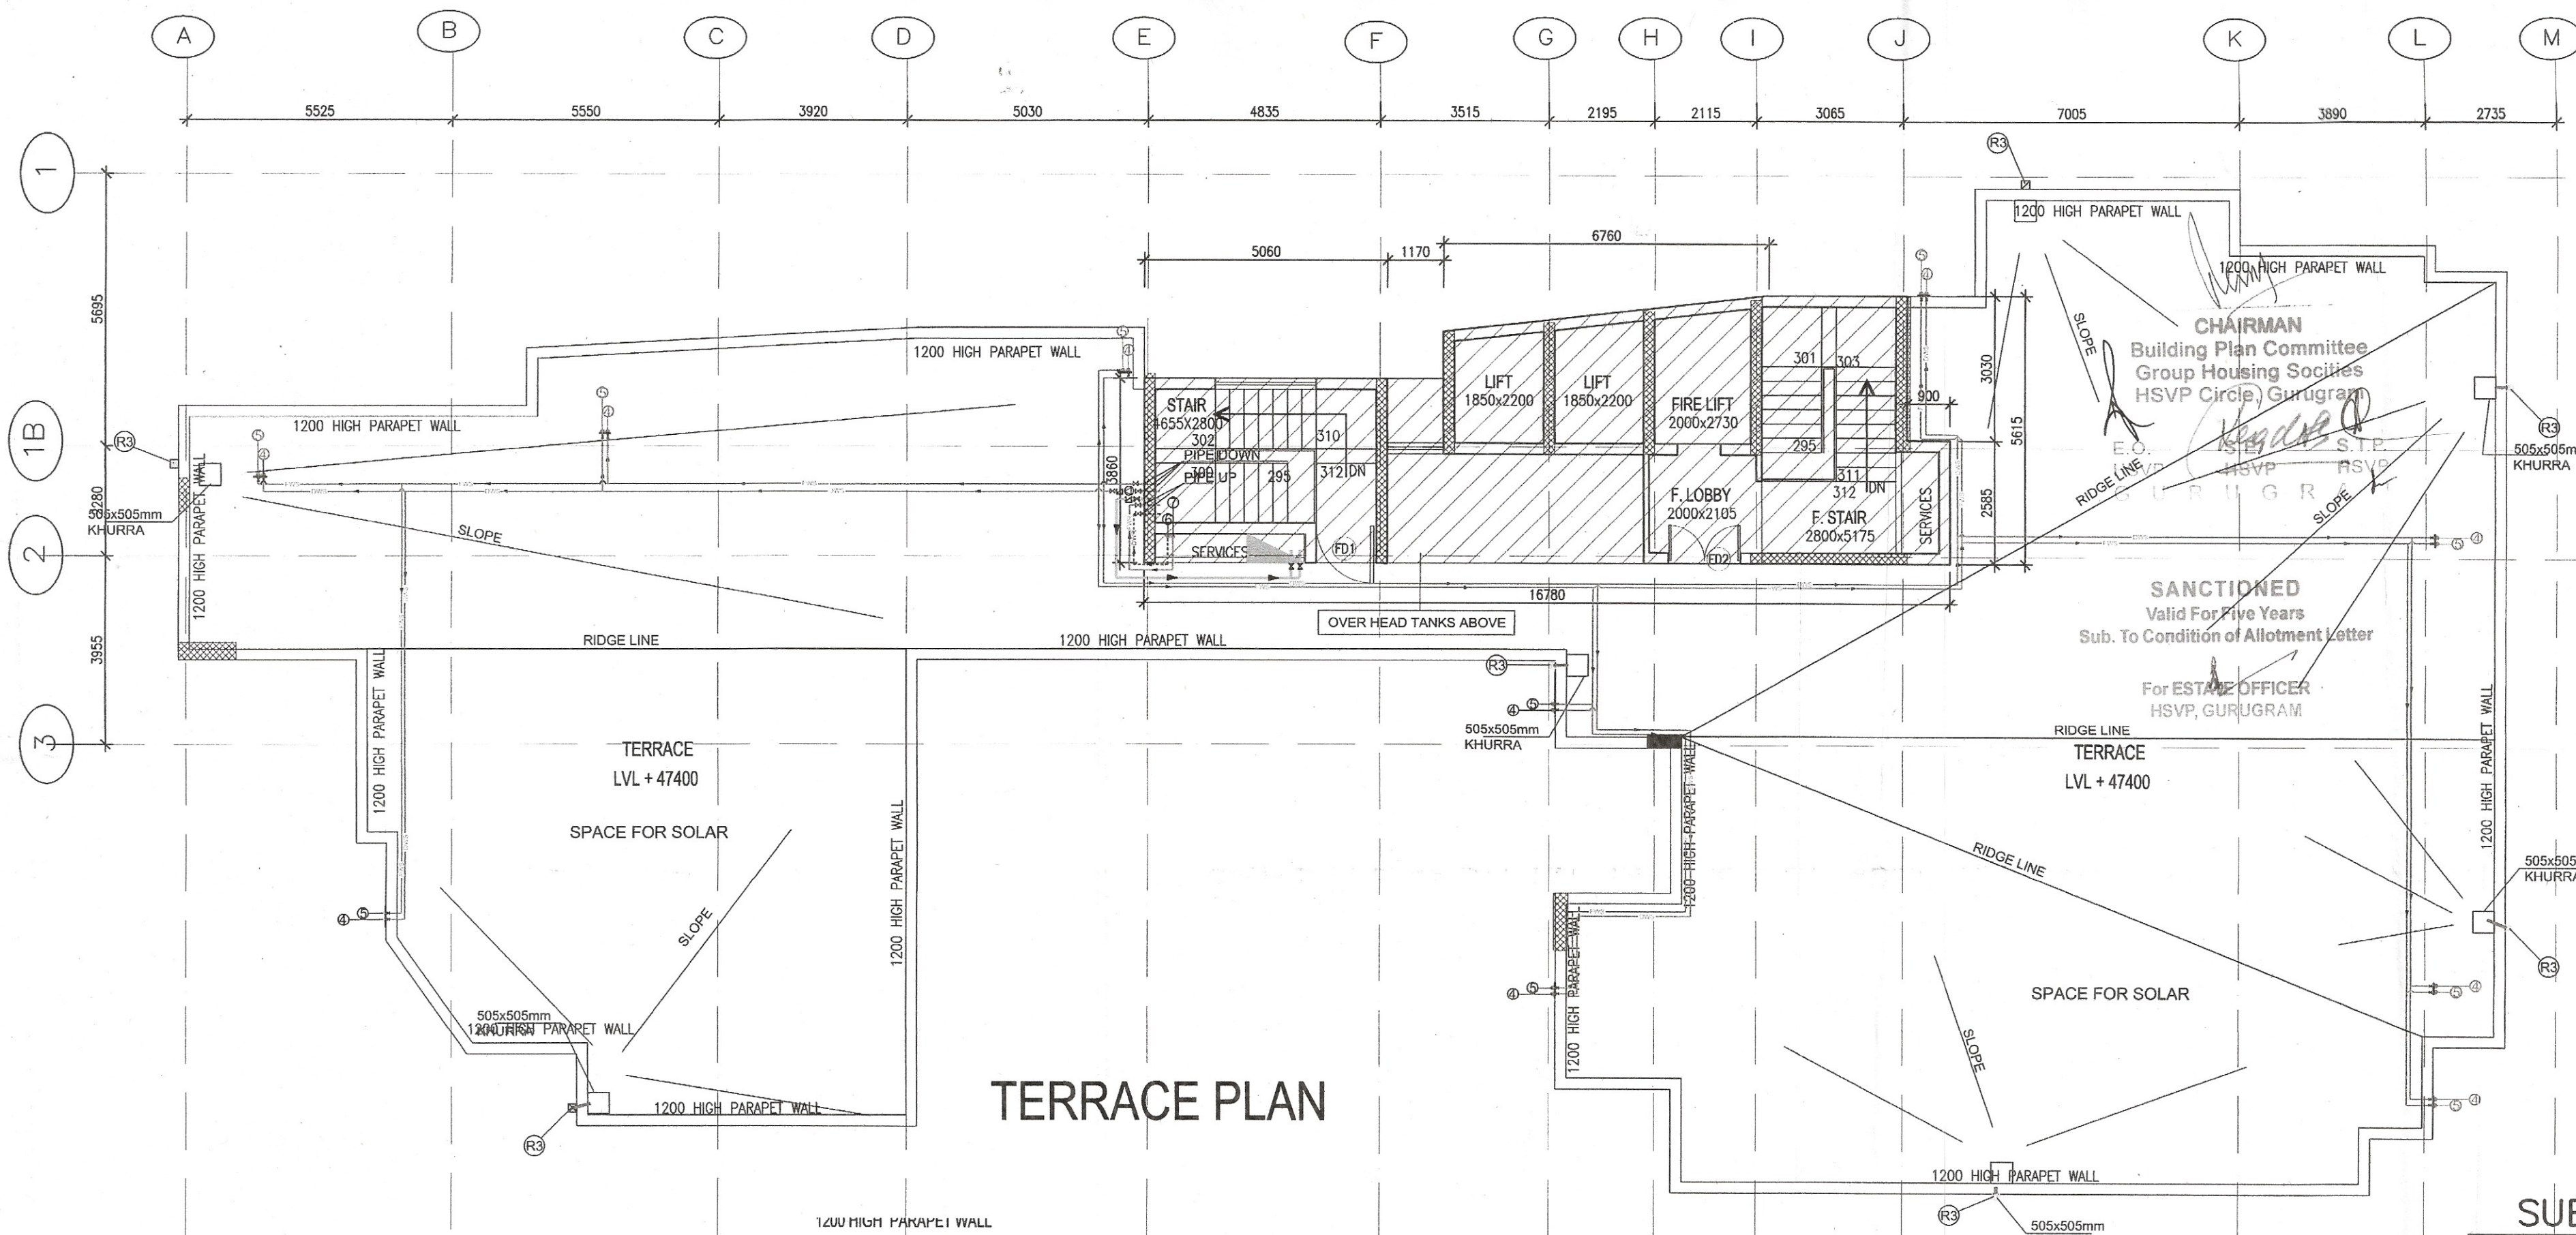


SYMBOL	DESCRIPTION
①	1000 SOIL & VENT PIPE
②	1000 WASTE & VENT PIPE
③	1000 ANTISYPHONAGE PIPE
④	DOMESTIC WATER SUPPLY
⑤	FLASHING WATER SUPPLY
⑥	DOMESTIC WATER RISER SUPPLY TO OVER HEAD TANK
⑦	FLUSHING WATER RISER
⑧	1500 MS FIRE LINE
⑨	1500 MS SPRINKLER LINE
⑩	800 DRAIN PIPE
R1	75 OD RAIN WATER PIPE
R2	90 OD RAIN WATER PIPE
R3	110 OD RAIN WATER PIPE
R4	160 OD RAIN WATER PIPE


SYMBOL	DESCRIPTION
→	1000 SOIL & VENT PIPE
→	1000 WASTE & VENT PIPE
⊙	FLOOR TRAP 100x100 DIA WITH 125mm GRATING
⊙	FLOOR DRAIN 100x100 DIA WITH GRATING
⊙	URINAL TRAP 100x100 DIA WITH 125mm GRATING
⊙	FLOOR CLEAN OUTLET

HORIZONTAL PIPE CONNECTIONS SHALL BE AS FOLLOWS.

FROM WASH BASIN TO FT	320GI PIPE
FROM FD TO FT	500GI PIPE
FROM URINAL TO UT	400 PIPE
FROM FT TO VERTICAL STACK	1000 PIPE
FROM WC TO VERTICAL STACK	1000 PIPE
FROM UT TO VERTICAL STACK	1000 PIPE

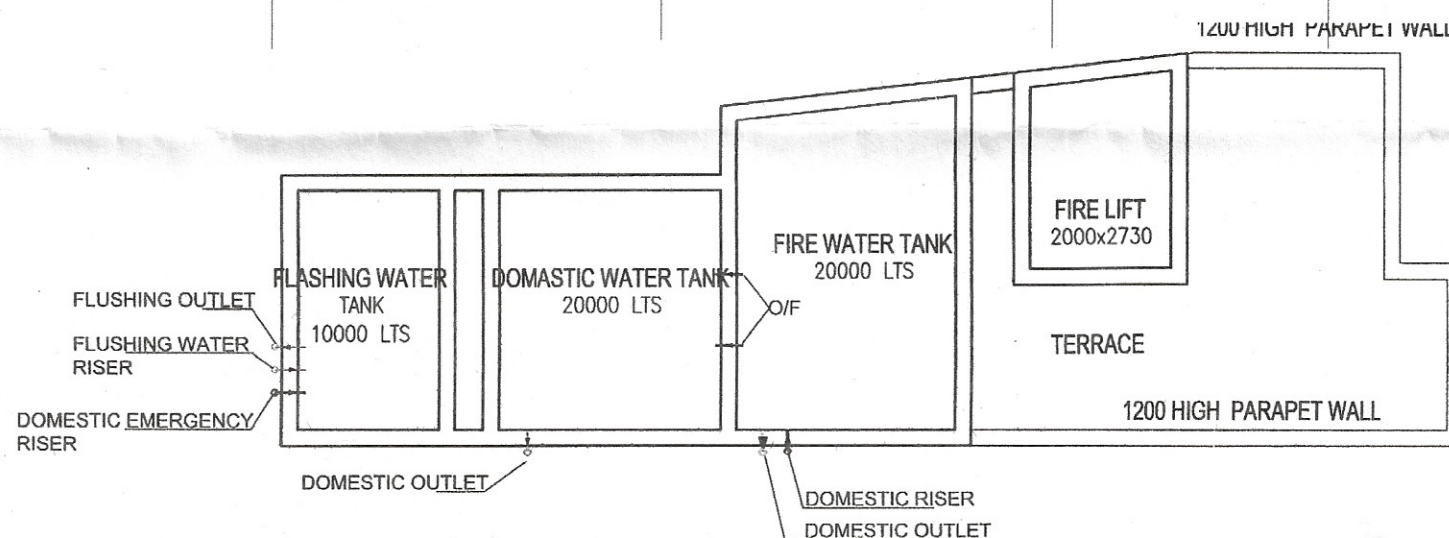


OVERHEAD WATER TANK PLAN

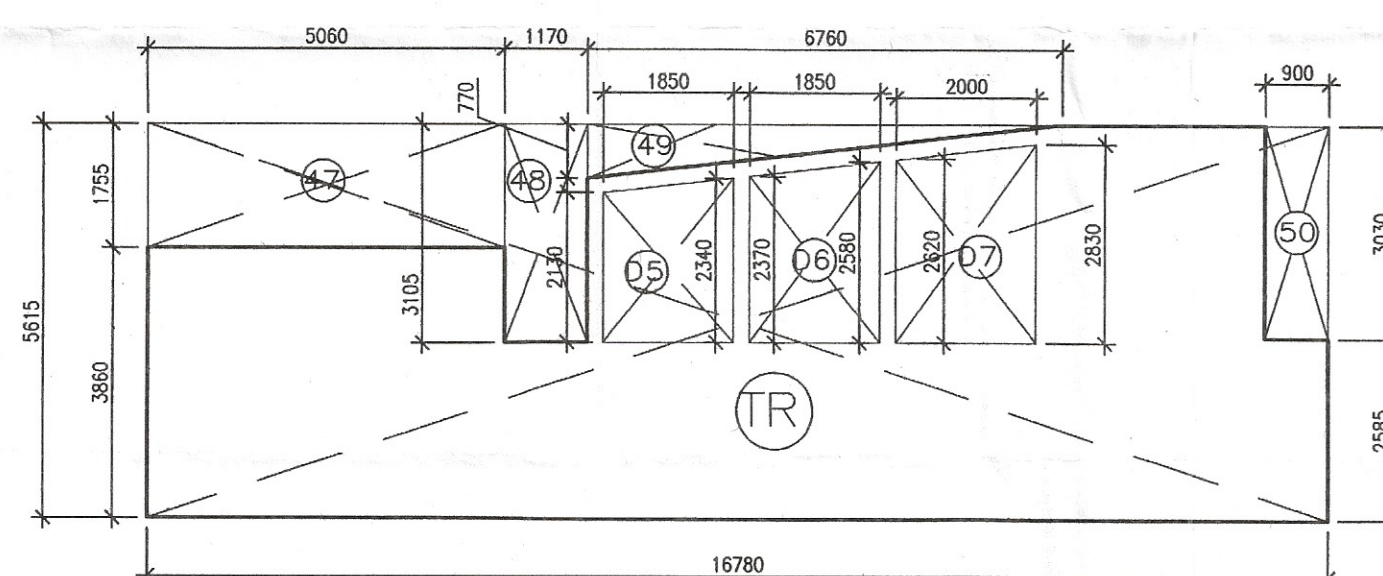

AREA DIAGRAM (MUMTY & MACHINE ROOM)

TERRACE COVERED AREA				
1	TR	16.780	5.615	16.780x5.615
				94.220
DEDUCTIONS				
1	D5	(2.130+2.340)/2	1.850	(2.130+2.340)/2x1.850
2	D6	(2.370+2.580)/2	1.850	(2.370+2.580)/2x1.850
3	D7	(2.620+2.830)/2	2.000	(2.62+2.83)/2x2.000
4	47	5.060	1.755	5.060x1.755
5	48	1.170	3.105	1.170x3.105
6	49	6.760	0.770	6.760x0.770x1/2
7	50	0.900	3.030	0.900x3.030
		TOTAL =DT		32.007
		NET COVERED AREA AT TERRACE=TR-DT		62.213

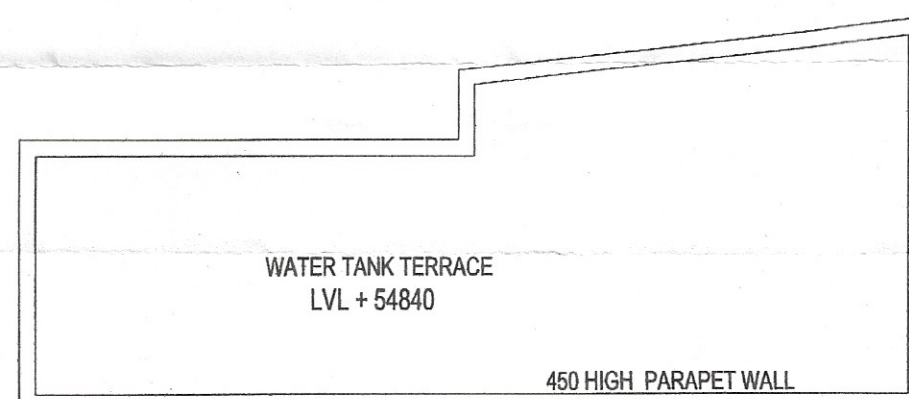

WATER TANK TERRACE PLAN

SUBMISSION DRAWING

PROJECT
BUILDING PLAN FOR GROUP HOUSING (GH1) AREA MEASURING 0.75989 ACRES IN SEC-23 & 23A, GURUGRAM BEING DEVELOPED BY M/S META DESIGN SOLUTIONS PVT. LTD.

ARCHITECT
DAULAT & PUNEET ARCHITECTS LLP.
408, Fourth Floor, Sun City Trade Tower, Sector - 21, Gurugram - 122016, E-MAIL: info@dnparchitects.com, Phone: +91-124-4376464
DnP ARCHITECTS LLP
Architecture Interior Planning Vastu

ARCHITECT
DAULAT & PUNEET ARCHITECTS LLP.
CA/2017/188437
OWNER
Director

SCALE 1:100
DATE ISSUED 29/01/2024
DRAWN BY VAIBHAV
CHECKED BY DAULAT GARG

DWG NO. TERRACE FLOOR PLAN
MDS/10