


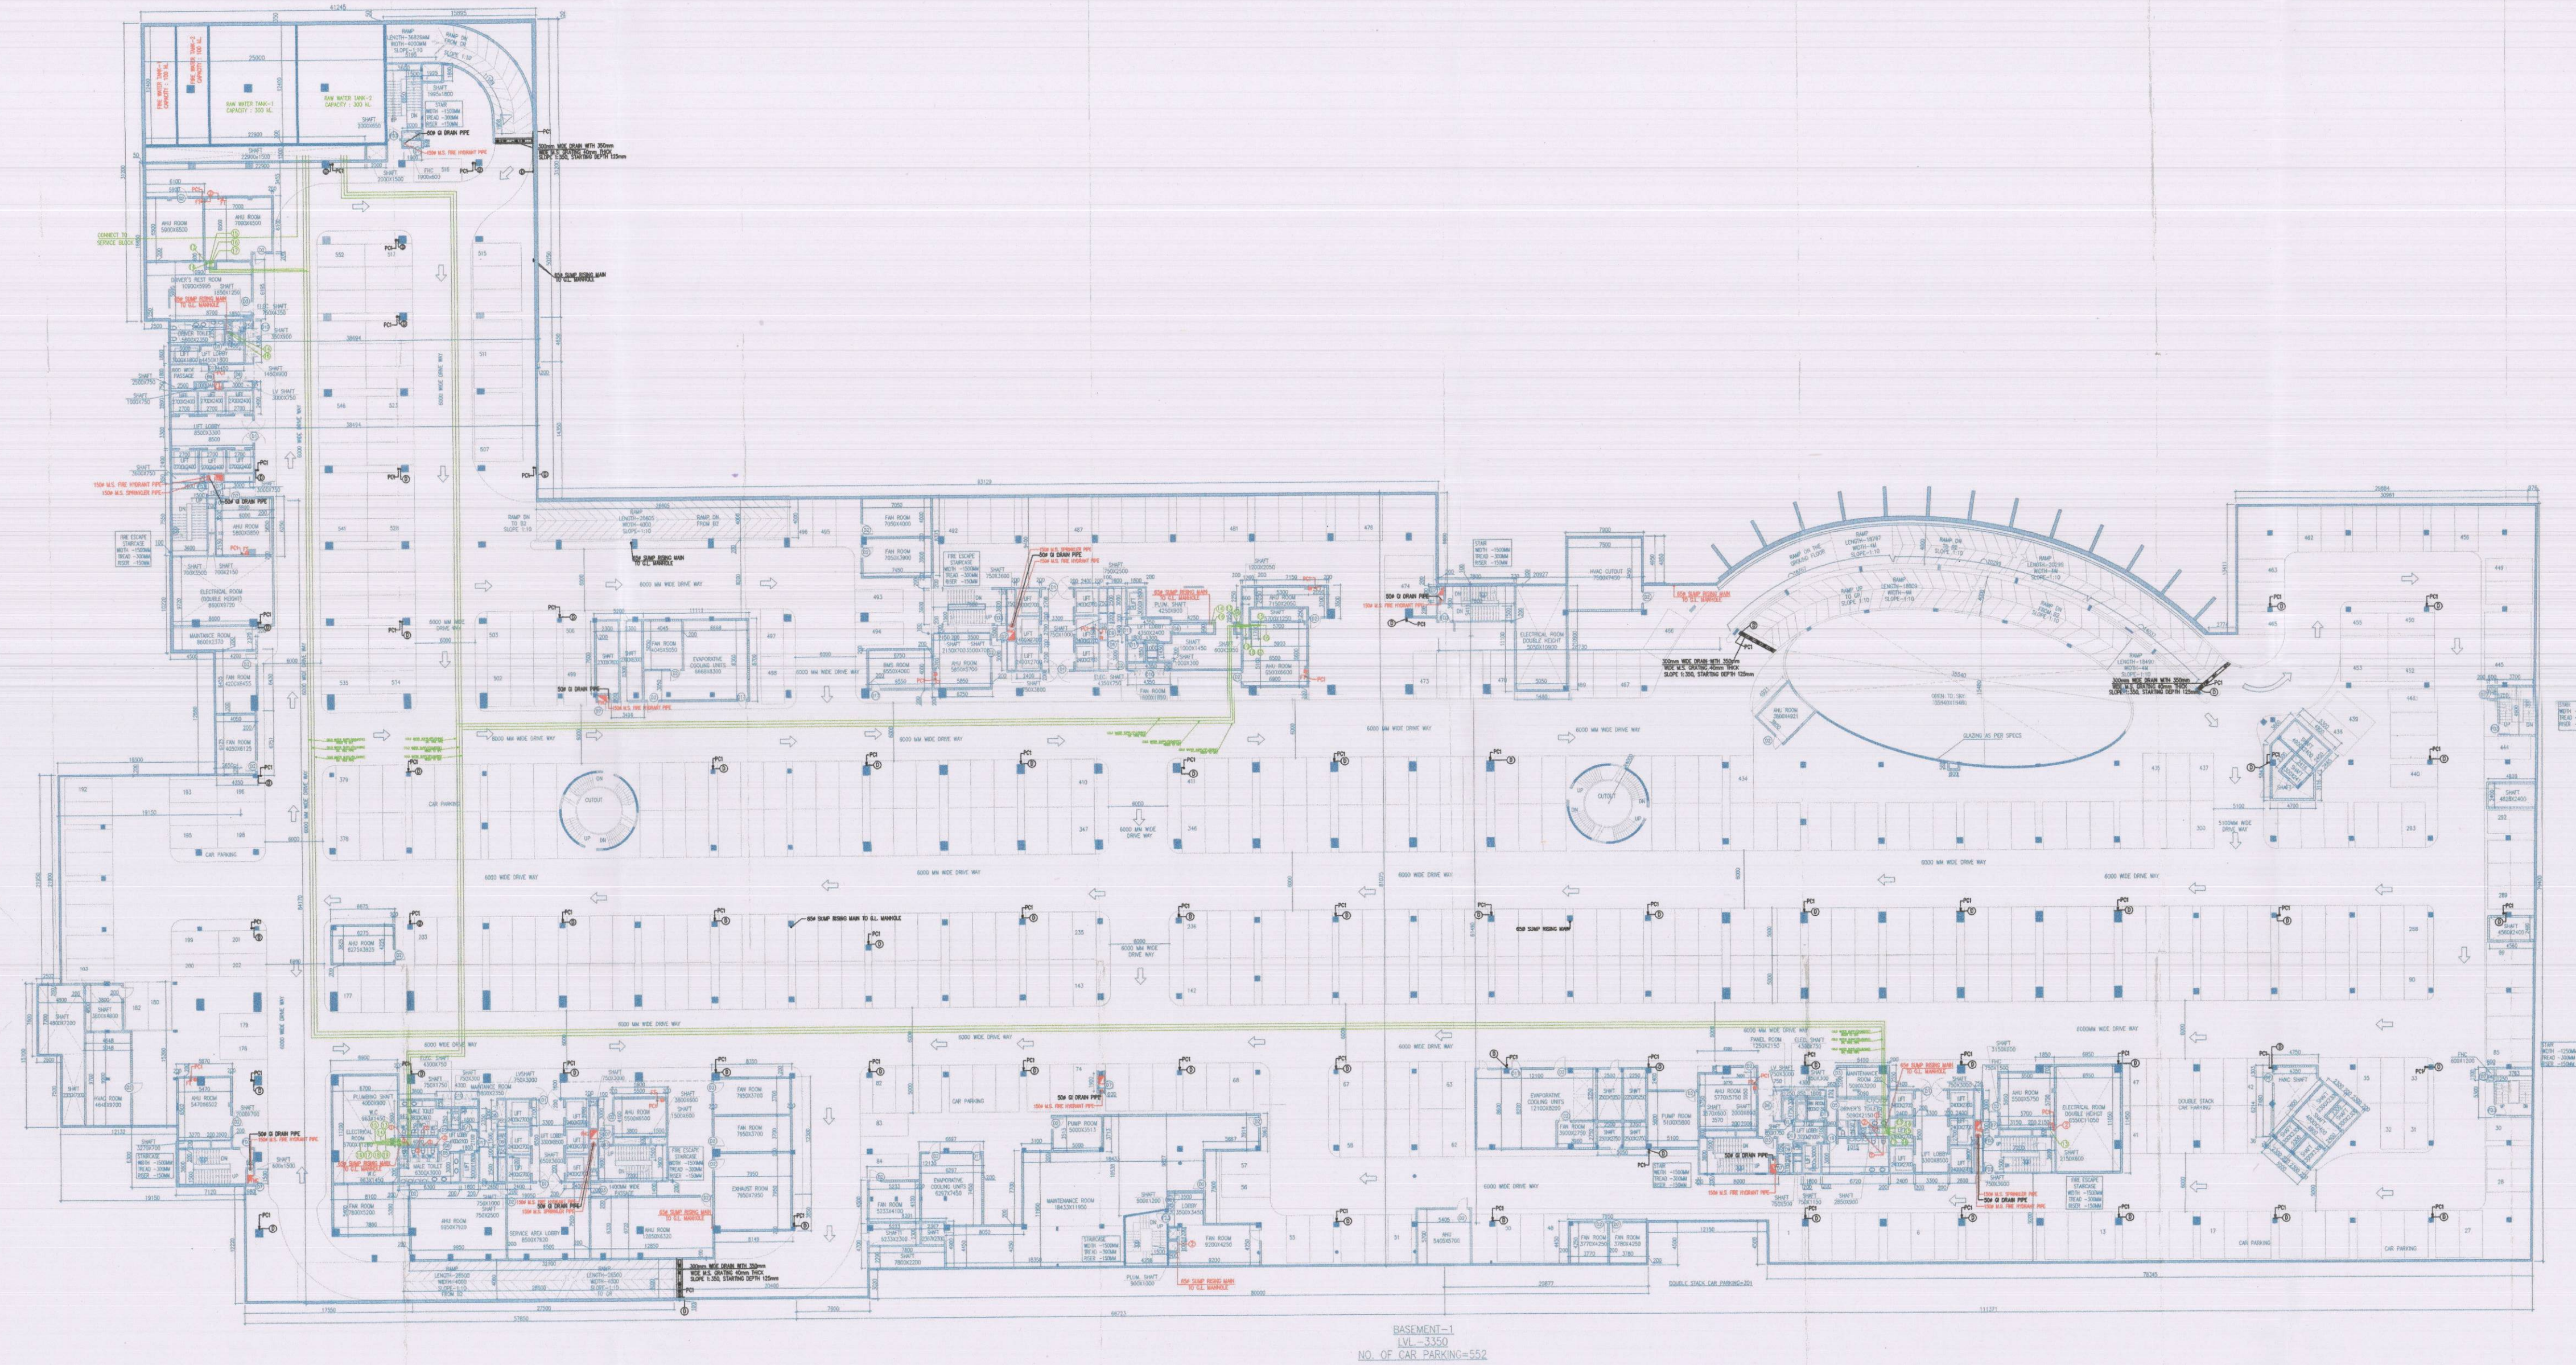

BASEMENT-1
U.M.-3350
NO. OF CAR PARKING=552

- Note:-
1. BUILDING HAS AUTOMATIC SPRINKLER SYSTEM WHEREVER REQUIRED BY NBC.
 2. BUILDING WILL BE DESIGNER STRUCTURES AS PER RELEVANT IS CODES FOR EARTH QUAKE RESISTANCE.
 3. BUILDING IS ARTIFICIALLY LIGHTED MECHANICALLY VENTILATED & CENTRALLY AIR-CONDITIONED.

- LEGEND:-
1. 100MM SOL & VENT PIPE
 2. 100MM WASTE & VENT PIPE
 3. 75MM ANTI-SYPHONAGE VENT PIPE(SOL)
 4. 75MM ANTI-SYPHONAGE VENT PIPE(WASTE)
 5. 100MM SOL PIPE
 6. 100MM WASTE PIPE
 7. 75MM WASTE PIPE
 8. 50MM ANTI-SYPHONAGE PIPE(SOL)
 9. 50MM ANTI-SYPHONAGE PIPE(WASTE)
 10. 50MM WASTE PIPE
 11. 40MM SOL/WASTE PIPE
 12. 32MM WASTE PIPE
 13. COLD WATER SUPPLY(DOMESTIC)
 14. COLD WATER SUPPLY(DOMESTIC)
 15. COLD WATER SUPPLY(FLUSHING)
 16. COLD WATER SUPPLY(FLUSHING)
 17. COLD WATER SUPPLY(DOMESTIC)
 18. COLD WATER SUPPLY(FLUSHING)
 19. COLD WATER SUPPLY(SOFT WATER)

Project:-
REVISED BUILDING PLAN OF
IT PARK MEASURING 8.793
ACRES (LICENCE NO. 1133
OF DATED 22.9.2006) IN
SECTOR-27 B FARIDABAD
BEING DEVELOPED BY M/S
VATIKA IT PARK PVT.
LTD. PREVIOUSLY KNOWN AS
HIND ENTERPRISES PVT. LTD.
Associate Architects

RISMS
ARCHITECTS
RSMS ARCHITECTS PVT. LTD.
69, Nara Niwas - Bhawani Kunj,
(Behind D2), Vasant Kunj,
New Delhi-110070.
Tel.: 011-26898616, 26898617
www.rsms-arch.com

Checked and Found ok for Public Health
(Internal) Services only subject to the
Approval of the Local Authorities.
Responsible Engineer
RISMS ARCHITECTS

ARCHITECT'S SEAL & SIGNATURE

OWNER'S SEAL & SIGNATURE



JULY, 2012 SCALE 1:200

DRAWING TITLE:-

FLOOR PLAN

BASEMENT-1

BS-01

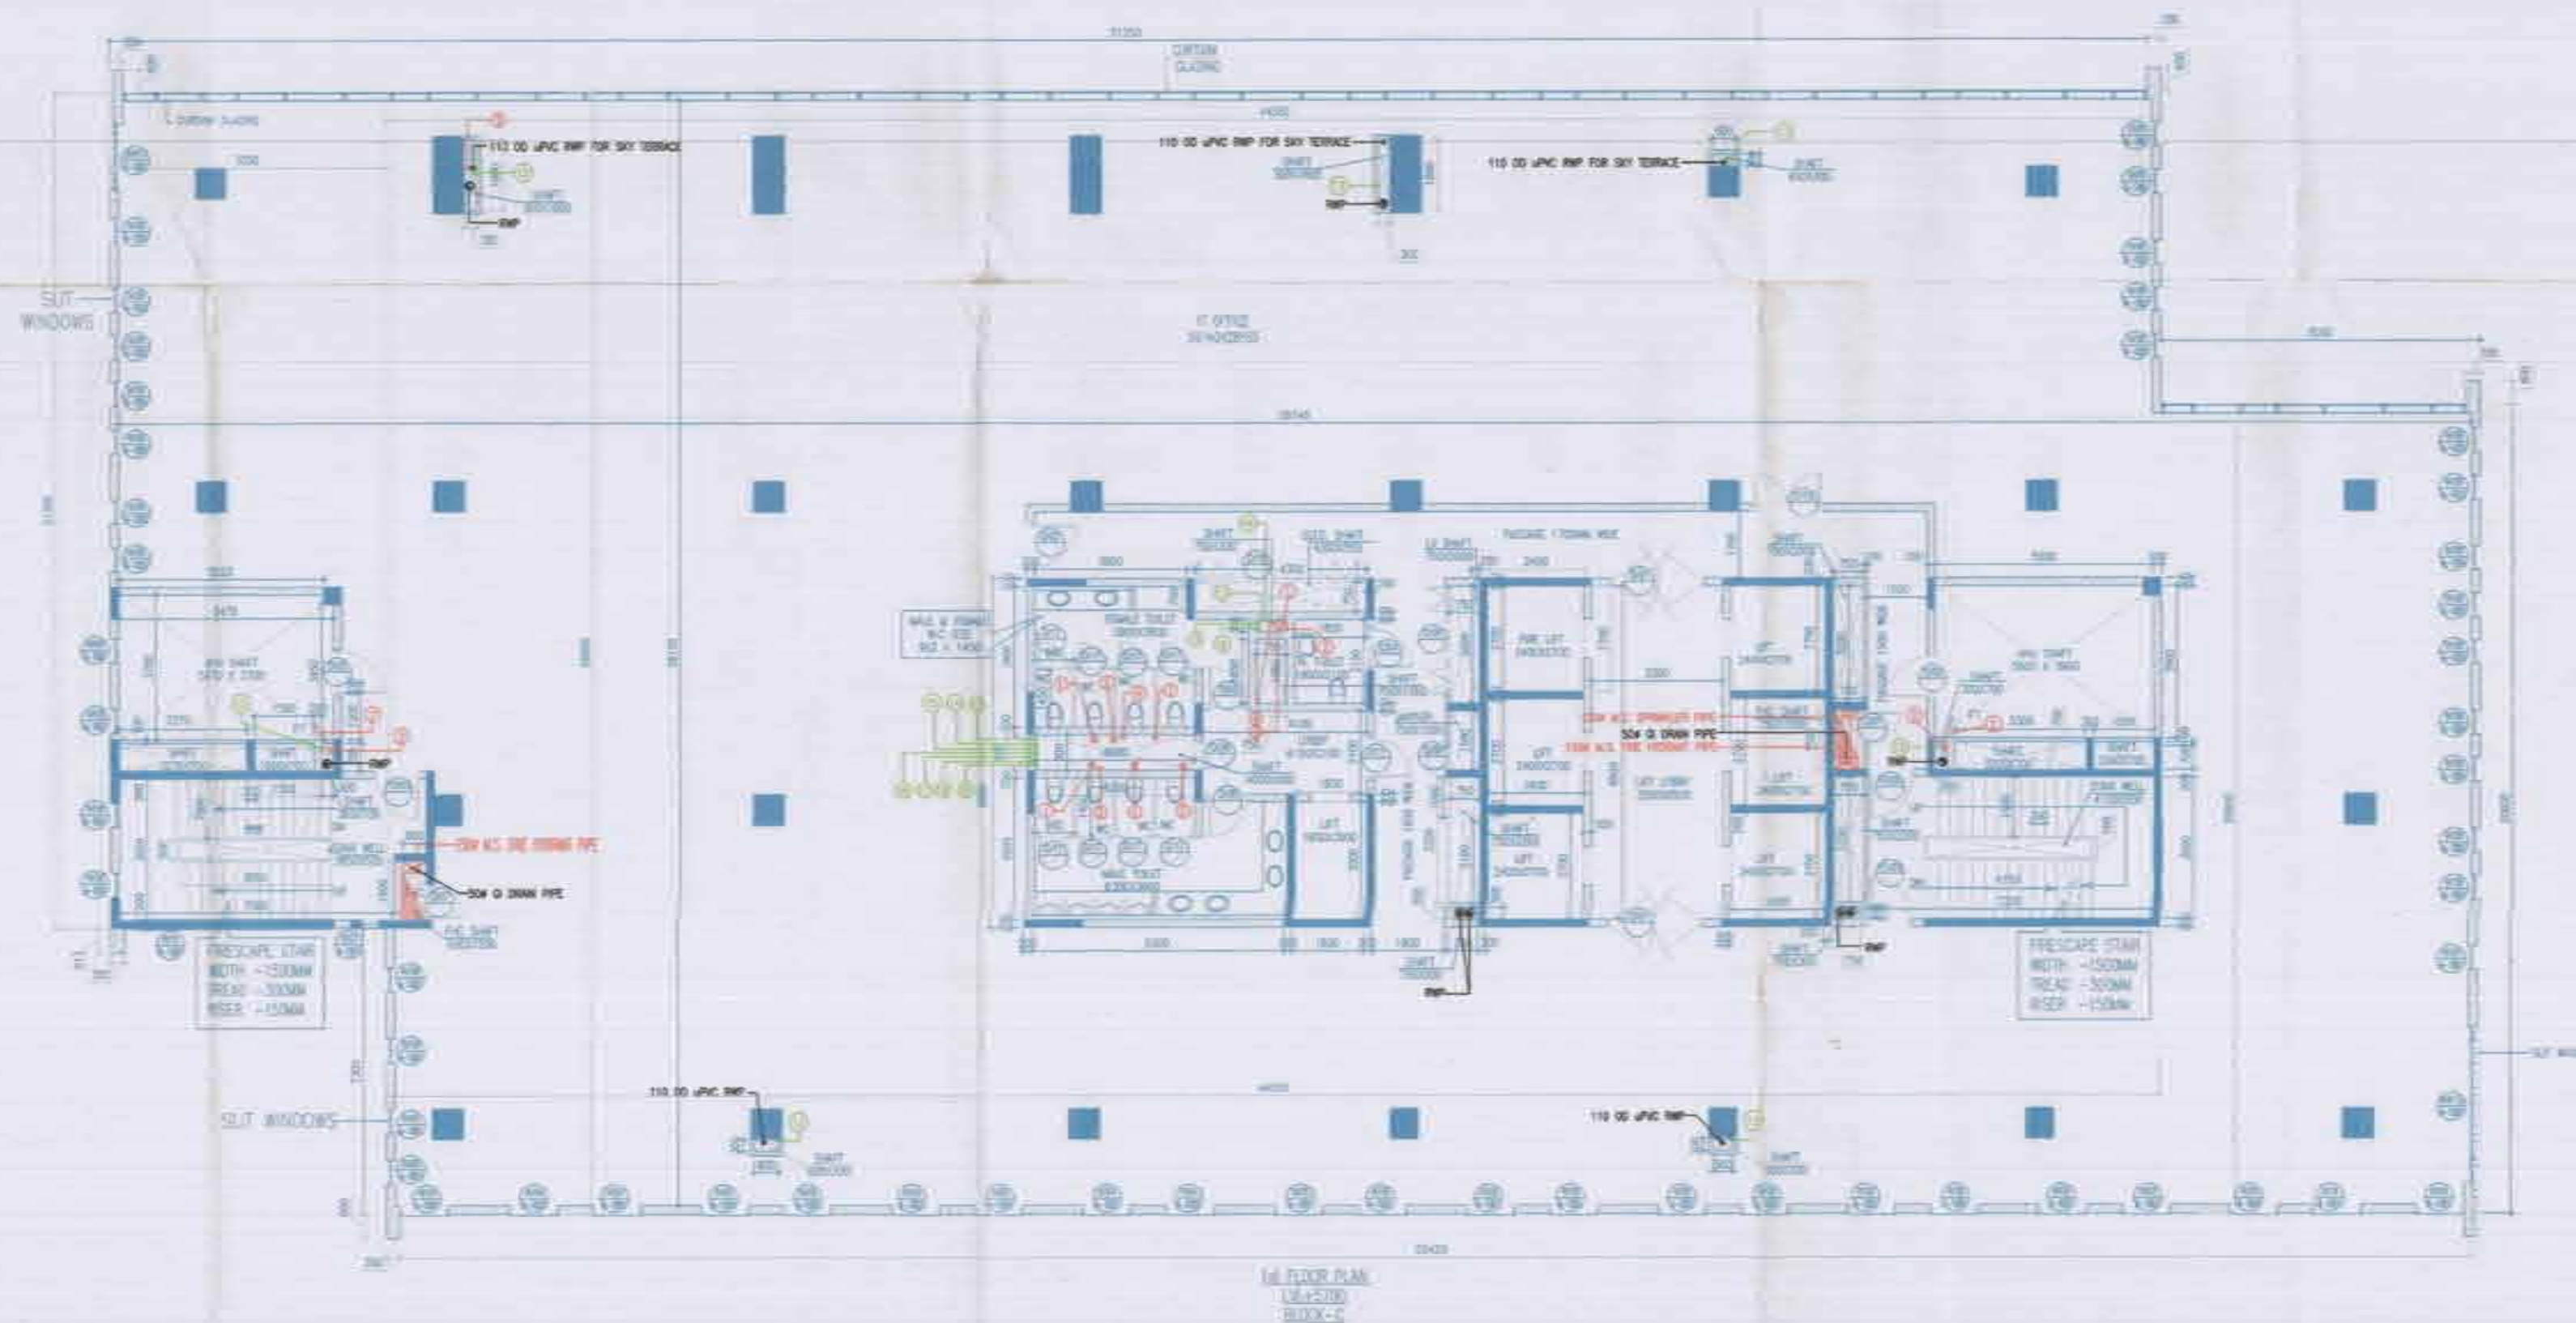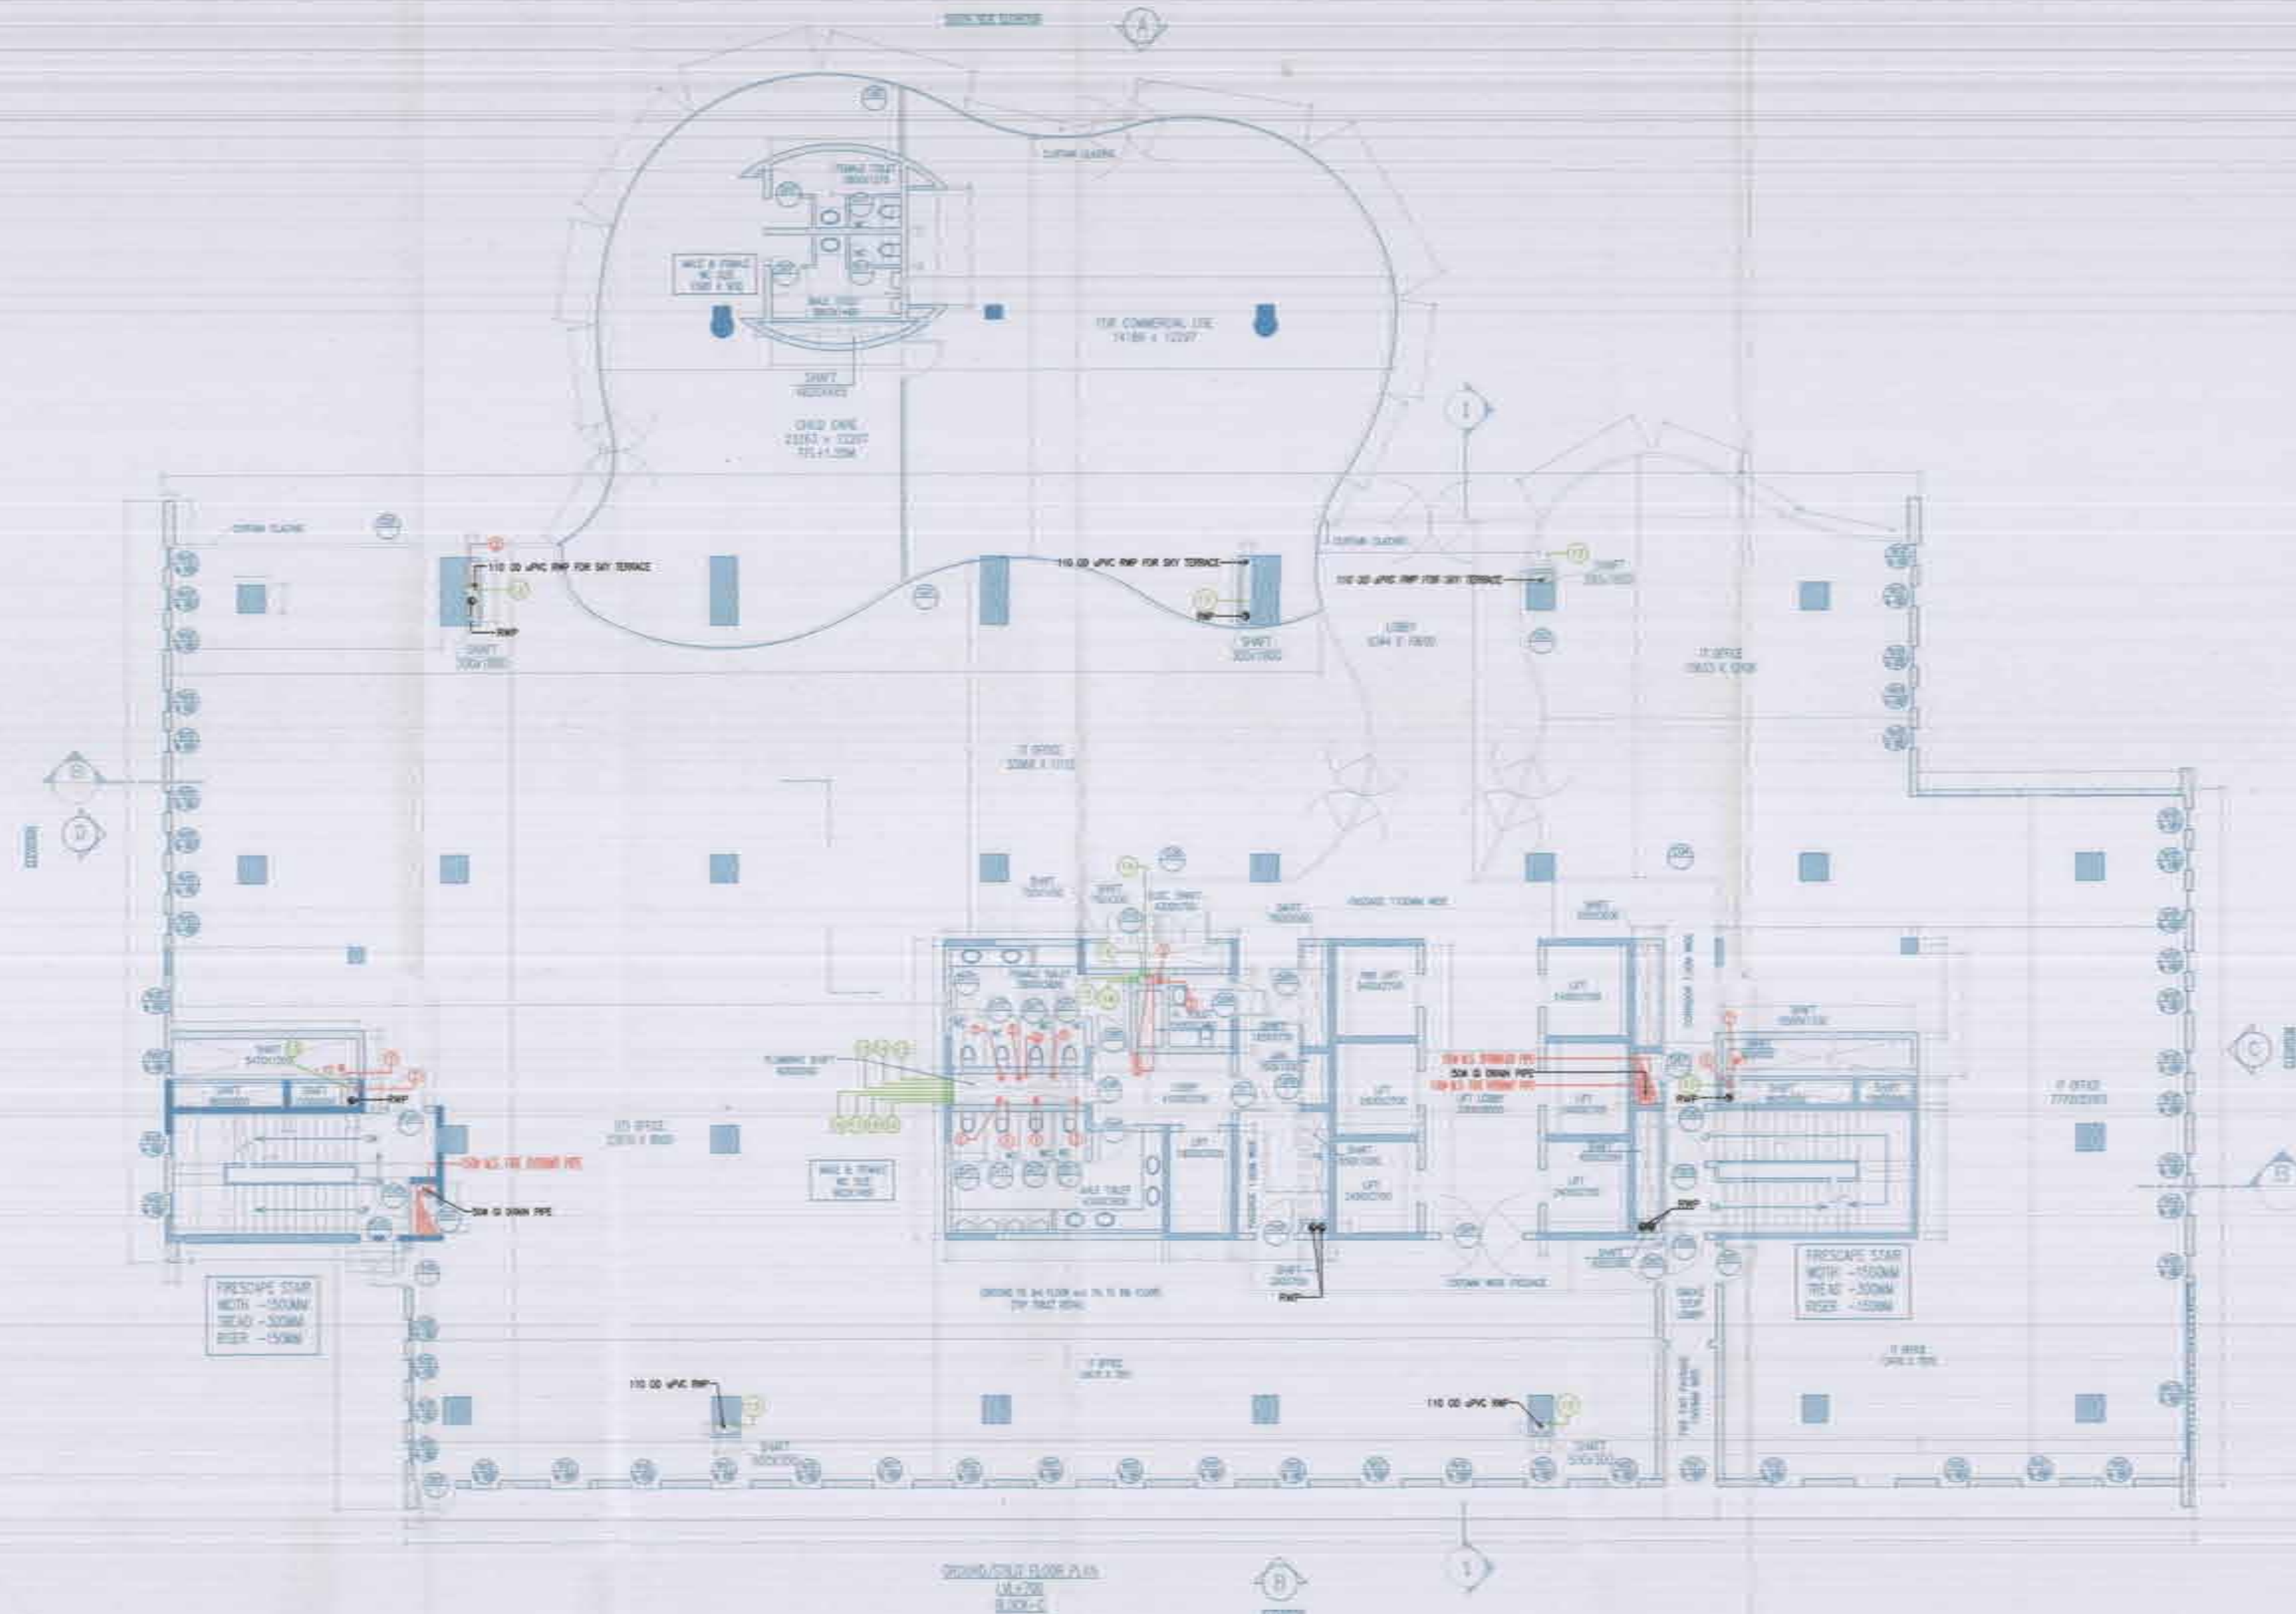

NO.	DESCRIPTION	QTY	UNIT	REMARKS
1	1000	1	sq. ft.	
2	1000	1	sq. ft.	
3	1000	1	sq. ft.	
4	1000	1	sq. ft.	
5	1000	1	sq. ft.	
6	1000	1	sq. ft.	
7	1000	1	sq. ft.	
8	1000	1	sq. ft.	
9	1000	1	sq. ft.	
10	1000	1	sq. ft.	
11	1000	1	sq. ft.	
12	1000	1	sq. ft.	
13	1000	1	sq. ft.	
14	1000	1	sq. ft.	
15	1000	1	sq. ft.	
16	1000	1	sq. ft.	
17	1000	1	sq. ft.	
18	1000	1	sq. ft.	
19	1000	1	sq. ft.	
20	1000	1	sq. ft.	

NO.	DESCRIPTION	QTY	UNIT	REMARKS
1	1000	1	sq. ft.	
2	1000	1	sq. ft.	
3	1000	1	sq. ft.	
4	1000	1	sq. ft.	
5	1000	1	sq. ft.	
6	1000	1	sq. ft.	
7	1000	1	sq. ft.	
8	1000	1	sq. ft.	
9	1000	1	sq. ft.	
10	1000	1	sq. ft.	
11	1000	1	sq. ft.	
12	1000	1	sq. ft.	
13	1000	1	sq. ft.	
14	1000	1	sq. ft.	
15	1000	1	sq. ft.	
16	1000	1	sq. ft.	
17	1000	1	sq. ft.	
18	1000	1	sq. ft.	
19	1000	1	sq. ft.	
20	1000	1	sq. ft.	

Note:-
 1. BUILDING HAS AUTOMATIC SPRINKLER SYSTEM WHEREVER REQUIRED BY NBC.
 2. BUILDING WILL BE DESIGNED (STRUCTURES) AS PER REQUIREMENT AS PER EARTH SHAKES.
 3. BUILDING IS ARTIFICIALLY LIGHTED MECHANICALLY VENTILATED & CENTRALLY AIR-CONDITIONED.

REVISIONS
 NO. 1
 DATE 10/07/2012
 BY ARCHITECT
 DESCRIPTION
 1. CORRECTION OF DIMENSIONS
 2. CORRECTION OF ROOM NO.
 3. CORRECTION OF ROOM NO.
 4. CORRECTION OF ROOM NO.
 5. CORRECTION OF ROOM NO.
 6. CORRECTION OF ROOM NO.
 7. CORRECTION OF ROOM NO.
 8. CORRECTION OF ROOM NO.
 9. CORRECTION OF ROOM NO.
 10. CORRECTION OF ROOM NO.



Project:-
 REVISED BUILDING PLAN OF LT PARK MEASURING 8.793 ACRES (LICENCE NO. 1133 OF DATED 22.9.2008) IN SECTOR-27 B FARIDABAD BEING DEVELOPED BY M/S. VATIKA IT PARK PVT. LTD. PREVIOUSLY KNOWN AS: HIND ENTERPRISES PVT. LTD.

Associate Architect
RISMS ARCHITECTS
 RISMS ARCHITECTS PVT. LTD.
 69, Nara Niwas, Bhowani Kunj (Behind D2), Vasant Kunj, New Delhi-110070
 Tel: 011-26898816, 26898617
 www.risms-arch.com

Sanctioned
 5-211-21113
 10/07/2012

ARCHITECT'S SEAL & SIGNATURE
 OWNER'S SEAL & SIGNATURE
 JULY 2012 Scale: 1:100
 Drawing Title: GROUND & 1ST FLOOR PLAN (BLOCK-C)
 Drawing No: C-01

For VATIKA LIMITED
 Authorised Signatory

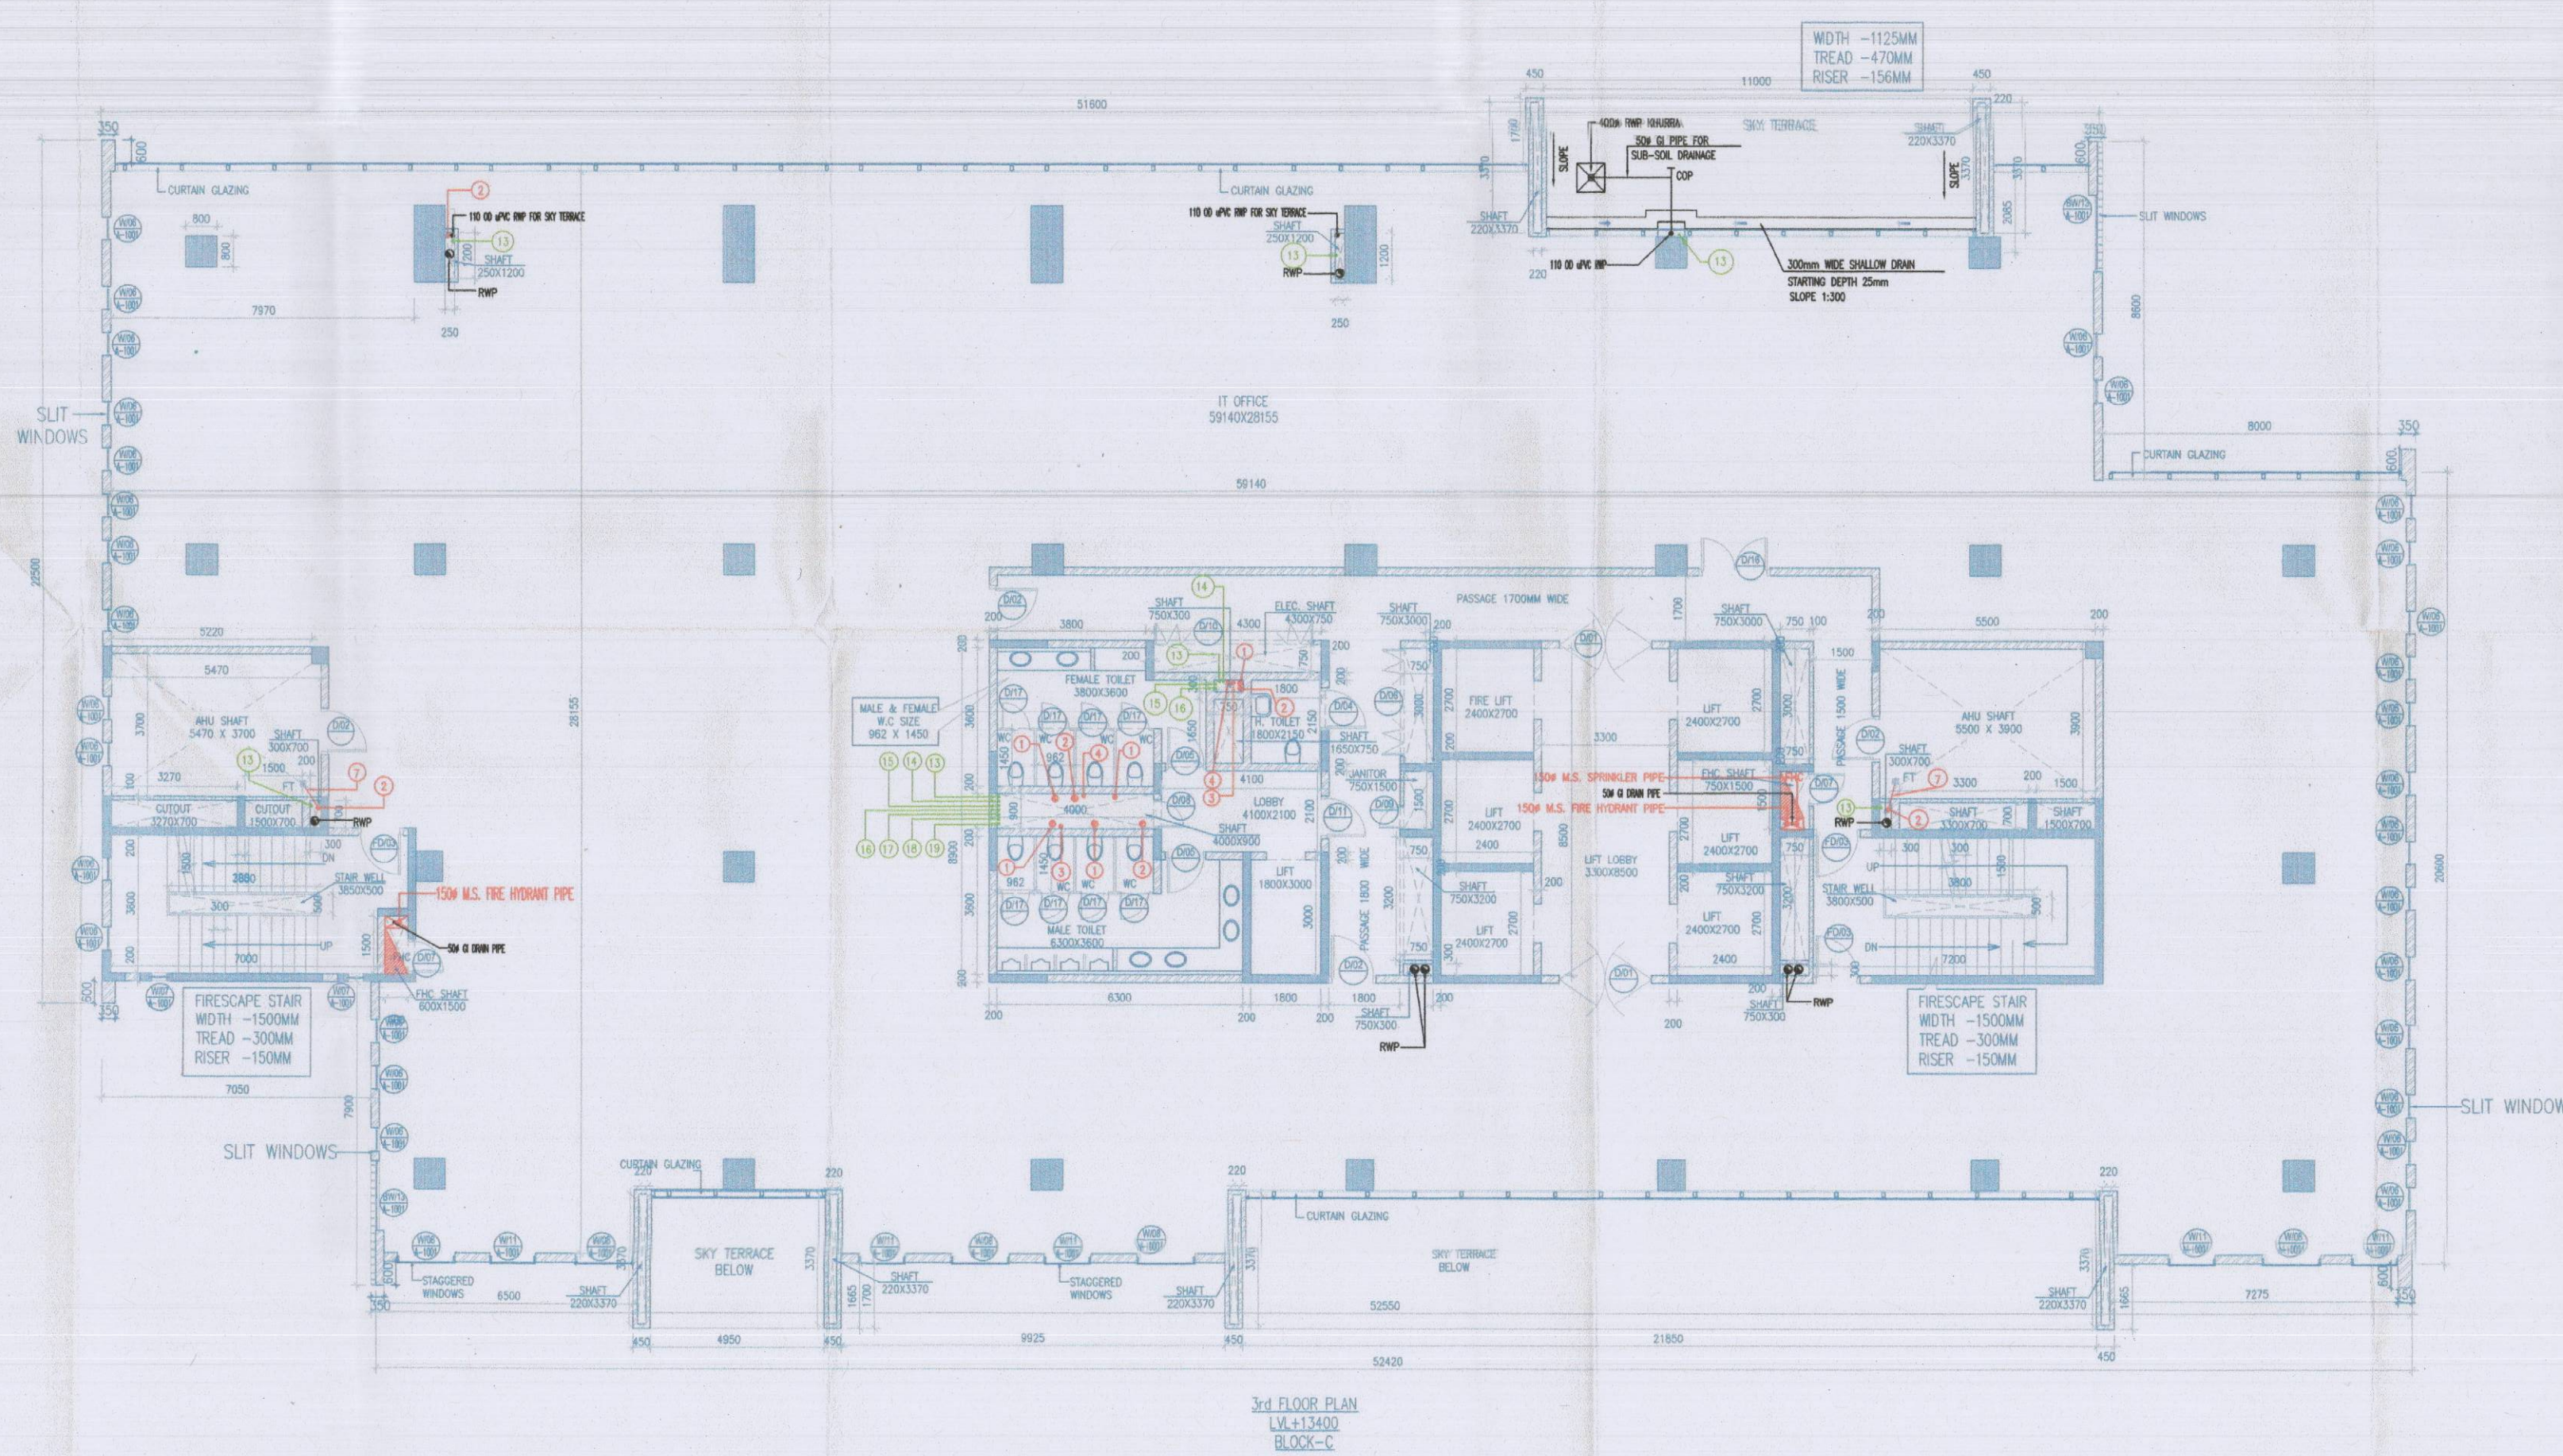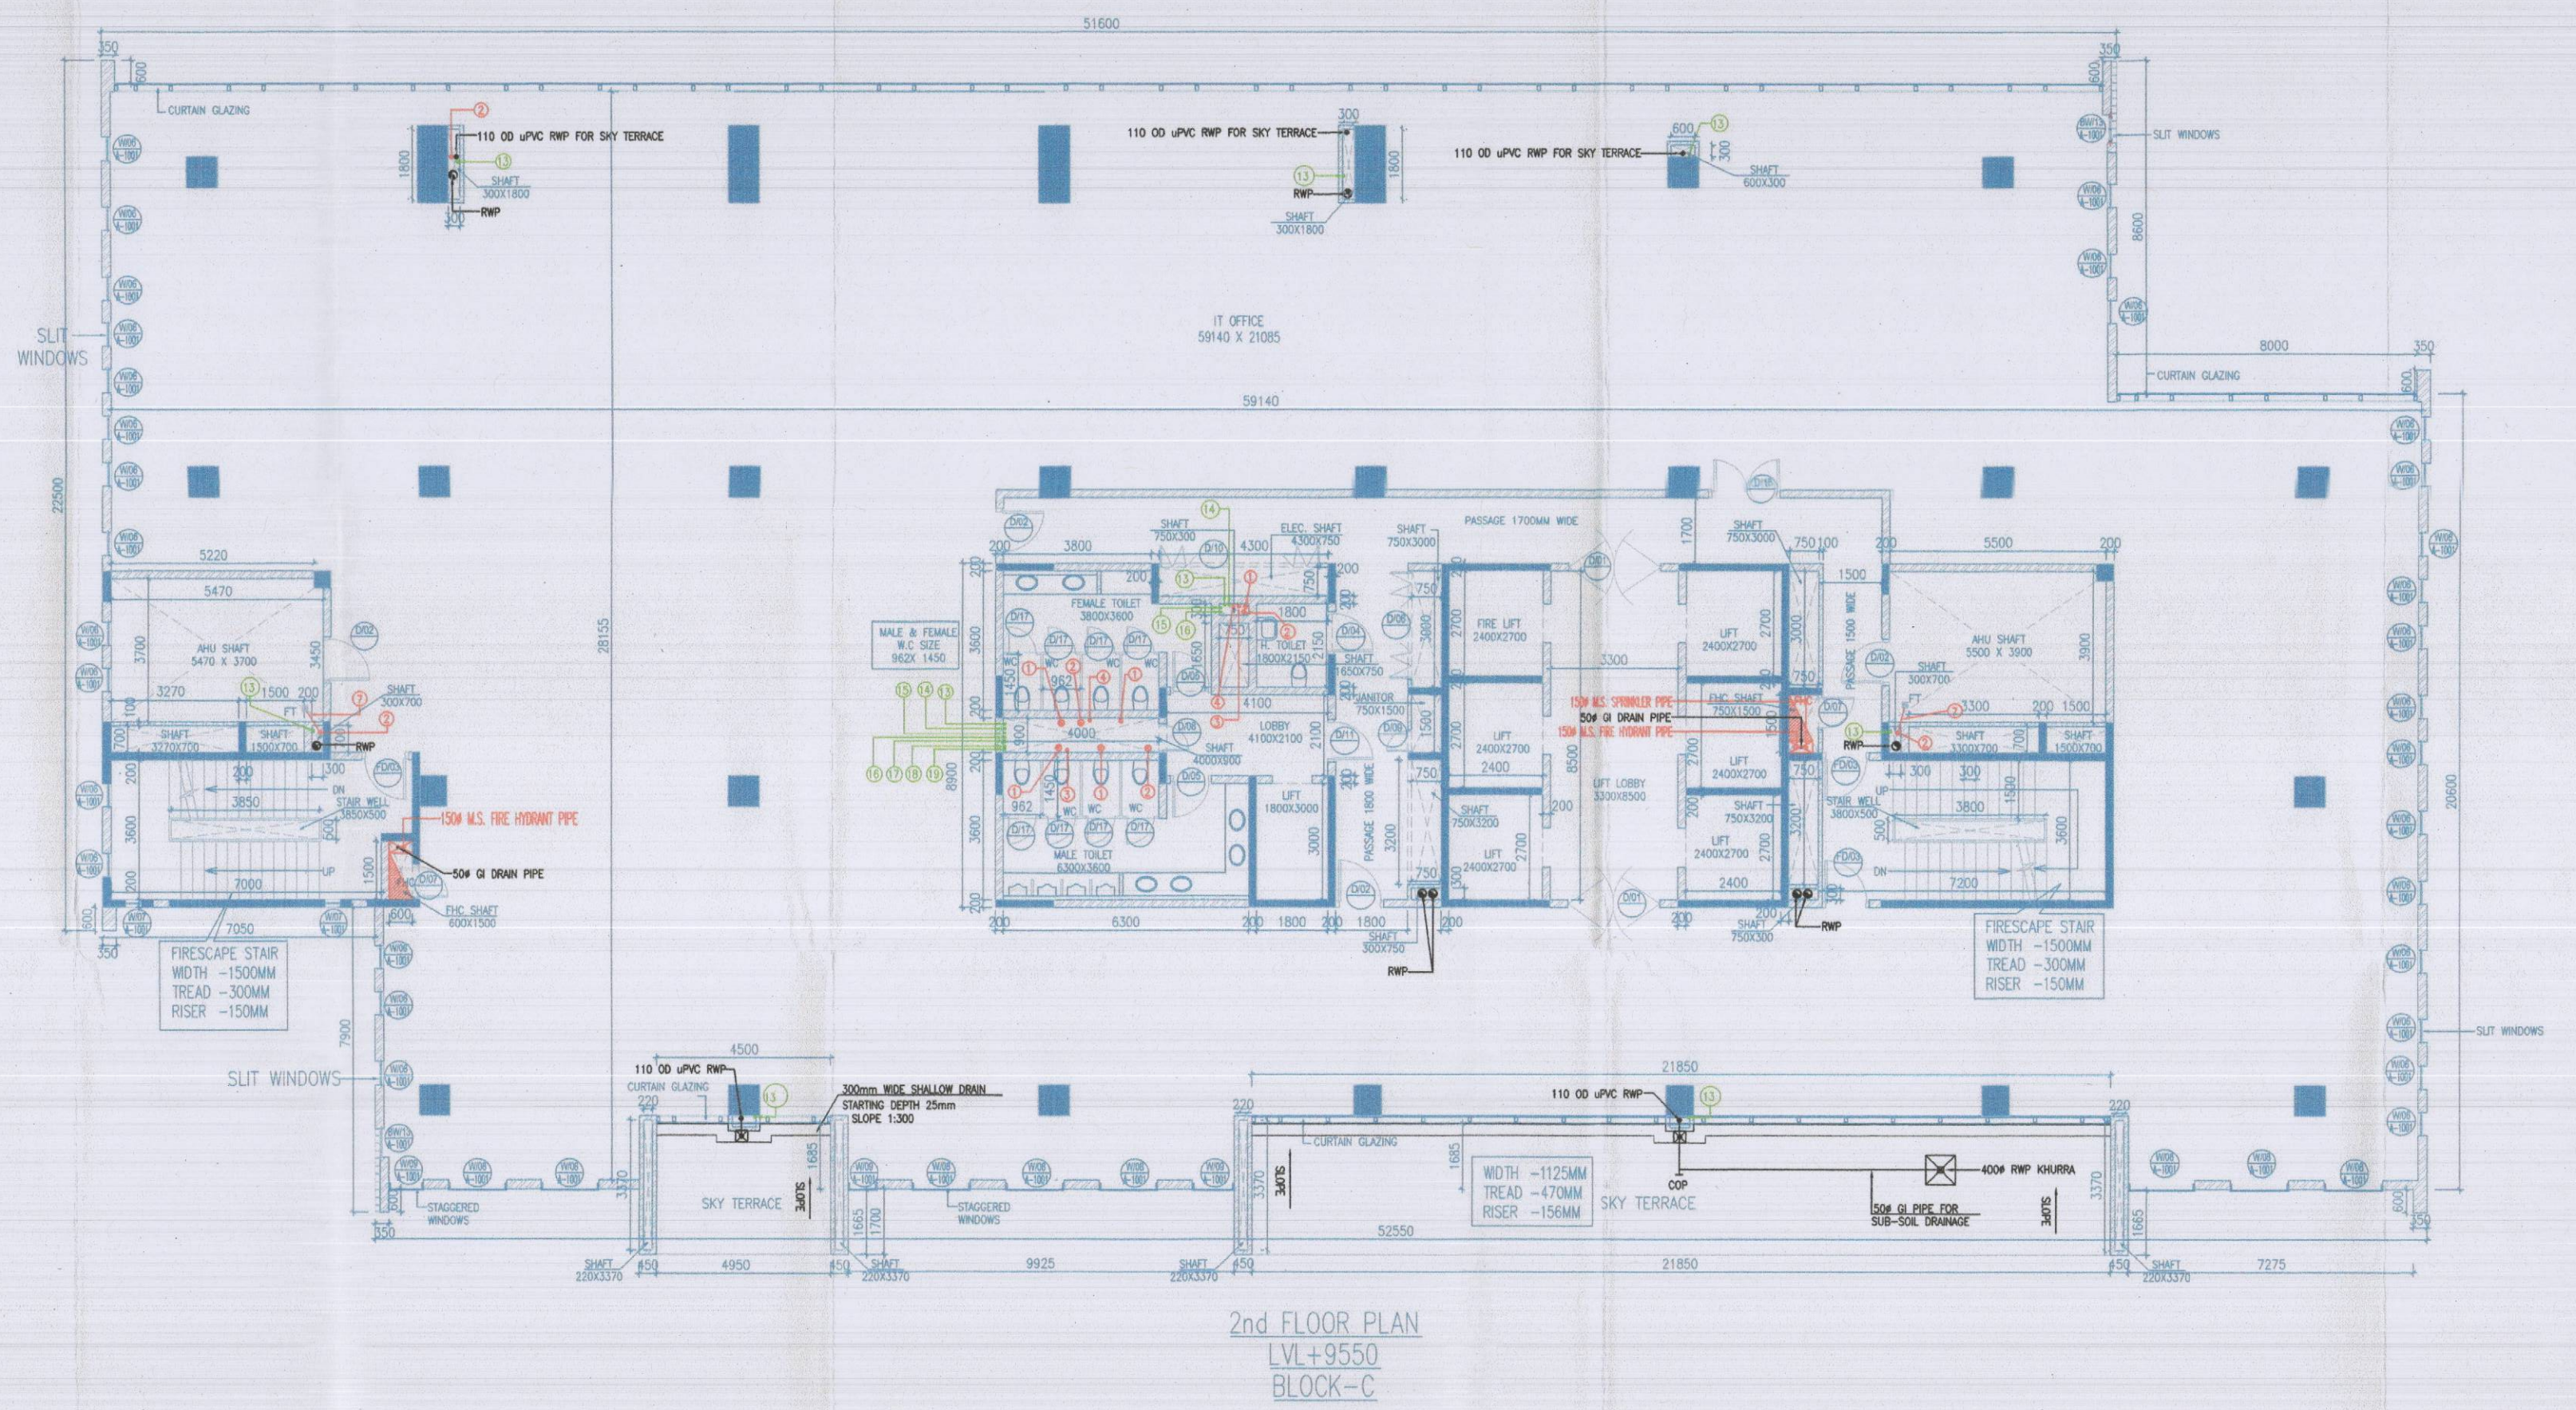

Note:-

1. BUILDING HAS AUTOMATIC SPRINKLER SYSTEM WHEREVER REQUIRED BY NBC.
2. BUILDING WILL BE DESIGNED (STRUCTURES) AS PER RELEVANT IS CODES FOR EARTHQUAKE RESISTANCE.
3. BUILDING IS ARTIFICIALLY LIGHTED MECHANICALLY VENTILATED & CENTRALLY AIRCONDITIONED.

LEGEND:-

Project:

REVISED BUILDING PLAN OF I.T. PARK MEASURING 8.793 ACRES (LICENCE NO. 1133 OF DATED 22.9.2006) IN SECTOR-27 B FARIDABAD BEING DEVELOPED BY M/S VATIKA IT PARK PVT. LTD. PREVIOUSLY KNOWN AS HIND ENTERPRISES PVT. LTD.

Associate Architects

RISMS ARCHITECTS

RSMS ARCHITECTS PVT. LTD.
69, Nara Niwas, Bhawani Kunj
(Behind D2), Vasant Kunj,
New Delhi-110070.
Tel.: 011-26898616, 26898617
www.rsms-arch.com

Checked and found ok for Public Health
(Seal) Services only subject to comments in
Working Order No. SE (HCU) 611, D-174/1-C

Sanctioning Engineer (Signature)


SANCTIONED

To be used in conjunction with
Drawing No. SE-273, D-174/1-C

For Vatika IT Park Pvt. Ltd.
Authorized Signatory

ARCHITECT'S SEAL & SIGNATURE	OWNER'S SEAL & SIGNATURE
JULY, 2012	Scale : 1:100
Drawing Title:- 2ND & 3RD FLOOR PLAN (BLOCK-C)	Drawing No:- C-02

For VATIKA LIMITED

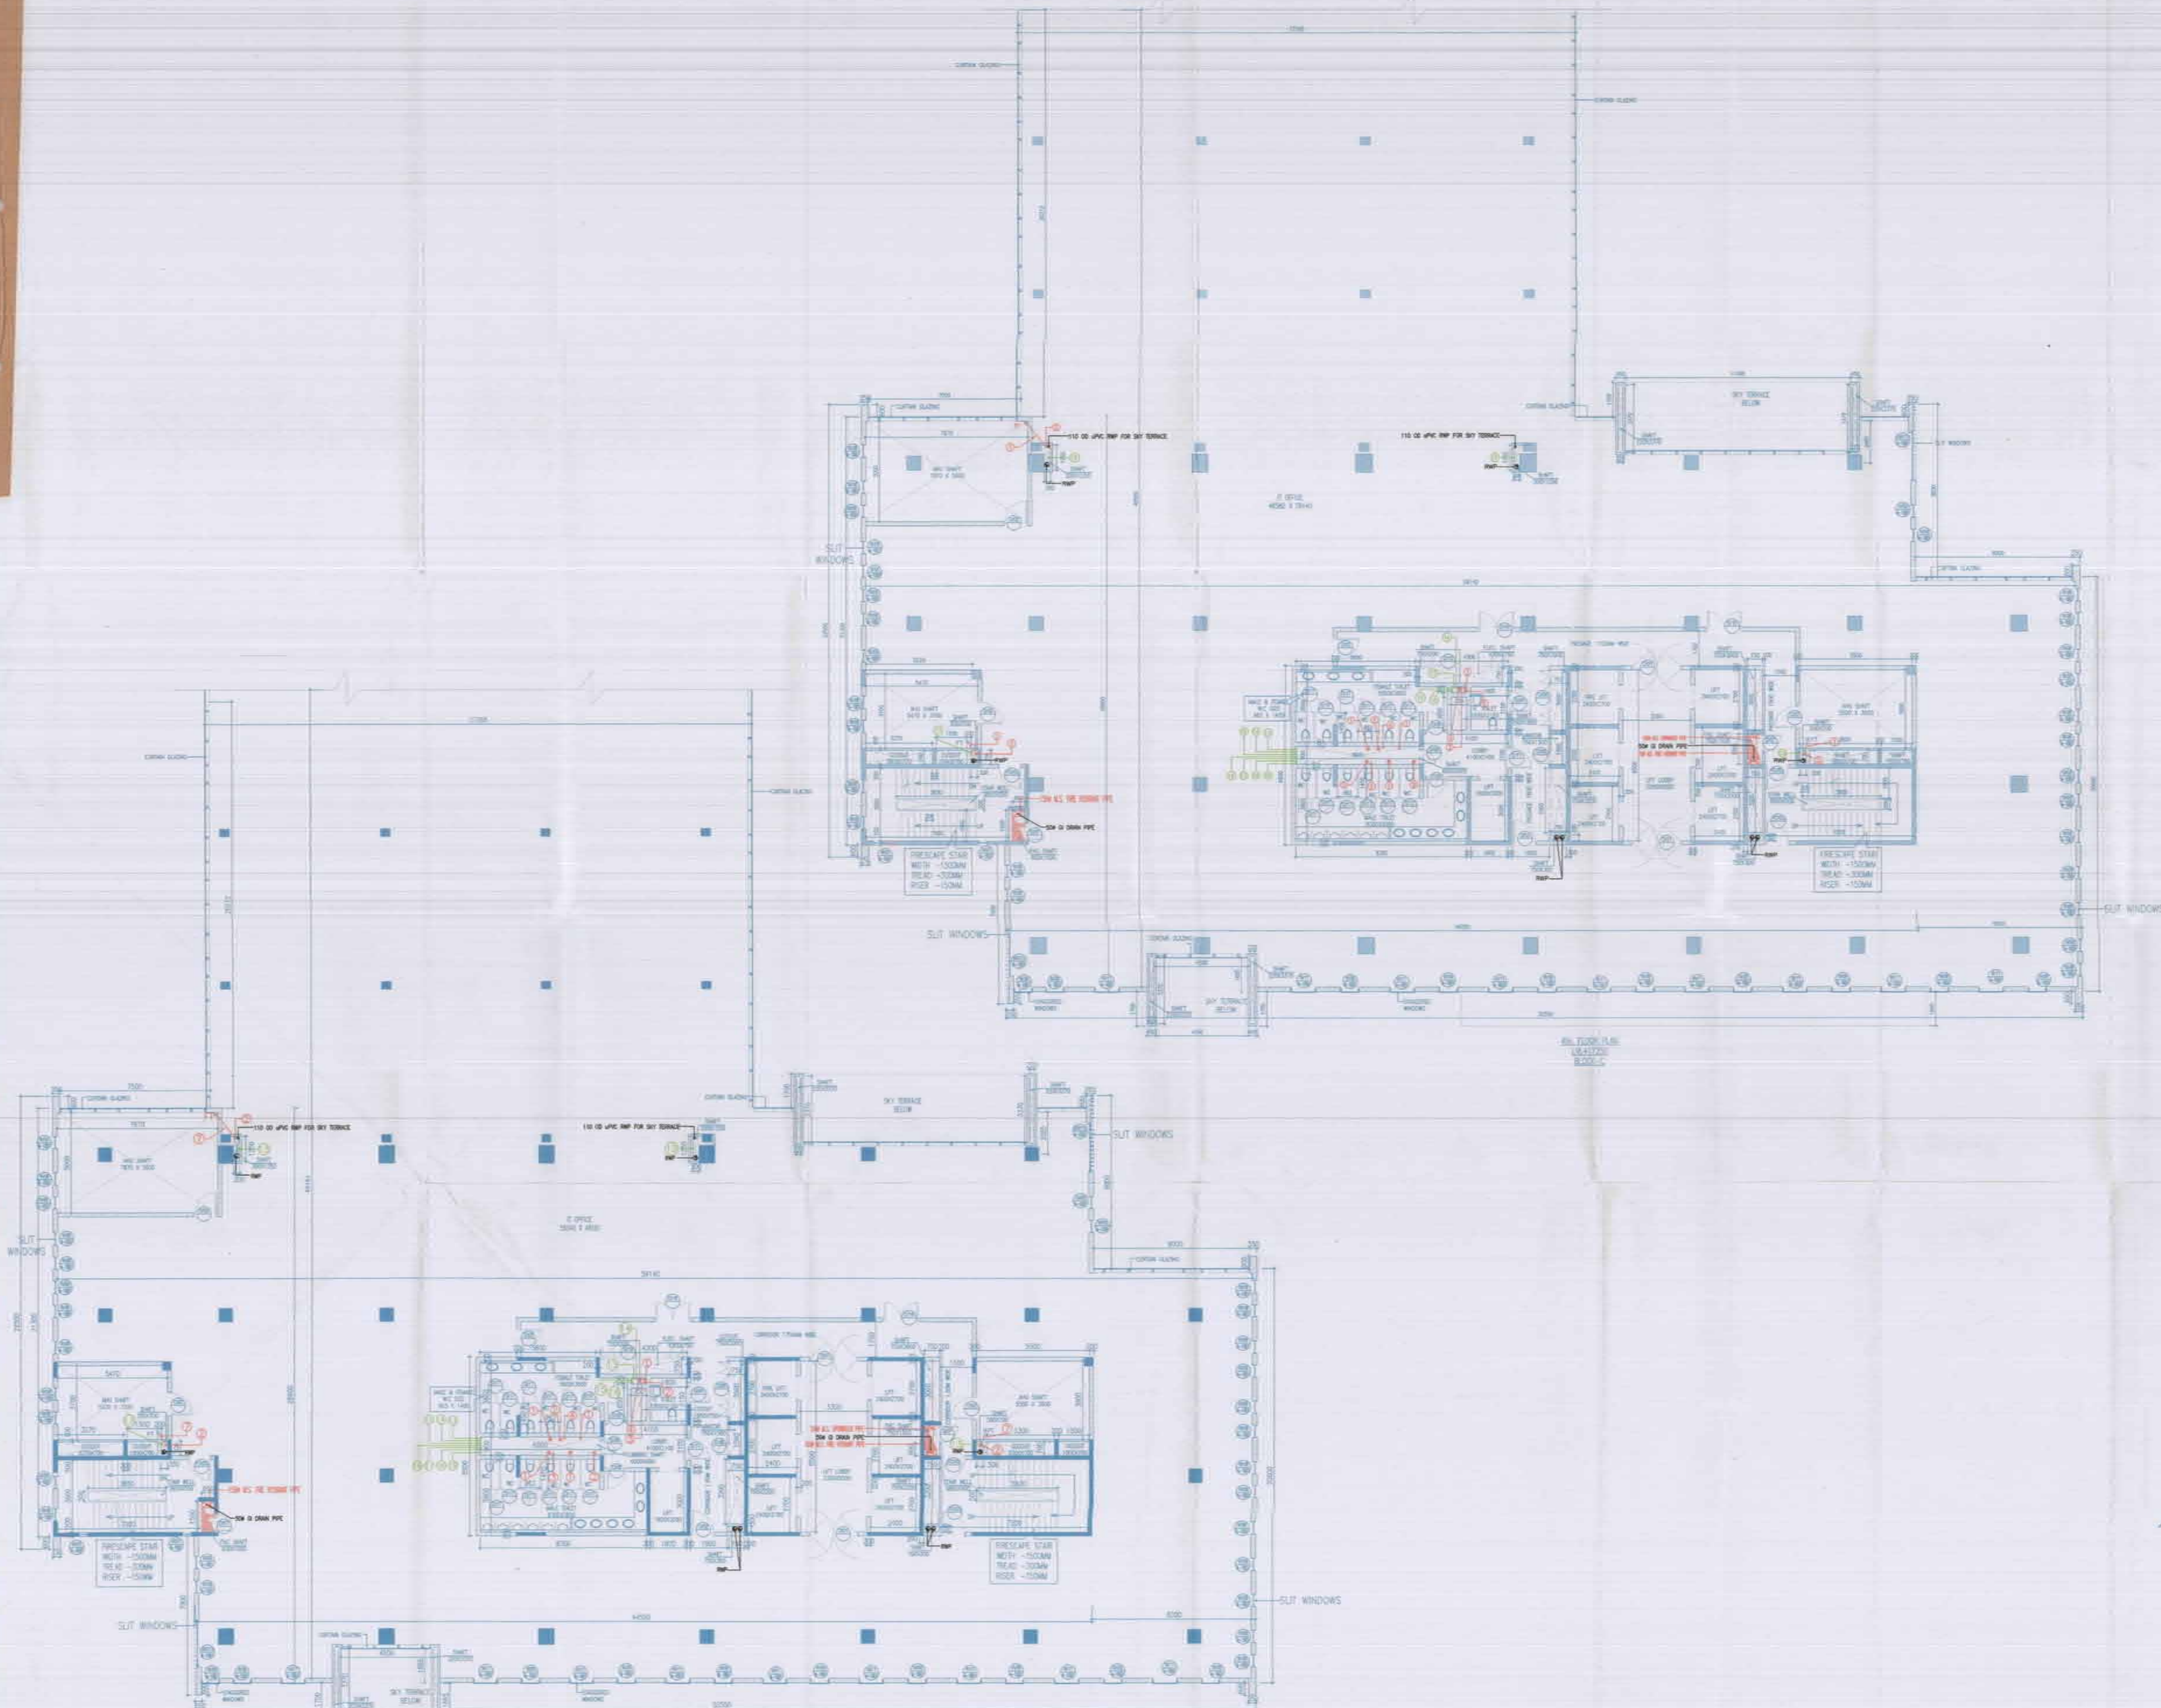

5th FLOOR PLAN
VL+21100
BLOCK-C

Note:-

1. BUILDING HAS AUTOMATIC SPRINKLER SYSTEM WHEREVER REQUIRED BY NBC.
2. BUILDING WILL BE DESIGNED (STRUCTURES) AS PER RELEVANT IS CODES FOR EARTH QUAKE RESISTANCE.
3. BUILDING IS ARTIFICIALLY LIGHTED MECHANICALLY VENTILATED & CENTRALLY AIRCONDITIONED.

LEGEND:-

- LEGEND:-**
1. 100mm SDR II VENT PIPE
 2. 150mm SDR II VENT PIPE
 3. 75mm ANTI SYPHONAGE VENT PIPE(SOLI)
 4. 75mm ANTI SYPHONAGE VENT PIPE(WASTE)
 5. 100mm SDR II VENT PIPE
 6. 100mm SDR II VENT PIPE
 7. 75mm SDR II VENT PIPE
 8. 50mm ANTI SYPHONAGE PIPE(SOLI)
 9. 50mm ANTI SYPHONAGE PIPE(WASTE)
 10. 50mm SDR II VENT PIPE
 11. 40mm SDR II VENT PIPE
 12. 32mm SDR II VENT PIPE
 13. COLD WATER SUPPLY (DOMESTIC)
 14. COLD WATER SUPPLY (DOMESTIC)
 15. COLD WATER SUPPLY (DOMESTIC)
 16. COLD WATER SUPPLY (DOMESTIC)
 17. COLD WATER SUPPLY (DOMESTIC)
 18. COLD WATER SUPPLY (DOMESTIC)
 19. COLD WATER SUPPLY (DOMESTIC)
 20. COLD WATER SUPPLY (DOMESTIC)

Project

REVISED BUILDING PLAN OF I.T. PARK MEASURING 8.793 ACRES (LICENCE NO. 1133 OF DATED 22.5.2006) IN SECTOR-27, B FARIDABAD BEING DEVELOPED BY M/S VATIKA IT PARK PVT. LTD. PREVIOUSLY KNOWN AS: HIND ENTERPRISES PVT. LTD.

Associate Architects




RSMS ARCHITECTS PVT. LTD.
69, Noida Noida Bhowani Kunj
(Behind D2), Vasant Kunj
New Delhi-110070.
Tel: 011-26898616, 26898617
www.rsms-arch.com

Approved by the Public Health
Department, Faridabad, India, subject to amendments by
the Public Health Department, Faridabad, India.

Sanctioned
By the Local Government
Faridabad, India.

ARCHITECT'S SEAL & SIGNATURE	OWNER'S SEAL & SIGNATURE
JULY 2012	Scale: 1:100
Drawing Title:- 4TH & 5TH FLOOR PLAN (BLOCK-C)	Drawing No:- C-03

For VATIKA LIMITED
Authorized Signatory

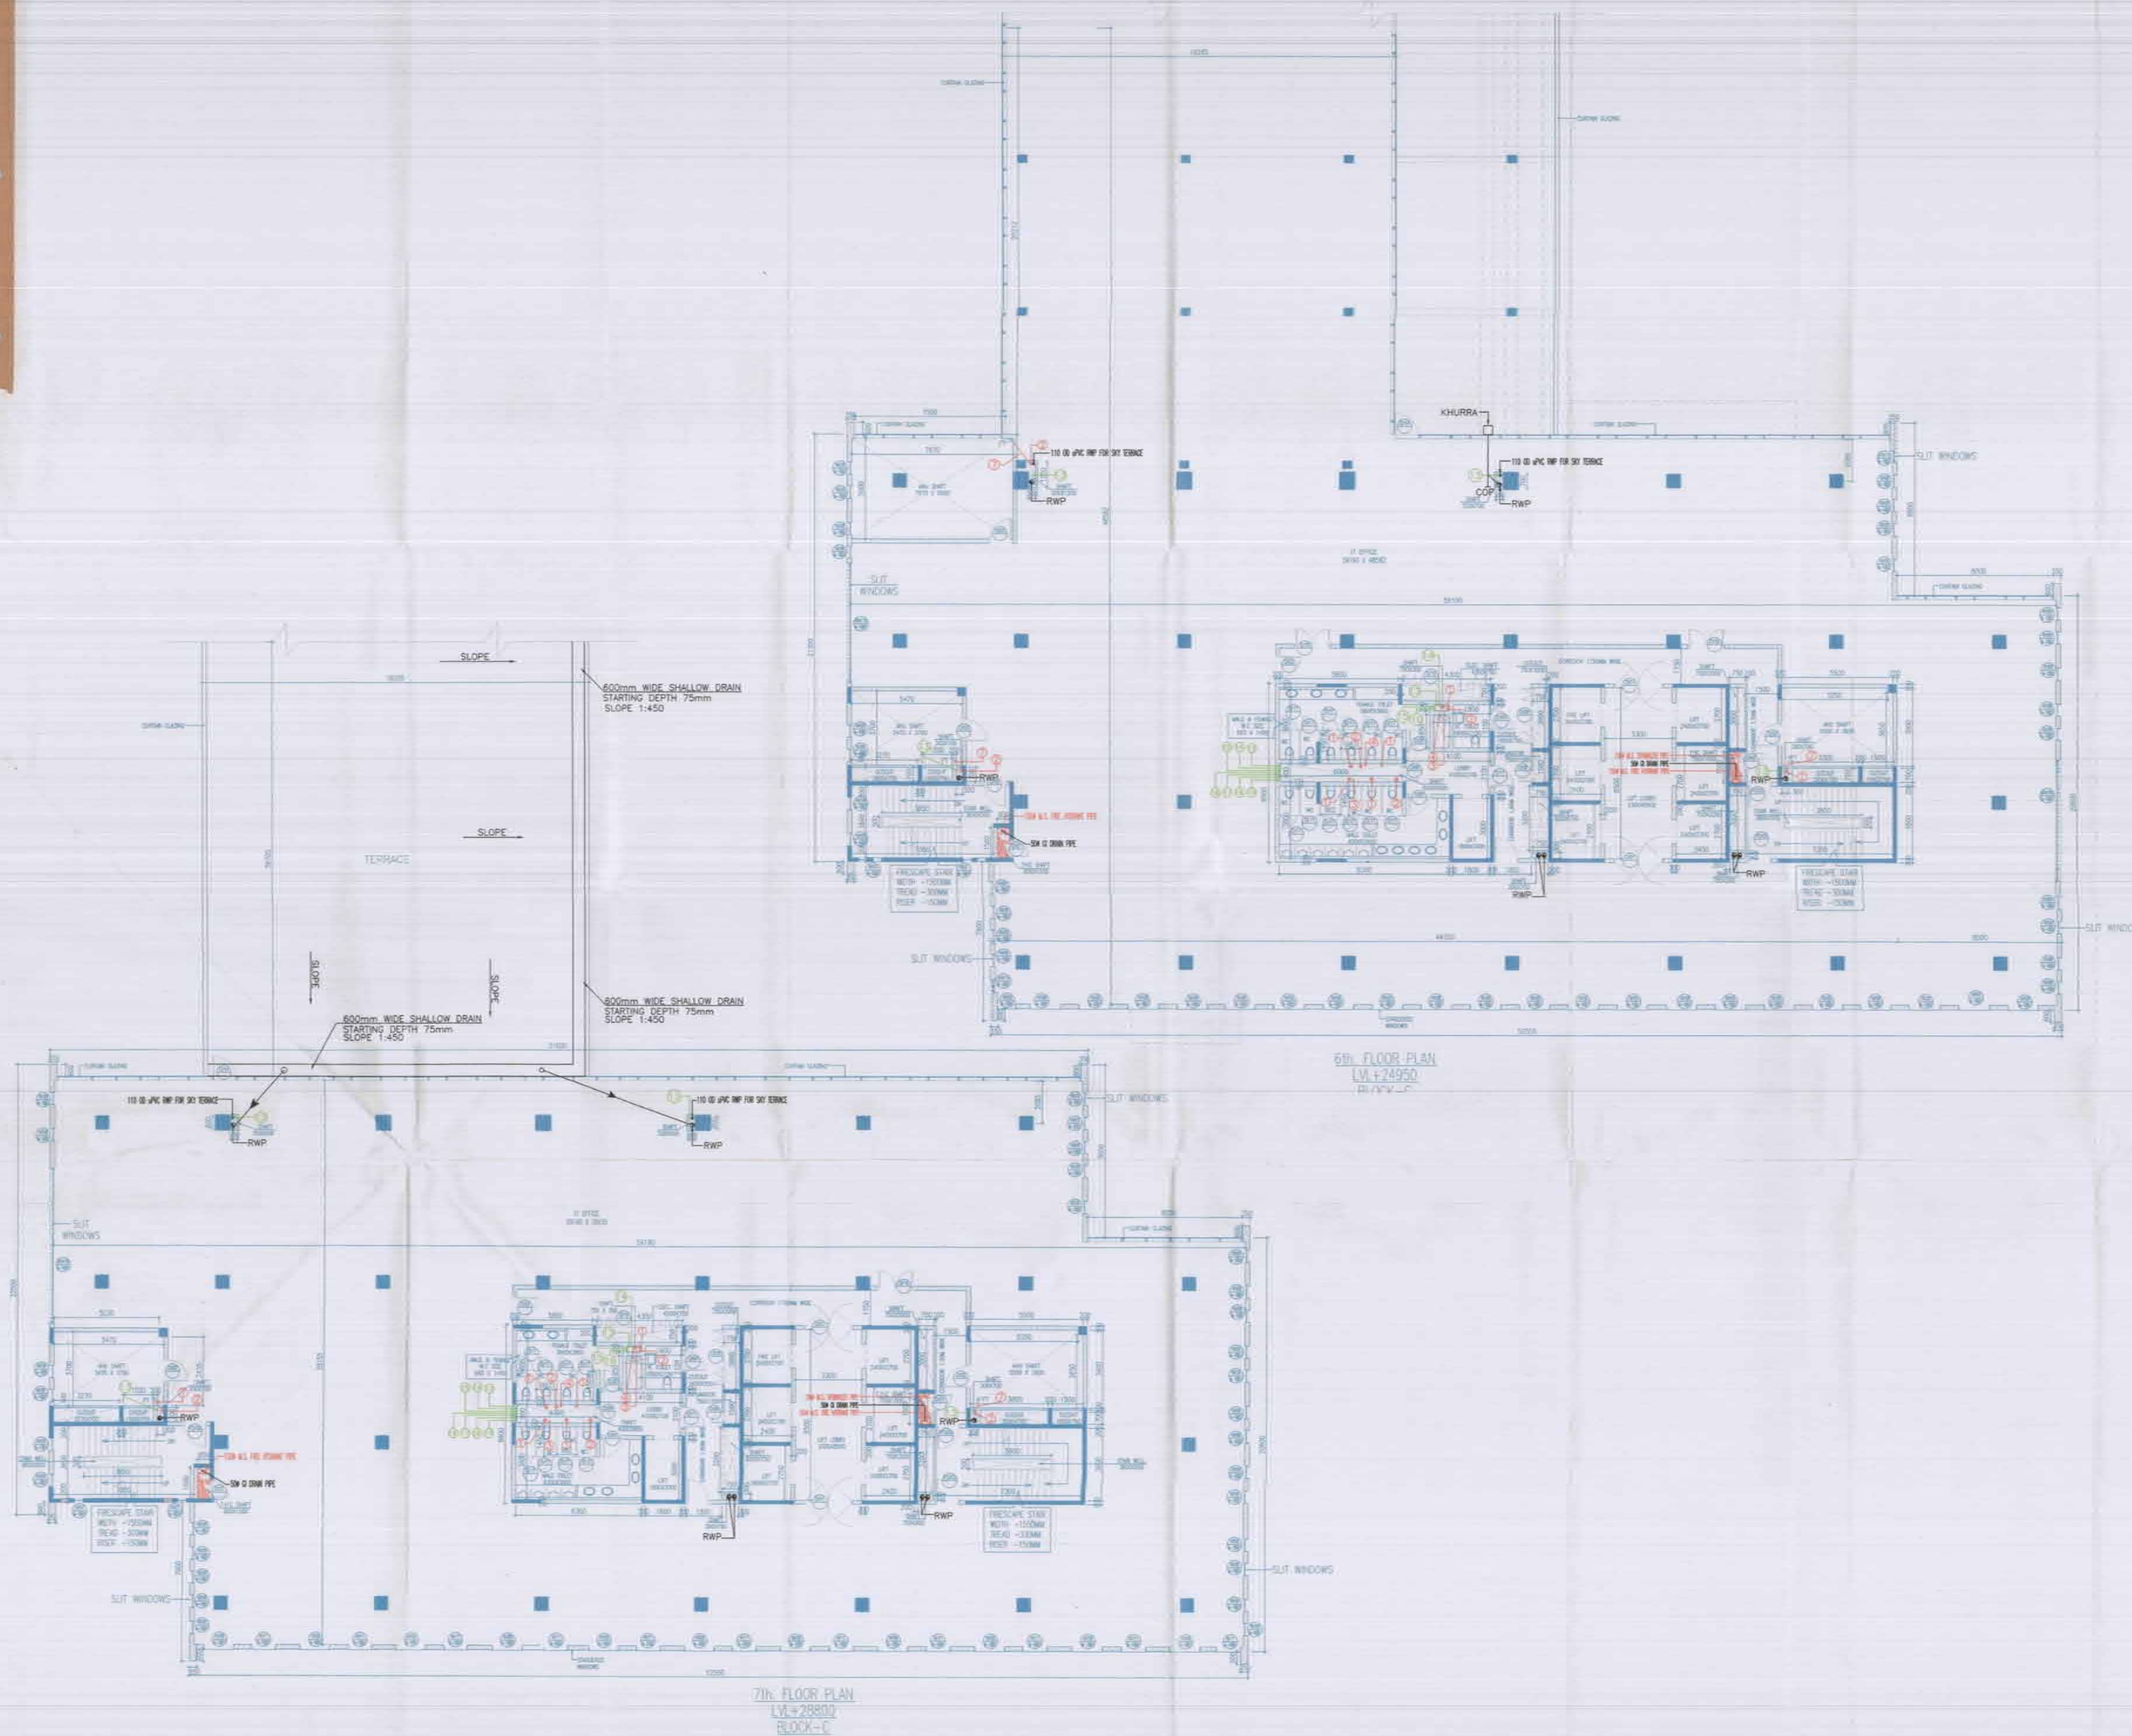

Note:-

1. BUILDING HAS AUTOMATIC SPRINKLER SYSTEM WHEREVER REQUIRED BY NRE.
2. BUILDING WILL BE DESIGNED (STRUCTURES) AS PER RELEVANT IS CODES FOR EARTHQUAKE RESISTANCE.
3. BUILDING IS ARTIFICIALLY LIGHTED MECHANICALLY VENTILATED & CENTRALLY AIR-CONDITIONED.

LEGEND:-

LEGEND:-

1. 1000 SOIL & VENT PIPE
2. 1000 WASTE & VENT PIPE
3. 750 ANTI-SYPHONAGE VENT PIPE(SOIL)
4. 750 ANTI-SYPHONAGE VENT PIPE(WASTE)
5. 1000 SOIL PIPE
6. 1000 WASTE PIPE
7. 750 WASTE PIPE
8. 500 ANTI-SYPHONAGE PIPE(SOIL)
9. 500 ANTI-SYPHONAGE PIPE(WASTE)
10. 500 WASTE PIPE
11. 400 SOIL/WASTE PIPE
12. 320 WASTE PIPE
13. COLD WATER SUPPLY(DOMESTIC) ON TAKE PIPE 1.5TH TO 7TH FLOOR
14. COLD WATER SUPPLY(DOMESTIC) ON DWE PIPE 6TH TO GROUND FLOOR
15. COLD WATER SUPPLY(FLUSHING) ON TAKE PIPE 1.5TH TO 7TH FLOOR
16. COLD WATER SUPPLY(FLUSHING) ON TAKE PIPE 6TH TO GROUND FLOOR
17. COLD WATER SUPPLY(DOMESTIC) RISER TO CHIT
18. COLD WATER SUPPLY(FLUSHING) RISER TO CHIT
19. COLD WATER SUPPLY(SOFT WATER) RISER TO CHIT

Project:

REVISED BUILDING PLAN OF I.T PARK MEASURING 5.793 ACRES (LICENCE NO. 1133 OF DATED 22.9.2006) IN SECTOR-27/B FARIDABAD BEING DEVELOPED BY M/S VATIKA IT PARK PVT. LTD. PREVIOUSLY KNOWN AS HIND ENTERPRISES PVT. LTD.

Associate Architects

RSMIS ARCHITECTS


RSMIS ARCHITECTS PVT. LTD.
69, Naga Niwas, Bhawani Kunj,
(Behind D2), Vasanti Kunj,
New Delhi-110070.
Tel. 011-26898616, 26898617
www.rsmis-arch.com

Drawings and Plans are for Public Use
Drawings and Plans are subject to correction
according to the IS 10254:2012


EXAMINED
By the local authorities
2012-11-25

ARCHITECT'S SEAL & SIGNATURE	OWNER'S SEAL & SIGNATURE
JULY 2012	Scale: 1:100
Drawing Title:-	Drawing No:-
6TH & 7TH FLOOR PLAN (BLOCK-C)	C-04

For VATIKA LIMITED

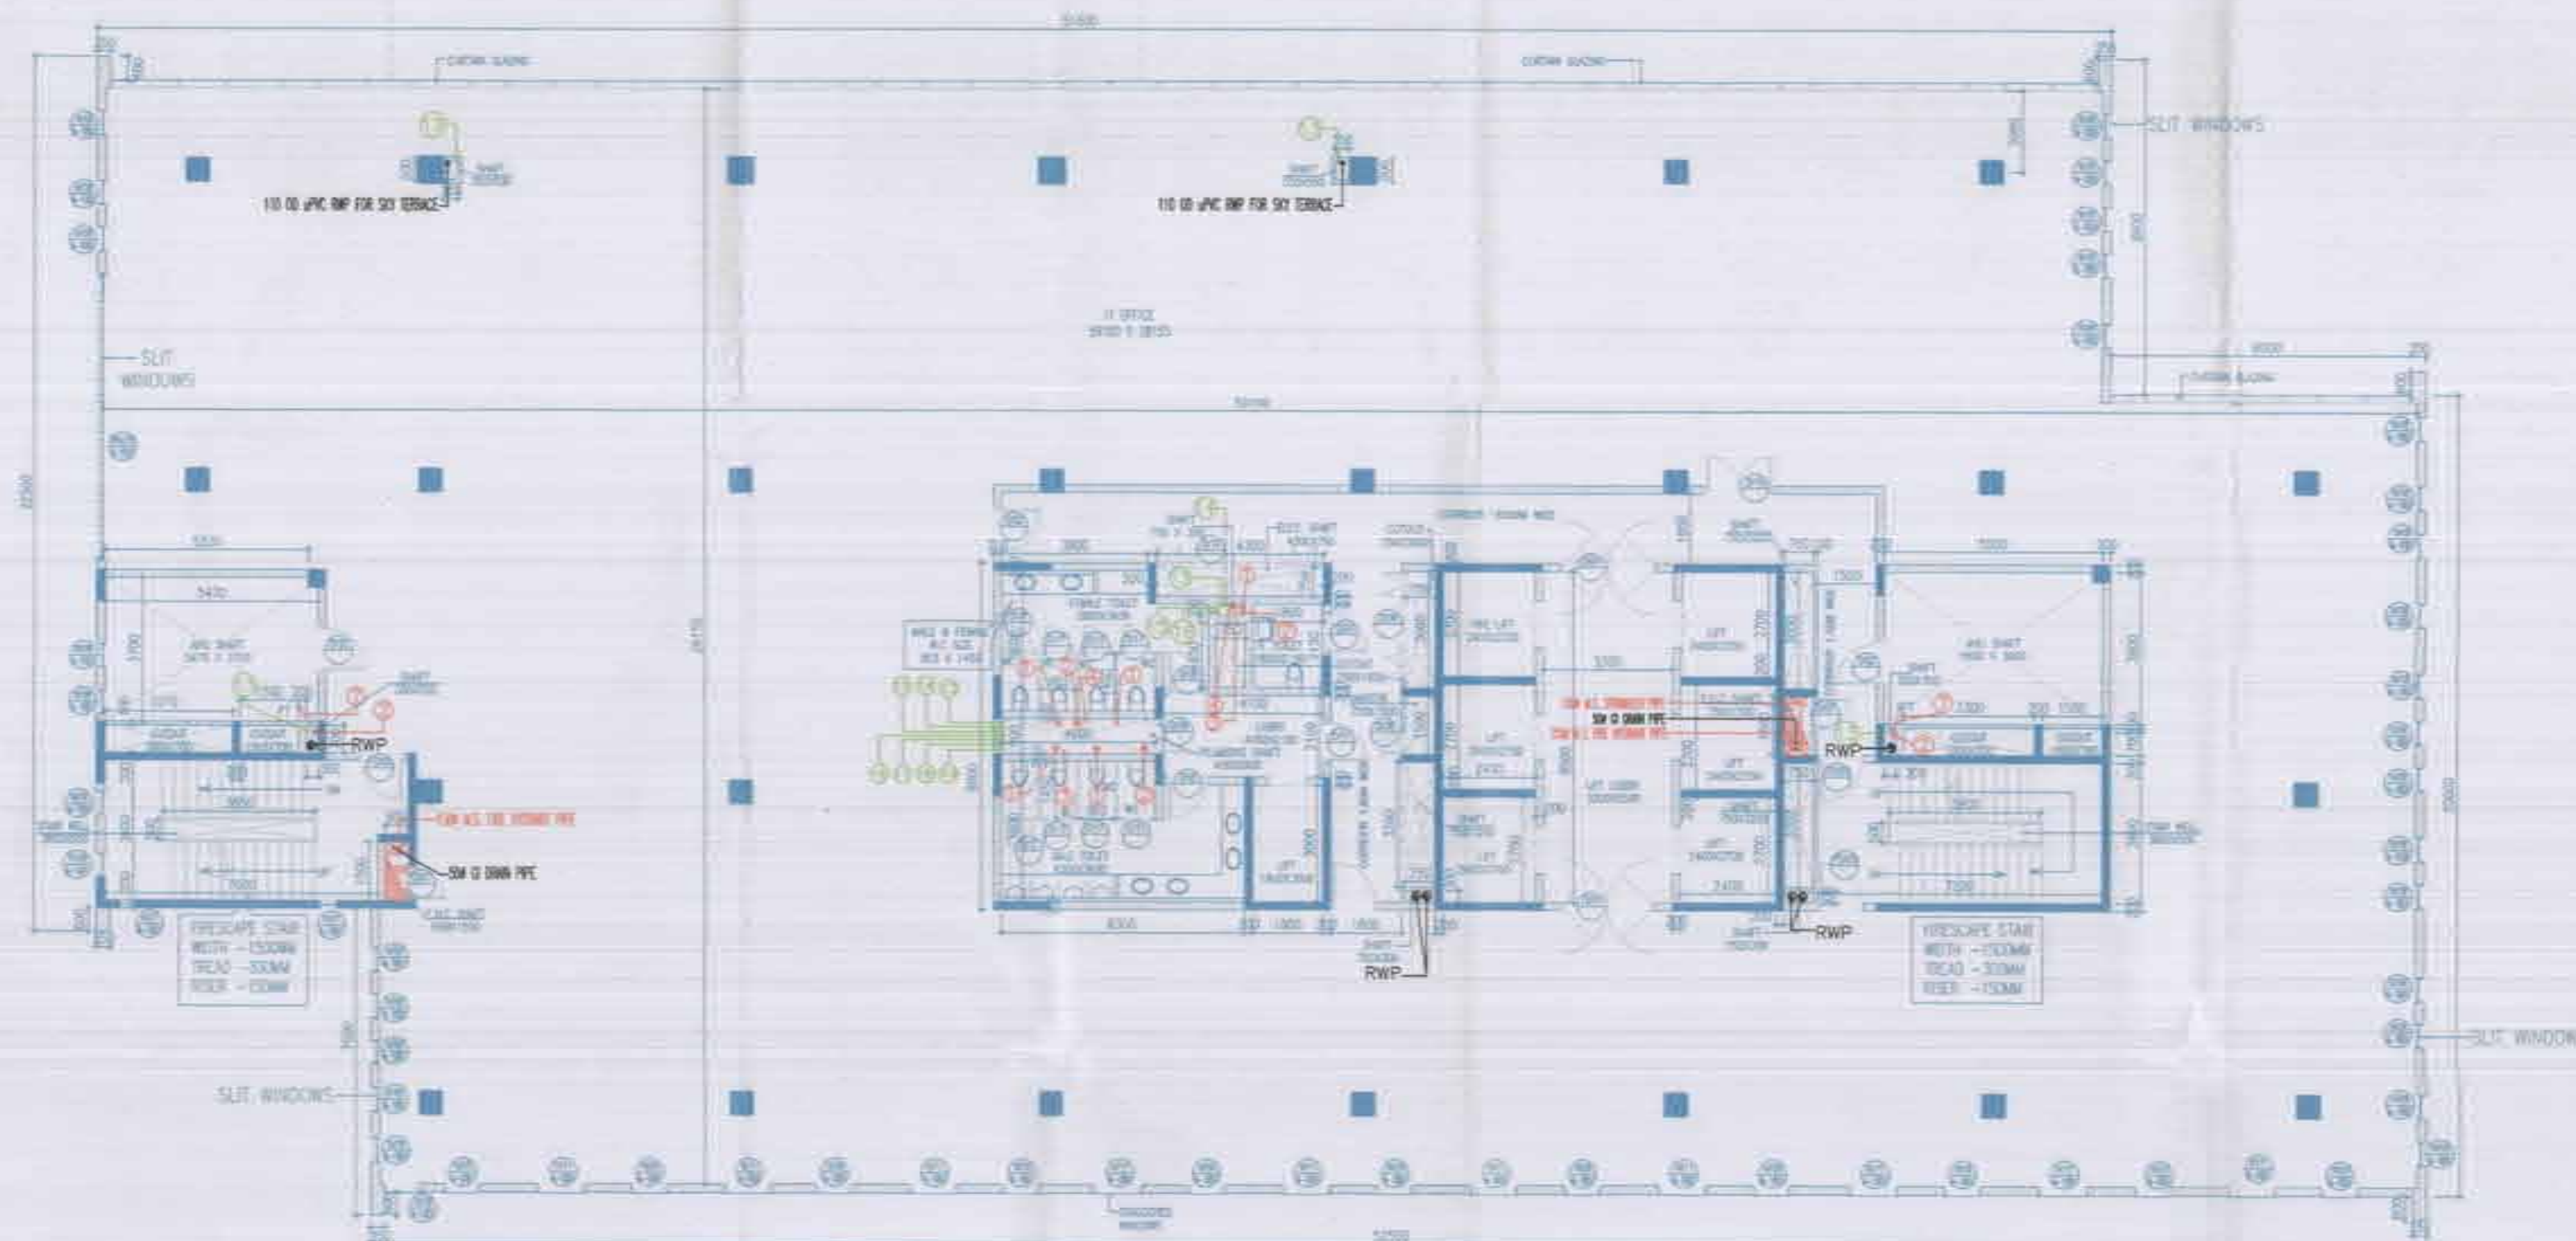

8th FLOOR PLAN
LVL + 32650
BLOCK-C

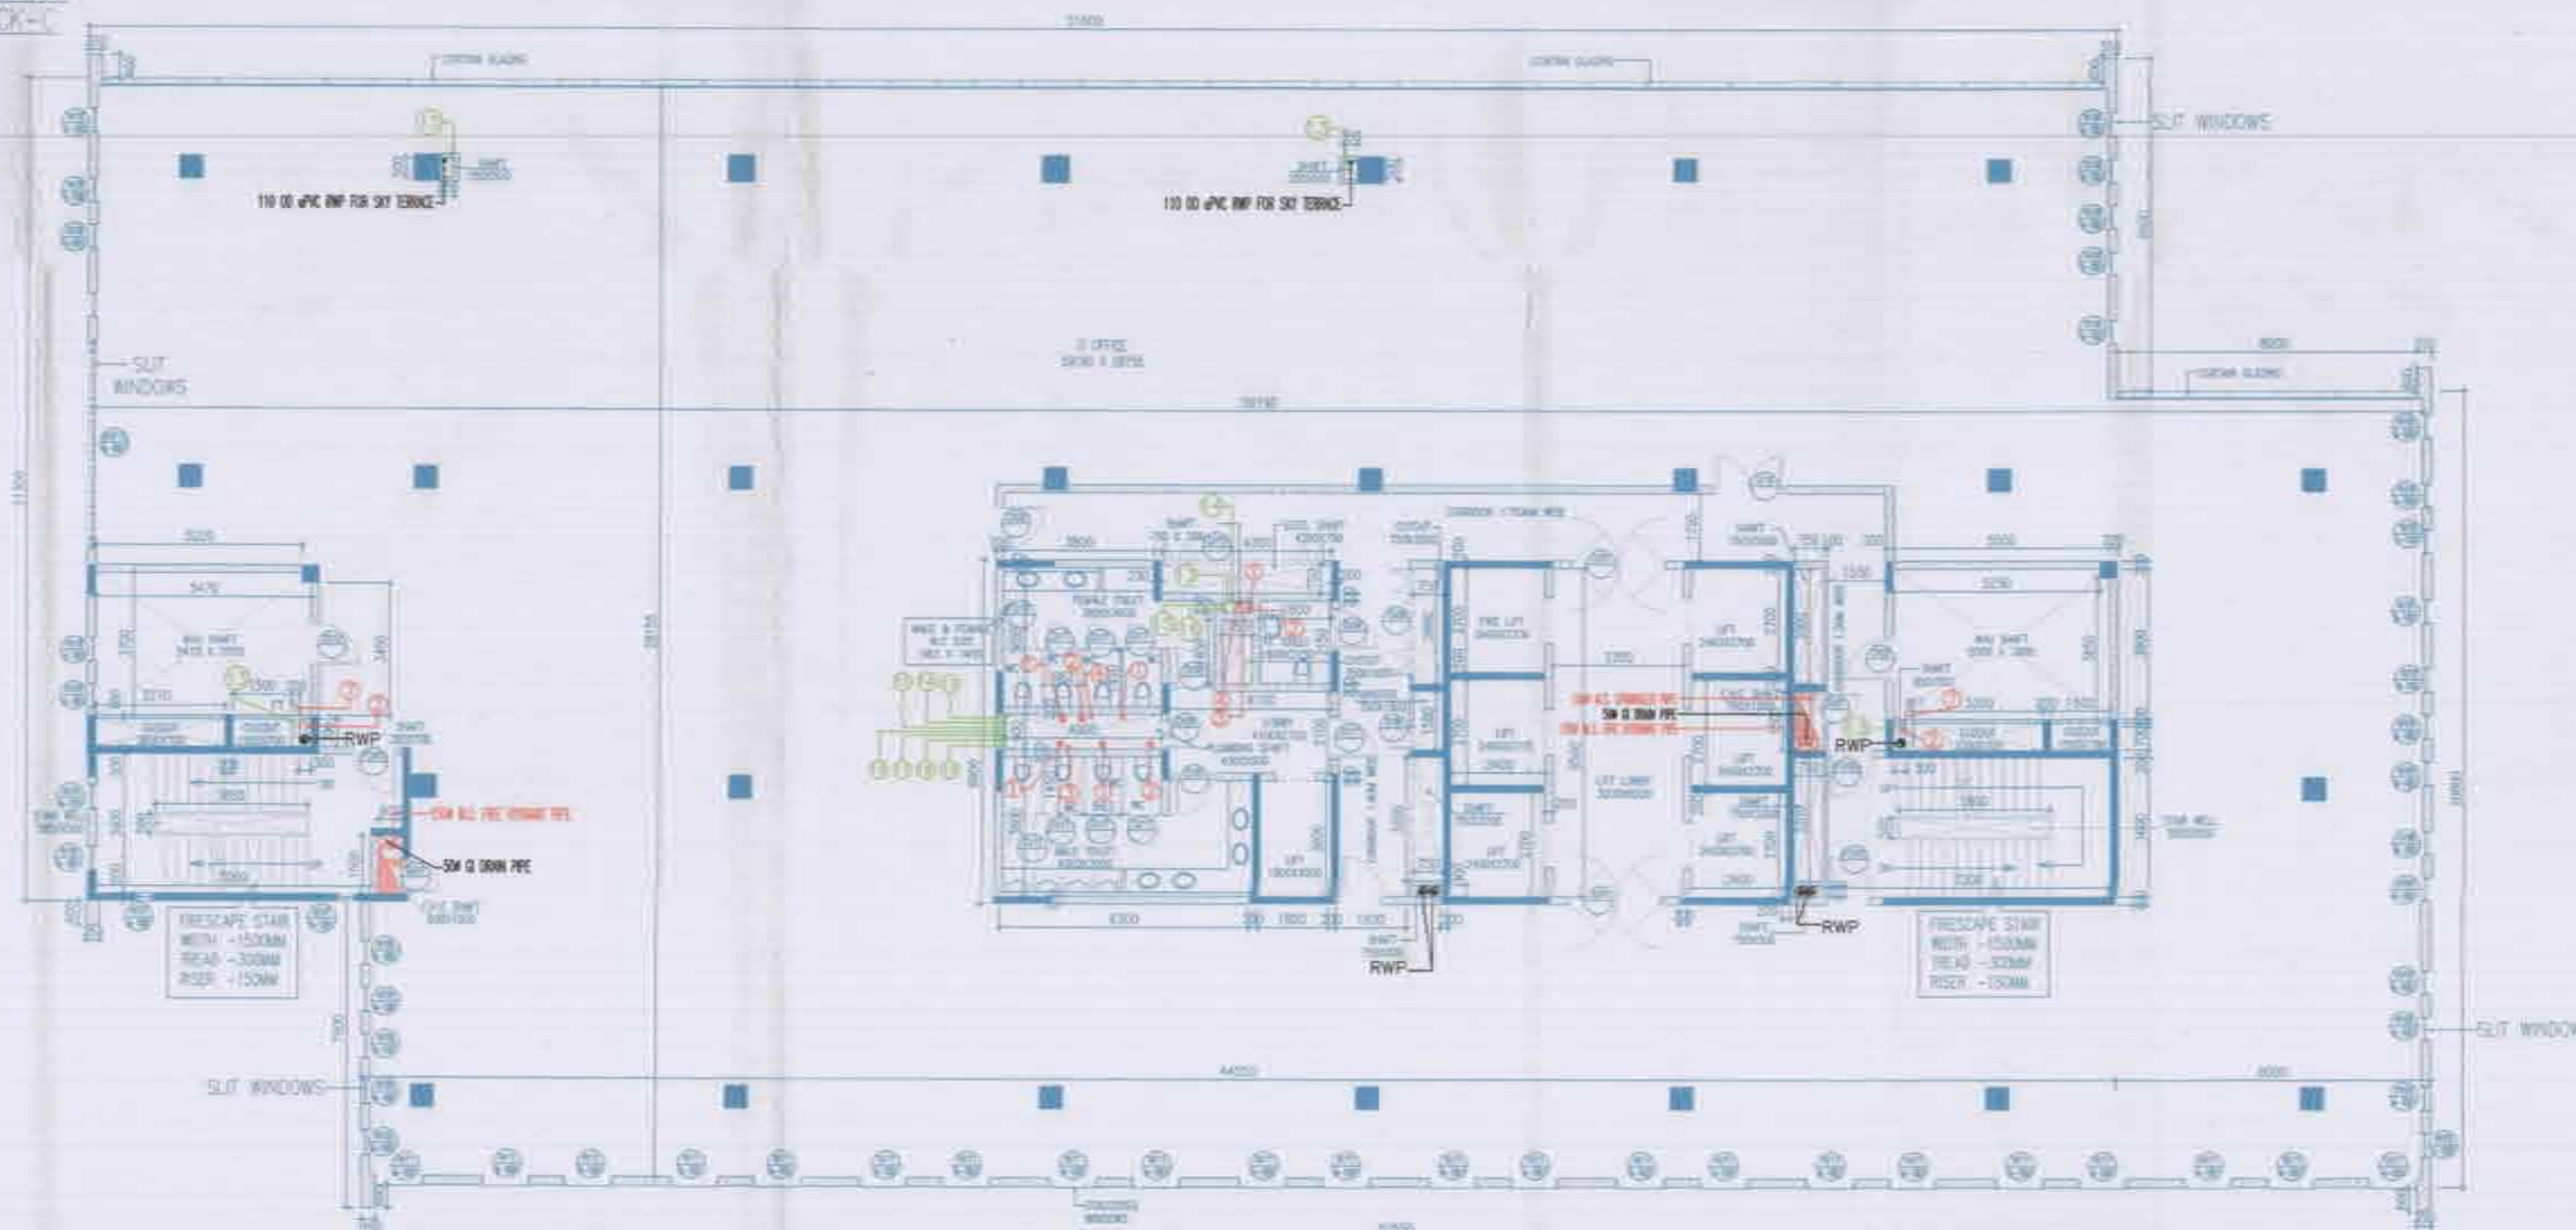

9th FLOOR PLAN
LVL + 36500
BLOCK-C

Note:-

1. BUILDING HAS AUTOMATIC SPRINKLER SYSTEM WHEREVER REQUIRED BY NBC.
2. BUILDING WILL BE DESIGNED TO STRUCTURE AS PER RELEVANT CODES FOR EARTH QUAKE RESISTANCE.
3. BUILDING IS ARTIFICIALLY LIGHTED MECHANICALLY VENTILATED & CENTRALLY AIR-CONDITIONED.

LEGEND:-

1. 100W SOL & VENT PIPE
2. 100W WASTE & VENT PIPE
3. 75W W/TH SYPHONAGE VENT PIPE(SOL)
4. 75W W/TH SYPHONAGE VENT PIPE(WASTE)
5. 100W SOL PIPE
6. 100W WASTE PIPE
7. 75W WASTE PIPE
8. 50W W/TH SYPHONAGE PIPE(SOL)
9. 50W W/TH SYPHONAGE PIPE(WASTE)
10. 50W WASTE PIPE
11. 40W SOL/WASTE PIPE
12. 30W WASTE PIPE

13. COLD WATER SUPPLY(DOMESTIC)
DN TAKE PIPE 12TH TO 2TH FLOOR
14. COLD WATER SUPPLY(DOMESTIC)
DN TAKE PIPE 6TH TO GROUND FLOOR
15. COLD WATER SUPPLY(LIGHTING)
DN TAKE PIPE 10TH TO 7TH FLOOR
16. COLD WATER SUPPLY(LIGHTING)
DN TAKE PIPE 6TH TO GROUND FLOOR
17. COLD WATER SUPPLY(DOMESTIC)
RISER TO CHT
18. COLD WATER SUPPLY(LIGHTING)
RISER TO CHT
19. COLD WATER SUPPLY(SOFT WATER)
RISER TO CHT

Project

REVISED BUILDING PLAN OF LT PARK MEASURING 8.793 ACRES (LICENCE NO. 1133 OF DATED 22.9.2006) IN SECTOR-27 B FARIDABAD BEING DEVELOPED BY M/S VATIKA IT PARK PVT. LTD. PREVIOUSLY KNOWN AS HIND ENTERPRISES PVT. LTD.

Associate Architect

R/S/M/S
ARCHITECTS

RSMS ARCHITECTS PVT. LTD.
69, Nara Niwas, Bhawani Kunj
(Behind D2), Vasant Kunj,
New Delhi-110070.
Tel: 011-26898016, 26898617
www.rsms-arch.com

Checked & Found OK for Public Notice
(General Conditions apply subject to compliance with the Act, Rules, Regulations, etc.)
Date: 22/07/12

SANCTIONED
To be submitted to the competent authority for sanctioning.
Date: 22/07/12

ARCHITECT'S SEAL & SIGNATURE
OWNER'S SEAL & SIGNATURE
For Vatika IT Park Pvt. Ltd.
Authorized Signatory

JULY, 2012 Scale: 1:100
Drawing Title:-
8TH & 9TH FLOOR PLAN (BLOCK-C)
Drawing No:-
C-05

For VATIKA LIMITED

Authorized Signatory