




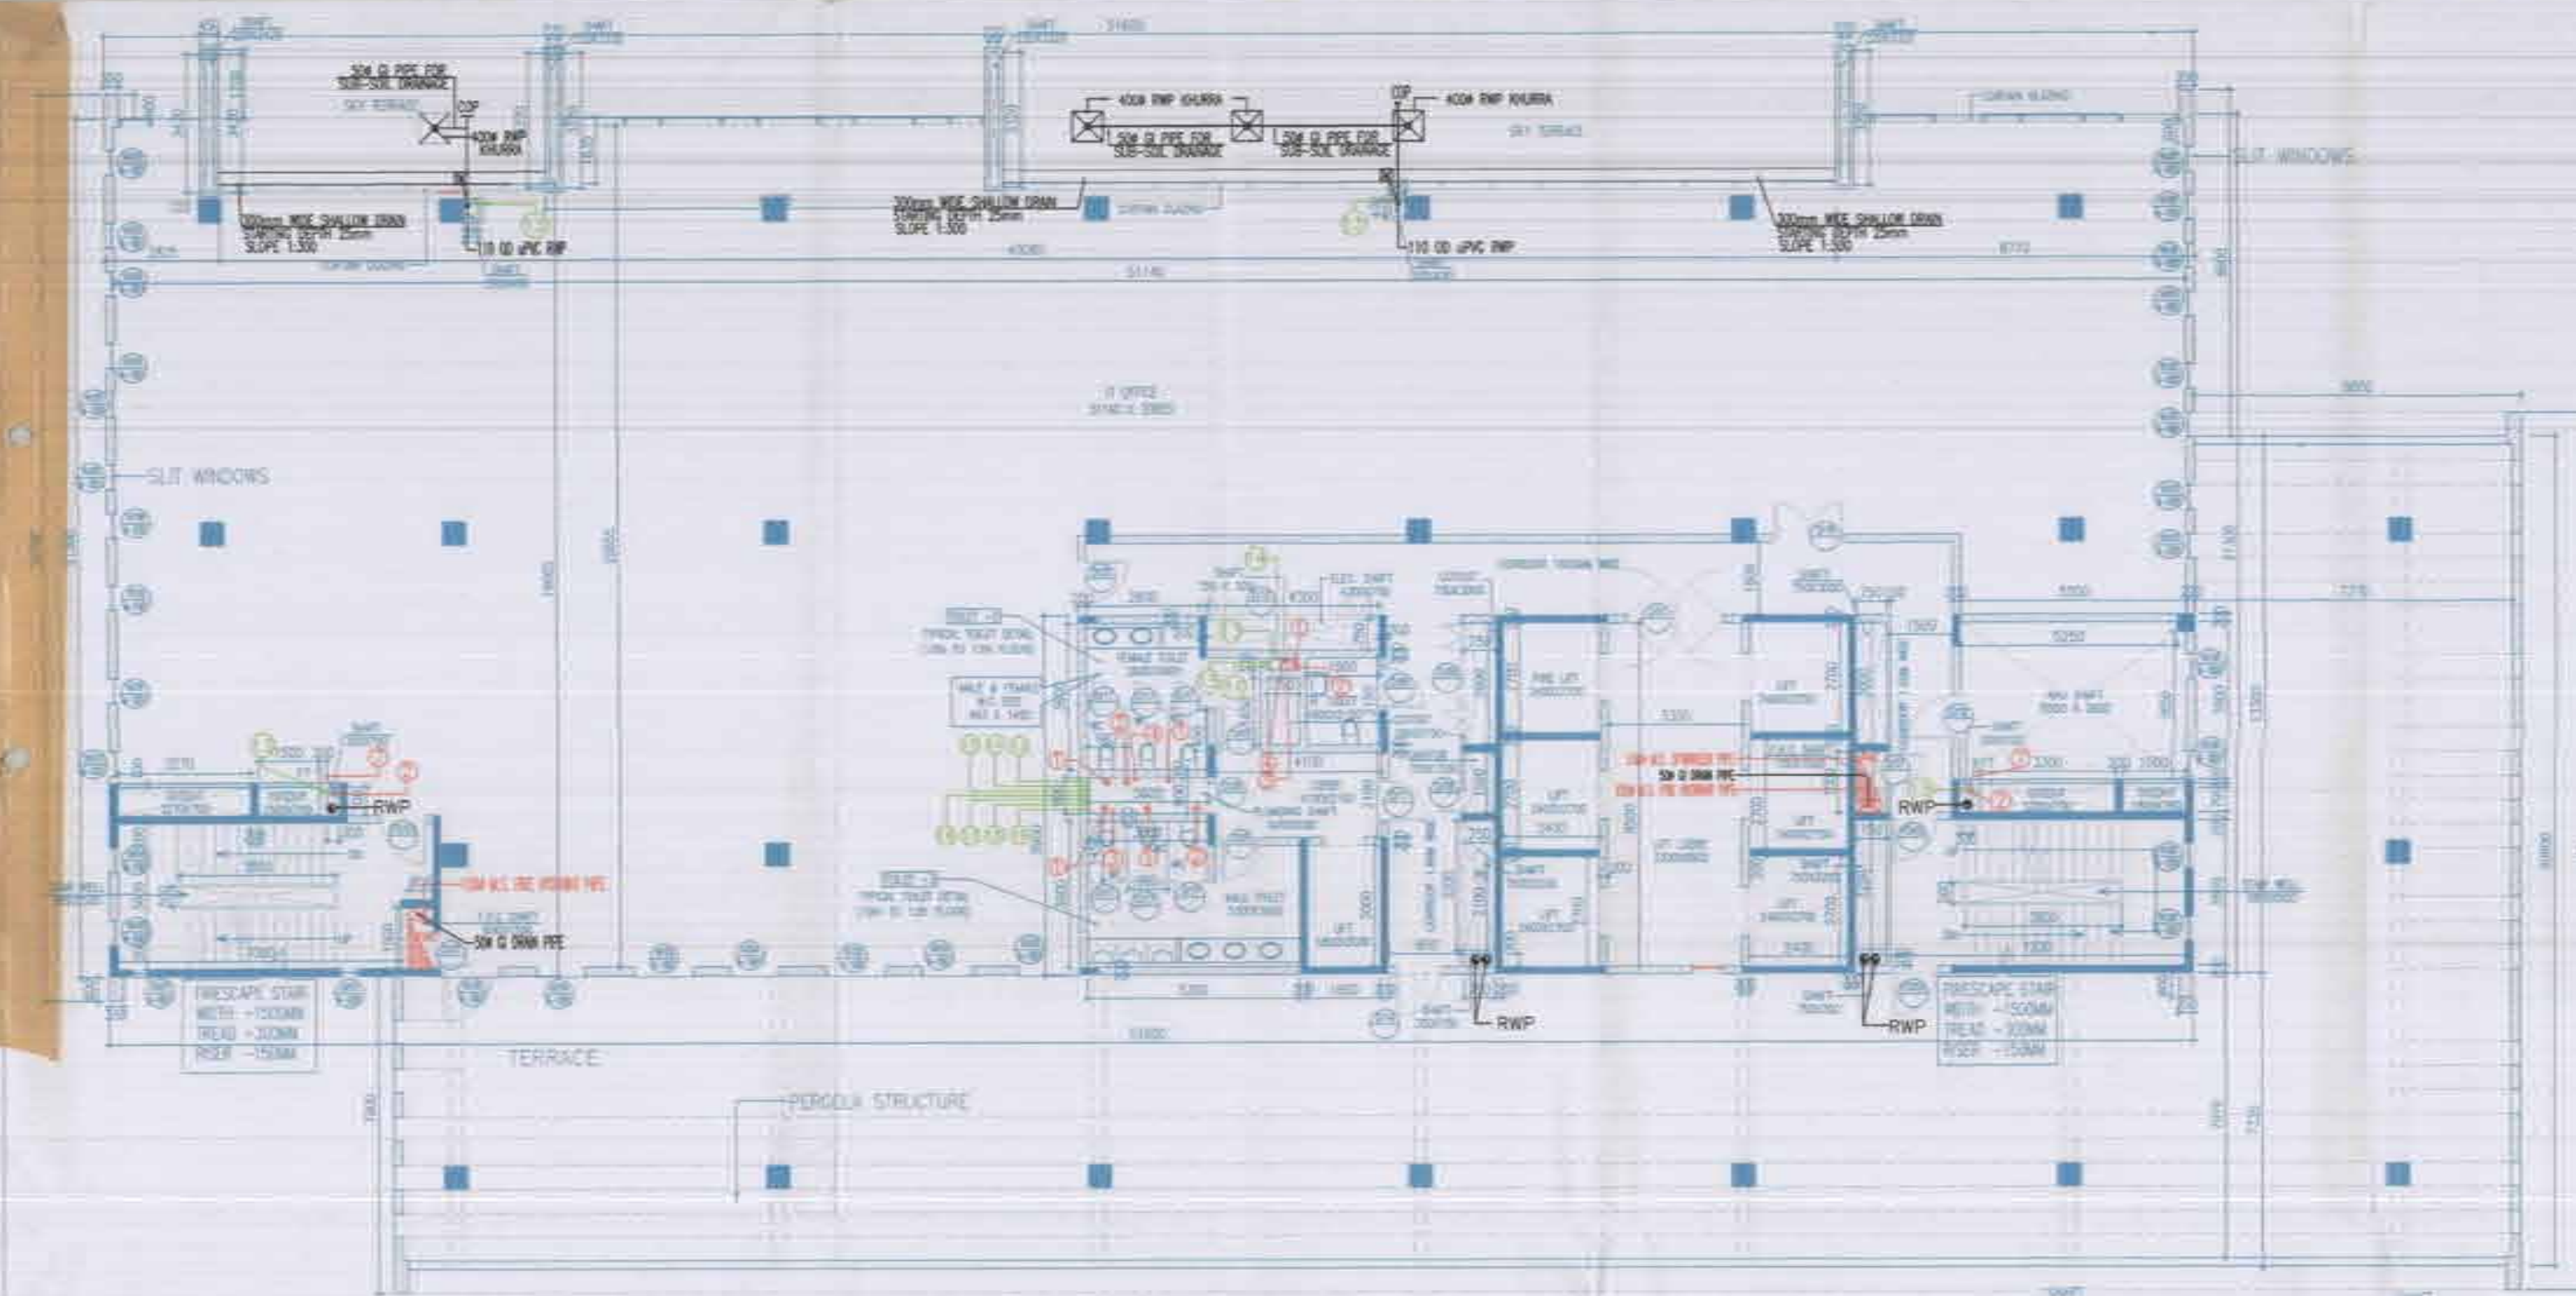

10th FLOOR PLAN
LVL+40250
BLOCK-C

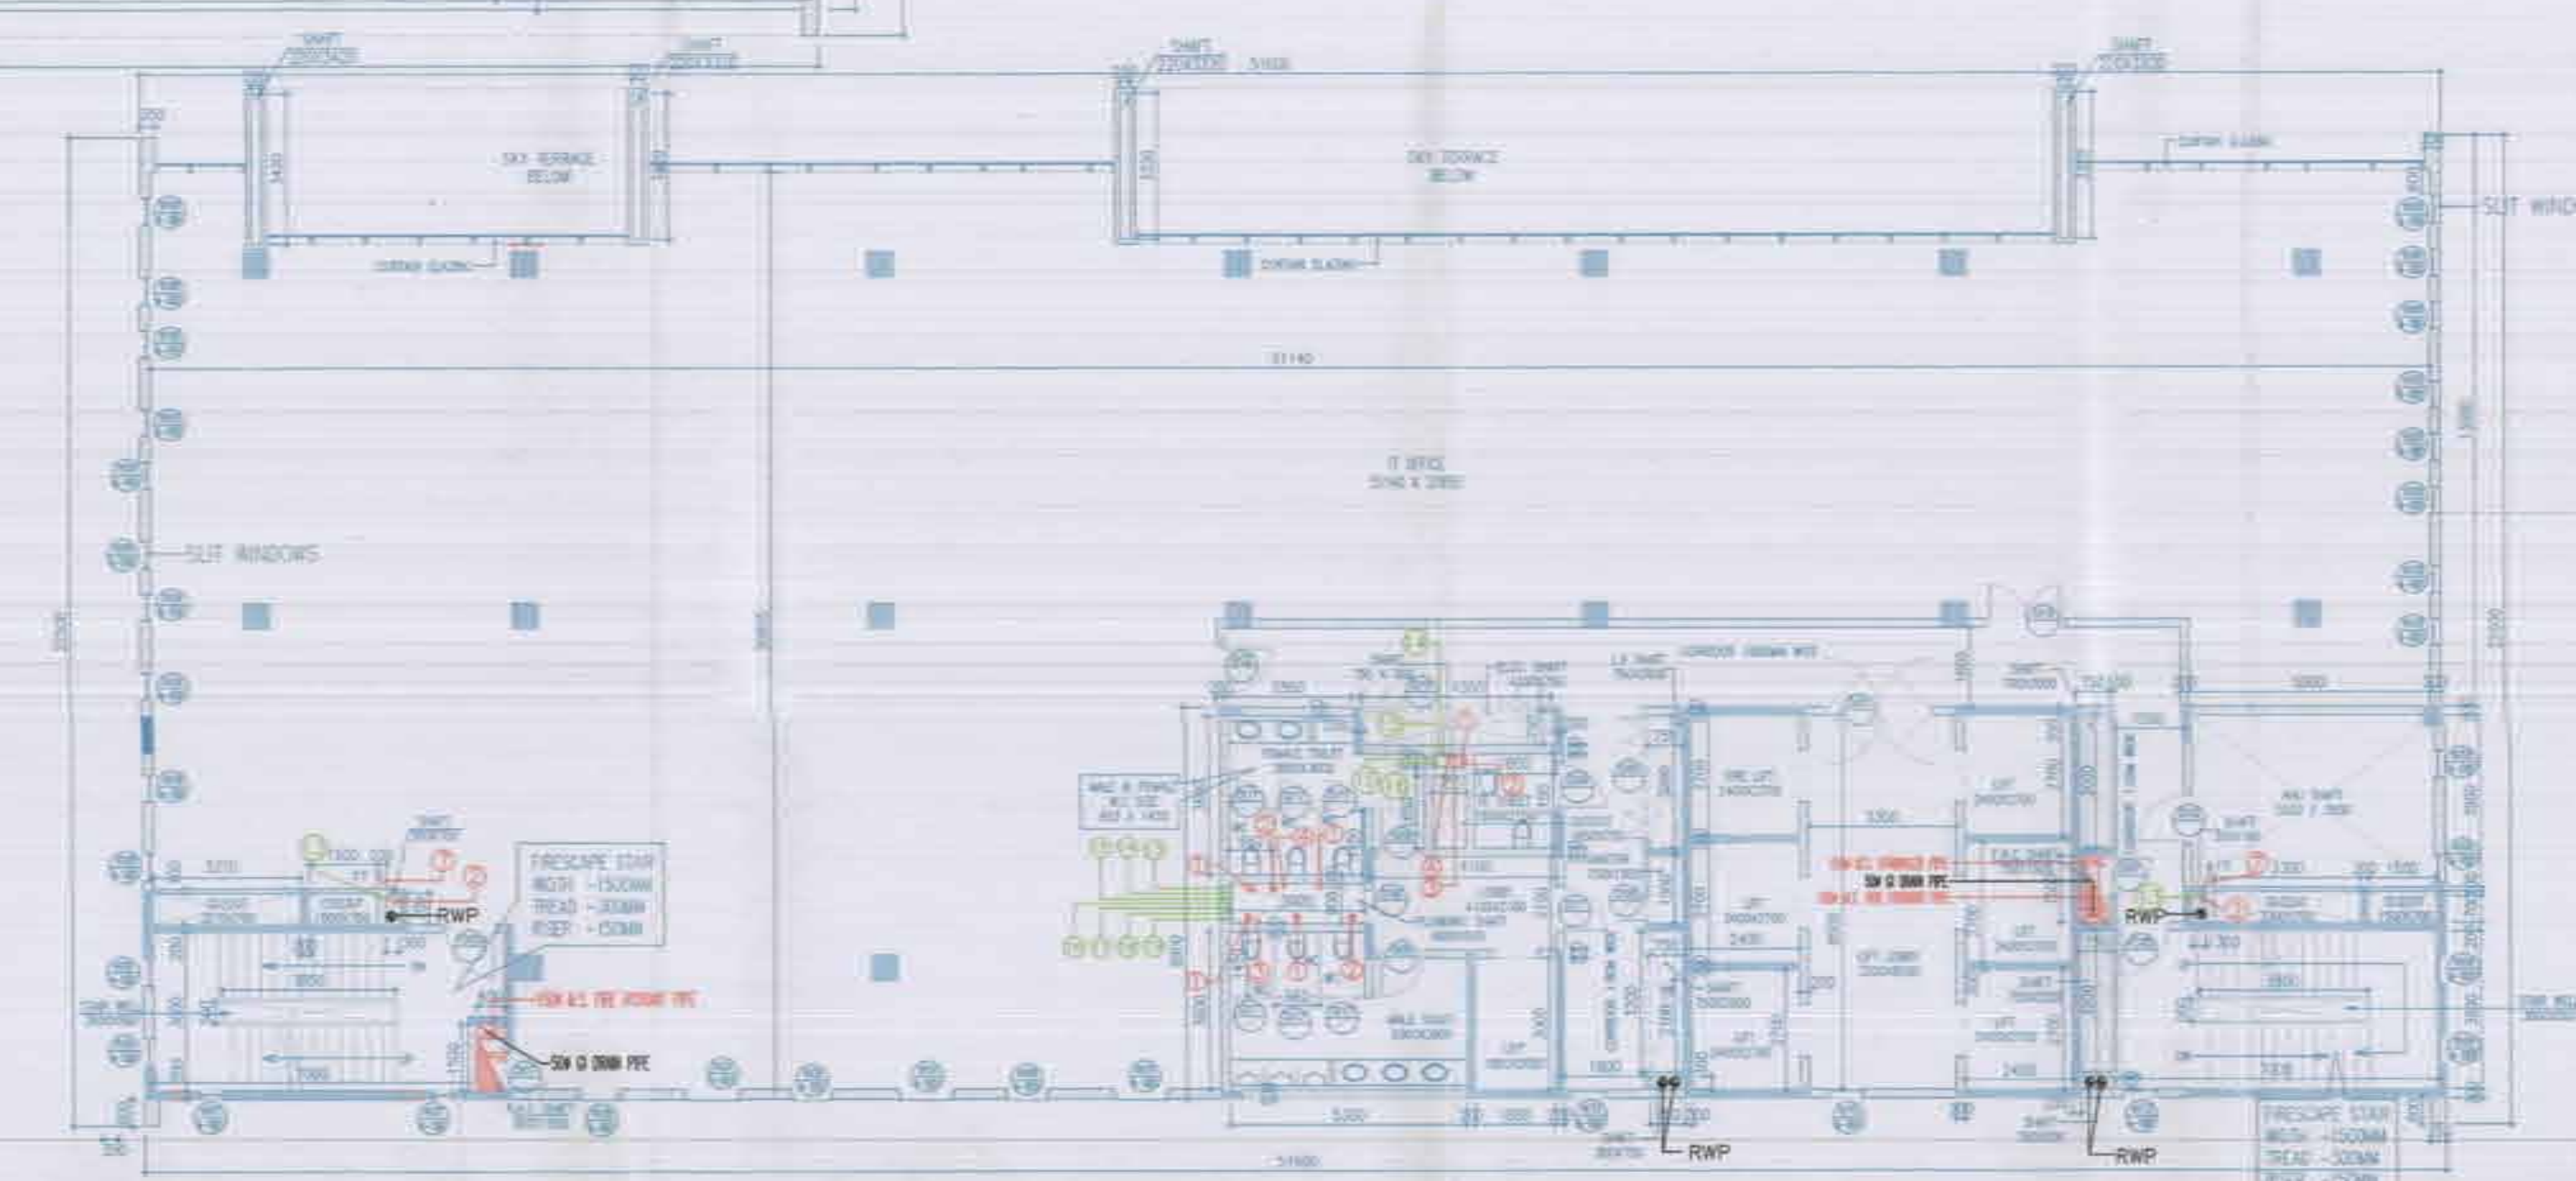

11th FLOOR PLAN
LVL+41200
BLOCK-C

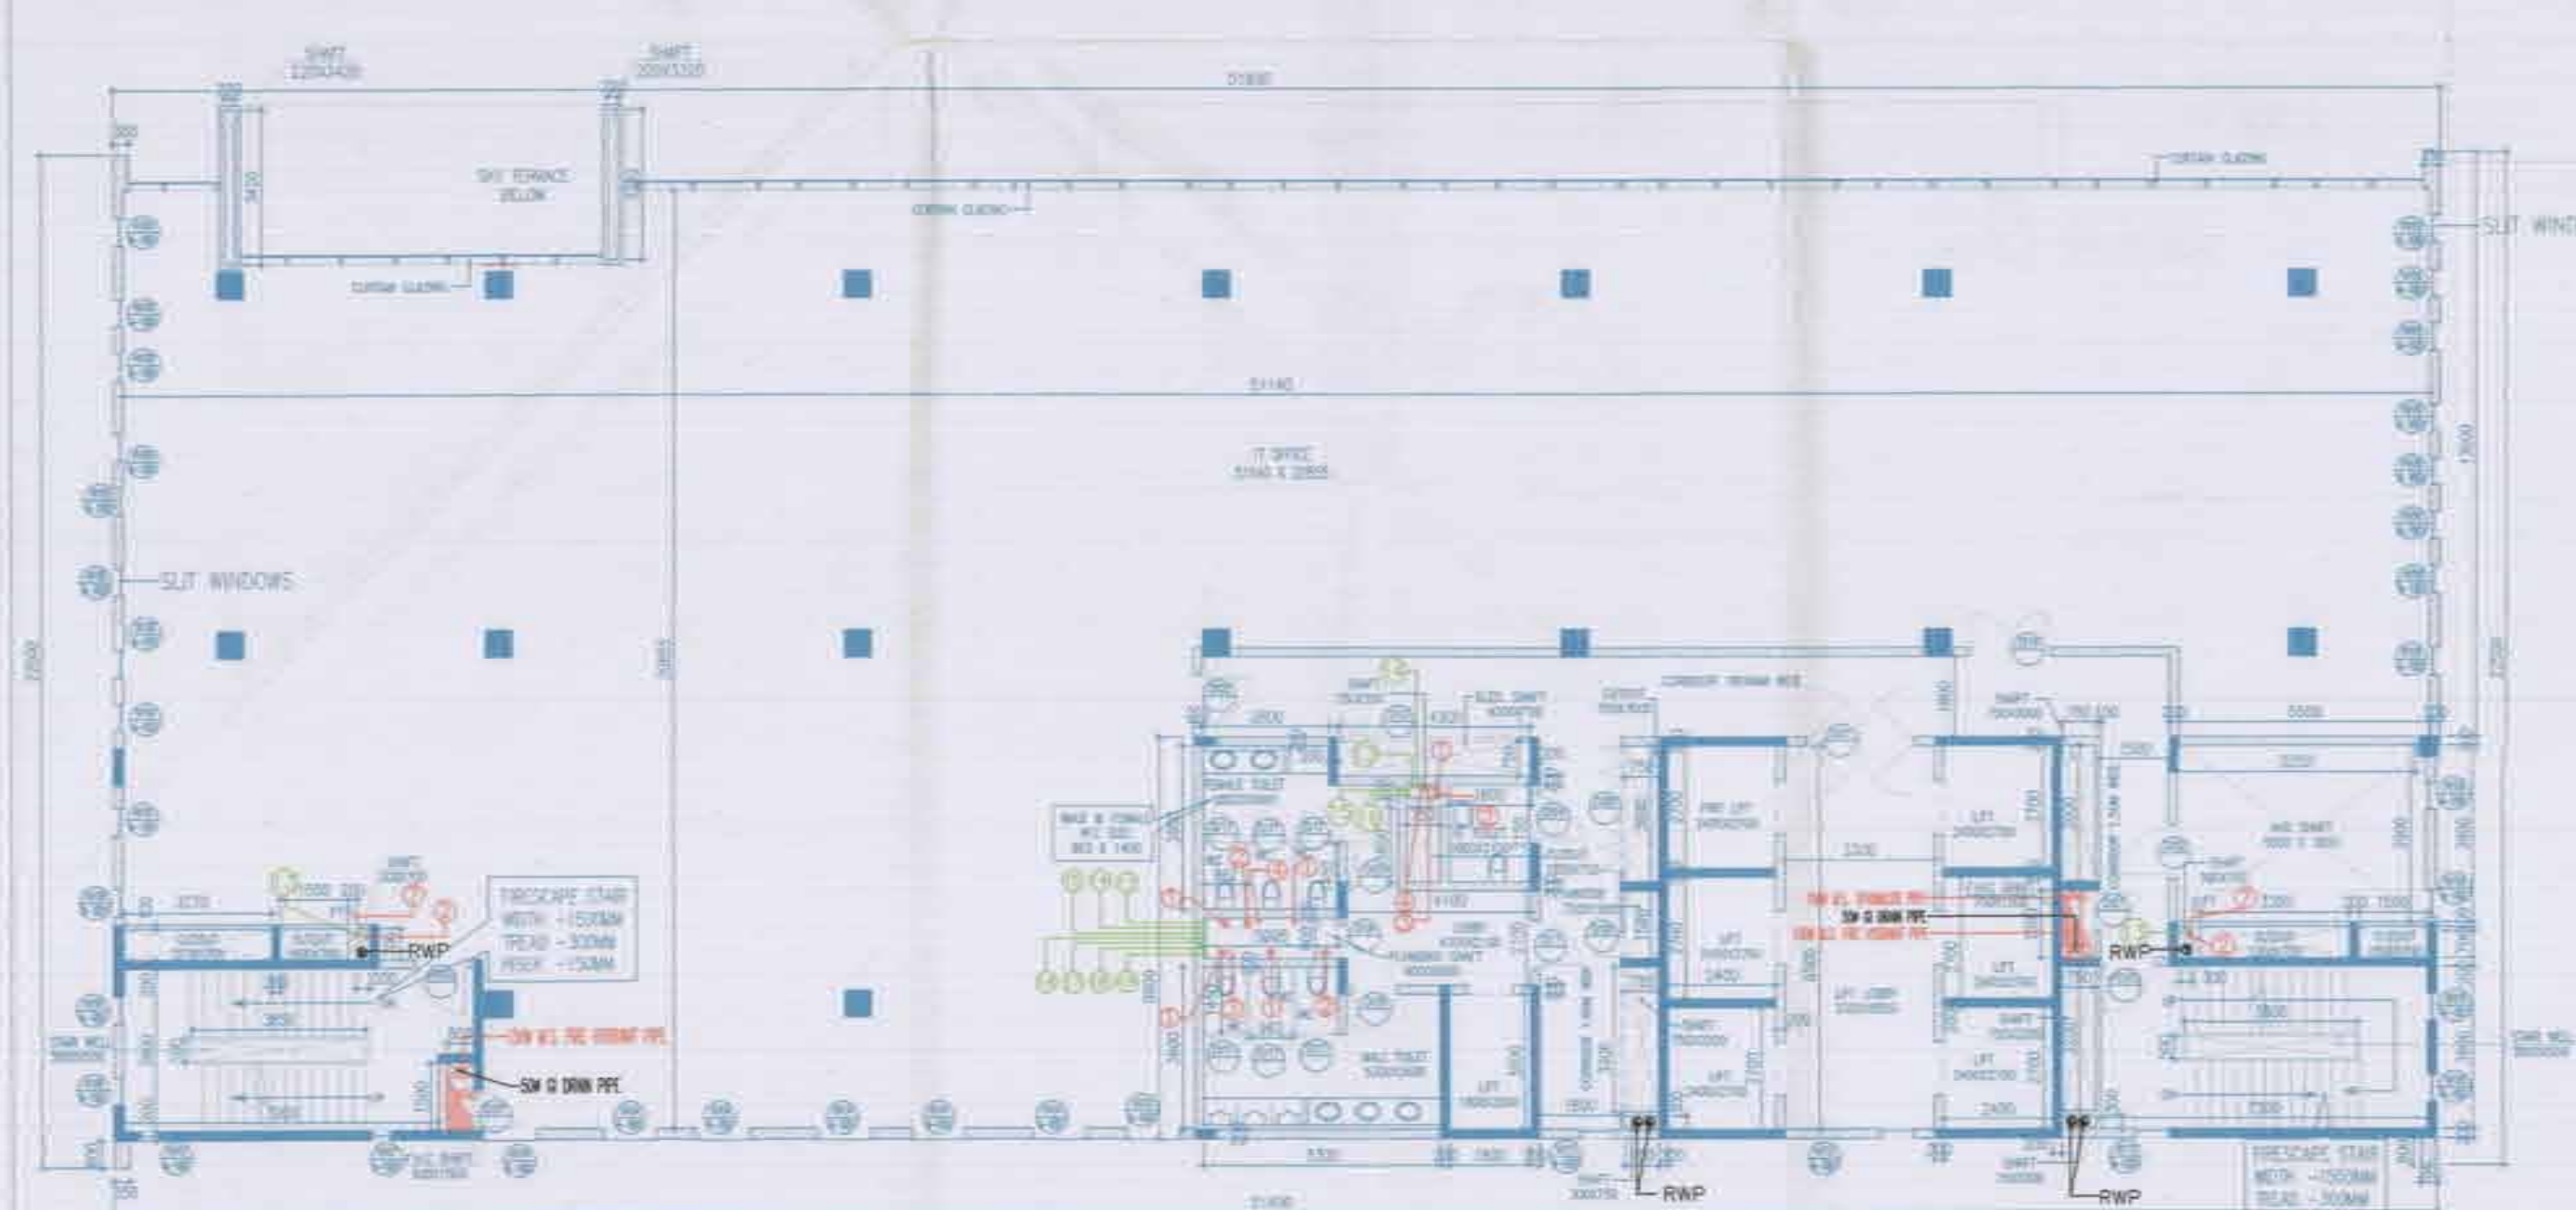

12th FLOOR PLAN
LVL+42050
BLOCK-C

Notes:-
1. BUILDING HAS AUTOMATIC SPINKLER SYSTEM WHEREVER REQUIRED BY NBC.
2. BUILDING WILL BE DESIGNED (STRUCTURES) AS PER RELEVANT IS CODES FOR EARTH QUAKE RESISTANCE.
3. BUILDING IS ARTIFICIALLY LIGHTED MECHANICALLY VENTILATED & CENTRALLY AIR-CONDITIONED.

- LEGEND:-
- 1. 100MM SOIL & VENT PIPE
 - 2. 100MM WASTE & VENT PIPE
 - 3. 75MM ANTI SYPHONAGE VENT PIPE(SOL)
 - 4. 75MM ANTI SYPHONAGE VENT PIPE(WASTE)
 - 5. 100MM SOIL PIPE
 - 6. 100MM WASTE PIPE
 - 7. 75MM WASTE PIPE
 - 8. 50MM ANTI SYPHONAGE PIPE(SOL)
 - 9. 50MM ANTI SYPHONAGE PIPE(WASTE)
 - 10. 50MM WASTE PIPE
 - 11. 40MM SOIL/WASTE PIPE
 - 12. 32MM WASTE PIPE
 - 13. COLD WATER SUPPLY(DOMESTIC)
DN TAKE PIPE: 1STH TO 7TH FLOOR
 - 14. COLD WATER SUPPLY(DOMESTIC)
DN TAKE PIPE: 8TH TO GROUND FLOOR
 - 15. COLD WATER SUPPLY(FLUSHING)
DN TAKE PIPE: 1STH TO 7TH FLOOR
 - 16. COLD WATER SUPPLY(FLUSHING)
DN TAKE PIPE: 8TH TO GROUND FLOOR
 - 17. COLD WATER SUPPLY(DOMESTIC)
RISEN TO OHT
 - 18. COLD WATER SUPPLY(FLUSHING)
RISEN TO OHT
 - 19. COLD WATER SUPPLY(DOMESTIC)
RISEN TO OHT


Project
REVISED BUILDING PLAN OF LT PARK MEASURING 8.793 ACRES (LICENCE NO. 1133 OF DATED 22.9.2006) IN SECTOR-27 B FARIDABAD BEING DEVELOPED BY M/S. VATIKA IT PARK PVT. LTD. PREVIOUSLY KNOWN AS HIND ENTERPRISES PVT. LTD.

Associate Architect
RSMS ARCHITECTS
RSMS ARCHITECTS PVT. LTD.
60, Nara Niwas, Bhawan Kunj (Behind D2), Vasant Kunj, New Delhi-110070.
Tel: 011-26898616, 26898617
www.rsms-arch.com


Sanctioned
The City Engineer, New Delhi
12/07/12
Sanctioned
The City Engineer, New Delhi
12/07/12

ARCHITECT'S SEAL & SIGNATURE	OWNER'S SEAL & SIGNATURE
JULY, 2012	Scale: 1:100
Drawing Title:- 10TH TO 12TH FLOOR PLAN (BLOCK-C)	Drawing No:- C-06


For VATIKA LIMITED
Authorized Signatory

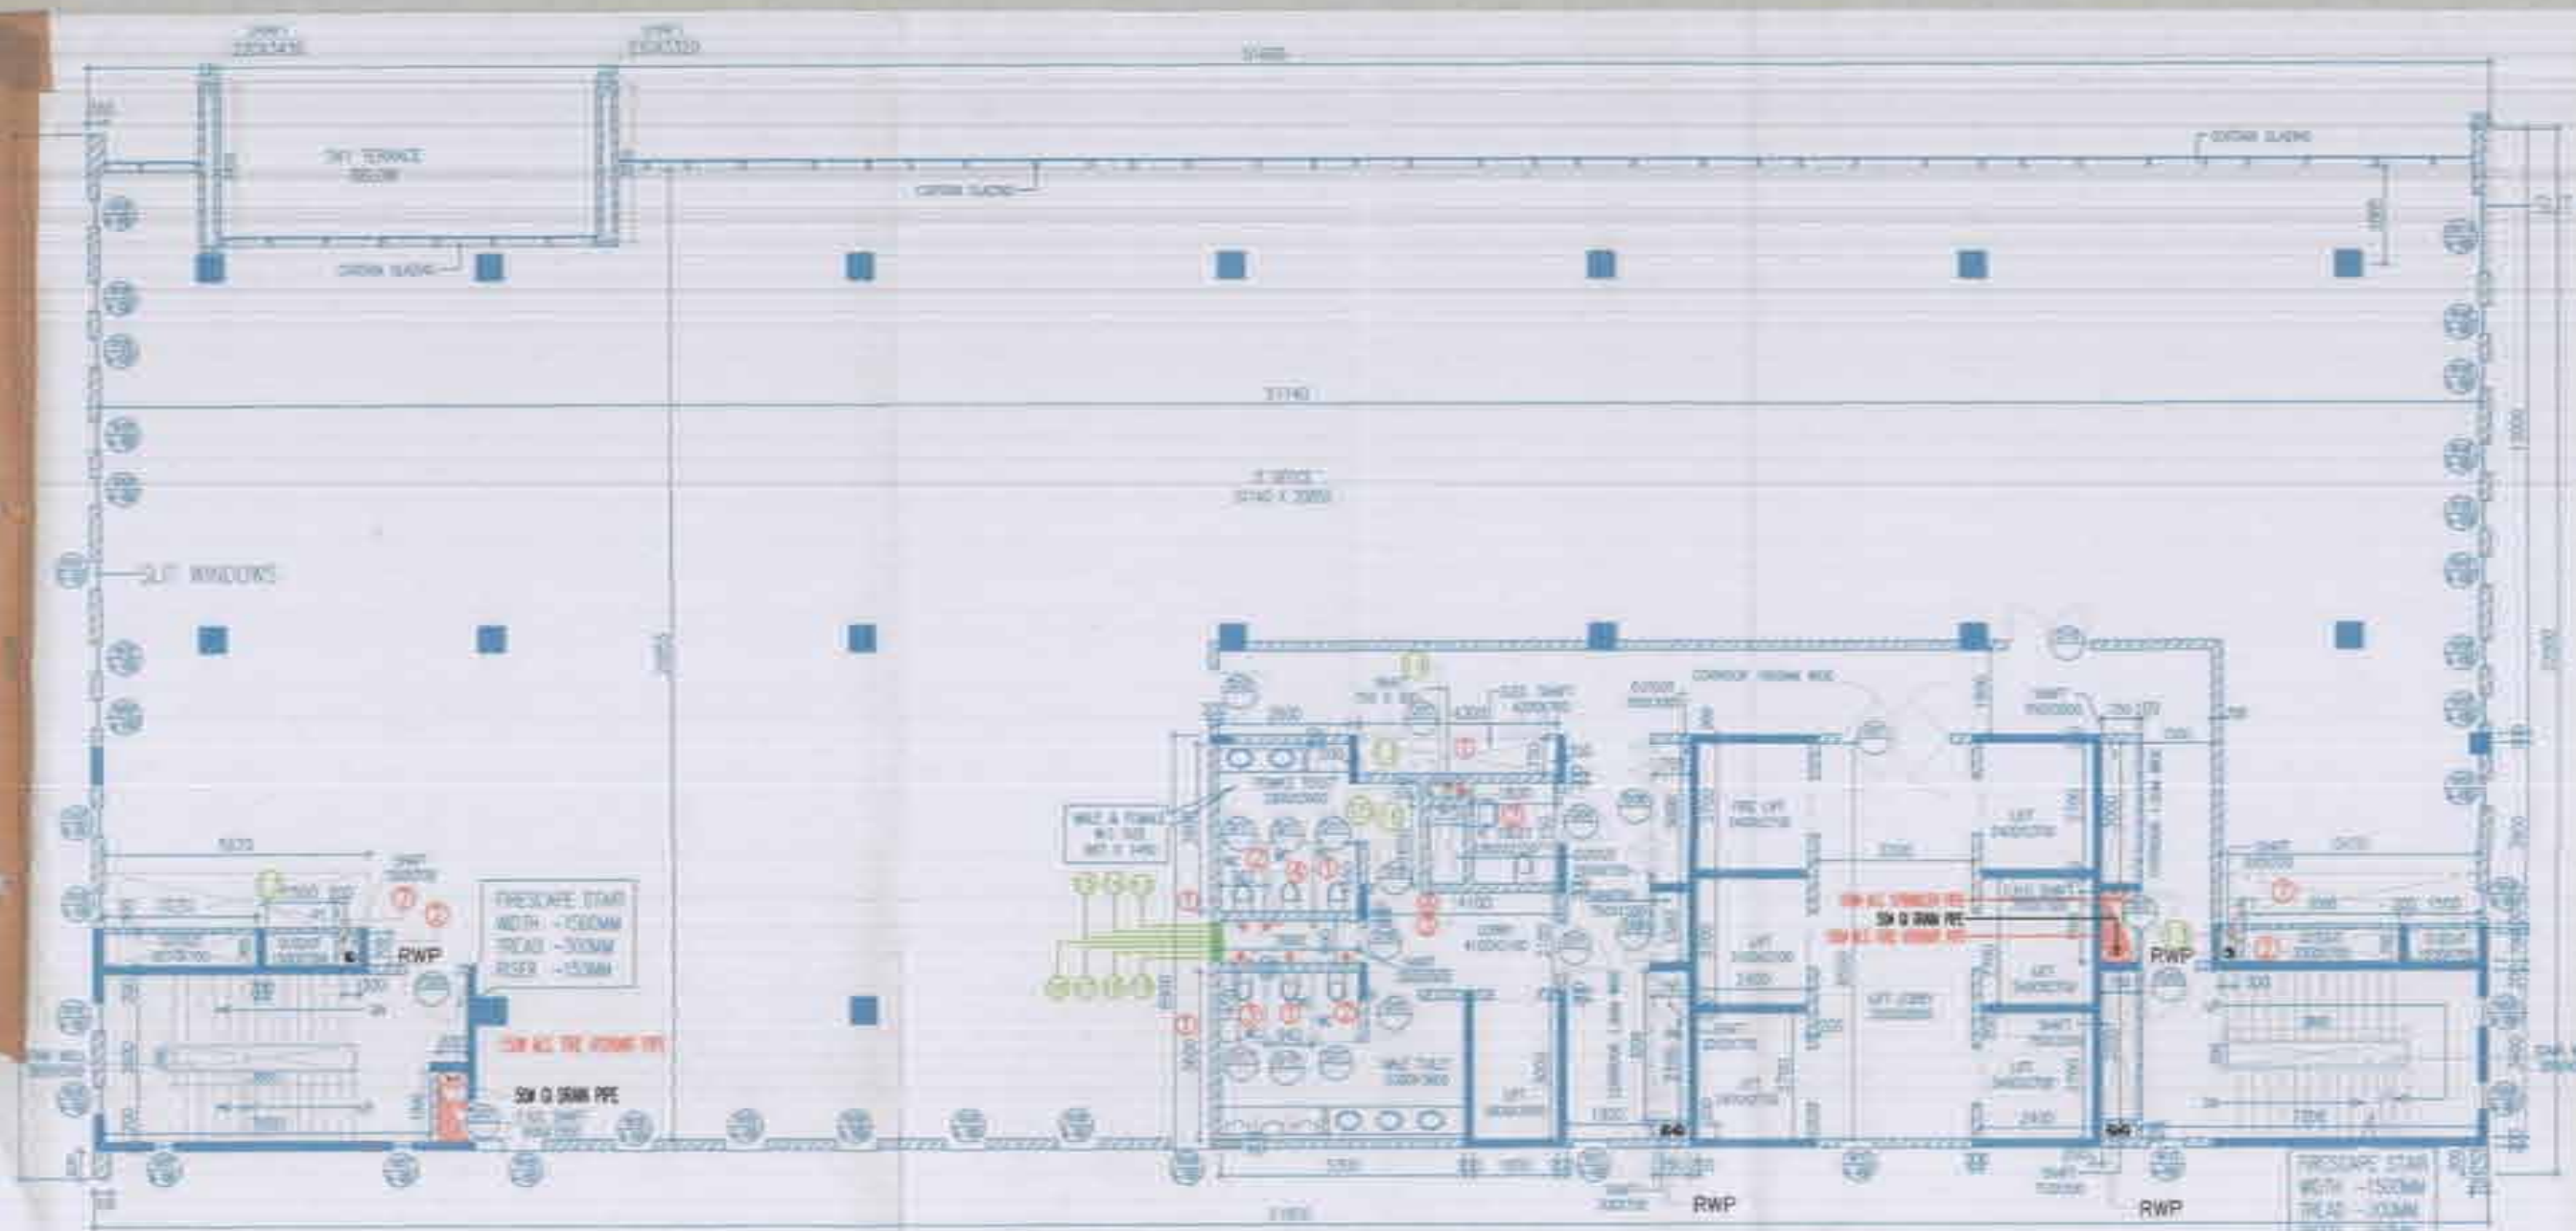

13th FLOOR PLAN
(Block-C)

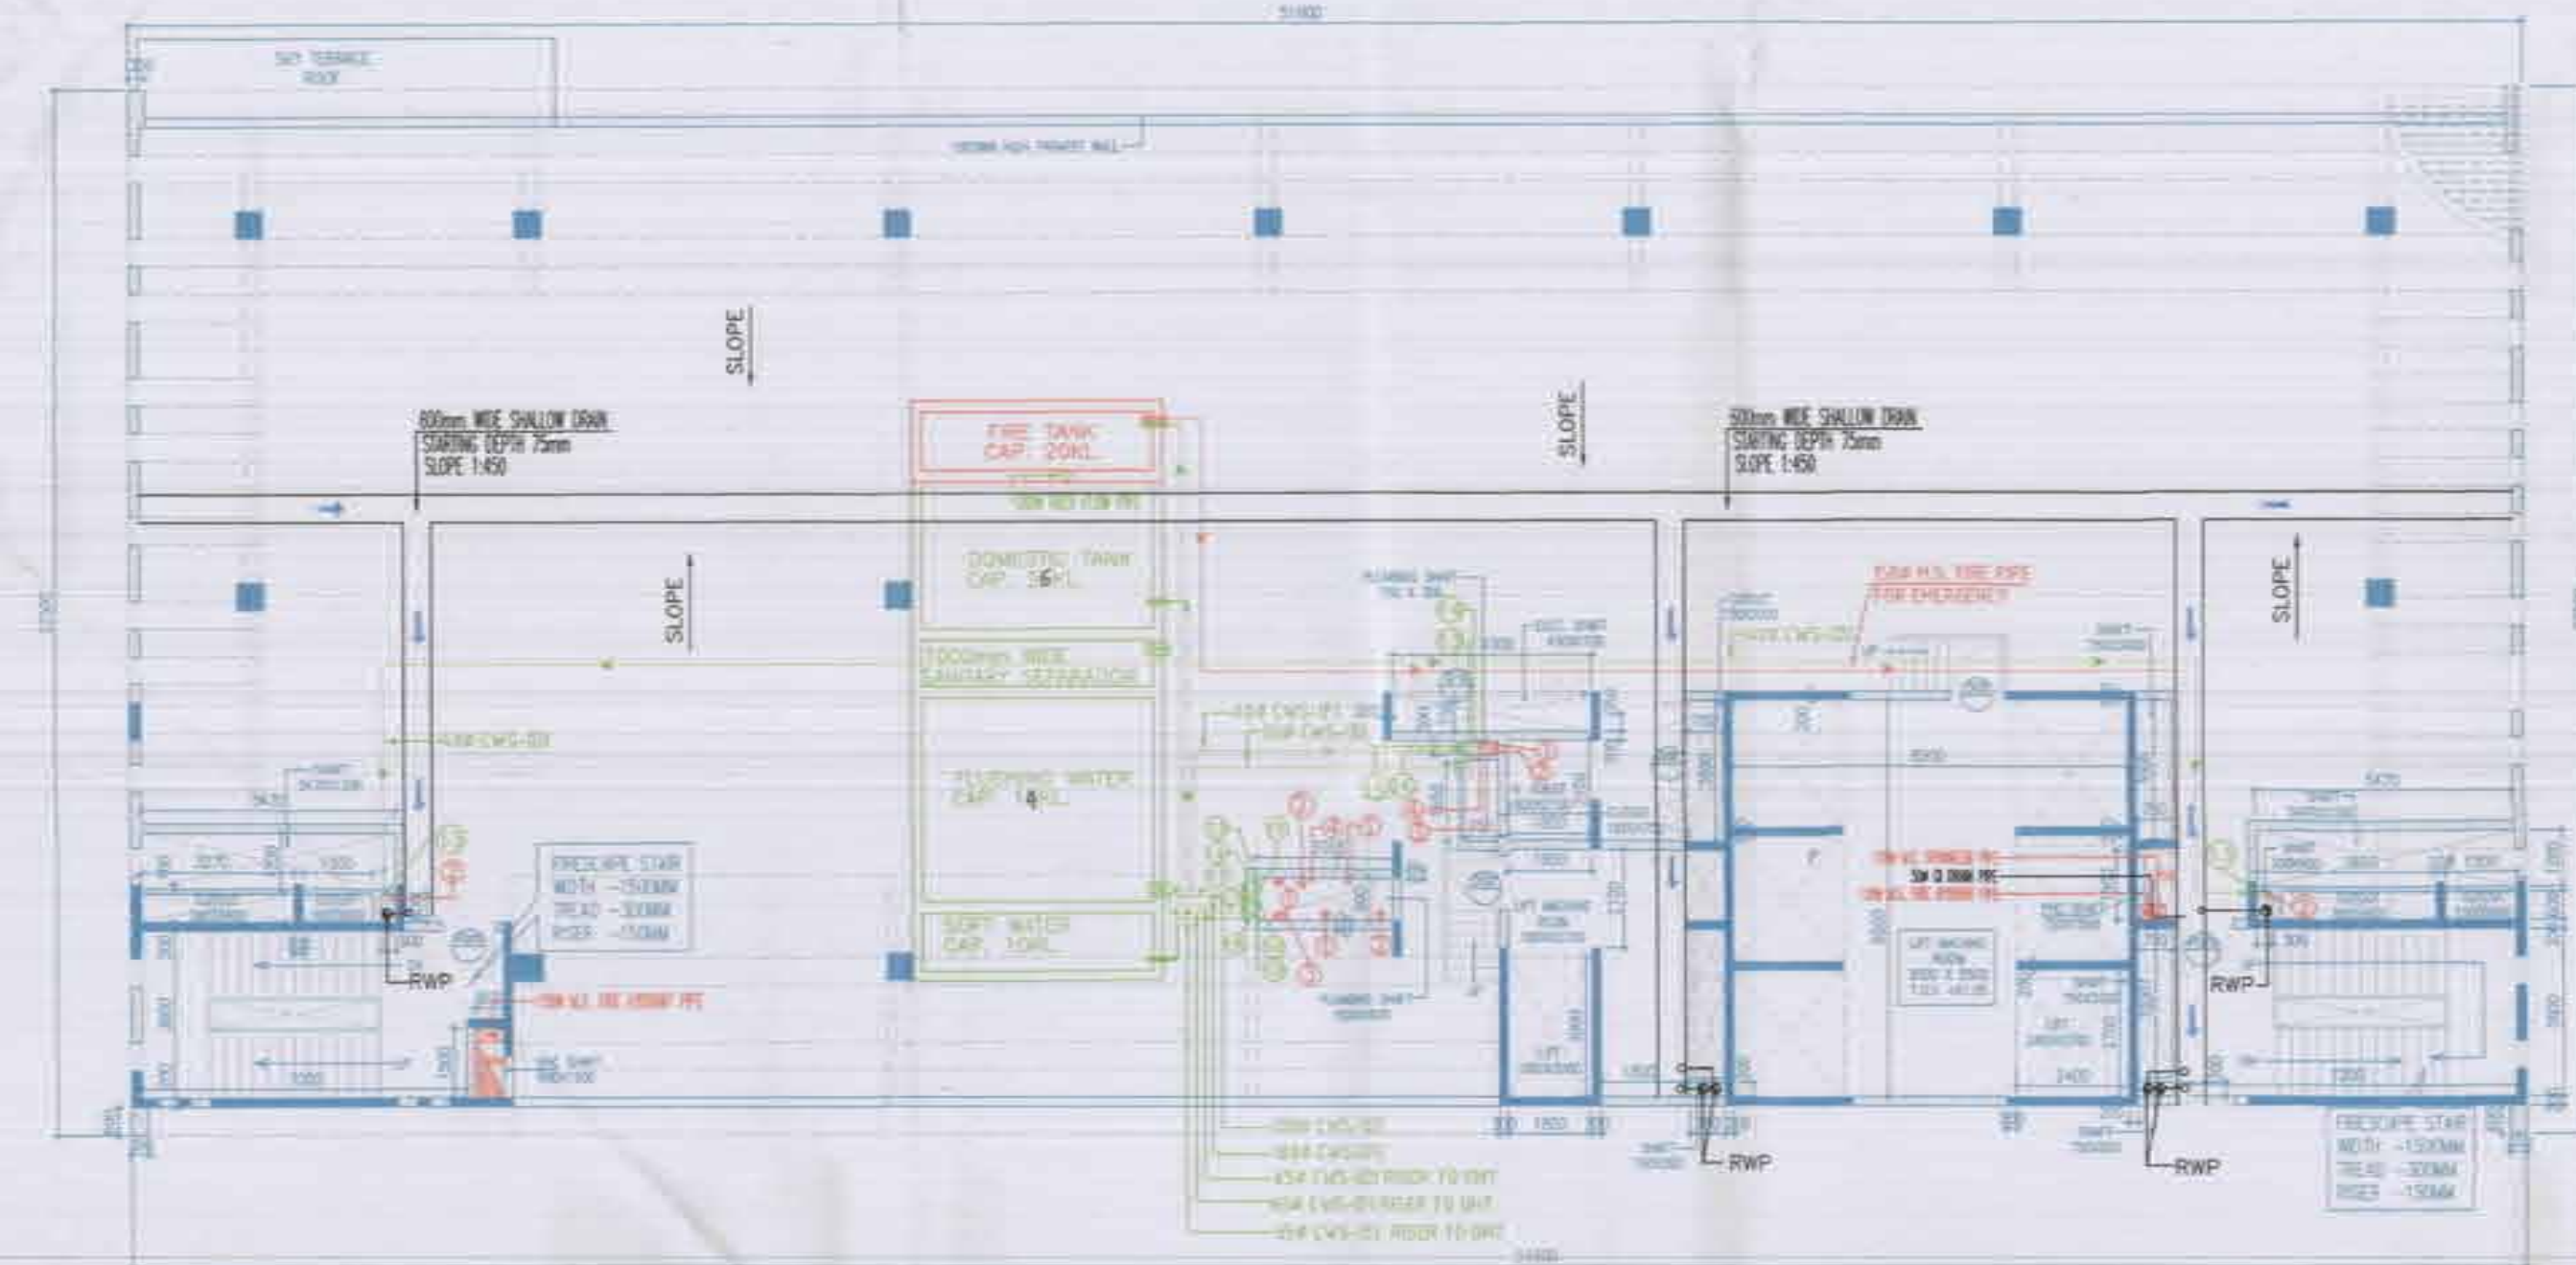


TERRACE FLOOR PLAN
(Block-C)

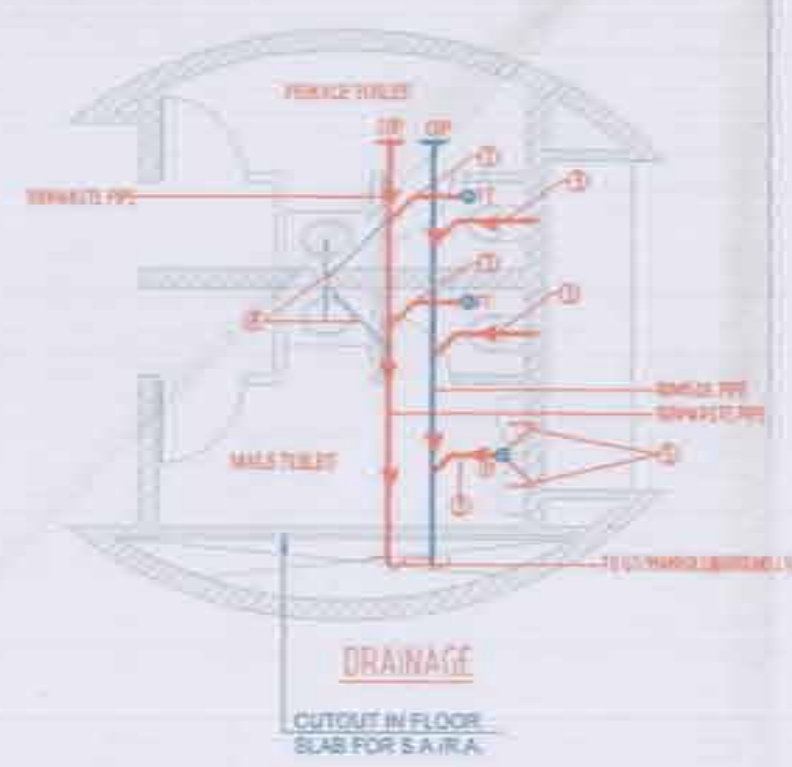


CHILD CARE CENTER AREA (TOILET DETAIL)
SCALE 1:50




TERRACE FLOOR PLAN
(Block-C)

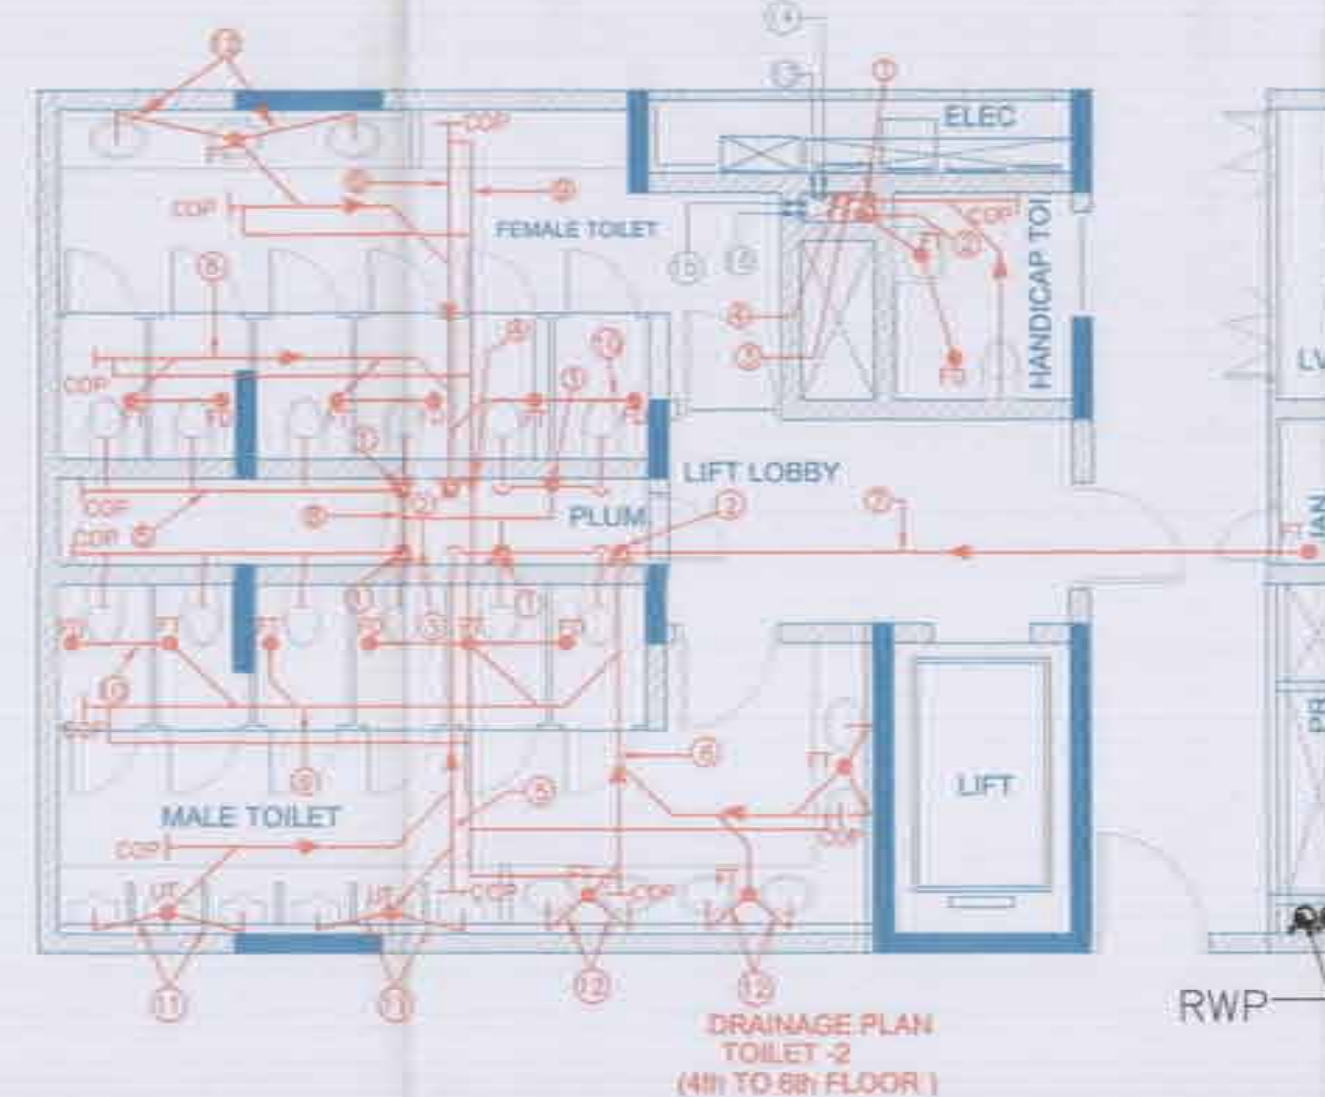


DRAINAGE PLAN
TOILET-2
(4th to 8th FLOOR)

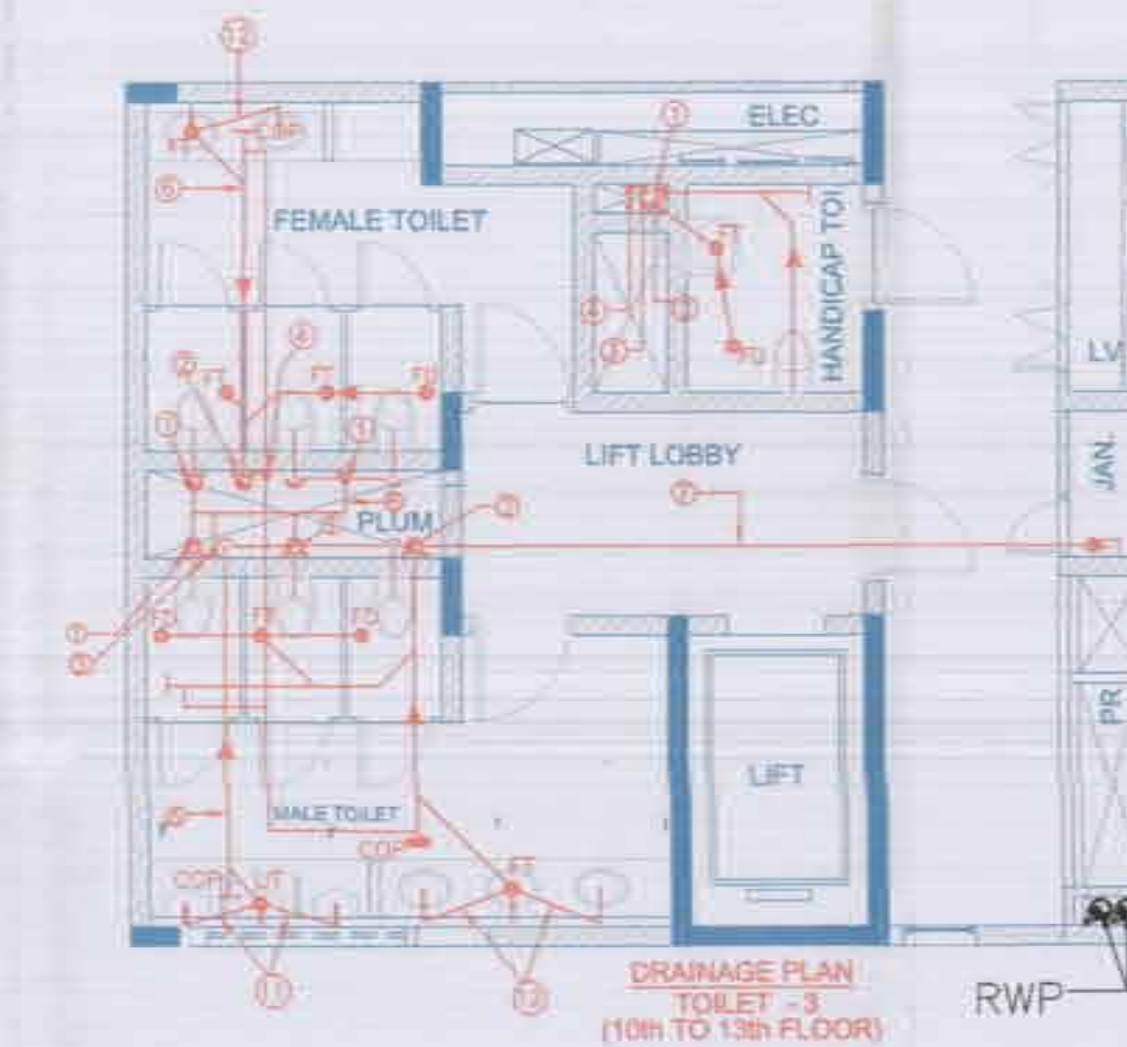


DRAINAGE PLAN
TOILET-3
(10th to 13th FLOOR)

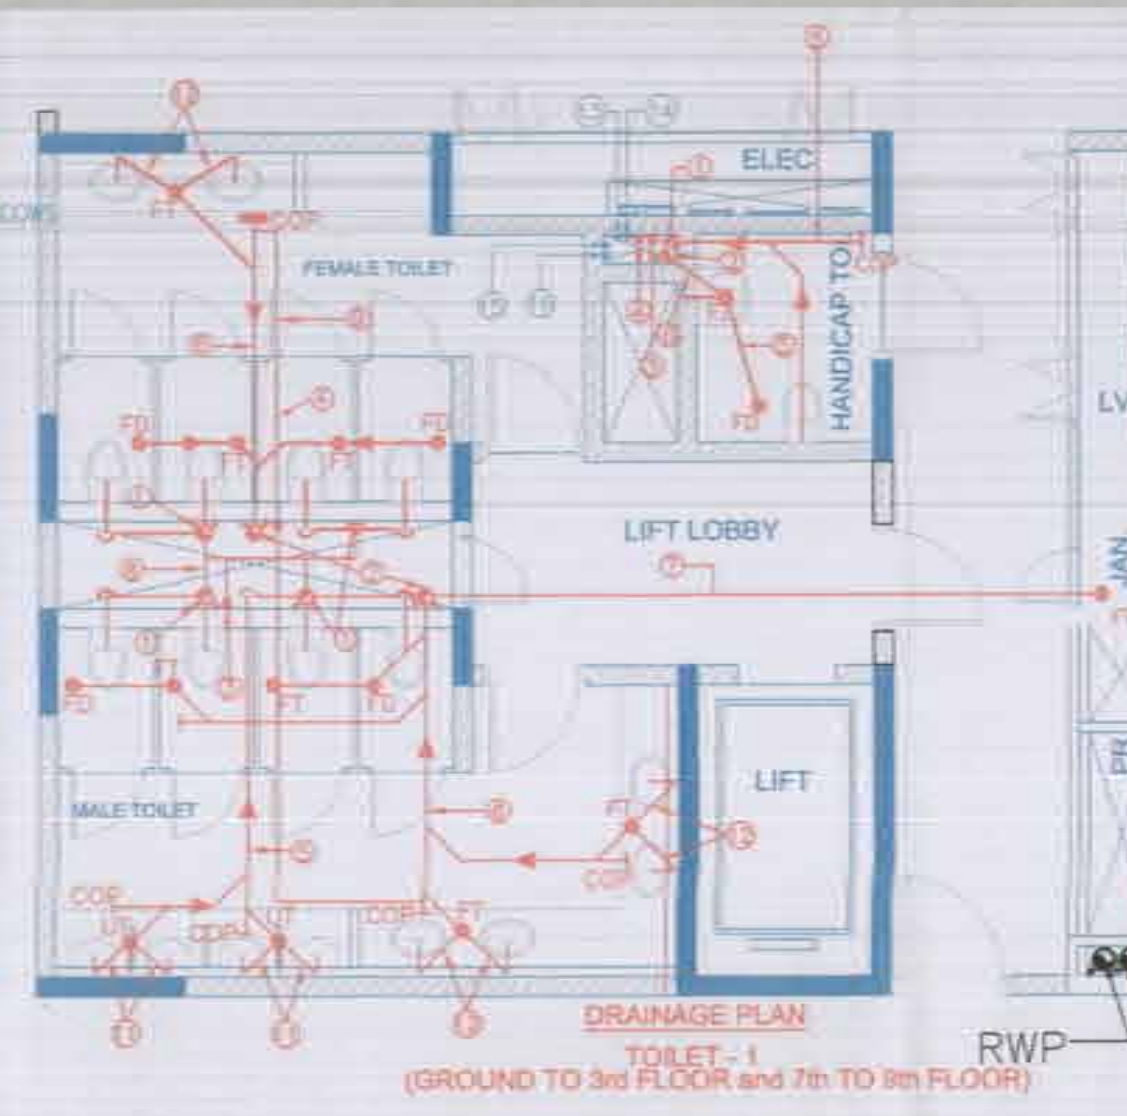


DRAINAGE PLAN
TOILET-1
(GROUND TO 3rd FLOOR and 7th to 8th FLOOR)

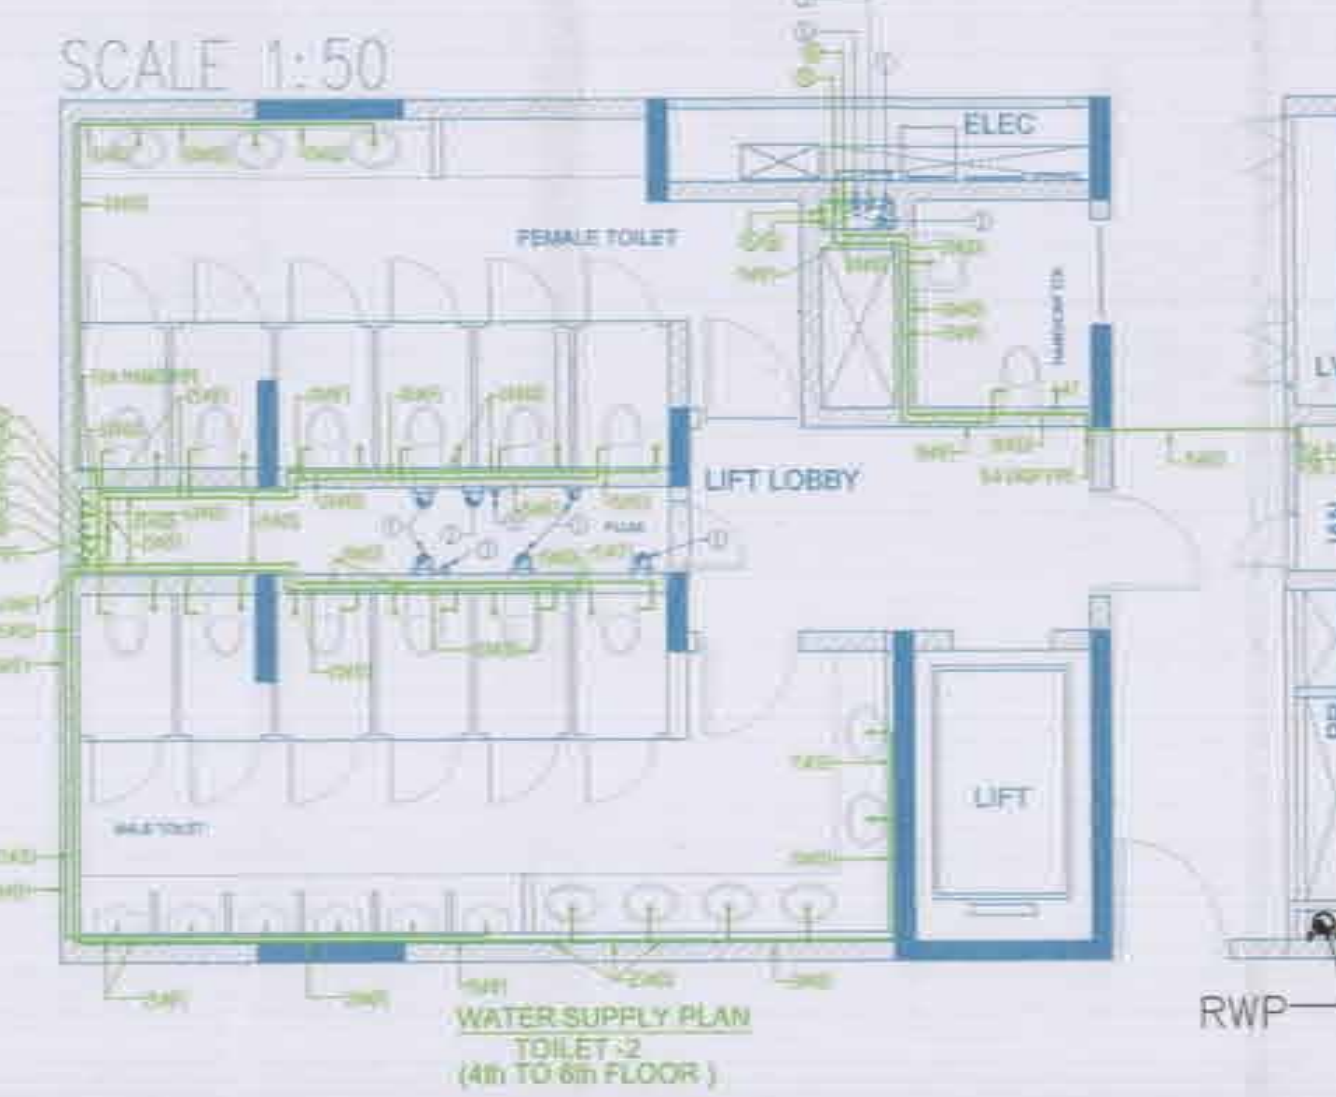

WATER SUPPLY PLAN
TOILET-2
(4th to 8th FLOOR)

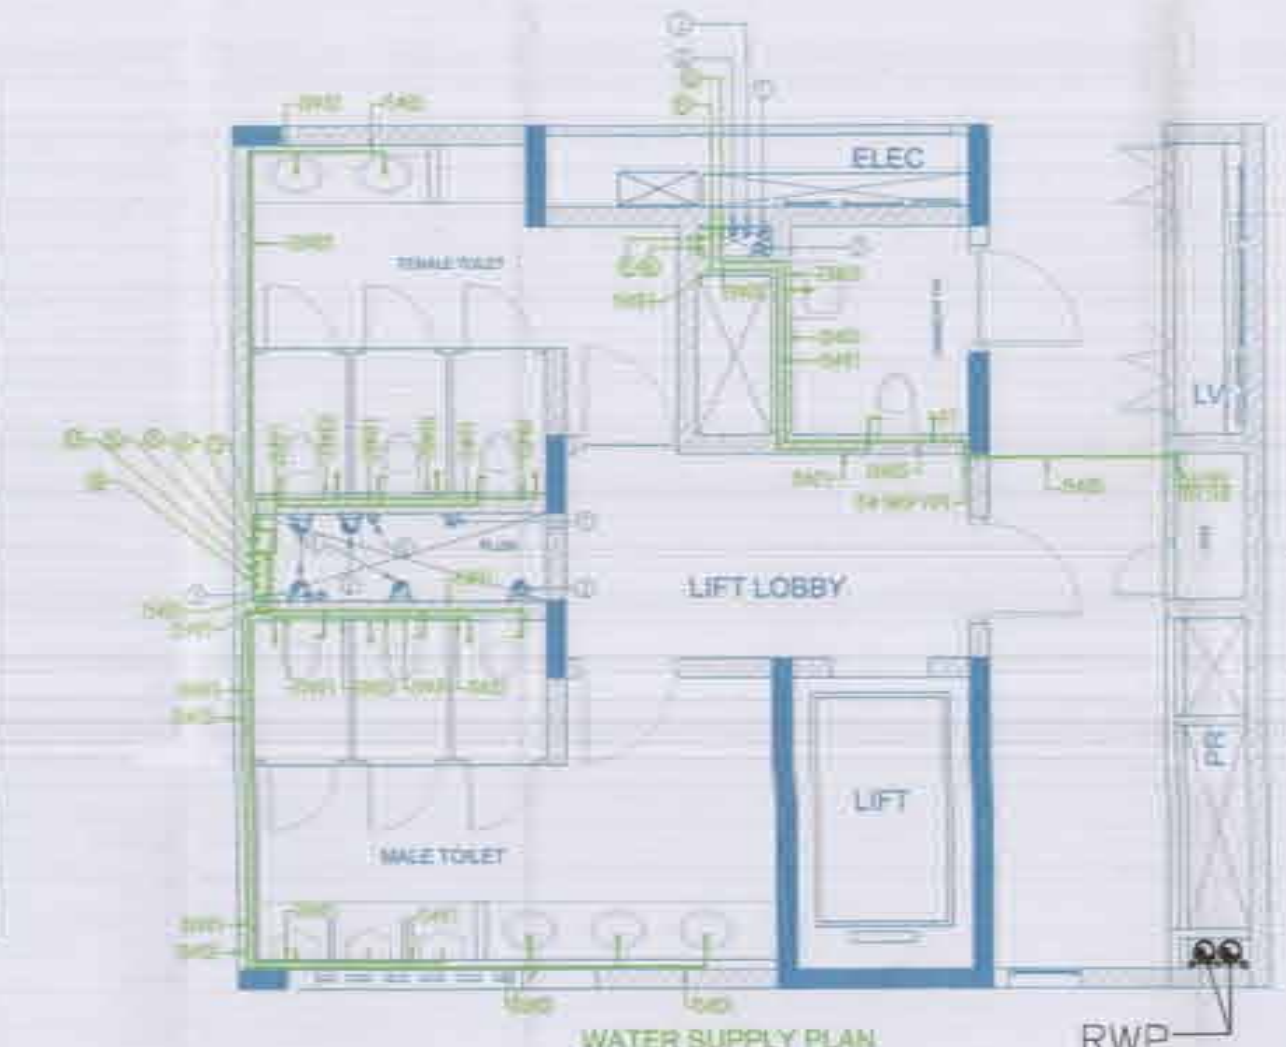

WATER SUPPLY PLAN
TOILET-3
(10th to 13th FLOOR)

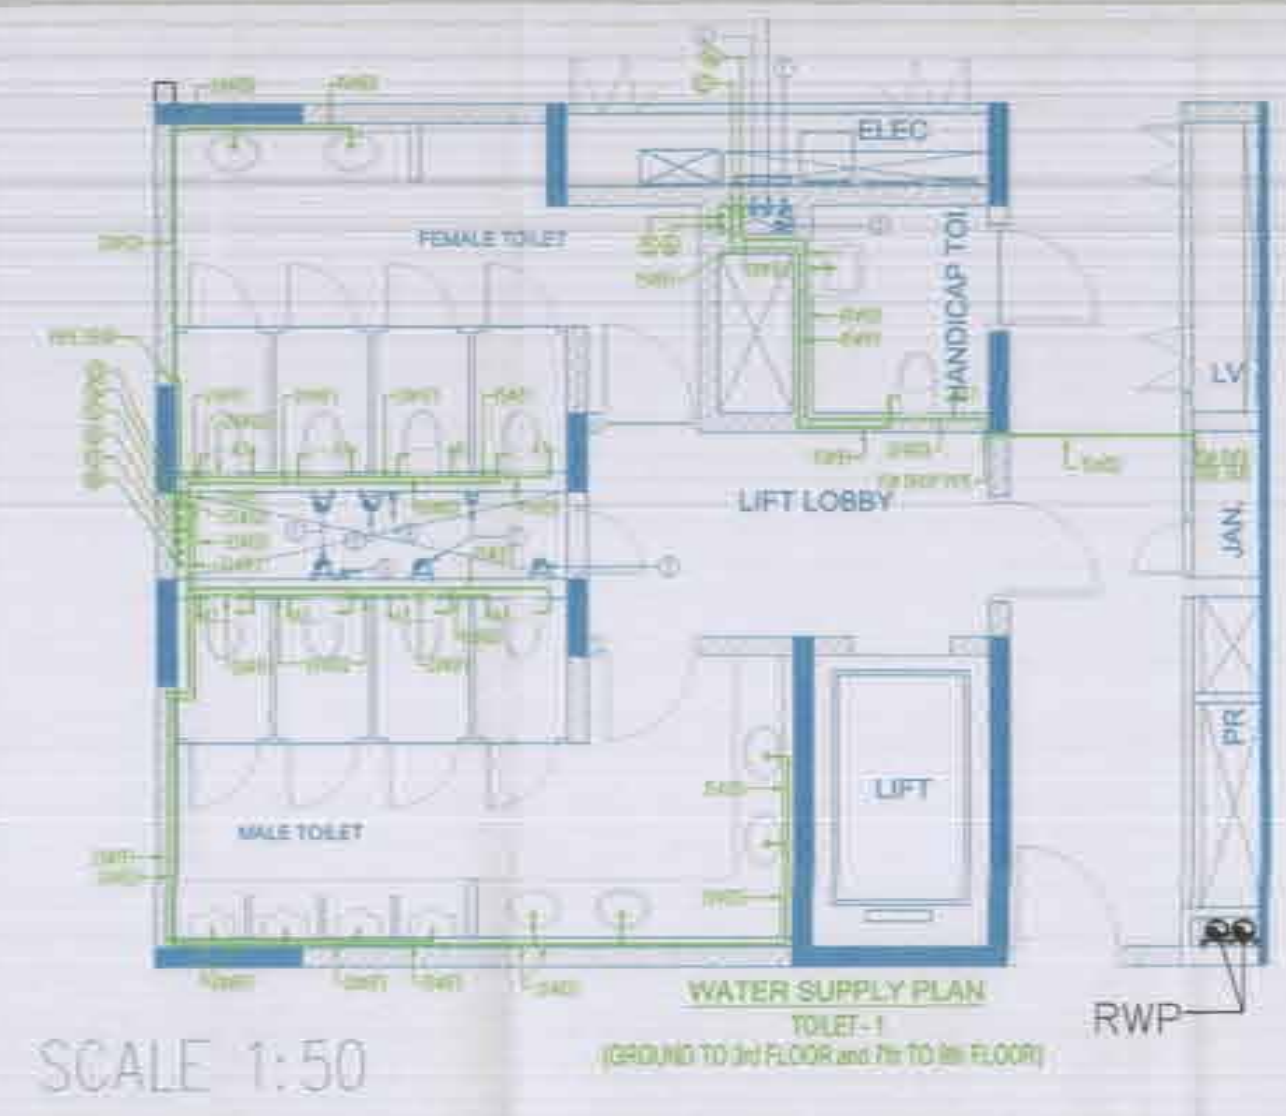

WATER SUPPLY PLAN
TOILET-1
(GROUND TO 3rd FLOOR and 7th to 8th FLOOR)

Note:-
1. BUILDING HAS AUTOMATIC SPRINKLER SYSTEM WHEREVER REQUIRED BY NBC.
2. BUILDING WILL BE DESIGNED (STRUCTURE) AS PER RELEVANT CODES FOR EARTH QUAKE RESISTANCE.
3. BUILDING IS MECHANICALLY VENTILATED & CENTRALLY AIR-CONDITIONED.
LEGEND:-


- LEGEND:-
1. 100mm SOIL & VENT PIPE
 2. 100mm WASTE & VENT PIPE
 3. 75mm ANTI-SYPHONAGE VENT PIPE(SOIL)
 4. 75mm ANTI-SYPHONAGE VENT PIPE(WASTE)
 5. 100mm SOIL PIPE
 6. 100mm WASTE PIPE
 7. 75mm WASTE PIPE
 8. 50mm ANTI-SYPHONAGE PIPE(SOIL)
 9. 50mm ANTI-SYPHONAGE PIPE(WASTE)
 10. 50mm WASTE PIPE
 11. 40mm SOIL/WASTE PIPE
 12. 32mm WASTE PIPE
 13. COLD WATER SUPPLY(DOMESTIC) ON TAKE PIPE - 13th to 7th FLOOR
 14. COLD WATER SUPPLY(DOMESTIC) ON TAKE PIPE - 6th to GROUND FLOOR
 15. COLD WATER SUPPLY(FLUSHING) ON TAKE PIPE - 13th to 7th FLOOR
 16. COLD WATER SUPPLY(FLUSHING) ON TAKE PIPE - 6th to GROUND FLOOR
 17. COLD WATER SUPPLY(DOMESTIC) RISER TO CHIT
 18. COLD WATER SUPPLY(FLUSHING) RISER TO CHIT
 19. COLD WATER SUPPLY(SOFT WATER) RISER TO CHIT

REVISED BUILDING PLAN OF I.T. PARK MEASURING 8.793 ACRES (LICENCE NO. 1133 OF DATED 22.9.2006) IN SECTOR-27, B FARIDABAD BEING DEVELOPED BY M/S VATIKA IT PARK PVT. LTD. PREVIOUSLY KNOWN AS HIND ENTERPRISES PVT. LTD.


Associated Architect
RIMS ARCHITECTS
RIMS ARCHITECTS PVT. LTD.
69, Naraina Heights, Bhopal (Kun)
(Behind D2), Vasant Kunj,
New Delhi-110070.
Tel: 011-26898616, 26898617
www.rims-arch.com

ARCHITECT'S SEAL & SIGNATURE
OWNER'S SEAL & SIGNATURE
JULY 2012 Scale: 1:100
Drawing No.: 13th FLOOR & TERRACE PLAN & TOILET DETAIL (BLOCK-C)
Drawing No.: C-07

For VATIKA LIMITED
Authorised Signatory

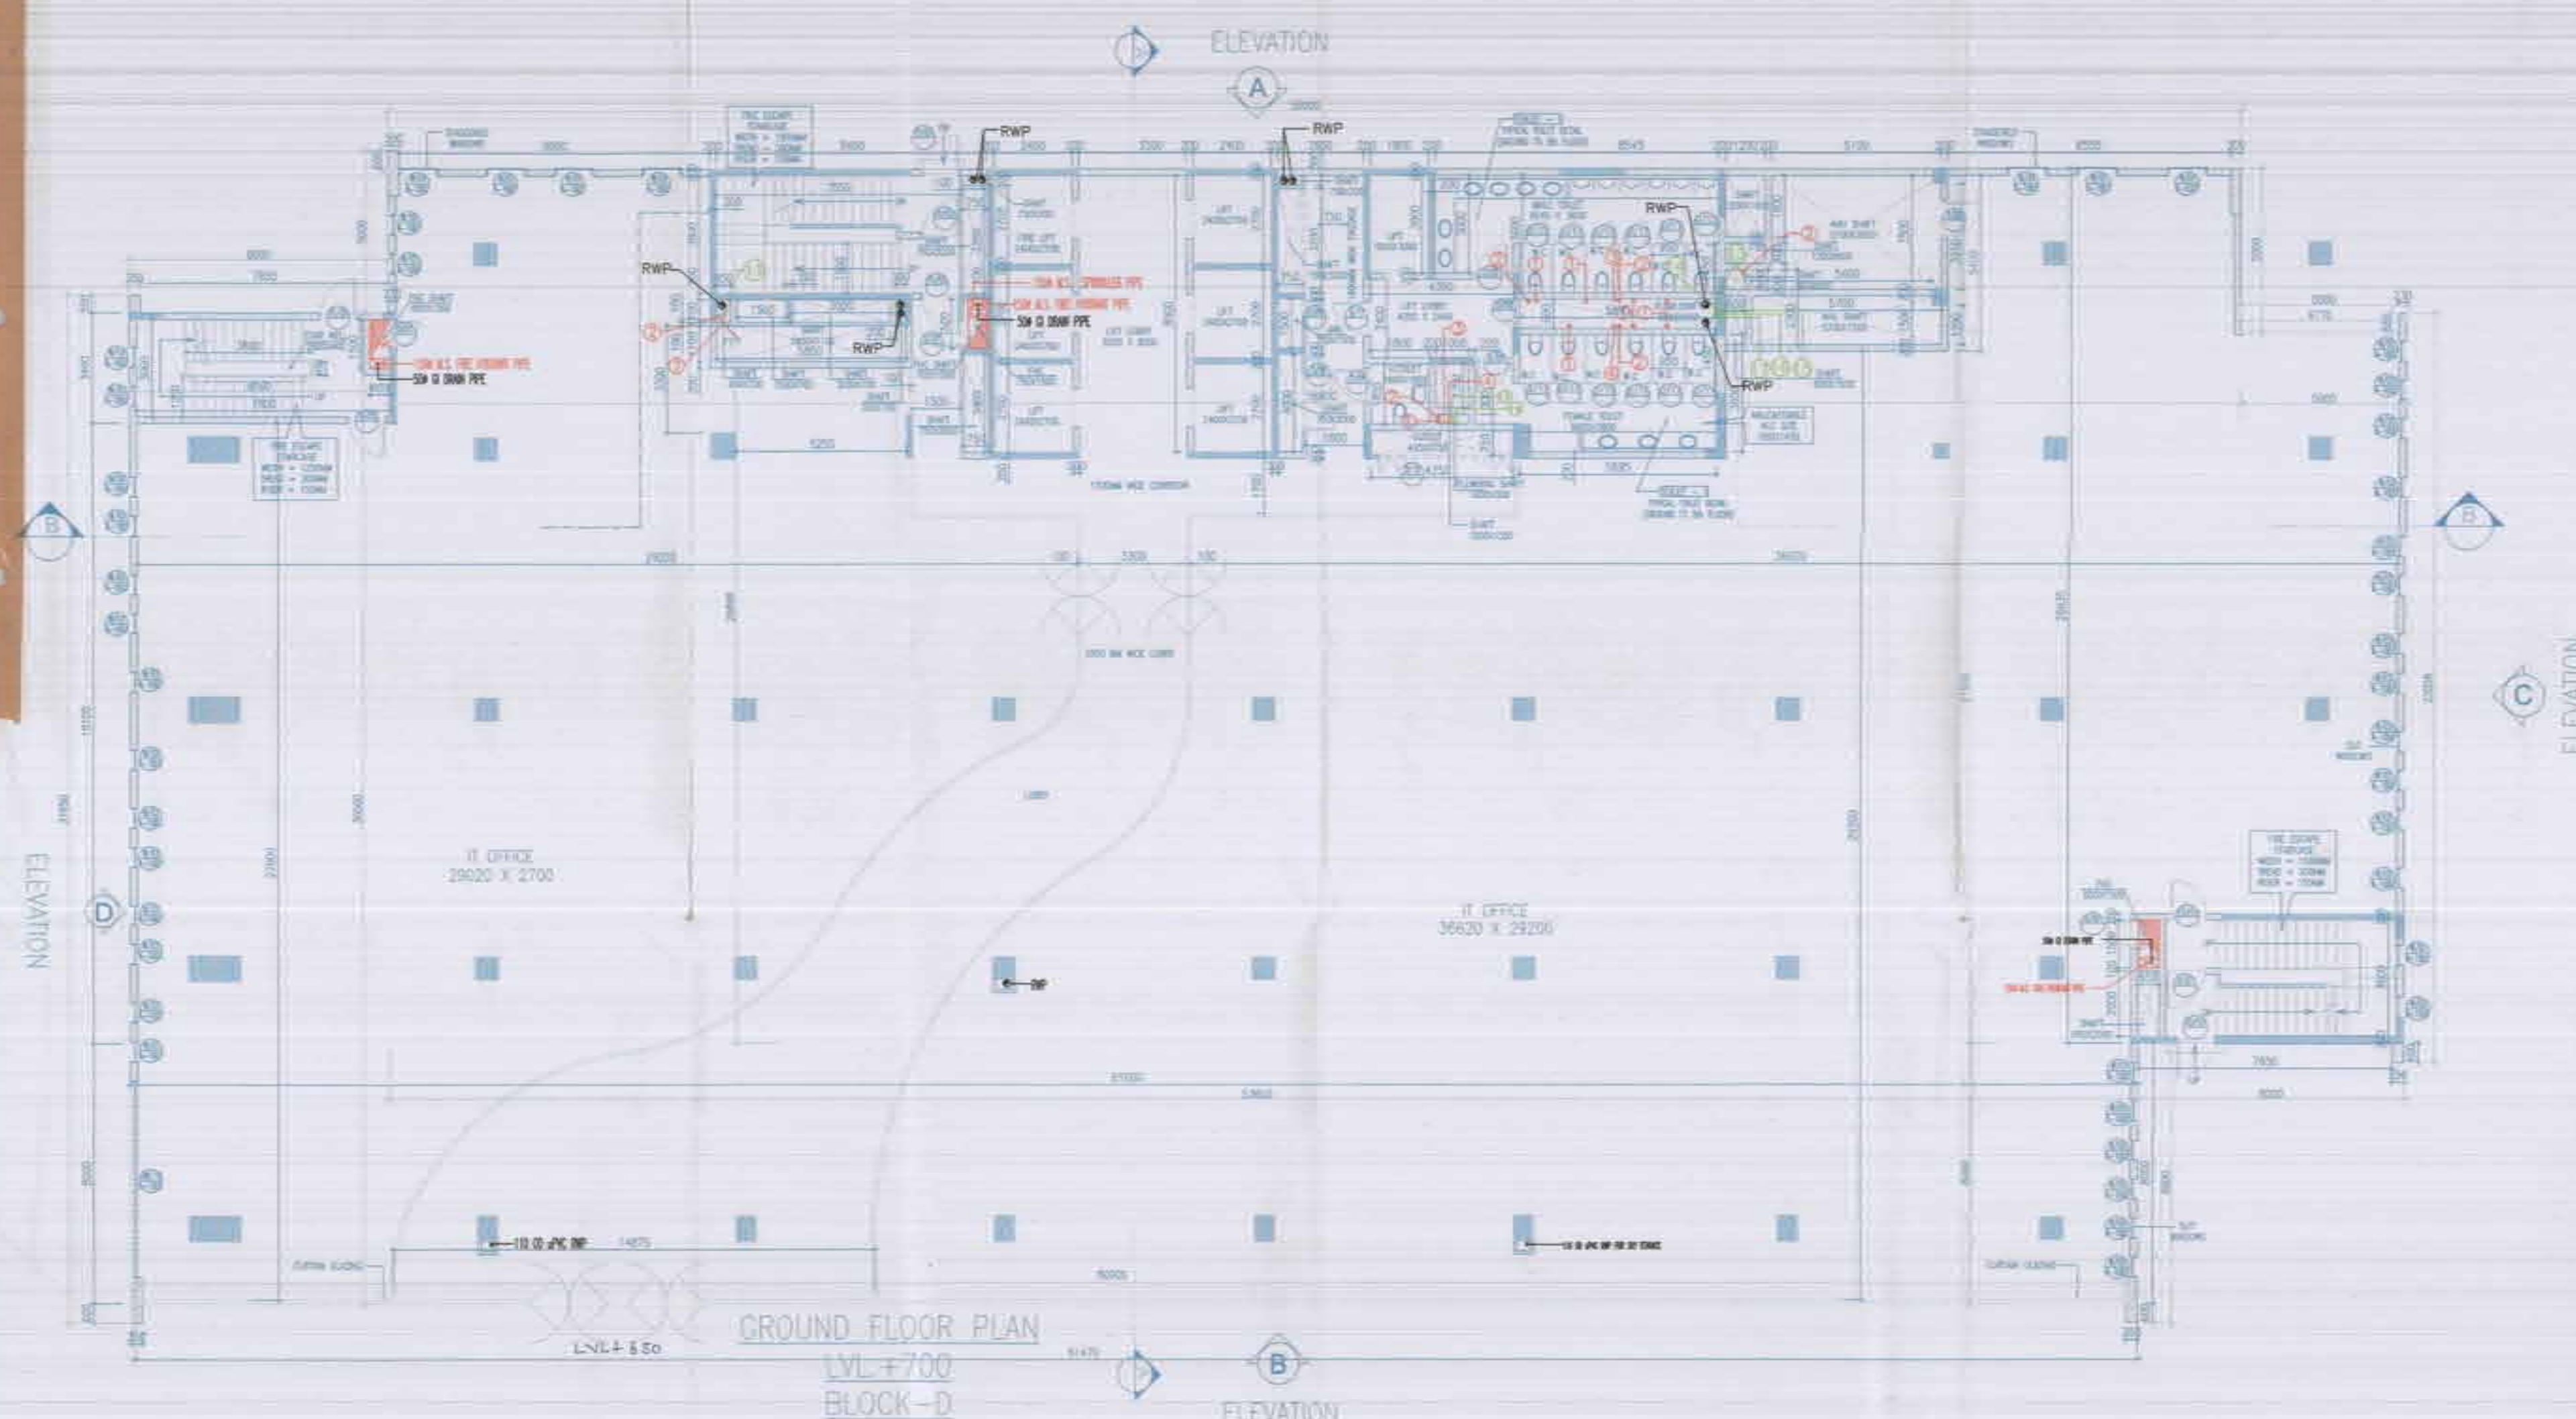

GROUND FLOOR PLAN
LVL +700
BLOCK-D

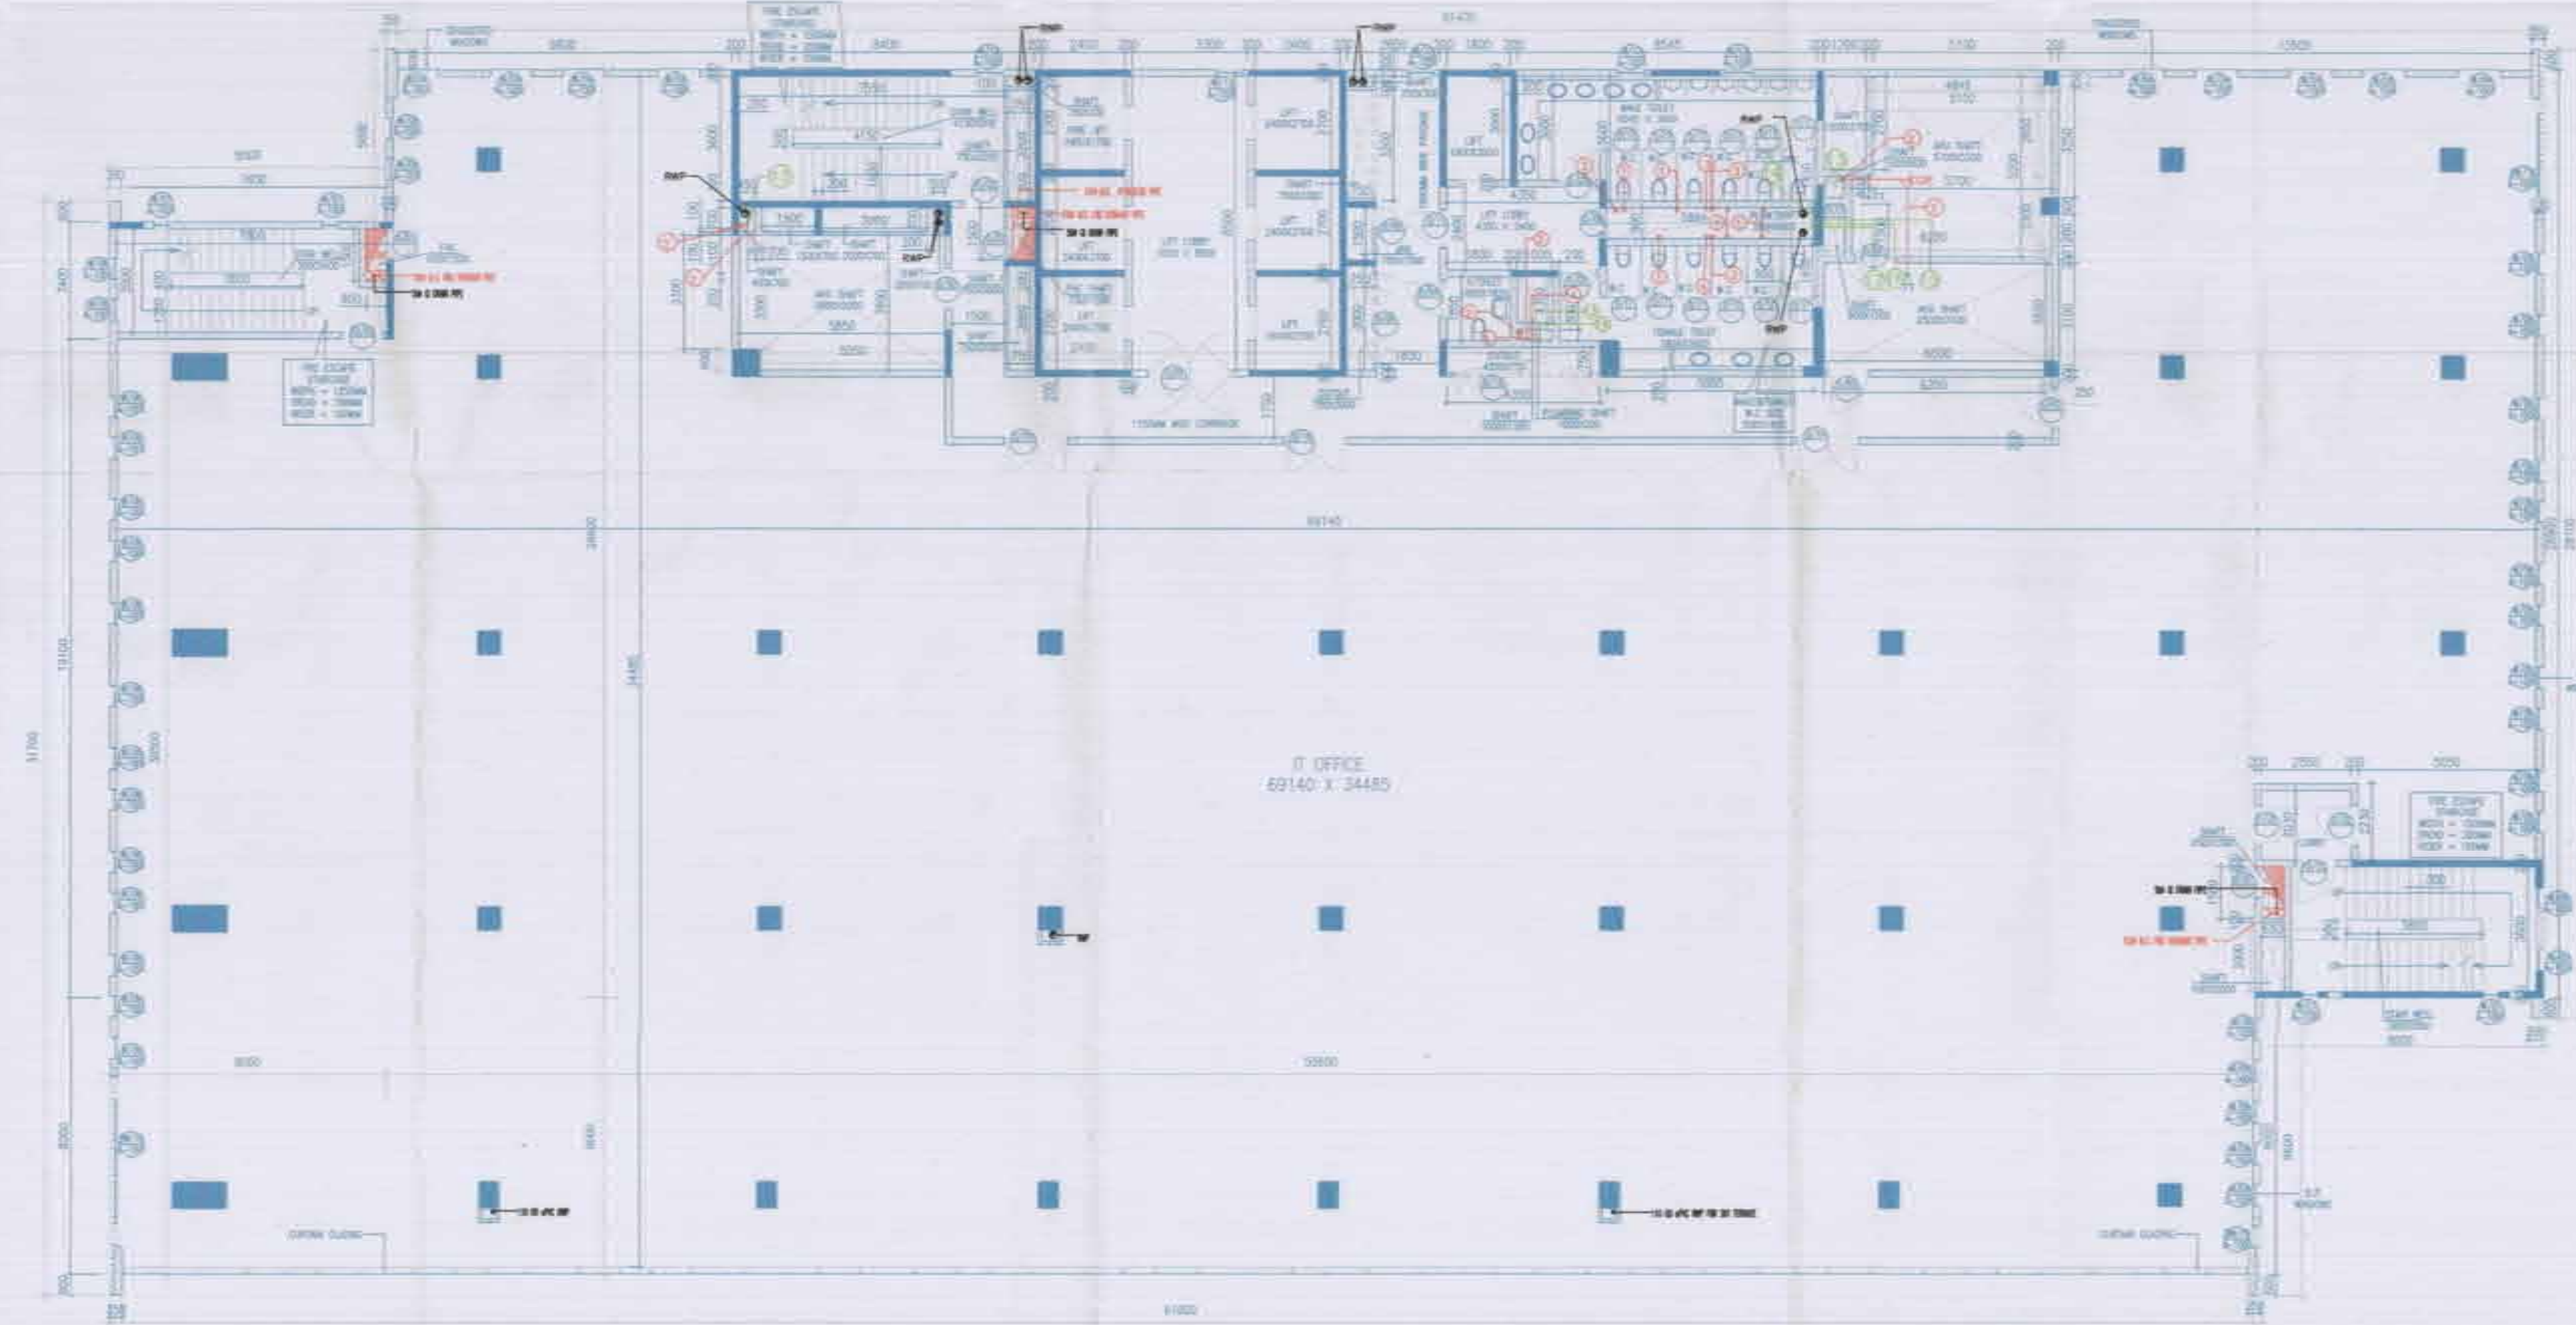

1st FLOOR PLAN
LVL +5700
BLOCK-D

DOOR SCHEDULE

NO.	DOOR TYPE	SIZE	FINISH
1	GLASS DOOR	1200 X 2100	GLASS
2	GLASS DOOR	1200 X 2100	GLASS
3	GLASS DOOR	1200 X 2100	GLASS
4	GLASS DOOR	1200 X 2100	GLASS
5	GLASS DOOR	1200 X 2100	GLASS
6	GLASS DOOR	1200 X 2100	GLASS
7	GLASS DOOR	1200 X 2100	GLASS
8	GLASS DOOR	1200 X 2100	GLASS
9	GLASS DOOR	1200 X 2100	GLASS
10	GLASS DOOR	1200 X 2100	GLASS
11	GLASS DOOR	1200 X 2100	GLASS
12	GLASS DOOR	1200 X 2100	GLASS
13	GLASS DOOR	1200 X 2100	GLASS
14	GLASS DOOR	1200 X 2100	GLASS
15	GLASS DOOR	1200 X 2100	GLASS
16	GLASS DOOR	1200 X 2100	GLASS
17	GLASS DOOR	1200 X 2100	GLASS
18	GLASS DOOR	1200 X 2100	GLASS
19	GLASS DOOR	1200 X 2100	GLASS
20	GLASS DOOR	1200 X 2100	GLASS

WINDOW SCHEDULE

NO.	WINDOW TYPE	SIZE	FINISH
1	GLASS WINDOW	1200 X 1500	GLASS
2	GLASS WINDOW	1200 X 1500	GLASS
3	GLASS WINDOW	1200 X 1500	GLASS
4	GLASS WINDOW	1200 X 1500	GLASS
5	GLASS WINDOW	1200 X 1500	GLASS
6	GLASS WINDOW	1200 X 1500	GLASS
7	GLASS WINDOW	1200 X 1500	GLASS
8	GLASS WINDOW	1200 X 1500	GLASS
9	GLASS WINDOW	1200 X 1500	GLASS
10	GLASS WINDOW	1200 X 1500	GLASS
11	GLASS WINDOW	1200 X 1500	GLASS
12	GLASS WINDOW	1200 X 1500	GLASS
13	GLASS WINDOW	1200 X 1500	GLASS
14	GLASS WINDOW	1200 X 1500	GLASS
15	GLASS WINDOW	1200 X 1500	GLASS
16	GLASS WINDOW	1200 X 1500	GLASS
17	GLASS WINDOW	1200 X 1500	GLASS
18	GLASS WINDOW	1200 X 1500	GLASS
19	GLASS WINDOW	1200 X 1500	GLASS
20	GLASS WINDOW	1200 X 1500	GLASS

Note:
1. BUILDING HAS AUTOMATIC SPRINKLER SYSTEM WHEREVER REQUIRED BY NBC.
2. BUILDING WILL BE DESIGNED (STRUCTURE) AS PER RELEVANT CODES FOR EARTH QUAKE RESISTANCE.
3. BUILDING IS ARTIFICIALLY LIGHTED MECHANICALLY VENTILATED & CENTRALLY AIR-CONDITIONED.

- LEGEND:-
1. 100% SOLID & VENT PIPE
 2. 100% WASTE & VENT PIPE
 3. 75% ANTI-SIPHONAGE VENT PIPE(SOL)
 4. 75% ANTI-SIPHONAGE VENT PIPE(WASTE)
 5. 100% SOLID PIPE
 6. 100% WASTE PIPE
 7. 75% WASTE PIPE
 8. 50% ANTI-SIPHONAGE PIPE(SOL)
 9. 50% ANTI-SIPHONAGE PIPE(WASTE)
 10. 50% WASTE PIPE
 11. 40% SOLID/WASTE PIPE
 12. 20% WASTE PIPE
 13. COLD WATER SUPPLY (DOMESTIC) 10% FMS PIPE
 14. COLD WATER SUPPLY (DOMESTIC) 10% FMS PIPE
 15. COLD WATER SUPPLY (DOMESTIC) RISER TO CH
 16. COLD WATER SUPPLY (DOMESTIC) RISER TO CH
 17. COLD WATER SUPPLY (DOMESTIC) RISER TO CH

Project:
REVISED BUILDING PLAN OF I.T. PARK MEASURING 8.793 ACRES (LICENCE NO. 1133 OF DATED 22.9.2006) IN SECTOR-27 B FARIDABAD BEING DEVELOPED BY M/S. VATIKA I.T. PARK PVT. LTD. PREVIOUSLY KNOWN AS HIND ENTERPRISES PVT. LTD.


Associate Architects
RSMS ARCHITECTS
RSMS ARCHITECTS PVT. LTD.
69, Nara Nivas, Bhawani Kunj (Behind D2), Vasant Kunj, New Delhi-110070.
Tel.: 011-26898616, 26898617
www.rsms-arch.com

Sanctioned by:
Date: 05.05.2012
For Vatika I.T. Park Pvt. Ltd.
Architect's Seal & Signature: [Signature]
Owner's Seal & Signature: [Signature]
MAY, 2012 Scale: 1:100
Drawing Title: GROUND & 1ST FLOOR PLAN (BLOCK-D)
Drawing No.: D-01

For VATIKA LIMITED
Authorized Signatory: [Signature]



2nd FLOOR PLAN
LVL +9550
BLOCK-D

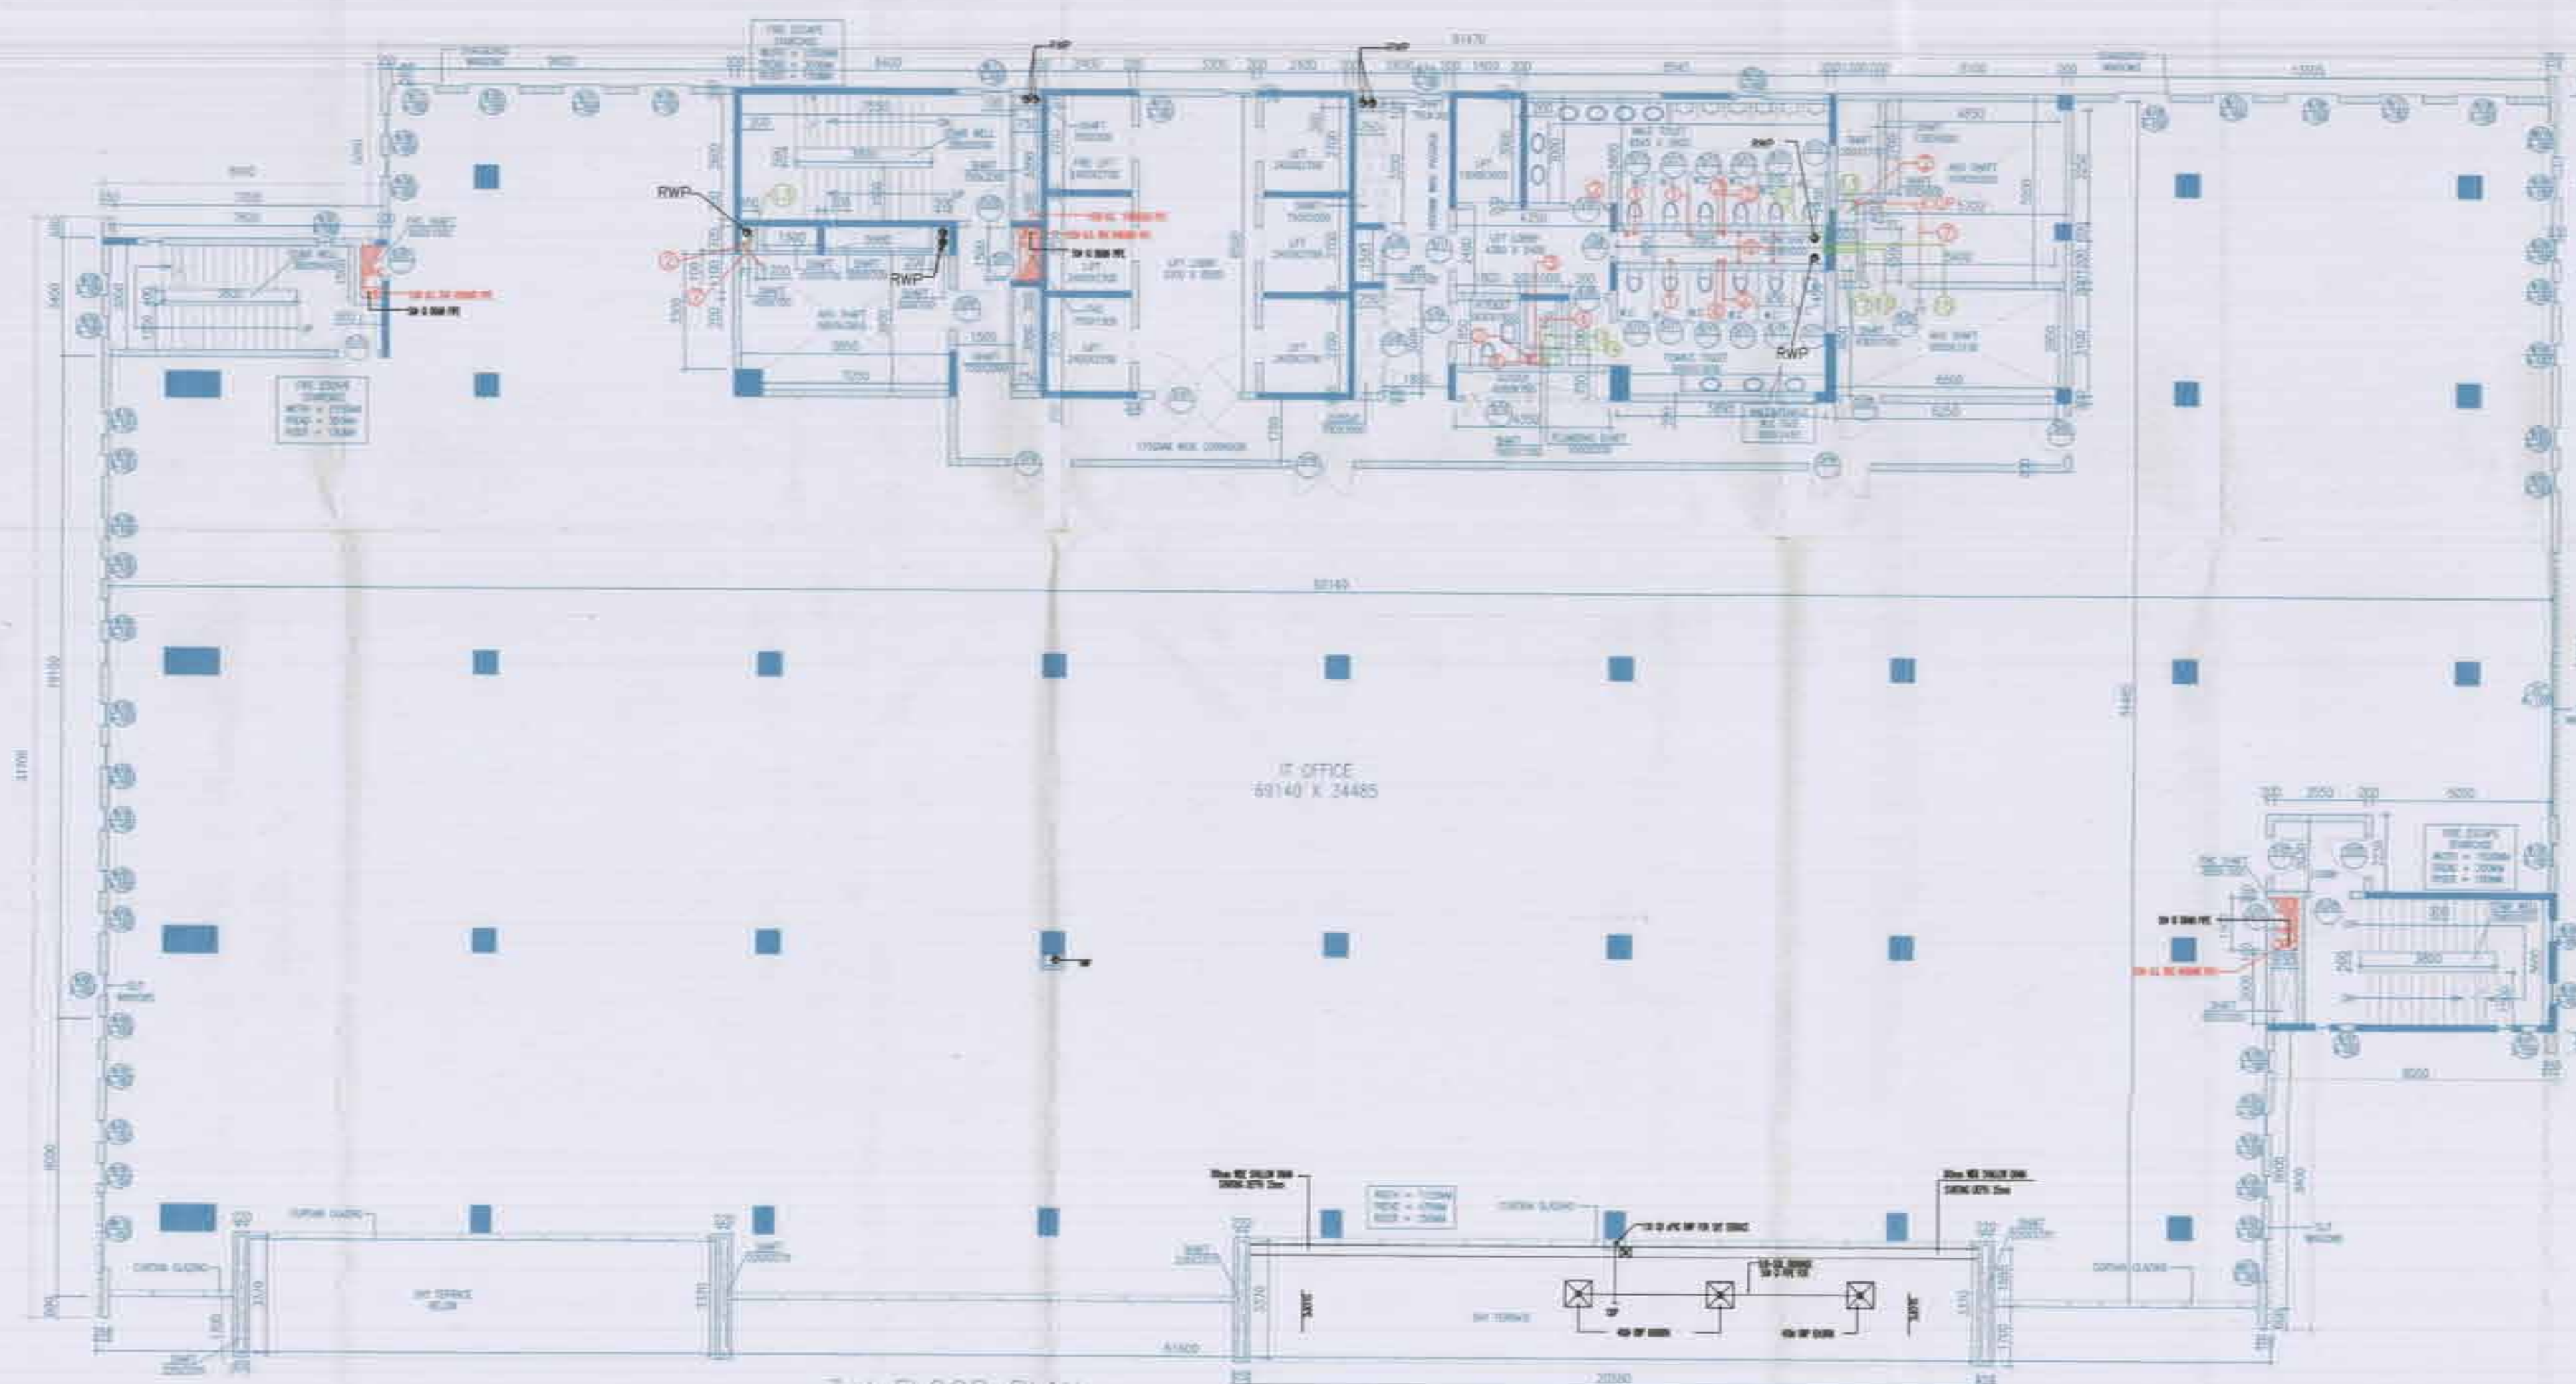

3rd FLOOR PLAN
LVL +13400
BLOCK-D

Note:-

1. BUILDING HAS AUTOMATIC SPRINKLER SYSTEM WHEREVER REQUIRED BY NBC.
2. BUILDING WILL BE DESIGNED (STRUCTURES) AS PER RELEVANT IS CODES FOR EARTH QUAKE RESISTANCE.
3. BUILDING IS ARTIFICIALLY LIGHTED MECHANICALLY VENTILATED & CENTRALLY AIR-CONDITIONED.

LEGEND:-

1. 100# SOIL & VENT PIPE
2. 100# WASTE & VENT PIPE
3. 75# ANTI-SYPHONAGE VENT PIPE(SOIL)
4. 75# ANTI-SYPHONAGE VENT PIPE(WASTE)
5. 100# SOIL PIPE
6. 100# WASTE PIPE
7. 75# WASTE PIPE
8. 50# ANTI-SYPHONAGE PIPE(SOIL)
9. 50# ANTI-SYPHONAGE PIPE(WASTE)
10. 50# WASTE PIPE
11. 40# SOIL/WASTE PIPE
12. 32# WASTE PIPE
13. COLD WATER SUPPLY(DOMESTIC) ON TAKE PIPE
14. COLD WATER SUPPLY(FLUSHING) ON TAKE PIPE
15. COLD WATER SUPPLY(DOMESTIC) RISER TO OHT
16. COLD WATER SUPPLY(FLUSHING) RISER TO OHT
17. COLD WATER SUPPLY(SOFT WATER) RISER TO OHT

Project:-

REVISED BUILDING PLAN OF I.T PARK MEASURING 8.793 ACRES (LICENCE NO. 1133 OF DATED 22.9.2006) IN SECTOR-27 B FARIDABAD BEING DEVELOPED BY M/S VATIKA IT PARK PVT. LTD. PREVIOUSLY KNOWN AS HIND ENTERPRISES PVT. LTD.

Associate Architects

RISMS ARCHITECTS

RISMS ARCHITECTS PVT. LTD.
69, Nara Niwas, Bhawani Kunj
(Behind D2), Vasant Kunj,
New Delhi-110070.
Tel: 011-26838616, 26838617
www.risms-arch.com

Seal of the Architect
Seal of the Engineer
Seal of the Surveyor


Checked and found to be correct
As per the drawings of the project

Seal of the Architect
Seal of the Engineer
Seal of the Surveyor


ARCHITECT'S SEAL & SIGNATURE	OWNER'S SEAL & SIGNATURE
MAY, 2012	Scale: 1:100
Drawing Title:- 2ND & 3RD FLOOR PLAN (BLOCK-D)	Drawing No:- D-02

For VATIKA LIMITED

Authorized Signatory

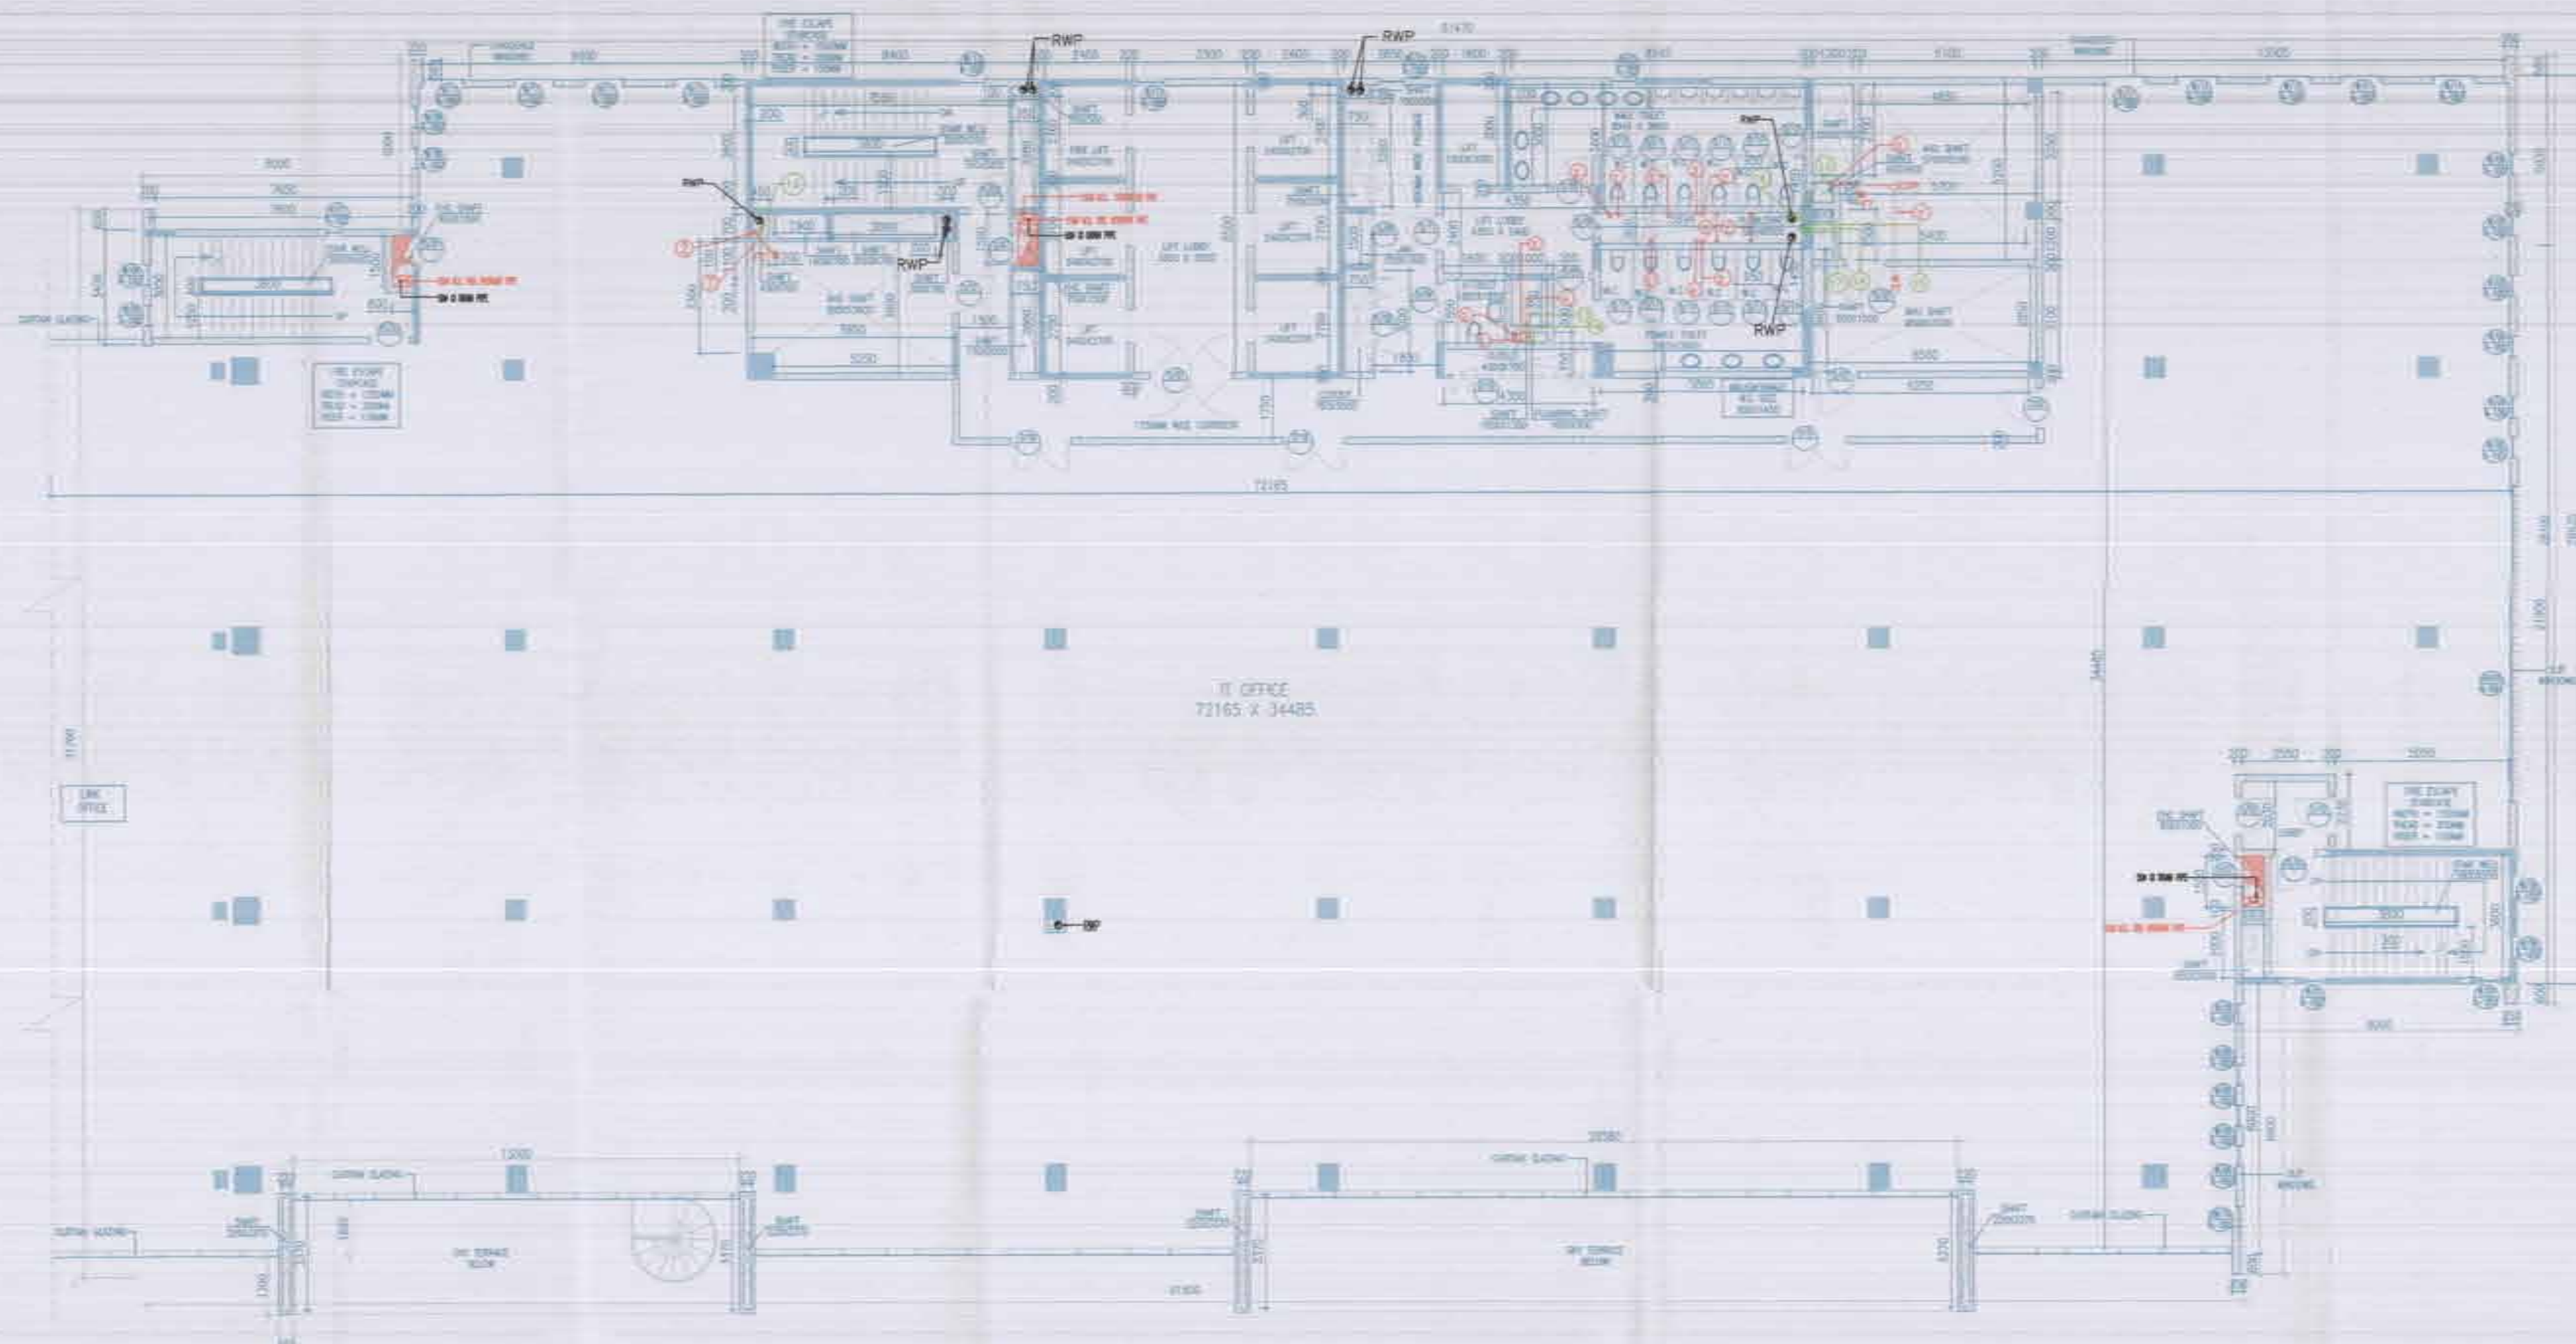

4th FLOOR PLAN
LVL +17250
BLOCK-D

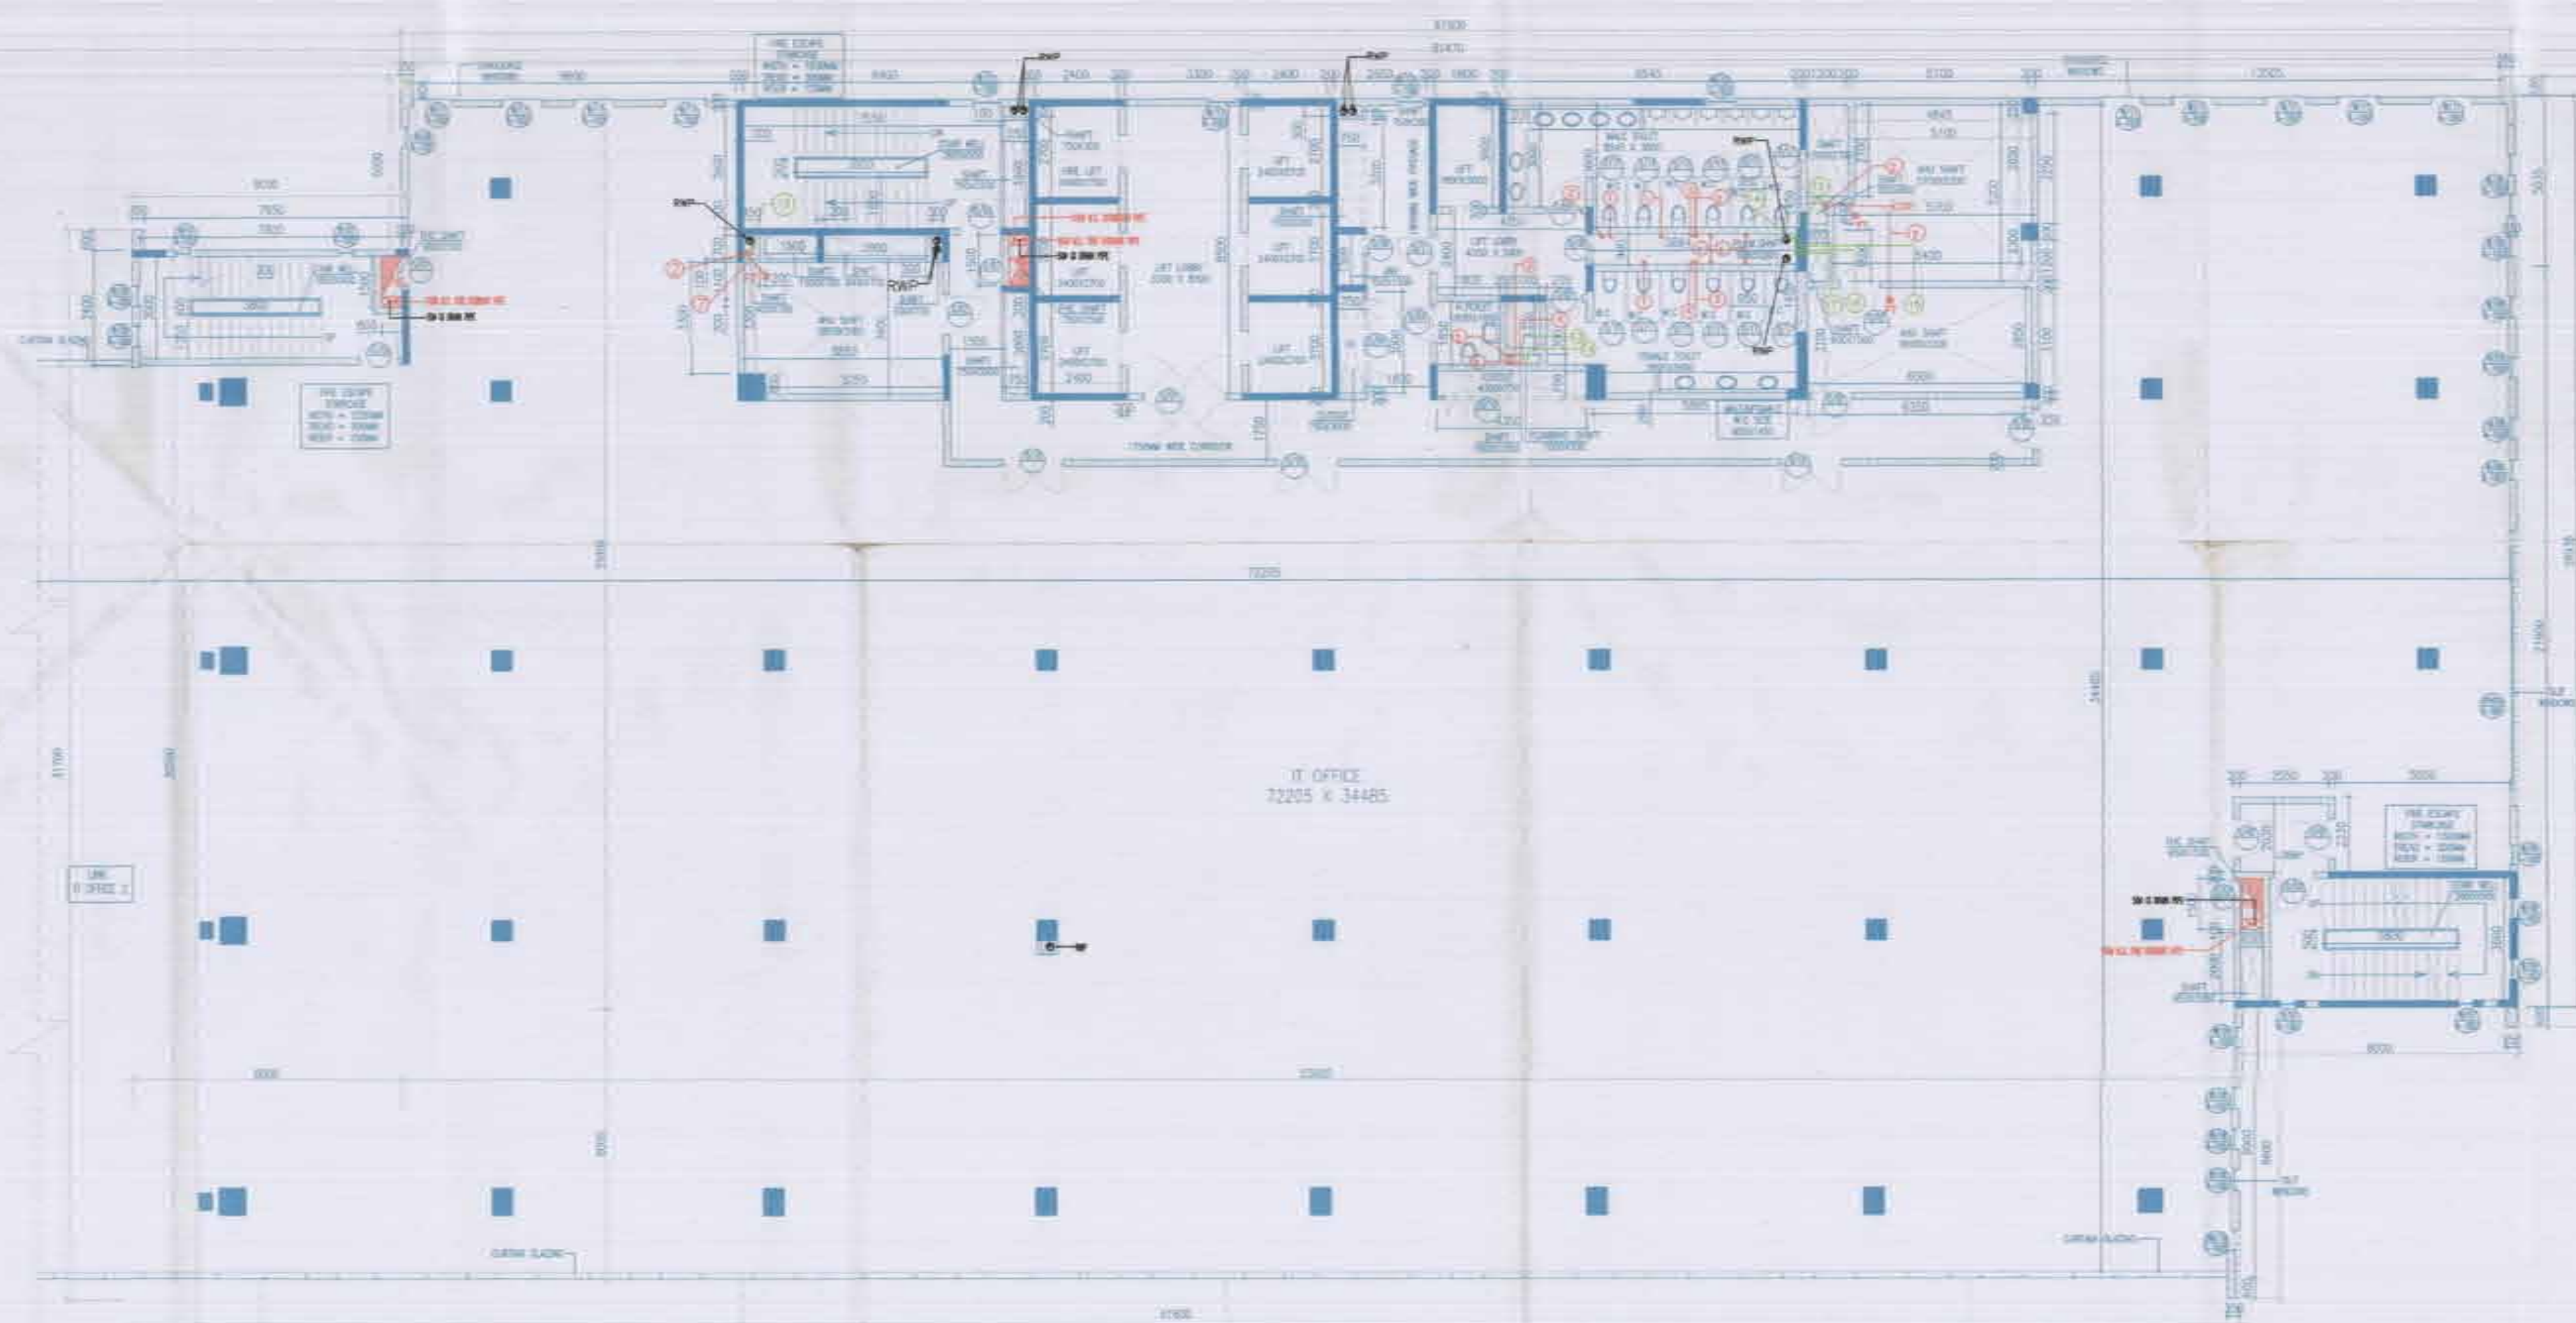

5th FLOOR PLAN
LVL +21100
BLOCK-D

- LEGEND:**
- 1. 100% CIVIL & MECH. PIPING
 - 2. 100% MECH. & ELEC. PIPING
 - 3. 100% MECH. & ELEC. PIPING
 - 4. 100% MECH. & ELEC. PIPING
 - 5. 100% MECH. & ELEC. PIPING
 - 6. 100% MECH. & ELEC. PIPING
 - 7. 100% MECH. & ELEC. PIPING
 - 8. 100% MECH. & ELEC. PIPING
 - 9. 100% MECH. & ELEC. PIPING
 - 10. 100% MECH. & ELEC. PIPING
 - 11. 100% MECH. & ELEC. PIPING
 - 12. 100% MECH. & ELEC. PIPING
 - 13. 100% MECH. & ELEC. PIPING
 - 14. 100% MECH. & ELEC. PIPING
 - 15. 100% MECH. & ELEC. PIPING
 - 16. 100% MECH. & ELEC. PIPING
 - 17. 100% MECH. & ELEC. PIPING
 - 18. 100% MECH. & ELEC. PIPING
 - 19. 100% MECH. & ELEC. PIPING
 - 20. 100% MECH. & ELEC. PIPING

Note:-

- 1. BUILDING HAS AUTOMATIC SPRINKLER SYSTEM WHEREVER REQUIRED BY NBC.
- 2. BUILDING WILL BE DESIGNED TO STRUCTURE I.
- 3. BUILDING IS ARTIFICIALLY LIGHTED MECHANICALLY VENTILATED & CENTRALLY AIR-CONDITIONED.

LEGEND:-

Project:

REVISED BUILDING PLAN OF IT PARK MEASURING 8.793 ACRES (LICENCE NO. 1133 OF DATED 22.9.2006) IN SECTOR-27 B FARIDABAD BEING DEVELOPED BY M/S. VATIKA IT PARK PVT. LTD. PREVIOUSLY KNOWN AS: HIND ENTERPRISES PVT. LTD.

Associate Architects

RISMS
ARCHITECTS

RISMS ARCHITECTS PVT. LTD.
69, Nara Niwas, Bhawani Kunj
(Behind D2), Vasant Kunj,
New Delhi-110070.
Tel: 011-26598616, 26598617
www.risms-arch.com

Sanctioned by the Local Authority

Sanctioned by the Local Authority

Sanctioned by the Local Authority


Sanctioned by the Local Authority

ARCHITECT'S SEAL & SIGNATURE: *[Signature]*
OWNER'S SEAL & SIGNATURE: *[Signature]*

MAY, 2012 Scale: 1:100
Drawing Title: 4TH & 5TH FLOOR PLAN (BLOCK-D)
Drawing No: 0-03

For VATIKA LIMITED

[Signature]
Authorized Signatory

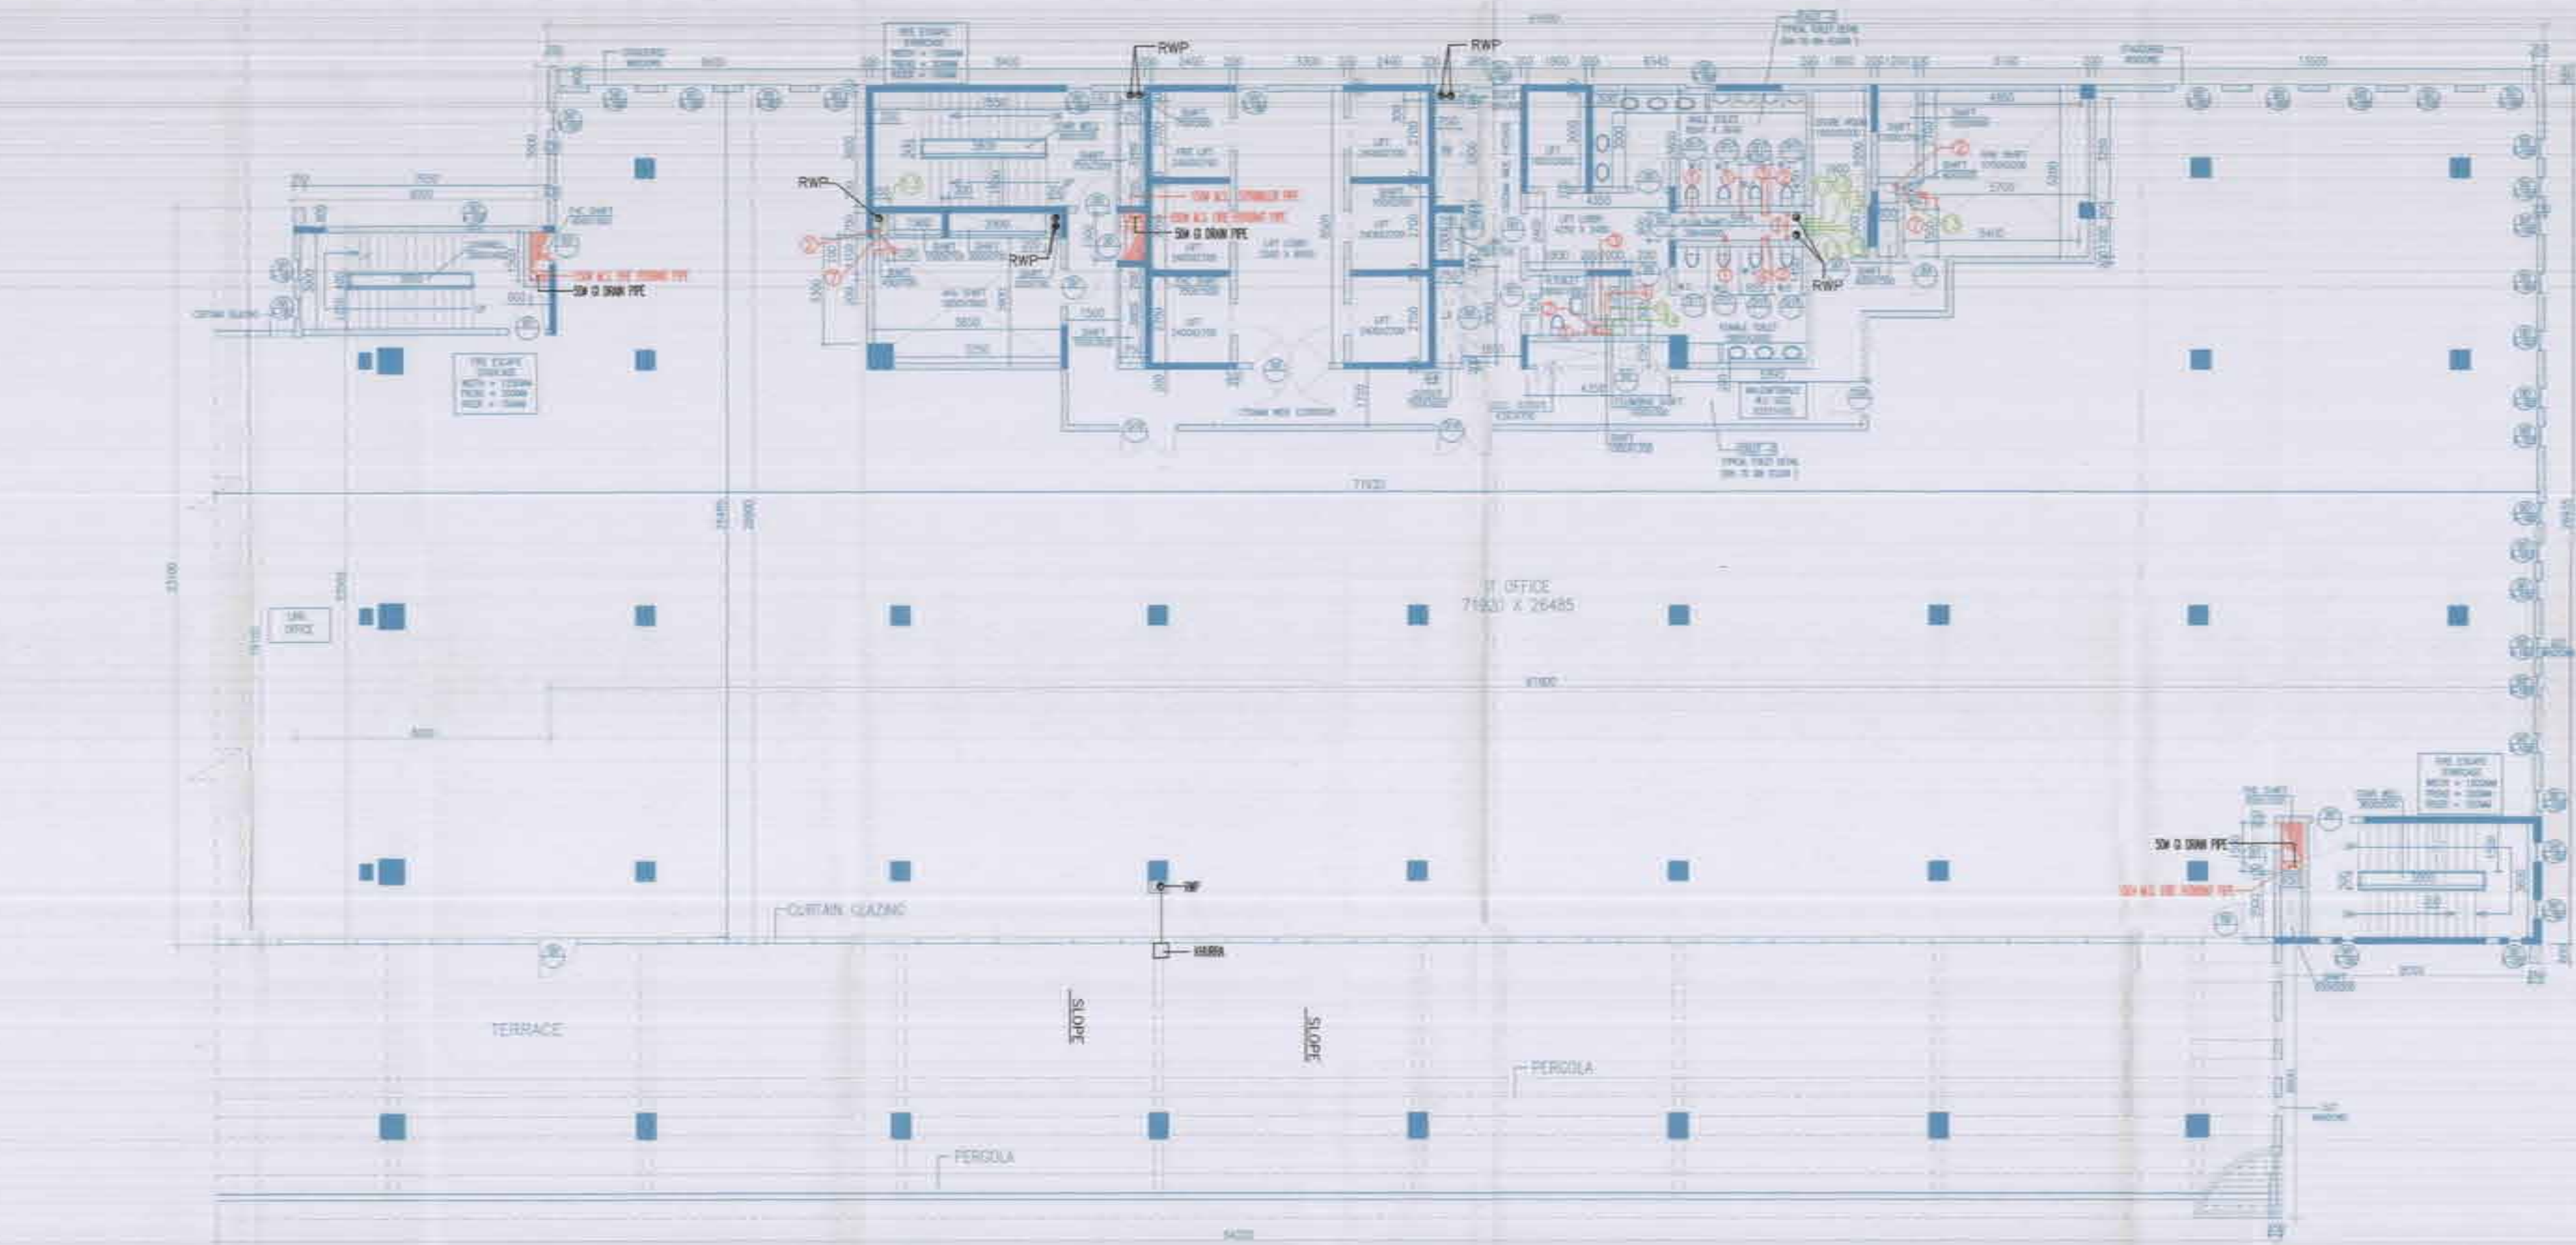

6th FLOOR PLAN
LVL +24950
BLOCK-D



7th FLOOR
LVL +28800
BLOCK - D

- LEGEND:-**
- 1. R/W AS PER CITY PLAN
 - 2. R/W AS PER CITY PLAN
 - 3. R/W AS PER CITY PLAN
 - 4. R/W AS PER CITY PLAN
 - 5. R/W AS PER CITY PLAN
 - 6. R/W AS PER CITY PLAN
 - 7. R/W AS PER CITY PLAN
 - 8. R/W AS PER CITY PLAN
 - 9. R/W AS PER CITY PLAN
 - 10. R/W AS PER CITY PLAN
 - 11. R/W AS PER CITY PLAN
 - 12. R/W AS PER CITY PLAN
 - 13. R/W AS PER CITY PLAN
 - 14. R/W AS PER CITY PLAN
 - 15. R/W AS PER CITY PLAN
 - 16. R/W AS PER CITY PLAN
 - 17. R/W AS PER CITY PLAN

Note:-

1. BUILDING HAS AUTOMATIC SPRINKLER SYSTEM WHEREVER REQUIRED BY NBC
2. BUILDING WILL BE DESIGNED (STRUCTURES) AS PER IS 456:2000
3. BUILDING IS ARTIFICIALLY LIGHTED MECHANICALLY VENTILATED & CENTRALLY AIR-CONDITIONED

LEGEND:-

Project:

REVISED BUILDING PLAN OF IT PARK MEASURING 8.793 ACRES (LICENCE NO. 11133 OF DATED 22.9.2006) IN SECTOR-27 B FARIDABAD BEING DEVELOPED BY M/S. VATIKA IT PARK PVT. LTD. PREVIOUSLY KNOWN AS HIND ENTERPRISES PVT. LTD.




RSMS ARCHITECTS

ARCHITECTS PVT. LTD.
69, Nara Niwas, Bhawani Kunj,
(Behind D2), Vasant Kunj,
New Delhi-110070
Tel: 011-26898616, 26898617
www.rsms-arch.com

ARCHITECT'S SEAL & SIGNATURE		OWNER'S SEAL & SIGNATURE	
MAY, 2012		Scale: 1:100	
Drawing Title:-		Drawing No:-	
6TH & 7TH FLOOR PLAN (BLOCK-D)		D-04	

For VATIKA LIMITED

Authorized Signatory

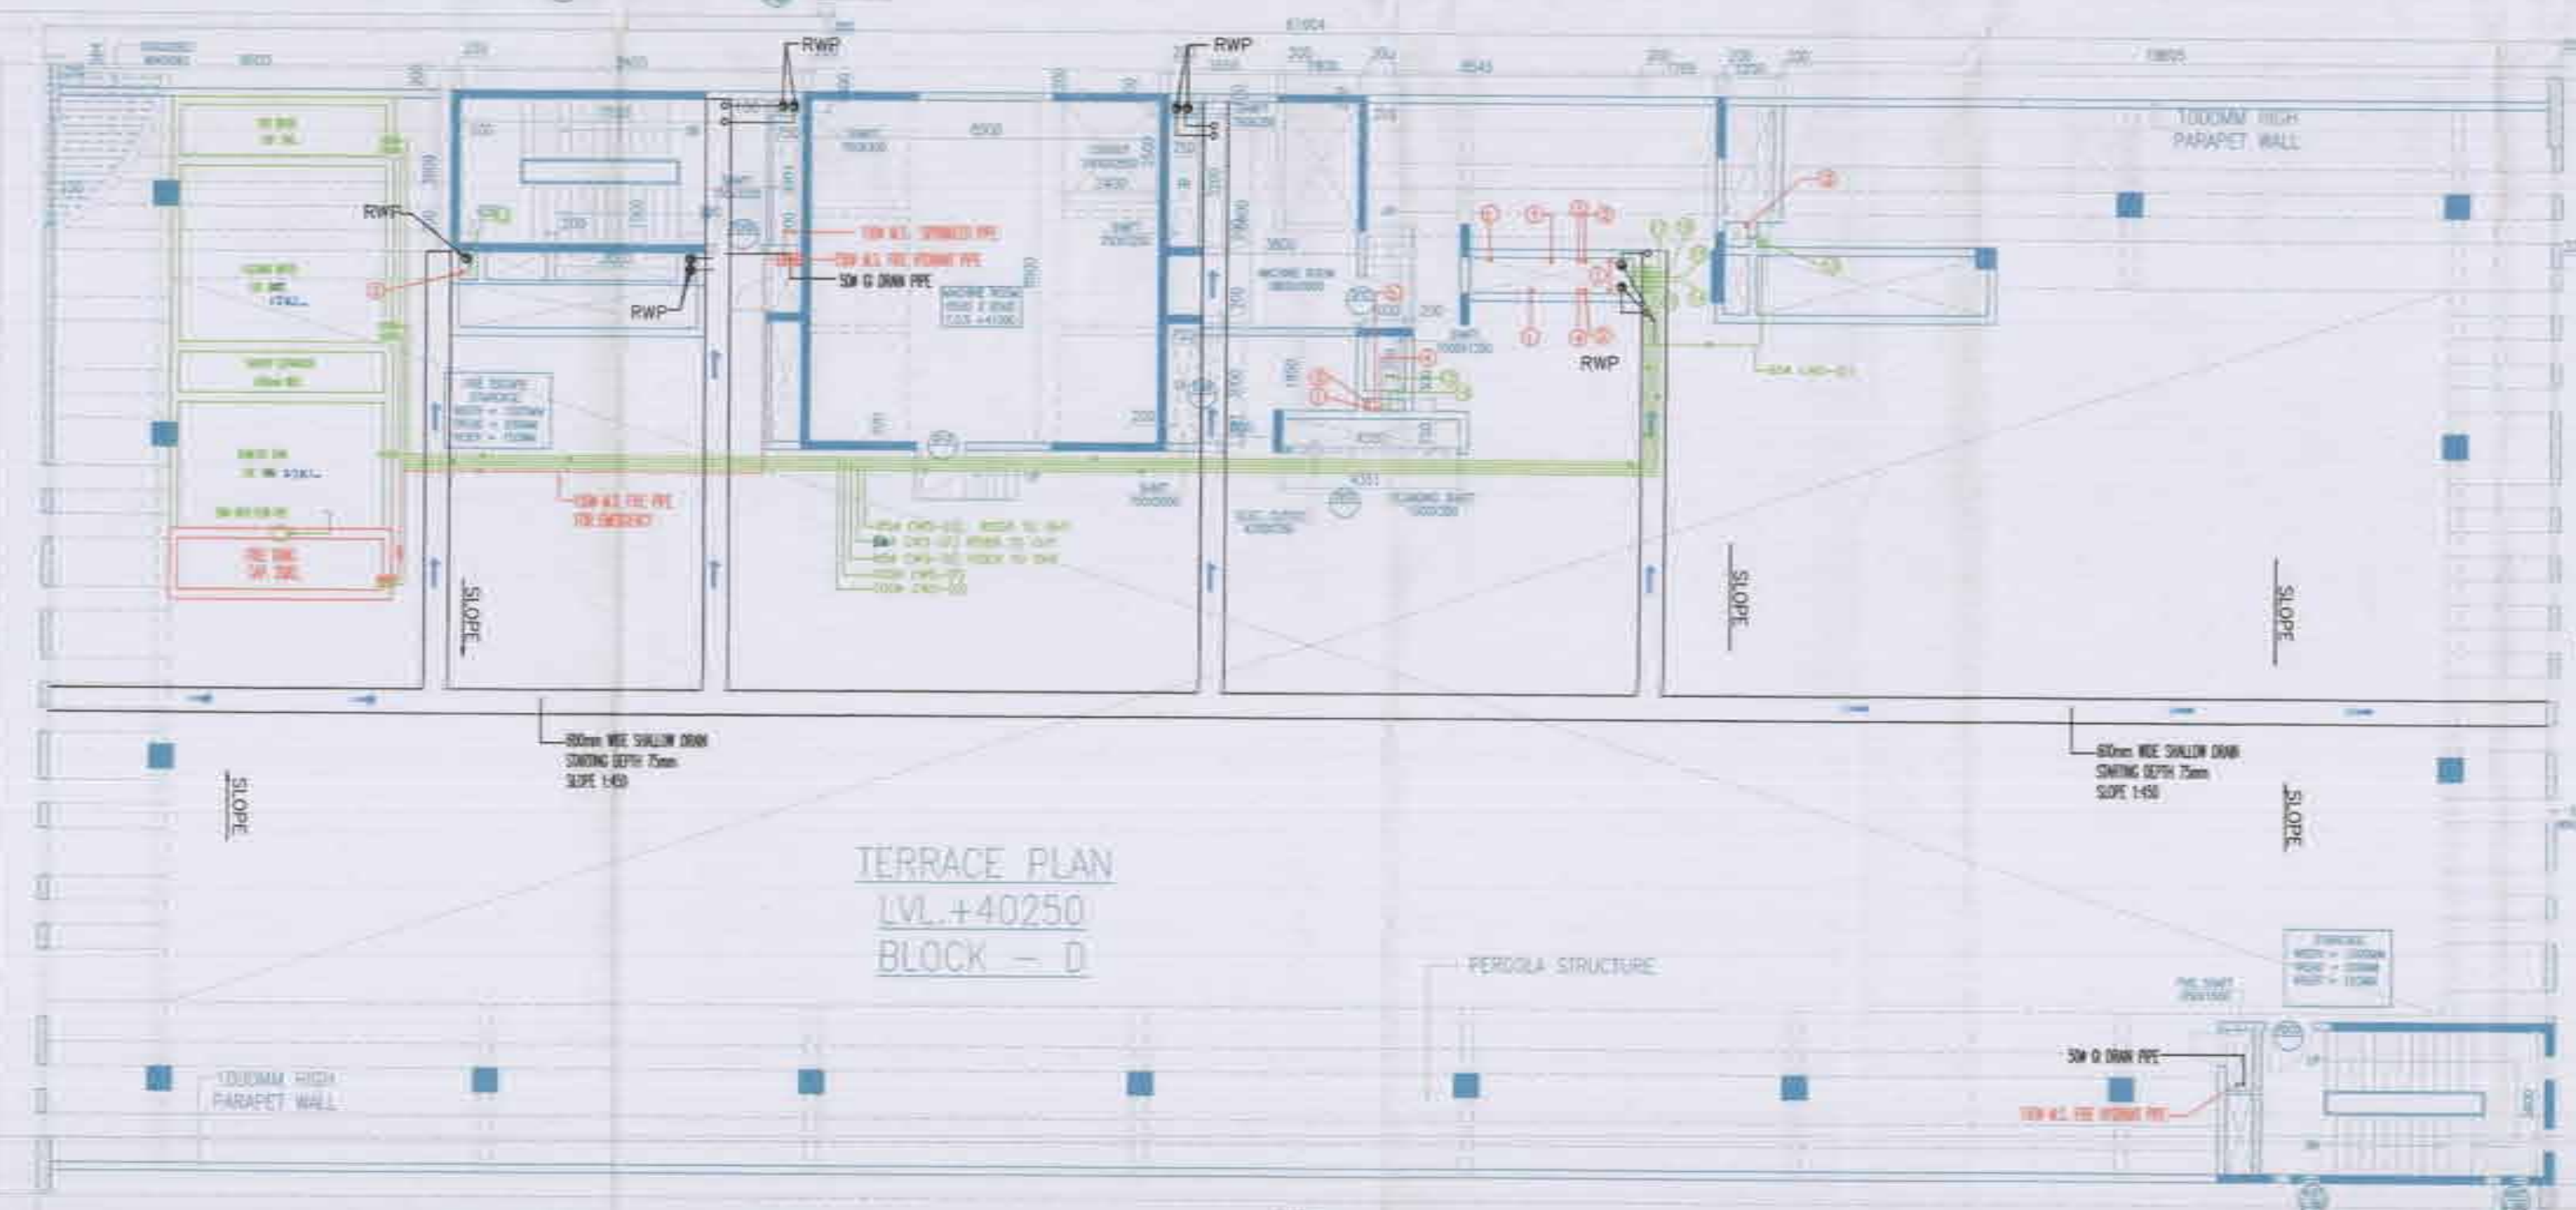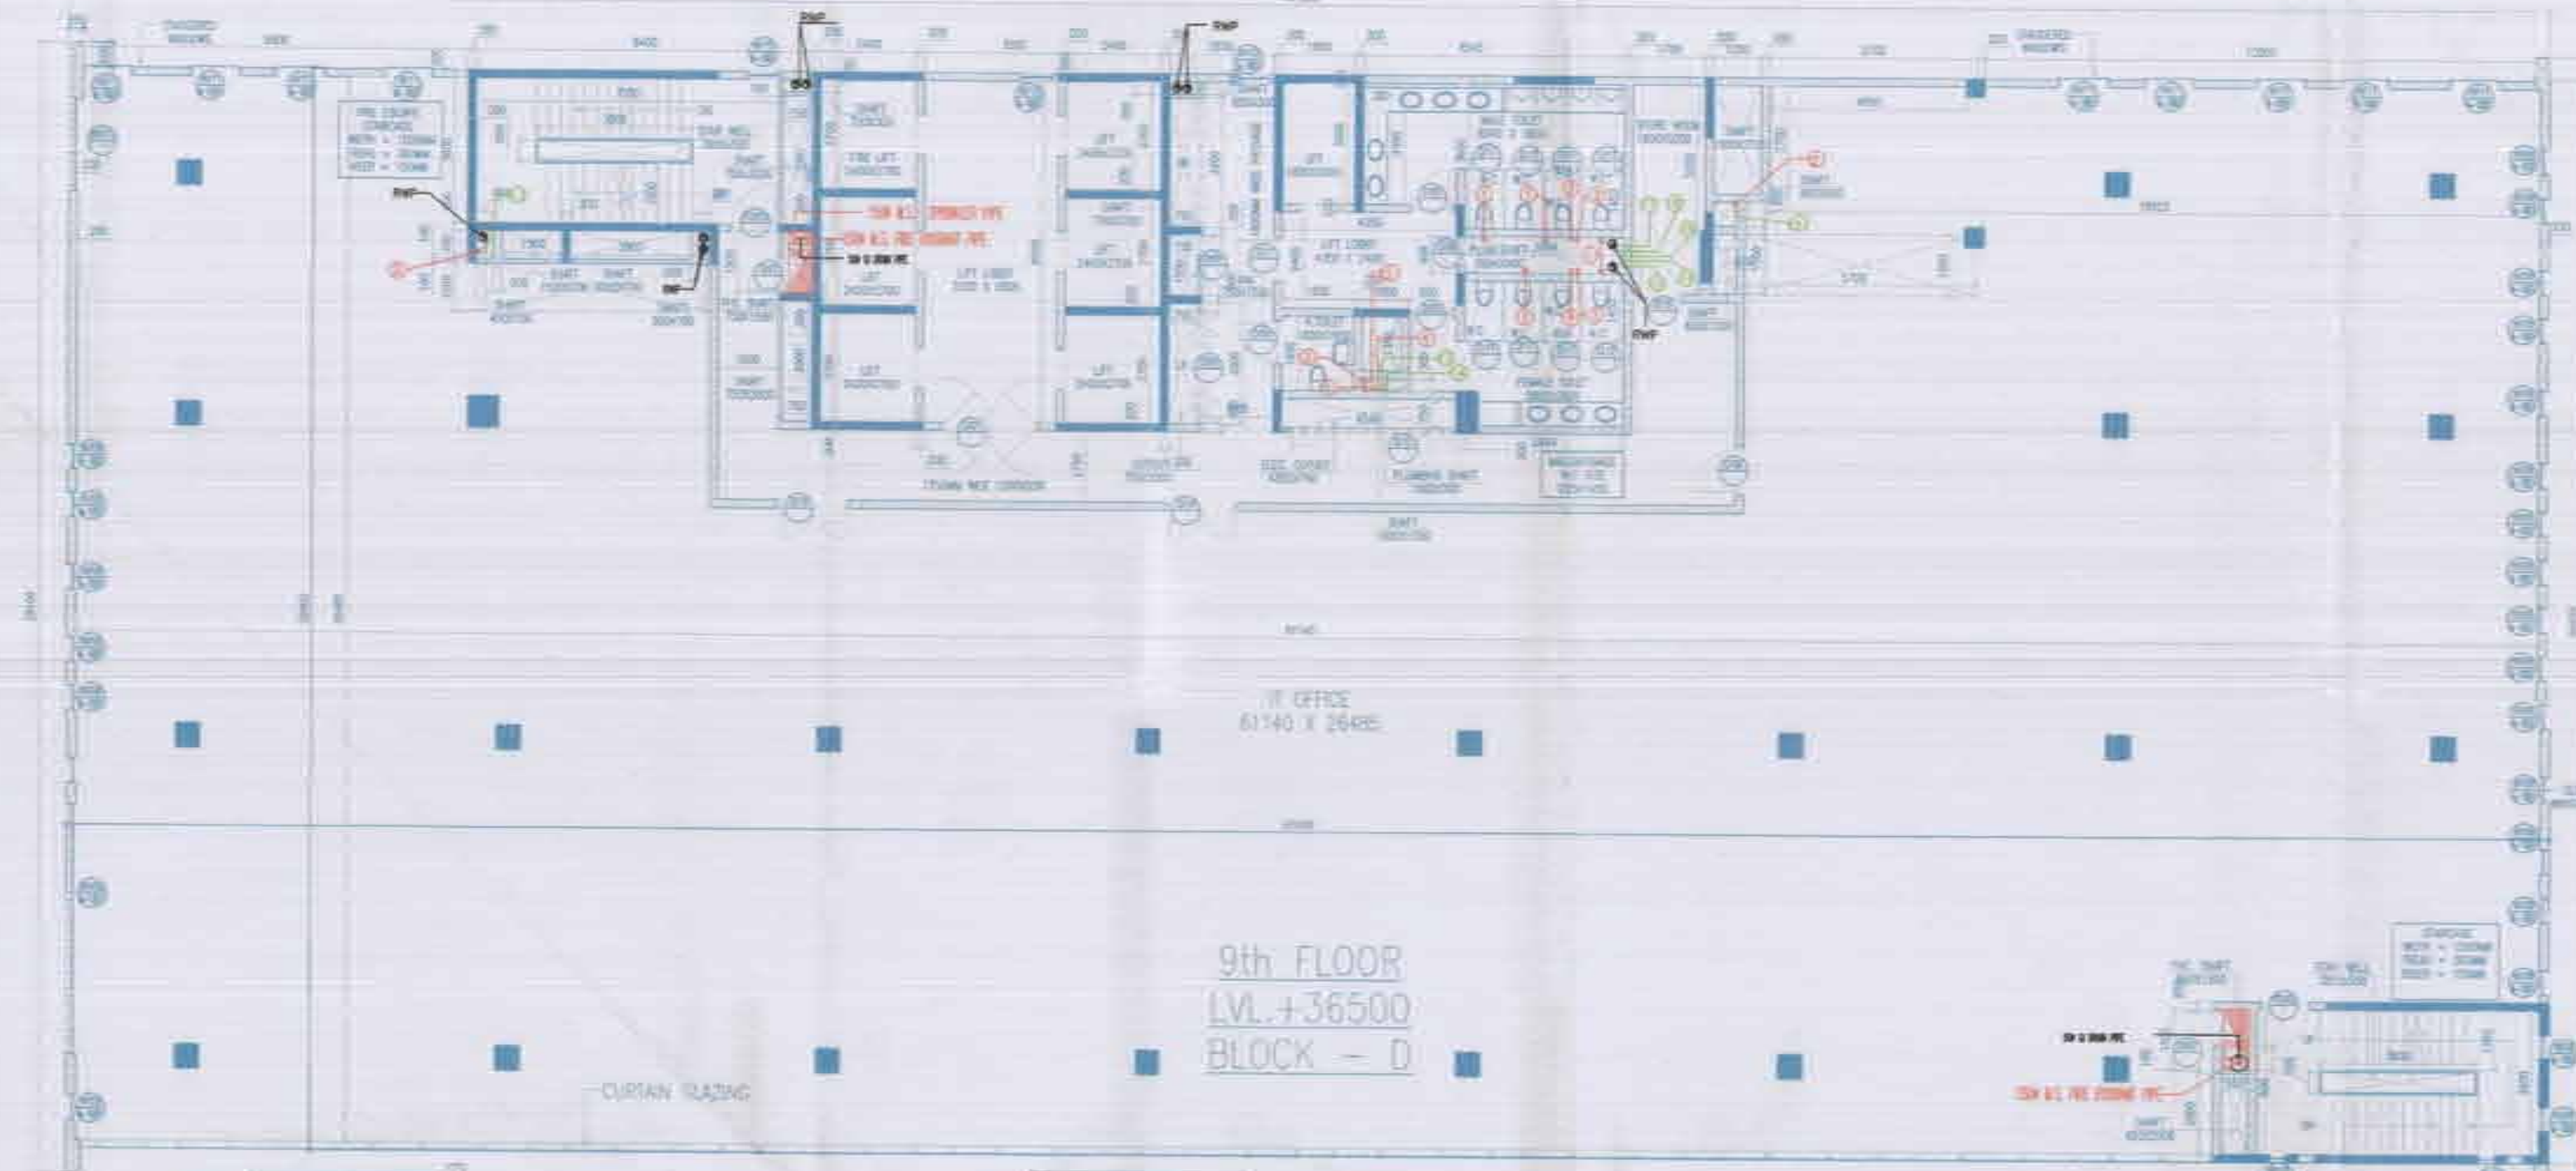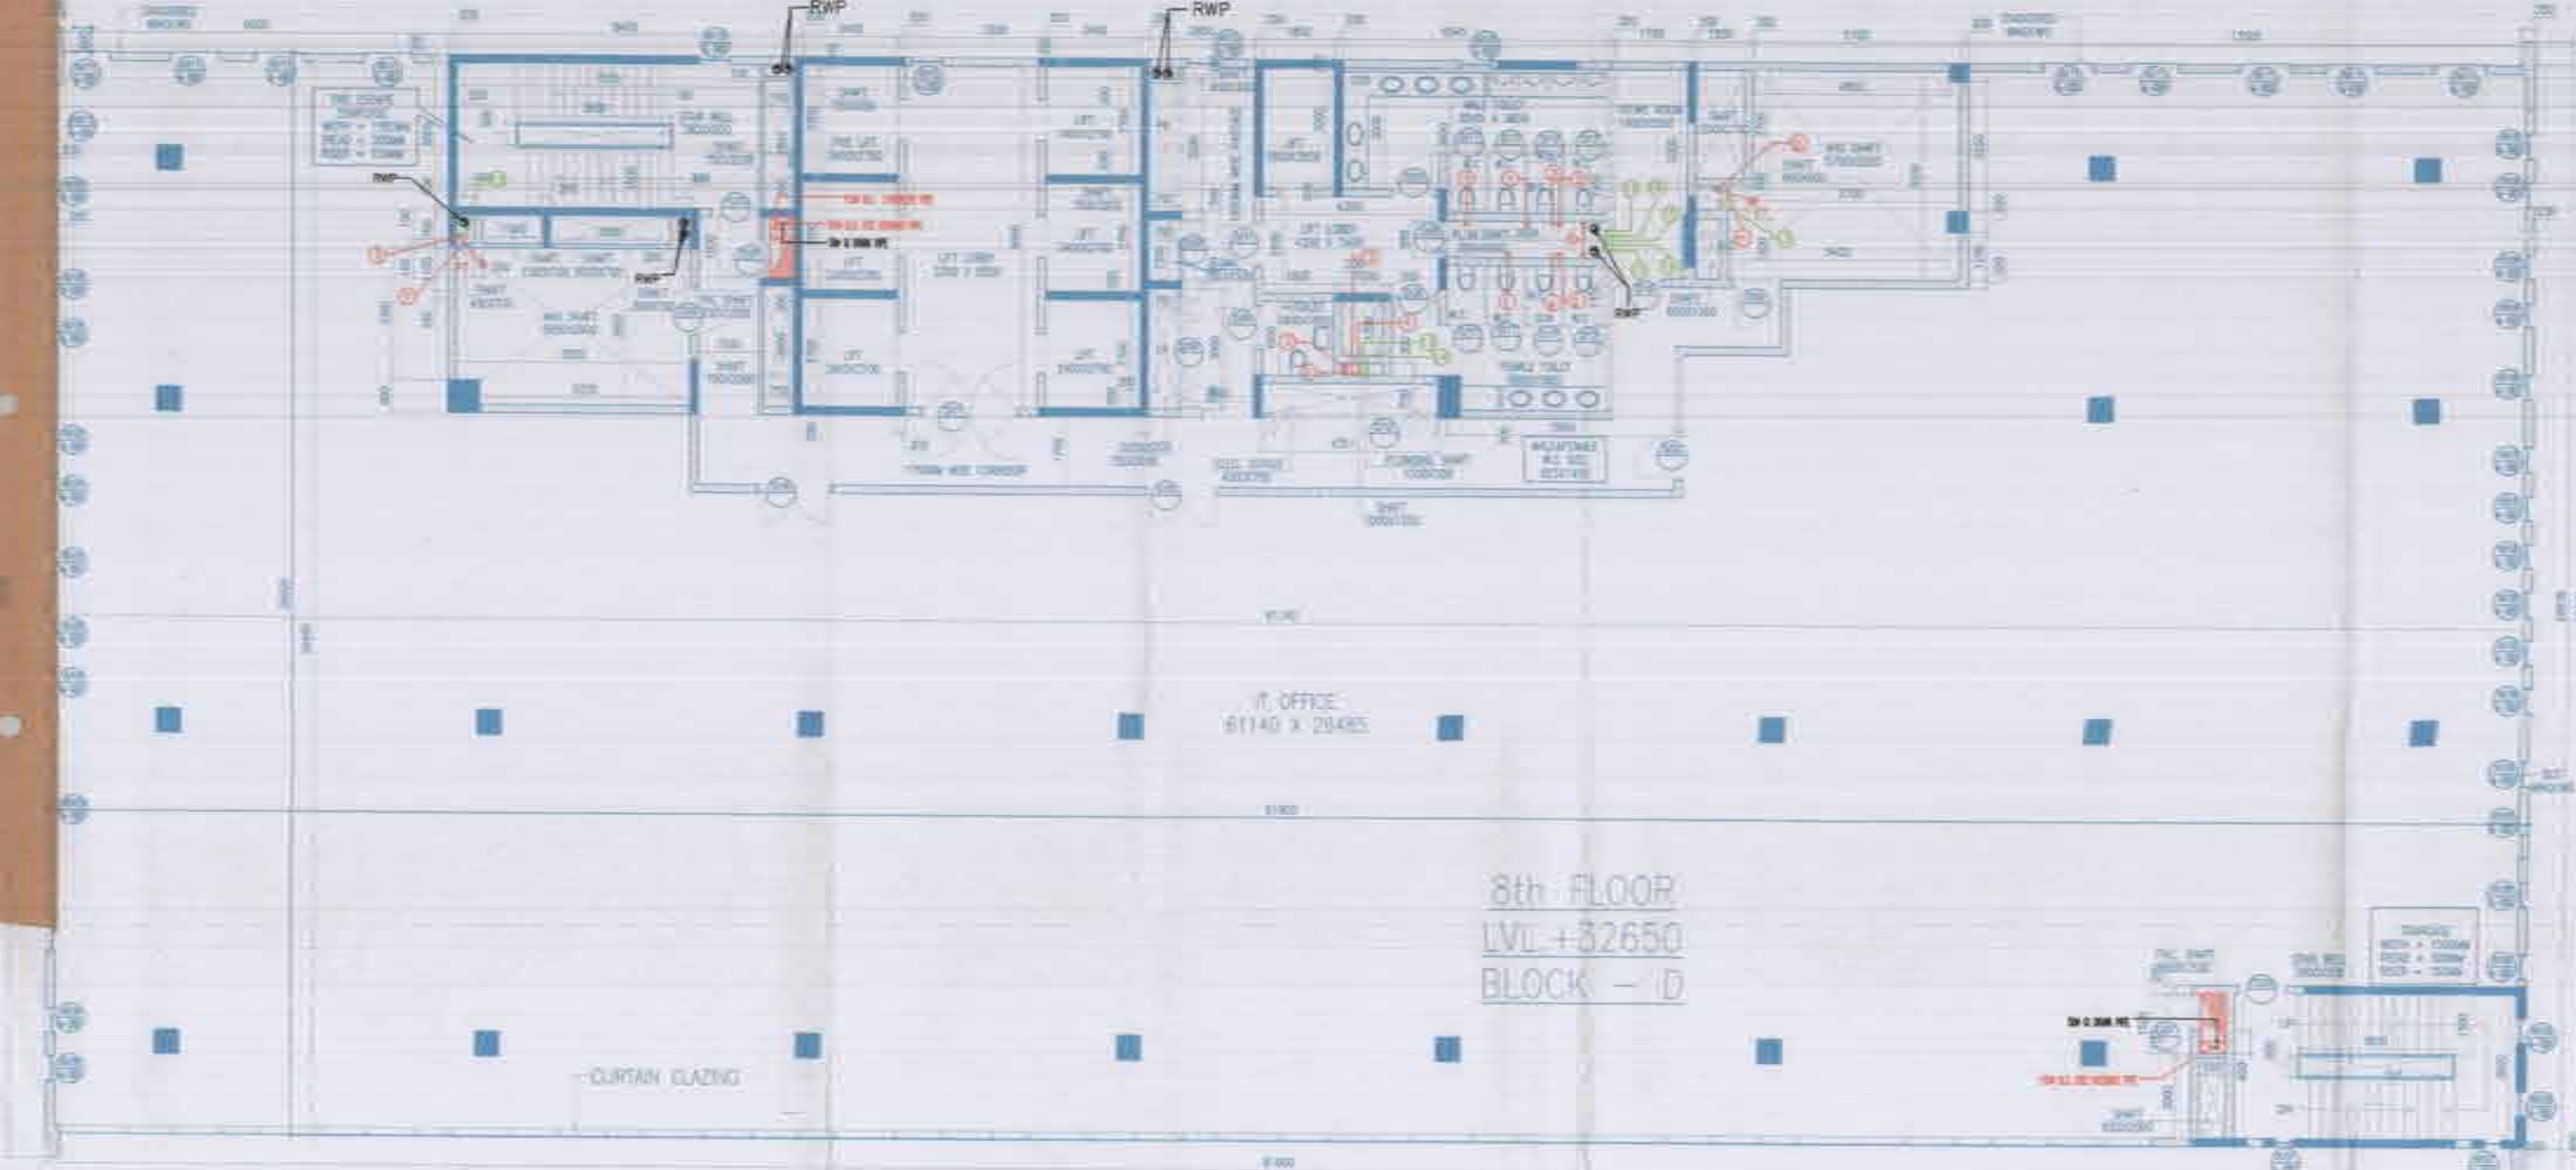

- Note:-**
1. BUILDING HAS AUTOMATIC SPRINKLER SYSTEM WHEREVER REQUIRED BY NBC
 2. BUILDING WILL BE DESIGNED (STRUCTURES) AS PER RELEASED IS CODES FOR EARTH QUAKE RESISTANCE
 3. BUILDING IS ARTIFICIALLY LIGHTED MECHANICALLY VENTILATED & CENTRALLY AIRCONDITIONED

- LEGEND:-**
- 1. 100mm dia. & 100mm deep
 - 2. 100mm dia. & 100mm deep
 - 3. 100mm dia. & 100mm deep
 - 100. 100mm dia. & 100mm deep

Project:
REVISED BUILDING PLAN OF I.T. PARK MEASURING 8.793 ACRES (LICENCE NO. 1133 OF DATED 22.9.2006) IN SECTOR-27 'B' FARIDABAD BEING DEVELOPED BY M/S. VATIKA I.T. PARK PVT. LTD. PREVIOUSLY KNOWN AS: HIND ENTERPRISES PVT. LTD.

Associate Architects:
RISMS ARCHITECTS
RISMS ARCHITECTS PVT. LTD.
B9, Nara Niwas - Bhawani Kunj (Behind D2), Vasant Kunj, New Delhi-110070.
Tel.: 011-26898616, 26898617
www.risms-arch.com

ARCHITECT'S SEAL & SIGNATURE OWNER'S SEAL & SIGNATURE For Vatika IT Park Pvt. Ltd.	
DATE: 2012 Scale: 1:100	Drawing No: D-05
Drawing Title: 8TH, 9TH FLOOR & TERRACE PLAN & TOILET DETAIL (BLOCK - D)	

For VATIKA LIMITED
Authorized Signatory

