

1. BUILDING WILL BE DESIGNED (STRUCTURES) AS PER RELEVANT IS CODES FOR EARTH QUAKE RESISTANCE.

SR	DOOR AND WINDOW		HEIGHT	SILL	JAMBLINE	FINISH
	NAME	QTY				
1	D1	900	2400	0	2400	-
2	D1	800	2400	0	2400	-
3	D1	900	2400	0	2400	-
4	D18	750	2635	0	2635	-
5	D3	1000	2400	0	2400	-
6	D31	900	2600	0	2600	-
7	D31	900	2600	0	2600	-
8	S22	1600	2600	0	2600	-
9	S22A	1600	2600	0	2600	-
10	D1	875	2600	0	2600	-
11	D1	875	2600	0	2600	-
12	W1	1100	1350	2450	-	-
13	W13	725	1100	1350	2450	-
14	D1	900	2600	0	2600	-
15	D1	900	2600	0	2600	-
16	D12	1200	2600	0	2400	2400
17	D13	1000	2600	0	2350	2400
18	D13	1000	2600	0	2350	2400
19	F14	900	2600	0	2150	2400

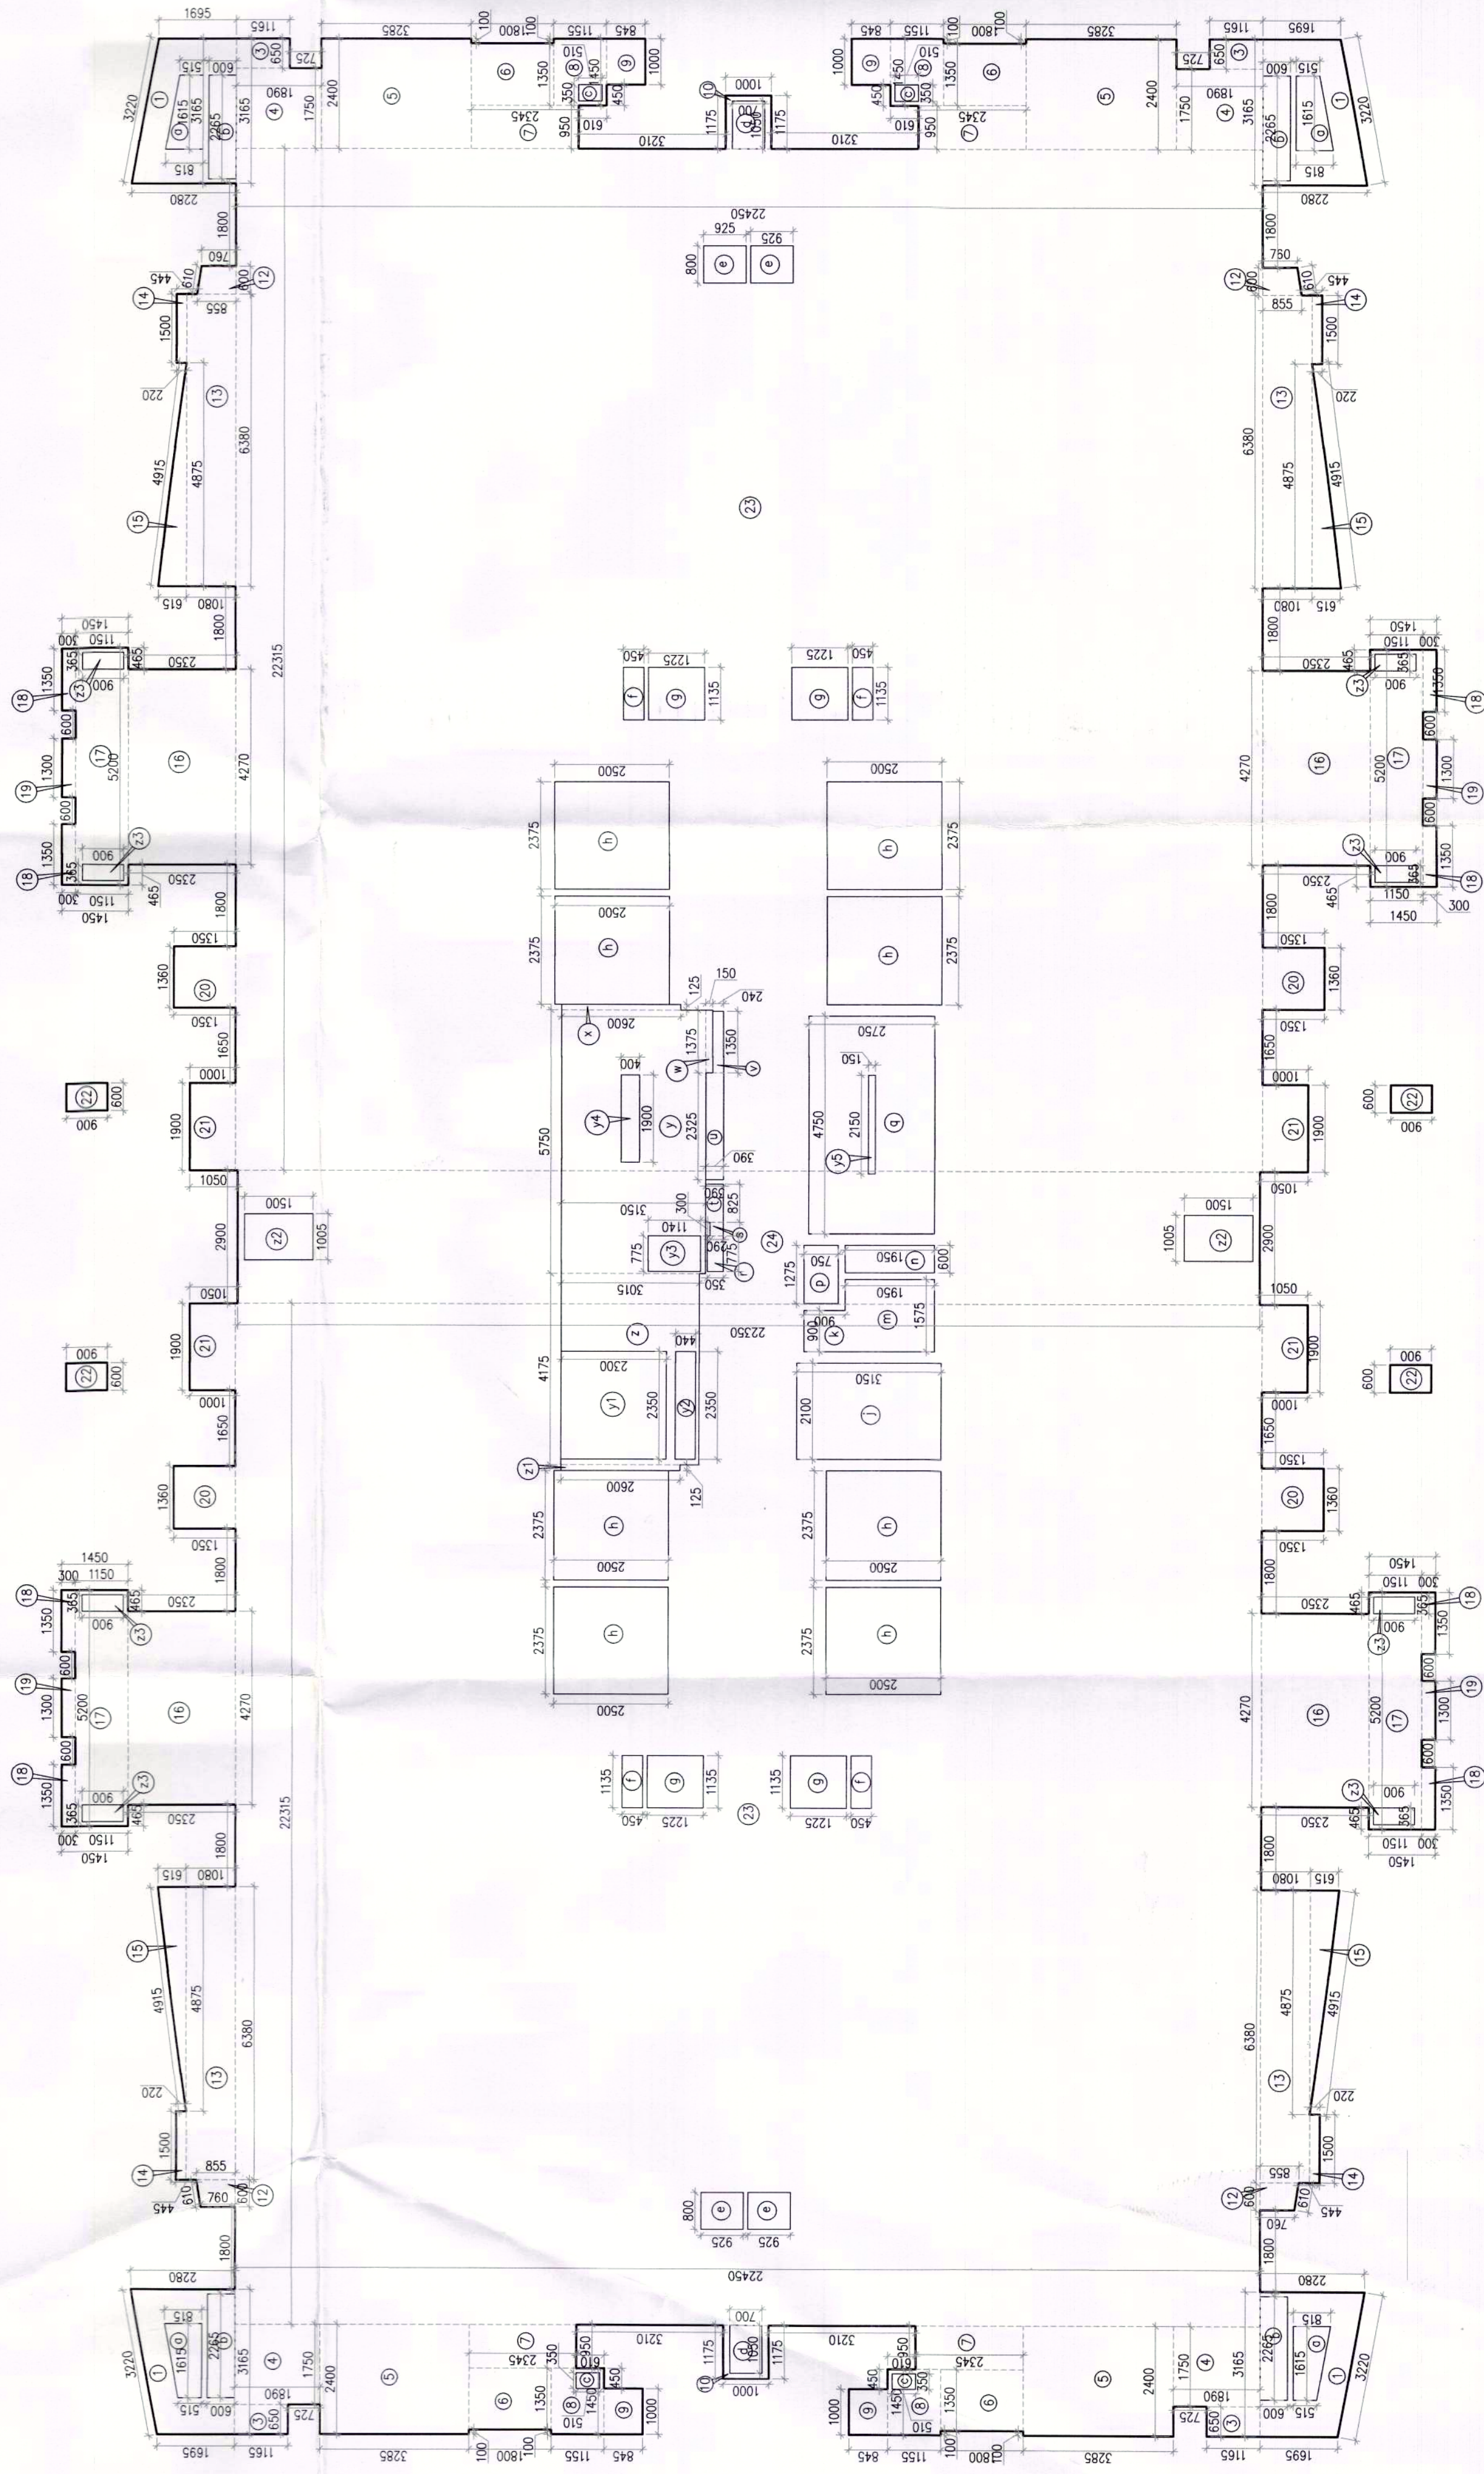
SYMBOL	ABBREVIATION	DESCRIPTION
①	SP	1500 SOL & WASTE PIPE
②	VP	1000 VENT PIPE
③	DMS	DOMESTIC WATER SUPPLY DN TAKE PIPE TO TOP (FOUR FLOOR)
④	DWS	DOMESTIC WATER SUPPLY DN TAKE PIPE
⑤	RWP	1500 RAIN WATER PIPE
⑥	WASTE	1000 WASTE PIPE FOR KITCHEN
⑦	FWS	FLUSHING WATER SUPPLY DN TAKE PIPE
⑧	RWP	750 RAIN WATER PIPE FOR BALCONY
⑨	DWS	DOMESTIC WATER SUPPLY RISER PIPE
⑩	FWSR	FLUSHING WATER SUPPLY RISER PIPE

DIMENSION LEGEND:	
1525	ARCHITECTURE DIM.
1525	AREA DIM.

SHAFTE PIPE

SECTION-AA

TYPICAL MECHANICAL VENTILATION CALCULATION FOR POWDER ROOM						
S. NO.	LOCATION	AREA (sq.ft)	HEIGHT (ft.)	VOLUME (Cu.ft)	DESIGN CFM CFM	EXHAUST DUCT SIZE DIAMETER (mm)
1	TYPICAL MECHANICAL VENTILATION FOR POWDER ROOM				SELECTED EXHAUST FAN	FAN SIZE DIA
1.1	POWDER ROOM	26.4	9	238	47.60	150
					1800cfm cassette in line fan	110(CD)

[illegible]

TYPICAL FLOOR AREA
TOWER-A,C

DESIGN ARCHITECT

ARCHITECTS:-

DESIGN FORUM
INTERNATIONAL

 **DESIGN FORUM**
INTERNATIONAL

Address : K-47, KAILASH COLONY, NEW
DELHI - 48

Phone : 011-46556600, 46556601, FAX -
46556601

Website: www.designforuminternational.com

ASSOCIATE ARCHITECTS

RSMS
ARCHITECTS

RSMS ARCHITECTS PVT. LTD.
69, Nara Nivas Bhawanij Kunj
(Behind D2), Vasant Kunj,
New Delhi-110070.
Tel.: 011-268938616, 268898617
www.rsms-arch.com

[illegible]

ARCHITECT'S SEAL & SIGNATURE	OWNER'S SEAL & SIGNATURE
 MANISH KUMAR CA/2008/42027	 DLF Limited <i>Manish Kumar</i> Authorised Signatory

FEB.-2025	Scale : 1:100	
Drawing Title: - TYPICAL FLOOR PLAN OF AREA CALCULATION		
		Drawing No: TA-05

02-11043025