

Sign & Stamp

Checked and found in for public health
(Internal) Services only subject to comments in
in forwarding letter dated 28.08.2014/45

NOTE:- ALL TOILETS ARE MECHANICALLY
VENTILATED WITH 100% POWER BACKUP

PROJECT :

BUILDINGS PLANS OF PHASE-II & NO
PHASE (EWS & NURSERY SCHOOL) PART
OF GROUP HOUSING COLONY AREA
MEASURING 22.50 ACRES (LICENCE NO 9
OF 2010 DATED 23.01.2010) IN SECTOR-71,
GURUGRAM BEING DEVELOPED BY
SIGNATURE GLOBAL (INDIA) LTD.

CLIENT :

SIGNATURE GLOBAL INDIA LTD.

ARCHITECT :

Confidence
NEW DELHI, INDIA

P-1, FIRST FLOOR, MBA CORPORATE SUITES,
H-16, 65, INDIA, New Delhi-110028
architecture urban design hospitality
Member of: GBC
www.confidence.com ISO 9001:2000
interiors

CLIENT'S SIGN & STAMP

Signature of Architect
Signature of Client
Stamp of Architect
Stamp of Client


DRAWING TITLE

TOWER 01
GROUND FLOOR PLAN, AREA
DIAGRAM & INTERMEDIATE FLOOR
PLAN

SCALE NORTH DRAWING NO.

1:100

11

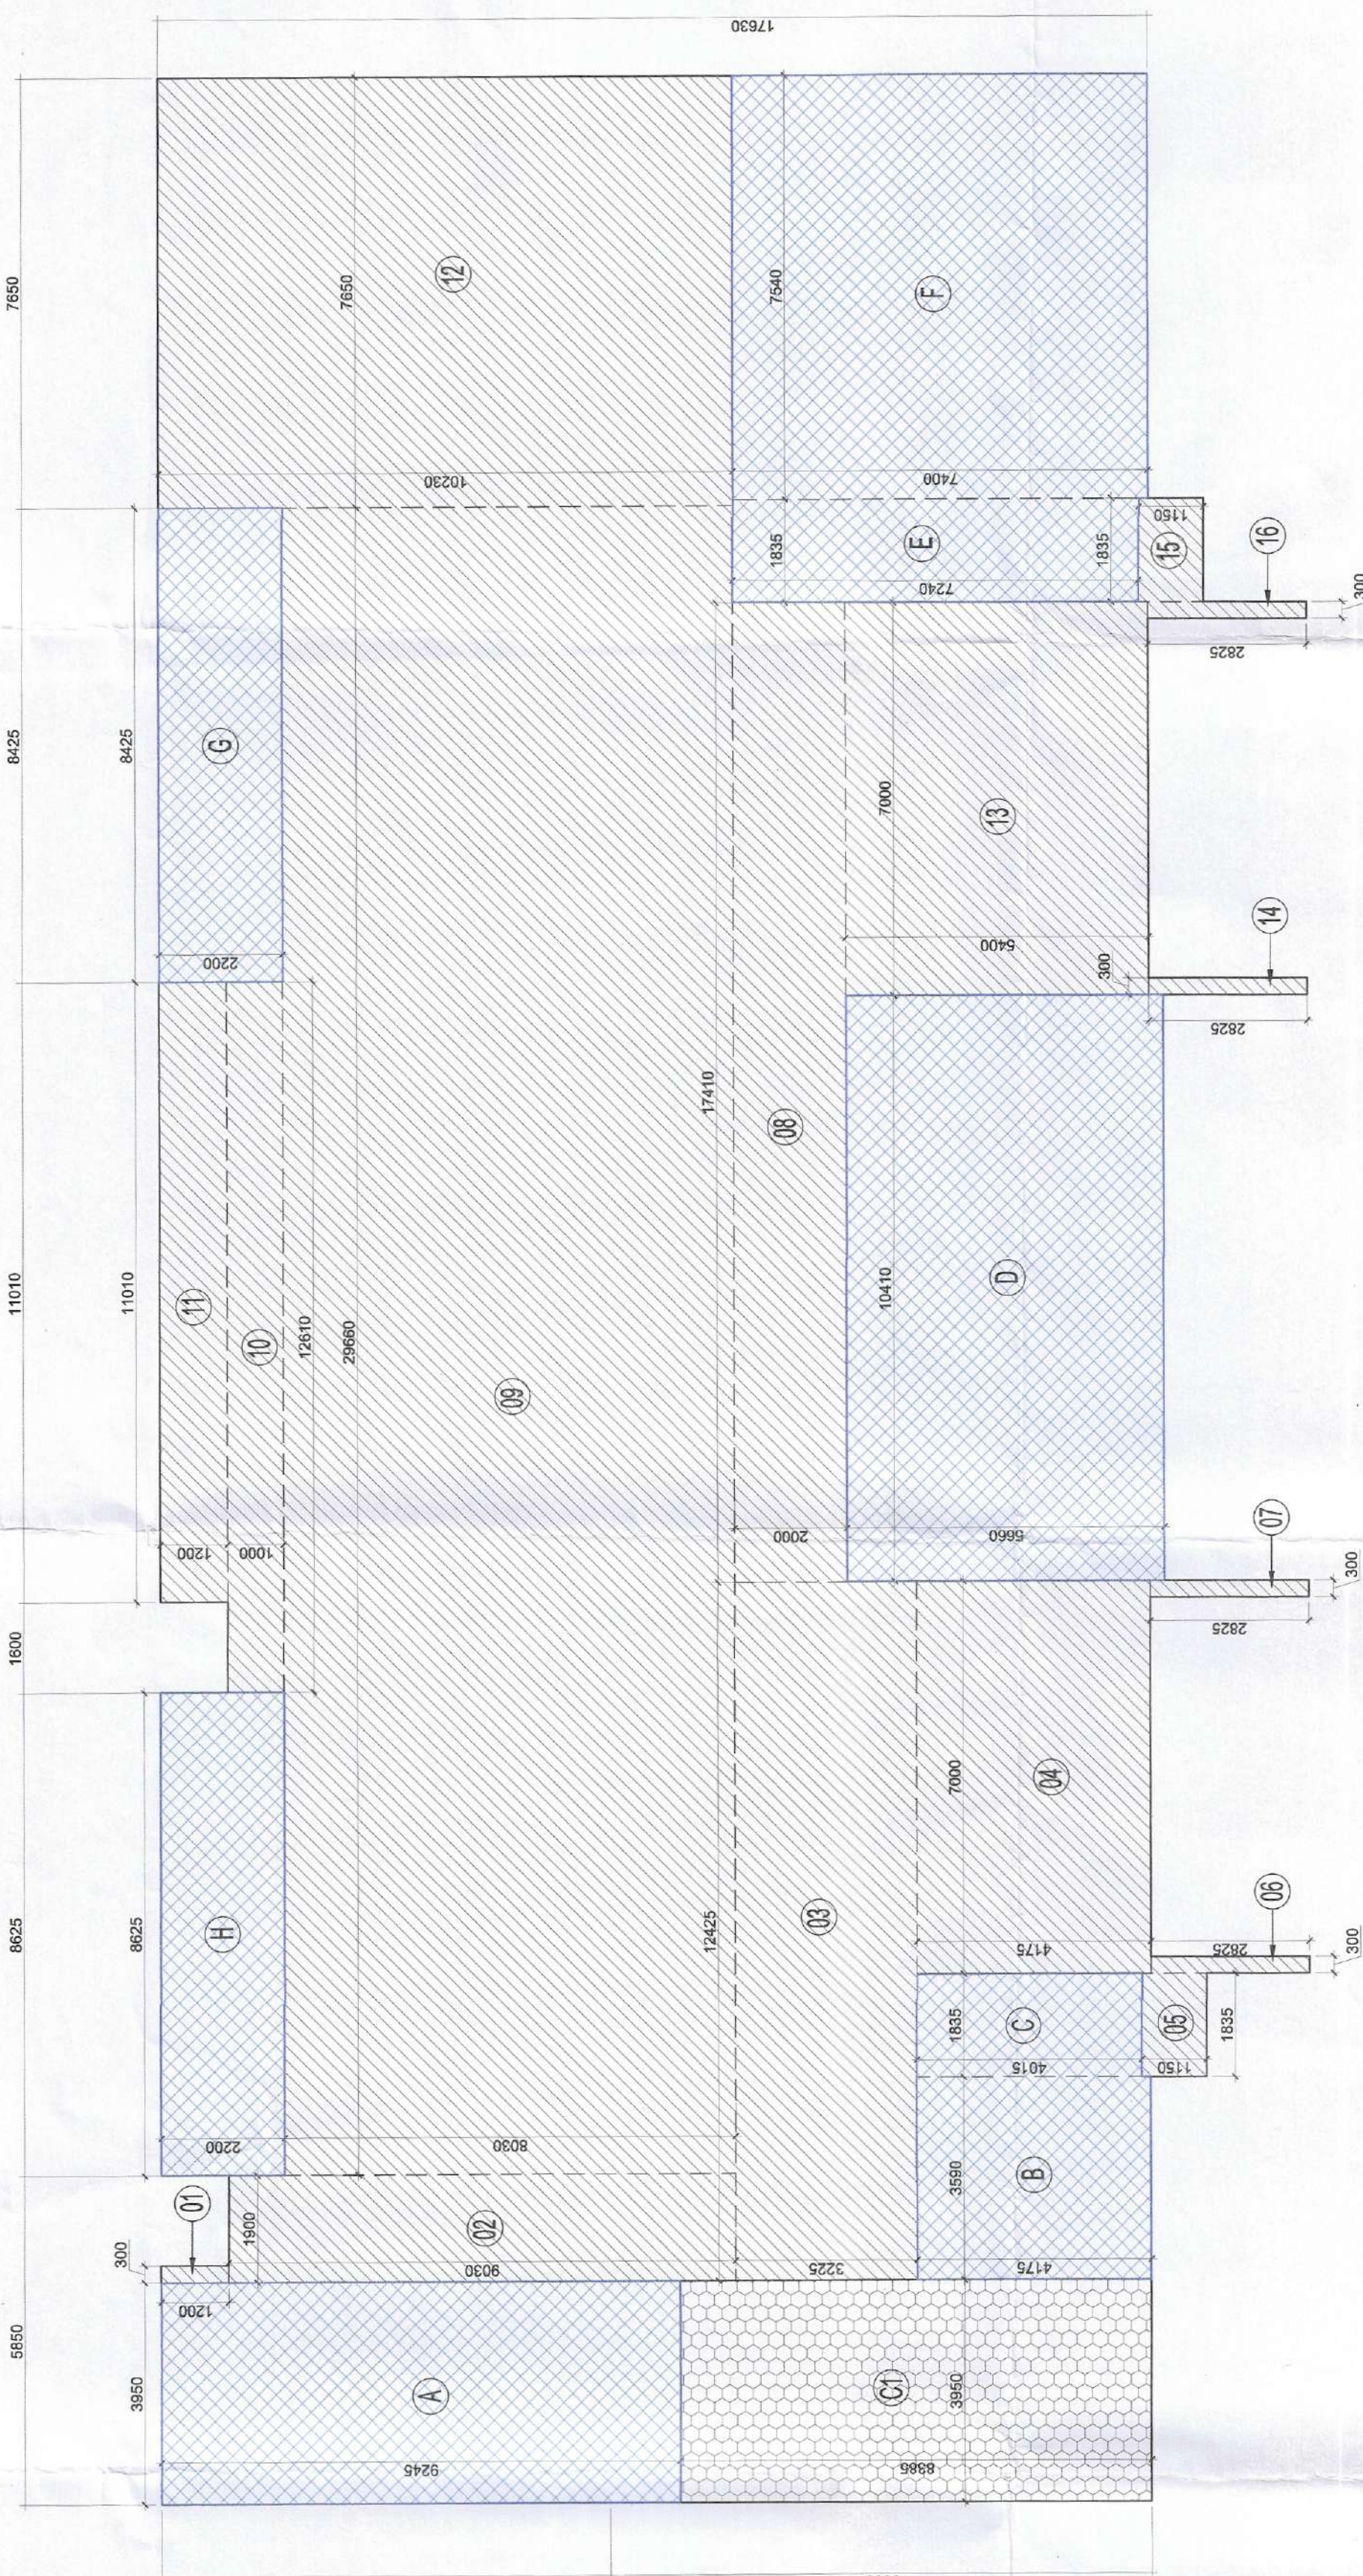

TOWER - 1 F.A.R. AREA CALCULATION FOR GROUND FLOOR			
S.NO.	PARTICULARS	AREA (SQM)	
1	1. 110 CD SOIL AND VENT PIPE	1.50	
2	2. 110 CD WASTE AND VENT PIPE	1.50	
3	3. 110 CD KITCHEN WASTE AND VENT PIPE	1.50	
4	4. 110 CD ANTISIPHONAGE PIPE	1.50	
5	5. 110 CD DOMESTIC WATER SUPPLY DN, TAKE PIPE	1.50	
6	6. 110 CD DOMESTIC WATER SUPPLY DN, TAKE PIPE	1.50	
7	7. 110 CD DOMESTIC WATER SUPPLY DN, TAKE PIPE	1.50	
8	8. 110 CD DOMESTIC WATER SUPPLY DN, TAKE PIPE	1.50	
9	9. 110 CD DOMESTIC WATER SUPPLY DN, TAKE PIPE	1.50	
10	10. 110 CD DOMESTIC WATER SUPPLY DN, TAKE PIPE	1.50	
11	11. 110 CD DOMESTIC WATER SUPPLY DN, TAKE PIPE	1.50	
12	12. 110 CD DOMESTIC WATER SUPPLY DN, TAKE PIPE	1.50	
13	13. 110 CD DOMESTIC WATER SUPPLY DN, TAKE PIPE	1.50	
14	14. 110 CD DOMESTIC WATER SUPPLY DN, TAKE PIPE	1.50	
15	15. 110 CD DOMESTIC WATER SUPPLY DN, TAKE PIPE	1.50	
16	16. 110 CD DOMESTIC WATER SUPPLY DN, TAKE PIPE	1.50	
17	17. 110 CD DOMESTIC WATER SUPPLY DN, TAKE PIPE	1.50	
18	18. 110 CD DOMESTIC WATER SUPPLY DN, TAKE PIPE	1.50	
TOTAL TOWER'S GROUND FLOOR F.A.R. AREA		24.00	

S.NO.	DESCRIPTION
1	1. 110 CD SOIL AND VENT PIPE
2	2. 110 CD WASTE AND VENT PIPE
3	3. 110 CD KITCHEN WASTE AND VENT PIPE
4	4. 110 CD ANTISIPHONAGE PIPE
5	5. 110 CD DOMESTIC WATER SUPPLY DN, TAKE PIPE
6	6. 110 CD DOMESTIC WATER SUPPLY DN, TAKE PIPE
7	7. 110 CD DOMESTIC WATER SUPPLY DN, TAKE PIPE
8	8. 110 CD DOMESTIC WATER SUPPLY DN, TAKE PIPE
9	9. 110 CD DOMESTIC WATER SUPPLY DN, TAKE PIPE
10	10. 110 CD DOMESTIC WATER SUPPLY DN, TAKE PIPE
11	11. 110 CD DOMESTIC WATER SUPPLY DN, TAKE PIPE
12	12. 110 CD DOMESTIC WATER SUPPLY DN, TAKE PIPE
13	13. 110 CD DOMESTIC WATER SUPPLY DN, TAKE PIPE
14	14. 110 CD DOMESTIC WATER SUPPLY DN, TAKE PIPE
15	15. 110 CD DOMESTIC WATER SUPPLY DN, TAKE PIPE
16	16. 110 CD DOMESTIC WATER SUPPLY DN, TAKE PIPE
17	17. 110 CD DOMESTIC WATER SUPPLY DN, TAKE PIPE
18	18. 110 CD DOMESTIC WATER SUPPLY DN, TAKE PIPE

RESIDENTIAL FAR
RETAIL FAR
NON FAR


TOWER - 1 BUILT-UP AREA CALCULATION FOR GROUND FLOOR			
S.NO.	PARTICULARS	AREA (SQM)	
1	1. 110 CD SOIL AND VENT PIPE	1.50	
2	2. 110 CD WASTE AND VENT PIPE	1.50	
3	3. 110 CD KITCHEN WASTE AND VENT PIPE	1.50	
4	4. 110 CD ANTISIPHONAGE PIPE	1.50	
5	5. 110 CD DOMESTIC WATER SUPPLY DN, TAKE PIPE	1.50	
6	6. 110 CD DOMESTIC WATER SUPPLY DN, TAKE PIPE	1.50	
7	7. 110 CD DOMESTIC WATER SUPPLY DN, TAKE PIPE	1.50	
8	8. 110 CD DOMESTIC WATER SUPPLY DN, TAKE PIPE	1.50	
9	9. 110 CD DOMESTIC WATER SUPPLY DN, TAKE PIPE	1.50	
10	10. 110 CD DOMESTIC WATER SUPPLY DN, TAKE PIPE	1.50	
11	11. 110 CD DOMESTIC WATER SUPPLY DN, TAKE PIPE	1.50	
12	12. 110 CD DOMESTIC WATER SUPPLY DN, TAKE PIPE	1.50	
13	13. 110 CD DOMESTIC WATER SUPPLY DN, TAKE PIPE	1.50	
14	14. 110 CD DOMESTIC WATER SUPPLY DN, TAKE PIPE	1.50	
15	15. 110 CD DOMESTIC WATER SUPPLY DN, TAKE PIPE	1.50	
16	16. 110 CD DOMESTIC WATER SUPPLY DN, TAKE PIPE	1.50	
17	17. 110 CD DOMESTIC WATER SUPPLY DN, TAKE PIPE	1.50	
18	18. 110 CD DOMESTIC WATER SUPPLY DN, TAKE PIPE	1.50	
TOTAL TOWER'S GROUND FLOOR BUILT-UP AREA (GROUND COVER)		24.00	

TOWER - 1 COMMERCIAL FAR AREA CALCULATION			
S.NO.	PARTICULARS	AREA (SQM)	
1	1. 110 CD SOIL AND VENT PIPE	1.50	
2	2. 110 CD WASTE AND VENT PIPE	1.50	
3	3. 110 CD KITCHEN WASTE AND VENT PIPE	1.50	
4	4. 110 CD ANTISIPHONAGE PIPE	1.50	
5	5. 110 CD DOMESTIC WATER SUPPLY DN, TAKE PIPE	1.50	
6	6. 110 CD DOMESTIC WATER SUPPLY DN, TAKE PIPE	1.50	
7	7. 110 CD DOMESTIC WATER SUPPLY DN, TAKE PIPE	1.50	
8	8. 110 CD DOMESTIC WATER SUPPLY DN, TAKE PIPE	1.50	
9	9. 110 CD DOMESTIC WATER SUPPLY DN, TAKE PIPE	1.50	
10	10. 110 CD DOMESTIC WATER SUPPLY DN, TAKE PIPE	1.50	
11	11. 110 CD DOMESTIC WATER SUPPLY DN, TAKE PIPE	1.50	
12	12. 110 CD DOMESTIC WATER SUPPLY DN, TAKE PIPE	1.50	
13	13. 110 CD DOMESTIC WATER SUPPLY DN, TAKE PIPE	1.50	
14	14. 110 CD DOMESTIC WATER SUPPLY DN, TAKE PIPE	1.50	
15	15. 110 CD DOMESTIC WATER SUPPLY DN, TAKE PIPE	1.50	
16	16. 110 CD DOMESTIC WATER SUPPLY DN, TAKE PIPE	1.50	
17	17. 110 CD DOMESTIC WATER SUPPLY DN, TAKE PIPE	1.50	
18	18. 110 CD DOMESTIC WATER SUPPLY DN, TAKE PIPE	1.50	
TOTAL COMMERCIAL FAR AREA (GROUND COVER)		24.00	

GROUND FLOOR LEVEL
+1200MM F.F.L.

INTERMEDIATE FLOOR LEVEL
+1200MM F.F.L.


S.NO.	TYPE	HEIGHT	DEPTH	LOCATION
1	1. 110 CD SOIL AND VENT PIPE	1.50	1.50	110 CD SOIL AND VENT PIPE
2	2. 110 CD WASTE AND VENT PIPE	1.50	1.50	110 CD WASTE AND VENT PIPE
3	3. 110 CD KITCHEN WASTE AND VENT PIPE	1.50	1.50	110 CD KITCHEN WASTE AND VENT PIPE
4	4. 110 CD ANTISIPHONAGE PIPE	1.50	1.50	110 CD ANTISIPHONAGE PIPE
5	5. 110 CD DOMESTIC WATER SUPPLY DN, TAKE PIPE	1.50	1.50	110 CD DOMESTIC WATER SUPPLY DN, TAKE PIPE
6	6. 110 CD DOMESTIC WATER SUPPLY DN, TAKE PIPE	1.50	1.50	110 CD DOMESTIC WATER SUPPLY DN, TAKE PIPE
7	7. 110 CD DOMESTIC WATER SUPPLY DN, TAKE PIPE	1.50	1.50	110 CD DOMESTIC WATER SUPPLY DN, TAKE PIPE
8	8. 110 CD DOMESTIC WATER SUPPLY DN, TAKE PIPE	1.50	1.50	110 CD DOMESTIC WATER SUPPLY DN, TAKE PIPE
9	9. 110 CD DOMESTIC WATER SUPPLY DN, TAKE PIPE	1.50	1.50	110 CD DOMESTIC WATER SUPPLY DN, TAKE PIPE
10	10. 110 CD DOMESTIC WATER SUPPLY DN, TAKE PIPE	1.50	1.50	110 CD DOMESTIC WATER SUPPLY DN, TAKE PIPE
11	11. 110 CD DOMESTIC WATER SUPPLY DN, TAKE PIPE	1.50	1.50	110 CD DOMESTIC WATER SUPPLY DN, TAKE PIPE
12	12. 110 CD DOMESTIC WATER SUPPLY DN, TAKE PIPE	1.50	1.50	110 CD DOMESTIC WATER SUPPLY DN, TAKE PIPE
13	13. 110 CD DOMESTIC WATER SUPPLY DN, TAKE PIPE	1.50	1.50	110 CD DOMESTIC WATER SUPPLY DN, TAKE PIPE
14	14. 110 CD DOMESTIC WATER SUPPLY DN, TAKE PIPE	1.50	1.50	110 CD DOMESTIC WATER SUPPLY DN, TAKE PIPE
15	15. 110 CD DOMESTIC WATER SUPPLY DN, TAKE PIPE	1.50	1.50	110 CD DOMESTIC WATER SUPPLY DN, TAKE PIPE
16	16. 110 CD DOMESTIC WATER SUPPLY DN, TAKE PIPE	1.50	1.50	110 CD DOMESTIC WATER SUPPLY DN, TAKE PIPE
17	17. 110 CD DOMESTIC WATER SUPPLY DN, TAKE PIPE	1.50	1.50	110 CD DOMESTIC WATER SUPPLY DN, TAKE PIPE
18	18. 110 CD DOMESTIC WATER SUPPLY DN, TAKE PIPE	1.50	1.50	110 CD DOMESTIC WATER SUPPLY DN, TAKE PIPE

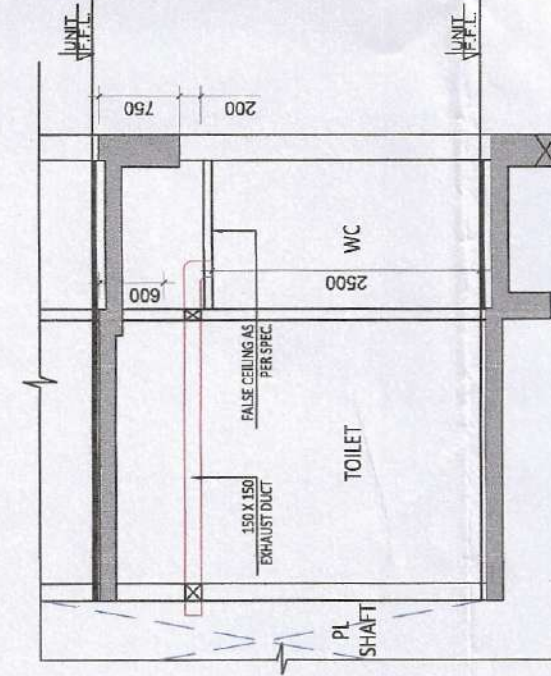


TYPICAL MECHANICAL VENTILATION
SECTION FOR W.C.

TYPICAL MECHANICAL VENTILATION CALCULATION FOR W.C.

TOWER - 1 (TOILET EXHAUST)					
S.NO.	Location	Area (sqft)	Height (ft)	Volume (cuft)	Per Dia (mm)
1	W.C.	26.91	11	300	75
2	W.C.	26.91	11	300	75

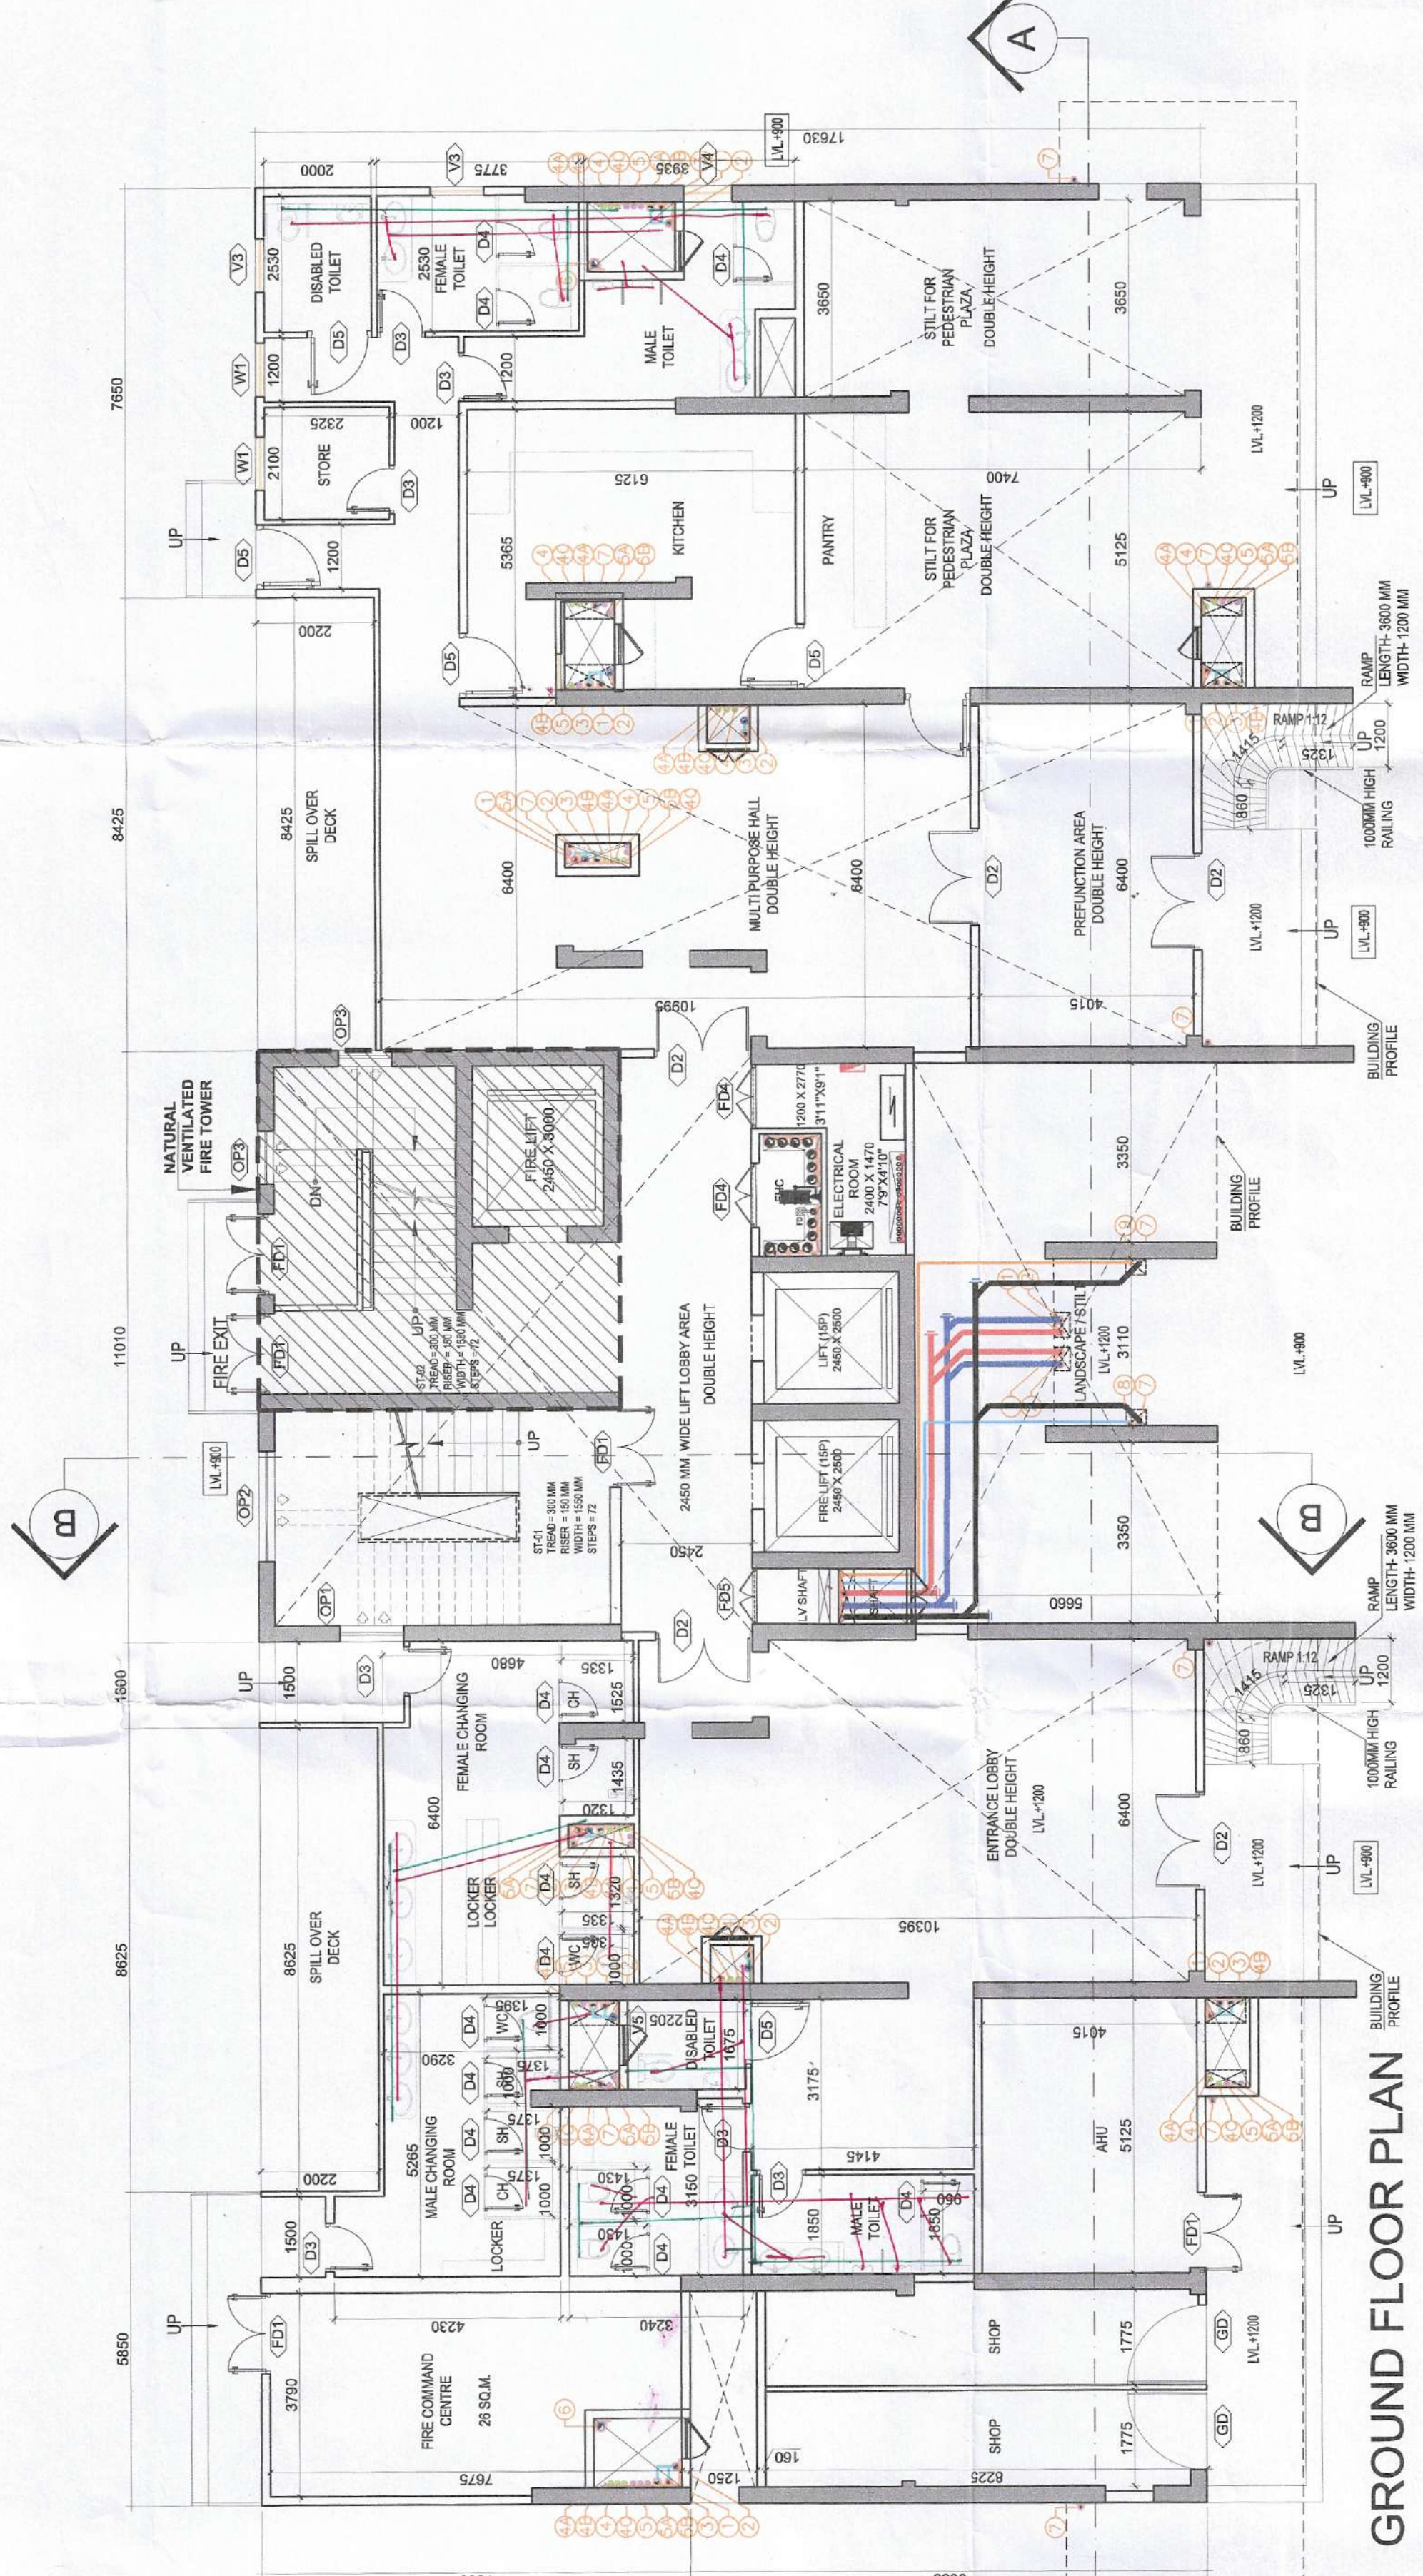

GROUND FLOOR PLAN

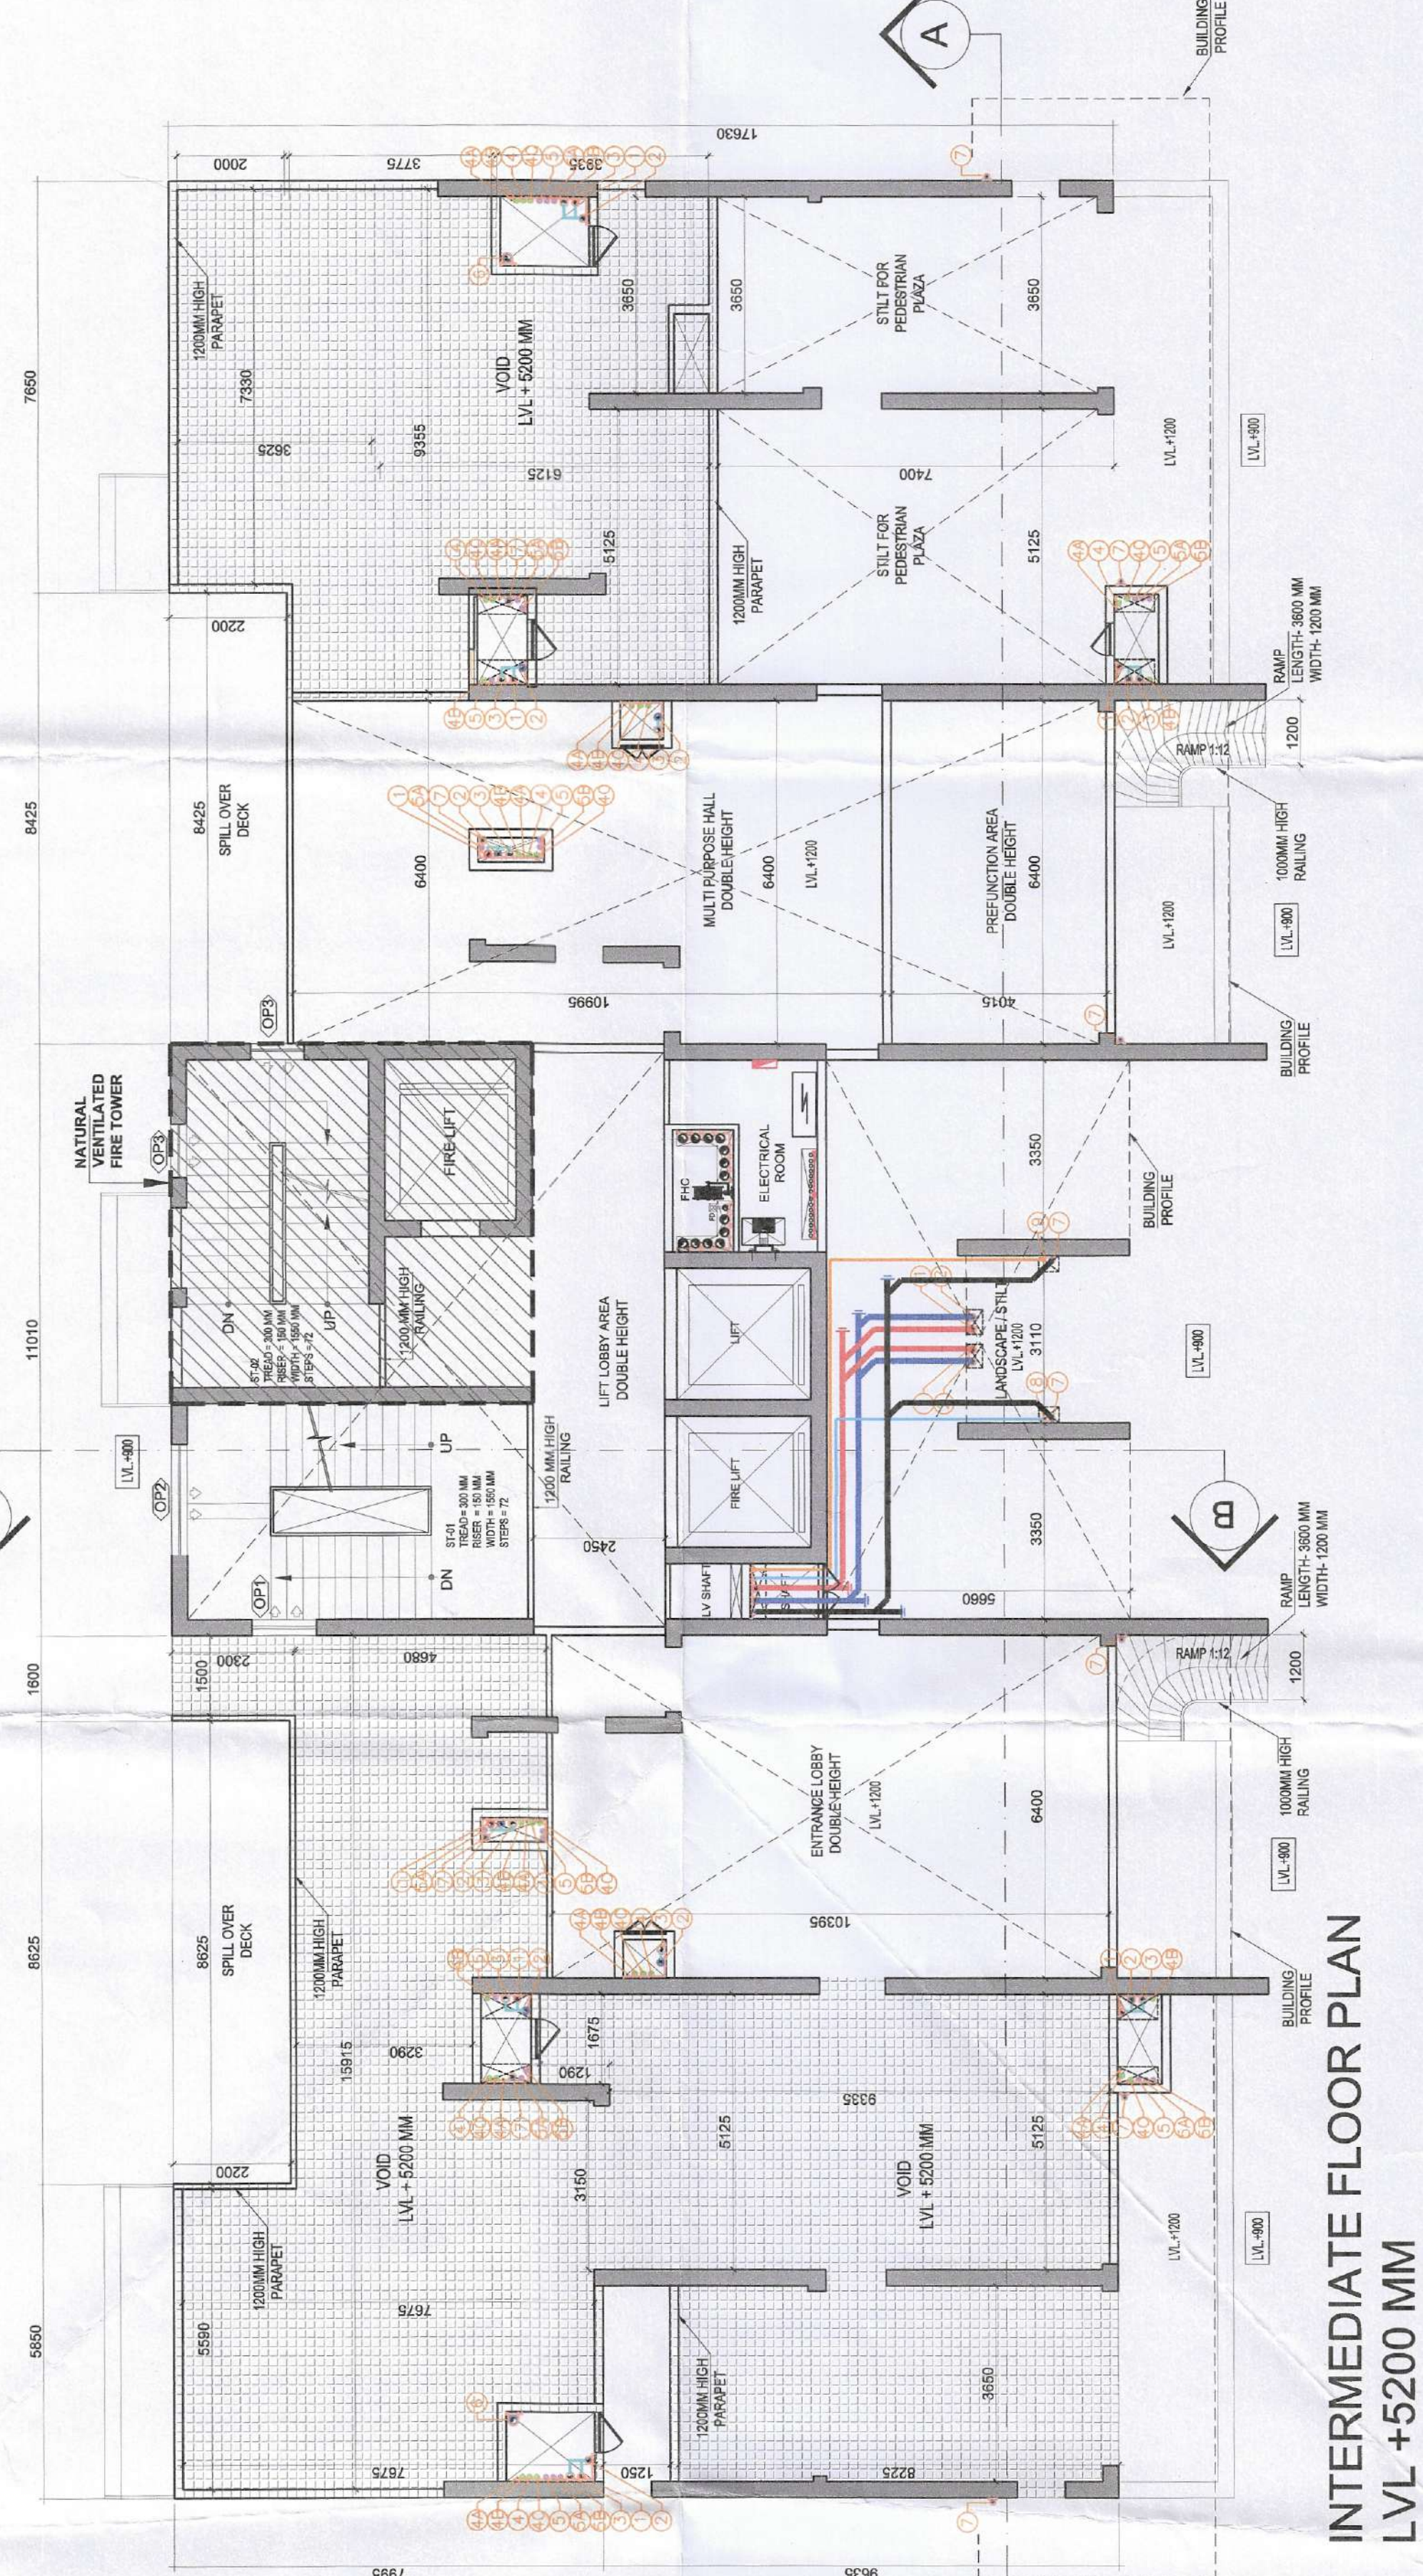

INTERMEDIATE FLOOR PLAN
LVL +5200 MM