
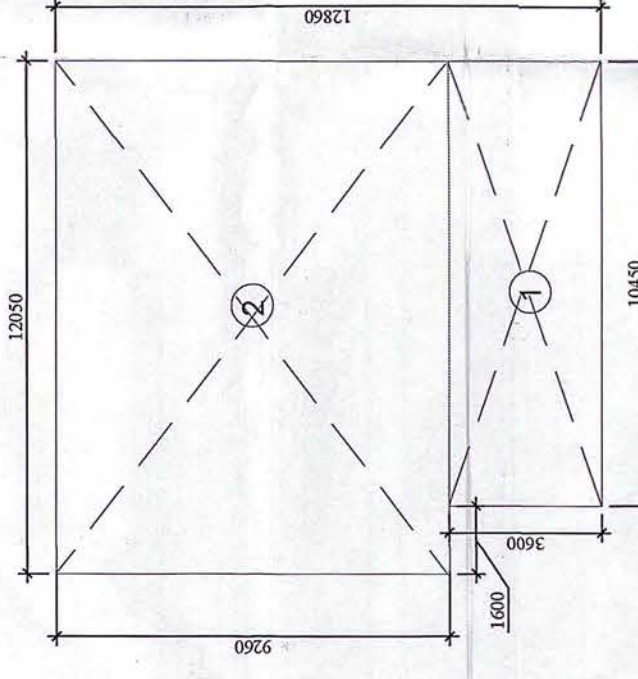



PLUMBING LEGEND	
(A)	110 OD SOIL PIPE
(B)	110 OD WASTE PIPE
(C)	63 OD SOIL PIPE
(D)	40 OD WASTE PIPE
(E)	50 OD SOIL PIPE

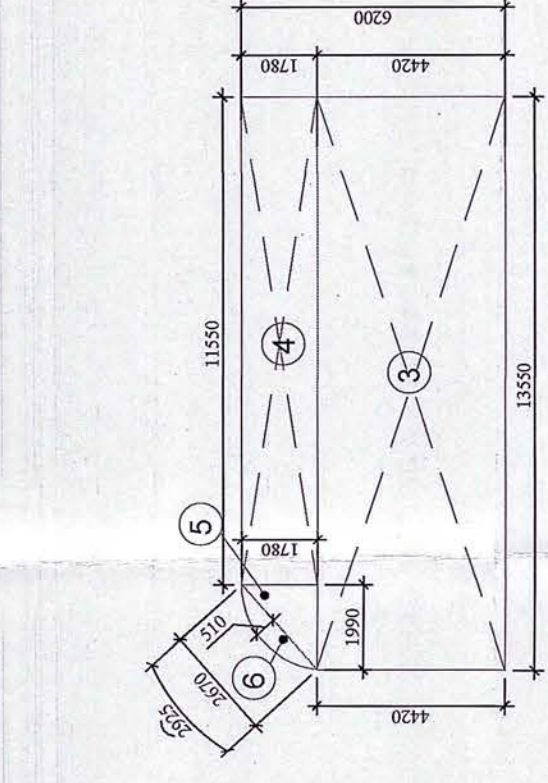

AREA DIAGRAM MUMTY & MACHINE ROOM

S. No.	COEFF	WIDTH	LENGTH	NOS.	Area in sq. mt.
1	1	10.450	3.600	1	37.620
2	1	12.050	9.250	1	111.593
3	1	13.550	4.420	1	59.891
4	1	11.150	1.750	1	20.559
5	0.5	1.990	1.750	1	1.771
6	0.697	2.670	0.510	1	0.908
NON FAR AREA					232.33
TOTAL NON FAR AREA					232.33

MACHINE ROOM / OHT PLAN

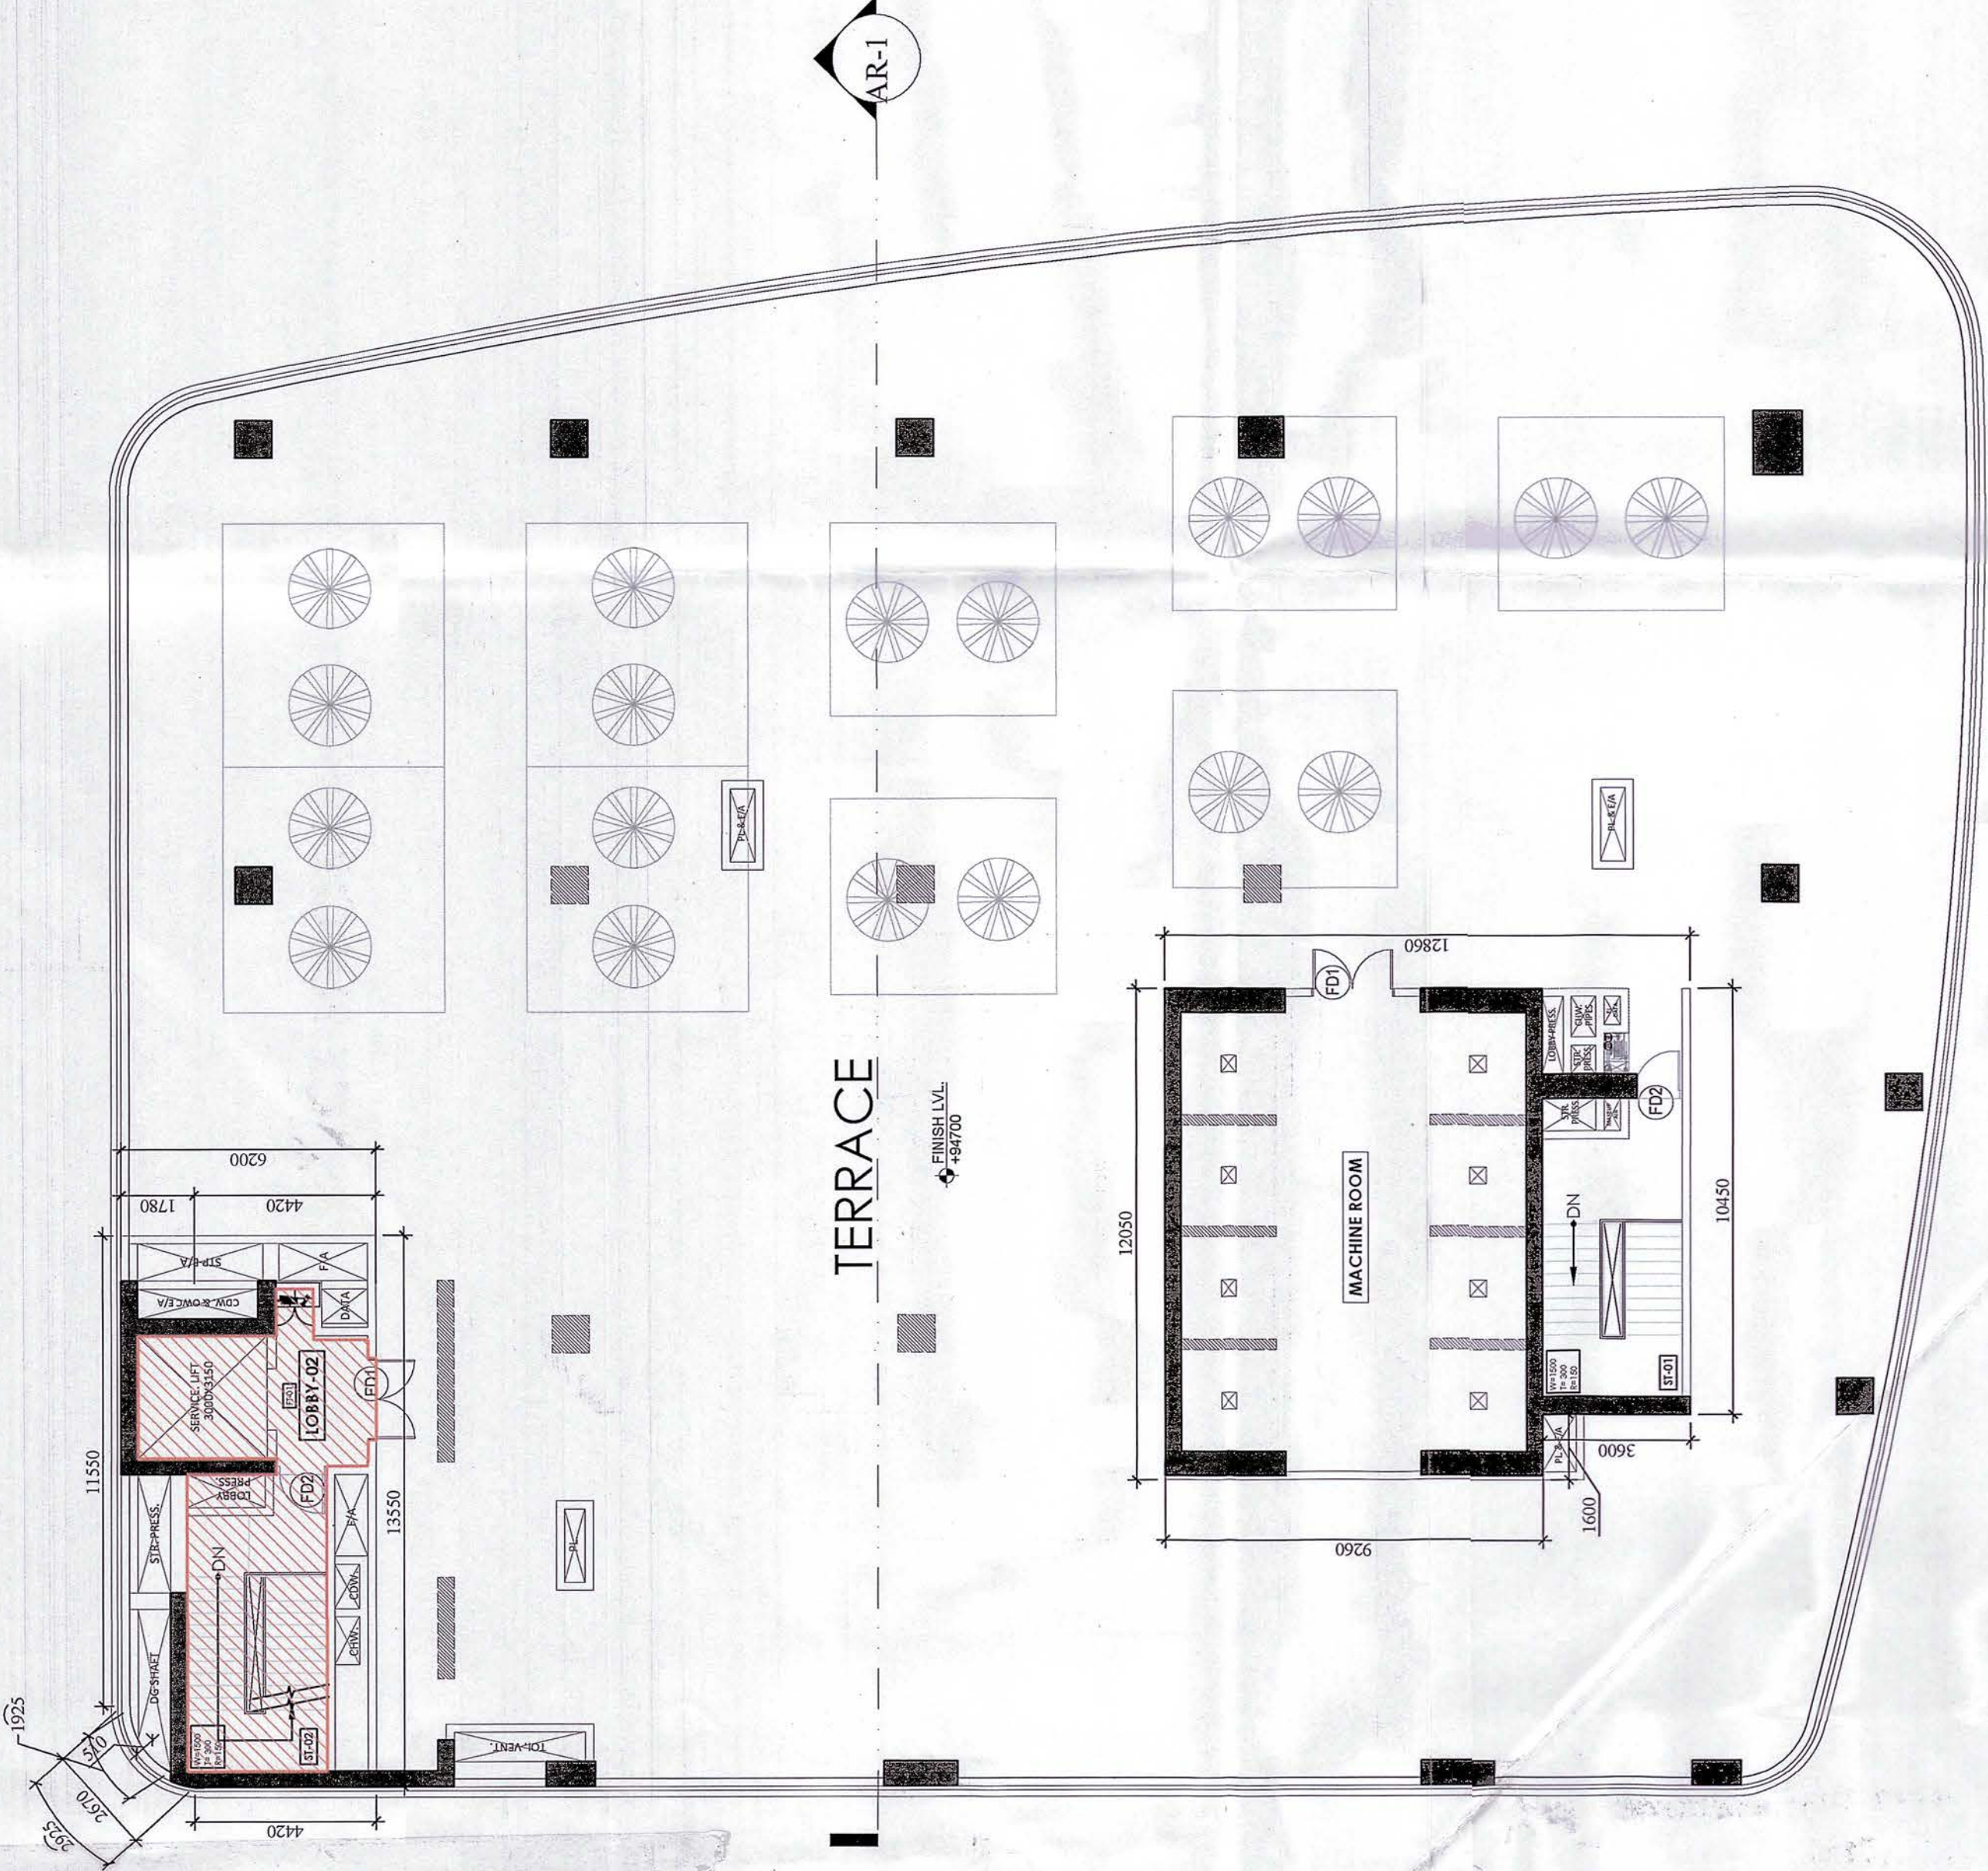

TERRACE FLOOR PLAN

PLUMBING LEGEND	
1	110 OD SOIL PIPE
2	110 OD WASTE PIPE
3	160 OD SOIL PIPE
4	160 OD WASTE PIPE
5	75 OD ANTISIPHONAGE VENT PIPE
6	DOMESTIC WATER SUPPLY PIPE (HYDROPNEUMATIC)
7	FLUSHING WATER SUPPLY PIPE (HYDROPNEUMATIC)
8	DOMESTIC WATER SUPPLY DNT TAKE PIPE (OFFICE BLOCK)
9	FLUSHING WATER SUPPLY DNT TAKE PIPE (OFFICE BLOCK)
10	FLUSHING WATER RISER PIPE
11	DOMESTIC WATER RISER PIPE
12	SOFT WATER RISER PIPE
13	110 OD RAIN WATER PIPE
14	160 OD RAIN WATER PIPE
15	210 OD RAIN WATER PIPE

FIRE LEGEND	
(A)	150Ø FIRE PIPE UPPER ZONE
(A1)	150Ø FIRE PIPE LOWER ZONE
(B)	150Ø SPRINKLER PIPE UPPER ZONE
(B1)	150Ø SPRINKLER PIPE LOWER ZONE
(B2)	150Ø ALTERNATE RISER UPPER ZONE
(B3)	150Ø ALTERNATE RISER LOWER ZONE
(C)	80Ø DRAIN PIPE

TO BE READ WITH THIS OFFICE
MEMO NO.:
DATED:

NOTES:-

1. ALL DRAWING ARE TO BE READ ONLY AND NOT TO BE SCALED.
2. ALL DIMENSIONS ARE IN MM UNLESS MENTIONED.
3. BASEMENTS ARE MECHANICALLY VENTILATED ONLY.
4. STRUCTURAL SYSTEM BEAM-COLUMN SYSTEM.
5. STAIRS, FLOOR PLANS AND BASEMENTS HAVE AUTOMATIC SPRINKLER SYSTEM FOR FIRE FIGHTING.
7. GATE AND BOUNDARY WALL AS PER STANDARD DETAIL.
8. COMPLETE BUILDING WALL BE CENTRALIZED AIR CONDITIONED AND MECHANICALLY VENTILATED WITH 100% POWER BACKUP.

PROJECT

REVISE BUILDING PLAN FOR SETTING UP OF
COMMERCIAL COLONY OVER AN AREA
MEASURING 8.3075 ACRES (LICENCE NO, 17 OF
2010 DATED 13.02.2010 AND LICENCE NO. 150
OF 2022 DATED 28.09.2022) IN THE
COMMERCIAL BELT OF SECTOR 68,
GURUGRAM BEING DEVELOPED BY REACH
PROMOTERS PVT. LTD.

ARCHITECTS

ACPL

ISO 9001:2008

Architecture
Management

ACPL Design Ltd
www.acplonline.com
E-24 South Extension II-191 11 24822195
New Delhi 110049, India +91 11 24846709
E: acplnet@acplonline.com 01 11 24837050

E-24 South Extension I-1+91 11 24622195
New Delhi 110049. India +91 11 24646709
E: contact@acplonline.org+91 11 24634069

"This is a 'PROVISIONAL BUILDING PLAN' approved only for the purpose of inviting applications from the general public."

objections from the general public

ATP(HQ) *[Signature]* A.P.P.

DTP(HQ) *[Signature]* PA.

GEN JD.

Checked and found ok for Public Health	DINESH KUMAR PA(HQ)
ARCHITECTS SEAL & SIGNATURE	OWNER'S SEAL

1/1/82
Supervising Engineer (1/1)

RAVI KUMAR GARG
Chartered Engineer (rtd)
to Civil Engineer-I
HSPV, Panchkula

ARC/21/TECI
CA/2013/58473

SCALE :- 1: 200

DRG. TITLE :

DRAWING NO.

10

TERRACE PLAN
(AREA CALCULATION PLAN)