


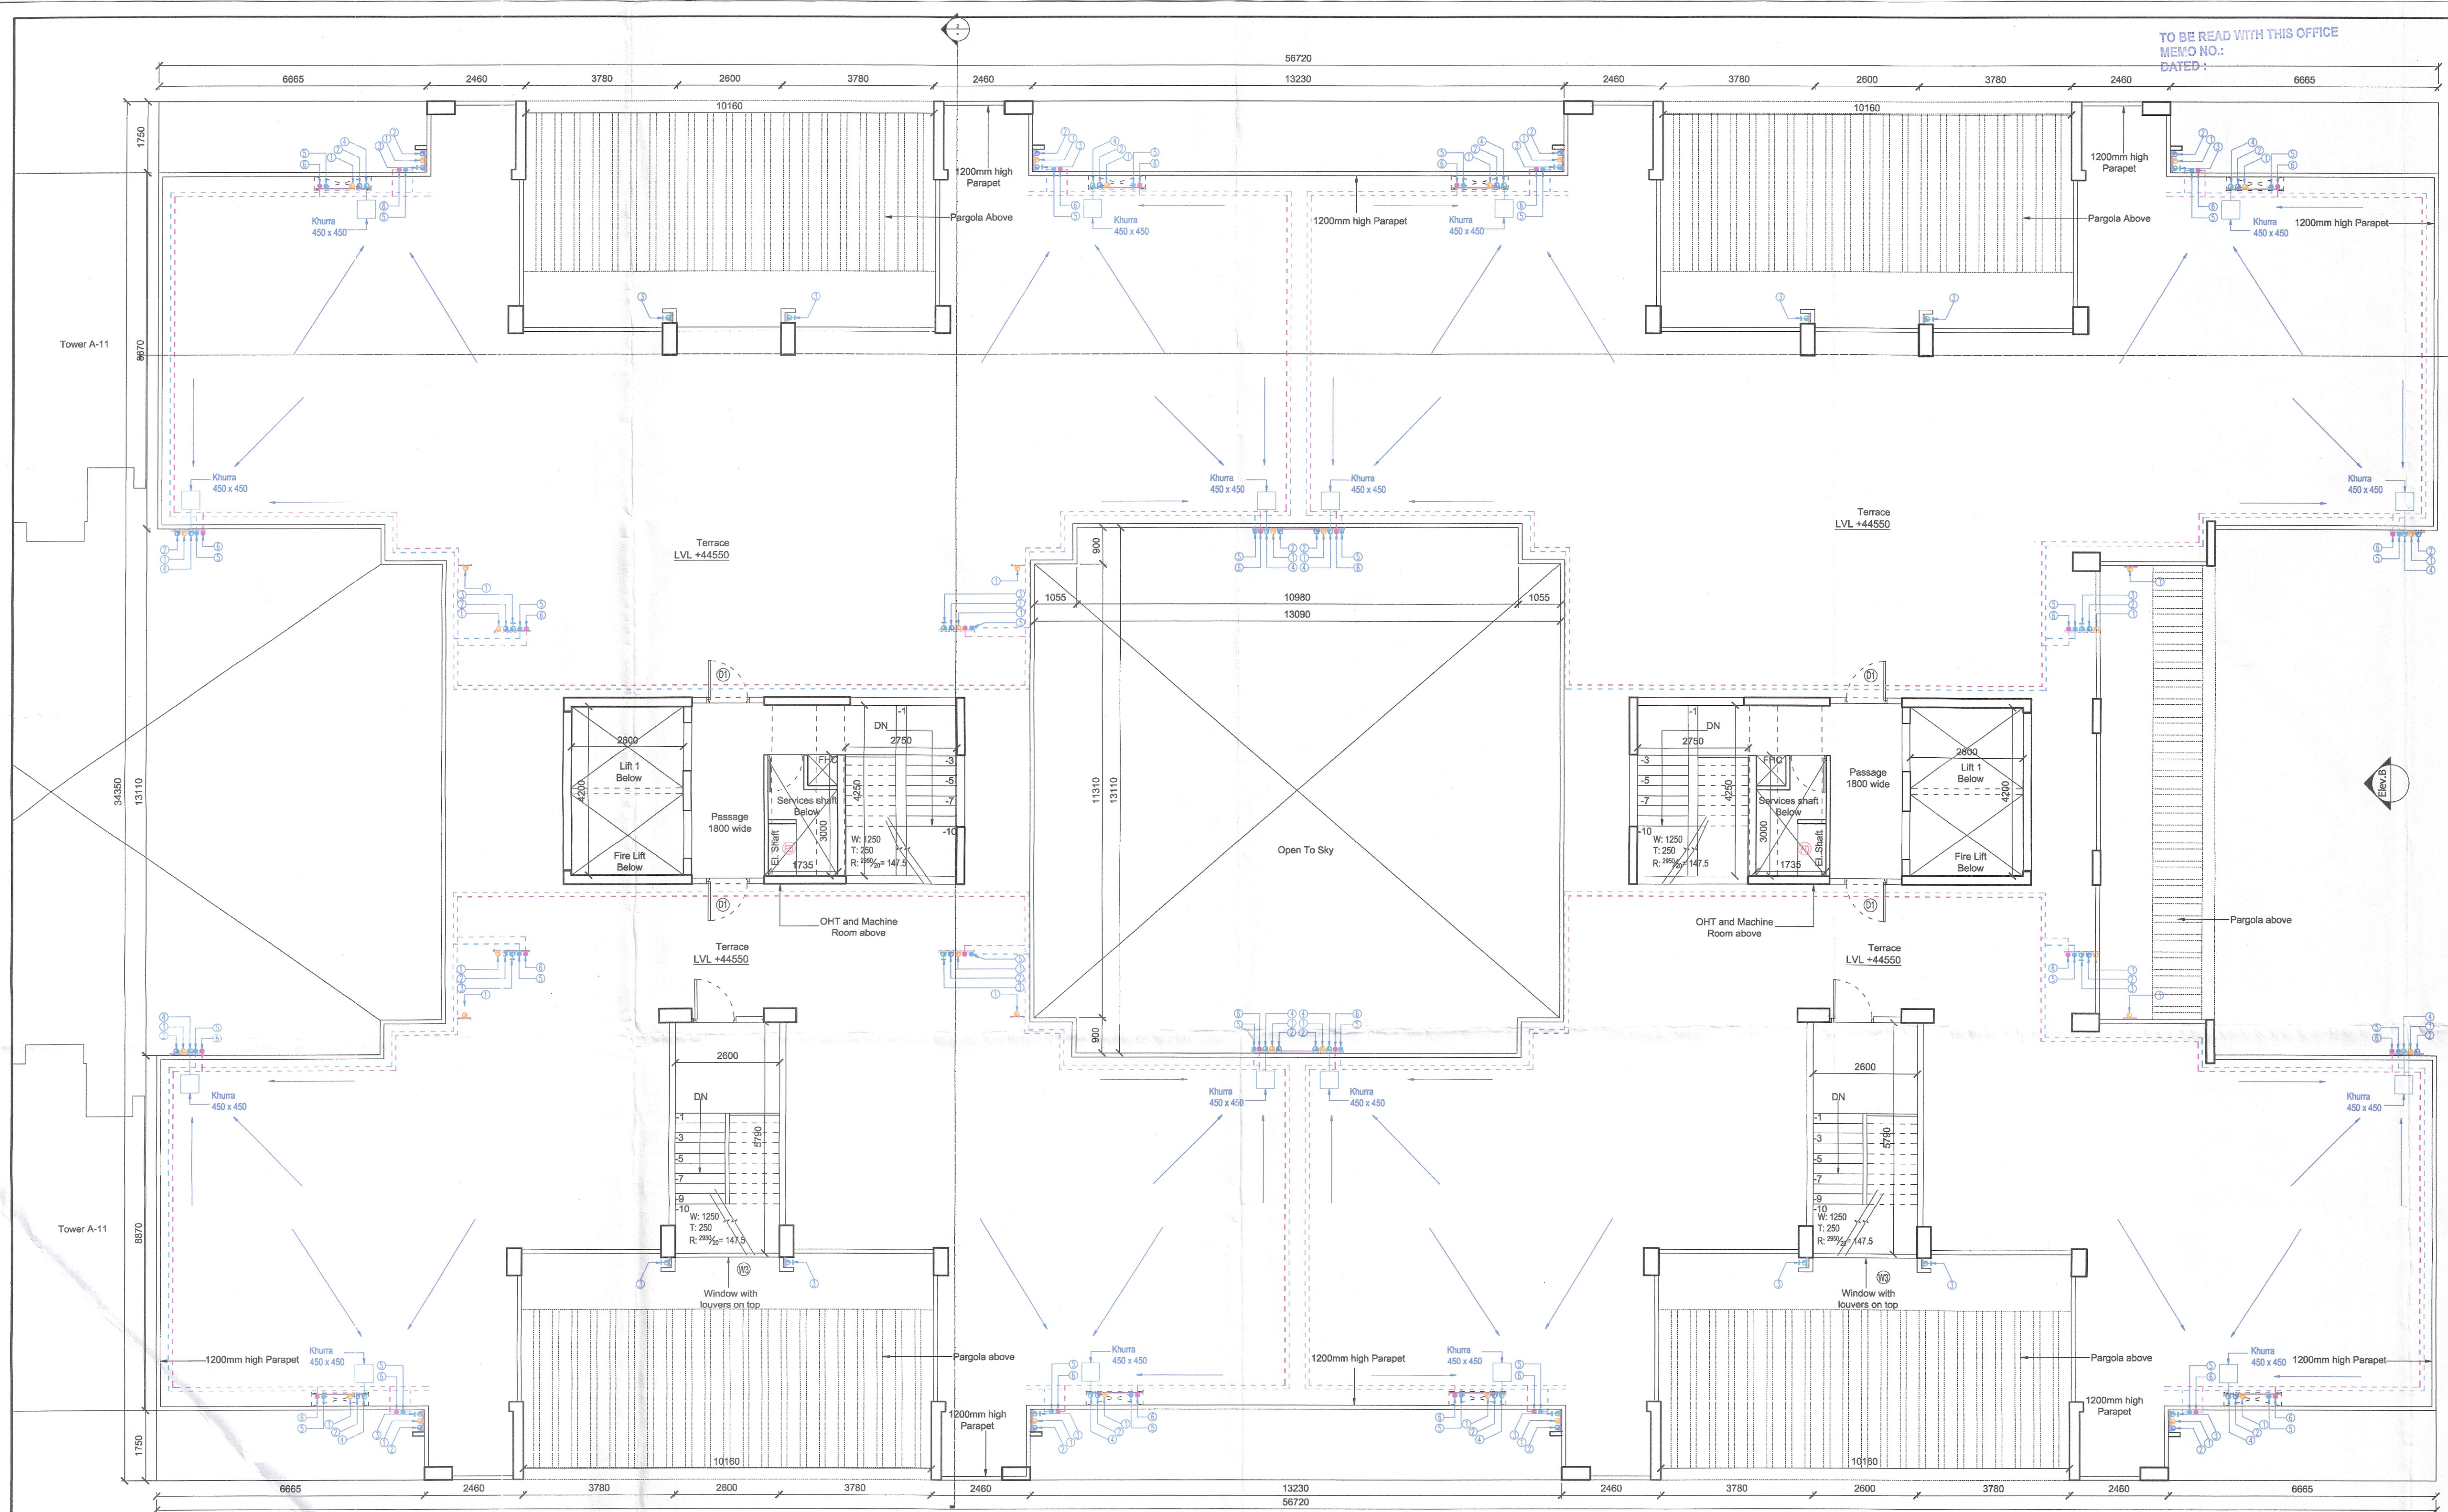

DRAWING TITLE DWG. NO.

Type A-Block 9&10
Terrace Floor
Layout

S - 103d

This is a "PROVISIONAL BUILDING PLAN" approved only for the purpose of inviting objections from the general public

Usham
S.T.P (H)
Member Secretary
B.P.A.C.

Checked and found ok for Public Health (Internal) Service only subject to comments in forwarding letter No. 2.2.6.7.5.DU/1.9.17/24

Site Intending Engineer (H)
for Civil Engineer-I
V.P. Panchkula

JINESH KUMAR
PA(HQ)

DD(HQ)
Member
BPAC

PROJECT TITLE

Approval of Building plans for Group Housing Colony over an additional area measuring 7.64375 acres (Licence No. 34 of 2024 dated 07.03.2024) in addition to group housing colony measuring 25.44 acres (Licence No. 78 of 2010 dated 15.10.2010), Grand total area 33.08375 acres in Sector-69-70, GMUC, Gurgram being developed by M/S Tulip Infratech Pvt. Ltd. in collaboration with land owners .

OWNERS

TULIP INFRATECH PVT. LTD.

ARCHITECTS

designcosmos

A-609, Second Floor,
Sushant Lok Ph-1, Gurgaon
Ph- 0124 4203676

DATE March 2024

SCALE 1:85

DEALT SD

CHECKED MA

OWNER'S SIGNATURE


For TULIP INFRATECH PVT. LTD.

Authorised Signatory


ARCHITECT'S SIGNATURE

APOORV SINGH
CA/200012704

1 Type A- Terrace Floor Plan
SCALE - 1:85

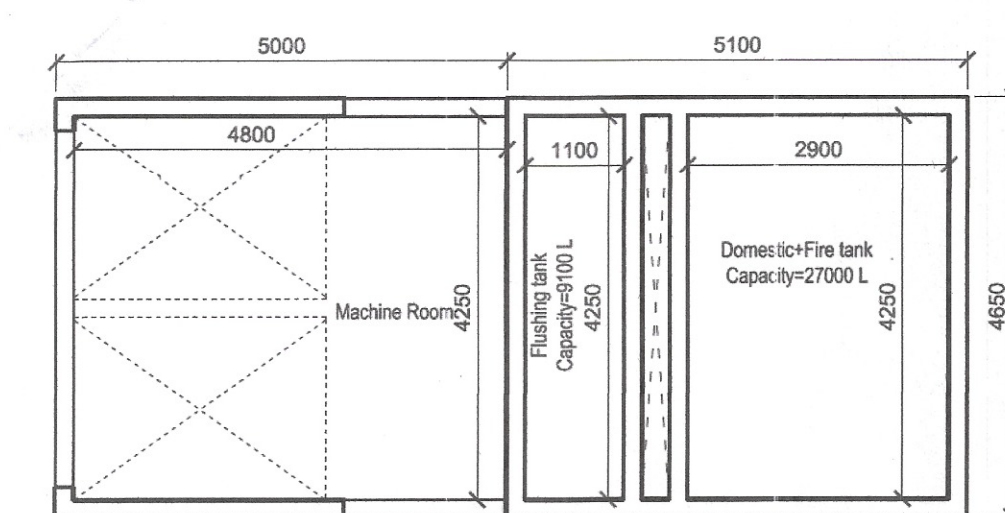


2 OHT Layout (Mumty 01)
SCALE - 1:85

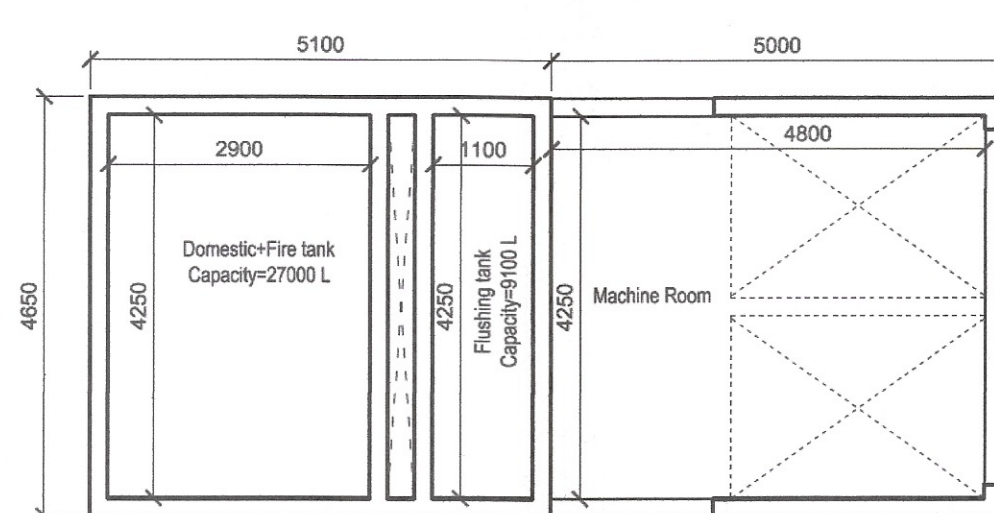

3 OHT Layout (Mumty 02)
SCALE - 1:85

Water Tank Capacity Tower A
No. of Units= 58 Units
CAP. = $\frac{[(58 \times 5) + (6 \times 2)] \times 172.5}{2}$
= 26047.5 lts.
= Say 26100 lts.
Flushing = 9,100 lts.
Domestic = 17,000 lts.
Fire = 10,000 lts.

Water Tank Capacity Tower A
No. of Units= 58 Units
CAP. = $\frac{[(58 \times 5) + (6 \times 2)] \times 172.5}{2}$
= 26047.5 lts.
= Say 26100 lts.
Flushing = 9,100 lts.
Domestic = 17,000 lts.
Fire = 10,000 lts.

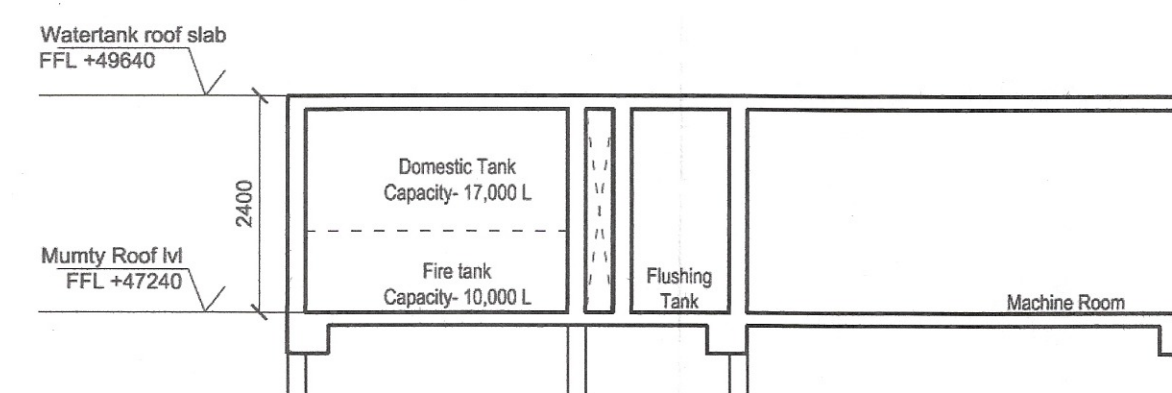

4 OHT Section
SCALE - 1:85

DOOR/WINDOW SCHEDULE				
SN.	Type	Width (mm)	Cill (mm)	Height (mm)
1	D1	1050	±00	+2100
				2100

LEGEND:-

1	110 OD SWR PVC SOL & WASTE PIPE
2	75 OD SWR PVC VENT PIPE
3	110 OD uPVC RAIN WATER PIPE (FOR BALCONY)
4	110 OD uPVC RAIN WATER PIPE (FOR TERRACE)
5	110 OD uPVC DOMESTIC WATER PIPE
6	110 OD uPVC FLUSHING WATER PIPE
F.T.	FLOOR TRAP
F.D.	FLOOR DRAIN