




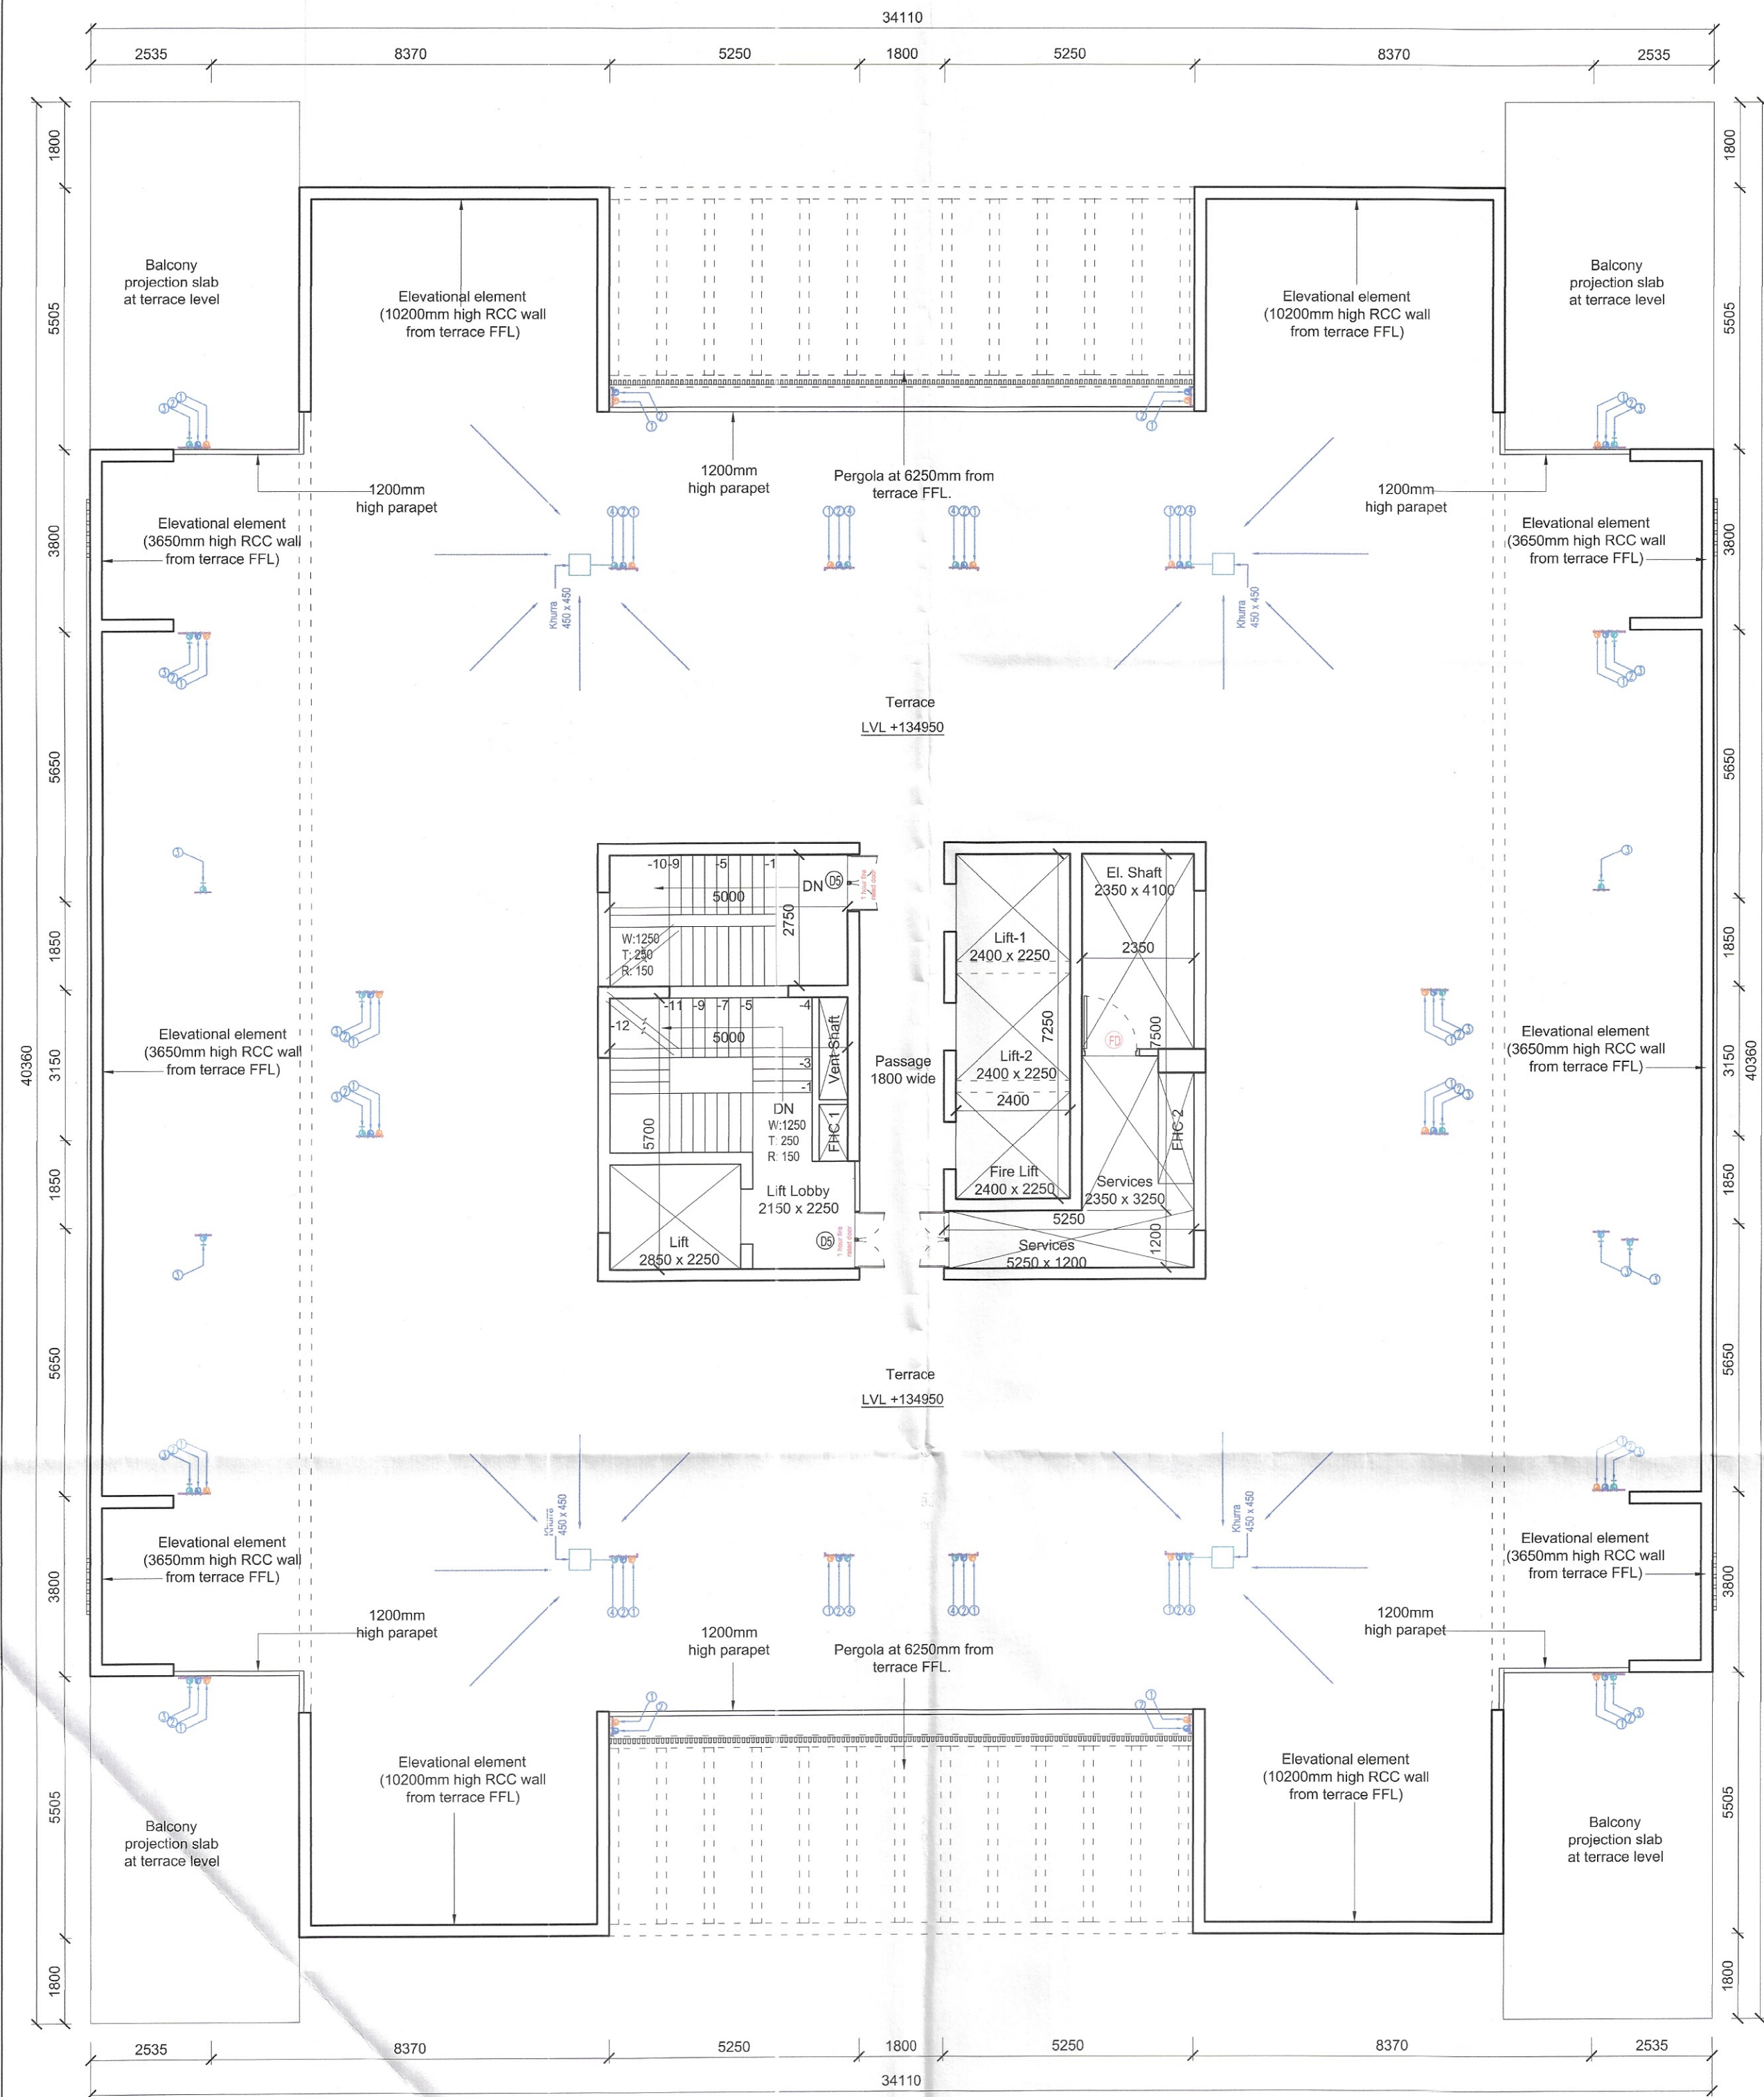

1 Type D- Terrace Floor Plan
SCALE - 1:100

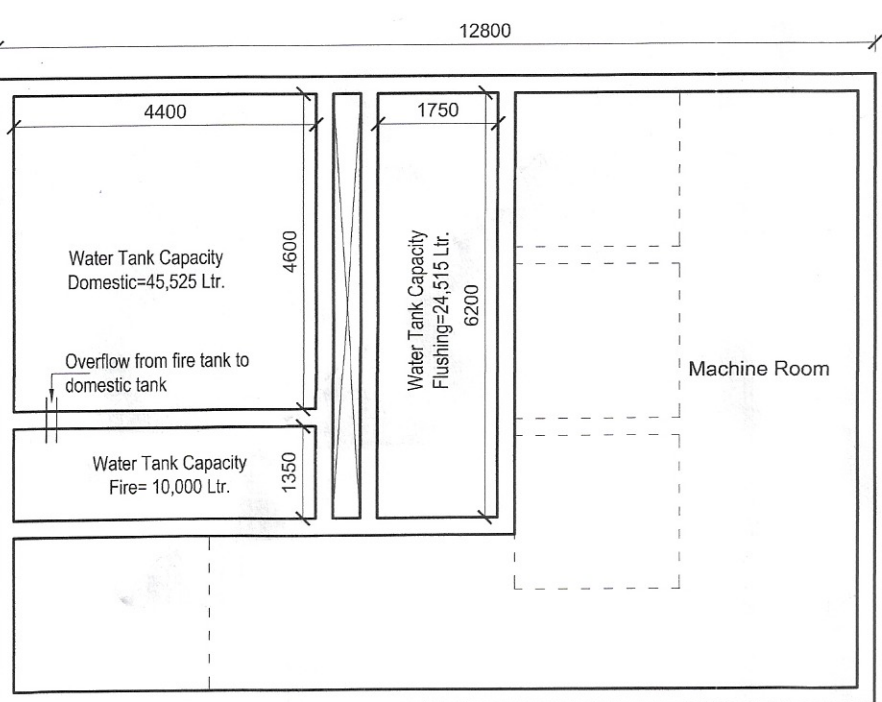

3 Tower D- OHT Plan
SCALE - 1:100

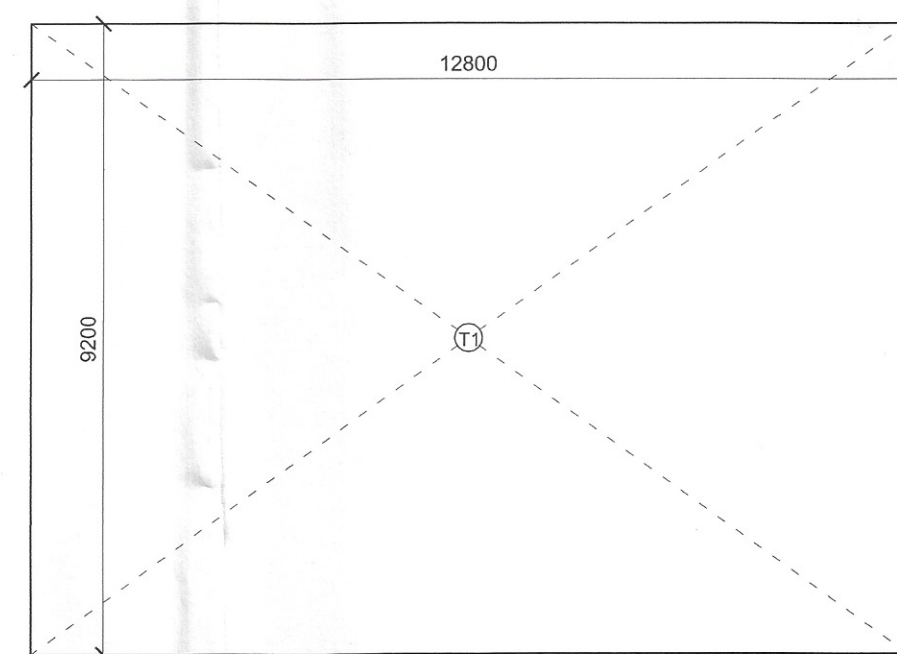


4 OHT, Machine Room -Area Details
SCALE - NTS

Water Tank Capacity Tower D
No. of Units= 156 Units
 $CAP. = \frac{[(156 \times 5) + (16 \times 2)] \times 172.5}{2}$
= 70,035 Its.
= Say 70,040 Its.
Flushing = 24,515 Its.
Domestic = 45,525 Its.
Fire = 10,000 Its.

MUMTY/ OVERHEAD WATER TANK AREA DETAIL				
NAME	WIDTH (MM)	HEIGHT (MM)	NO. OF UNITS	AREA (SQ M)
T1	12800	9200	1	117.76
			TOTAL	117.76

2 Type D- Ground Floor Area detail
SCALE - 1:110

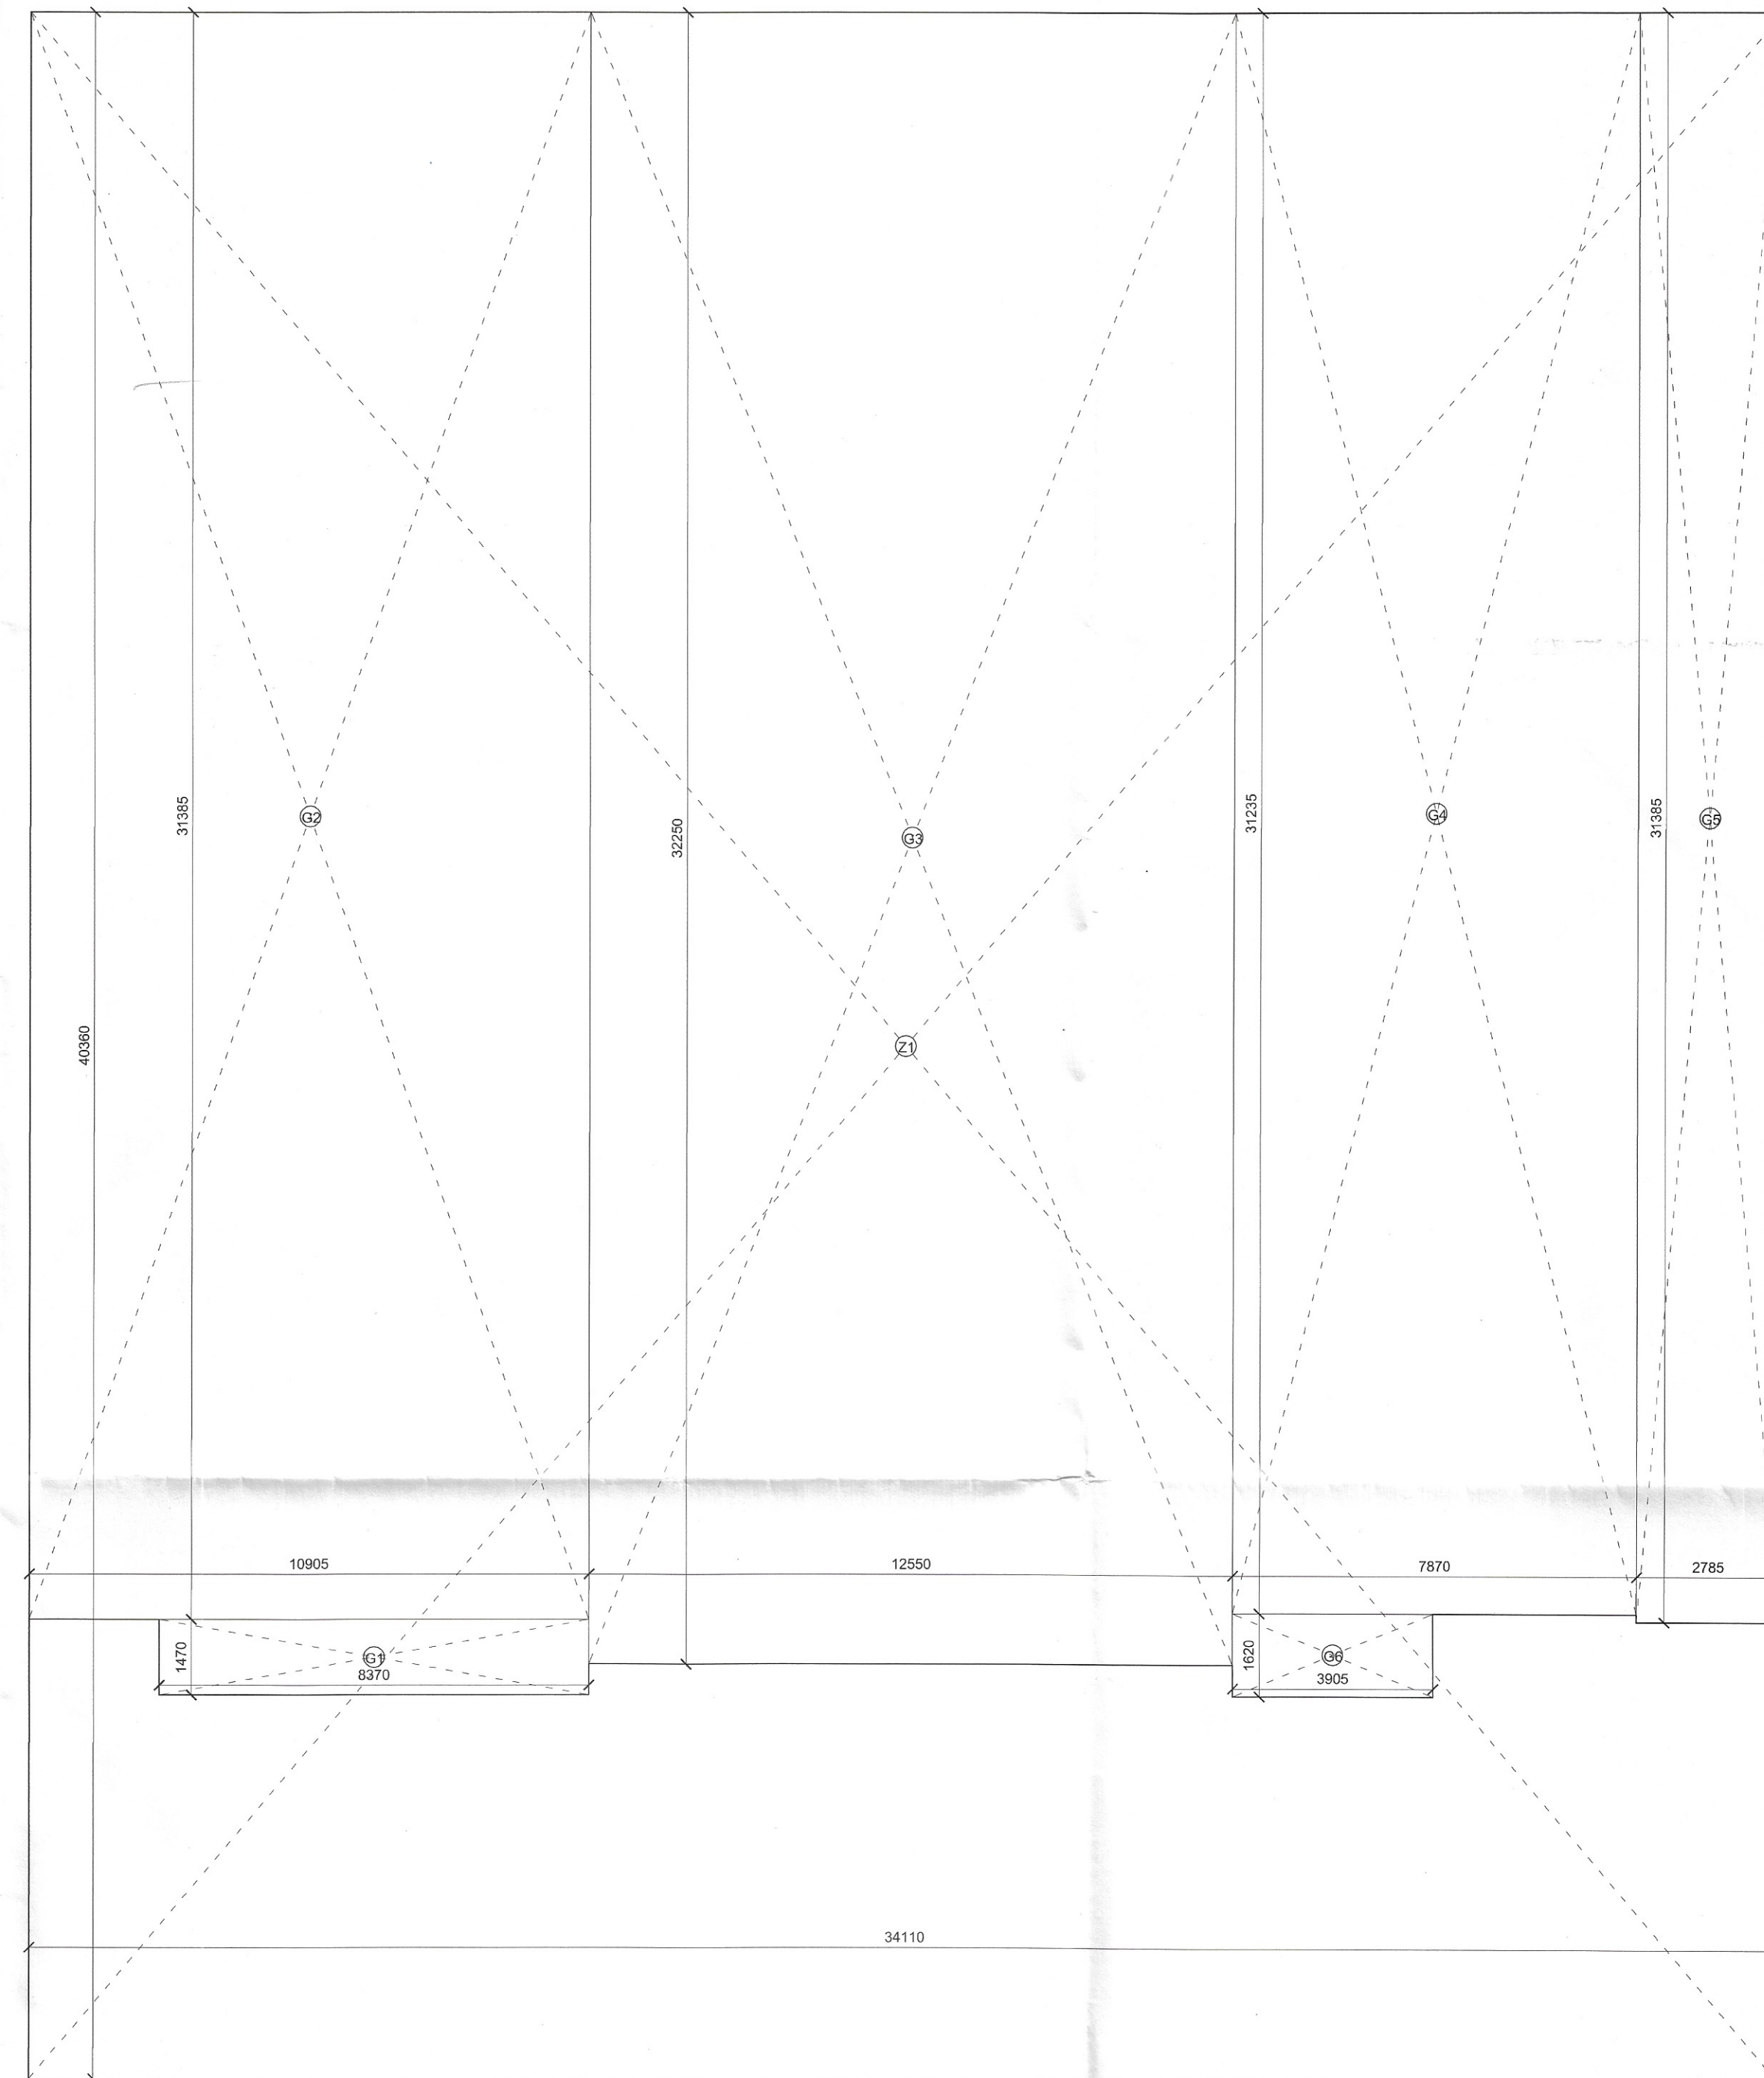

DOOR/WINDOW SCHEDULE						
SN.	Type	Width (mm)	Cill (mm)	Lintel (mm)	Height (mm)	Notes
1	D1	1100	±00	+2400	2400	1 hour fire rated door
2	D2	800	±00	+2400	2400	
3	D3	1050	±00	+2400	2400	
4	D4	750	±00	+2400	2400	
5	D5	1200	±00	+2400	2400	1 hour fire rated door
6	D6	1000	±00	+2400	2400	
7	DW1	2595	±00	+2650(BOB)	2650	
8	DW2	1350	±00	+2650(BOB)	2650	
9	DW3	3200	±00	+2650(BOB)	2650	
10	DW4	1630	±00	+2650(BOB)	2650	
11	DW5	1390	±00	+2650(BOB)	2650	
12	DW6	1200	±00	+2650(BOB)	2650	
13	DW7	3150	±00	+5350(BOB)	5350	
14	DW8	2400	±00	+5350(BOB)	5350	
15	DW9	1230	±00	+5350(BOB)	5350	
16	V1	800	+1350	+2100	750	
17	V2	450	+1350	+2100	750	
18	V3	1200	+2400	+2650(BOB)	250	
19	W1	1800	+1200	+2650(BOB)	1450	

LEGEND:-

- 1 110 OD SWR PVC SOIL & WASTE PIPE
- 2 75 OD SWR PVC VENT PIPE
- 3 110 OD uPVC RAIN WATER PIPE (FOR BALCONY)
- 4 110 OD uPVC RAIN WATER PIPE (FOR TERRACE)
- 5 F.T. FLOOR TRAP
- 6 F.D. FLOOR DRAIN
- 7 PENDENT SPRINKLER
- 8 SIDEWALL SPRINKLER

DRAWING TITLE	DWG. NO.
TYPE D- TERRACE & OHT FLOOR AREA DETAIL	S - 105c

This is a "PROVISIONAL BUILDING PLAN" approved only for the purpose of inviting objections from the general public

S.T.P (H) S.T.P (G) C.T.P (Hr.)
B.P.A.C. Member Chairman
B.P.A.C. B.P.A.C. B.P.A.C.

DTP (HQ) ATP (HQ)
S.D. P.A. A.P.

Checked and found ok for Public Health (Internal) Service only subject to comments in forwarding letter No. 2026.75.DV...19/07/2024

Superintending Engineer (HQ)
Chief Engineer-I
MVP, Panchkula


DDP (HQ)
Member
BPAC

PROJECT TITLE
Approval of Building plans for Group Housing Colony over an additional area measuring 7.64375 acres (Licence No. 34 of 2024 dated 07.03.2024) in addition to group housing colony measuring 25.44 acres (Licence No. 78 of 2010 dated 15.10.2010), Grand total area 33.08375 acres in Sector-69-70, GMUC, Gurgram being developed by M/S Tulip Infratech Pvt. Ltd. in collaboration with land owners .

OWNERS
TULIP INFRATECH PVT. LTD.

ARCHITECTS
designcosmos
A-609, Second Floor,
Sushant Lok Ph-1, Gurgaon
Ph- 0124 4203676

DATE March 2024
SCALE 1:110
DEALT AB
CHECKED MA

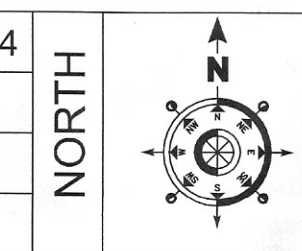

OWNER's SIGNATURE
For TULIP INFRATECH PVT. LTD.
Authorised Signatory

ARCHITECT's SIGNATURE
APOORV SINGH
CA/2008/42704