



LEGEND	
1	110 OD SWR PVC SOIL & VENT PIPE
2	110 OD SWR PVC WASTE & VENT PIPE
3	110 OD SWR PVC ANTISYPHONIC PIPE
4	DWS DN. TAKE PIPE (GROUND TO 12th FLOOR)
5	FWS DN. TAKE PIPE (GROUND TO 18th FLOOR)
6	DWS DN. TAKE PIPE (13 TO 24th FLOOR)
7	DWS DN. TAKE PIPE (25 TO 36th FLOOR)
8	FWS DN. TAKE PIPE (19 TO 38th FLOOR)
9	DWS DN. TAKE PIPE (37th & 38th FLOOR)
10	500 DWS RISER TO O.H.T. FILLING TANK
11	500 FWS RISER TO O.H.T. FILLING TANK
12	110 OD uPVC RAIN WATER PIPE FOR BALCONY
13	110 OD uPVC RAIN WATER PIPE FOR TERRACE
F.T.	FLOOR TRAP
F.D.	FLOOR DRAIN

LEGEND:-	
1	1500 M.S. FIRE SPRINKLER PIPE (LOW ZONE) GROUND FLOOR TO 13th FLOOR
2	1500 M.S. FIRE SPRINKLER STANDBY PIPE (LOW ZONE) GROUND FLOOR TO 13th FLOOR
3	1500 M.S. FIRE SPRINKLER PIPE (MIDDLE ZONE) 14th FLOOR TO 25th FLOOR
4	1500 M.S. FIRE SPRINKLER STANDBY PIPE (MIDDLE ZONE) 14th FLOOR TO 25th FLOOR
5	1500 M.S. FIRE SPRINKLER PIPE (HIGH ZONE) 26th FLOOR TO TERRACE FLOOR
6	1500 M.S. FIRE SPRINKLER STANDBY PIPE (LOW ZONE) 26th FLOOR TO TERRACE FLOOR
7	1000 M.S. FIRE HYDRANT PIPE (LOW ZONE) GROUND FLOOR TO 13th FLOOR
8	1000 M.S. FIRE HYDRANT PIPE (LOW ZONE) 14th FLOOR TO 25th FLOOR
9	1000 M.S. FIRE HYDRANT PIPE (LOW ZONE) 26th FLOOR TO TERRACE FLOOR
10	1500 M.S. FIRE MAKE-UP PIPE
11	500 M.S. FIRE SPRINKLER DRAIN PIPE

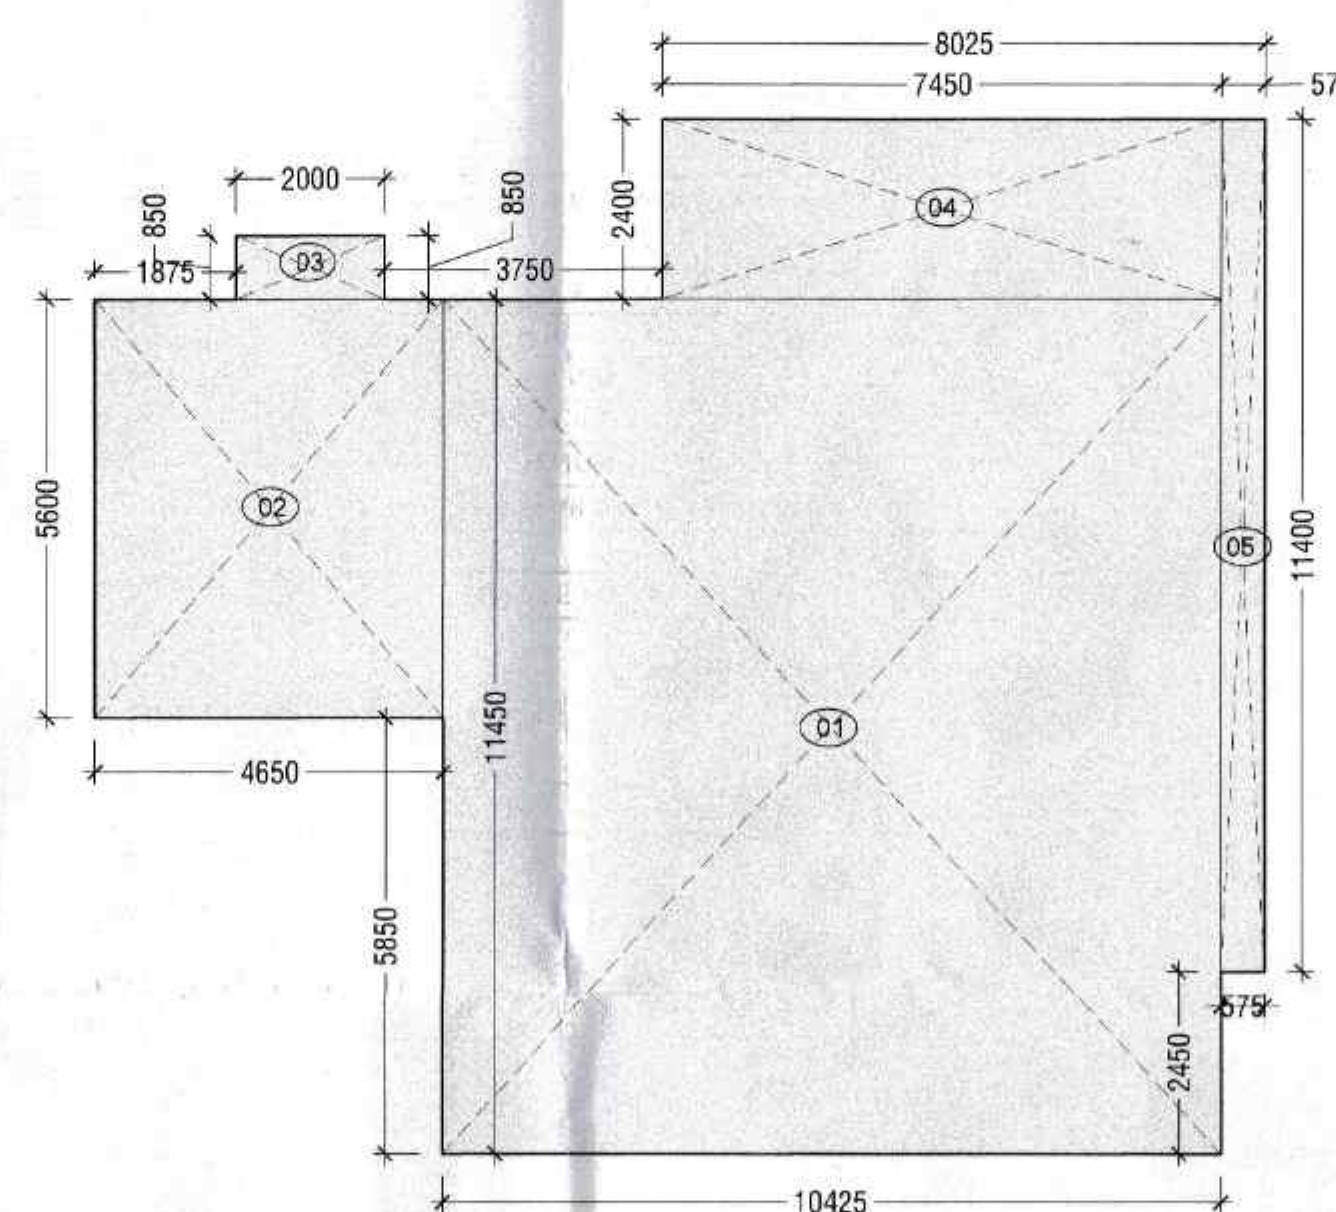



TERRACE AREA PLAN

TERRACE FLOOR AREA DETAIL					
NON - FAR AREA CALCULATIONS					
ITEM	WIDTH-1	LENGTH	FACTOR	NOS	AREA
1	10.425	X 11.450	X 1	X 1	119.366
2	4.650	X 5.600	X 1	X 1	26.040
3	2.000	X 0.850	X 1	X 1	1.700
4	7.450	X 2.400	X 1	X 1	17.880
5	0.575	X 11.400	X 1	X 1	6.555
TOTAL NON FAR AREA (Y) =					171.541

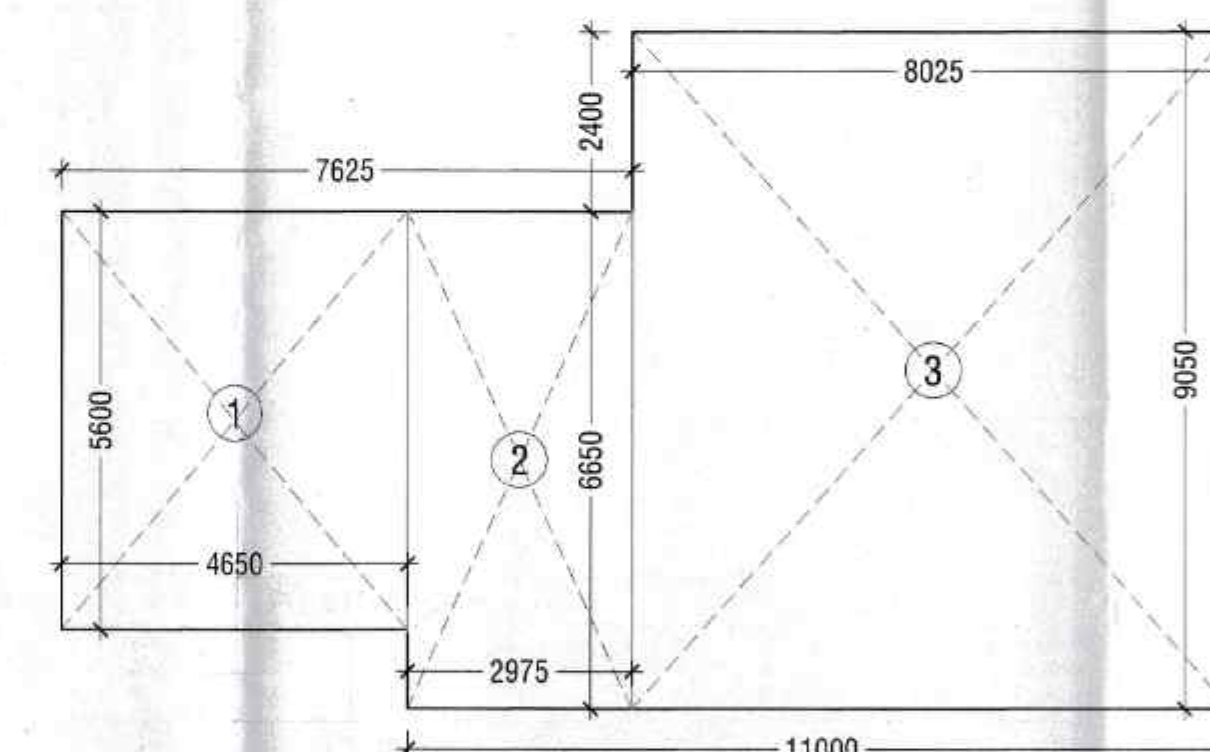

OH TANK & MACHINE ROOM AREA PLAN

MUMTY & MACHINE ROOM AREA CALCULATION					
S. No.	COEFF.	WIDTH	LENGTH	NOS.	AREA IN SQMT
1	1	4.650	5.600	1	26.040
2	1	2.975	6.550	1	19.784
3	1	8.025	9.050	1	72.626
TOTAL AREA					118.450

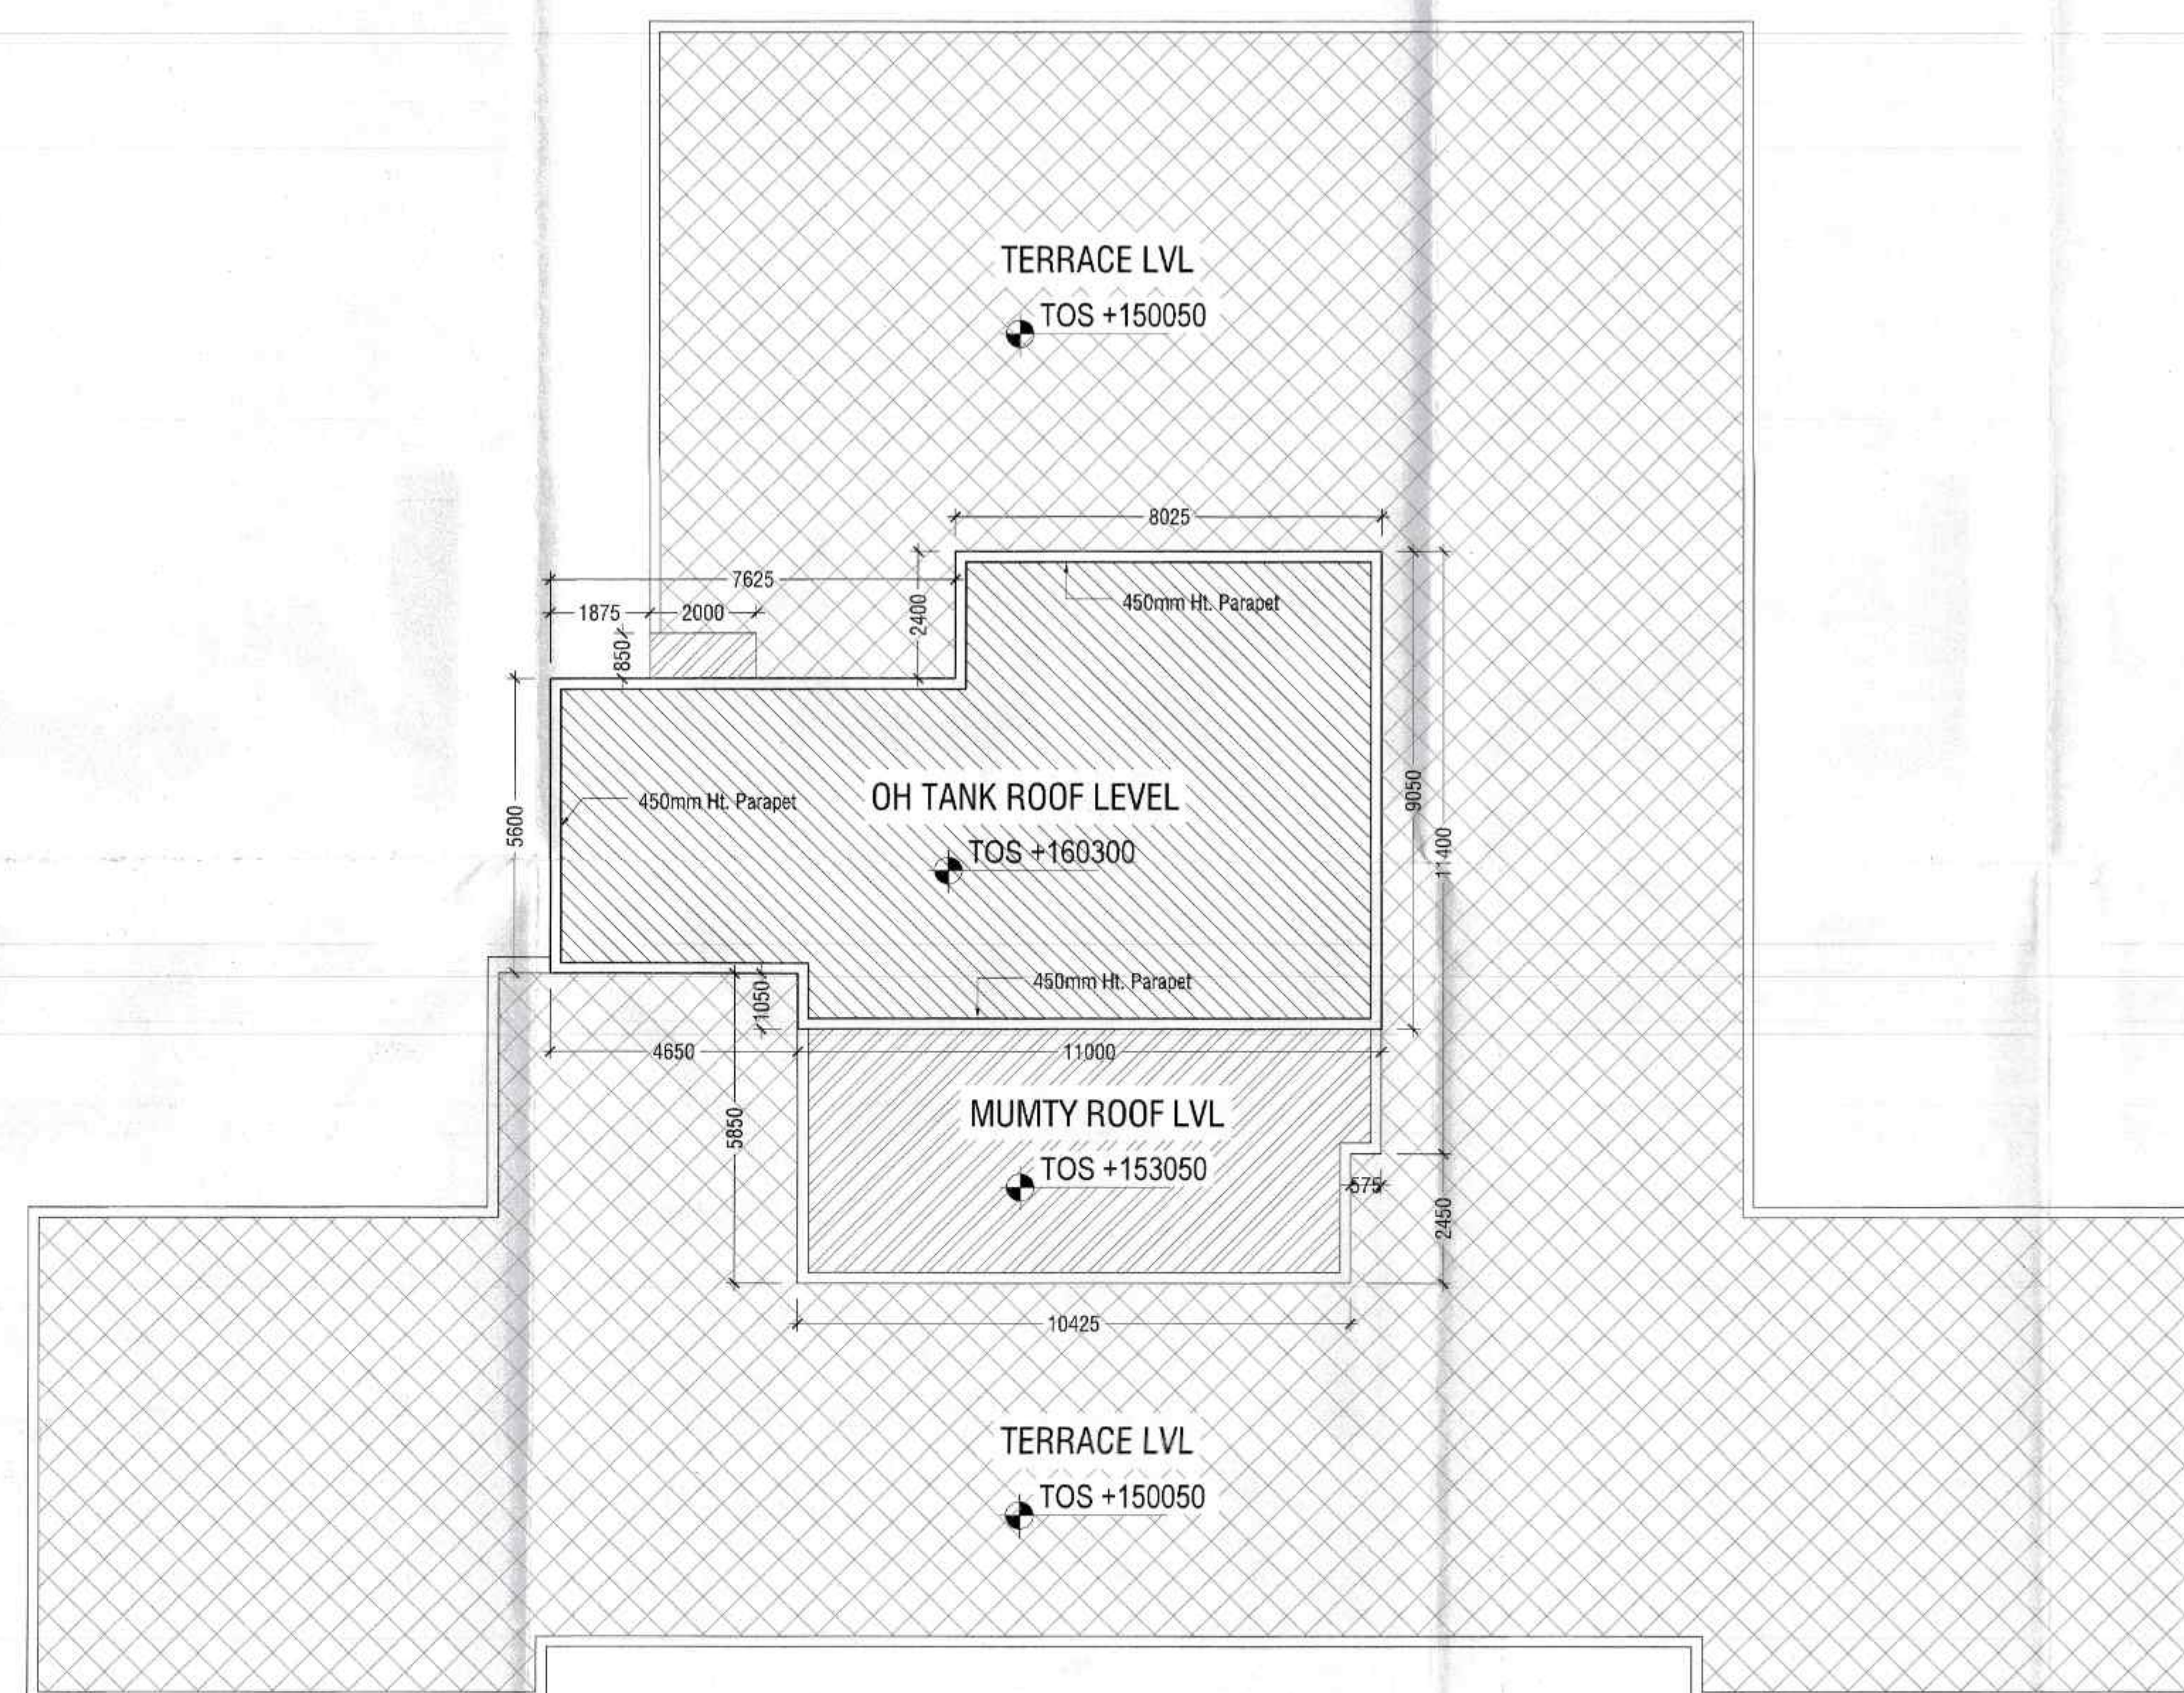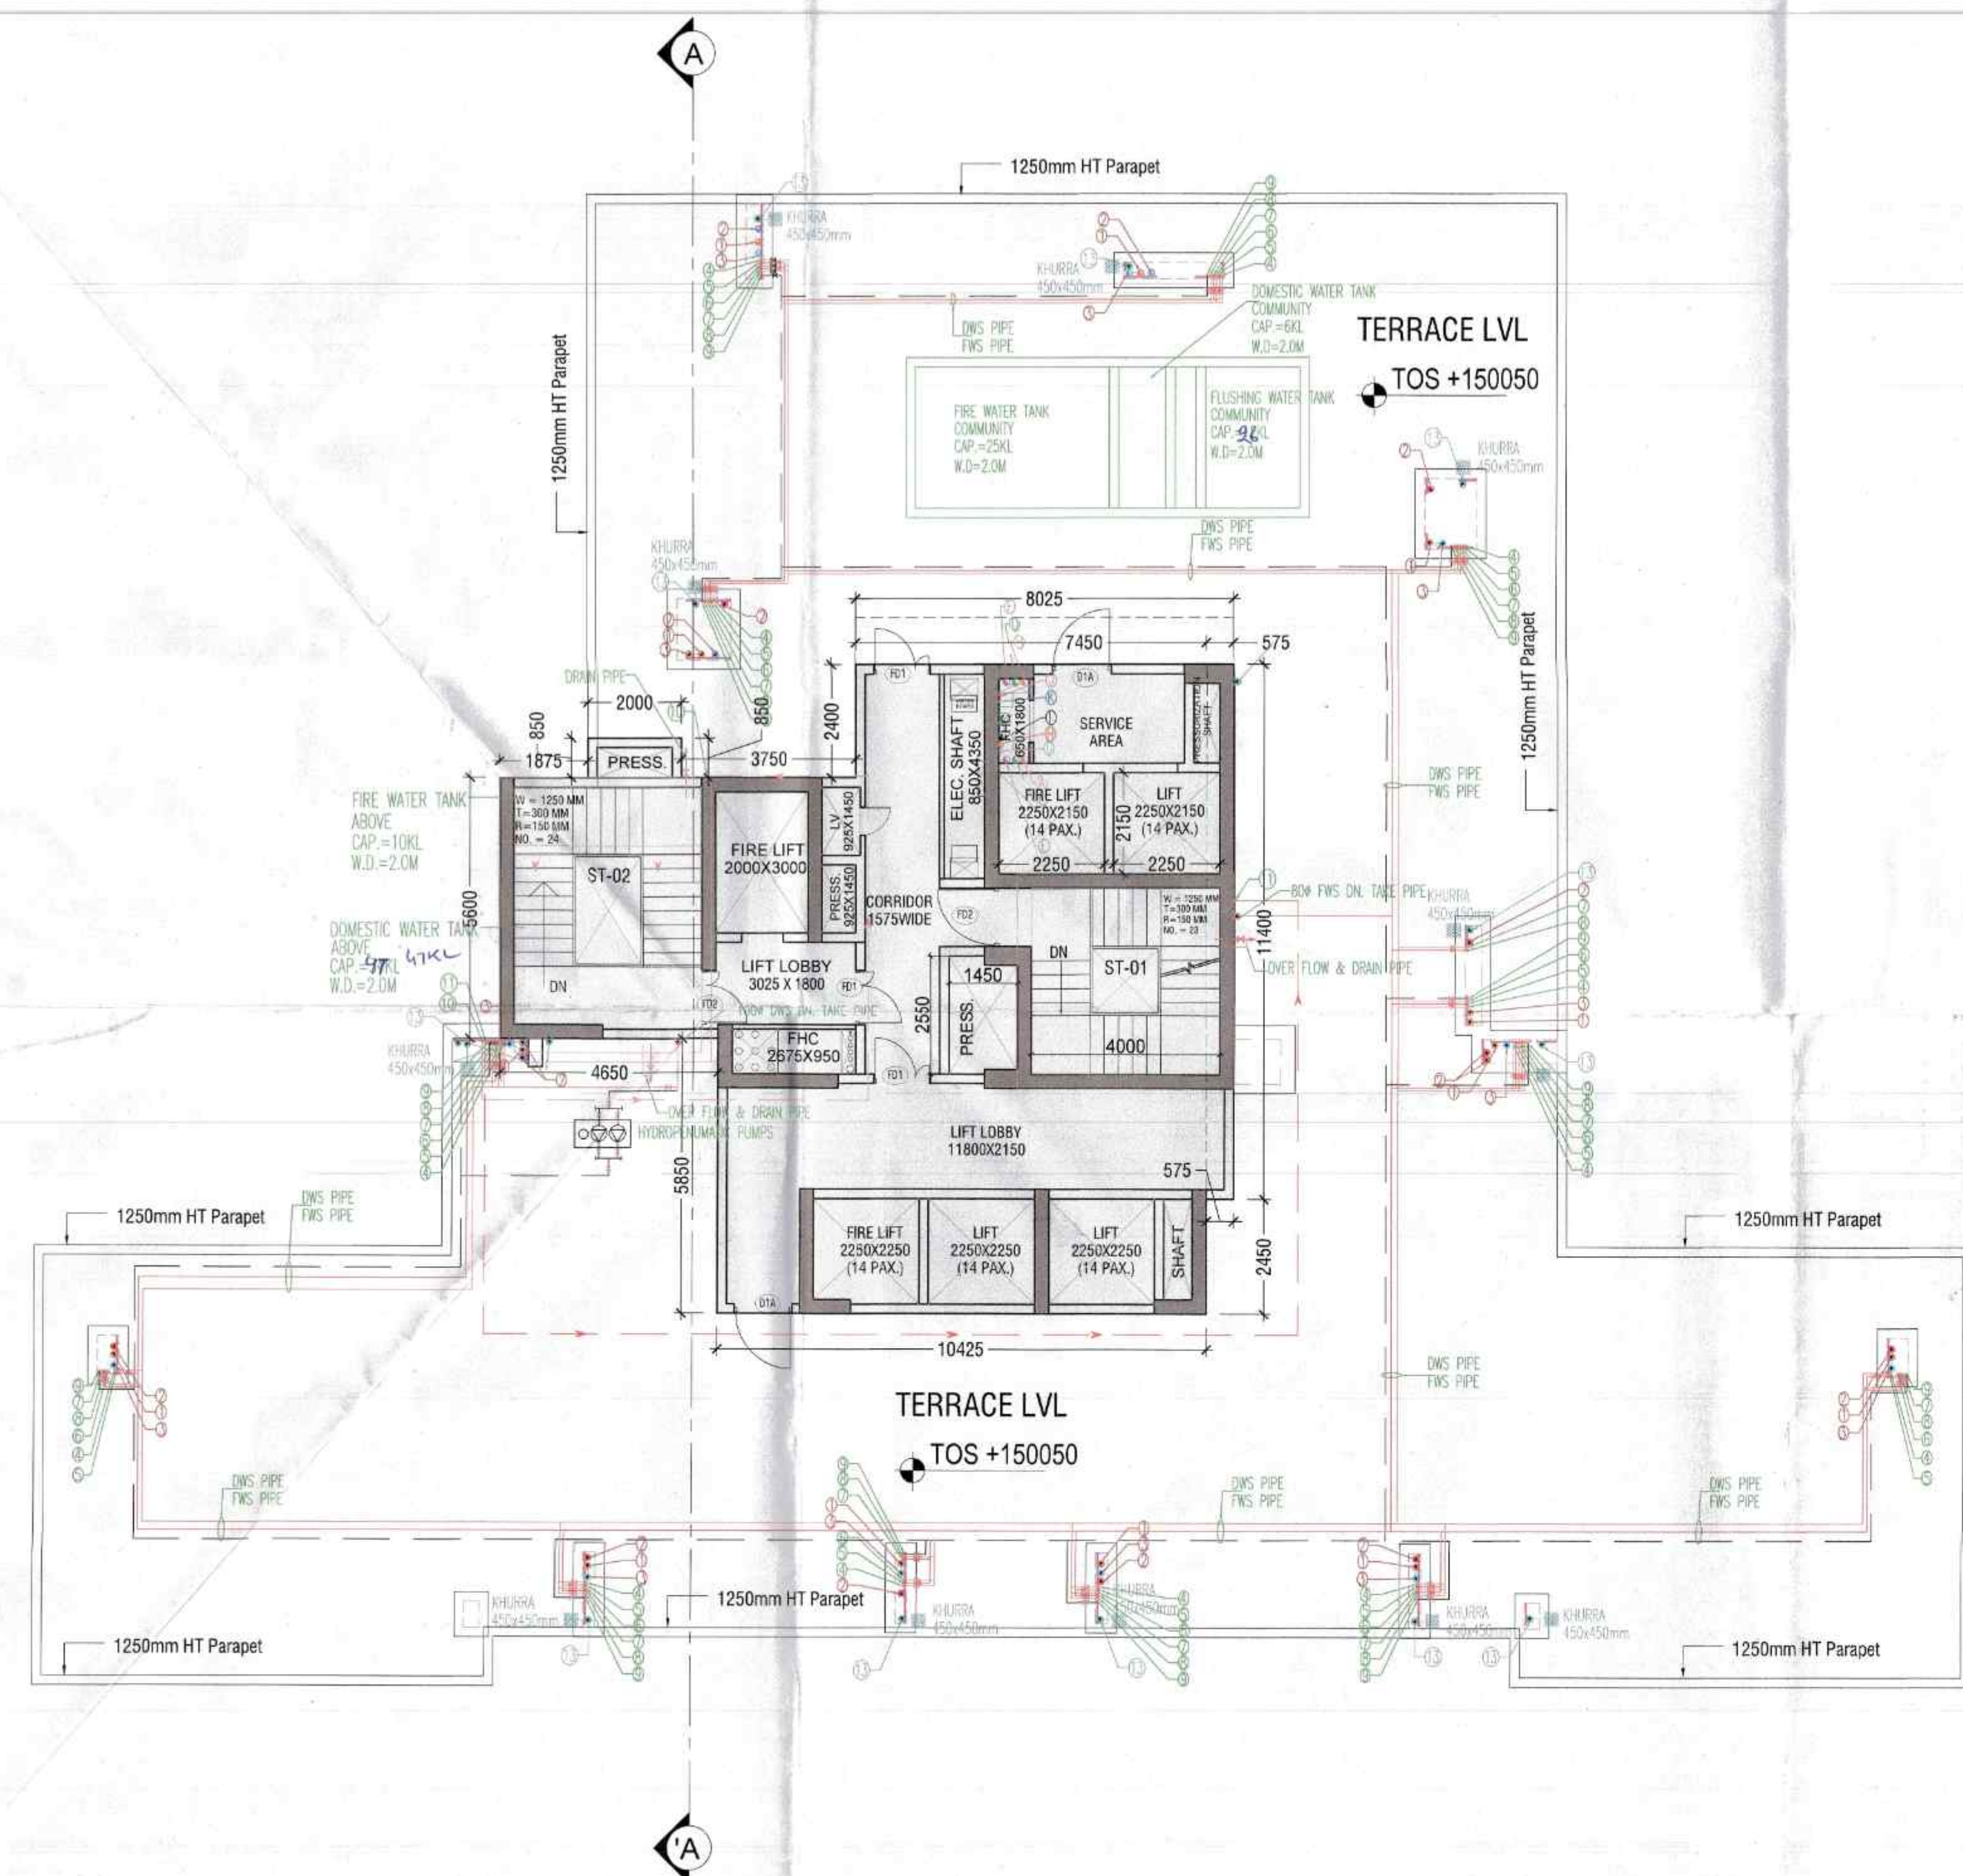

This is a "PROVISIONAL BUILDING PLAN" approved only for the purpose of inviting objections from the general public.

DTF(HQ) ATP(HQ) Rajesh Dutt SD(HQ)

TO BE READ WITH THIS OFFICE MEMO NO. DATED:

Checked and found ok for Public Health (Internal) Service only subject to comments in forwarding. DATED: 20/01/2023

Superintending Engineer (HQ) Civil Engineer-I 15319, Panjabnagar

DRAWING TITLE: TERRACE FLOOR & ROOF PLAN PLAN & AREA DETAIL (TOWER-B1)

DRAWING NO: S08 DTP(T) MEMBER BPAC

ACPL

ACPL Design Ltd

ISO 9001:2015 Architecture Management Planning

PROPOSED BUILDING PLANS OF GROUP HOUSING COLONY MEASURING 10.868 ACRES (LICENSE NO. 33 OF 2011 DATED 16.04.2011) IN THE REVENUE ESTATE OF VILLAGE TIKAMPUR, SECTOR - 103, GURGAON, MANESAR URBAN COMPLEX, IS BEING DEVELOPED BY SH. ROSHAN LAL AND OTHERS C/O M/s LANDMARK APARTMENT Pvt. Ltd.

For Landmark Apartments Pvt. Ltd. Authorized Signatory

Sumit Shandani Architect

OWNER'S/AUTHORIZED SIGN.

ARCHITECT'S SIGN.

TERRACE FLOOR & ROOF PLAN PLAN & AREA DETAIL (TOWER-B1)

DRAWING NO. S-08

SCALE: 1:100