






12th FLOOR PLAN

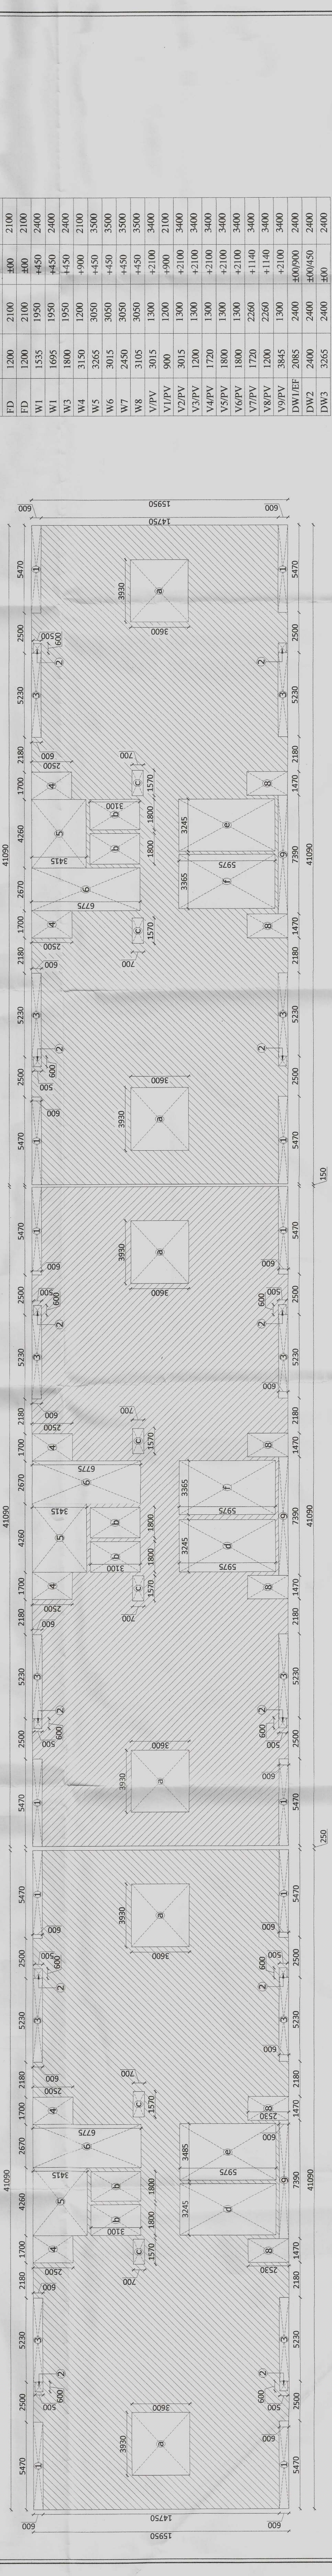

3rd to 12th FLOOR PLAN

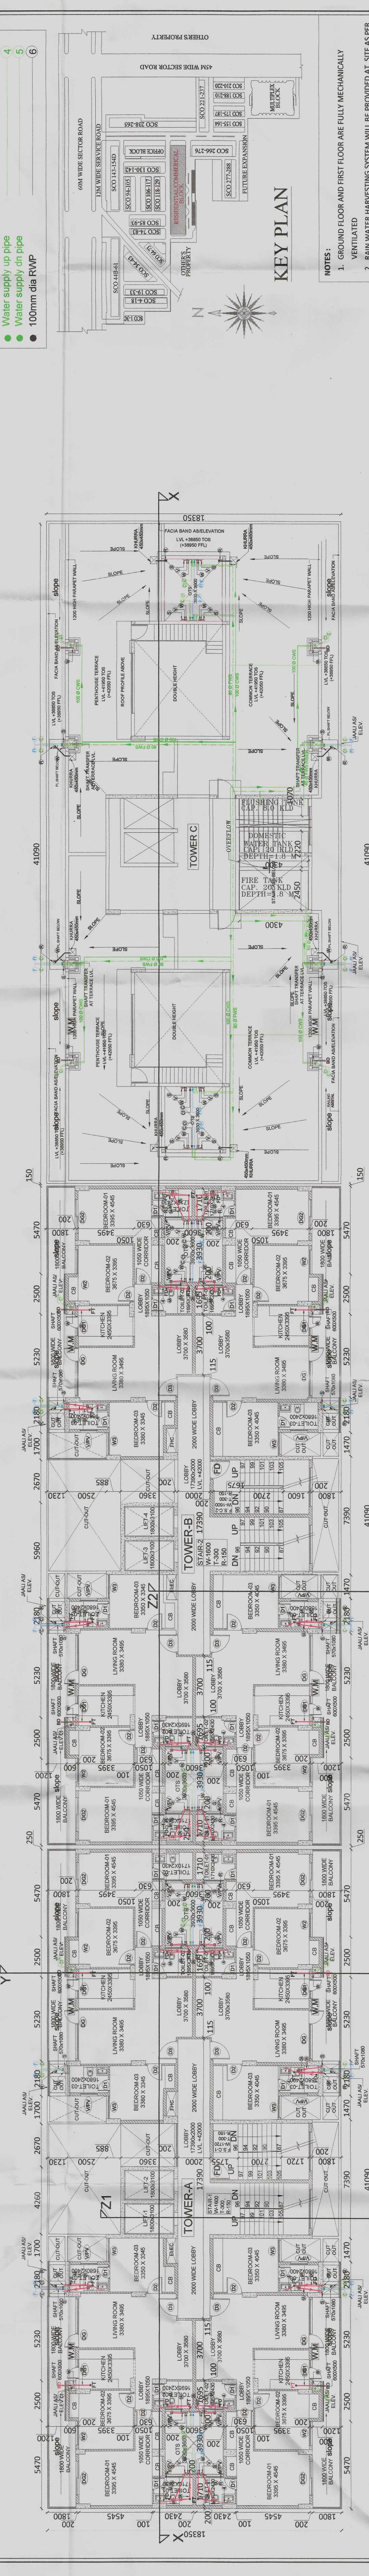

13th FLOOR PLAN

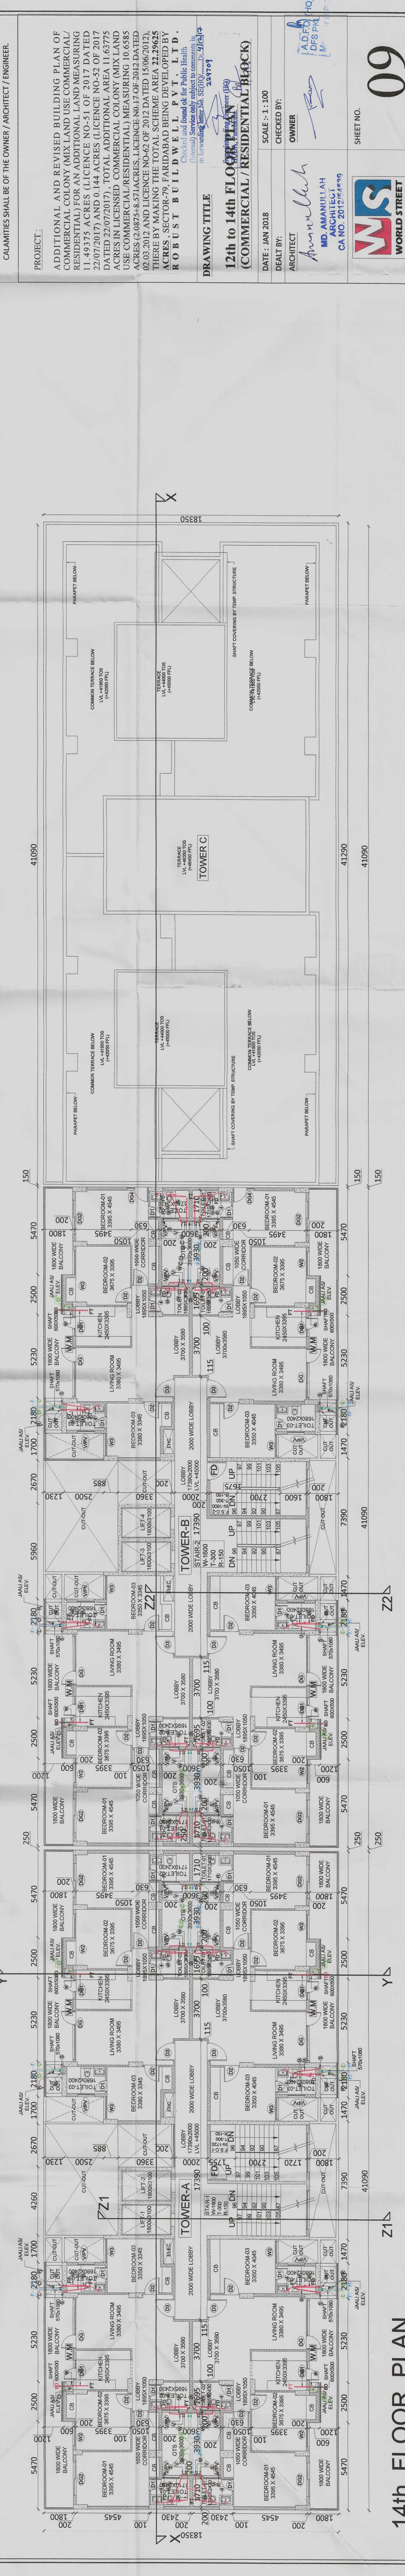


14th FLOOR PLAN

SCHEDULE OF OPENING

TYPE	WIDTH	HEIGHT	CILL	LINTEL
D1	750	2100	400	2100
D2	1000	2100	400	2100
D3	1000	2100	400	2100
D4	1200	2100	400	2100
D5	1200	2100	400	2100
D6	1200	2100	400	2100
D100	1200	2100	400	2100

- LEGEND
- 100mm dia SOIL WASTE PIPE
 - 100mm dia WASTE PIPE
 - 75mm dia Antisiphonage pipe
 - Water supply to pipe
 - Water supply to RWP
 - 100mm dia RWP

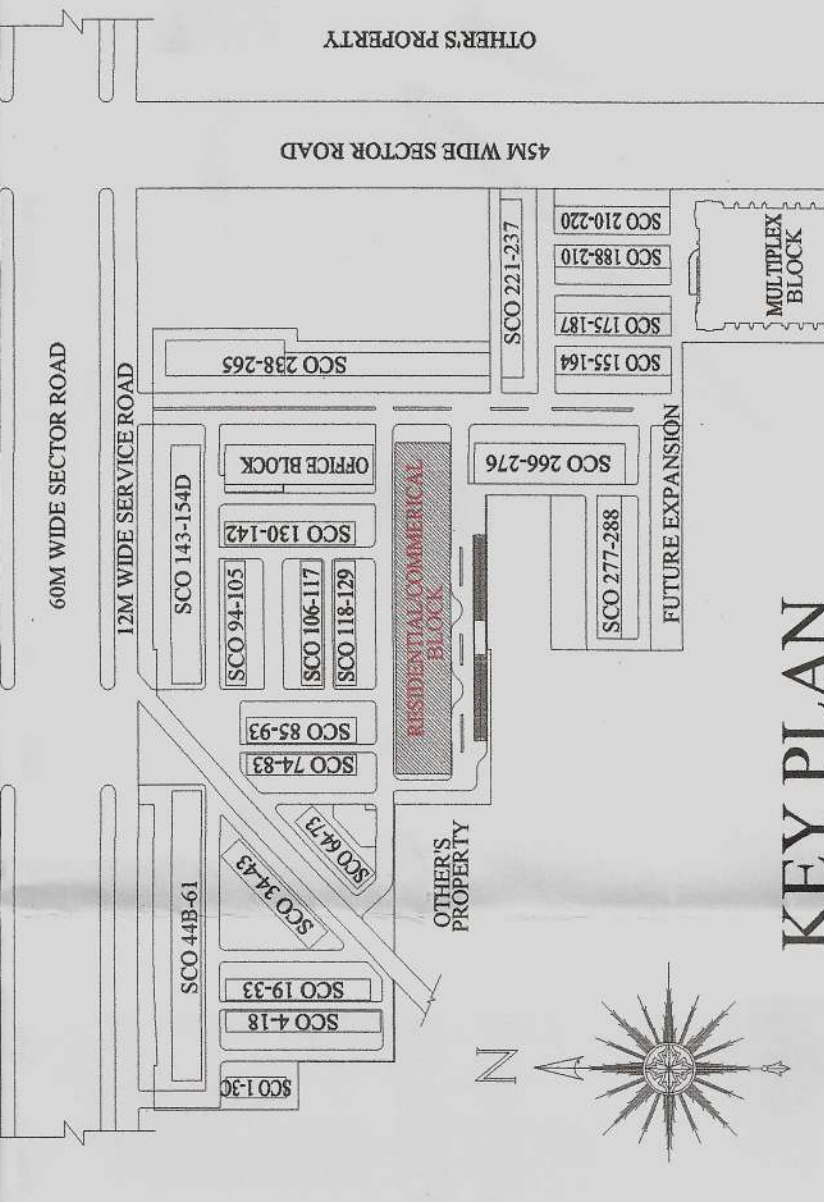

- NOTES:
- GROUND FLOOR AND FIRST FLOOR ARE FULLY MECHANICALLY VENTILATED
 - RAIN WATER HARVESTING SYSTEM WILL BE PROVIDED AT SITE AS PER PREVAILING GOVERNMENT NORMS
 - SOAK WATER PIT SHALL BE PROVIDED AT SITE AS PER PREVAILING GOVERNMENT NORMS
 - RESPONSIBILITY OF STRUCTURE STABILITY OF ENTIRE BUILDING BLOCKS W.E.T. EARTH QUAKE POINT OF VIEW AND OTHER NATURAL CALAMITIES SHALL BE OF THE OWNER / ARCHITECT / ENGINEER.

PROJECT: ADDITIONAL AND REVISED BUILDING PLAN OF ROBUST BUILDWELL PVT. LTD. (COMMERCIAL / RESIDENTIAL BLOCKS) 12th to 14th FLOOR PLAN

DATE: JAN 2018

CHECKED BY: SCALE: 1:100

DESIGN BY: OWNER

ARCHITECT: Anandh

MD ANANDH

CA NO 2012/4499

SHEET NO. 09

WORLD STREET

ROBUST BUILDWELL PVT. LTD.