




Note:-
1. BUILDING WILL BE DESIGNED (STRUCTURES)
AS PER RELEVANT IS CODES FOR EARTH
QUAKE RESISTANCE
3. BUILDING IS ARTIFICIALLY LIGHTED MECHANICALLY
VENTILATED & WITH 100% POWER BACKUP

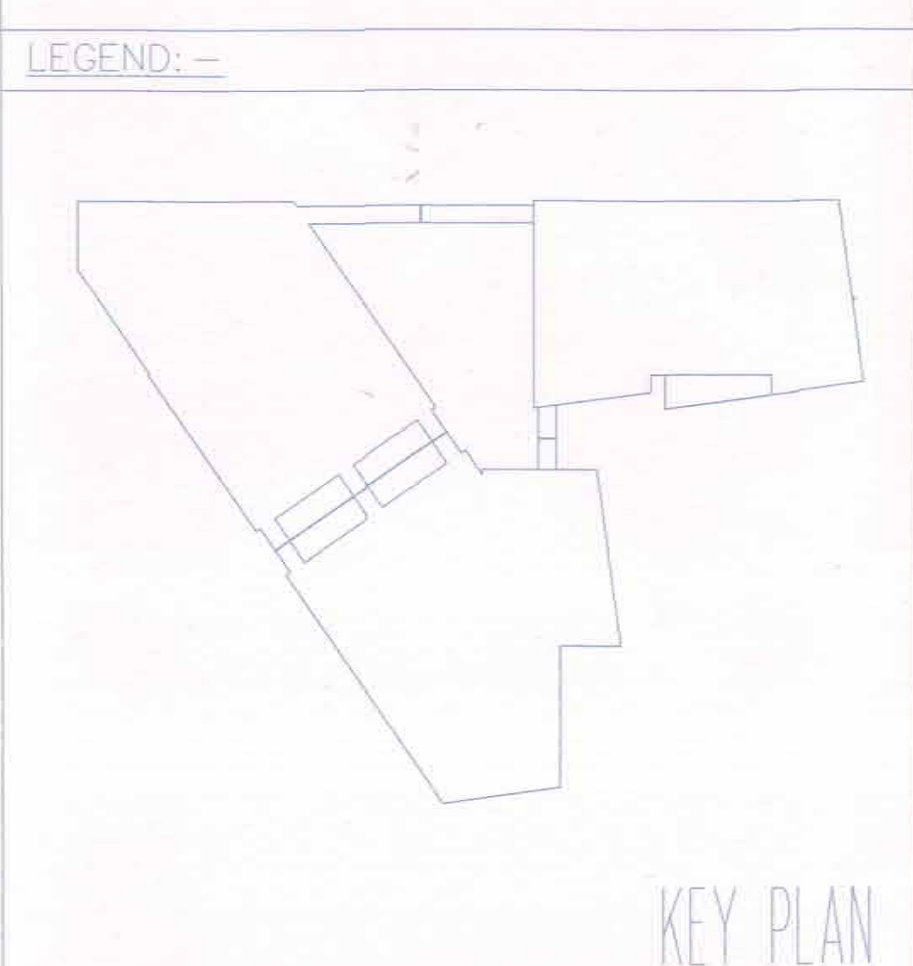

LEGEND:-

- 75 (d) UPVC GARDEN IRRIGATION RING MAIN
- GARDEN HYDRANT
- 1000 MUNICIPAL LINE TO LG TANK
- 1000 RECYCLED LINE TO LG TANK FROM TOWN SHIP
- BONE WELL

Project:

REVISED BUILDING PLAN OF WING-A(PART-01)
-GROUND & UPPER GROUND FLOOR &
WING-B - GROUND,UPPER GROUND,6TH & 7TH
FLOOR OF COMMERCIAL SITE MEASURING-1.60
ACRES, BLOCK-F (82)FALLING IN RESIDENTIAL
PLOTED COLONY MEASURING-477.206 ACRES
(LICENSE NO. 113 OF 2008 DATED
01-06-2008, LICENSE NO. 71 OF 2010 DATED
15-09-2010,LICENSE NO. 62 OF 2011 DATED
02-07-2011,LICENSE NO. 76 OF 2011 DATED
07-09-2011 & LICENSE NO. 66 OF 2014
DATED 15-07-2014)IN SECTOR-81 TO 85
,GURGAON MANESAR URBAN COMPLEX BEING
DEVELOPED BY VATIKA LTD. AND OTHERS.

project Architects

S U A
ARCHITECTS

S U A ARCHITECTS
FLOOR 14 BUILDING TWO VATIKA BUSINESS PARK
SEC 49 GURGAON 122018 Haryana, India
t: +91 124 4313000 , f: +91 124 4313001

Associate Architects

RSMS
ARCHITECTS

RSMS ARCHITECTS PVT. LTD.
69,Nora Niwas Bhowani Kunj
(Behind D2), Vasant Kunj,
New Delhi-110070.
Tel.: 011-26898616,26898617
www.rsms-arch.com

Sanctioned and valid for Five Years
Subject to validity of Licence CDU

OWNER'S SEAL
& SIGNATURE

VATIKA LIMITED

ARCHITECT'S SEAL
& SIGNATURE

S U A
ARCHITECTS

MAY-2018, Scale : 1:250

Drawing Title:-
SITE PLAN
(WATER SUPPLY & IRRIGATION SCHEME)

Drawing No:-
ST-02

RO-SUB: REVISED BUILDING PLAN OF 6TH & 7TH F WING-B
(6TH & 7TH FLOOR COMMERCIAL SITE
MEASURING-1.60 ACRES)BLOCK-F (82) FALLING IN
RESIDENTIAL PLOTED COLONY MEASURING -
477.206 ACRES

VATIKA TOWN
SQUARE - 2