
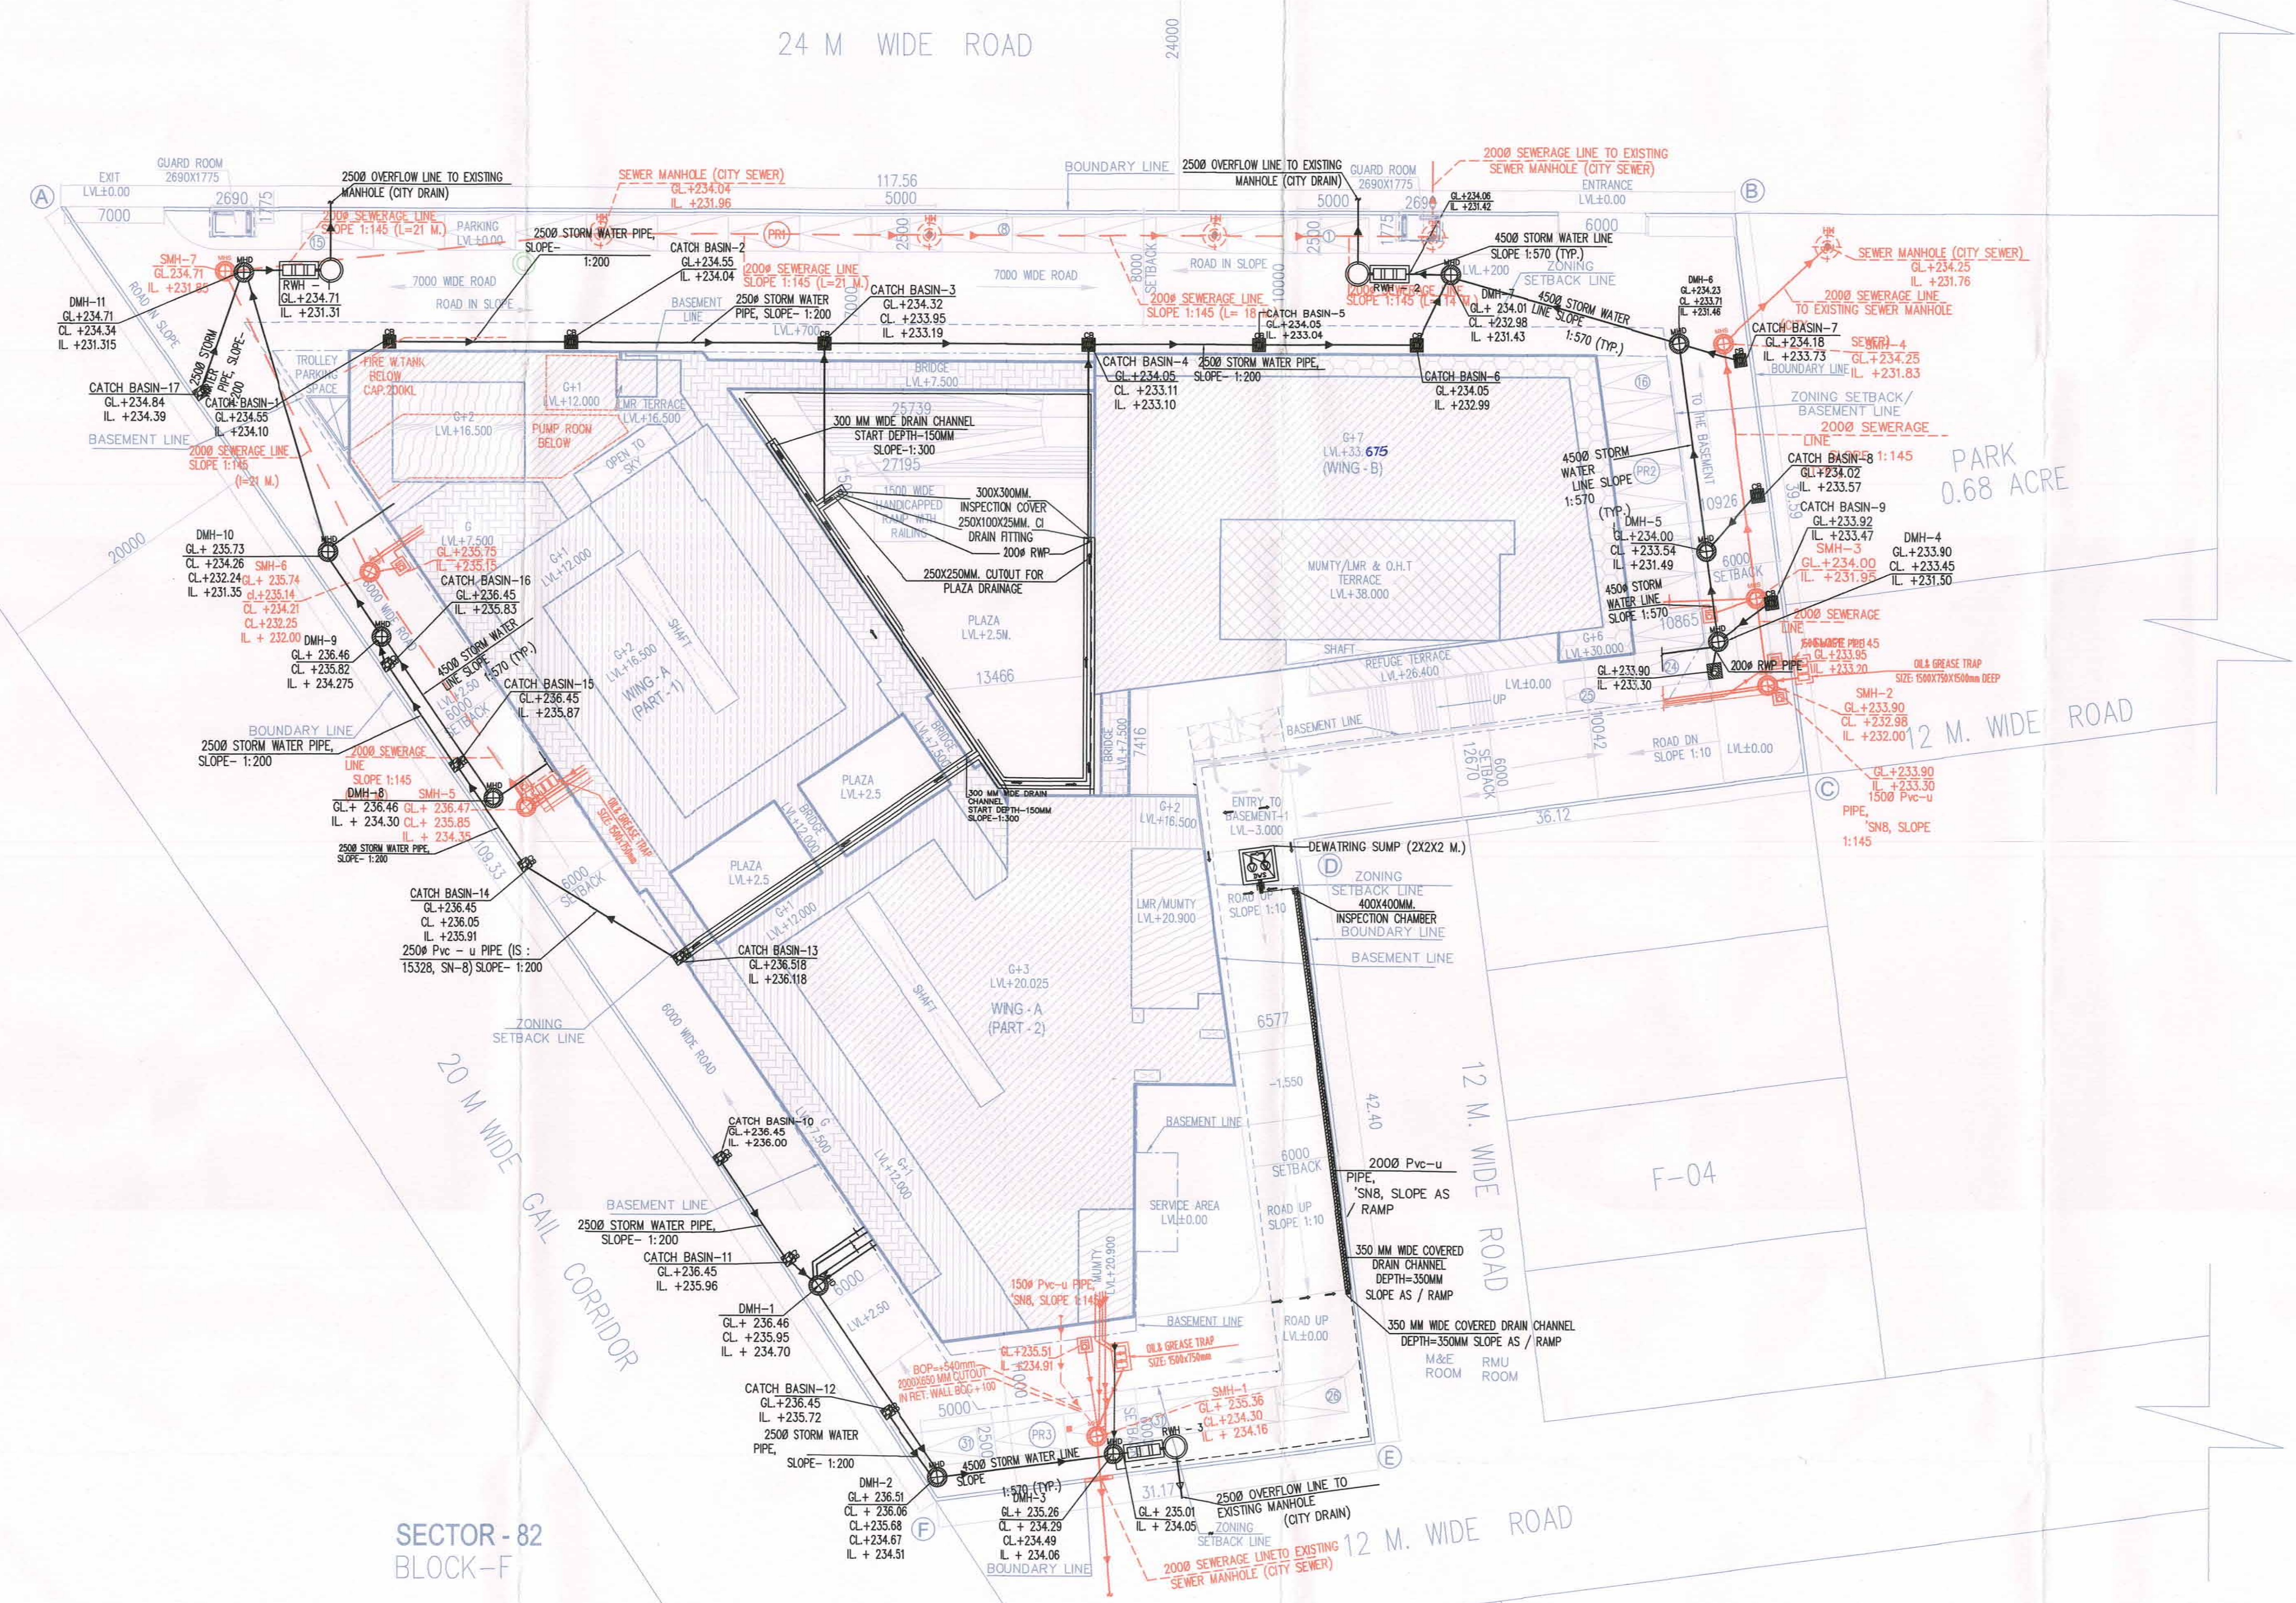


Note:-
1. BUILDING WILL BE DESIGNED (STRUCTURES)
AS PER RELEVANT CODES FOR EARTH
QUAKE RESISTANCE.
3. BUILDING IS ARTIFICIALLY LIGHTED MECHANICALLY
VENTILATED & WITH 100% POWER BACKUP

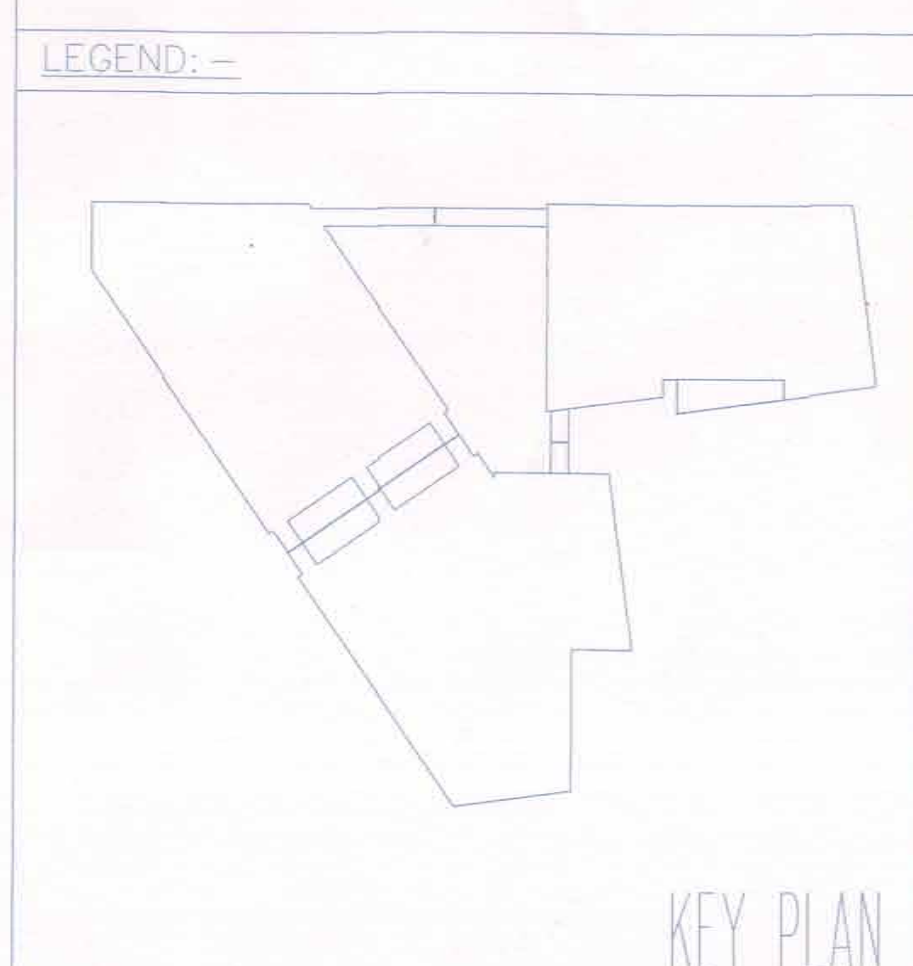

SEWERAGE:-

S.NO	DESCRIPTION	SYMBOL
1.	SUMP RISER PIPE	
2.	610X550 MM INSPECTION CHAMBER	
3.	2000 SEWERAGE PIPE LINE SLOPE @ 1:145	
4.	SEWER MANHOLE	
5.	910 mm Ø M.H. DEPTH= 900 - 1670mm	
6.	1220 mm Ø M.H. DEPTH= 1680 - 2290mm	
7.	1550mm Ø M.H. DEPTH= 2300 - 4500mm & above	
8.	GROUND LEVEL	G.L.
9.	CONNECTION LEVEL	C.L.
10.	INVERT LEVEL	I.L.

LEGEND:-

	2000 SEWERAGE PIPE LINE, SLOPE - 1:145
	SUMP RISER TO MANHOLE
	610X550 MM INSPECTION CHAMBER
	SEWERAGE MANHOLE

STORM WATER DRAINAGE:-

S.NO	DESCRIPTION	SYMBOL
1.	STORM WATER PIPE LINE 450M R.C.C PIPE SLOPE 1:570	
2.	U/LAY BASIN SIZE=500X450mm	
3.	STORM WATER MANHOLE	
4.	MAN HOLE SIZE=900mm DEPTH=910 TO 1670mm	
5.	MAN HOLE SIZE=1220mm DEPTH=1680 TO 2290mm	
6.	MAN HOLE SIZE=1550mm DEPTH=2300 TO 4500mm	
7.	RAIN WATER HARVESTING	
8.	GROUND LEVEL	G.L.
9.	CONNECTION LEVEL	C.L.
10.	INVERT LEVEL	I.L.

Project:
REVISED BUILDING PLAN OF WING-A(PART-01)
-GROUND & UPPER GROUND FLOOR &
WING-B - GROUND, UPPER GROUND, 6TH & 7TH
FLOOR OF COMMERCIAL SITE MEASURING-1.60
ACRES, BLOCK-F (82) FALLING IN RESIDENTIAL
PLOTTED COLONY MEASURING-477.206 ACRES
(LICENSE NO. 113 OF 2008 DATED
01-06-2008, LICENSE NO. 71 OF 2010 DATED
15-09-2010, LICENSE NO. 62 OF 2011 DATED
02-07-2011, LICENSE NO. 76 OF 2011 DATED
07-09-2011 & LICENSE NO. 66 OF 2014
DATED 15-07-2014) IN SECTOR-81 TO 85
GURGAON MANESAR URBAN COMPLEX BEING
DEVELOPED BY VATIKA LTD. AND OTHERS.

project Architects
S U A
ARCHITECTS
S U A ARCHITECTS
FLOOR 14 BUILDING TWO VATIKA BUSINESS PARK
SEC 49 GURGAON 122018 Haryana, India
t: +91 124 4313000, f: +91 124 4313001

Associate Architects
R S M S
ARCHITECTS

RSMS ARCHITECTS PVT. LTD.
69, Nara Niwas Bhawani Kunj
(Behind D2), Vasant Kunj,
New Delhi-110070.
Tel.: 011-26898616, 26898617
www.rsms-arch.com

OWNERS SEAL & SIGNATURE
Chairman
Building Plan Committee Controlled Area
Gurgaon City Corporation
Date: / /

ARCHITECT'S SEAL & SIGNATURE

MAY-2018. Scale: 1:250
Drawing Title:-
(STORM WATER & SEWERAGE SCHEME)
Drawing No:-
ST-03
SITE PLAN
REVISED BUILDING PLAN OF 6TH & 7TH F WING-B
(6TH & 7TH FLOOR COMMERCIAL SITE
MEASURING-1.60 ACRES, BLOCK-F (82) FALLING IN
RESIDENTIAL PLOTTED COLONY MEASURING -
477.206 ACRES
VATIKA TOWN
SQUARE - 2