

LEGEND:-



GARDEN HYDRANT LINE



GARDEN HYDRANT (TOTAL- 8)

- NOTES:
- 1) ALL FIXTURE PROVIDED IN TOILETS ARE AS PER N.B.C.
 - 2) BASEMENT WILL BE ARTIFICIALLY VENTILATED. ALL SPACES (OFFICE, PARKING BASEMENT, SERVICES BASEMENT ETC.) WILL BE ARTIFICIALLY LIGHT, ANY NATURAL LIGHT WHICH IS AVAILABLE IN THE OFFICE SPACES IS ONLY INCIDENTAL IN THE AND NOT ESSENTIAL TO THE FUNCTIONAL OF THE BUILDINGS.
 - 3) STANDBY GENERATING CAPACITY WILL BE PROVIDED FOR THE ELECTRICAL REQUIREMENT OF THE TOTAL SCHEME. THIS THEREFORE INCLUDES STANDBY GENERATION FOR ALL COMMON SERVICES, FIRE SERVICES, LIFTS ETC. AND ALSO THE ENTIRE ELECTRICAL LOAD FOR THE VENTILATION. THIS BUILDING SHALL BE SPRINKLERED AS/NBC.
 - 4) FIRE SAFETY MEASURES AS/NBC INCLUDES: SMOKE DETECTOR - 6MT C/C (WHEREVER REQUIRED) SPRINKLER 3MT C/C HEAT DETECTOR - 6MT C/C (WHEREVER REQUIRED).

key Plan

Project

Proposed Commercial Colony measuring 2.968 acres in Sector 114, Gurgaon Manesar Urban Complex being developed by M/S AMD ESTATE AND DEVELOPERS PVT LTD.

Owner's Sign

For:-
 M/S AMD ESTATE AND DEVELOPERS PVT. LTD.
 c/o VSR Infratech Pvt. Ltd.
 A-22, Hill View Apartments
 Vasant Vihar, New Delhi 110057

Architect's Sign

Morphogenesis
 N-85B, Panchsheel Park, New Delhi, 110017, India.
 TEL: 91 11 41827570 FAX: 91 11 26490351
 E Mail: studio@morphogenesis.org

Drawing Title
 GARDEN HYDRANT LAYOUT
 SITE PLAN


Sanction

Drawing No.
 11-240-FF-SP04


Scale 1@350


Date 10-10-2011

North

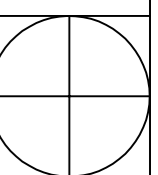

01 GROUND FLOOR PLAN
 SCALE 1:350

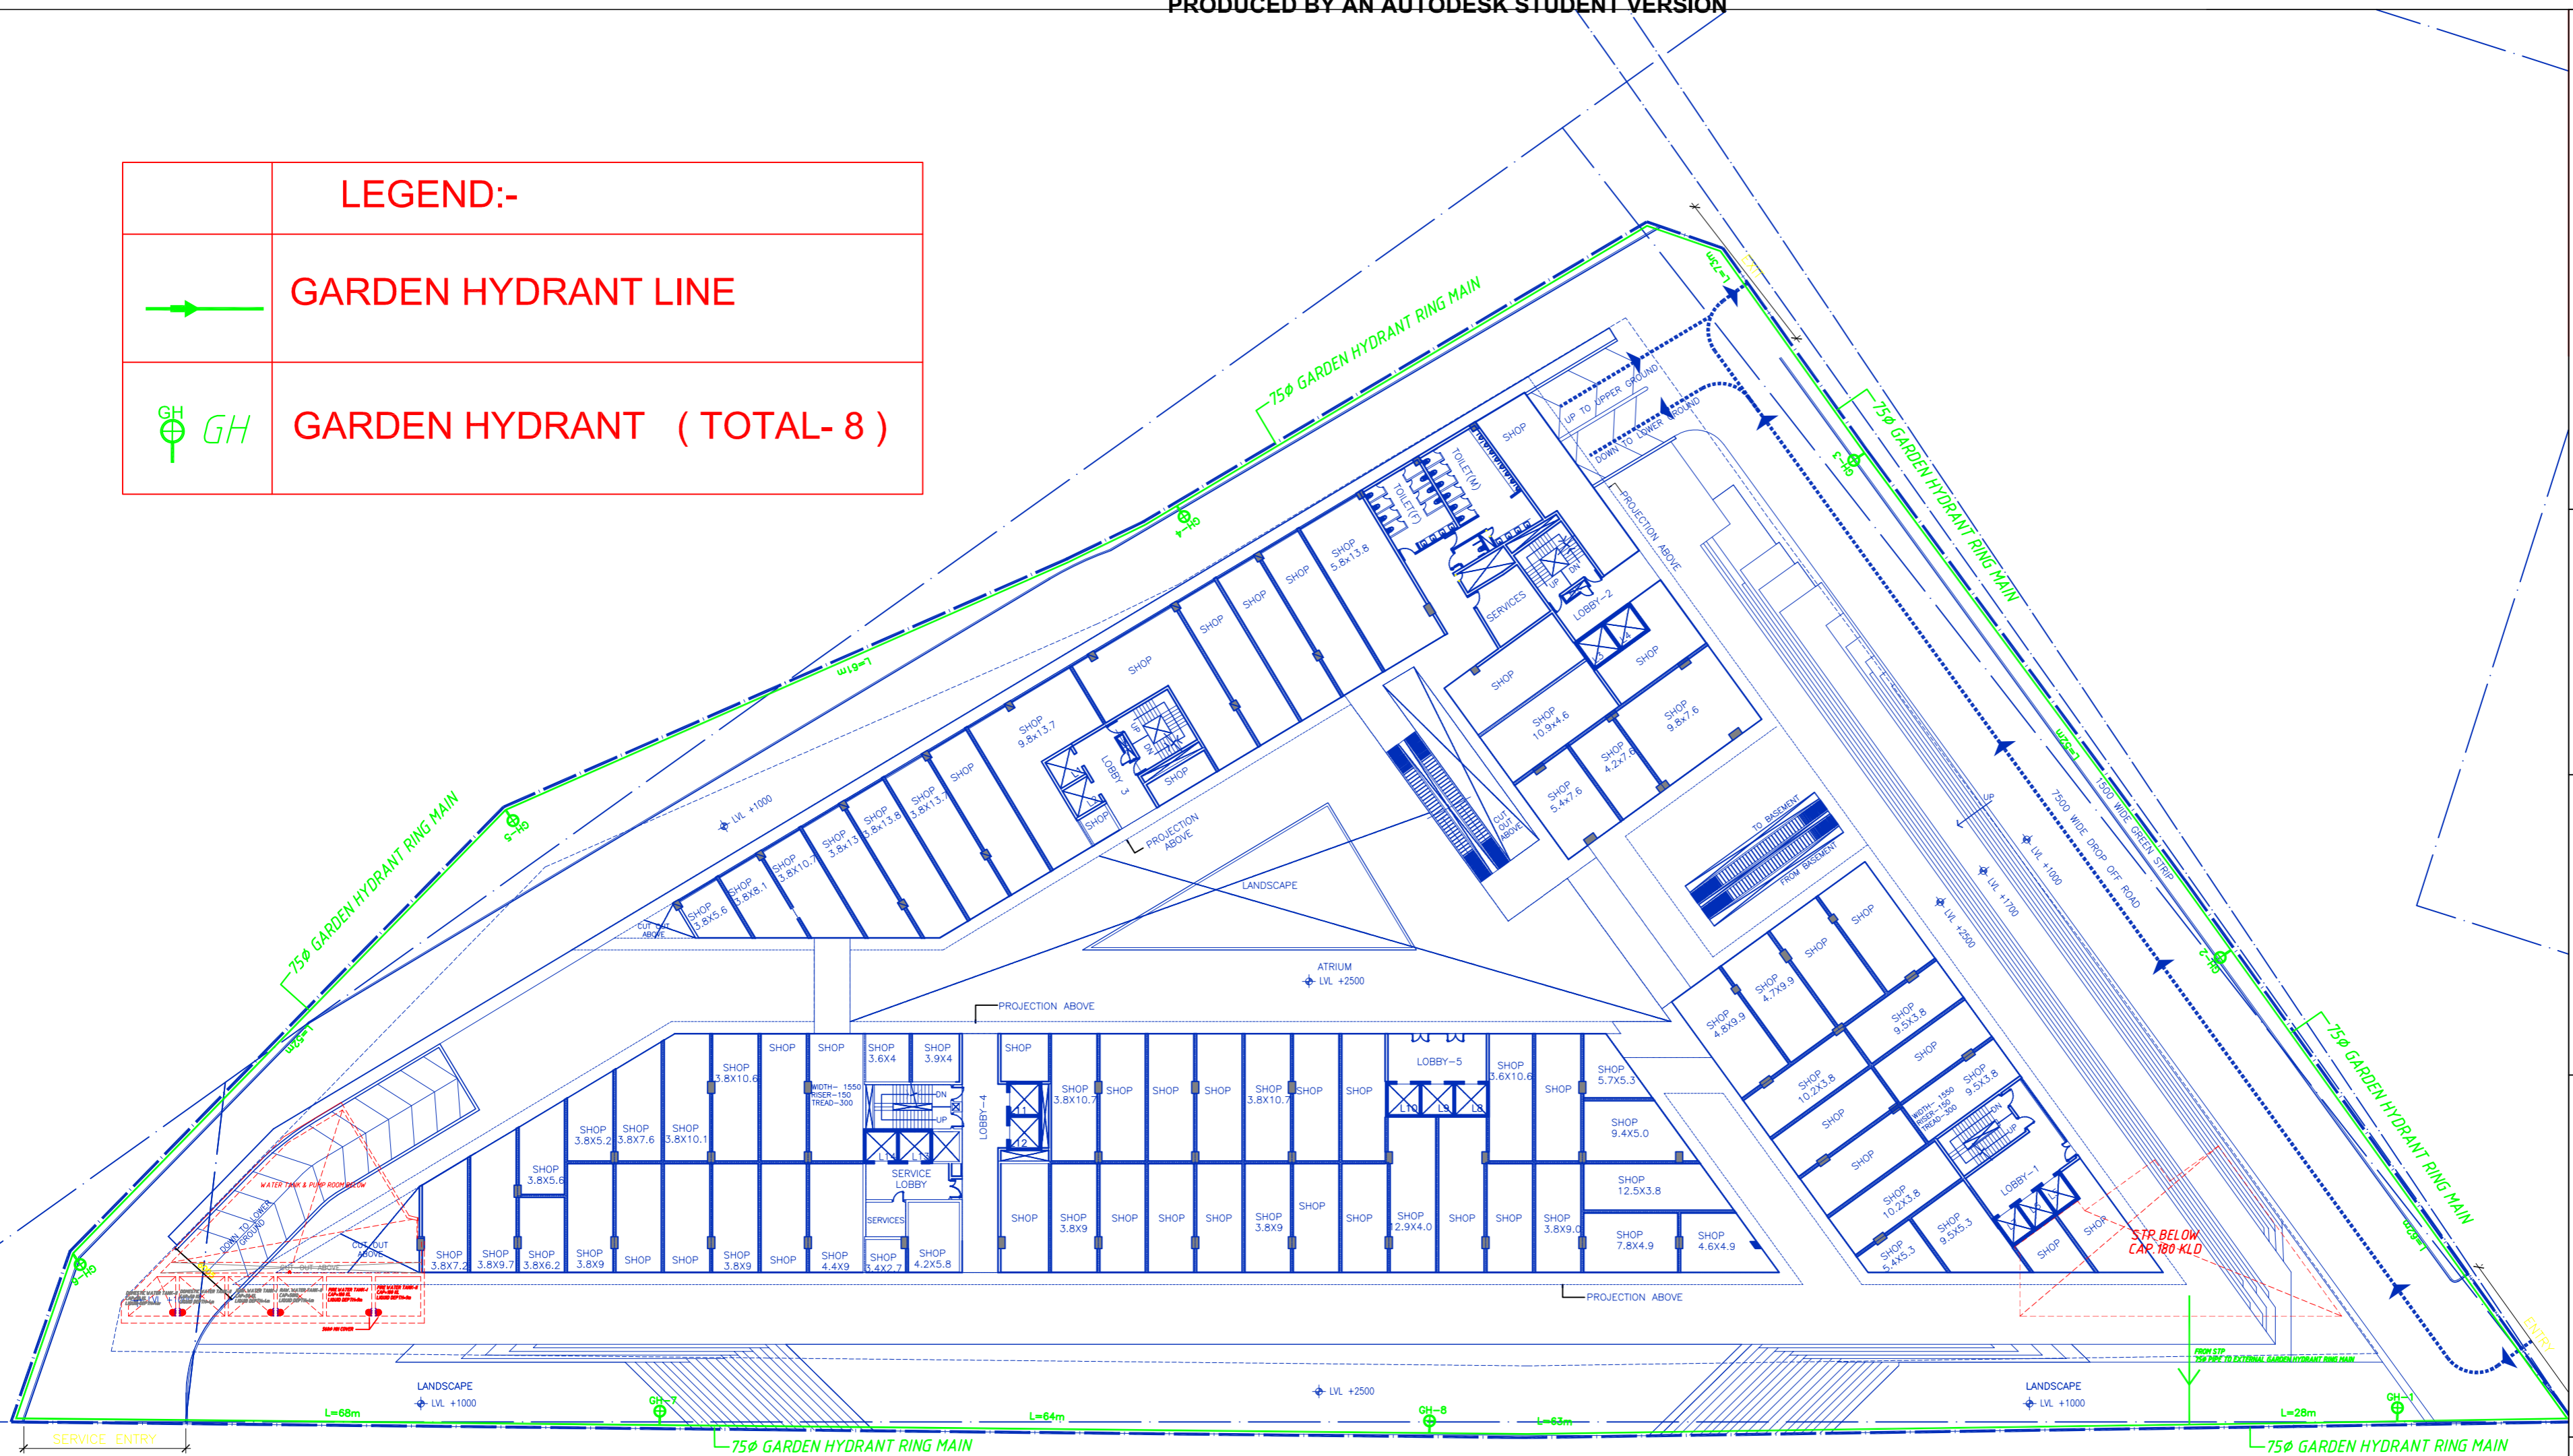

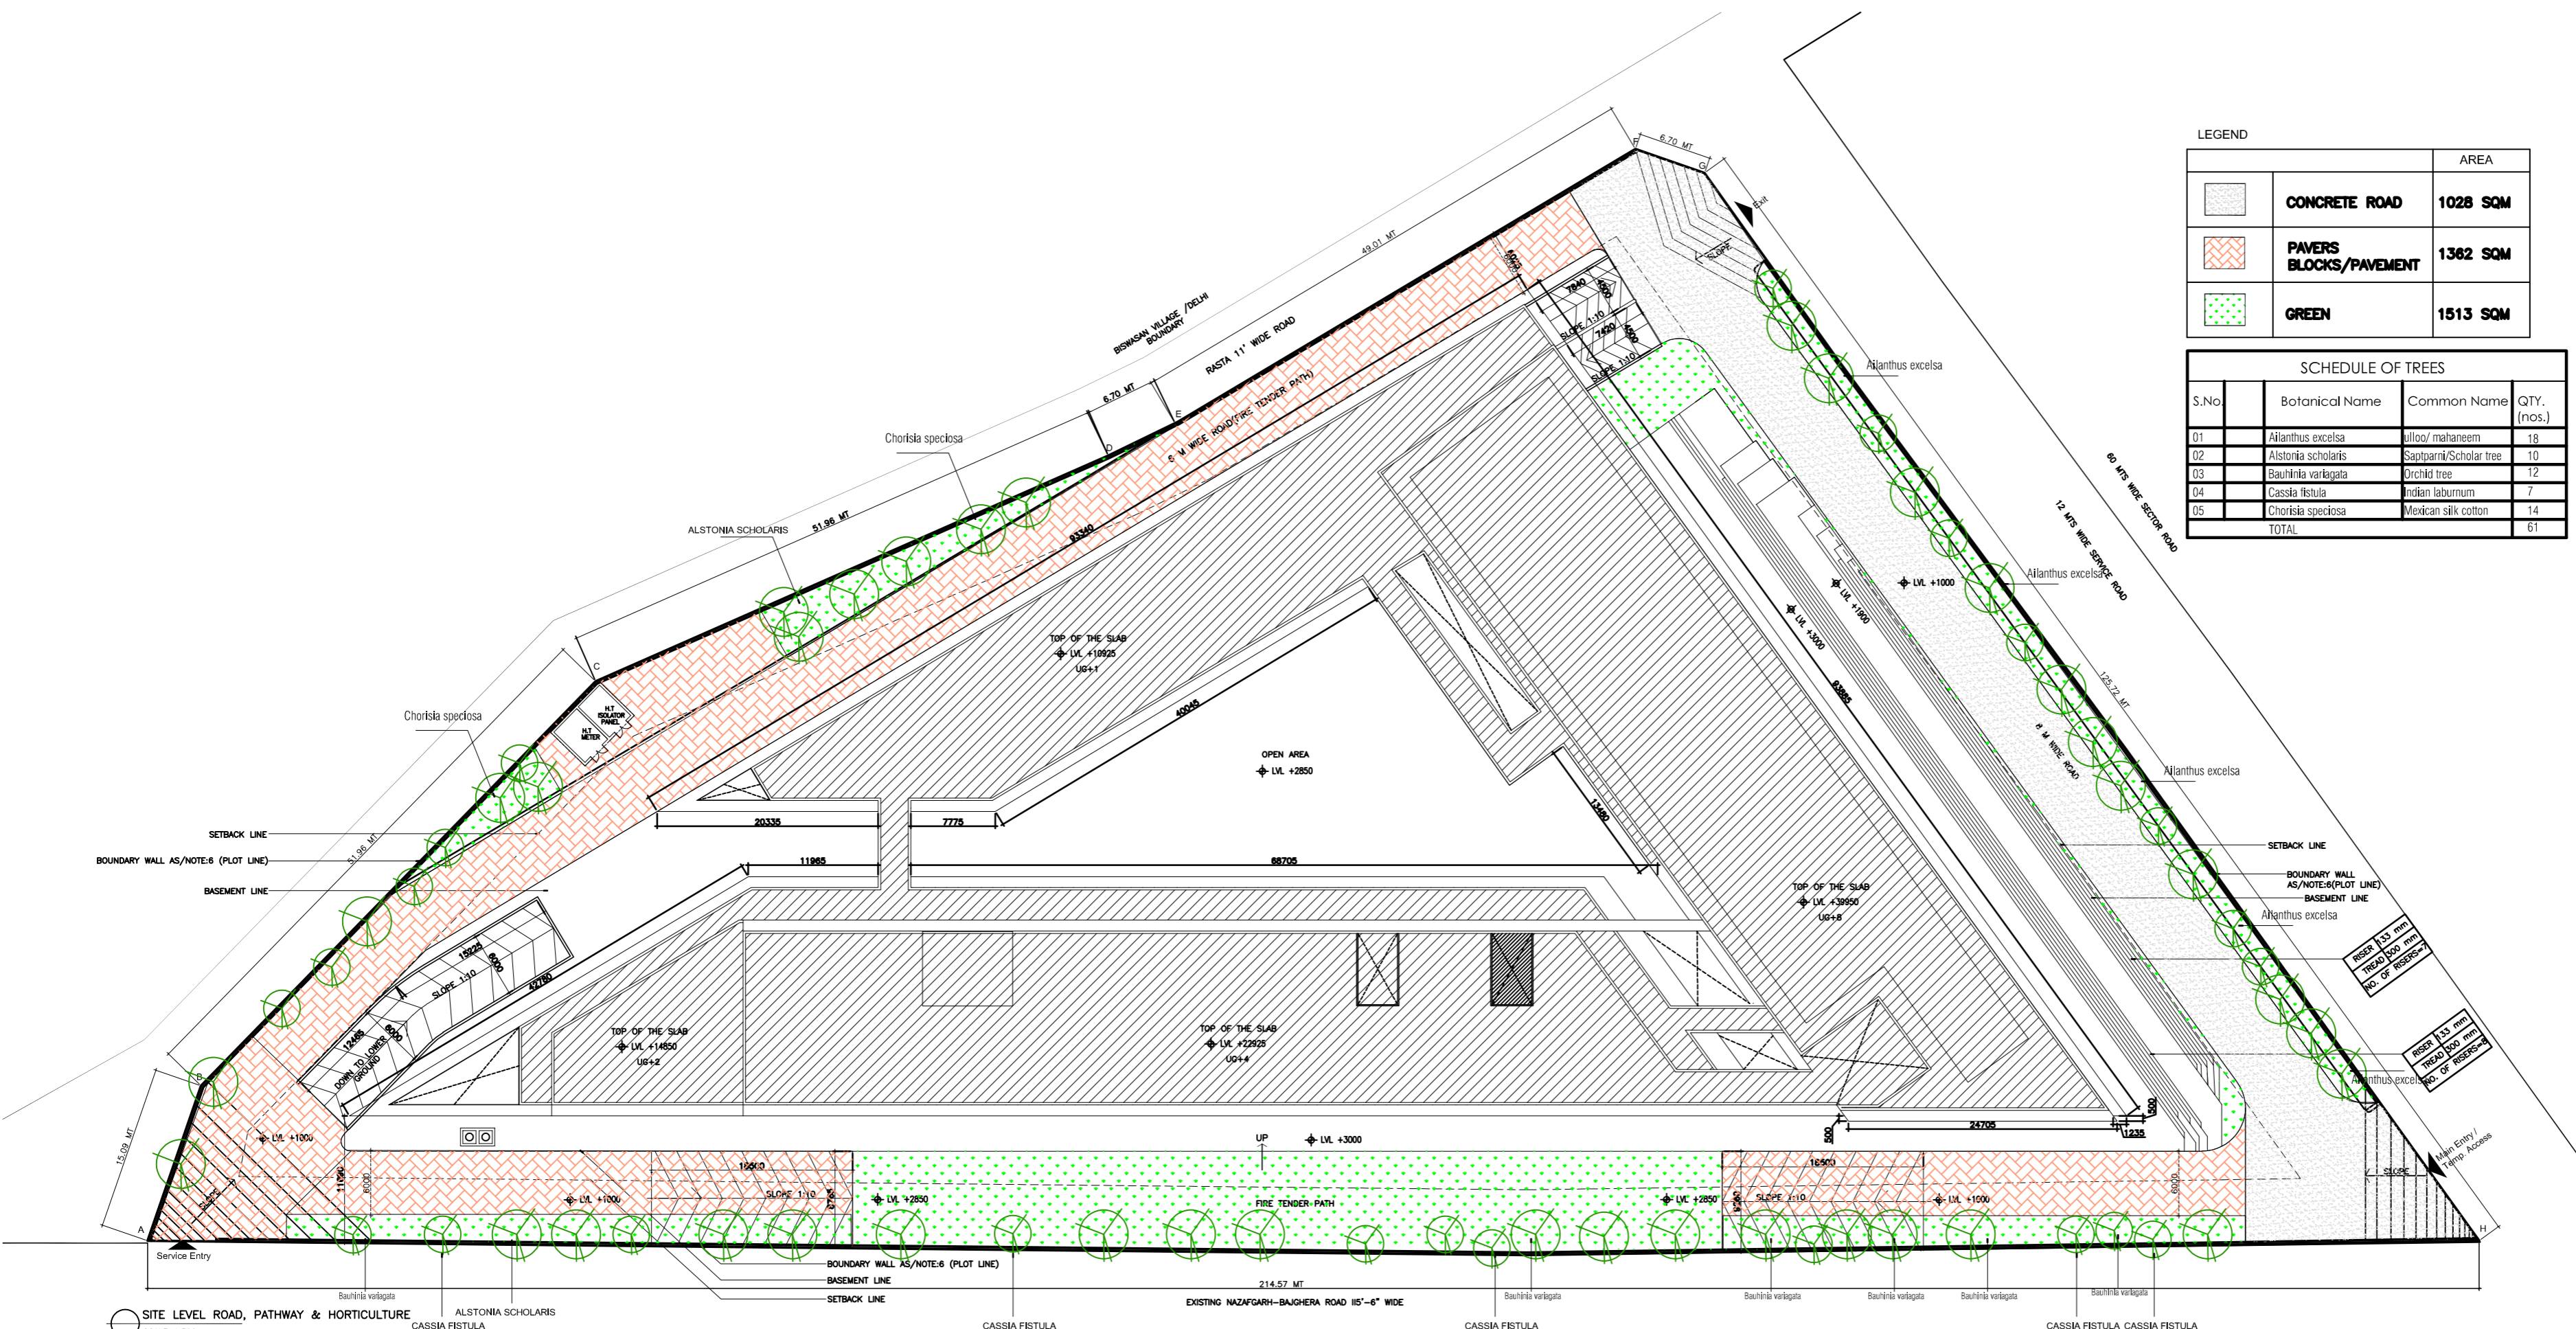

LEGEND

Symbol	Material	Area
[Grey hatched]	CONCRETE ROAD	1028 SQM
[Red hatched]	PAVERS BLOCKS/PAVEMENT	1362 SQM
[Green dotted]	GREEN	1513 SQM

SCHEDULE OF TREES

S.No	Botanical Name	Common Name	QTY. (nos.)
01	Albanus excelsa	ulool/ mahaneem	18
02	Alstonia scholaris	Saptarint/Scholar tree	10
03	Bauhinia variegata	Orchid tree	12
04	Cassia fistula	Indian laburnum	7
05	Chorisia speciosa	Mexican silk cotton	14
TOTAL			61

- NOTES:
- 1) ALL FIXTURE PROVIDED IN TOILETS ARE AS PER N.B.C.
 - 2) BASEMENT WILL BE ARTIFICIALLY VENTILATED. ALL SPACES (OFFICE, PARKING BASEMENT, SERVICES' BASEMENT ETC.) WILL BE ARTIFICIALLY LIGHT, ANY NATURAL LIGHT WHICH IS AVAILABLE IN THE OFFICE SPACES IS ONLY INCIDENTAL IN THE AND NOT ESSENTIAL TO THE FUNCTIONAL OF THE BUILDINGS.
 - 3) STANDBY GENERATING CAPACITY WILL BE PROVIDED FOR THE ELECTRICAL REQUIREMENT OF THE TOTAL SCHEME. THIS THEREFORE INCLUDES STANDBY GENERATION FOR ALL COMMON SERVICES, FIRE SERVICES, LIFTS ETC. AND ALSO THE ENTIRE ELECTRICAL LOAD FOR THE VENTILATION.
 - 4) THIS BUILDING SHALL BE SPRINKLERED AS/NBC.
 - 5) FIRE SAFETY MEASURES AS/NBC INCLUDES: SMOKE DETECTOR - 6MT C/C (WHEREVER REQUIRED) SPRINKLER 3MT C/C HEAT DETECTOR - 6MT C/C (WHEREVER REQUIRED).

Project

Proposed Commercial Colony measuring 2.968 acres in Sector 114, Gurgaon Manesar Urban Complex being developed by M/S AMD ESTATE AND DEVELOPERS PVT LTD.

Owner's Sign

 
 


For:-
M/S AMD ESTATE AND DEVELOPERS PVT LTD
c/o VSR Infotech Pvt. Ltd.
A-22, Hill View Apartments
Vasant Vihar, New Delhi 110057

Architect's Sign


Morphogenesis
N-85B, Panchsheel Park, New Delhi, 110017, India.
TEL: 91 11 41828070 FAX: 91 11 26490351
E-Mail: studio@morphogenesis.org

Drawing Title
SITE PLAN
AREA STATEMENT FOR
PAVEMENT, GREEN & ROAD
Sanction

Drawing No.	North
Scale	
Date	

FIRE FIGHTING LEGEND	
	3WAY WITHDRAWAL CONNECTION
	4WAY(150Ø M.S) FIRE BRIGADE INLET CONNECTION (TANK FILLING)
	EXTERNAL FIRE HYDRANT (TOTAL .12)
	EXTERNAL FIRE HYDRANT RING

- NOTES:
- 1) ALL FIXTURE PROVIDED IN TOILETS ARE AS PER N.B.C.
 - 2) BASEMENT WILL BE ARTIFICIALLY VENTILATED. ALL SPACES (OFFICE, PARKING BASEMENT, SERVICES BASEMENT ETC.) WILL BE ARTIFICIALLY LIGHT, ANY NATURAL LIGHT WHICH IS AVAILABLE IN THE OFFICE SPACES IS ONLY INCIDENTAL IN THE AND NOT ESSENTIAL TO THE FUNCTIONAL OF THE BUILDINGS.
 - 3) STANDBY GENERATING CAPACITY WILL BE PROVIDED FOR THE ELECTRICAL REQUIREMENT OF THE TOTAL SCHEME. THIS THEREFORE INCLUDES STANDBY GENERATION FOR ALL COMMON SERVICES, FIRE SERVICES, LIFTS ETC. AND ALSO THE ENTIRE ELECTRICAL LOAD FOR THE VENTILATION. THIS BUILDING SHALL BE SPRINKLERED AS/NBC.
 - 4) FIRE SAFETY MEASURES AS/NBC INCLUDES: SMOKE DETECTOR - 6MT C/C (WHEREVER REQUIRED) SPRINKLER 3MT C/C HEAT DETECTOR - 6MT C/C (WHEREVER REQUIRED).

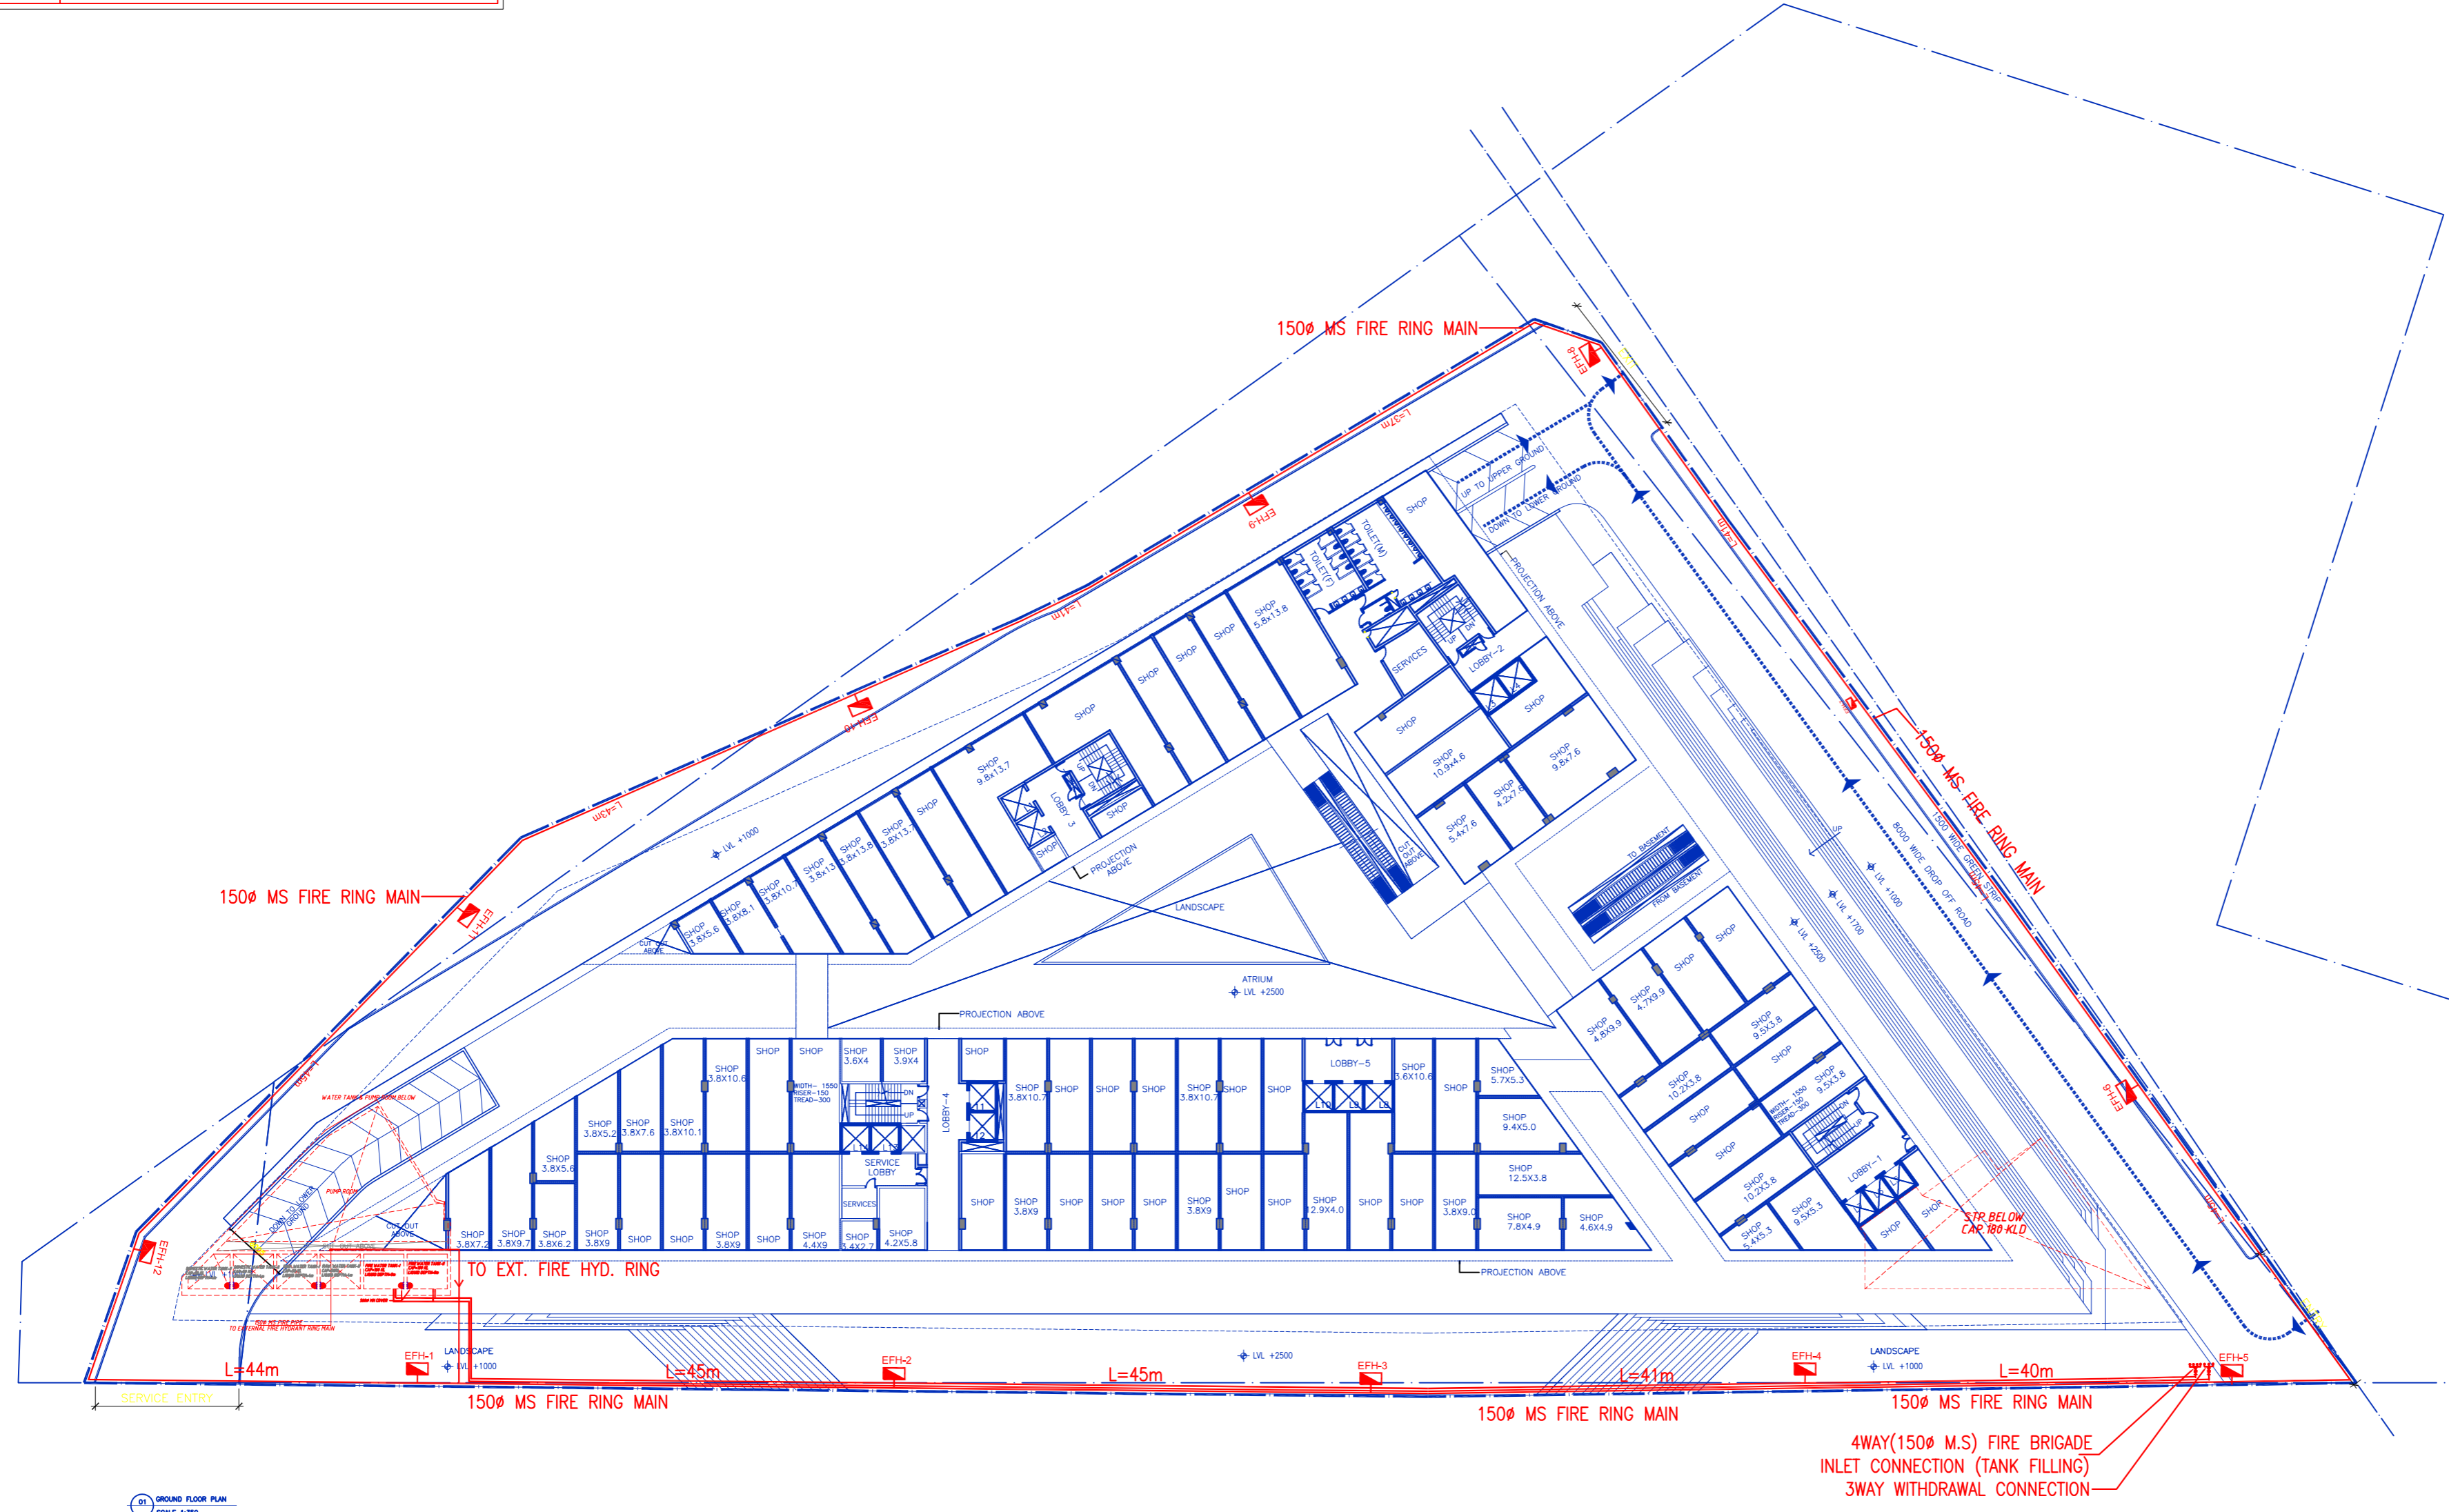

key Plan

Project

Proposed Commercial Colony measuring 2.968 acres in Sector 114, Gurgaon Manesar Urban Complex being developed by M/S AMD ESTATE AND DEVELOPERS PVT LTD.

Owner's Sign


For:-
M/S AMD ESTATE AND DEVELOPERS PVT. LTD.
c/o VSR Infratech Pvt. Ltd.
A-22, Hill View Apartments
Vasant Vihar, New Delhi 110057

Architect's Sign

Morphogenesis
N-85B, Panchsheel Park, New Delhi, 110017, India.
TEL: 91 11 41828070 FAX: 91 11 26490351
E Mail: studio@morphogenesis.org


Drawing Title
FIRE FIGHTING LAYOUT
SITE PLAN

Sanction

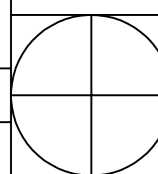Drawing No. 11-240-FF-SP03	North 
Scale 1@350	
Date 10-10-2011	

GROUND FLOOR PLAN
SCALE 1:300

	SEWER LEGEND
	SEWER LINE
	SEWER MANHOLE
	GULLY TRAP

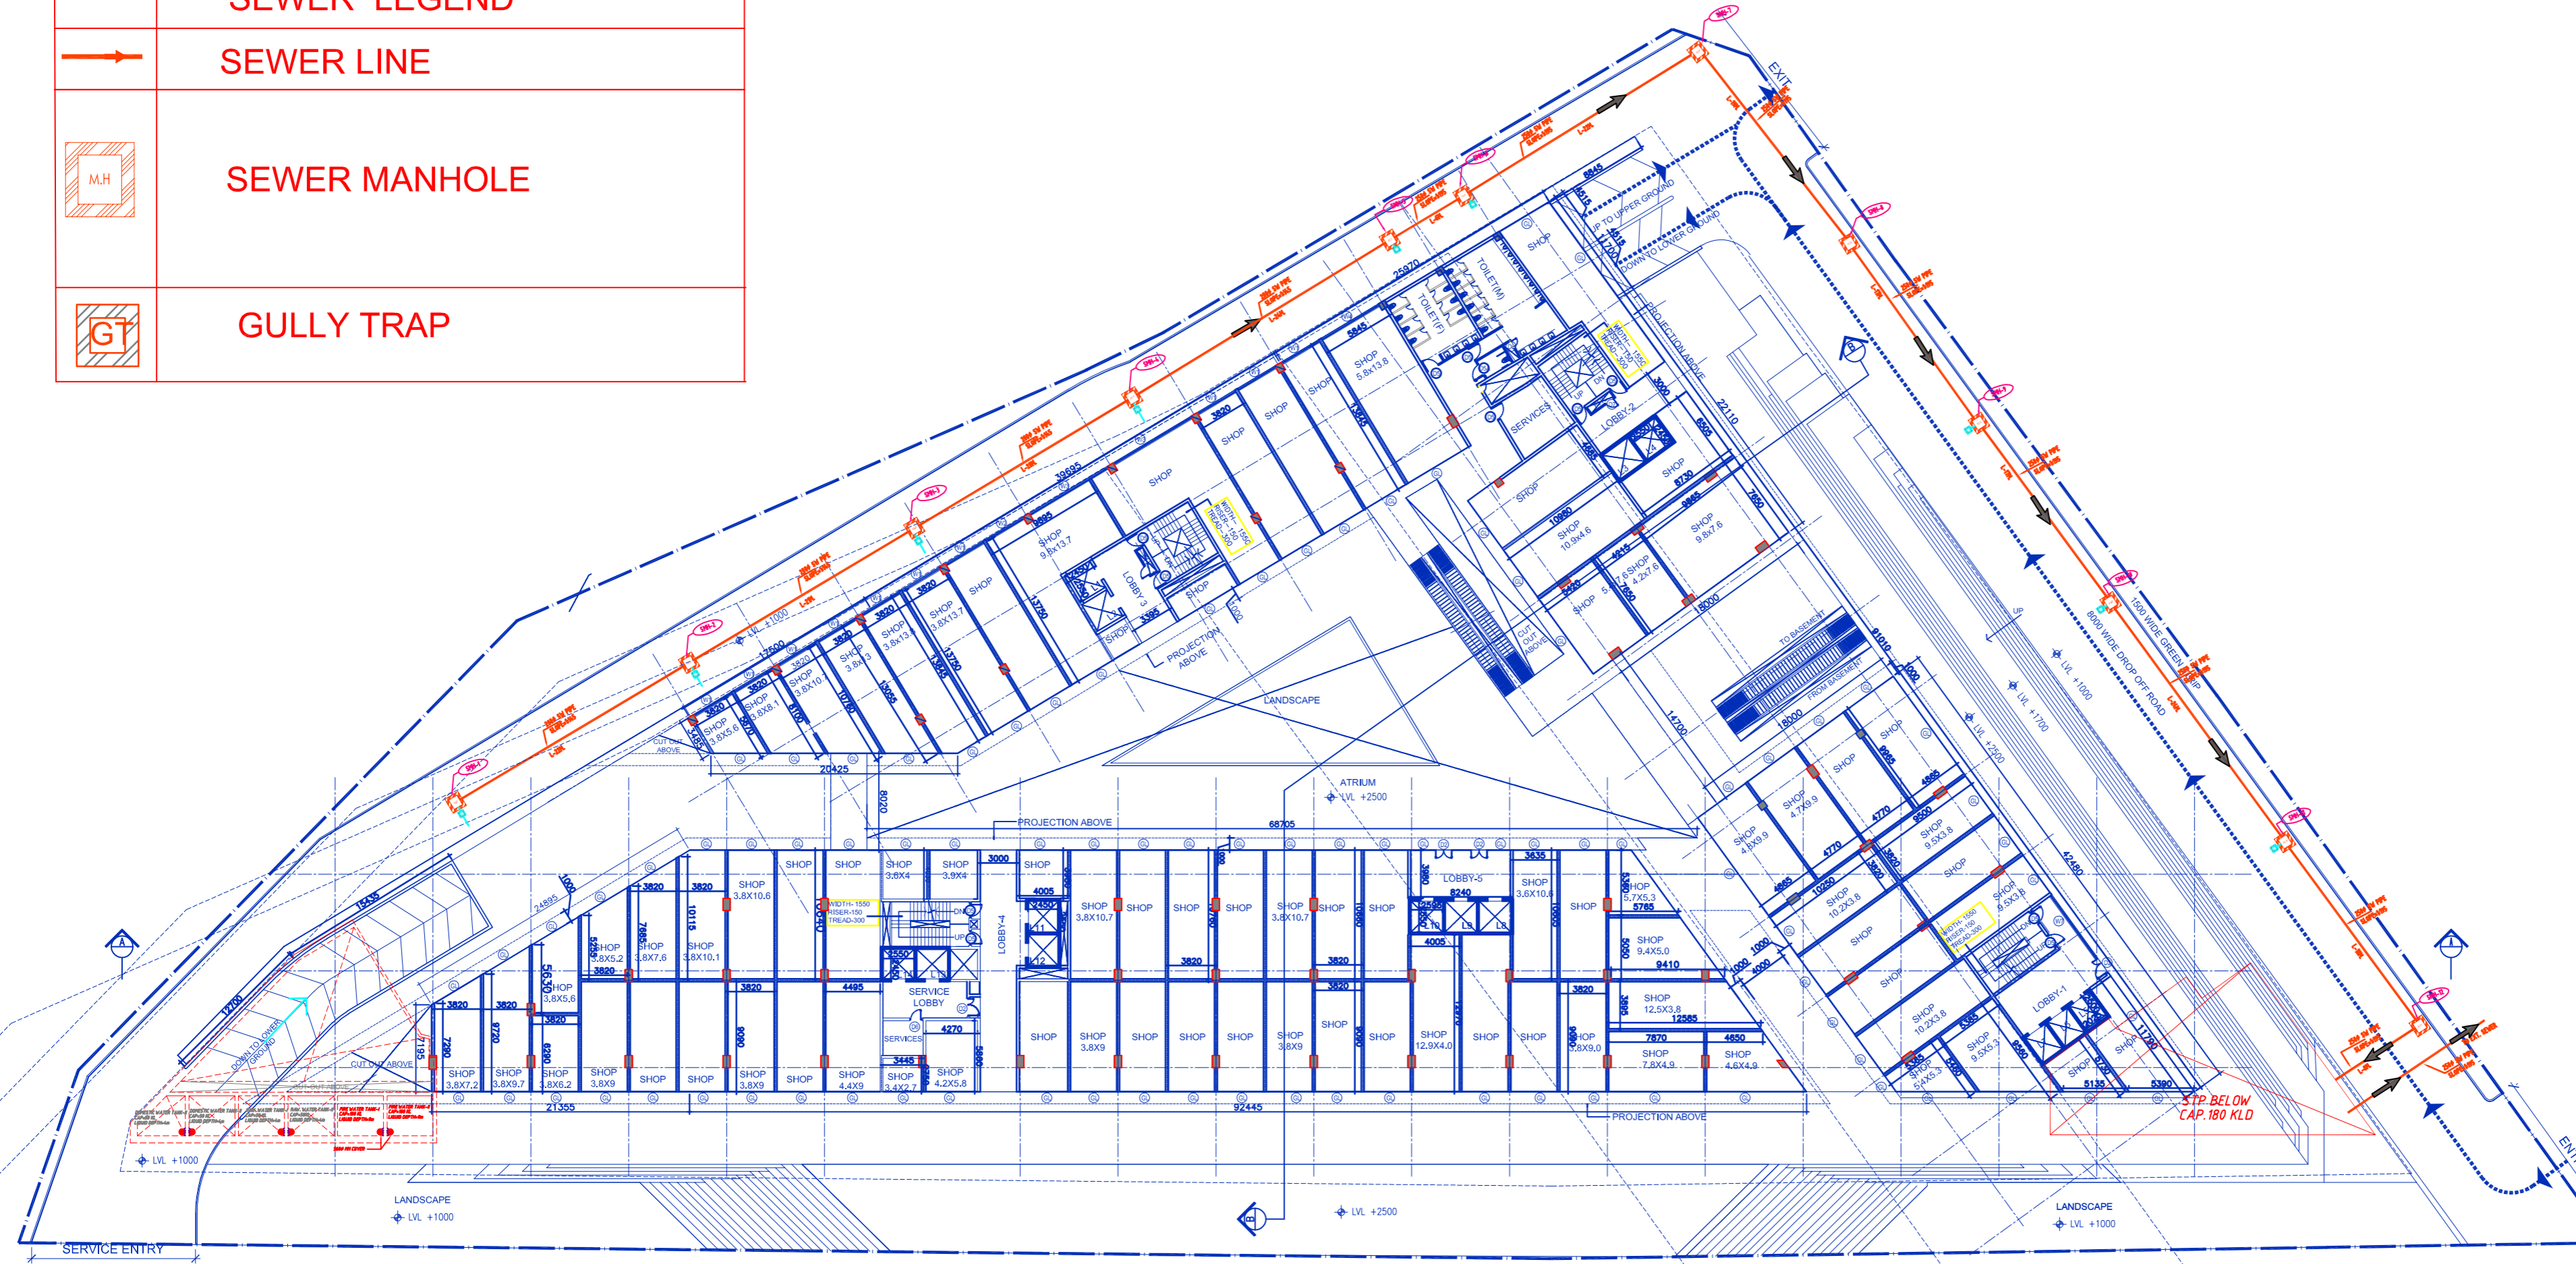

01 GROUND FLOOR PLAN
SCALE 1:350

- NOTES:
- 1) ALL FIXTURE PROVIDED IN TOILETS ARE AS PER N.B.C.
 - 2) BASEMENT WILL BE ARTIFICIALLY VENTILATED. ALL SPACES (OFFICE, PARKING BASEMENT, SERVICES BASEMENT ETC.) WILL BE ARTIFICIALLY LIGHT, ANY NATURAL LIGHT WHICH IS AVAILABLE IN THE OFFICE SPACES IS ONLY INCIDENTAL IN THE AND NOT ESSENTIAL TO THE FUNCTIONAL OF THE BUILDINGS.
 - 3) STANDBY GENERATING CAPACITY WILL BE PROVIDED FOR THE ELECTRICAL REQUIREMENT OF THE TOTAL SCHEME. THIS THEREFORE INCLUDES STANDBY GENERATION FOR ALL COMMON SERVICES, FIRE SERVICES, LIFTS ETC. AND ALSO THE ENTIRE ELECTRICAL LOAD FOR THE VENTILATION. THIS BUILDING SHALL BE SPRINKLERED AS/NBC.
 - 4) FIRE SAFETY MEASURES AS/NBC INCLUDES: SMOKE DETECTOR - 6MT C/C (WHEREVER REQUIRED) SPRINKLER 3MT C/C HEAT DETECTOR - 6MT C/C (WHEREVER REQUIRED).

key Plan

Project

Proposed Commercial Colony measuring 2.968 acres in Sector 114, Gurgaon Manesar Urban Complex being developed by M/S AMD ESTATE AND DEVELOPERS PVT LTD.

Owner's Sign

For:-
M/S AMD ESTATE AND DEVELOPERS PVT. LTD.
c/o VSR Infratech Pvt. Ltd.
A-22, Hill View Apartments
Vasant Vihar, New Delhi 110057

Architect's Sign




Morphogenesis
N-85B, Panchsheel Park, New Delhi, 110017, India.
TEL: 91 11 41828070 FAX: 91 11 26490351
E Mail: studio@morphogenesis.org

Drawing Title
PLUMBING DRAINAGE
SEWER LAYOUT SITE PLAN

Sanction

Drawing No.	11-240-PL-SP02	North
Scale	1@350	
Date	11-04-2012	

PLUMBING LEGEND:-

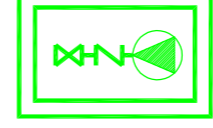	MUNICIPAL WATER SUPPLY LINE
	BORE WELL LINE
	BORE WELL-(TOTAL-2)

- NOTES:
- 1) ALL FIXTURE PROVIDED IN TOILETS ARE AS PER N.B.C.
 - 2) BASEMENT WILL BE ARTIFICIALLY VENTILATED. ALL SPACES (OFFICE, PARKING BASEMENT, SERVICES BASEMENT ETC.) WILL BE ARTIFICIALLY LIGHT, ANY NATURAL LIGHT WHICH IS AVAILABLE IN THE OFFICE SPACES IS ONLY INCIDENTAL IN THE AND NOT ESSENTIAL TO THE FUNCTIONAL OF THE BUILDINGS.
 - 3) STANDBY GENERATING CAPACITY WILL BE PROVIDED FOR THE ELECTRICAL REQUIREMENT OF THE TOTAL SCHEME. THIS THEREFORE INCLUDES STANDBY GENERATION FOR ALL COMMON SERVICES, FIRE SERVICES, LIFTS ETC. AND ALSO THE ENTIRE ELECTRICAL LOAD FOR THE VENTILATION. THIS BUILDING SHALL BE SPRINKLERED AS/NBC.
 - 4) FIRE SAFETY MEASURES AS/NBC INCLUDES: SMOKE DETECTOR - 6MT C/C (WHEREVER REQUIRED) SPRINKLER 3MT C/C HEAT DETECTOR - 6MT C/C (WHEREVER REQUIRED).

key Plan

Project

Proposed Commercial Colony measuring 2.968 acres in Sector 114, Gurgaon Manesar Urban Complex being developed by M/S AMD ESTATE AND DEVELOPERS PVT LTD.

Owner's Sign


For:-
M/S AMD ESTATE AND DEVELOPERS PVT LTD.
c/o VSR Infratech Pvt. Ltd.
A-22, Hill View Apartments
Vasant Vihar, New Delhi 110057

Architect's Sign

Morphogenesis
N-85B, Panchsheel Park, New Delhi, 110017, India.
TEL: 91 11 41828070 FAX: 91 11 26490351
E Mail: studio@morphogenesis.org

Drawing Title
WATER SUPPLY LAYOUT
SITE PLAN

Sanction

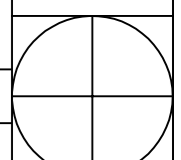Drawing No.	11-240-PL-SP05	North
Scale	1@350	
Date	10-10-2011	

